

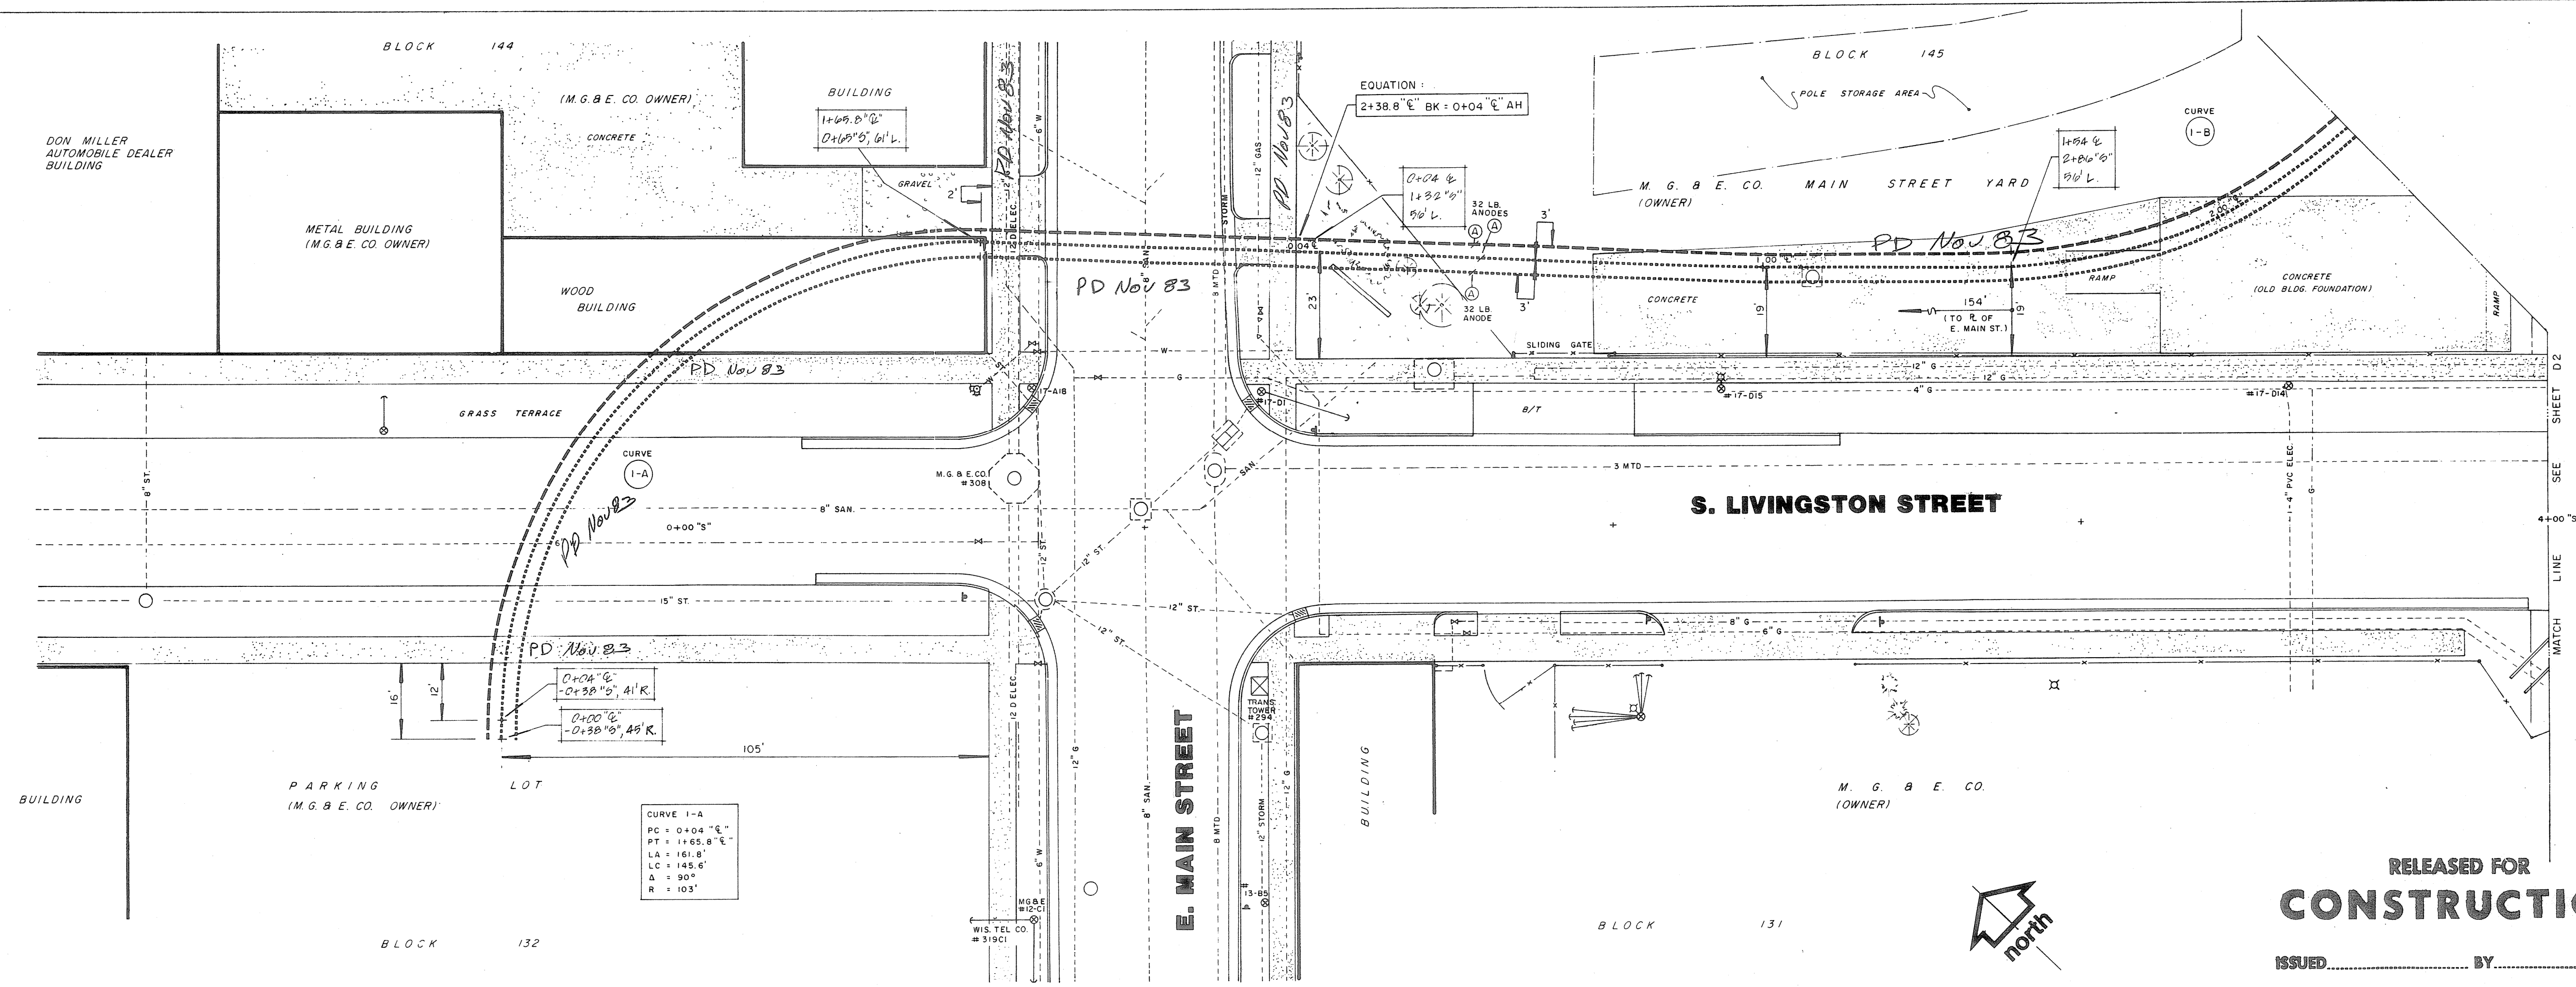


PLAN
 SURVEYED BY: _____ DATE: _____
 PLOTTED BY: _____
 NOTE BOOK NO. _____
 CHECKED BY: _____
 STRUCTURE NOTATIONS CHECKED BY: _____

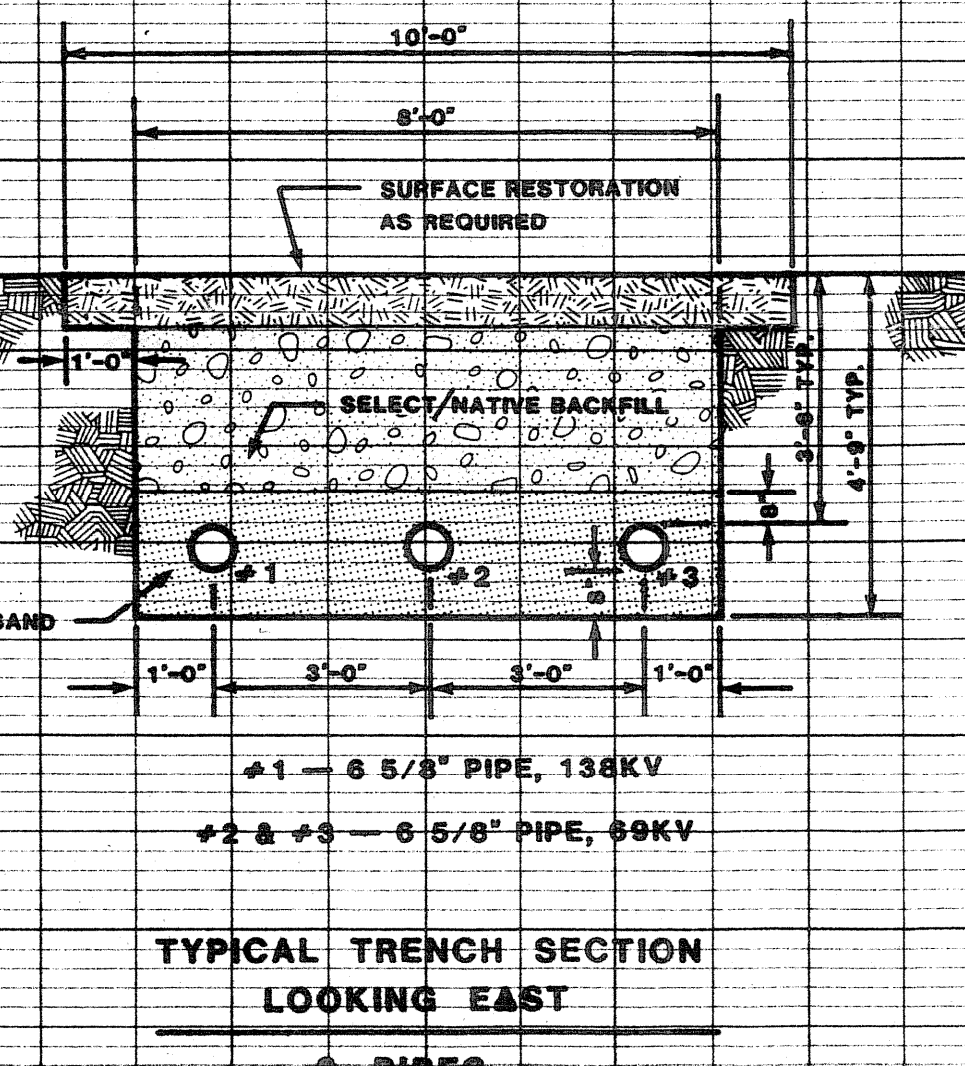

RELEASED FOR
CONSTRUCTION
 ISSUED _____ BY _____

PROFILE
 SURVEYED BY: _____ DATE: _____
 PLOTTED BY: _____
 NOTE BOOK NO. _____
 CHECKED BY: _____
 STRUCTURE NOTATIONS CHECKED BY: _____

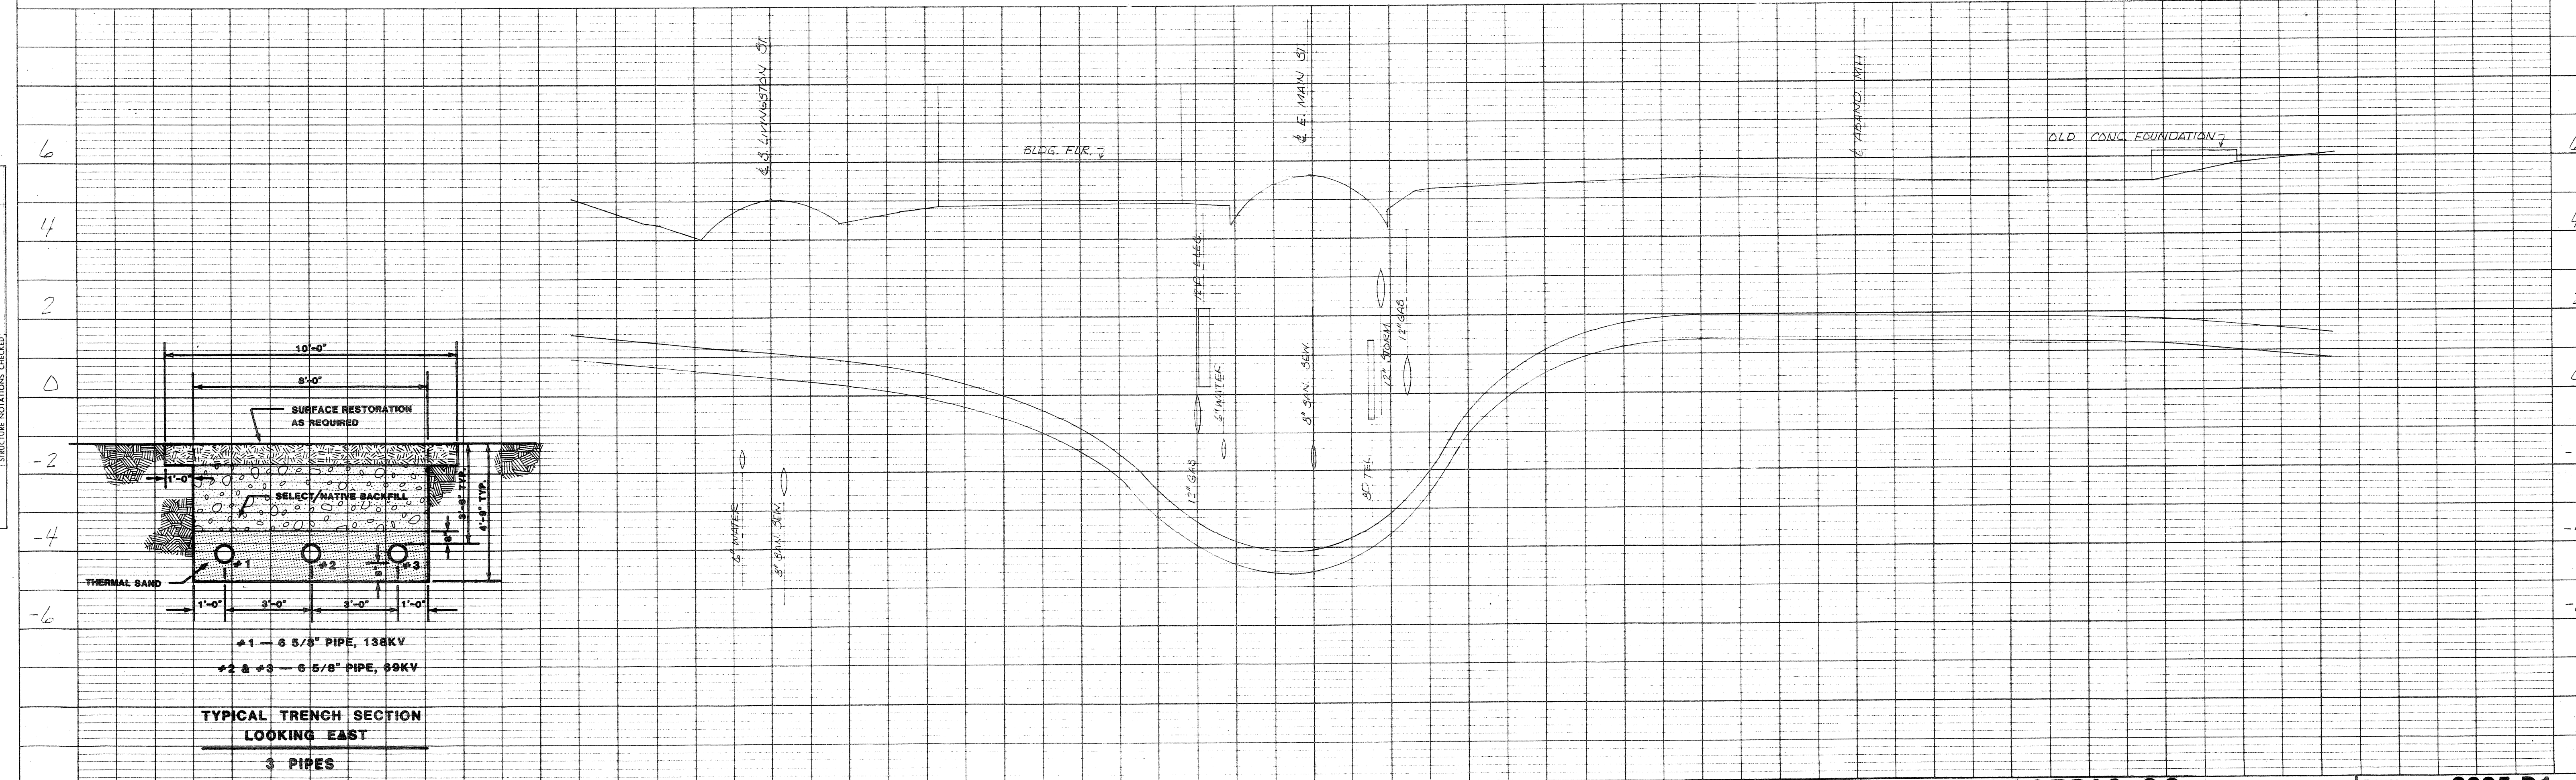

REV.	DATE	DESCRIPTION	BY	APPROVED	DATE
1	NOV. 2, '83	RELEASED FOR CONSTRUCTION	W.R.S.	J.G. HILLIARD	NOV. 2, '83

PLAN AND PROFILE DATA / CARL C. CRANE & ASSOC.
 FIELD SURVEY: CARL C. CRANE & ASSOC. BY: _____ DATE: _____
 LAYOUT OF FACILITY: CARL C. CRANE & ASSOC. BY: _____ DATE: _____
 SCALE: HORIZONTAL 1" = 20' VERTICAL 1" = 2'

MADISON GAS & ELECTRIC CO.
 BLOUNT TO SYCAMORE
 138 KV TRANSMISSION LINE

DWN. NO. 2295 D1
 W.O.NO. _____ REV. NO. 1