


ARCHITECTURE
ENGINEERING
INTERIOR DESIGN

STRANG INC.
6411 MINERAL POINT ROAD
MADISON, WI 53705-4395
T/ 608 276 9200
F/ 608 276 9204

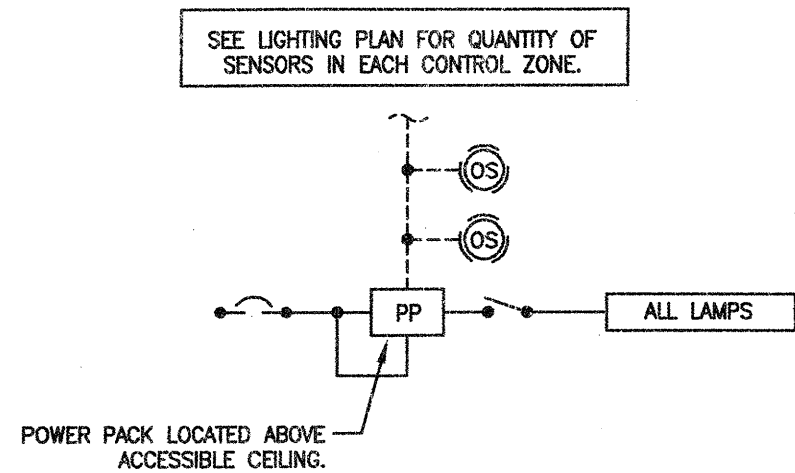


DETAIL IS SCHEMATIC AND INTENDED TO ILLUSTRATE
SWITCHING INTENT. VERIFY ACTUAL INSTALLATION WITH
MANUFACTURER'S REQUIREMENTS.

CEILING OCCUPANCY SENSOR W/ SINGLE POLE SWITCH

1
E401

SCALE: N.T.S.

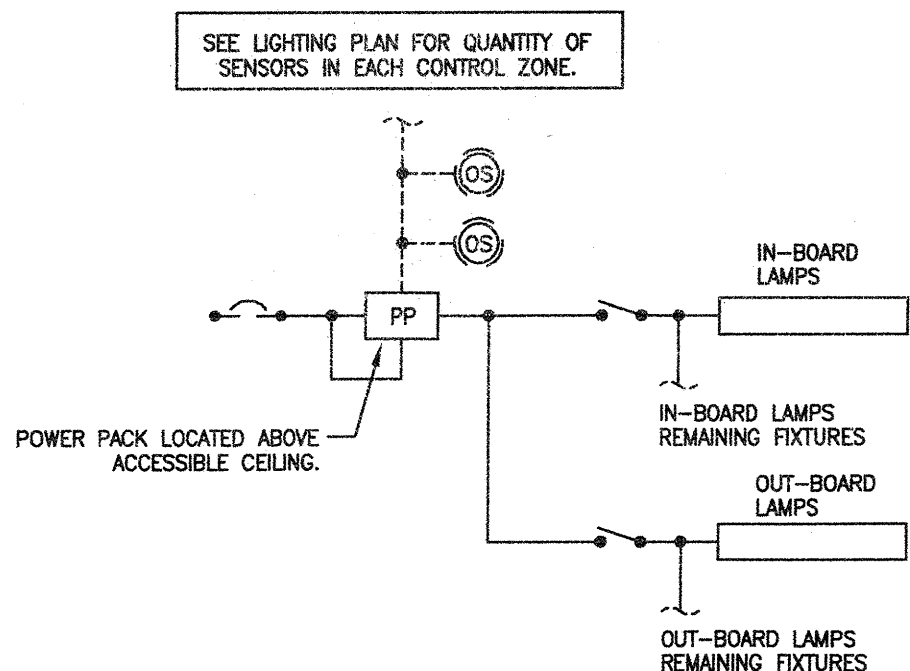


DETAIL IS SCHEMATIC AND INTENDED TO ILLUSTRATE
SWITCHING INTENT. VERIFY ACTUAL INSTALLATION WITH
MANUFACTURER'S REQUIREMENTS.

CEILING OCCUPANCY SENSOR W/TWO LEVELS OF LIGHTING

2
E401

SCALE: N.T.S.

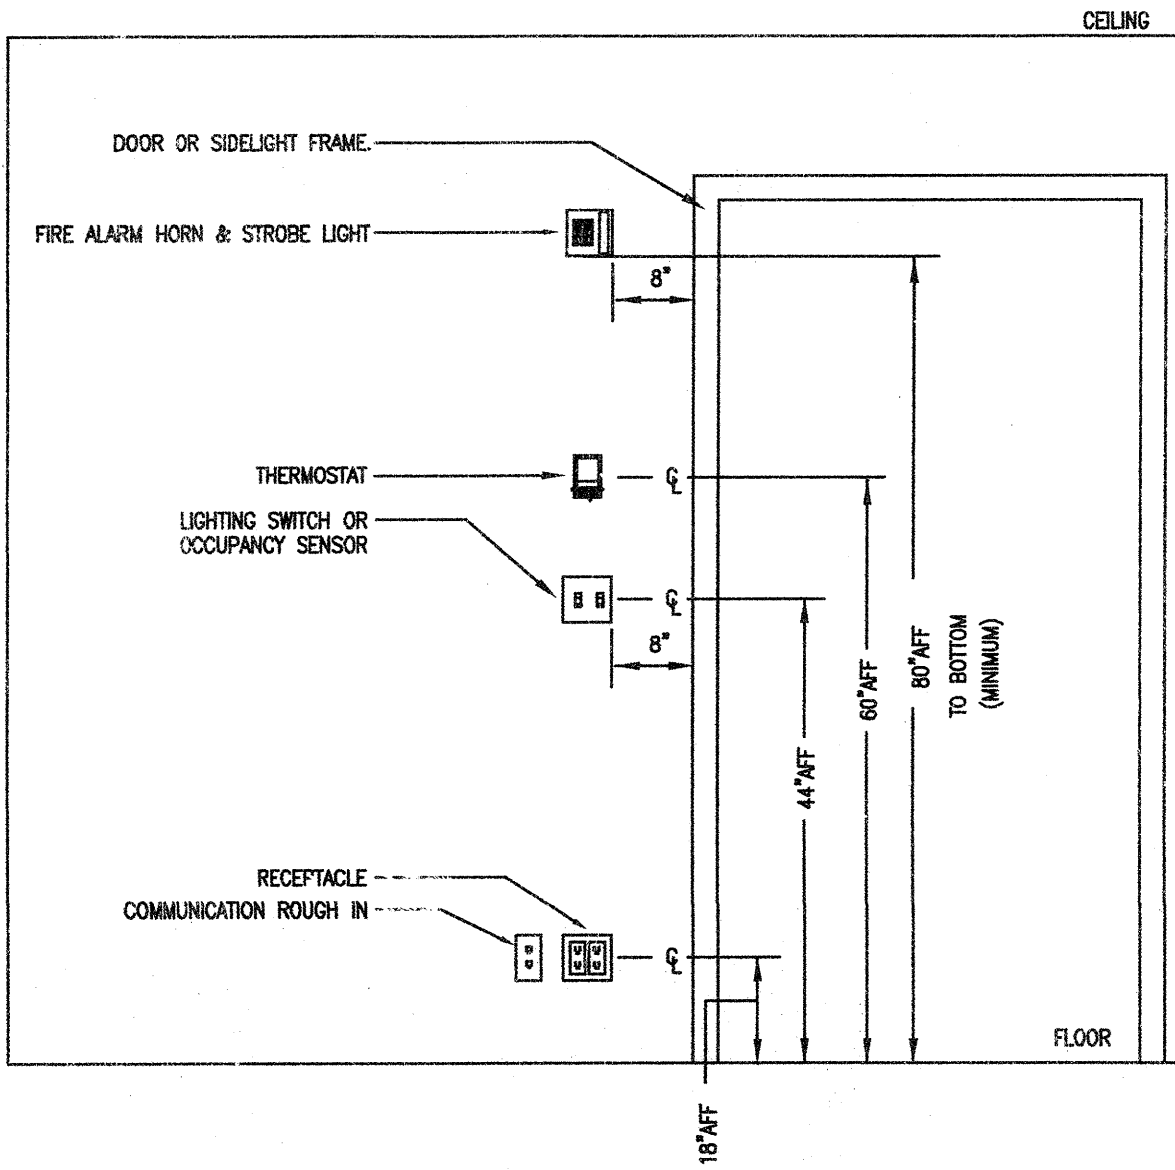

GENERAL NOTES:
NOT ALL DEVICES WILL BE PRESENT AT EACH ROOM ENTRY. THE INTENT OF THIS
ELEVATION IS TO EMPHASIZE THAT A VERTICAL ALIGNMENT OF DEVICES IS REQUIRED.

DEVICE MOUNTING DETAIL

3
E401

SCALE: N.T.S.

DRAWING SET	OWNER REVIEW
COPYRIGHT	2012
STRANG, INC.	
FILE NAME	2011009-E401.DWG
REVISIONS	

DRAWN	KK
CHECKED	AS
DATE	03-09-12
PROJECT NO.	2011009
PROJECT TITLE	

CITY OF MADISON FIRE STATION #2 ADDITION AND REMODELING

421 GRAND CANYON DRIVE
MADISON, WISCONSIN

SHEET TITLE

ELECTRICAL DETAILS

SHEET NO.

E401