

ARNOLD AND O'SHERIDAN INC
 CONSULTING ENGINEERS
 STRUCTURAL ■ CIVIL ■ HVAC ■ PLUMBING
 ELECTRICAL ■ TELECOMMUNICATIONS
 MADISON, WISCONSIN (608-871-8500)
 BROOKFIELD, WISCONSIN (762)783-6130
 WWW.ARNOLDANDOSHERIDAN.COM

Sheet Title:

BLOCK PLAN - OPTION 2



Project Title:

MID STATE STREET PARKING
 MADISON, WI
 CITY OF MADISON PARKING UTILITY

Drawing Number:

2

Project Number: 040069	Revised By:
Date Issued: 3-29-04	Issued With:



ARNOLD AND O'SHERIDAN INC
 CONSULTING ENGINEERS
 STRUCTURAL ■ CIVIL ■ HVAC ■ PLUMBING
 ELECTRICAL ■ TELECOMMUNICATIONS
 MADISON, WISCONSIN (608-871-8500)
 BROOKFIELD, WISCONSIN (262)783-6130
 WWW.ARNOLDANDOSHERIDAN.COM

Sheet Title:

SITE PLAN - OPTION 2C

Project Title:


MID STATE STREET PARKING
 MADISON, WI
 CITY OF MADISON PARKING UTILITY

Drawing Number:

2C-1

Project Number: 040069
 Date Issued: 3-29-04
 Revised By:
 Issued With:

LEVEL	STALLS
P1	12
L1	37
L2	43
L3	84
TOTAL	228

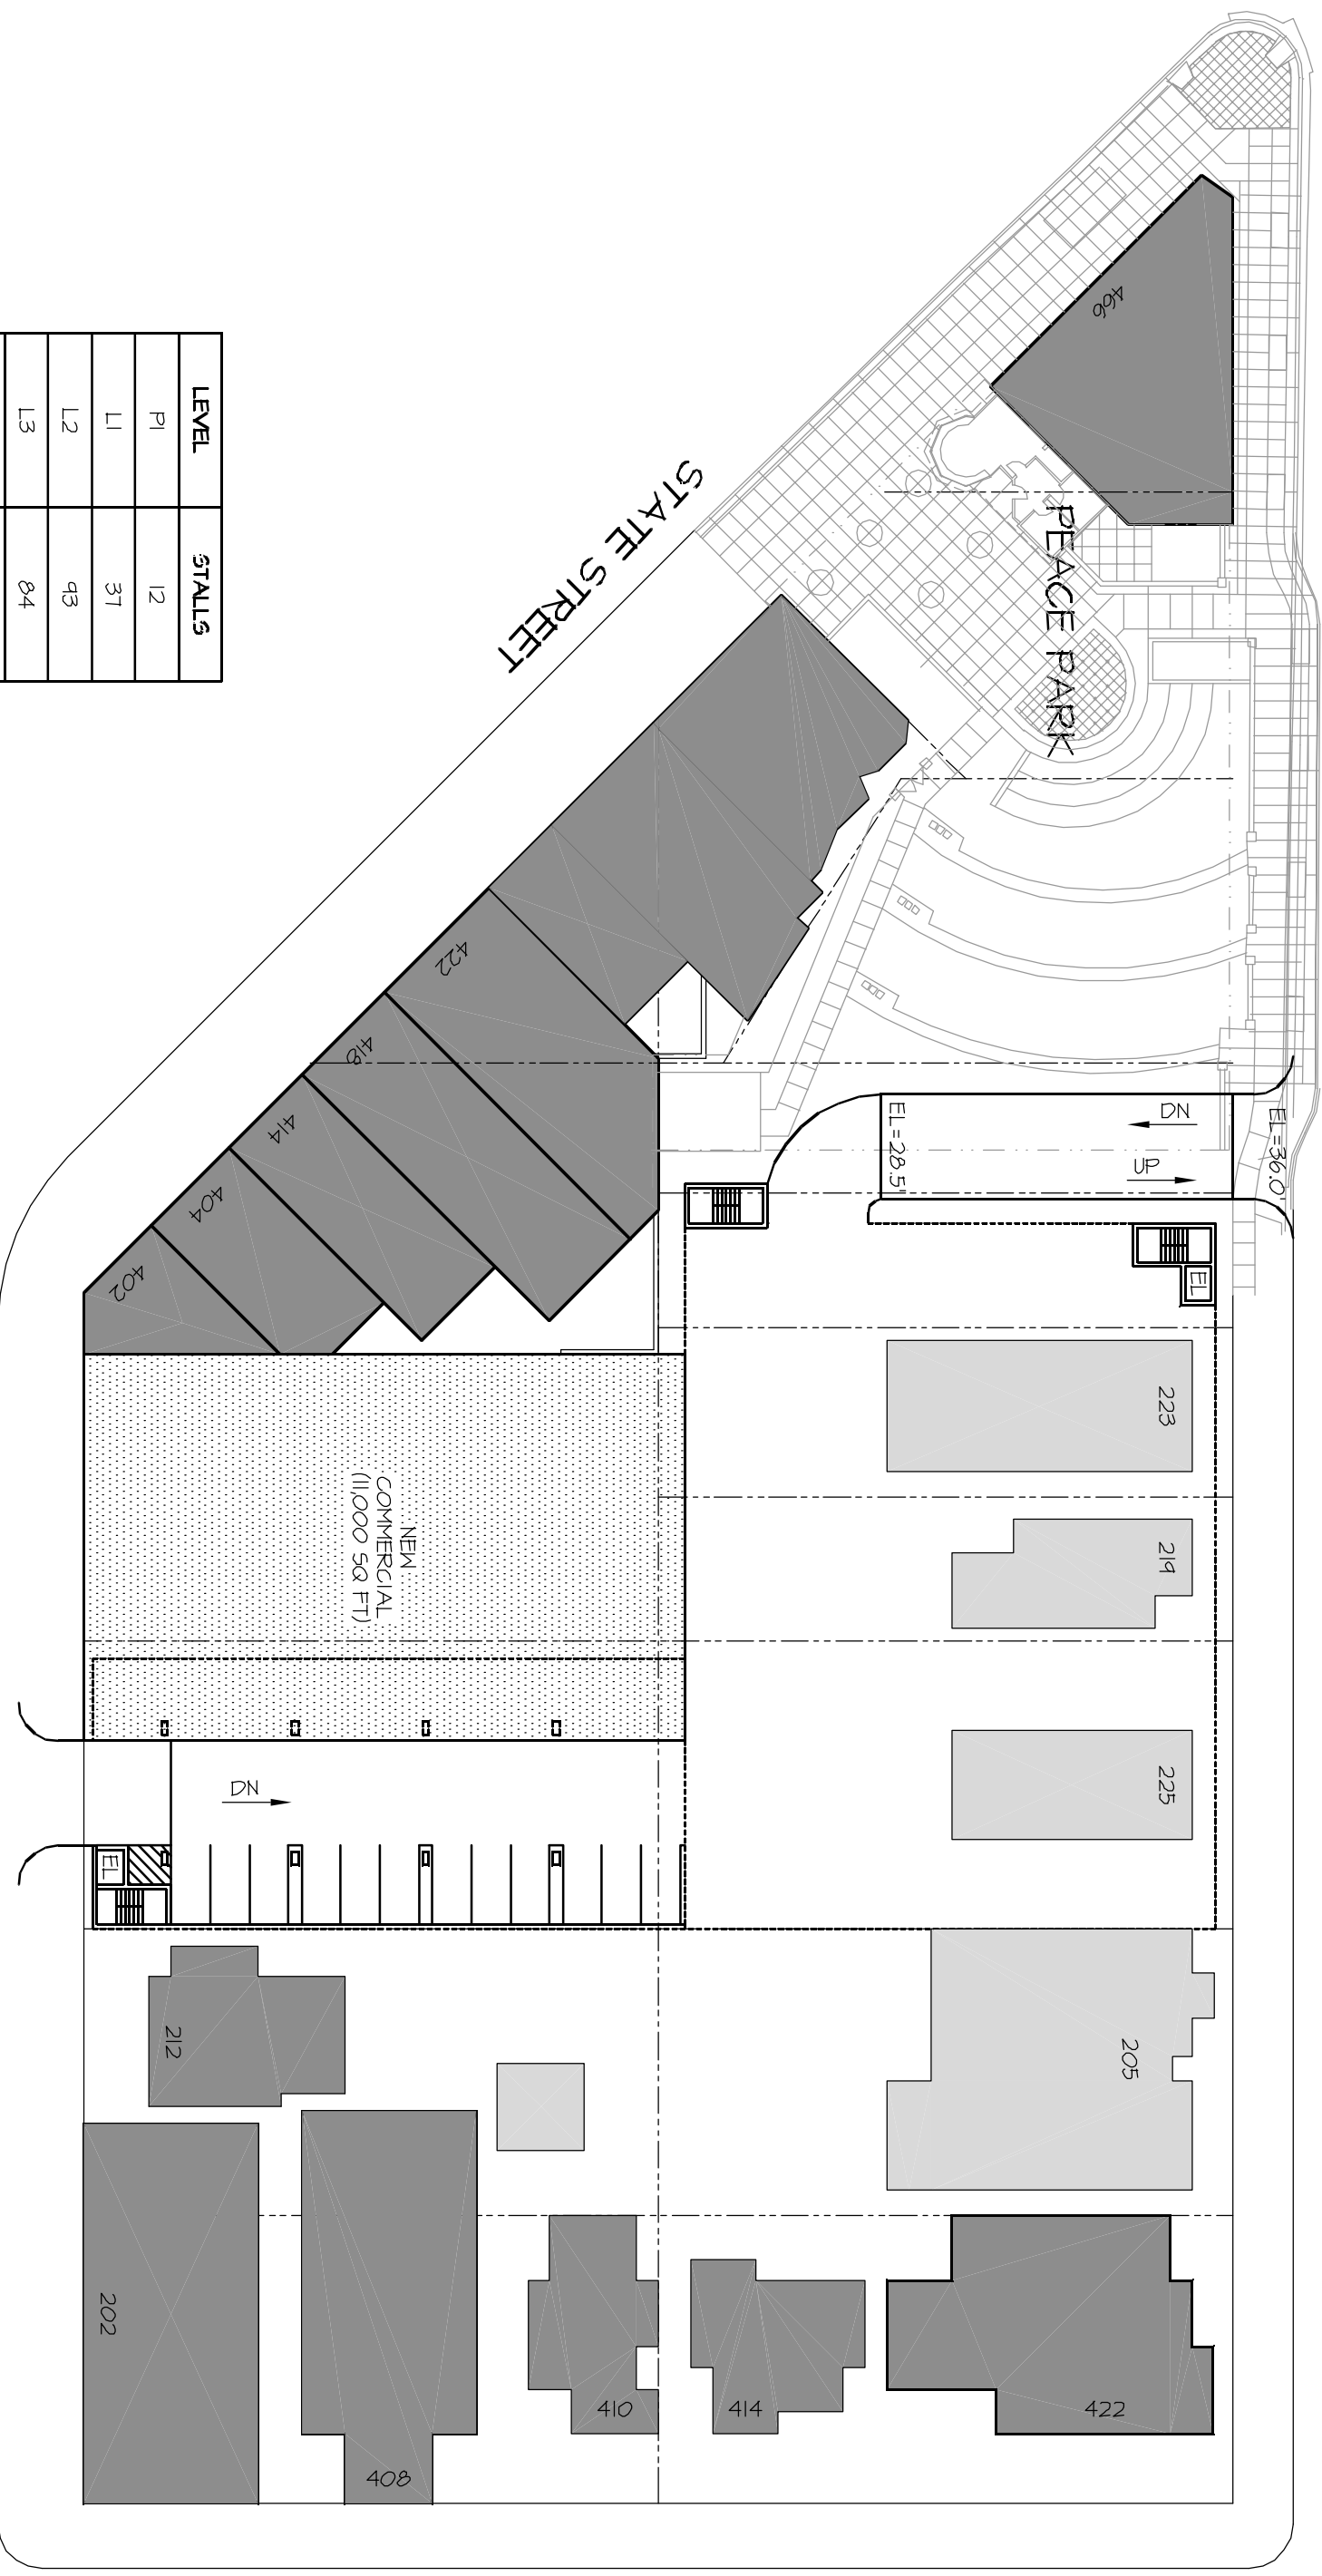

LEVEL P1 PLAN

WEST GORHAM STREET

WEST GILMAN STREET

STATE STREET

PEACE PARK

NEM
 COMMERCIAL
 (11,000 SQ FT)

EL=36.0

EL=28.5


DN

DN


EL



NORTH

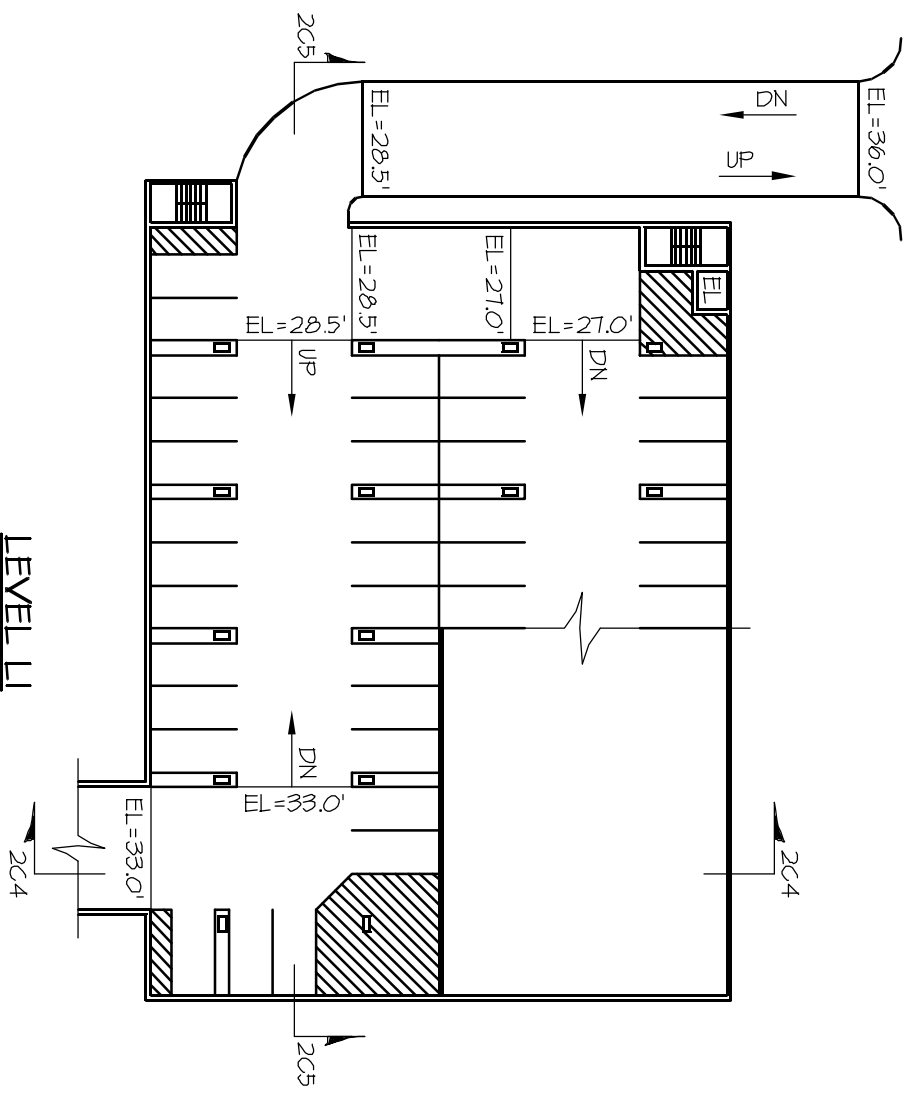

LEVEL L1

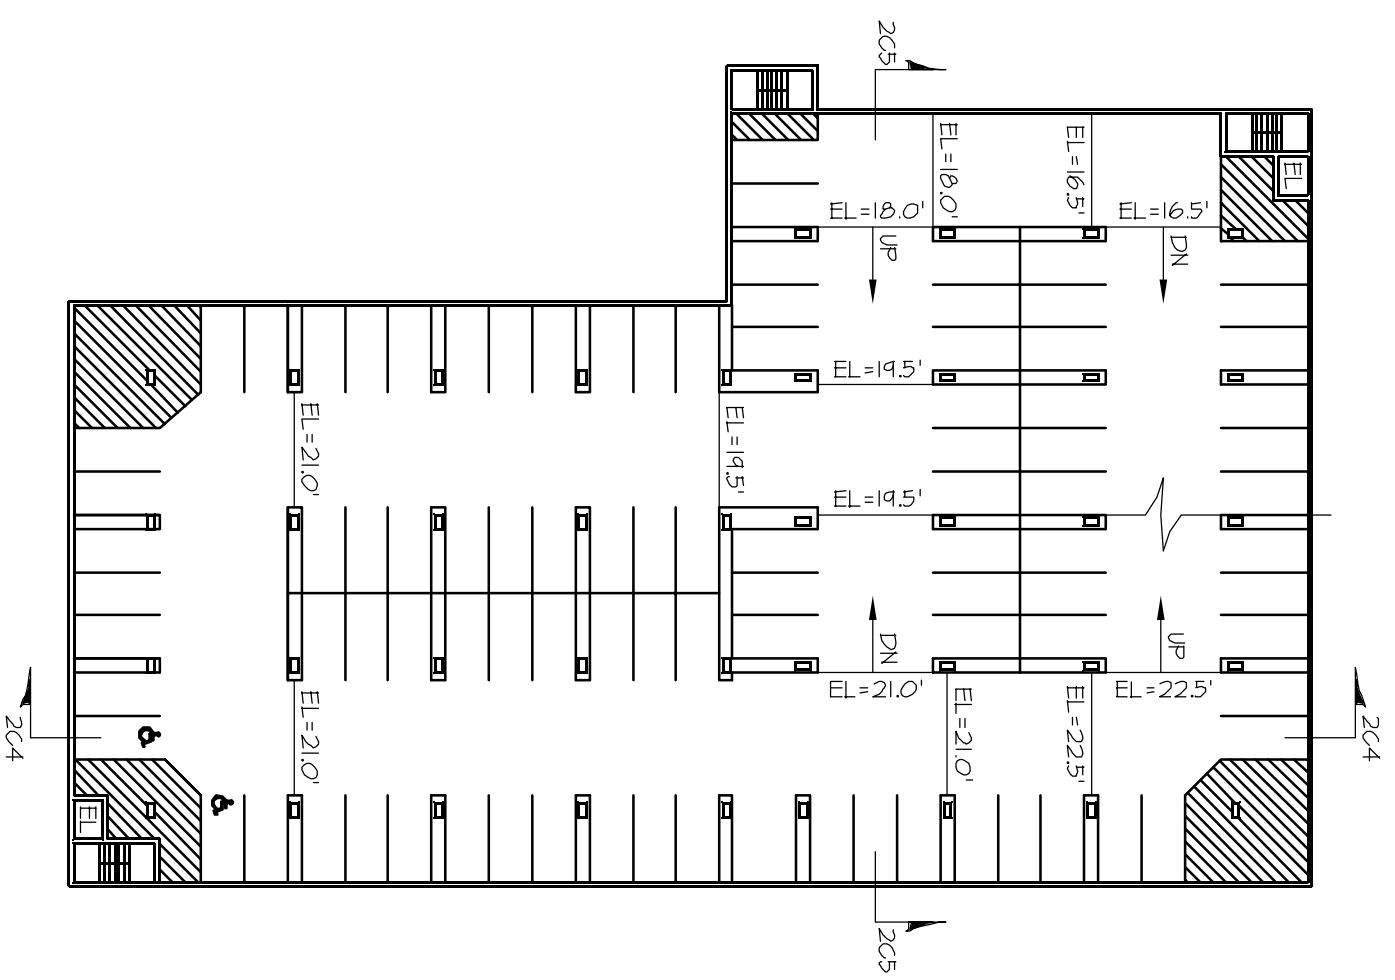

LEVEL L2

**ARNOLD AND
O'SHERIDAN INC**
CONSULTING ENGINEERS
STRUCTURAL ■ CIVIL ■ HVAC ■ PLUMBING
ELECTRICAL ■ TELECOMMUNICATIONS
MADISON, WISCONSIN (608-871-8500)
BROOKFIELD, WISCONSIN (762)733-6130
WWW.ARNOLDANDOSHERIDAN.COM

Sheet Title:
PARKING PLANS - OPTION 2C

0' 20' 40' 80'

NORTH

Project Title:
**MID STATE STREET PARKING
MADISON, WI
CITY OF MADISON PARKING UTILITY**

Drawing Number: 2C-2	
Project Number: 040069	Revised By:
Date Issued: 3-29-04	Issued With:



ARNOLD AND O'SHERIDAN INC
 CONSULTING ENGINEERS
 STRUCTURAL ■ CIVIL ■ HVAC ■ PLUMBING
 ELECTRICAL ■ TELECOMMUNICATIONS
 MADISON, WISCONSIN (608-871-8500)
 BROOKFIELD, WISCONSIN (762)733-6130
 WWW.ARNOLDANDOSHERIDAN.COM

Sheet Title:

PARKING PLANS - OPTION 2C



Project Title:

MID STATE STREET PARKING
 MADISON, WI
 CITY OF MADISON PARKING UTILITY




Drawing Number:


2C-3

Project Number: 040069
 Date Issued: 3-29-04

Revised By:
 Issued With:

LEVEL L3

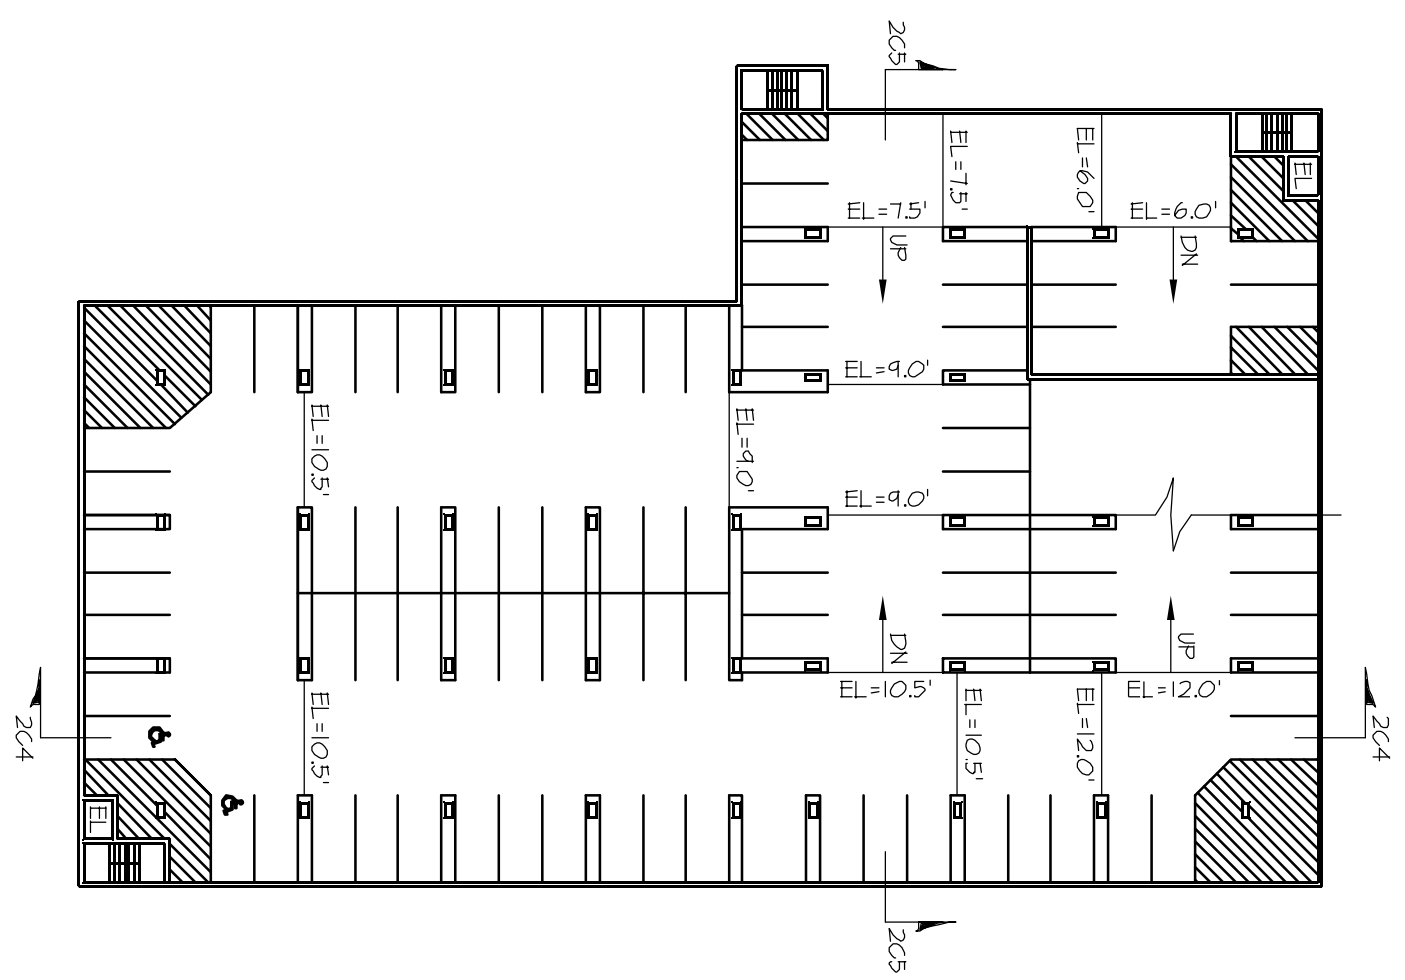

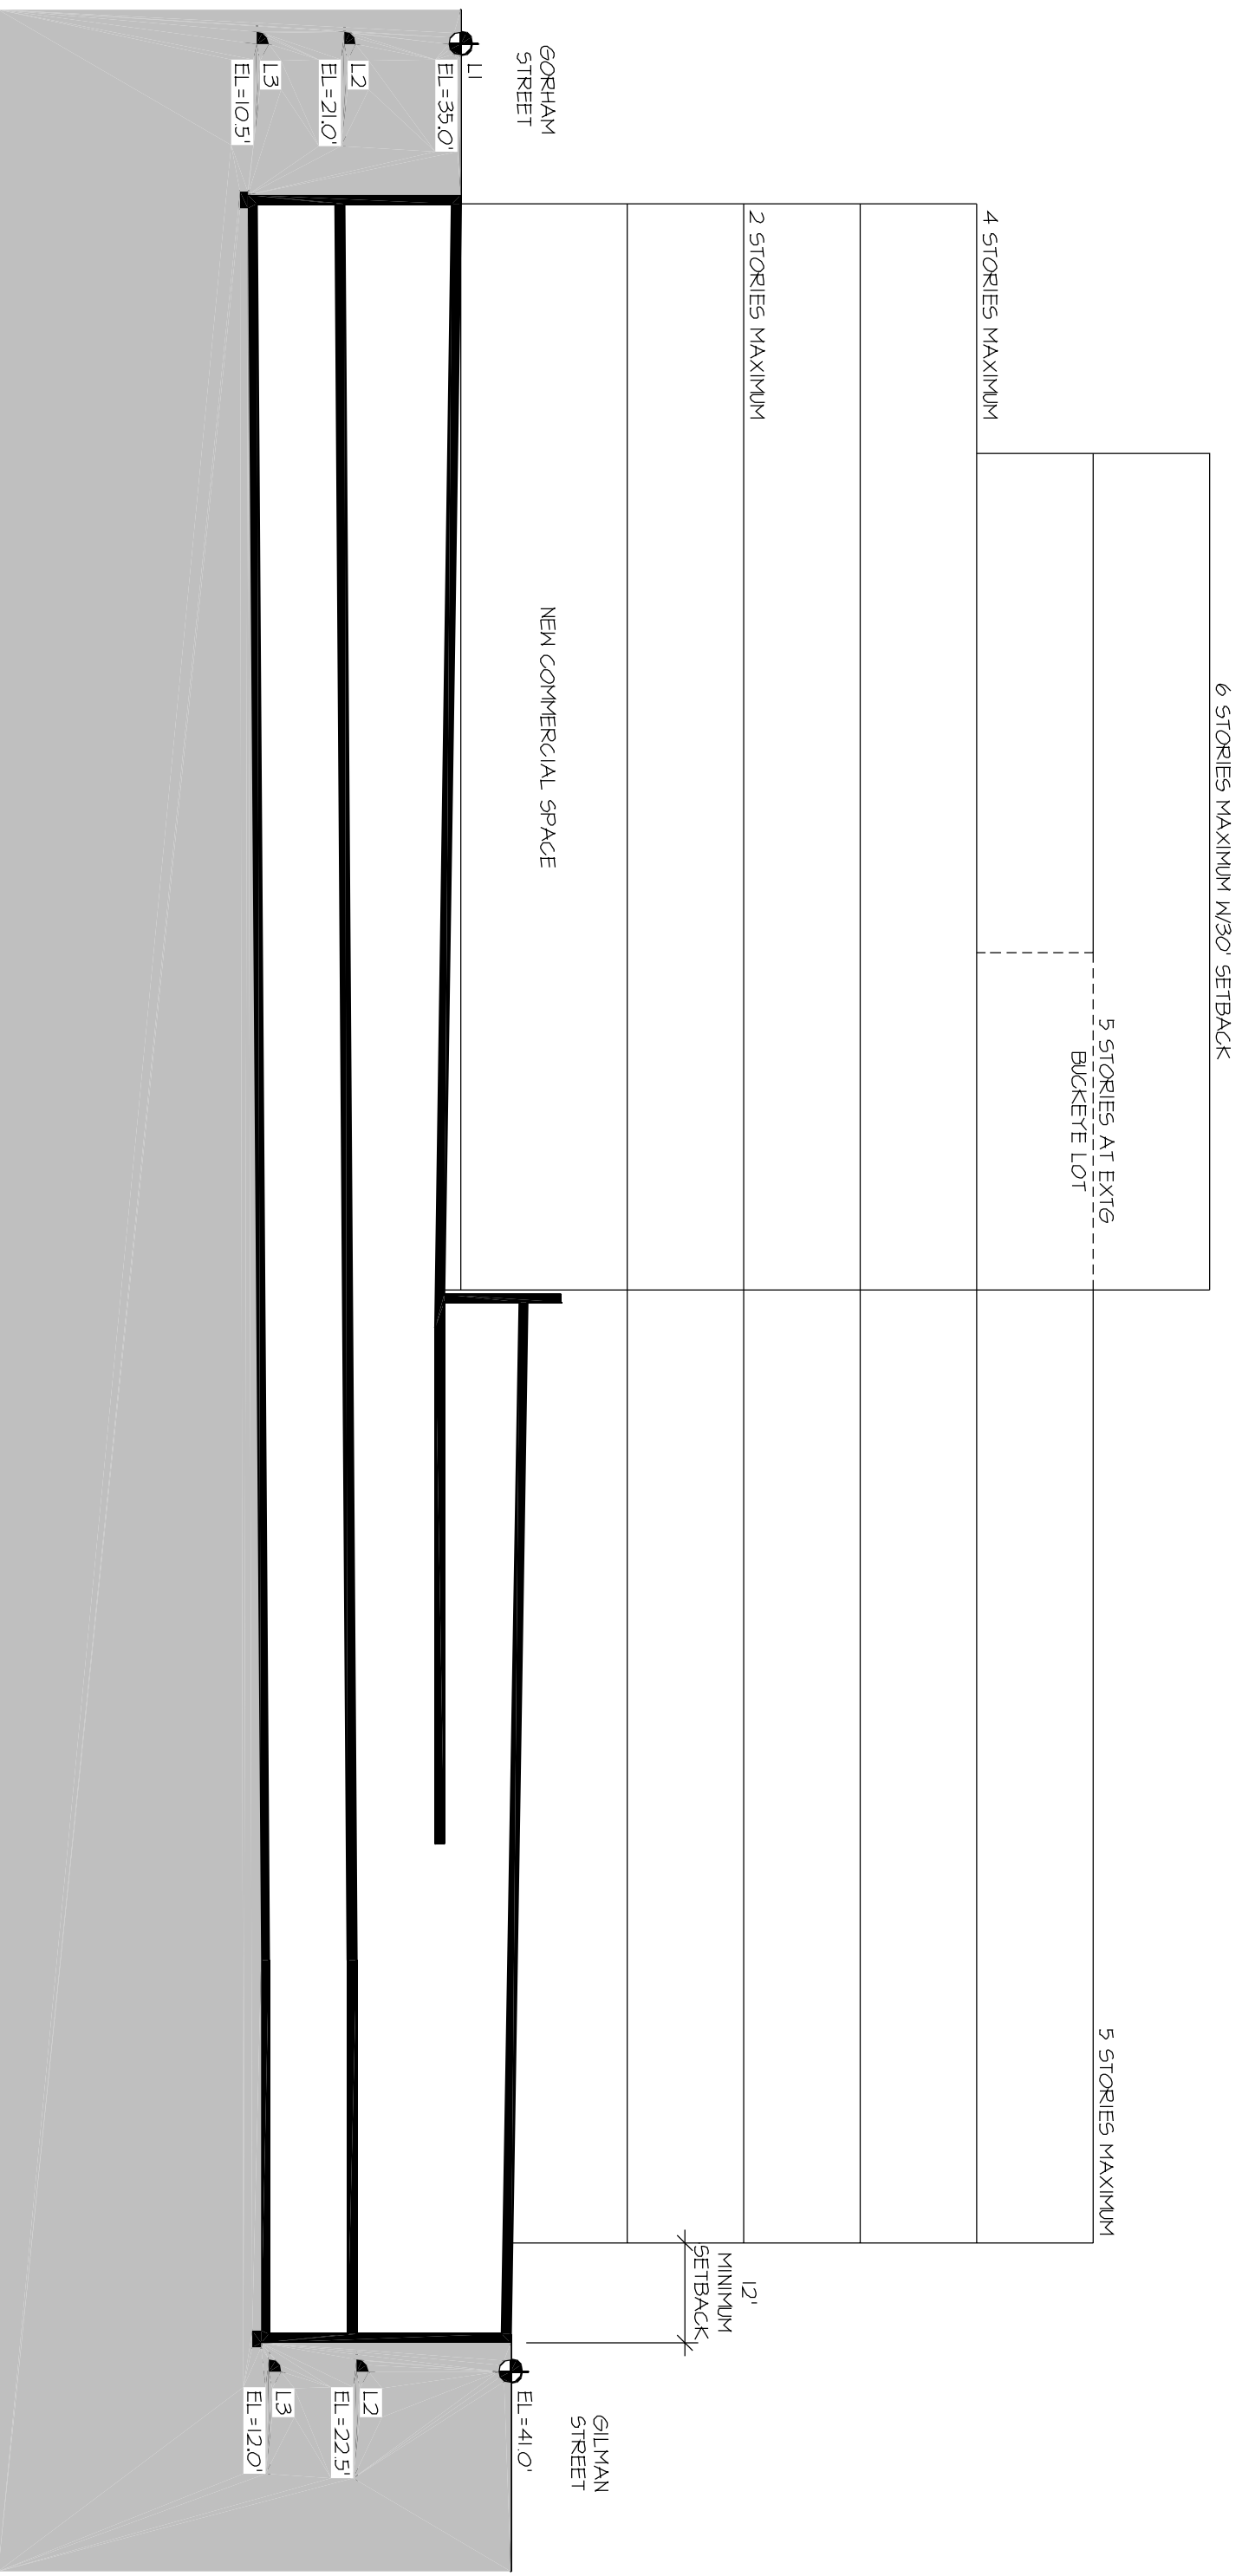

ARNOLD AND O'SHERIDAN INC.
CONSULTING ENGINEERS

STRUCTURAL ■ CIVIL ■ HVAC ■ PLUMBING
ELECTRICAL ■ TELECOMMUNICATIONS

MADISON, WISCONSIN (608-871-8500)
BROOKFIELD, WISCONSIN (762)783-6130
WWW.ARNOLDANDOSHERIDAN.COM

Sheet Title:

RAMP SECTION

0' 10' 20' 40'

NORTH

Project Title:

MID STATE STREET PARKING


MADISON, WI
CITY OF MADISON PARKING UTILITY

Drawing Number:

20-4

Project Number: 040069	Revised By:
Date Issued: 3-29-04	Issued With:

5 STORIES MAXIMUM

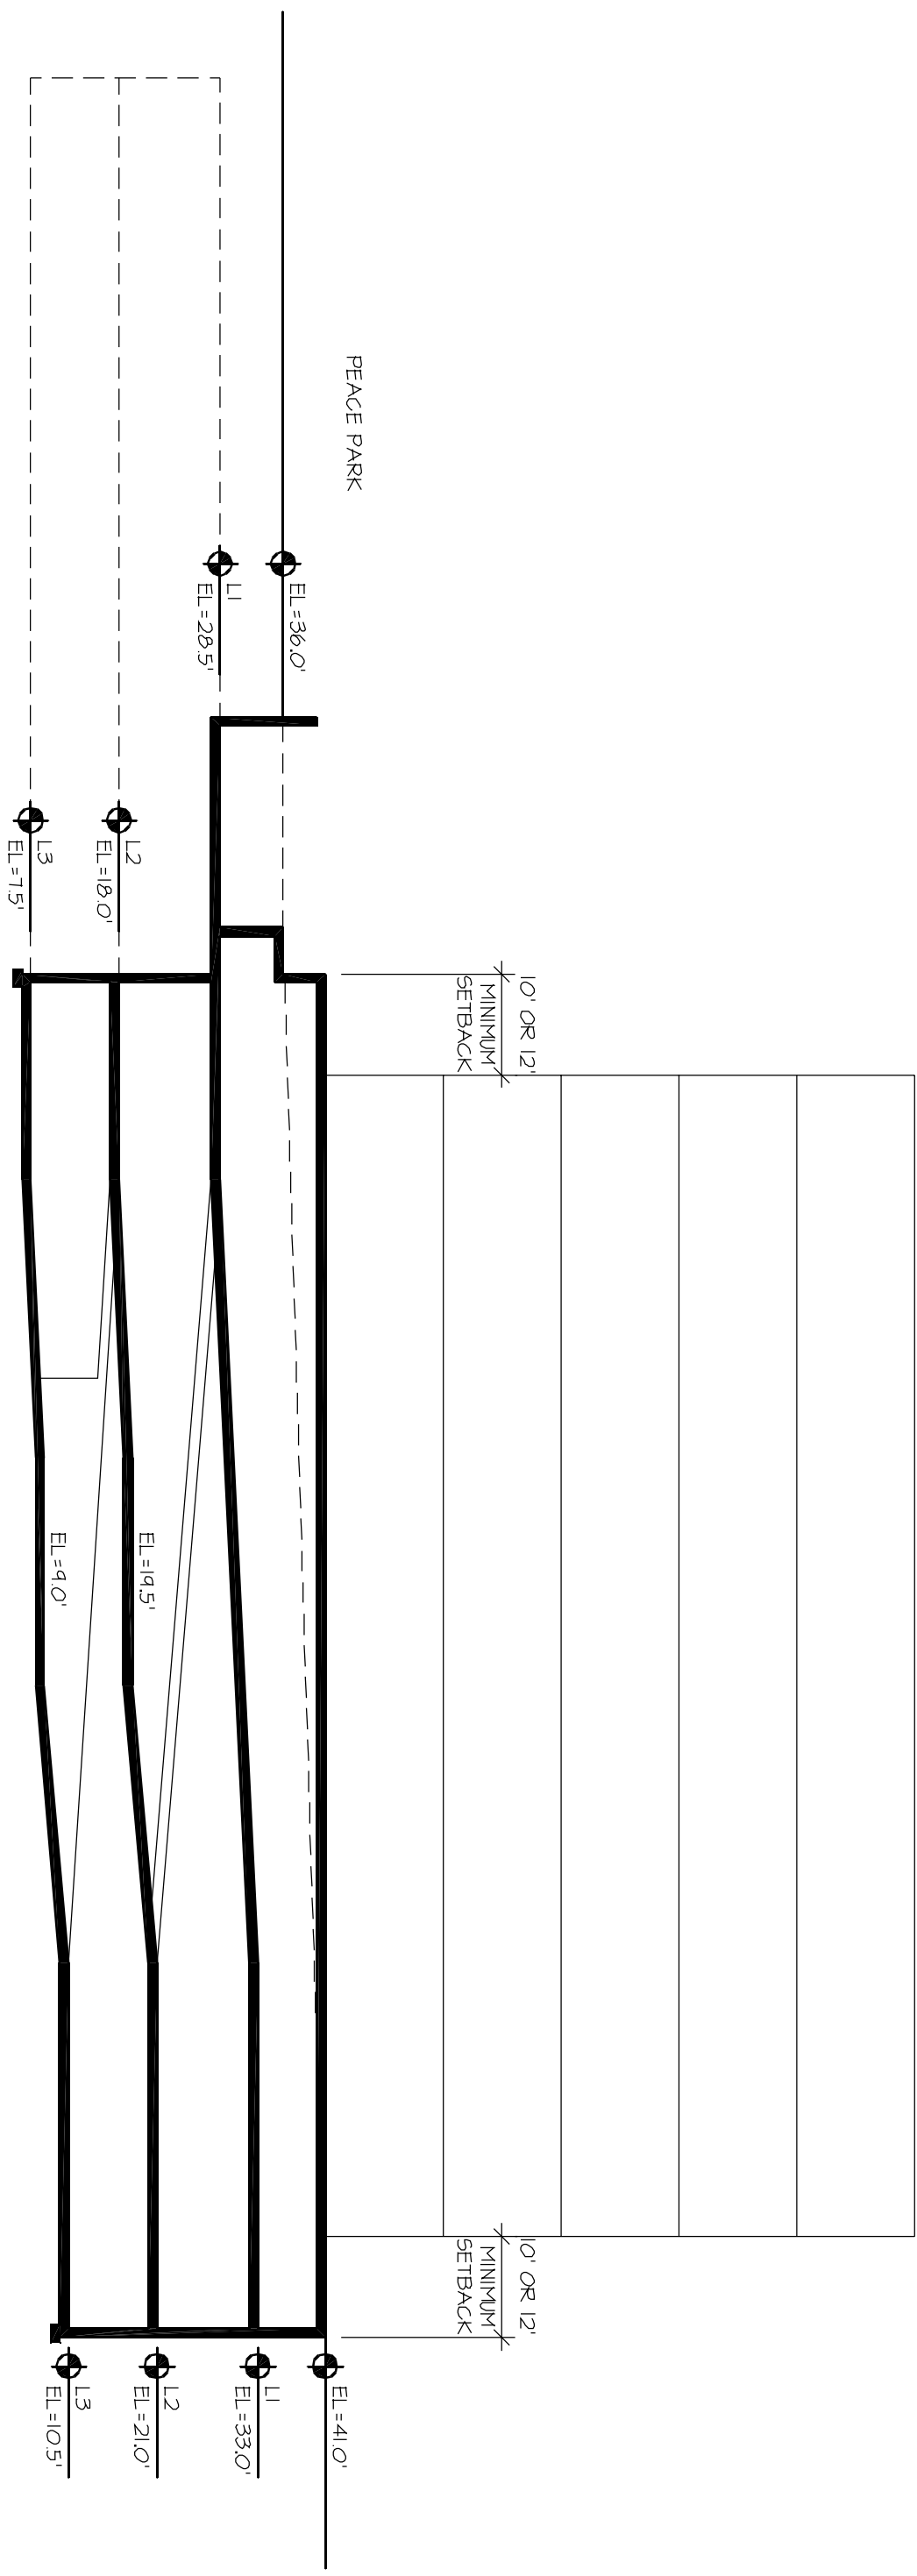

ARNOLD AND O'SHERIDAN INC
CONSULTING ENGINEERS
STRUCTURAL ■ CIVIL ■ HVAC ■ PLUMBING
ELECTRICAL ■ TELECOMMUNICATIONS
MADISON, WISCONSIN (608-871-8500)
BROOKFIELD, WISCONSIN (762)783-6130
WWW.ARNOLDANDOSHERIDAN.COM

Sheet Title:
RAMP SECTION - EASTWEST (FACING GILMAN ST)

0' 10' 20' 40'

NORTH

Project Title:
MID STATE STREET PARKING
MADISON, WI
CITY OF MADISON PARKING UTILITY

Drawing Number: 20-5	
Project Number: 040069	Revised By:
Date Issued: 3-29-04	Issued With:



ARNOLD AND O'SHERIDAN INC
 CONSULTING ENGINEERS
 STRUCTURAL ■ CIVIL ■ HVAC ■ PLUMBING
 ELECTRICAL ■ TELECOMMUNICATIONS
 MADISON, WISCONSIN (608-871-8500)
 BROOKFIELD, WISCONSIN (762)733-6130
 WWW.ARNOLDANDOSHERIDAN.COM

Sheet Title:

PARKING PLANS - OPTION 2C



Project Title:

MID STATE STREET PARKING
 MADISON, WI
 CITY OF MADISON PARKING UTILITY

Drawing Number:

2C-6

Project Number: 040069
 Date Issued: 3-29-04

Revised By:

Issued With:

LEVEL L2

