



ARNOLD AND O'SHERIDAN INC
 CONSULTING ENGINEERS
 STRUCTURAL ■ CIVIL ■ HVAC ■ PLUMBING
 ELECTRICAL ■ TELECOMMUNICATIONS
 MADISON, WISCONSIN (608-871-8500)
 BROOKFIELD, WISCONSIN (762)783-6130
 WWW.ARNOLDANDOSHERIDAN.COM

Sheet Title:

SITE PLAN - OPTION 2D



Project Title:


MID STATE STREET PARKING
 MADISON, WI
 CITY OF MADISON PARKING UTILITY

Drawing Number:

2D-1

Project Number: 040069
 Date Issued: 3-29-04
 Revised By:
 Issued With:

LEVEL	STALLS
P1	8
L1	84
L2	42
L3	34
TOTAL	223

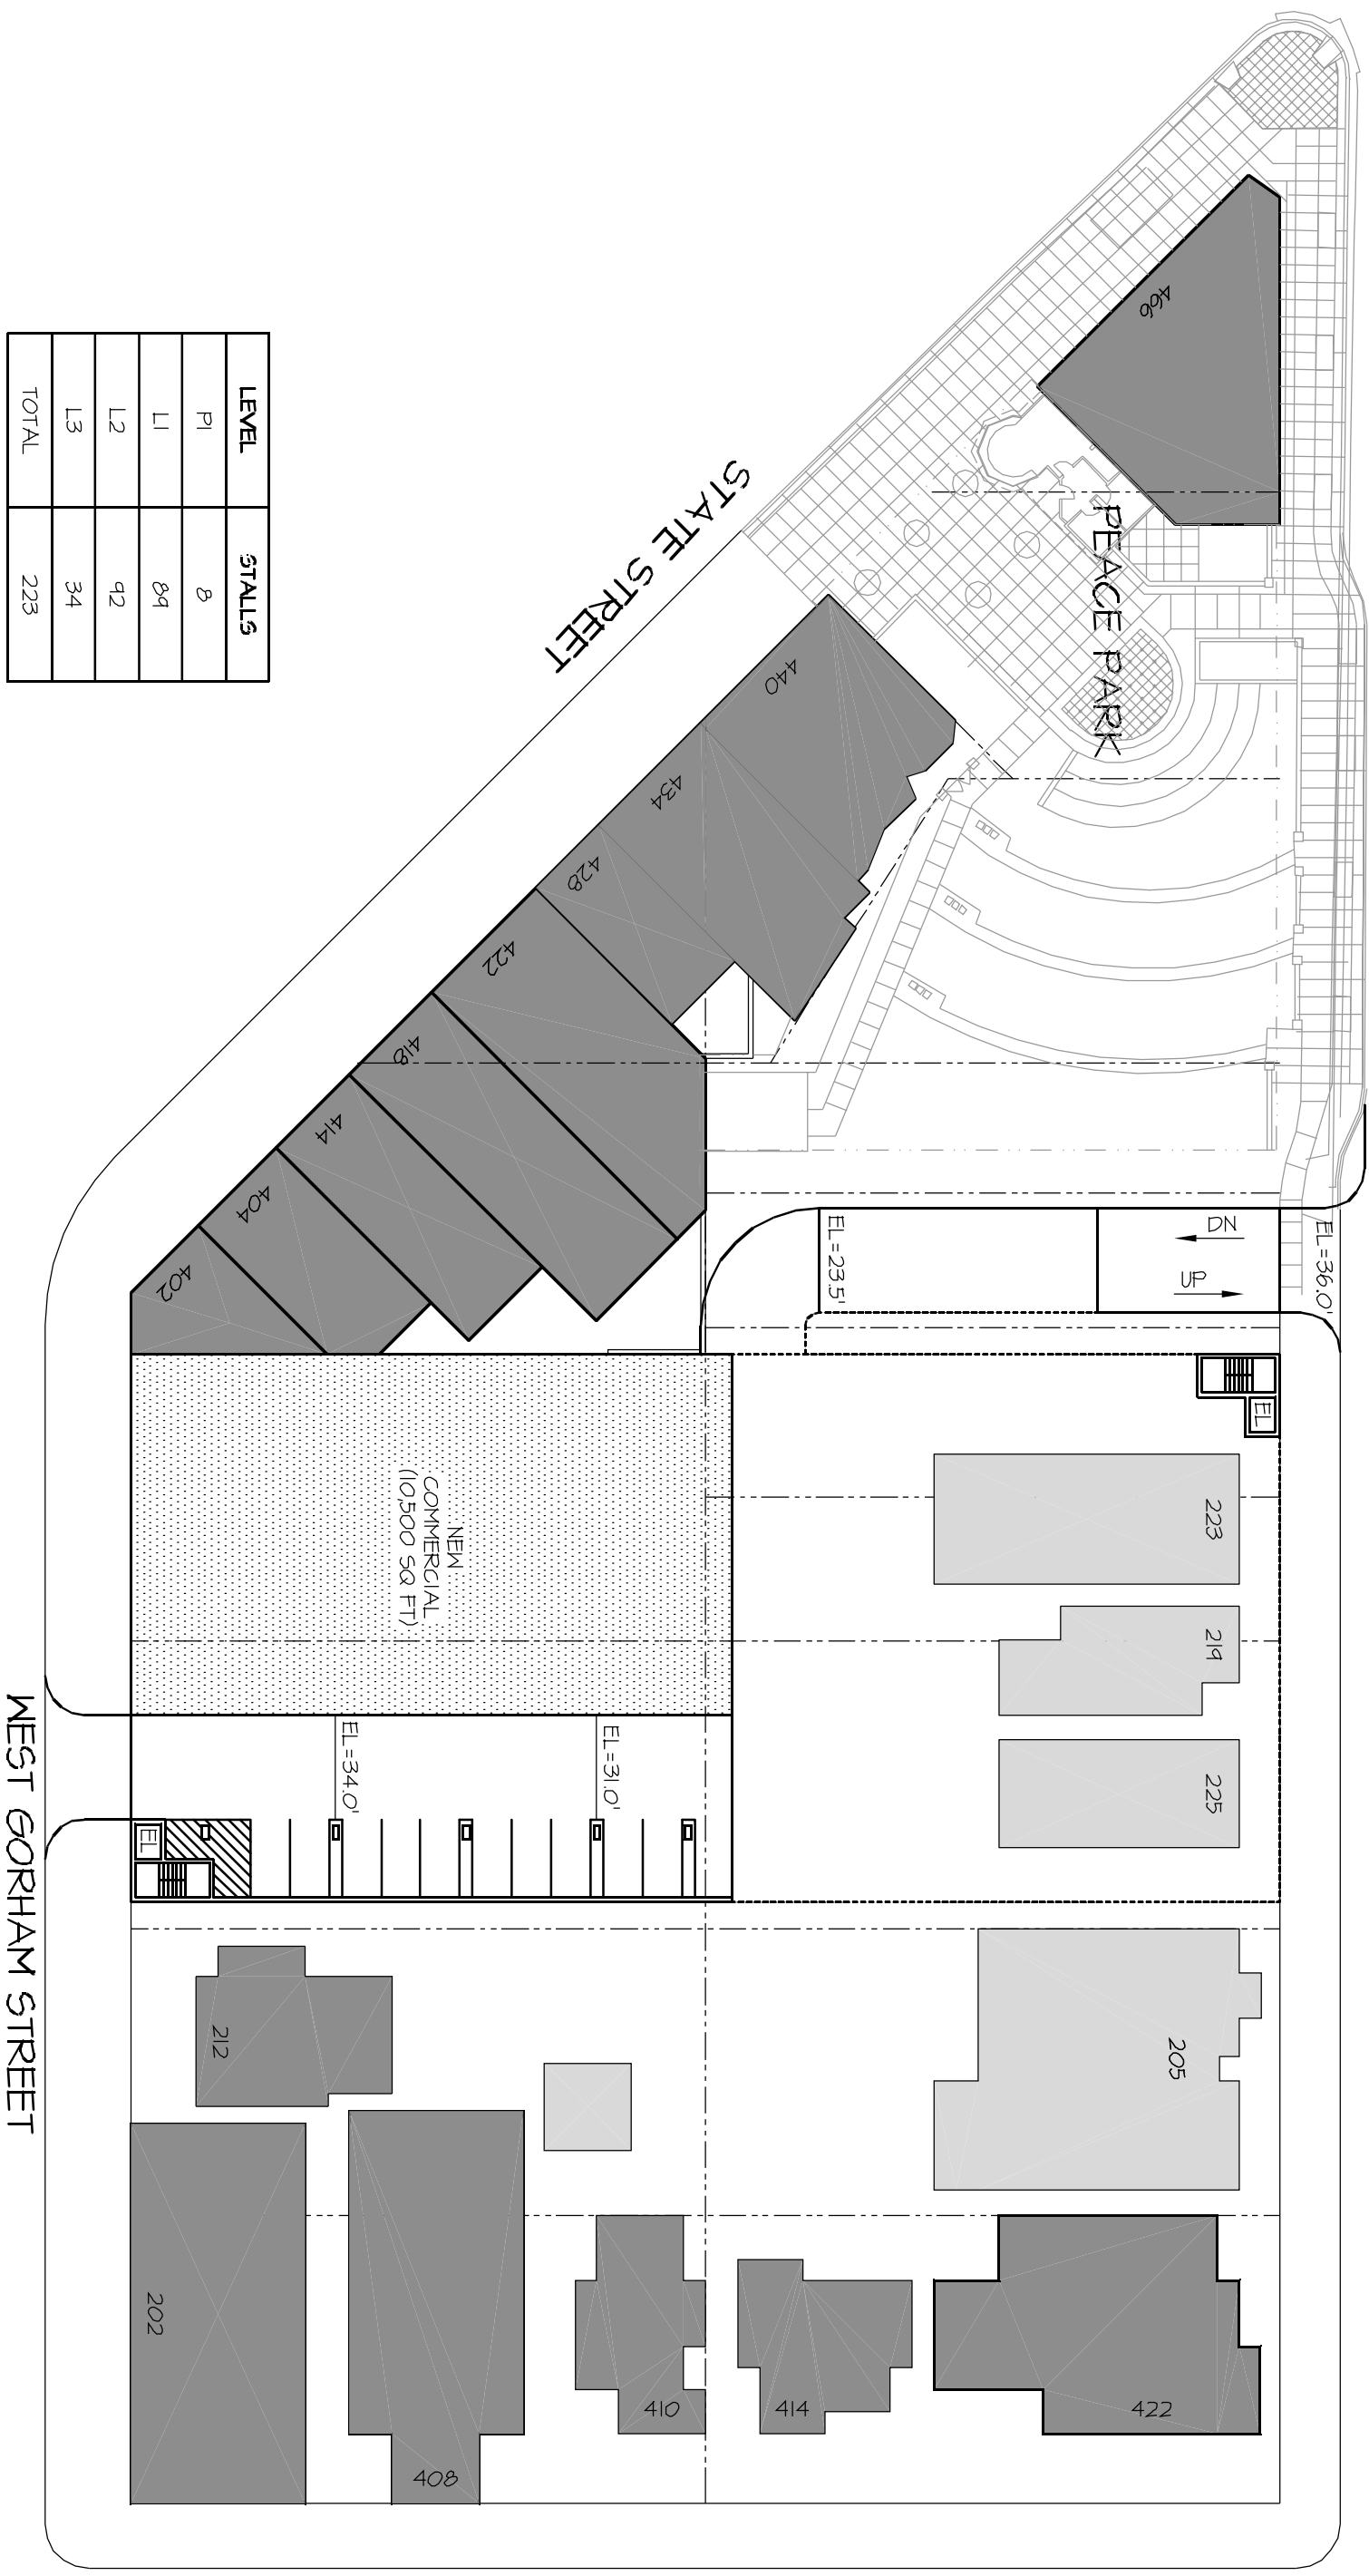




LEVEL P1 PLAN

WEST GORHAM STREET

WEST GILMAN STREET

PEACE PARK

STATE STREET

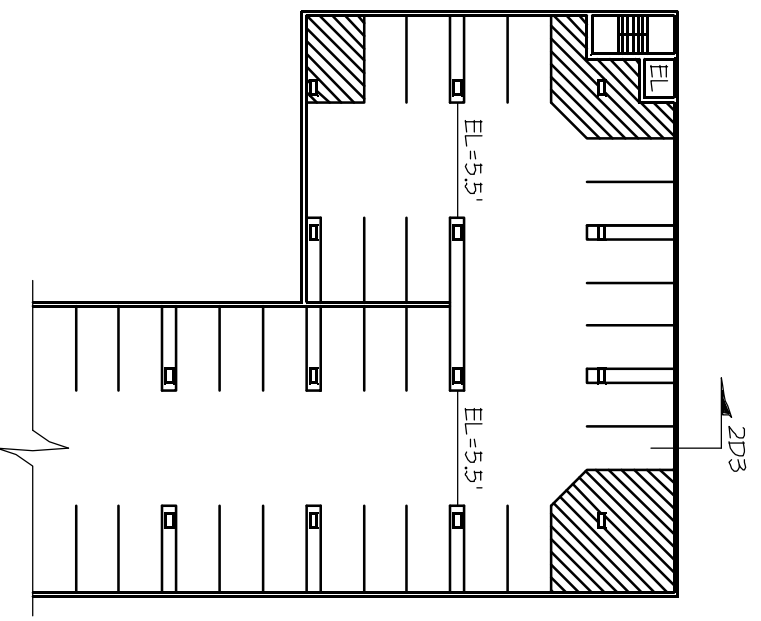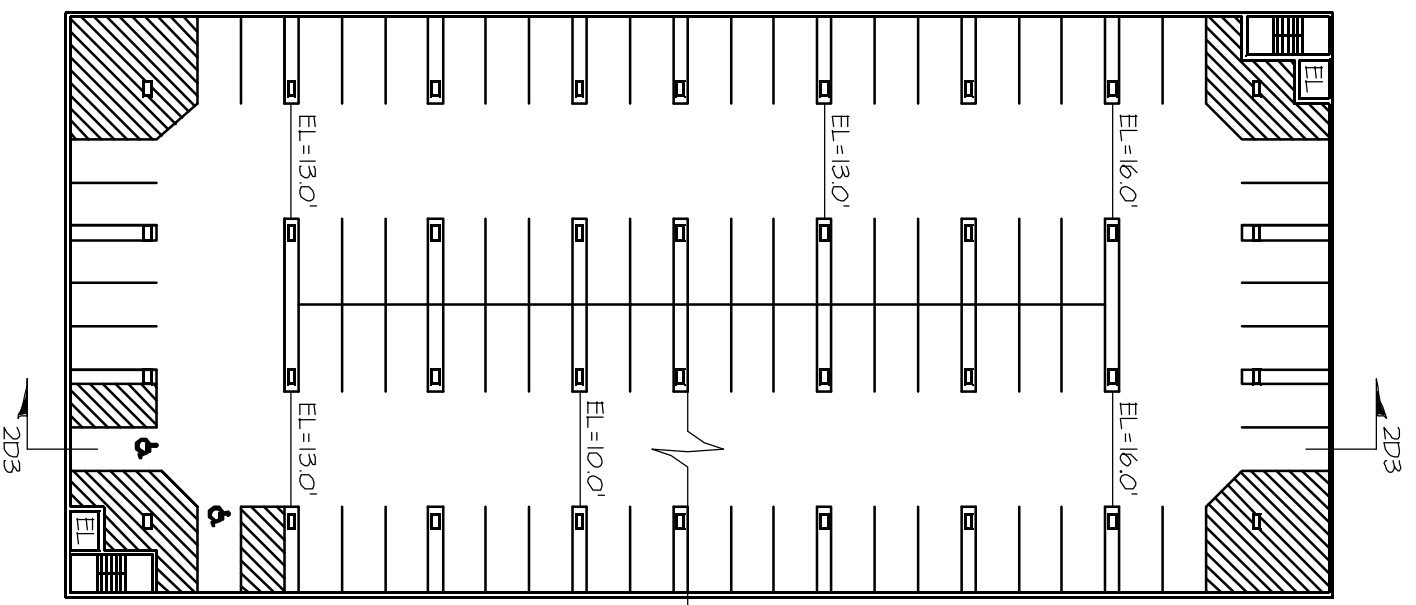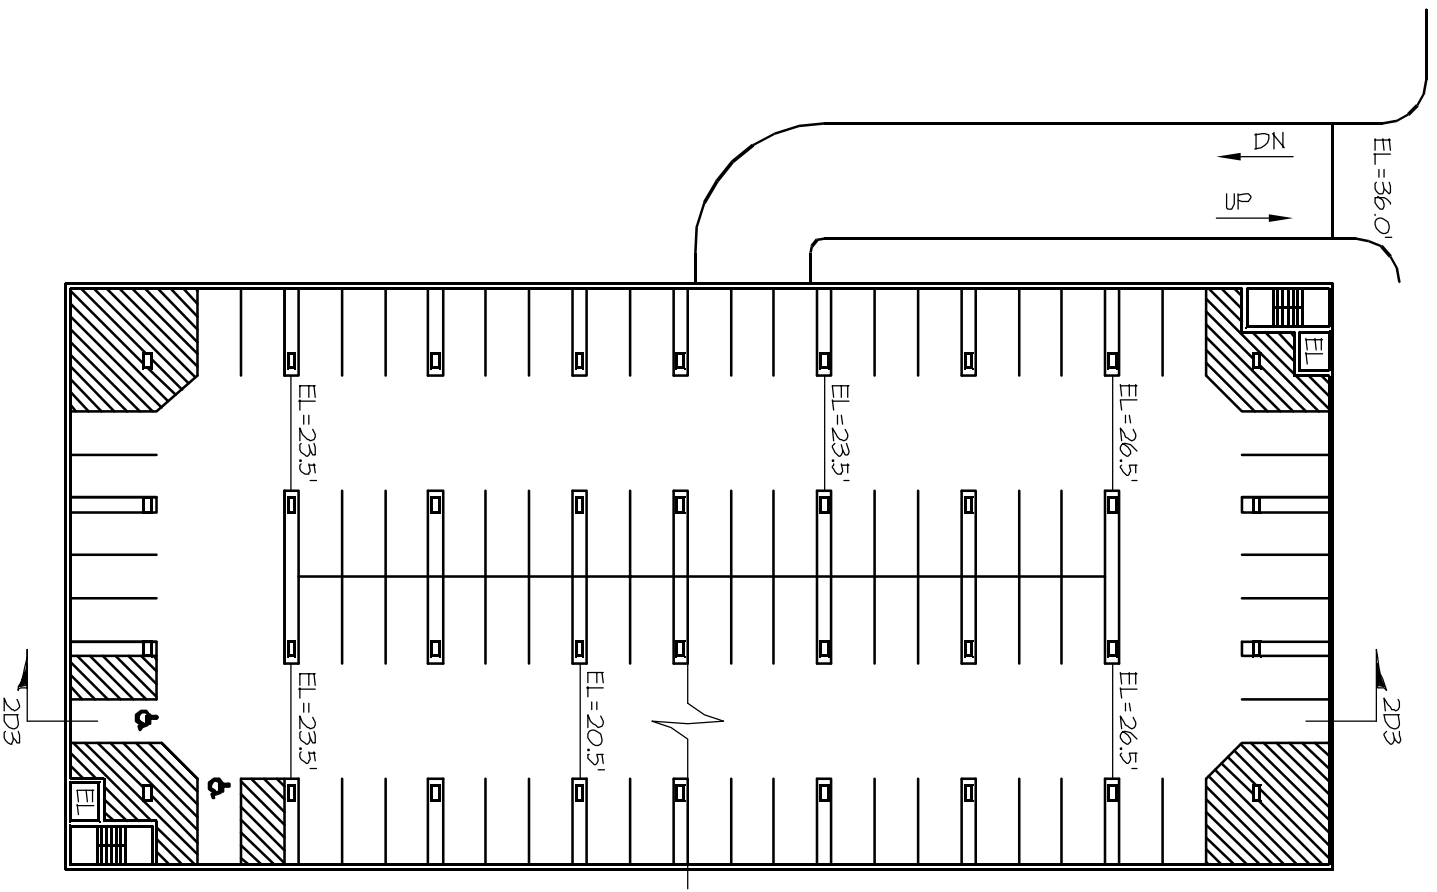

ARNOLD AND O'SHERIDAN INC.
CONSULTING ENGINEERS
STRUCTURAL ■ CIVIL ■ HVAC ■ PLUMBING
ELECTRICAL ■ TELECOMMUNICATIONS
MADISON, WISCONSIN (608-871-8500)
BROOKFIELD, WISCONSIN (762)733-6130
WWW.ARNOLDANDOSHERIDAN.COM


Sheet Title:
PARKING PLANS - OPTION 2D

0' 20' 40' 80'

NORTH

Project Title:
MID STATE STREET PARKING
MADISON, WI
CITY OF MADISON PARKING UTILITY

Drawing Number: 2D-2	
Project Number: 040069	Revised By:
Date Issued: 3-29-04	Issued With:

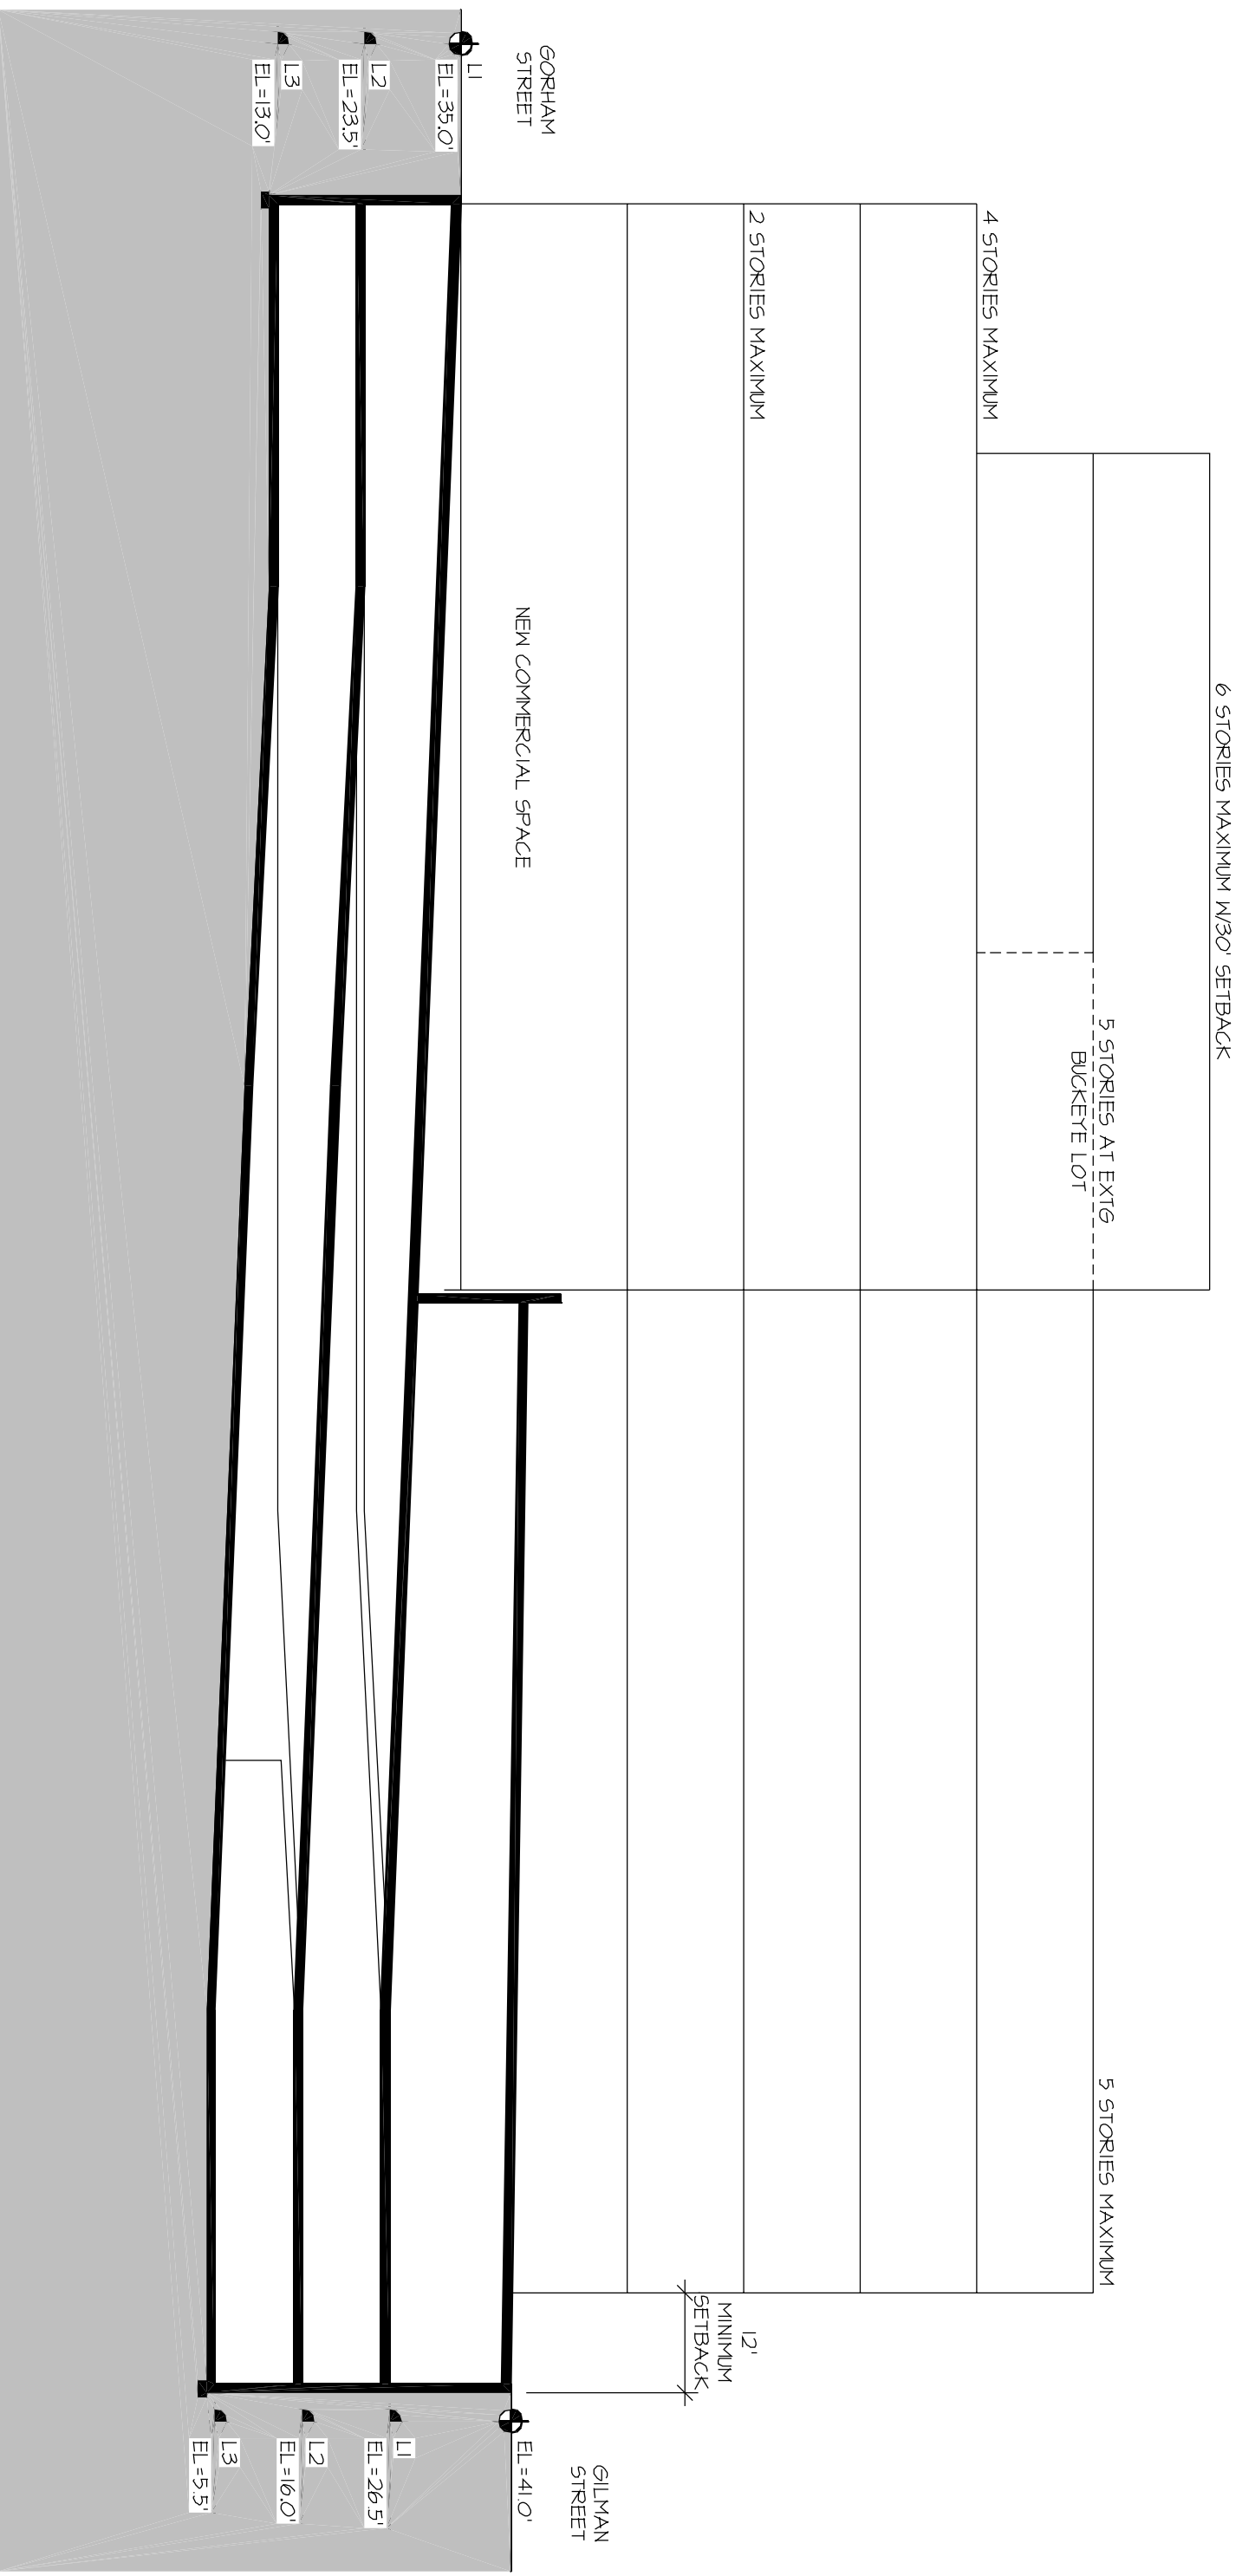

ARNOLD AND O'SHERIDAN INC.
CONSULTING ENGINEERS

STRUCTURAL ■ CIVIL ■ HVAC ■ PLUMBING
ELECTRICAL ■ TELECOMMUNICATIONS

MADISON, WISCONSIN (608-871-8500)
BROOKFIELD, WISCONSIN (762)783-6130
WWW.ARNOLDANDOSHERIDAN.COM

Sheet Title:

RAMP SECTION

0' 10' 20' 40'




Project Title:

MID STATE STREET PARKING
MADISON, WI
CITY OF MADISON PARKING UTILITY


Drawing Number:

2D-3

Project Number: 040069	Revised By:
Date Issued: 3-29-04	Issued With:

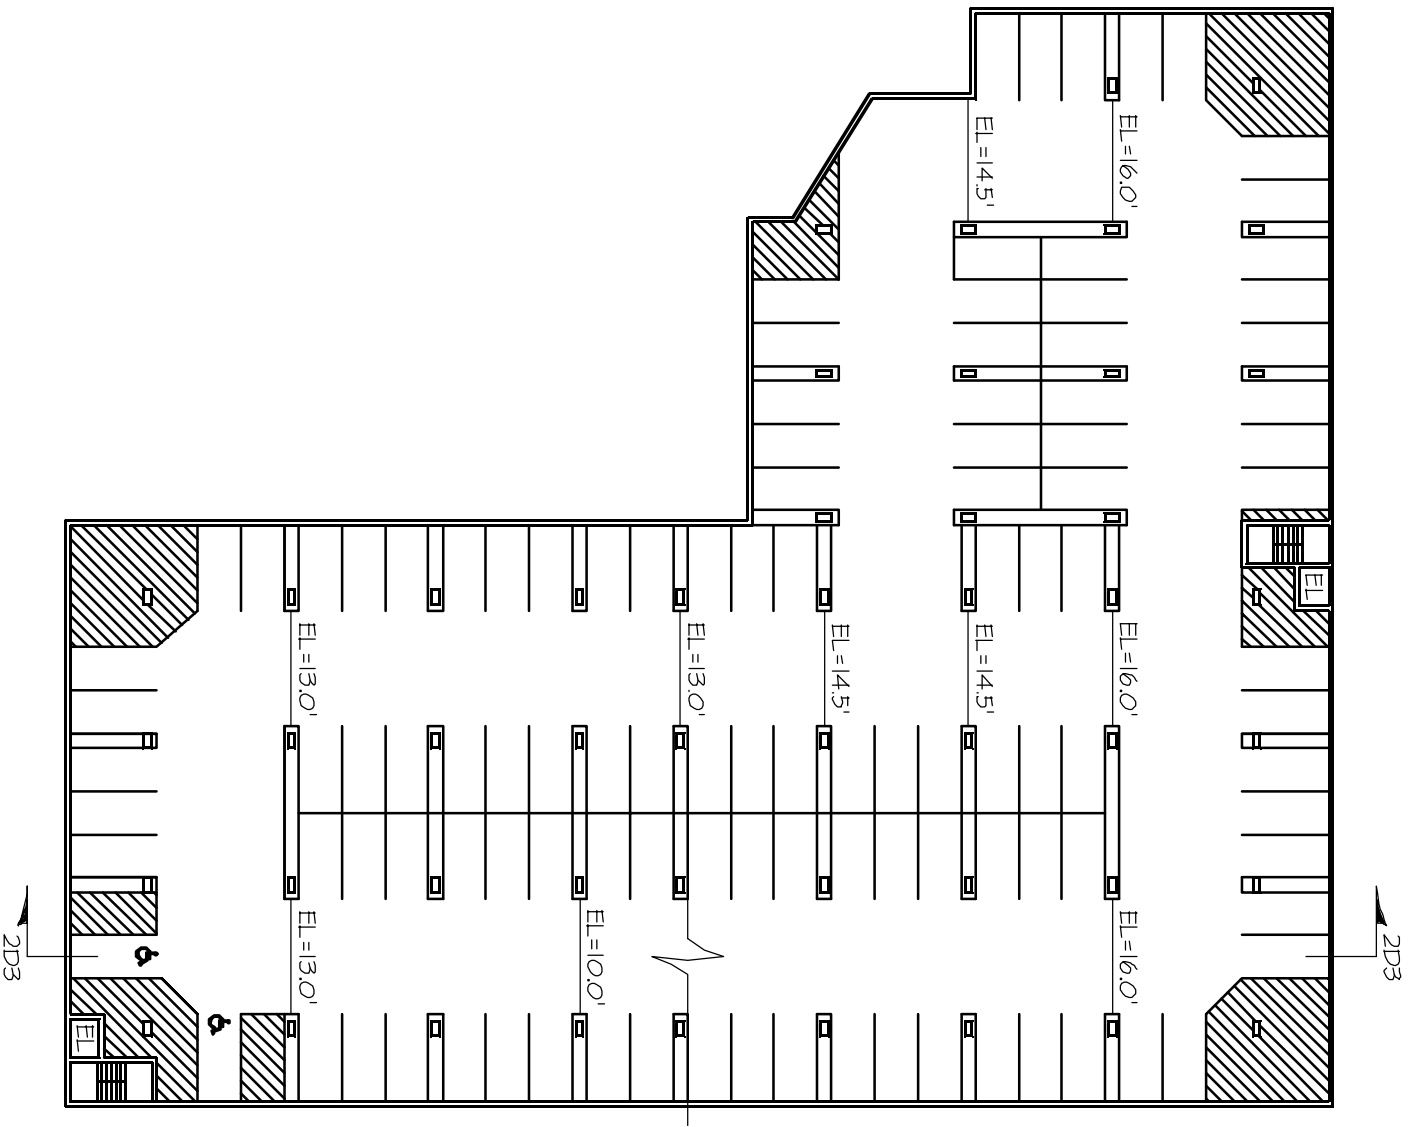

LEVEL L2

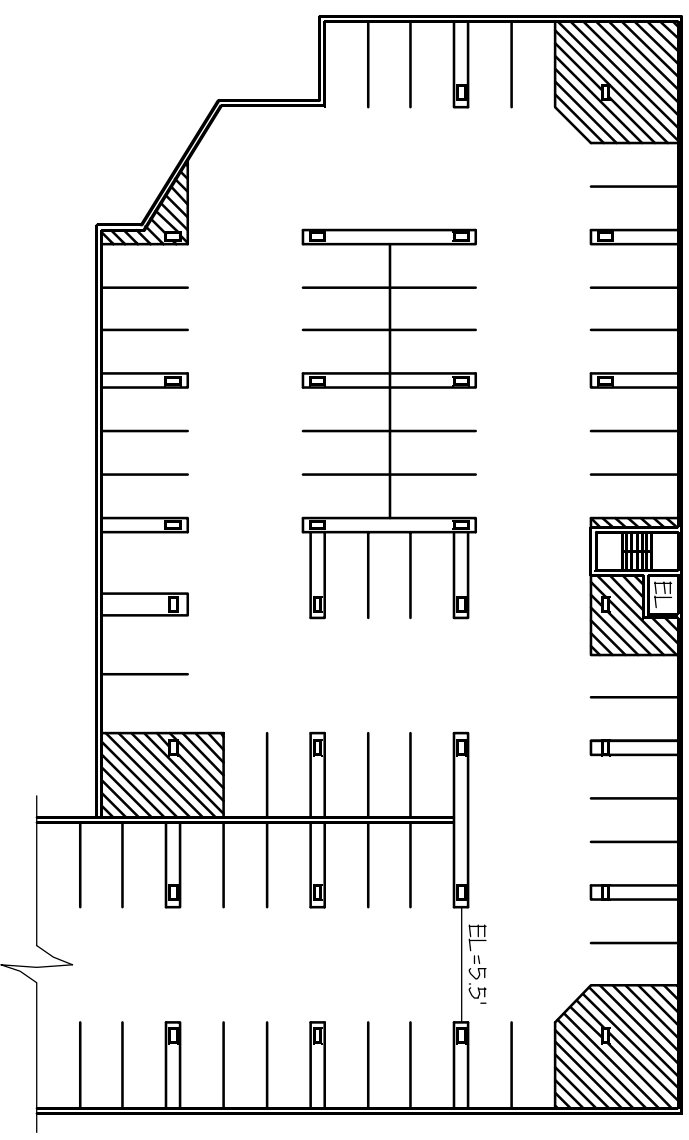

LEVEL L3



**ARNOLD AND
O'SHERIDAN INC**
CONSULTING ENGINEERS
STRUCTURAL ■ CIVIL ■ HVAC ■ PLUMBING
ELECTRICAL ■ TELECOMMUNICATIONS
MADISON, WISCONSIN (608-871-8500)
BROOKFIELD, WISCONSIN (762)733-6130
WWW.ARNOLDANDOSHERIDAN.COM

Sheet Title:

PARKING PLANS - OPTION 2D



Project Title:

**MID STATE STREET PARKING
MADISON, WI
CITY OF MADISON PARKING UTILITY**



Drawing Number:

2D-4

Project Number: 040069	Revised By:
Date Issued: 3-29-04	Issued With: