 


ARNOLD AND O'SHERIDAN INC.
 CONSULTING ENGINEERS
 STRUCTURAL ■ CIVIL ■ HVAC ■ PLUMBING
 ELECTRICAL ■ TELECOMMUNICATIONS
 MADISON, WISCONSIN (608-821-8300)
 BROOKFIELD, WISCONSIN (762) 83-6130
 WWW.ARNOLDANDOSHERIDAN.COM

Sheet Title:
BLOCK PLAN - OPTION 2



Project Title:
MID STATE STREET PARKING
 MADISON, WI
 CITY OF MADISON PARKING UTILITY

Drawing Number:
2

Project Number: 040069	Revised By:
Date Issued: 5-24-04	Issued With:



ARNOLD AND O'SHERIDAN INC
 CONSULTING ENGINEERS
 STRUCTURAL ■ CIVIL ■ HVAC ■ PLUMBING
 ELECTRICAL ■ TELECOMMUNICATIONS
 MADISON, WISCONSIN (608-821-8500)
 BROOKFIELD, WISCONSIN (262) 783-6130
 WWW.ARNOLDANDOSHERIDAN.COM

Sheet Title:

SITE PLAN - OPTION 2F

Project Title:

MID STATE STREET PARKING
 MADISON, WI
 CITY OF MADISON PARKING UTILITY


Drawing Number:

2F-1

Project Number: 040069	Revised By:
Date Issued: 5-24-04	Issued With:

LEVEL	STALLS		TOTAL
	PRIVATE	PUBLIC	
P1	0	24	24
L1	0	67	67
L2	0	118	118
L3	12	100	112
L4	12	0	12
	84	309	393

LEVEL P1 PLAN

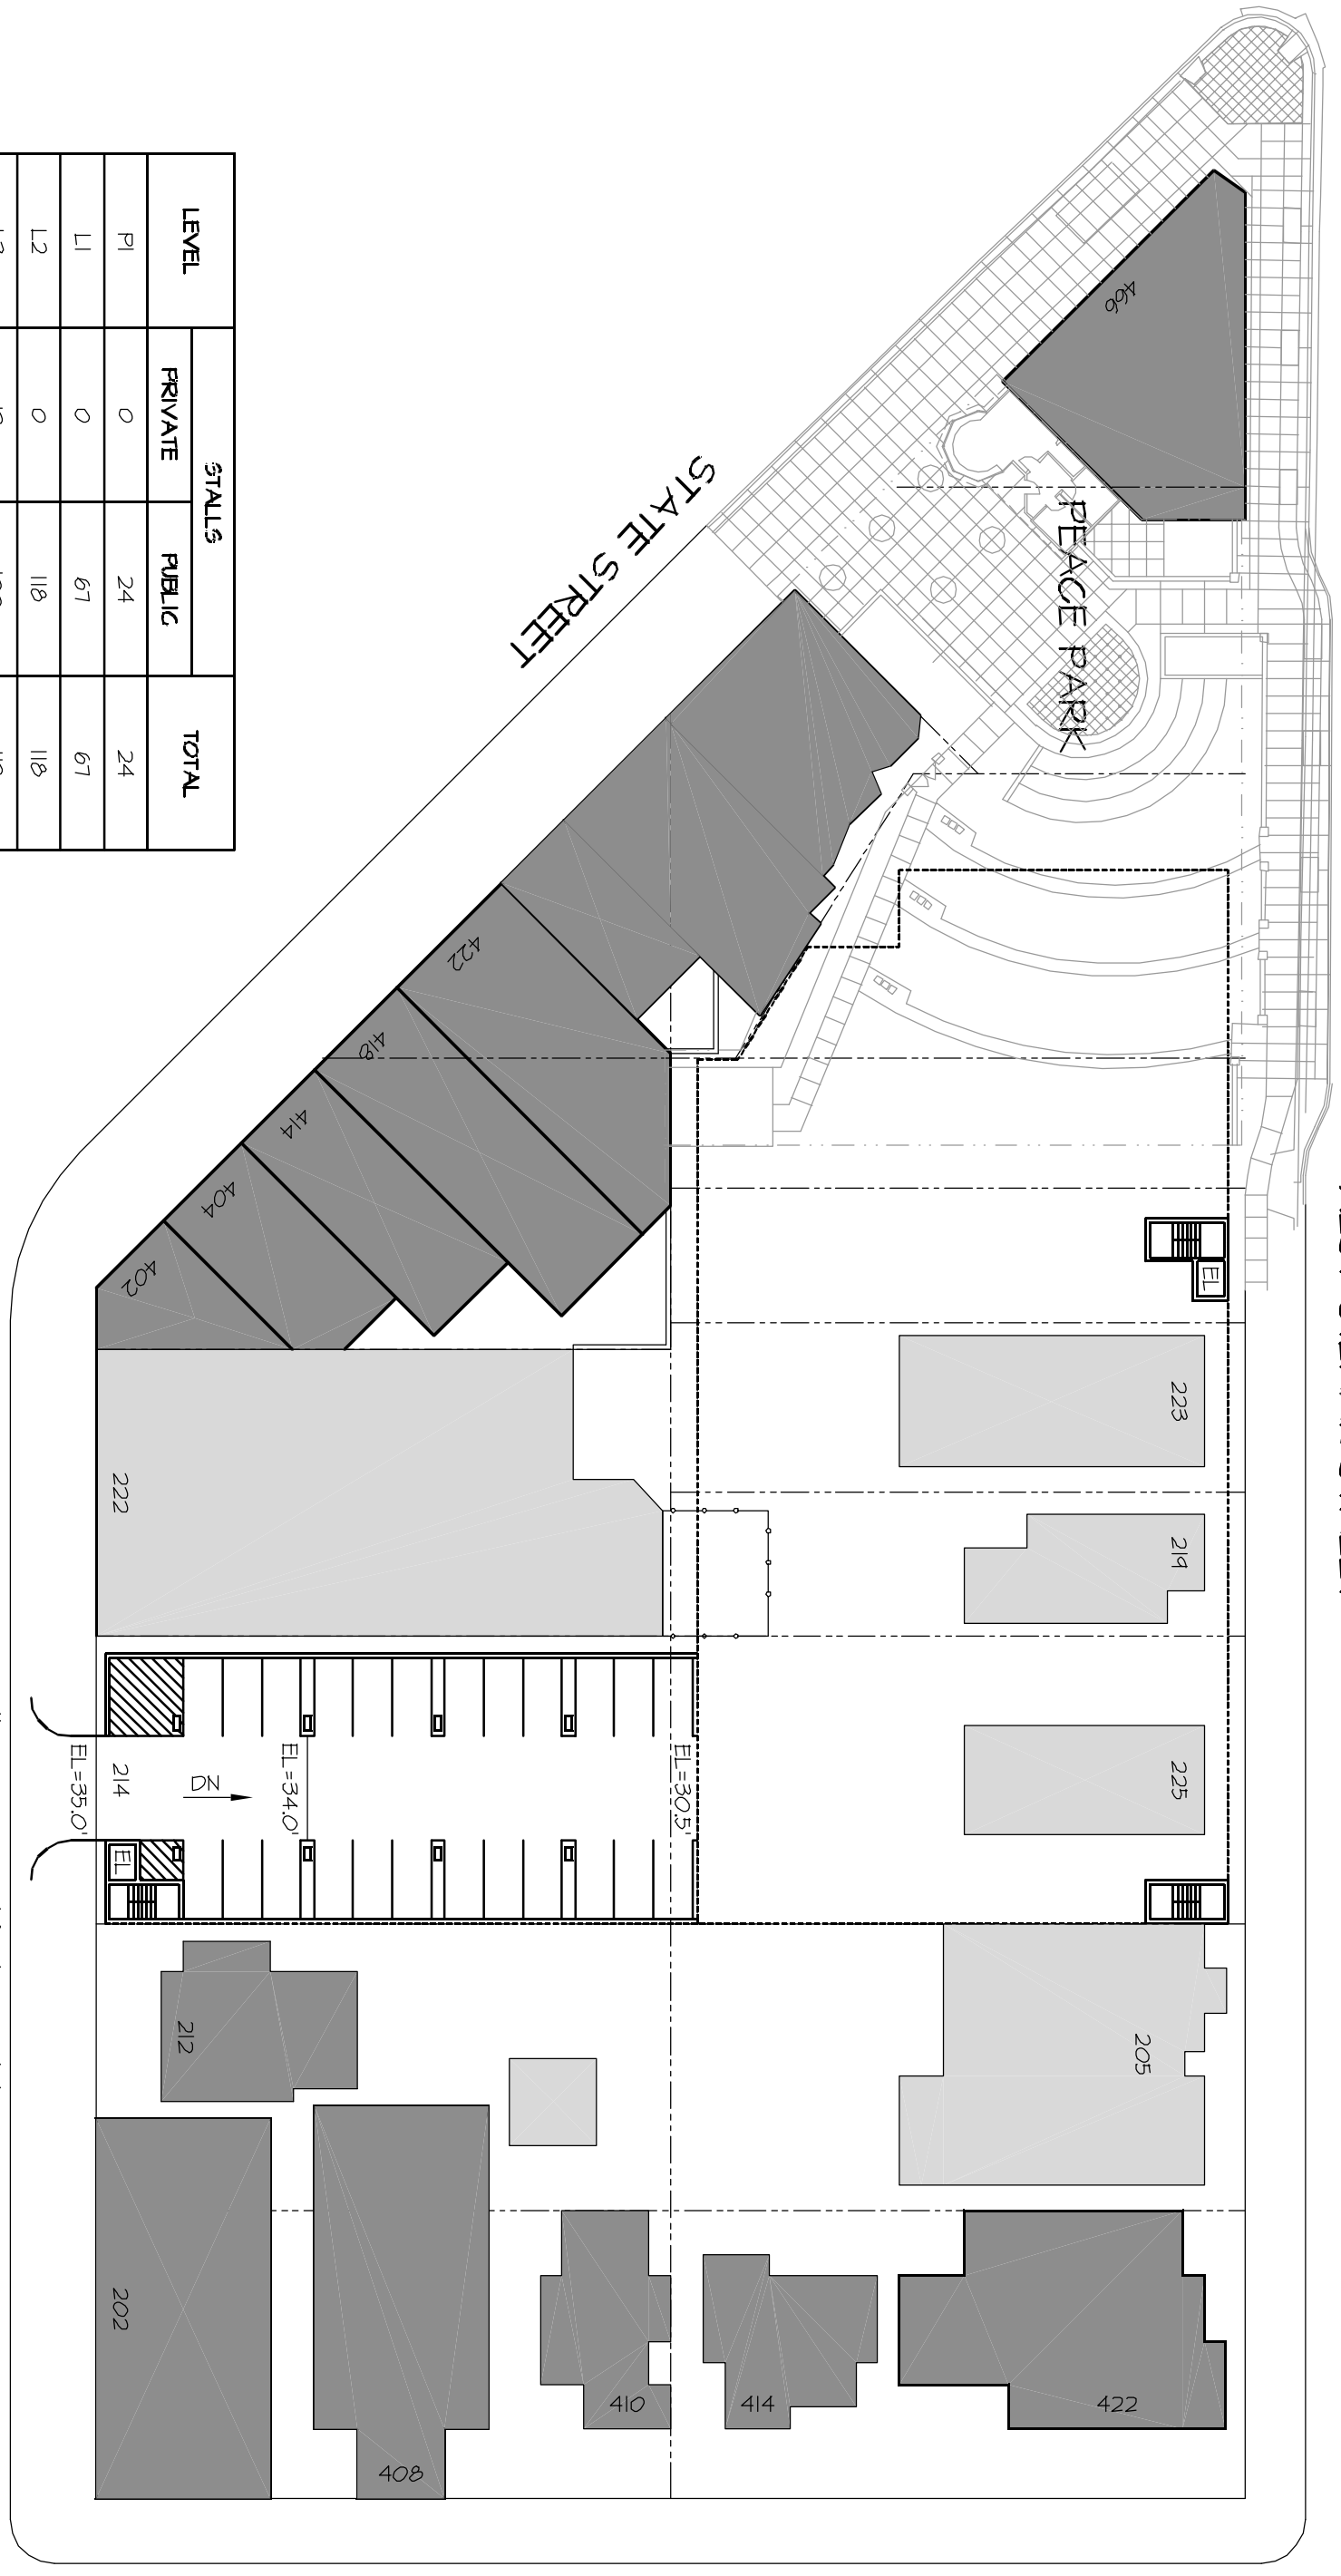

Sheet Title:

PARKING PLANS - OPTION 2F





Project Title:


MID STATE STREET PARKING
MADISON, WI
CITY OF MADISON PARKING UTILITY

Drawing Number:


2F-2

Project Number: 040069	Revised By:
Date Issued: 5-24-04	Issued With:

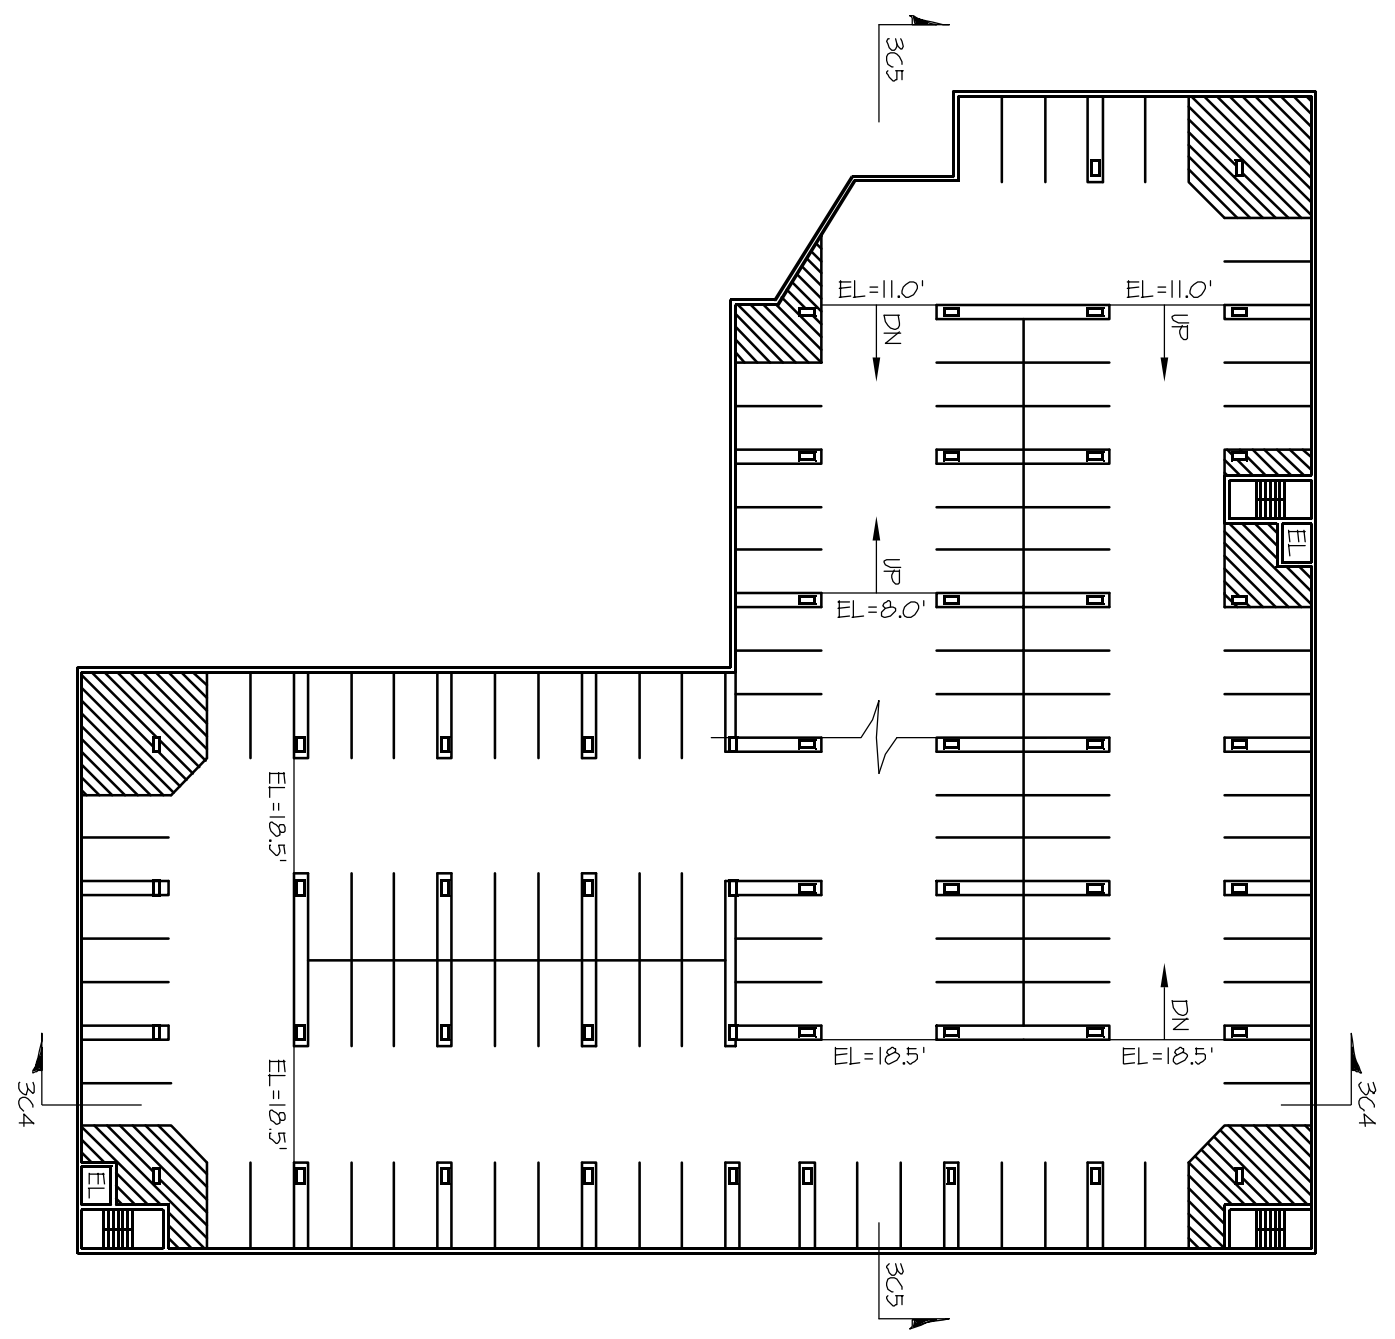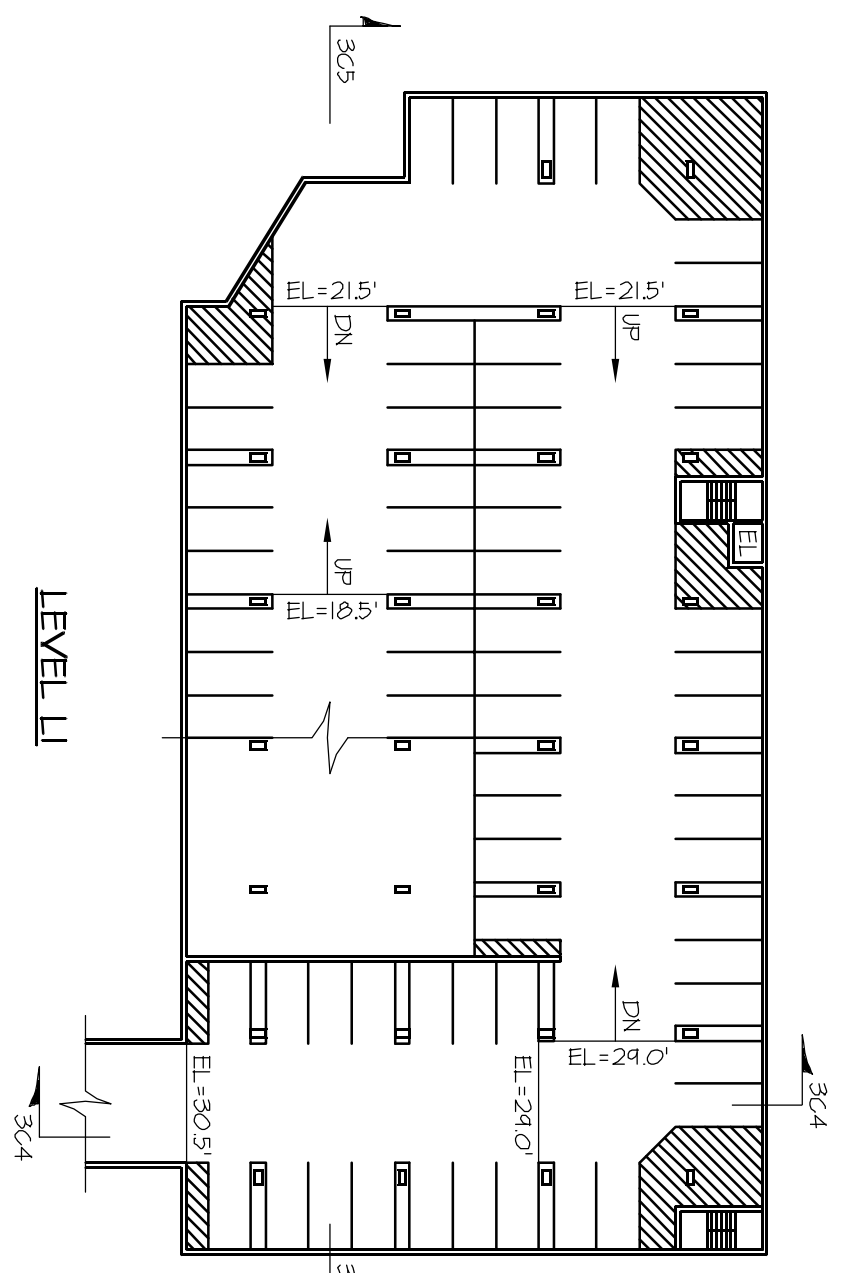

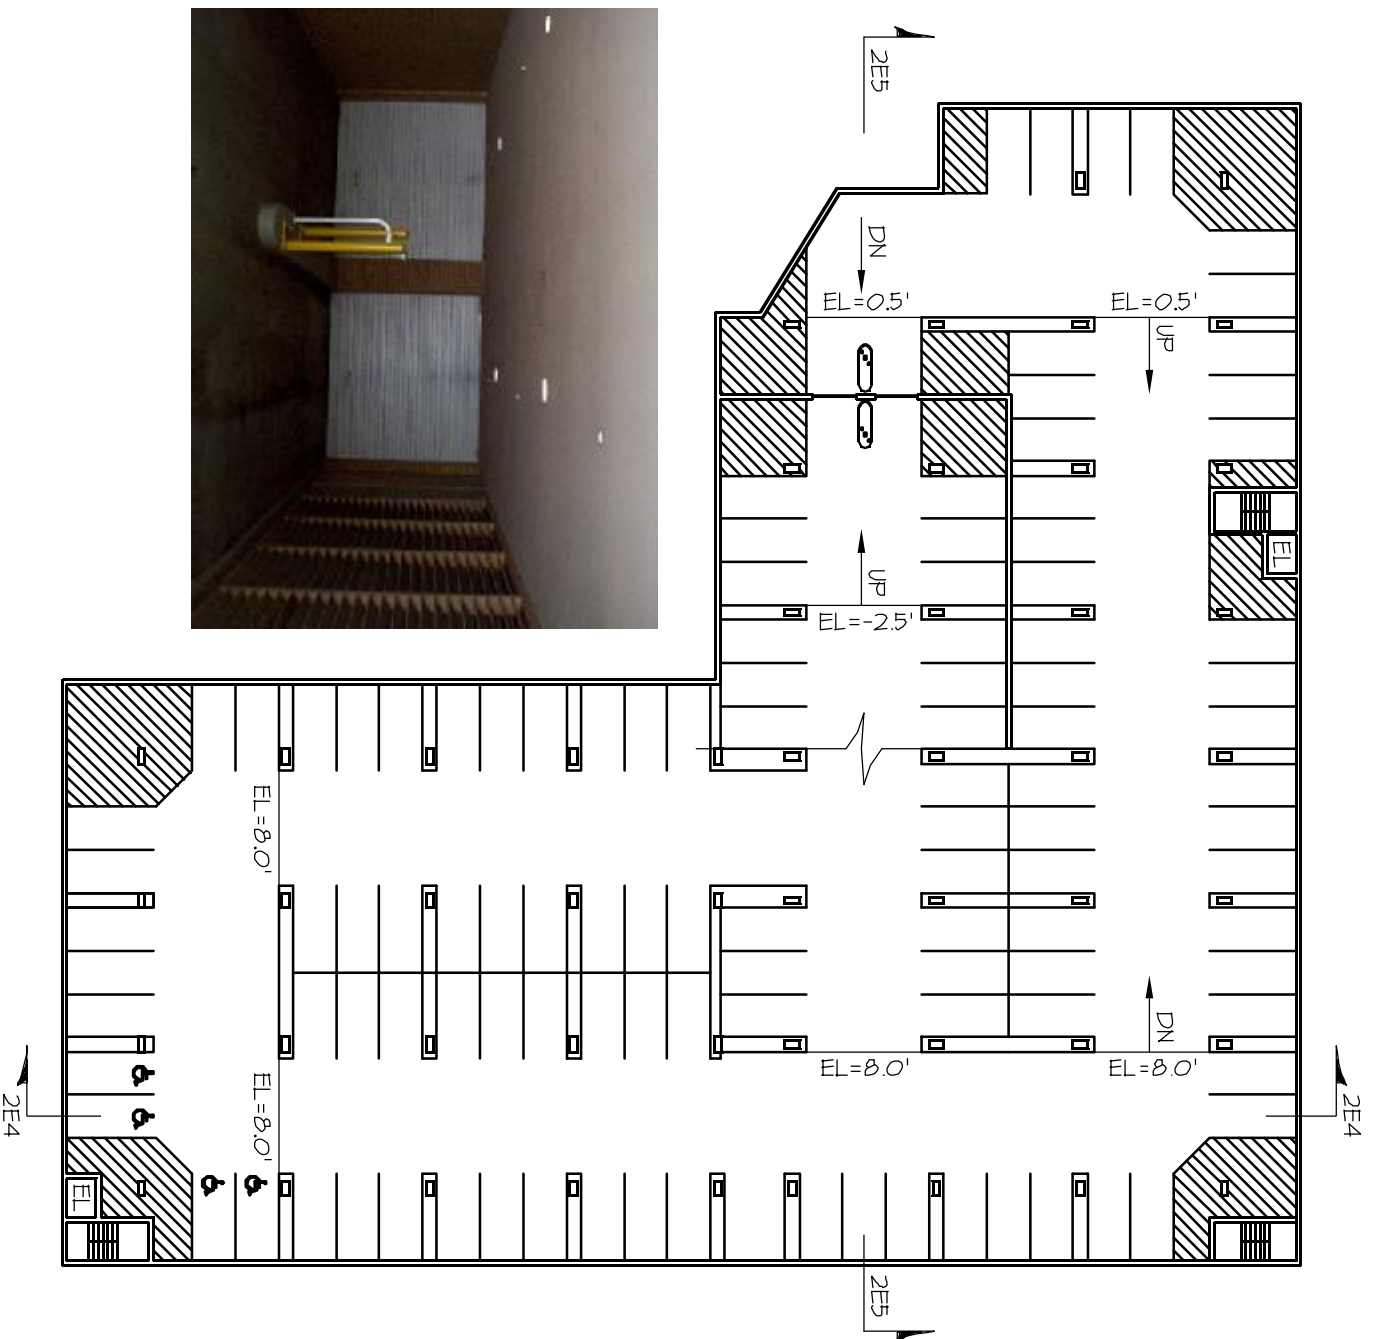

LEVEL L3

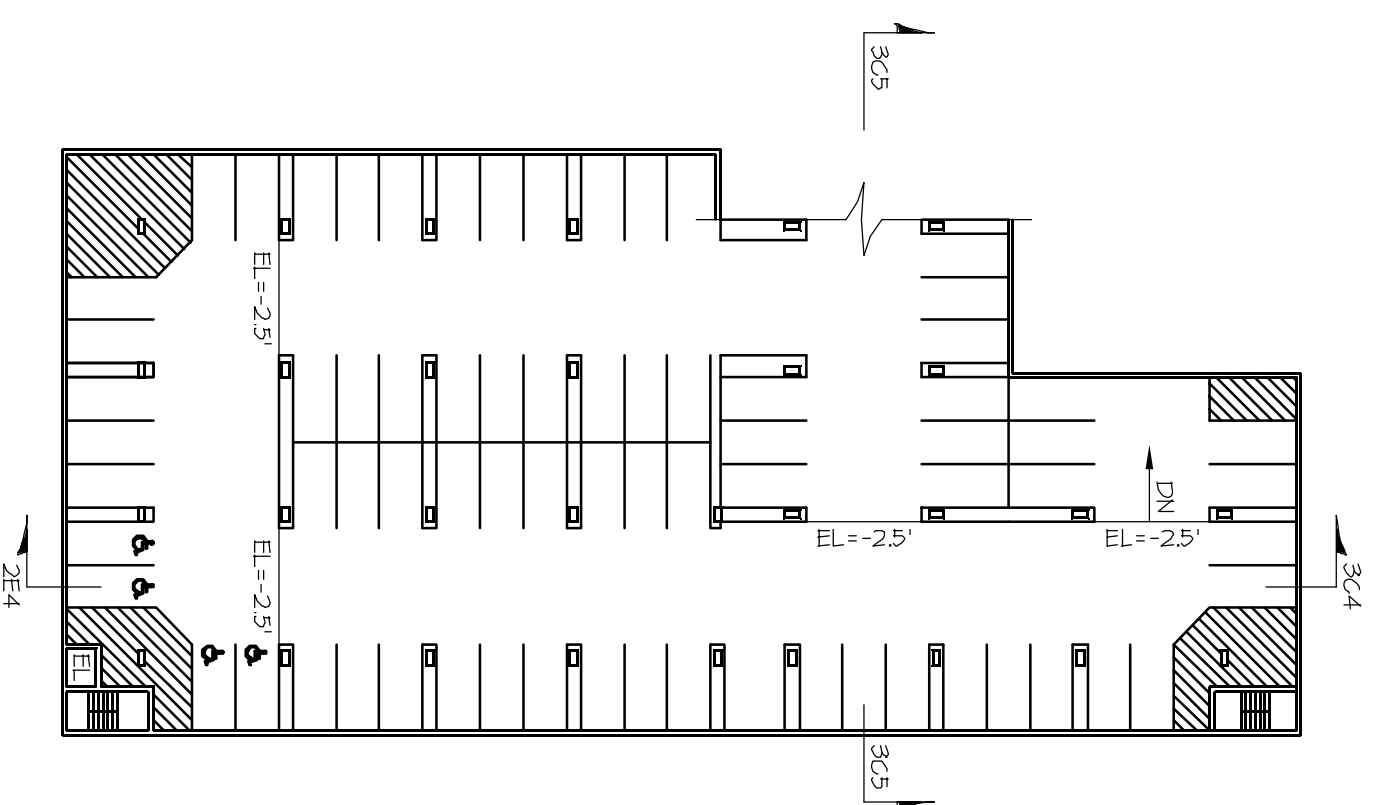

LEVEL L4



ARNOLD AND O'SHERIDAN INC.
CONSULTING ENGINEERS
STRUCTURAL ■ CIVIL ■ HVAC ■ PLUMBING
ELECTRICAL ■ TELECOMMUNICATIONS
MADISON, WISCONSIN (608-821-8300)
BROOKFIELD, WISCONSIN (762) 783-6130
WWW.ARNOLDANDOSHERIDAN.COM

Sheet Title:

PARKING PLANS - OPTION 2F




Project Title:

MID STATE STREET PARKING
MADISON, WI
CITY OF MADISON PARKING UTILITY

Drawing Number:

2F-3

Project Number: 040069	Revised By:
Date Issued: 5-24-04	Issued With:

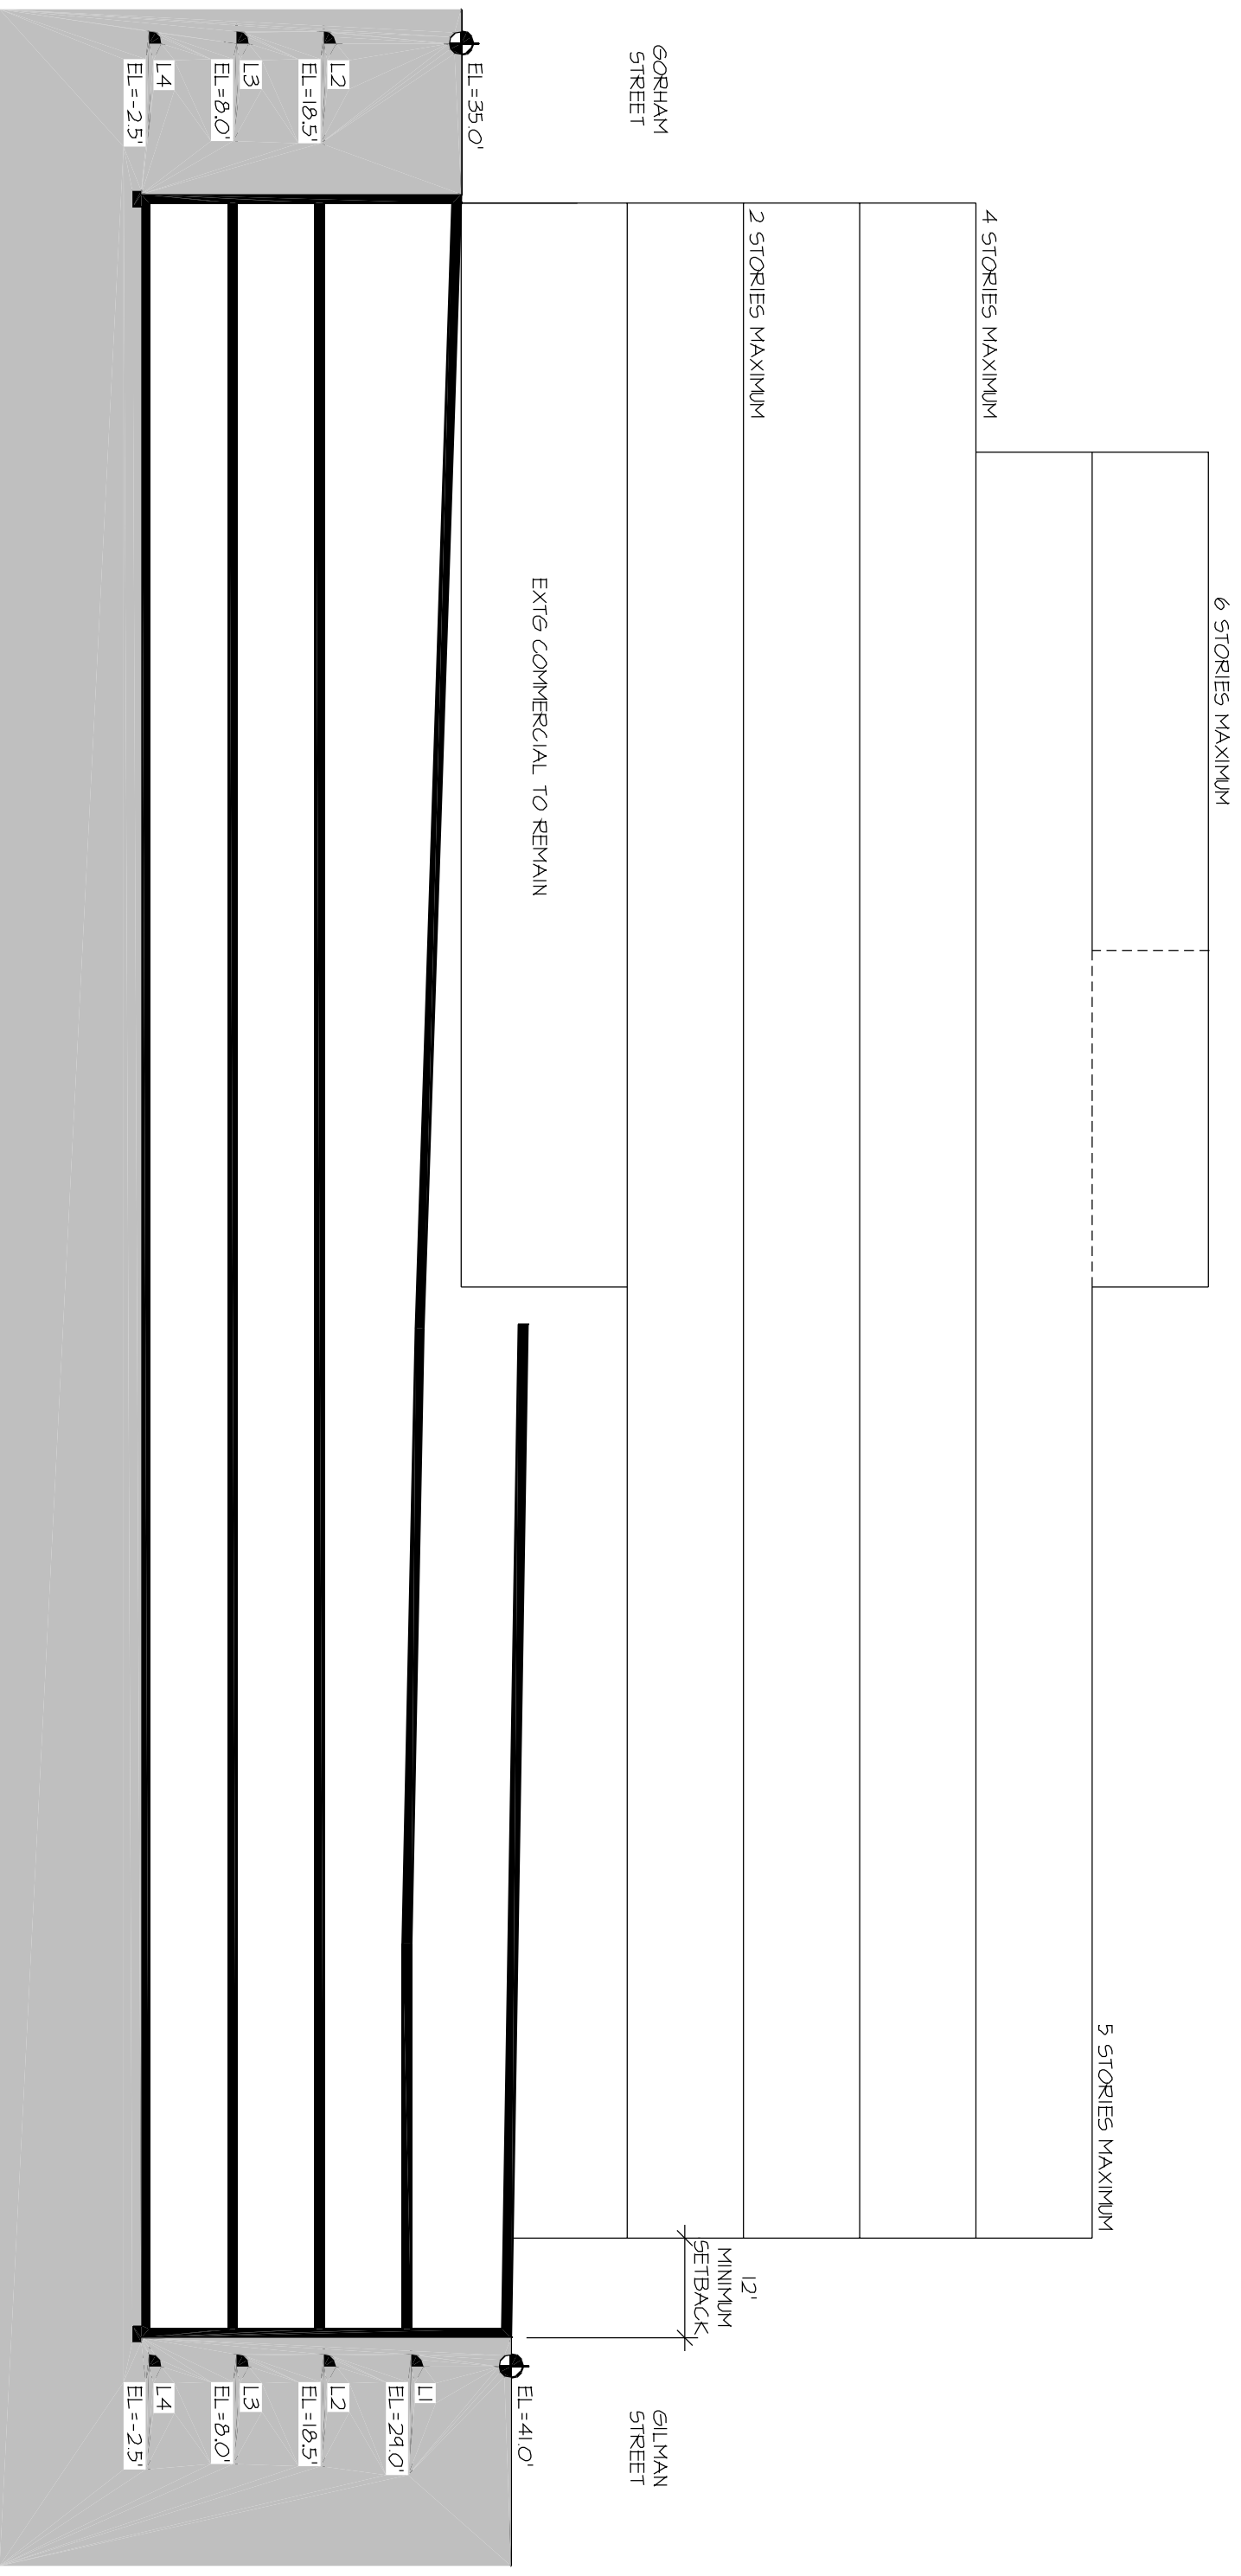

ARNOLD AND O'SHERIDAN INC
 CONSULTING ENGINEERS
 STRUCTURAL ■ CIVIL ■ HVAC ■ PLUMBING
 ELECTRICAL ■ TELECOMMUNICATIONS
 MADISON, WISCONSIN (608-821-8300)
 BROOKFIELD, WISCONSIN (762) 783-6130
 WWW.ARNOLDANDOSHERIDAN.COM

Sheet Title:

RAMP SECTION - NORTH/SOUTH



Project Title:


MID STATE STREET PARKING
 MADISON, WI
 CITY OF MADISON PARKING UTILITY



Drawing Number:

2F-4

Project Number:	Revised By:
040069	
Date Issued:	Issued With:
5-24-04	

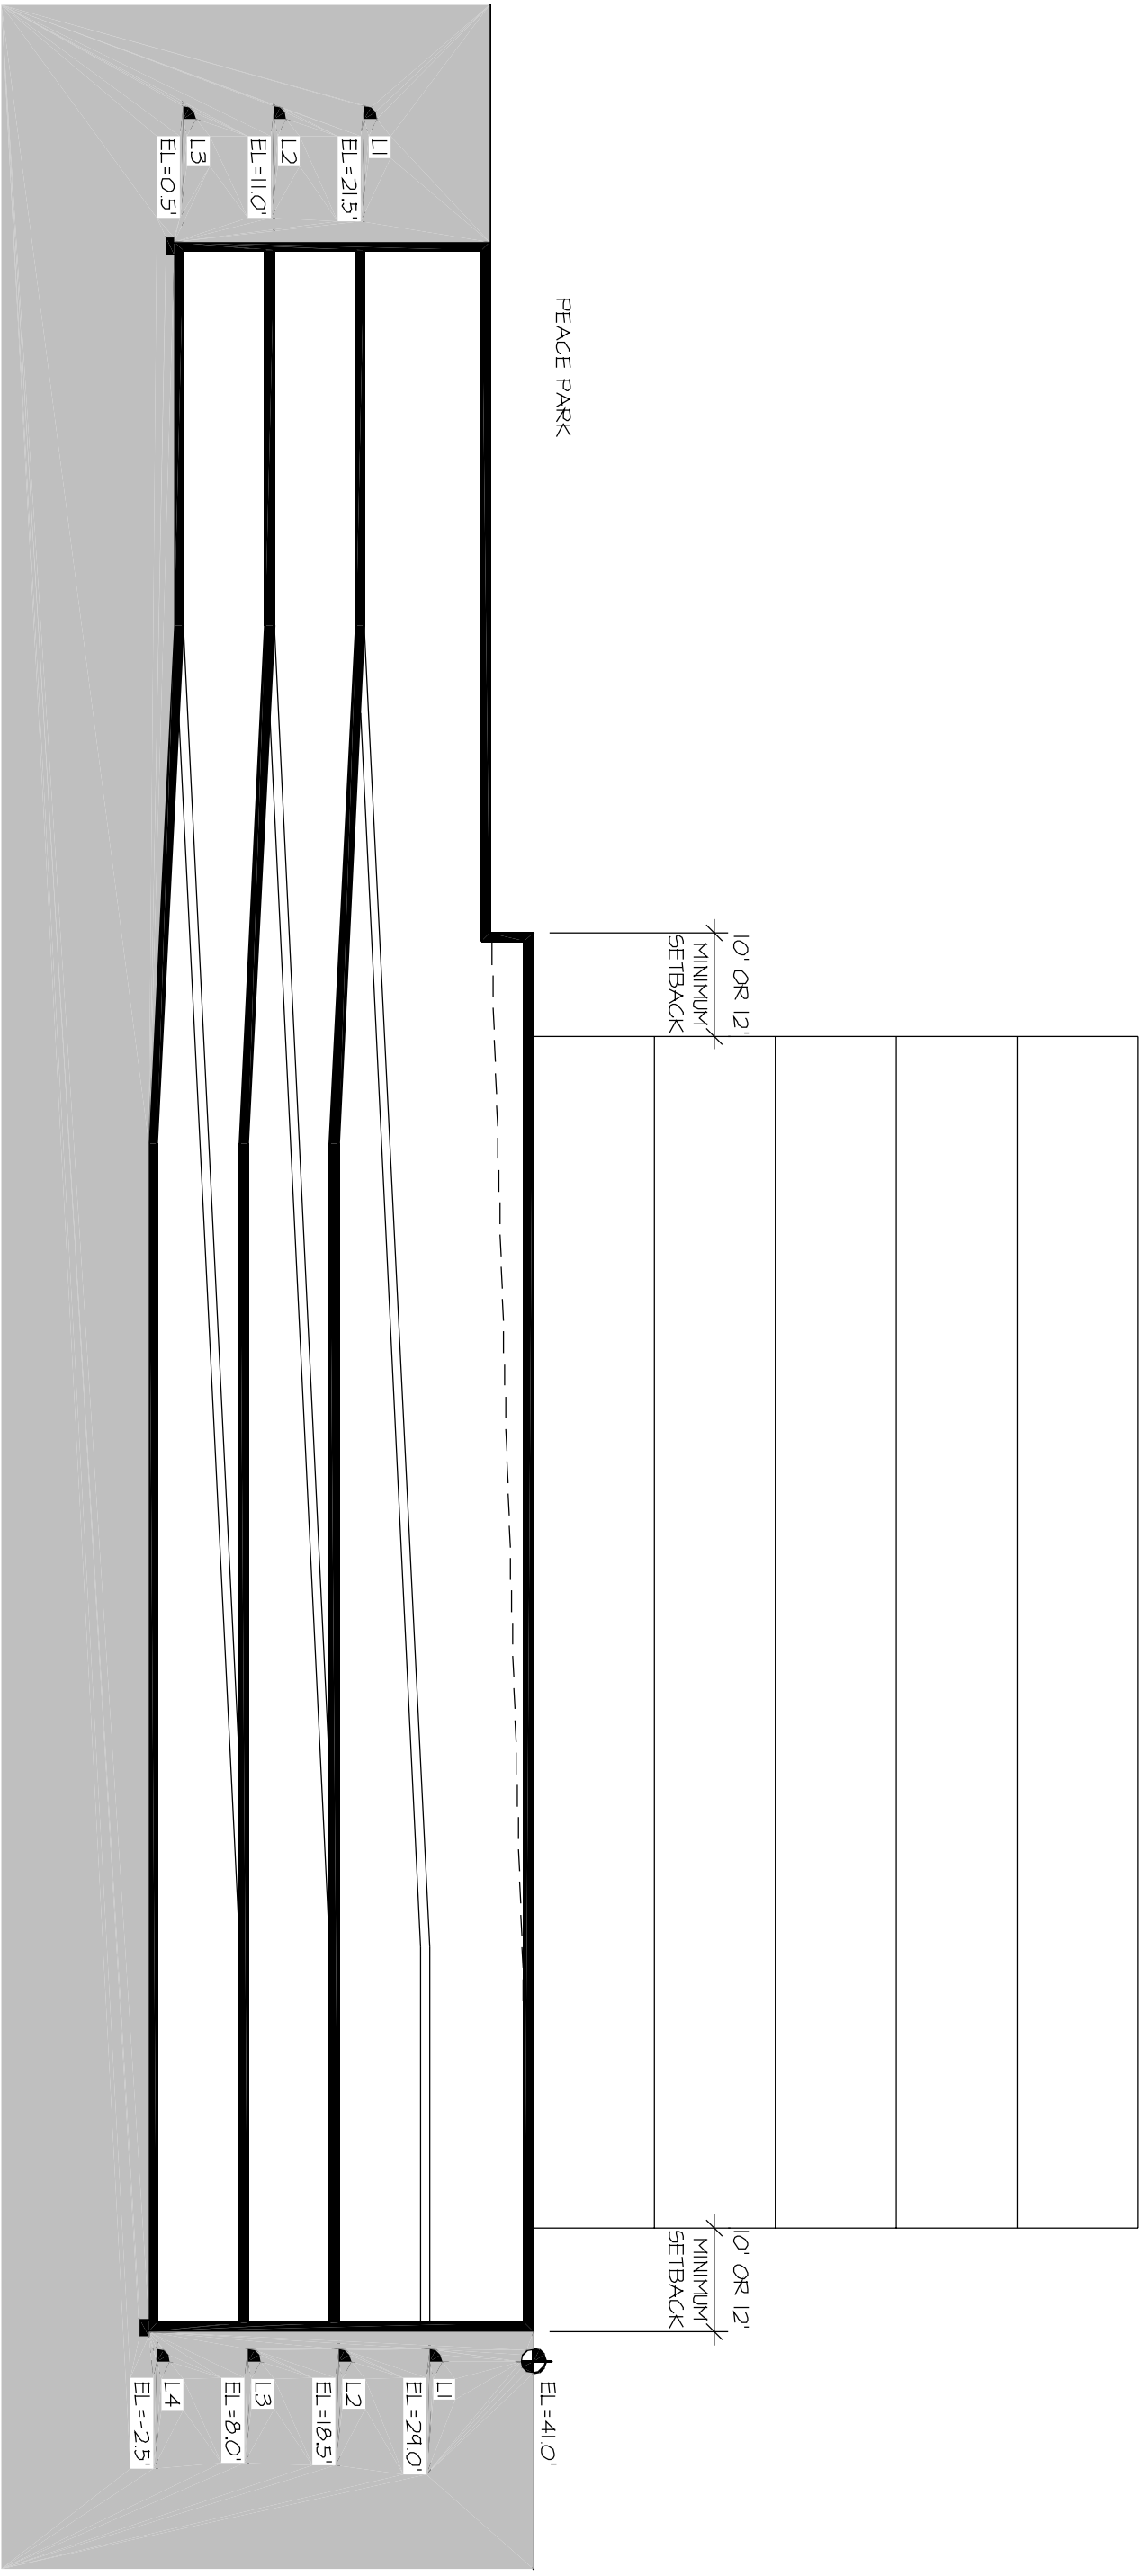

ARNOLD AND O'SHERIDAN INC
 CONSULTING ENGINEERS
 STRUCTURAL ■ CIVIL ■ HVAC ■ PLUMBING
 ELECTRICAL ■ TELECOMMUNICATIONS
 MADISON, WISCONSIN (608-821-8300)
 BROOKFIELD, WISCONSIN (762) 783-6130
 WWW.ARNOLDANDOSHERIDAN.COM


Sheet Title:

RAMP SECTION - EAST/WEST (FACING GILMAN ST)



Project Title:

MID STATE STREET PARKING
 MADISON, WI
 CITY OF MADISON PARKING UTILITY

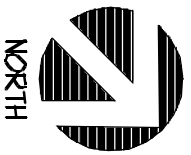

Drawing Number:

2F-5

Project Number:	Revised By:
040069	
Date Issued:	Issued With:
5-24-04	