

Madison, Wisconsin

CITY OF MADISON

MADISON WATER UTILITY

DEPARTMENT OF PUBLIC WORKS

PLAN OF PROPOSED IMPROVEMENT

INDEX OF SHEETS


SHEET NO.	1	TITLE SHEET
SHEET NO.	EC-1 TO EC-6	EROSION CONTROL PLAN
SHEET NO.	W-1 TO W-6	WATER PLAN & PROFILE
SHEET NO.	W-7 TO W-10	WATER IMPACT PLAN
SHEET NO.	W-11	WATER PLAN OVERVIEW
SHEET NO.	W-12	WATER ESTIMATE OF MATERIALS
SHEET NO.	R-1 TO R-6	RESTORATION PLAN
SHEET NO.	TC-1	TRAFFIC CONTROL PLAN

SHEBOYGAN AVE WATER MAIN REPLACEMENT

CITY PROJECT NO. 86001

MUNIS NO. 86001

CONTRACT NO. 8017

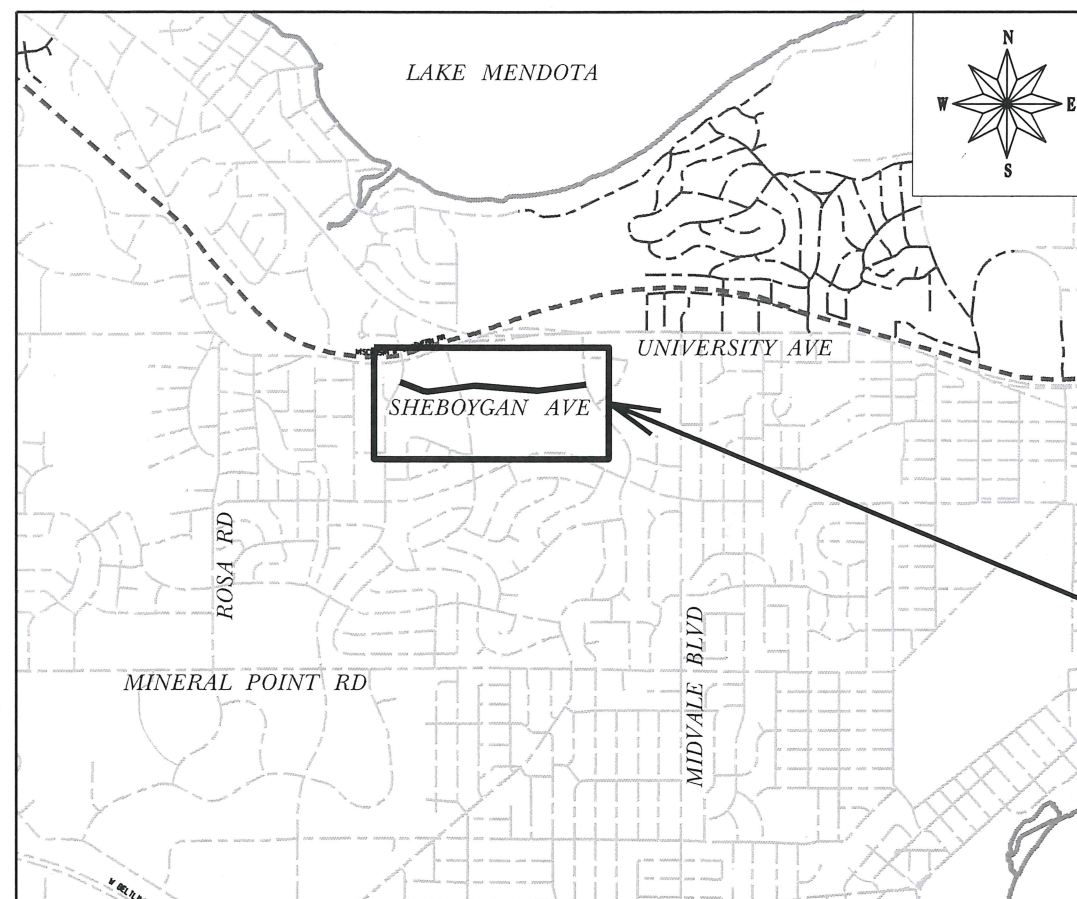

PROJECT
LOCATION

CONVENTIONAL SIGNS

FIELD VERIFY ALL UTILITY LOCATIONS

GAS	— G —
STORM SEWER	— ST —
SANITARY SEWER	— SAN —
WATER	— W —
BURIED ELECTRIC	— E —
OVERHEAD ELECTRIC	— OH —
POWER POLE	
ADA COMPLIANT RAMP W/ DETECTABLE WARNING FIELD	
COMBUSTIBLE FLUIDS	

PUBLIC IMPROVEMENT PROJECT
APPROVED

MAY 16, 2017


BY THE COMMON COUNCIL
OF MADISON, WISCONSIN

PUBLIC IMPROVEMENT DESIGN
APPROVED BY:

Principal Engineer
Madison Water Utility
Date 6/21/17

WATER
DESIGNED BY:



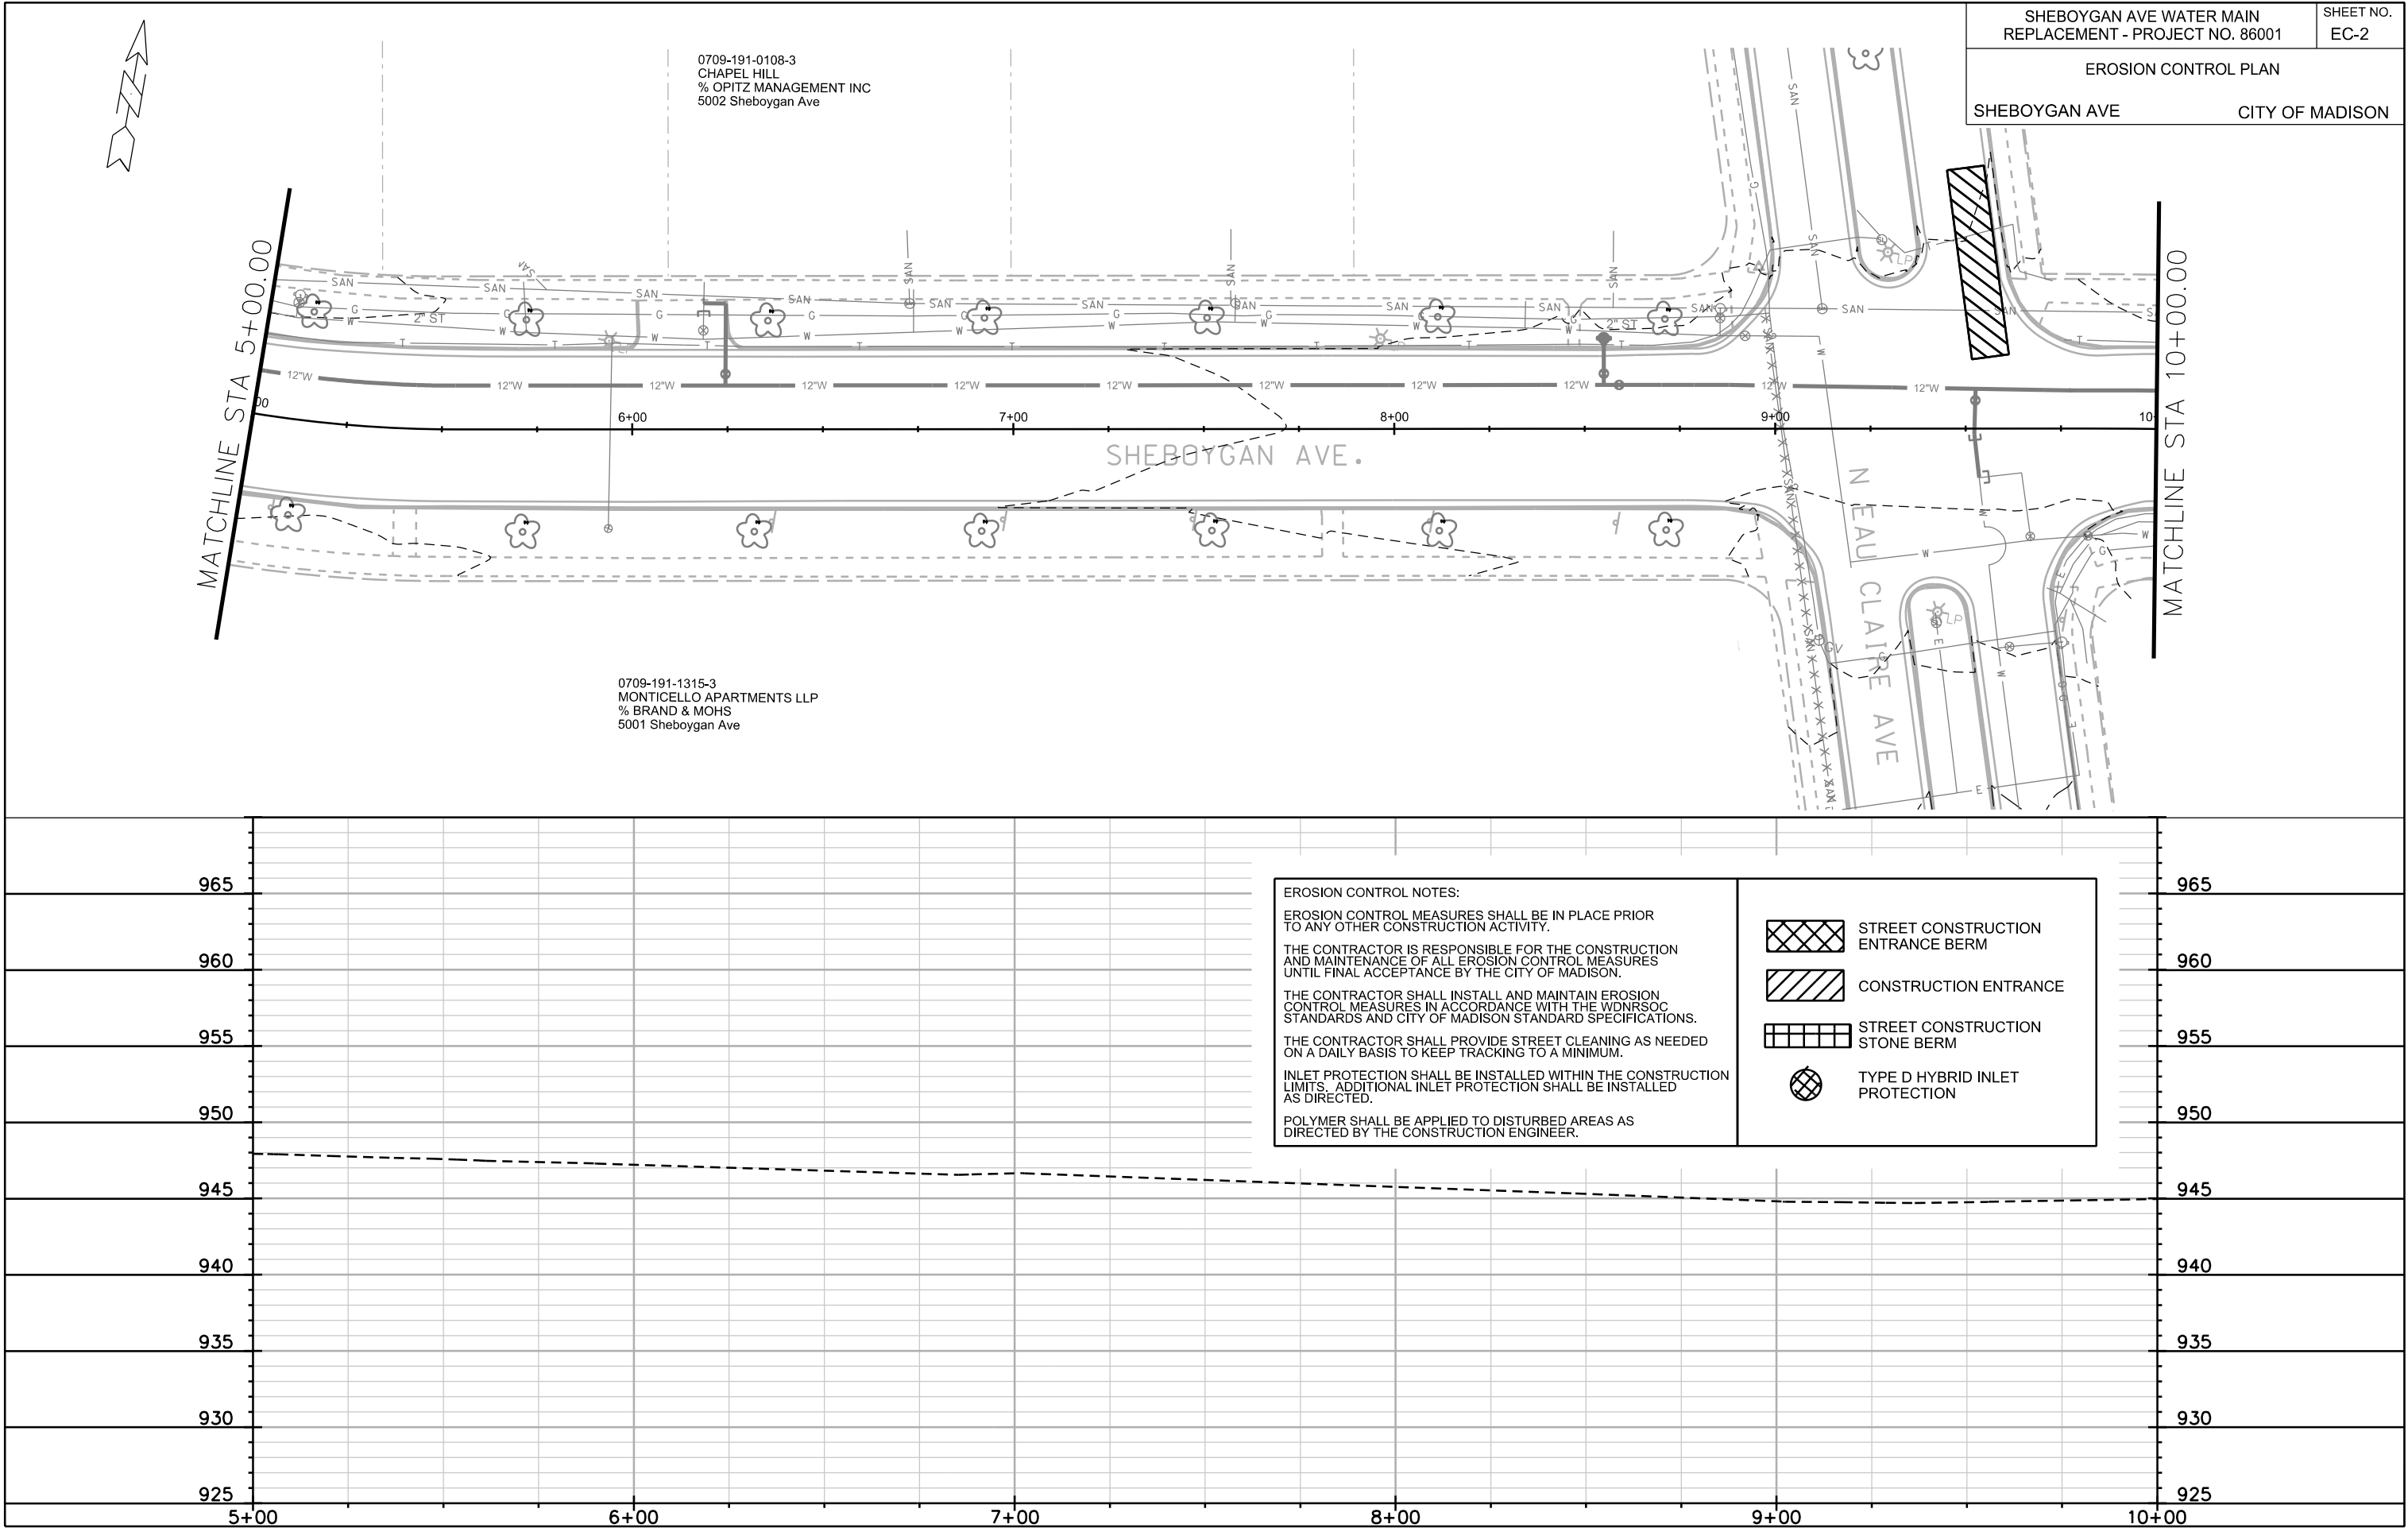

0709-191-0108-3
CHAPEL HILL
% OPITZ MANAGEMENT INC
5002 Sheboygan Ave

0709-191-1315-3
MONTICELLO APARTMENTS LLP
% BRAND & MOHS
5001 Sheboygan Ave

EROSION CONTROL NOTES:

EROSION CONTROL MEASURES SHALL BE IN PLACE PRIOR TO ANY OTHER CONSTRUCTION ACTIVITY.

THE CONTRACTOR IS RESPONSIBLE FOR THE CONSTRUCTION AND MAINTENANCE OF ALL EROSION CONTROL MEASURES UNTIL FINAL ACCEPTANCE BY THE CITY OF MADISON.

THE CONTRACTOR SHALL INSTALL AND MAINTAIN EROSION CONTROL MEASURES IN ACCORDANCE WITH THE WDNR SOC STANDARDS AND CITY OF MADISON STANDARD SPECIFICATIONS.


THE CONTRACTOR SHALL PROVIDE STREET CLEANING AS NEEDED ON A DAILY BASIS TO KEEP TRACKING TO A MINIMUM.

INLET PROTECTION SHALL BE INSTALLED WITHIN THE CONSTRUCTION LIMITS. ADDITIONAL INLET PROTECTION SHALL BE INSTALLED AS DIRECTED.

POLYMER SHALL BE APPLIED TO DISTURBED AREAS AS DIRECTED BY THE CONSTRUCTION ENGINEER.


- STREET CONSTRUCTION
ENTRANCE BERM
- CONSTRUCTION ENTRANCE
- STREET CONSTRUCTION
STONE BERM
- TYPE D HYBRID INLET
PROTECTION


0709-202-0303-4
AMERICAN NATIONAL
RED CROSS
4860 Sheboygan Ave


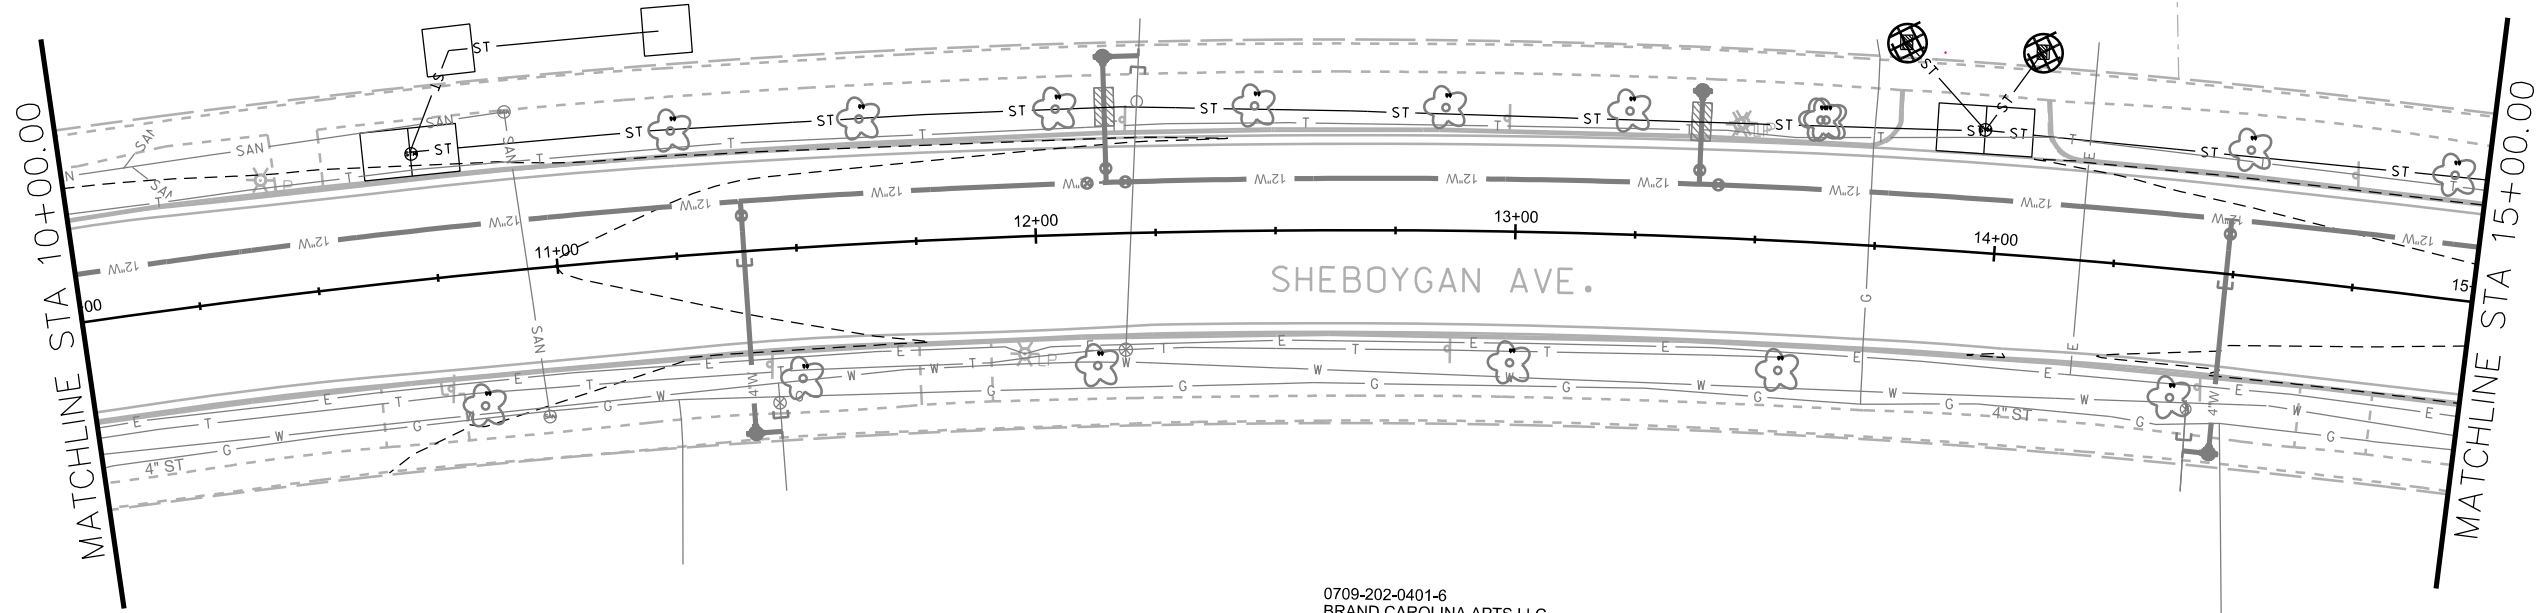




0709-202-0401-6
BRAND CAROLINA APTS LLC
MOHS CAROLINA APTS LLC
4901 Sheboygan Ave

EROSION CONTROL NOTES: EROSION CONTROL MEASURES SHALL BE IN PLACE PRIOR TO ANY OTHER CONSTRUCTION ACTIVITY. THE CONTRACTOR IS RESPONSIBLE FOR THE CONSTRUCTION AND MAINTENANCE OF ALL EROSION CONTROL MEASURES UNTIL FINAL ACCEPTANCE BY THE CITY OF MADISON. THE CONTRACTOR SHALL INSTALL AND MAINTAIN EROSION CONTROL MEASURES IN ACCORDANCE WITH THE WDNR SOC STANDARDS AND CITY OF MADISON STANDARD SPECIFICATIONS. THE CONTRACTOR SHALL PROVIDE STREET CLEANING AS NEEDED ON A DAILY BASIS TO KEEP TRACKING TO A MINIMUM. INLET PROTECTION SHALL BE INSTALLED WITHIN THE CONSTRUCTION LIMITS. ADDITIONAL INLET PROTECTION SHALL BE INSTALLED AS DIRECTED. POLYMER SHALL BE APPLIED TO DISTURBED AREAS AS DIRECTED BY THE CONSTRUCTION ENGINEER.	<table><tr><td></td><td>STREET CONSTRUCTION ENTRANCE BERM</td></tr><tr><td></td><td>CONSTRUCTION ENTRANCE</td></tr><tr><td></td><td>STREET CONSTRUCTION STONE BERM</td></tr><tr><td></td><td>TYPE D HYBRID INLET PROTECTION</td></tr></table>		STREET CONSTRUCTION ENTRANCE BERM		CONSTRUCTION ENTRANCE		STREET CONSTRUCTION STONE BERM		TYPE D HYBRID INLET PROTECTION
	STREET CONSTRUCTION ENTRANCE BERM								
	CONSTRUCTION ENTRANCE								
	STREET CONSTRUCTION STONE BERM								
	TYPE D HYBRID INLET PROTECTION								

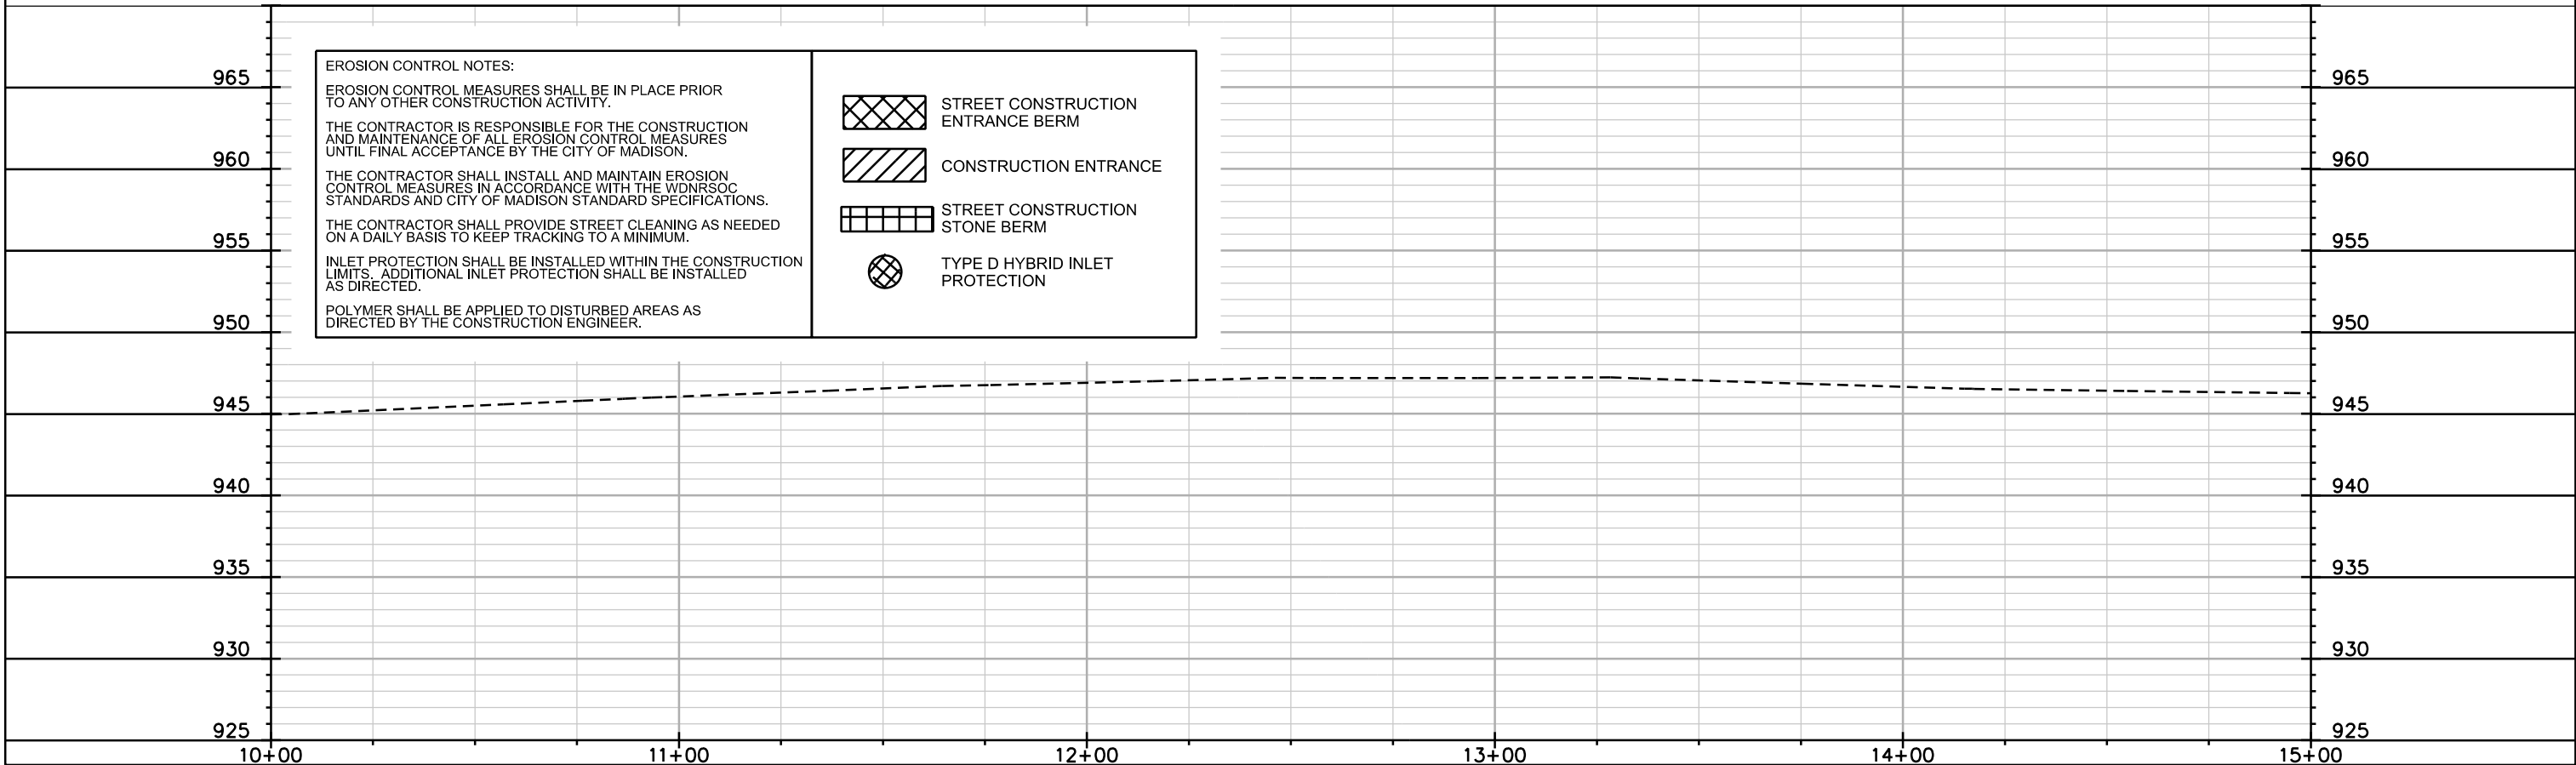



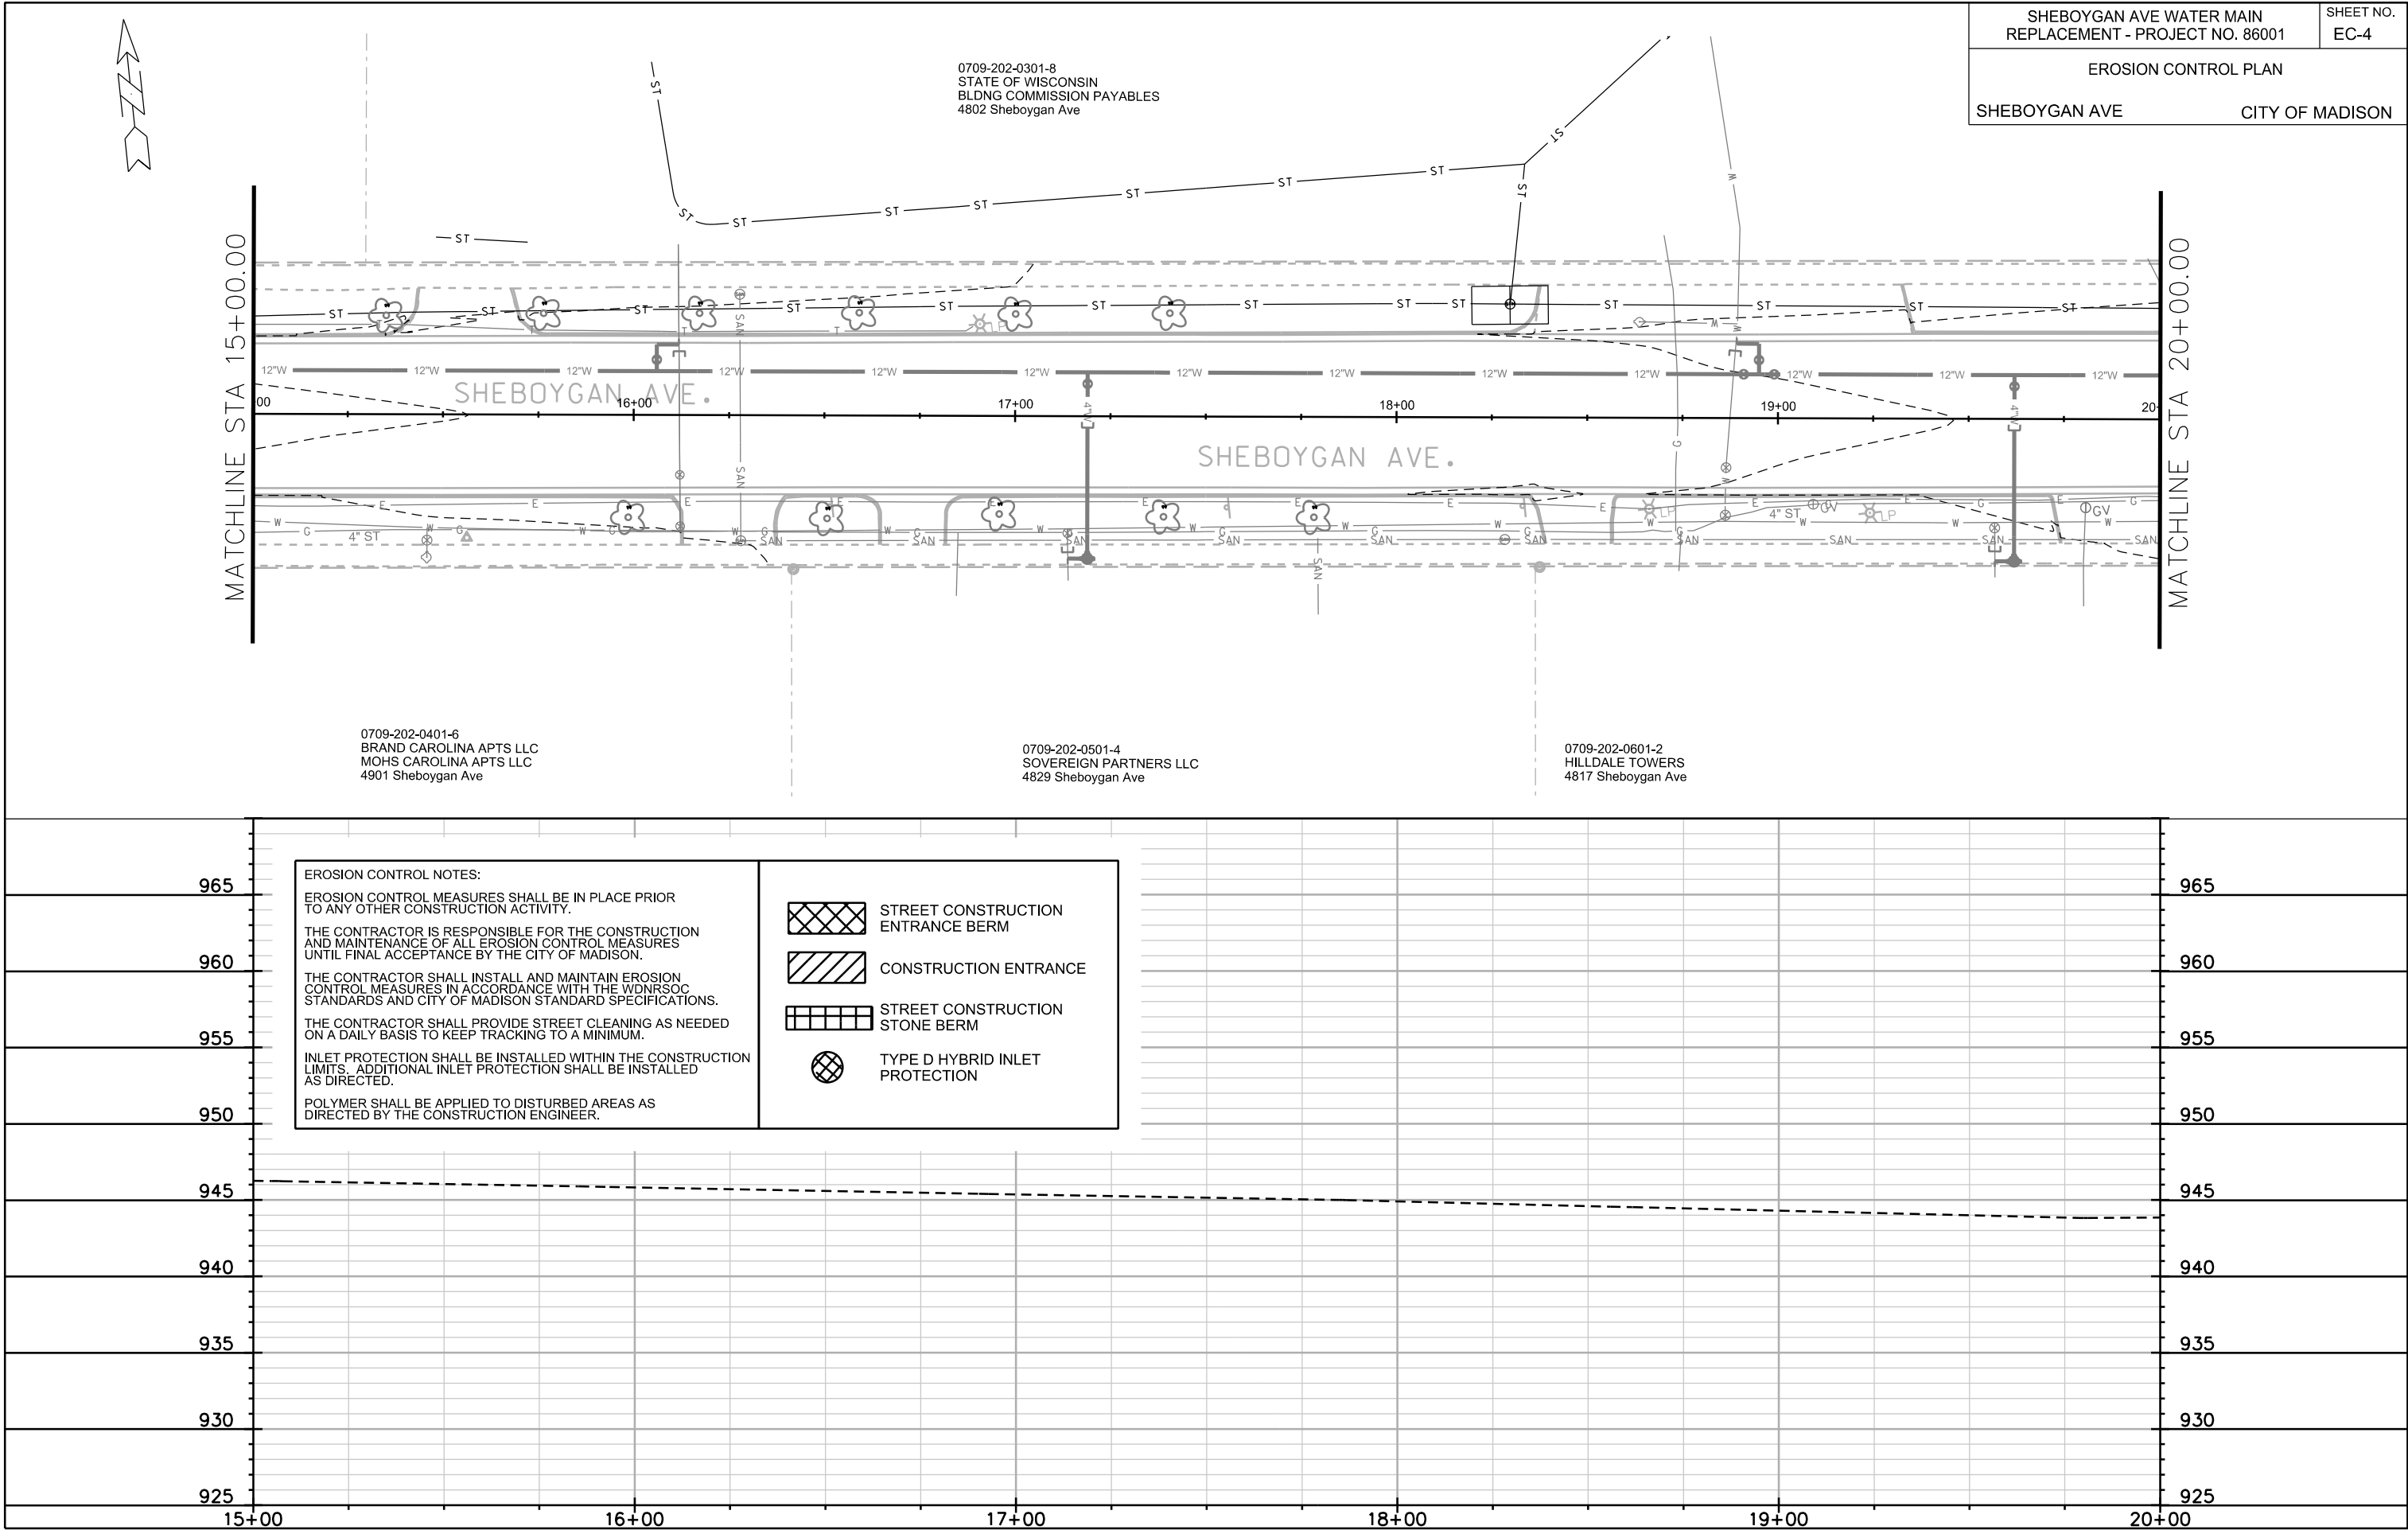


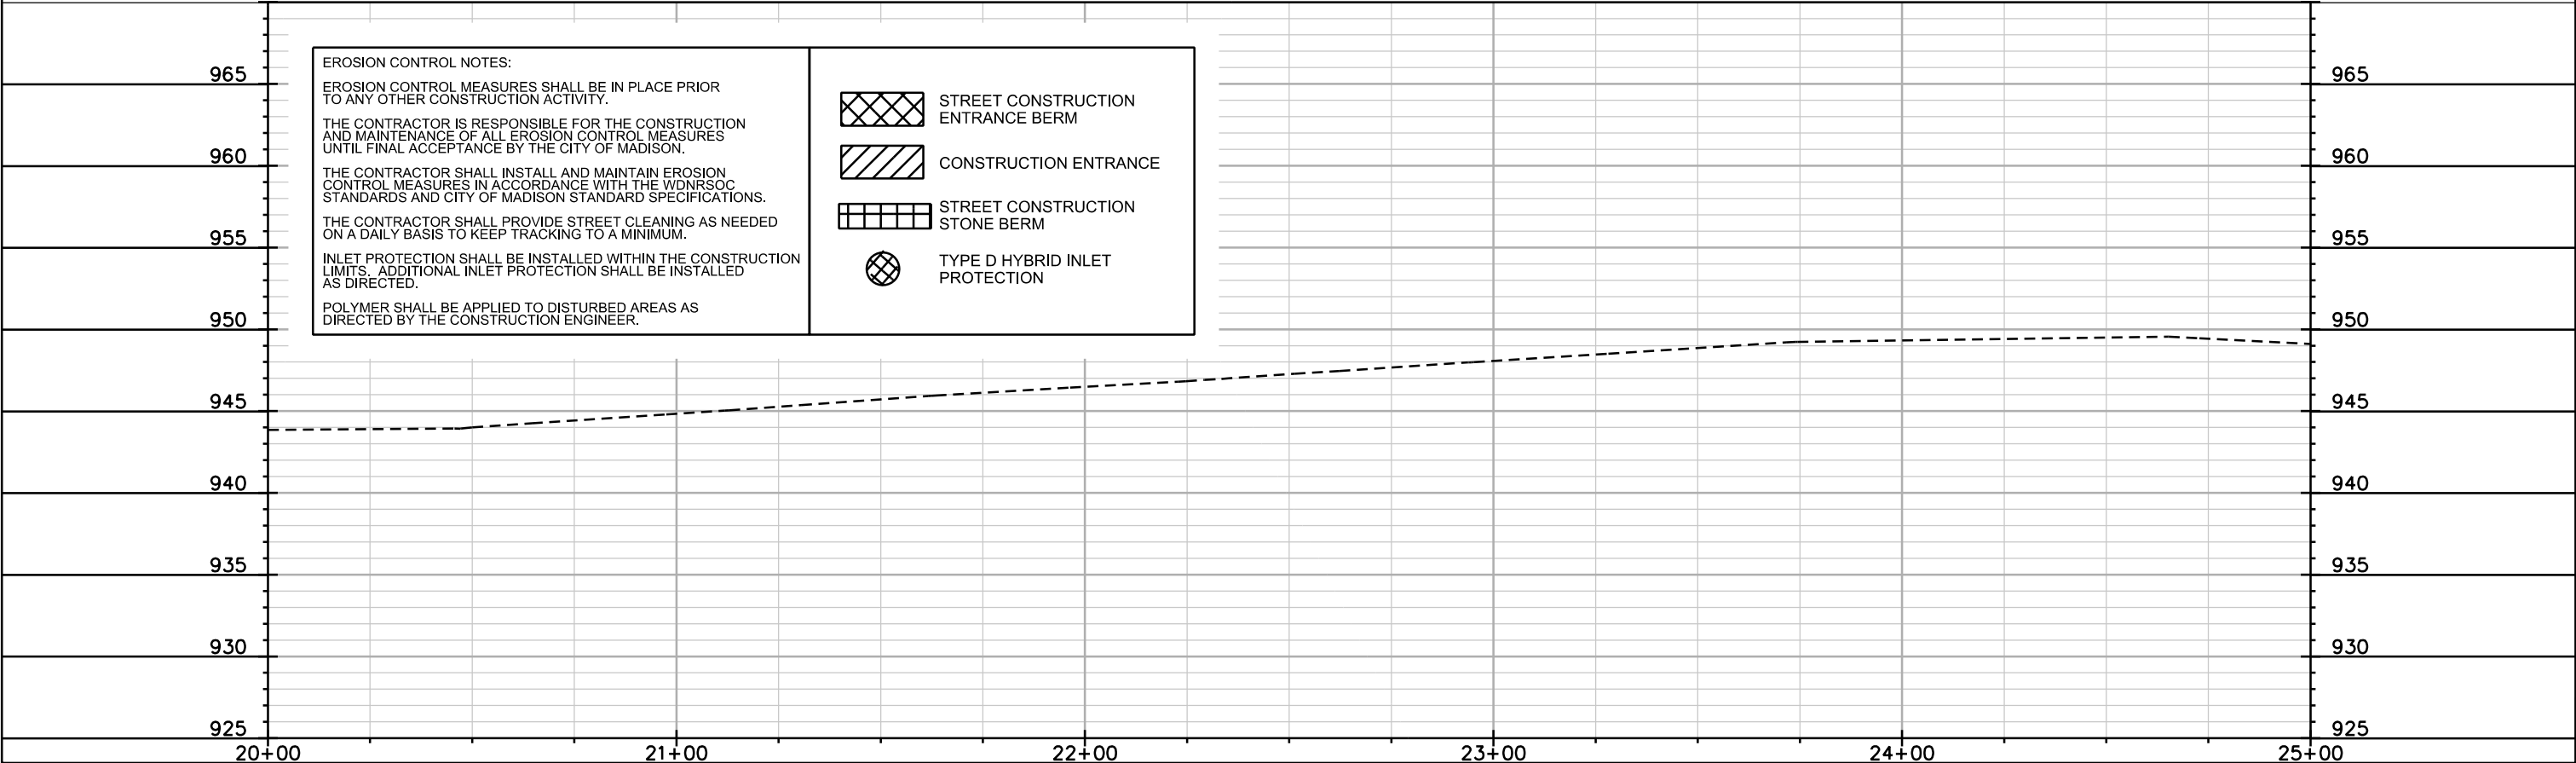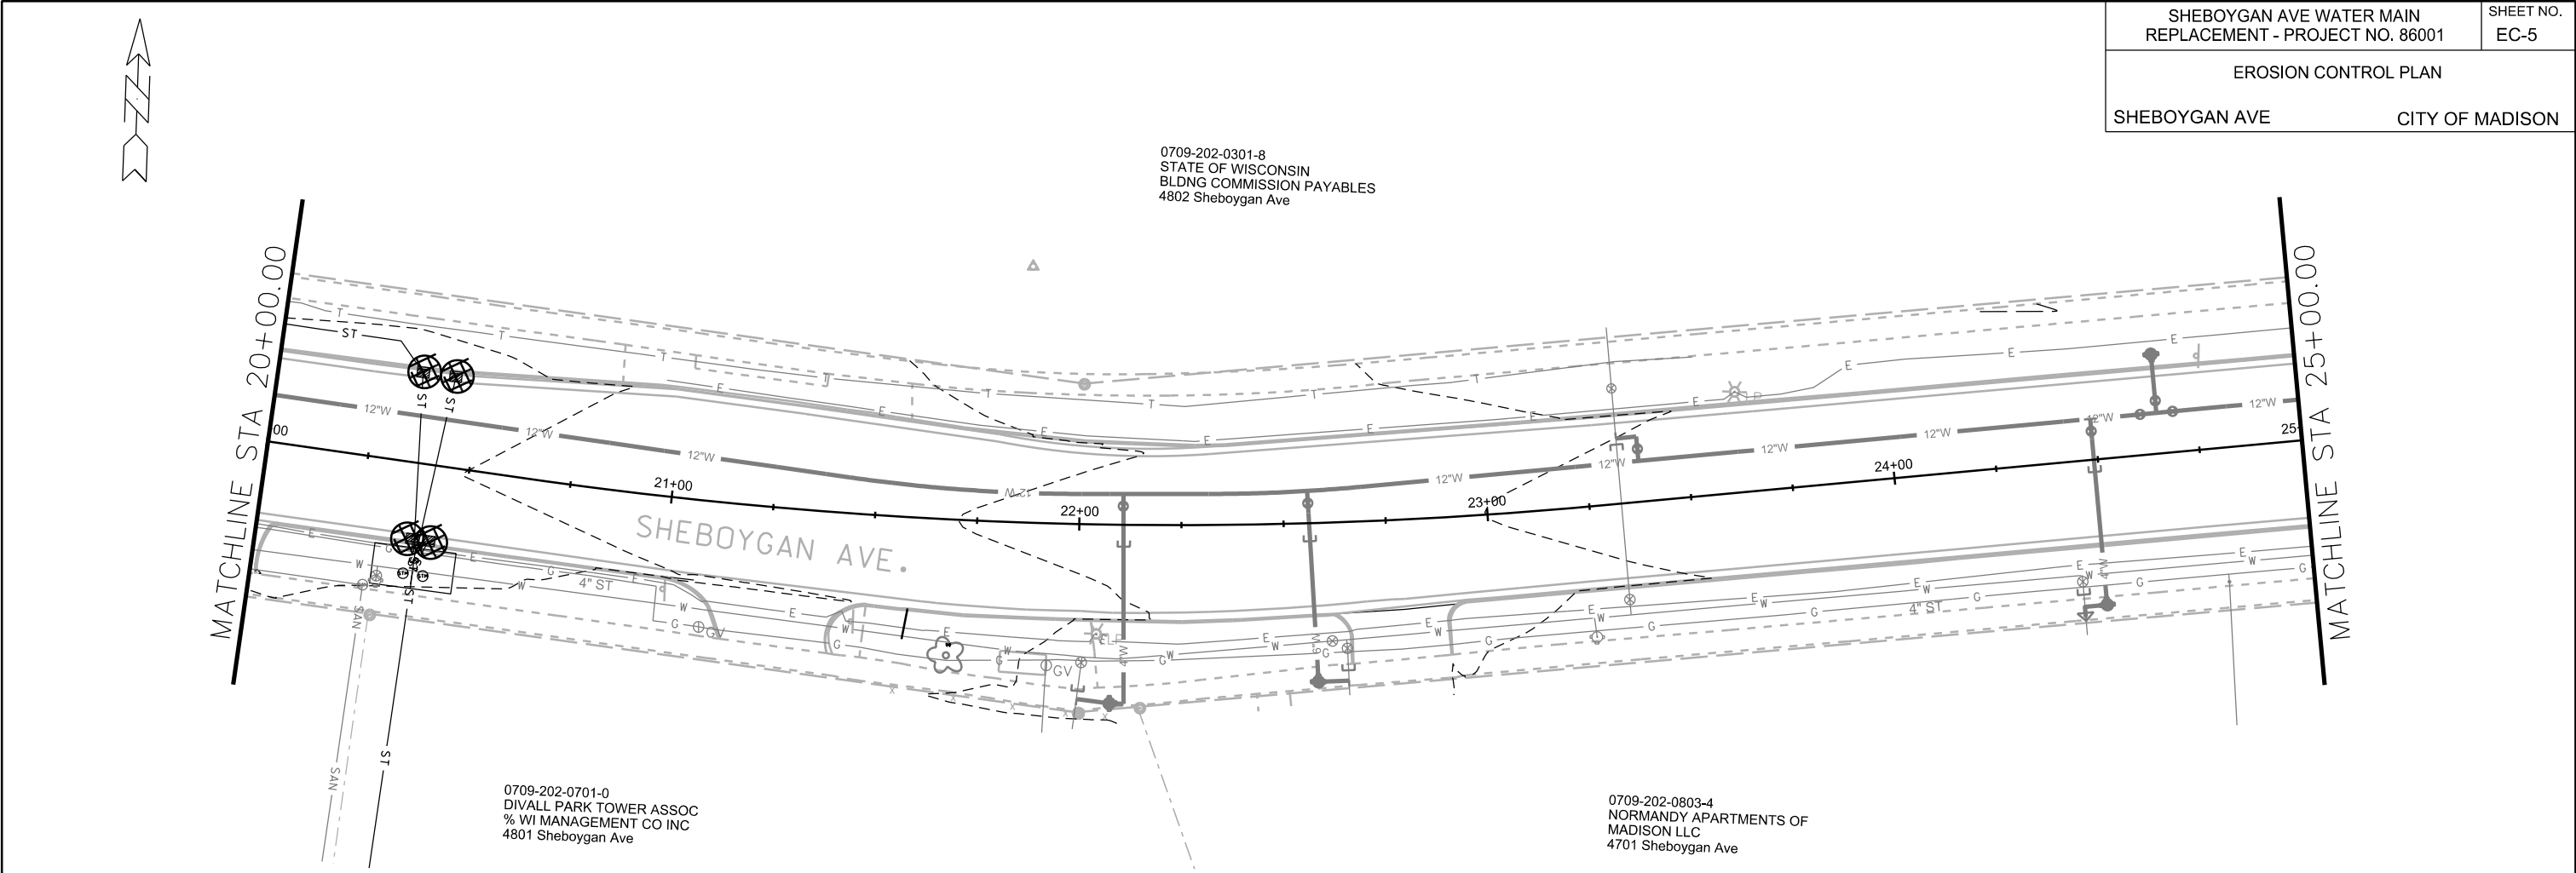

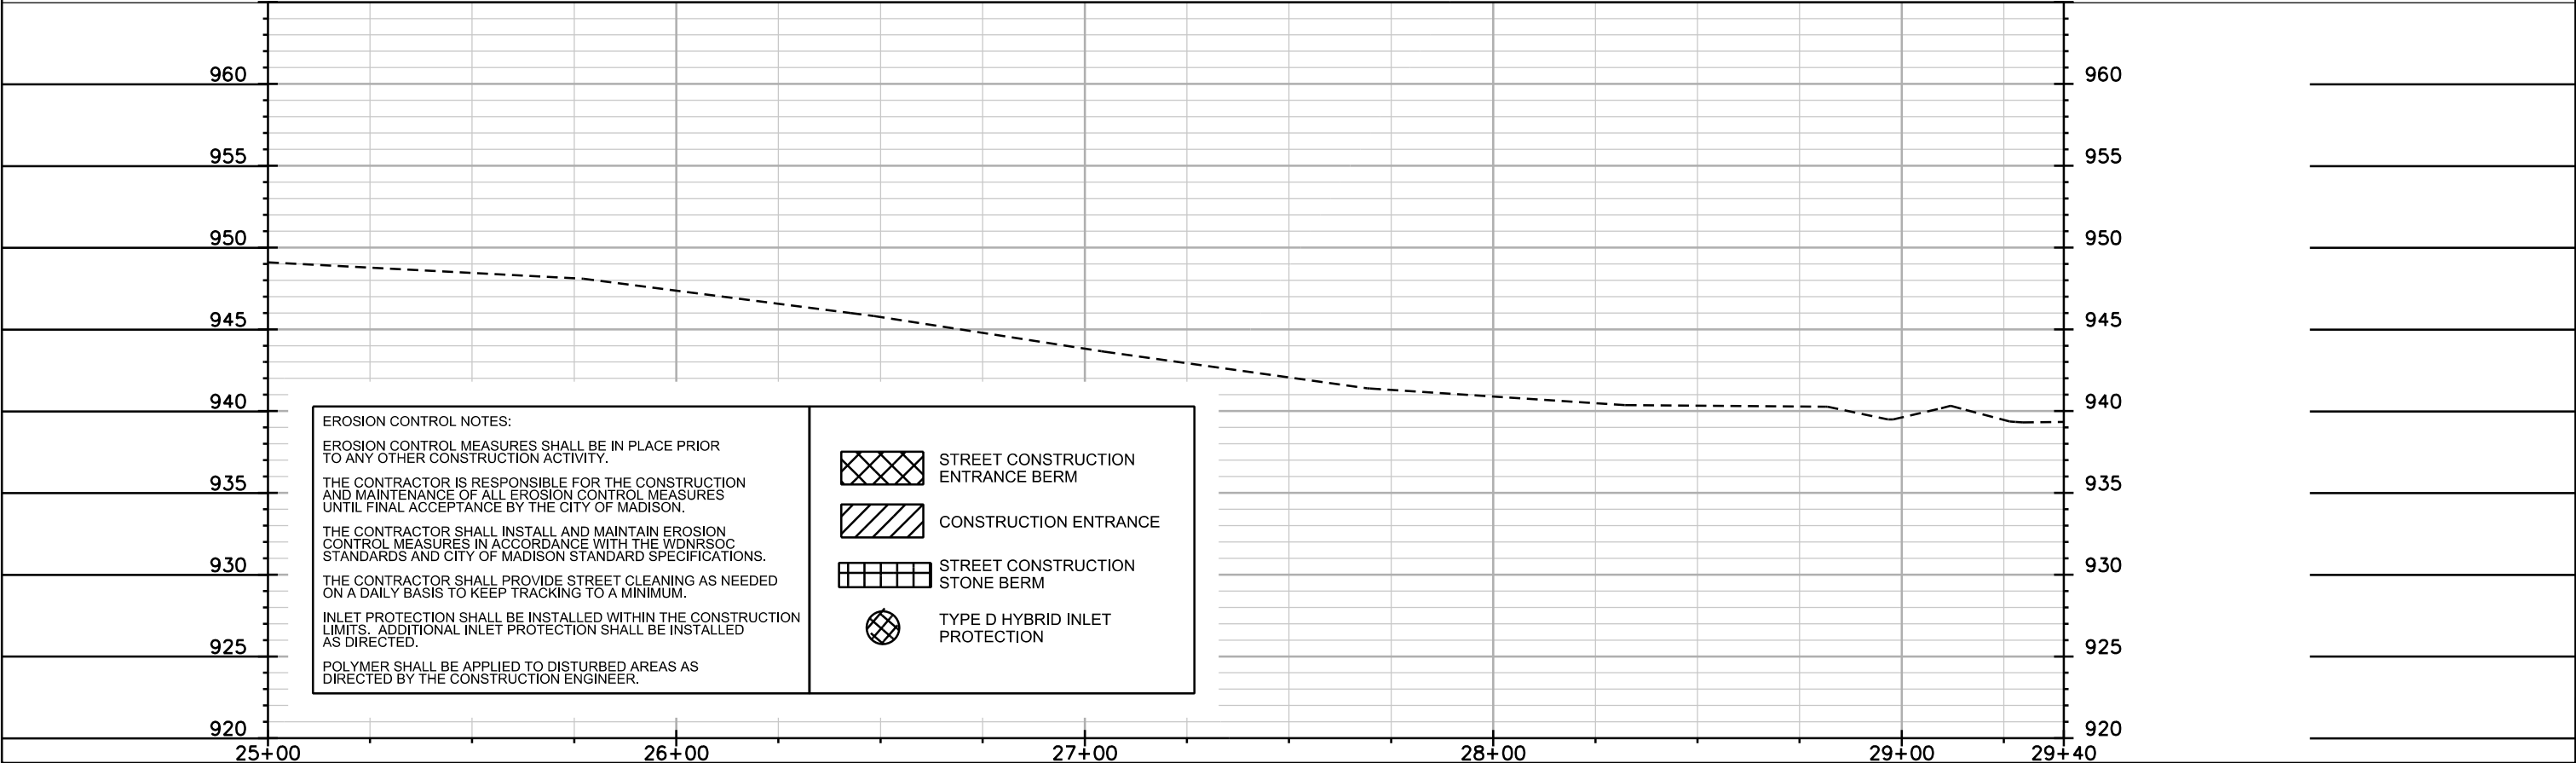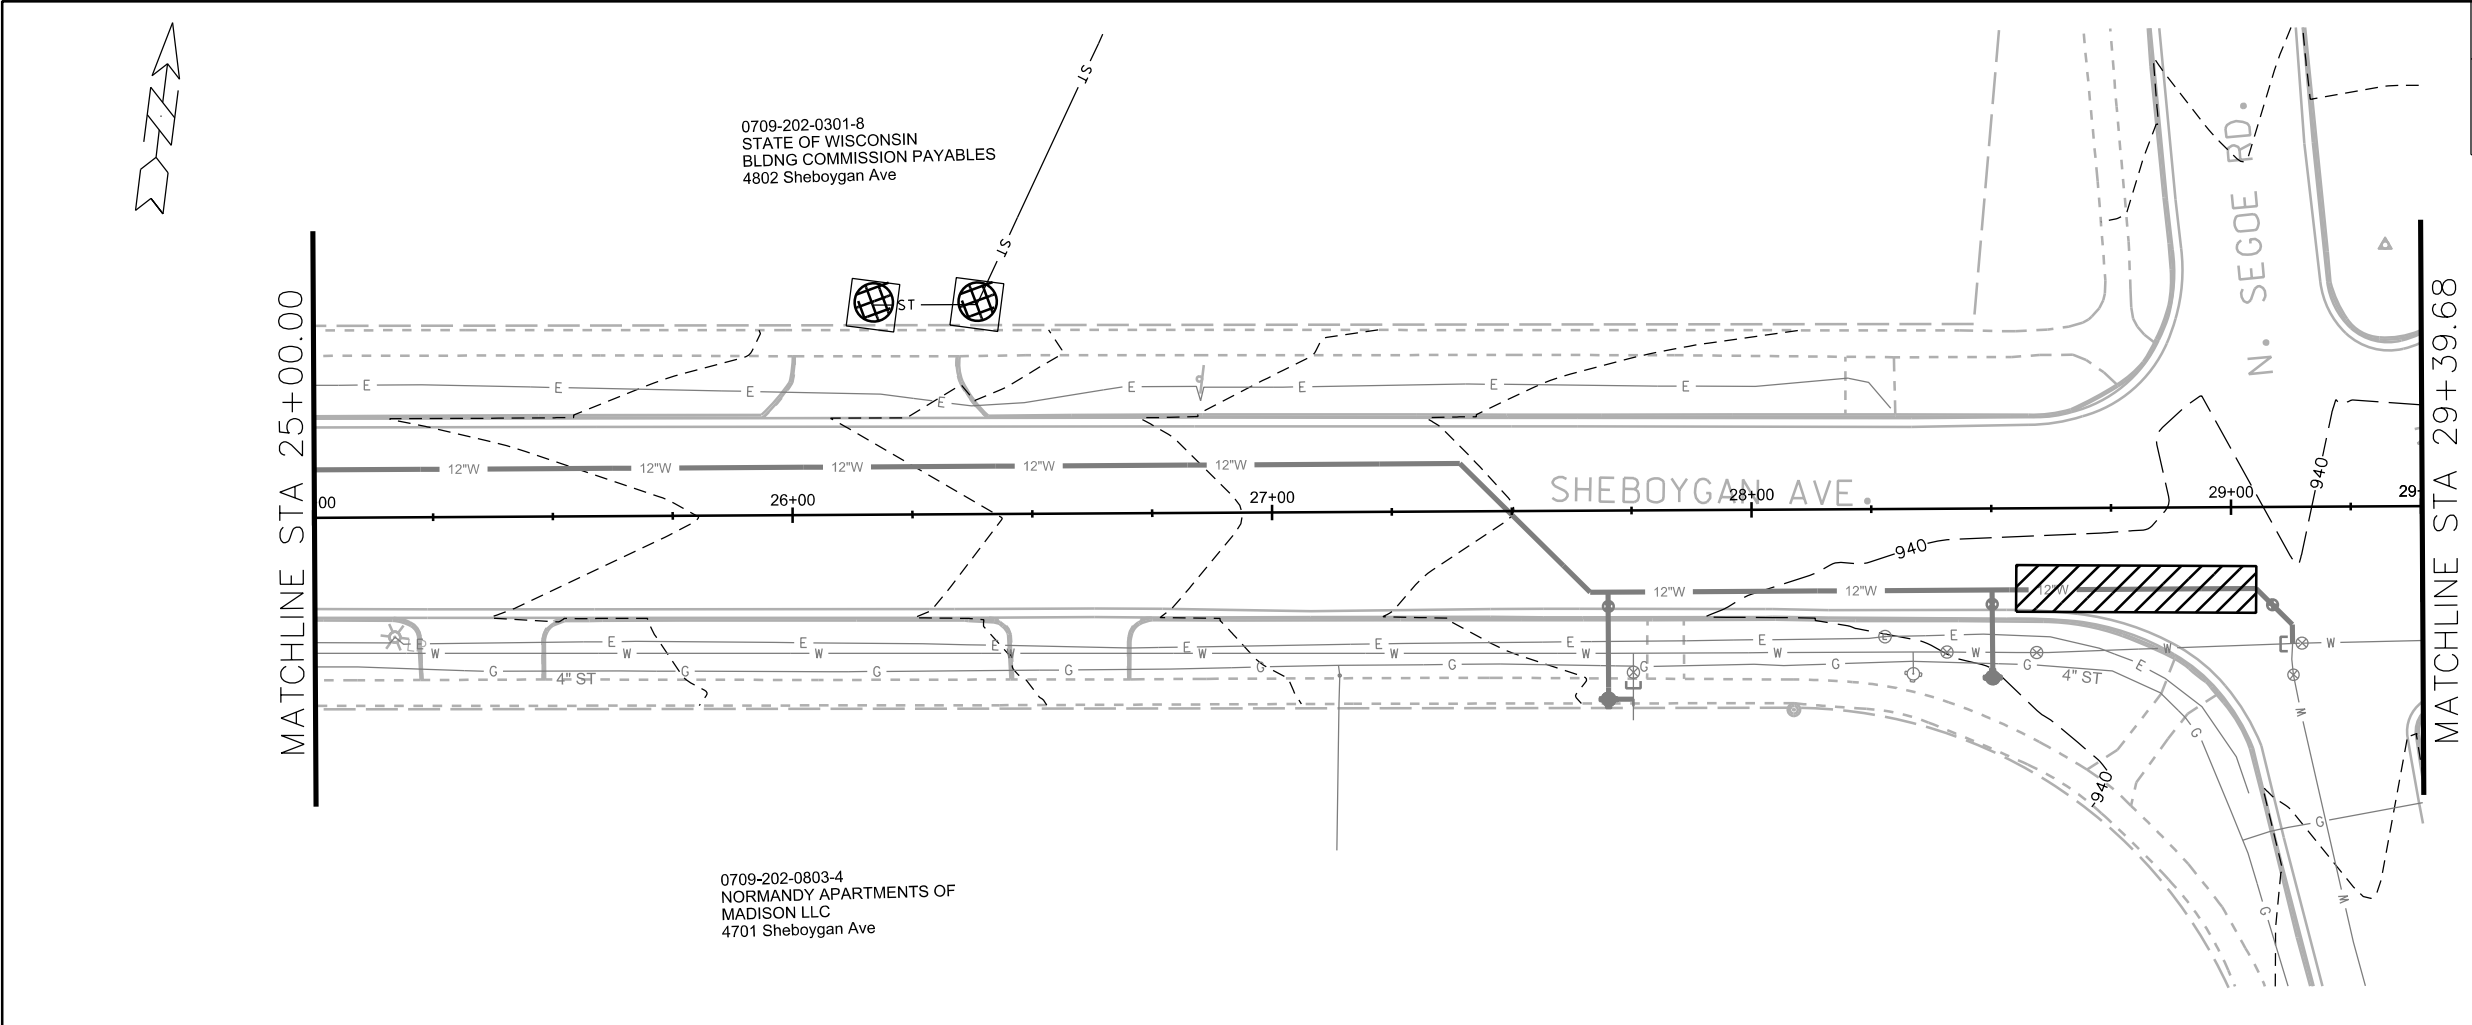



SHEBOYGAN AVE CITY OF MADISON


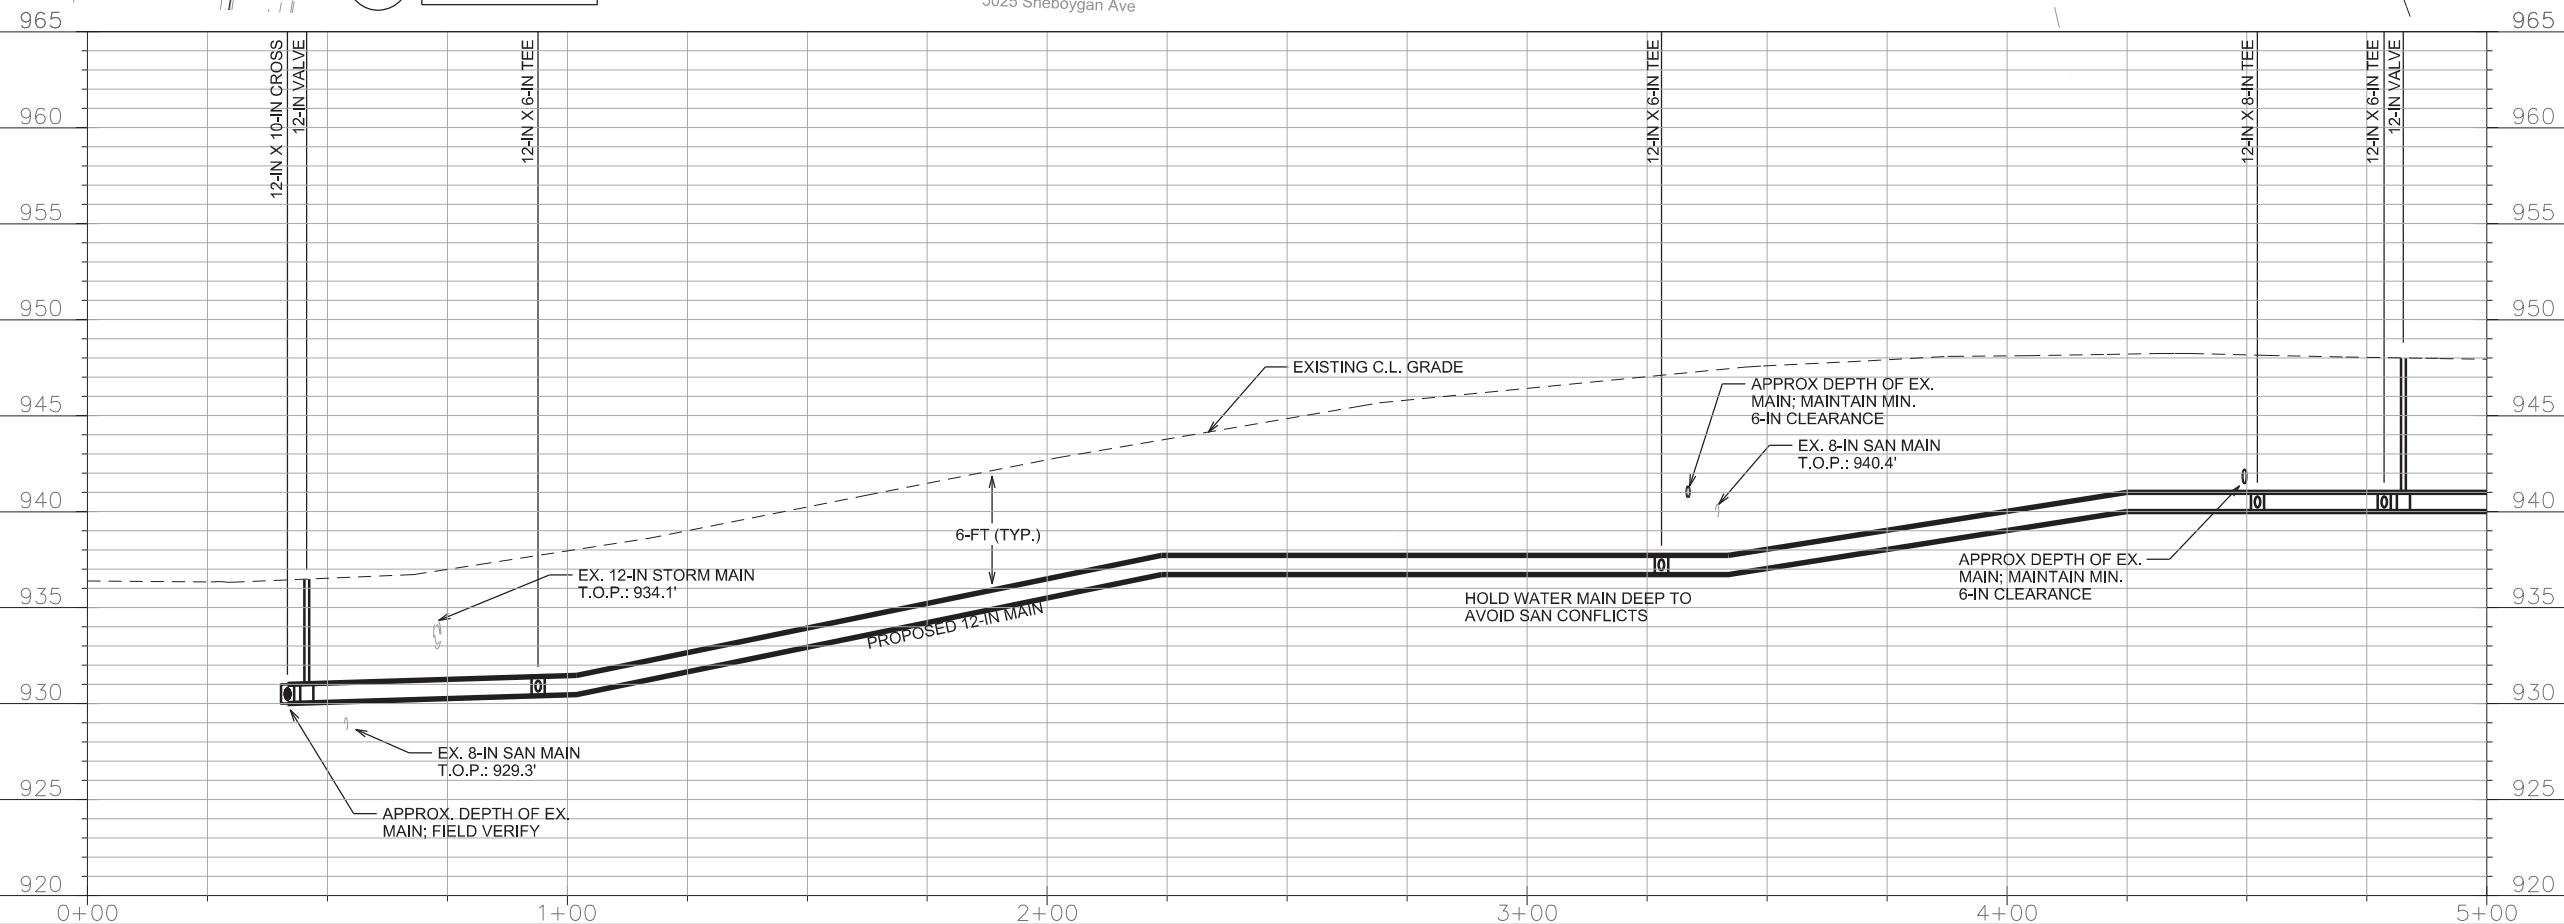


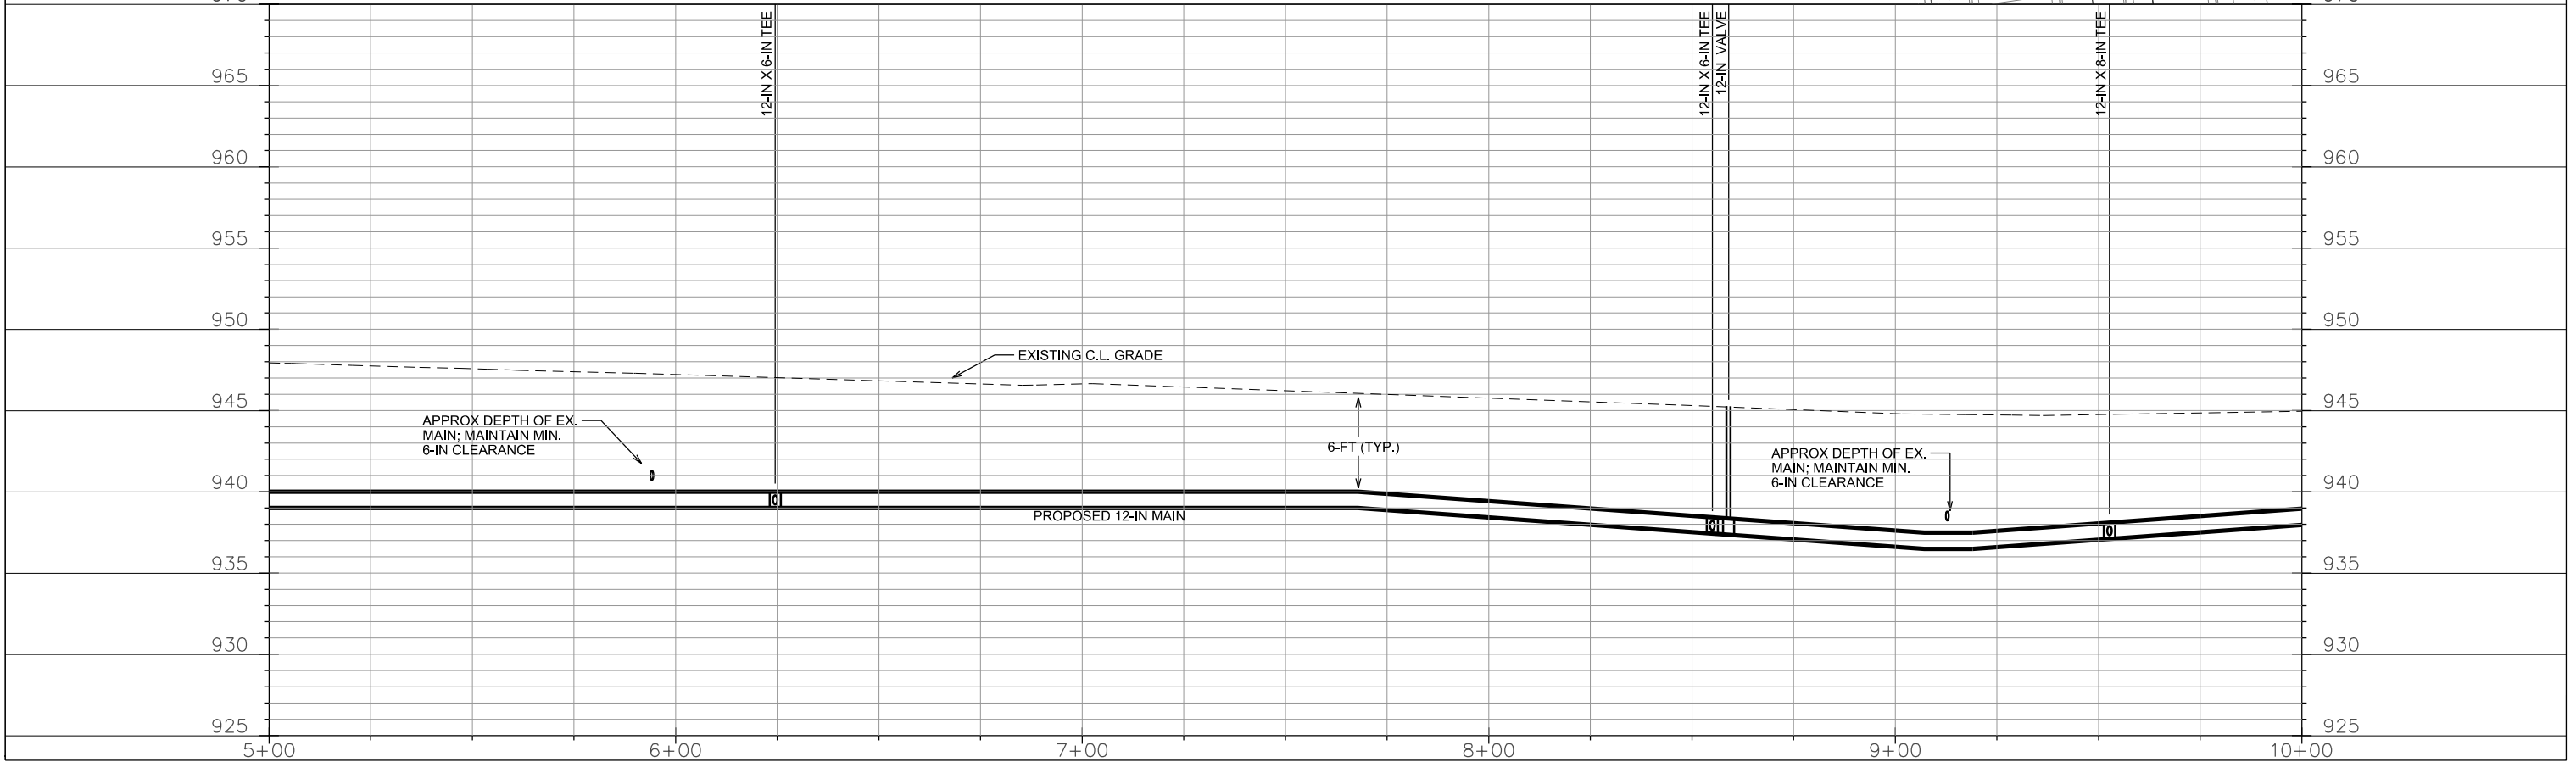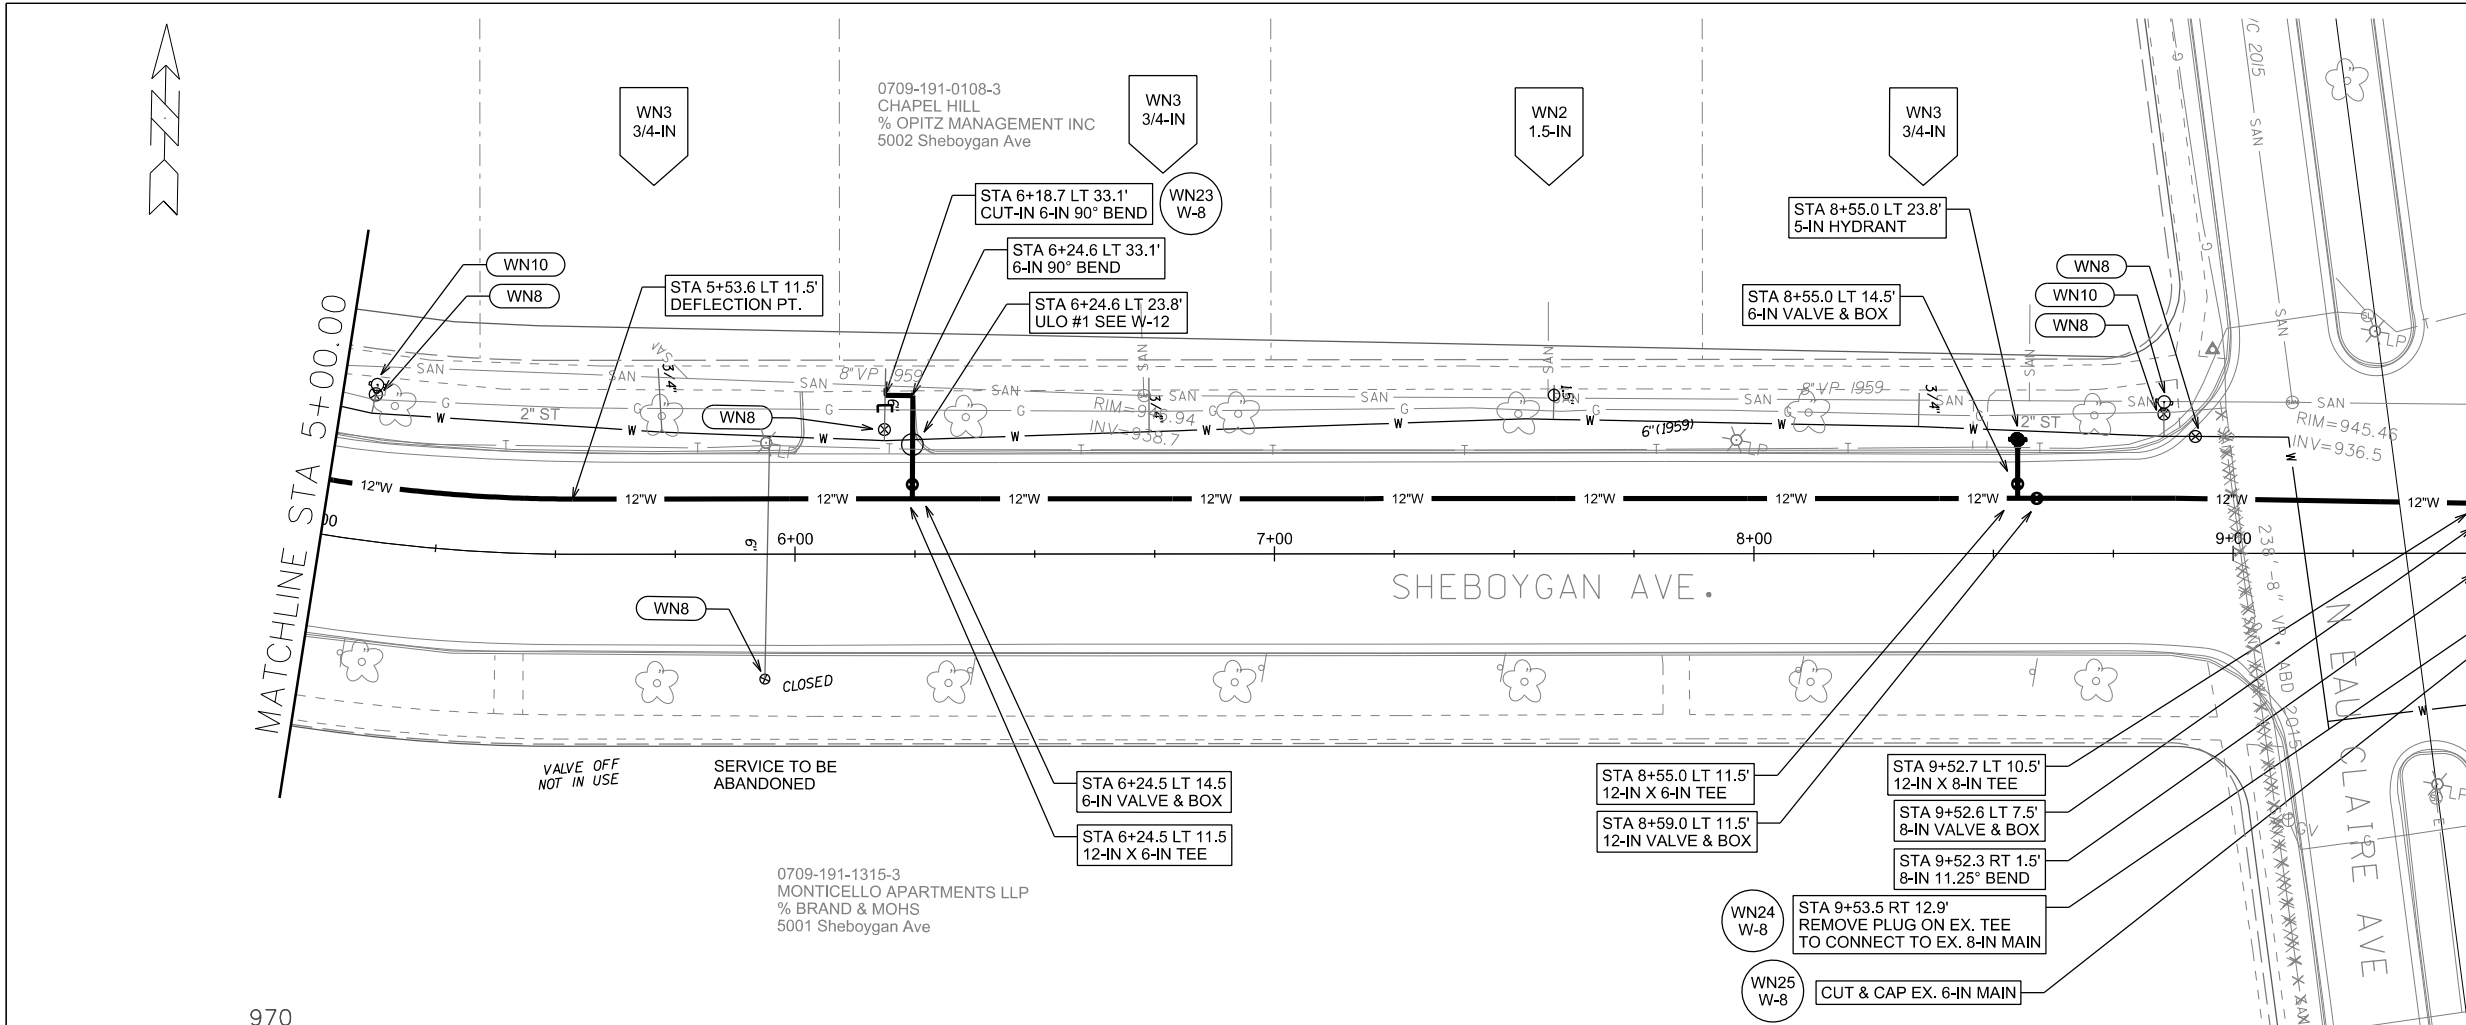



SHEBOYGAN AVE	CITY OF MADISON
---------------	-----------------

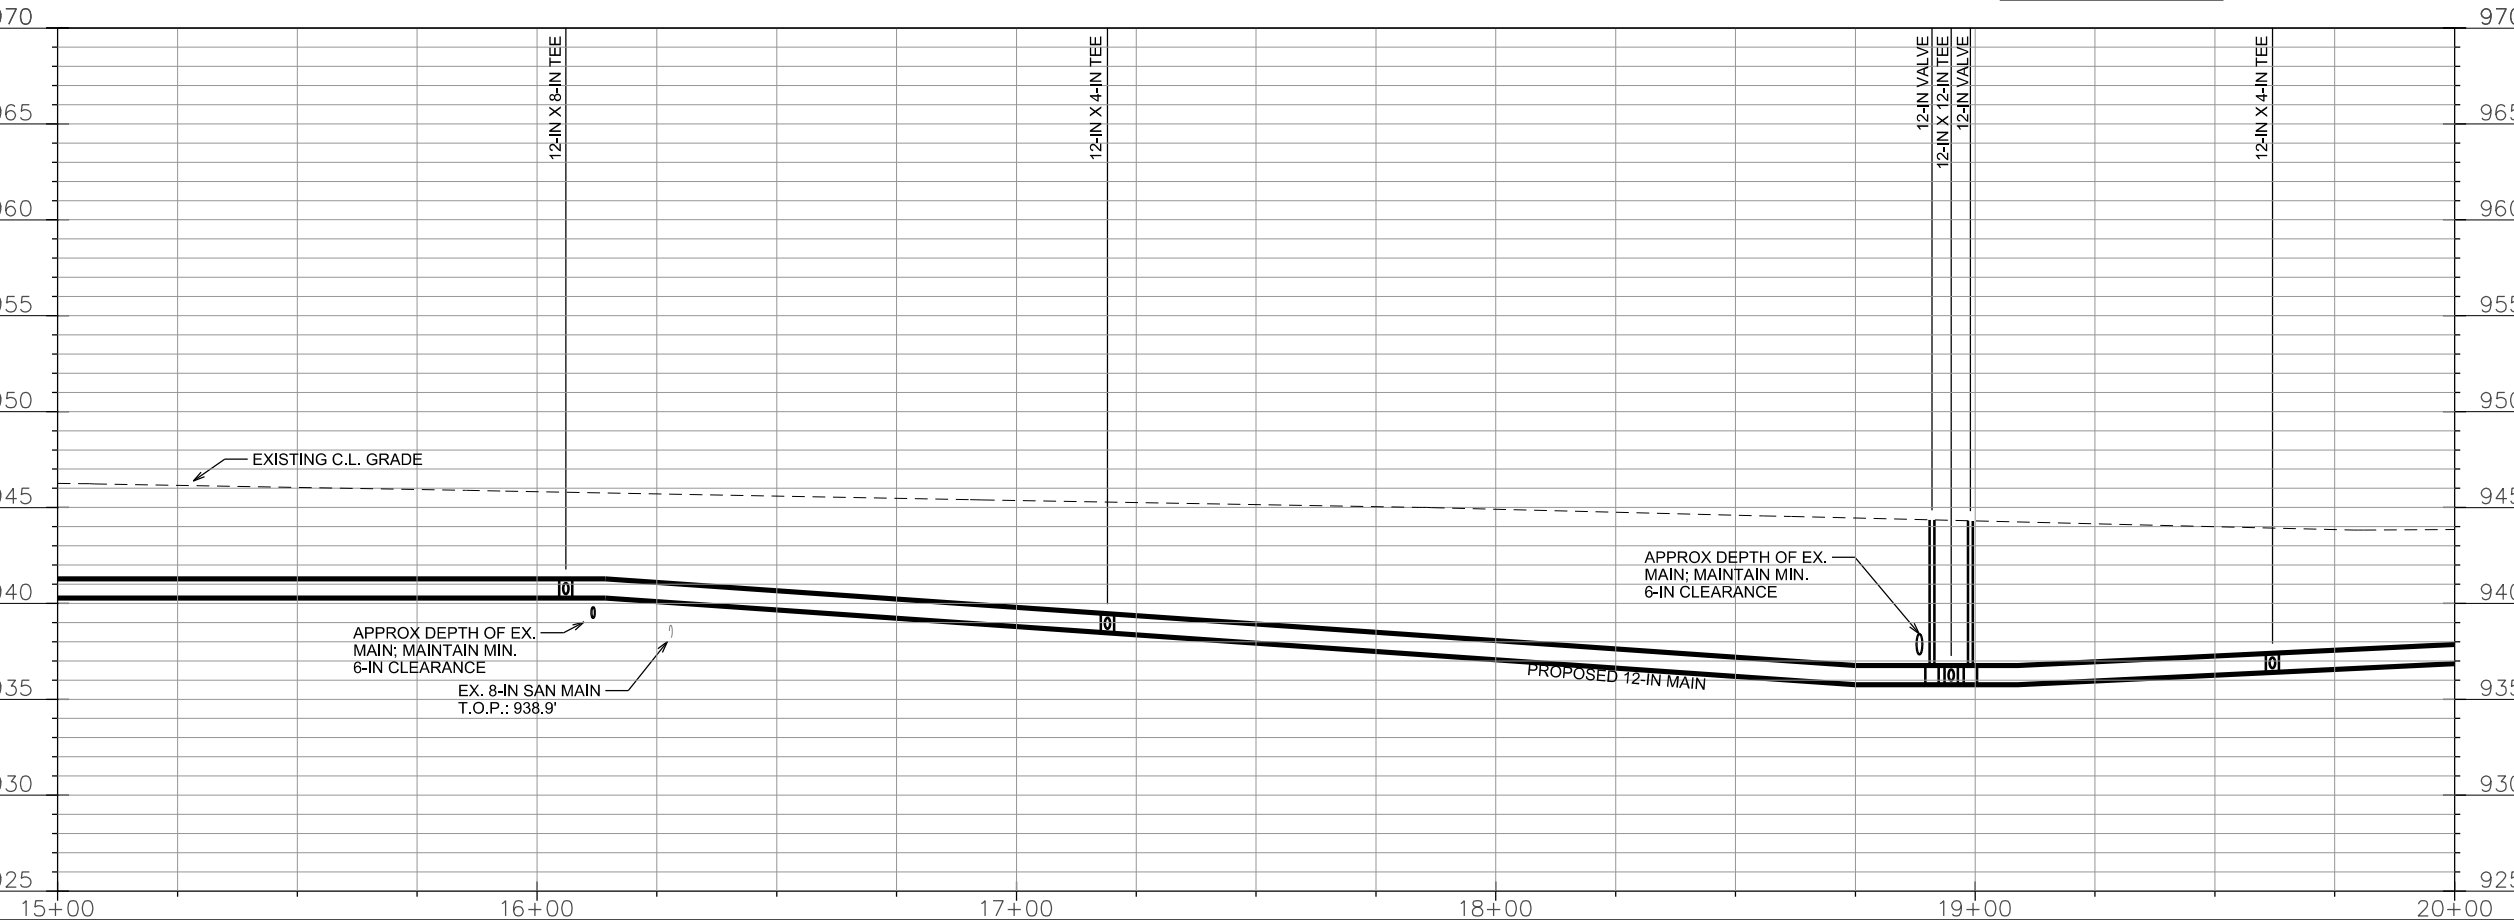

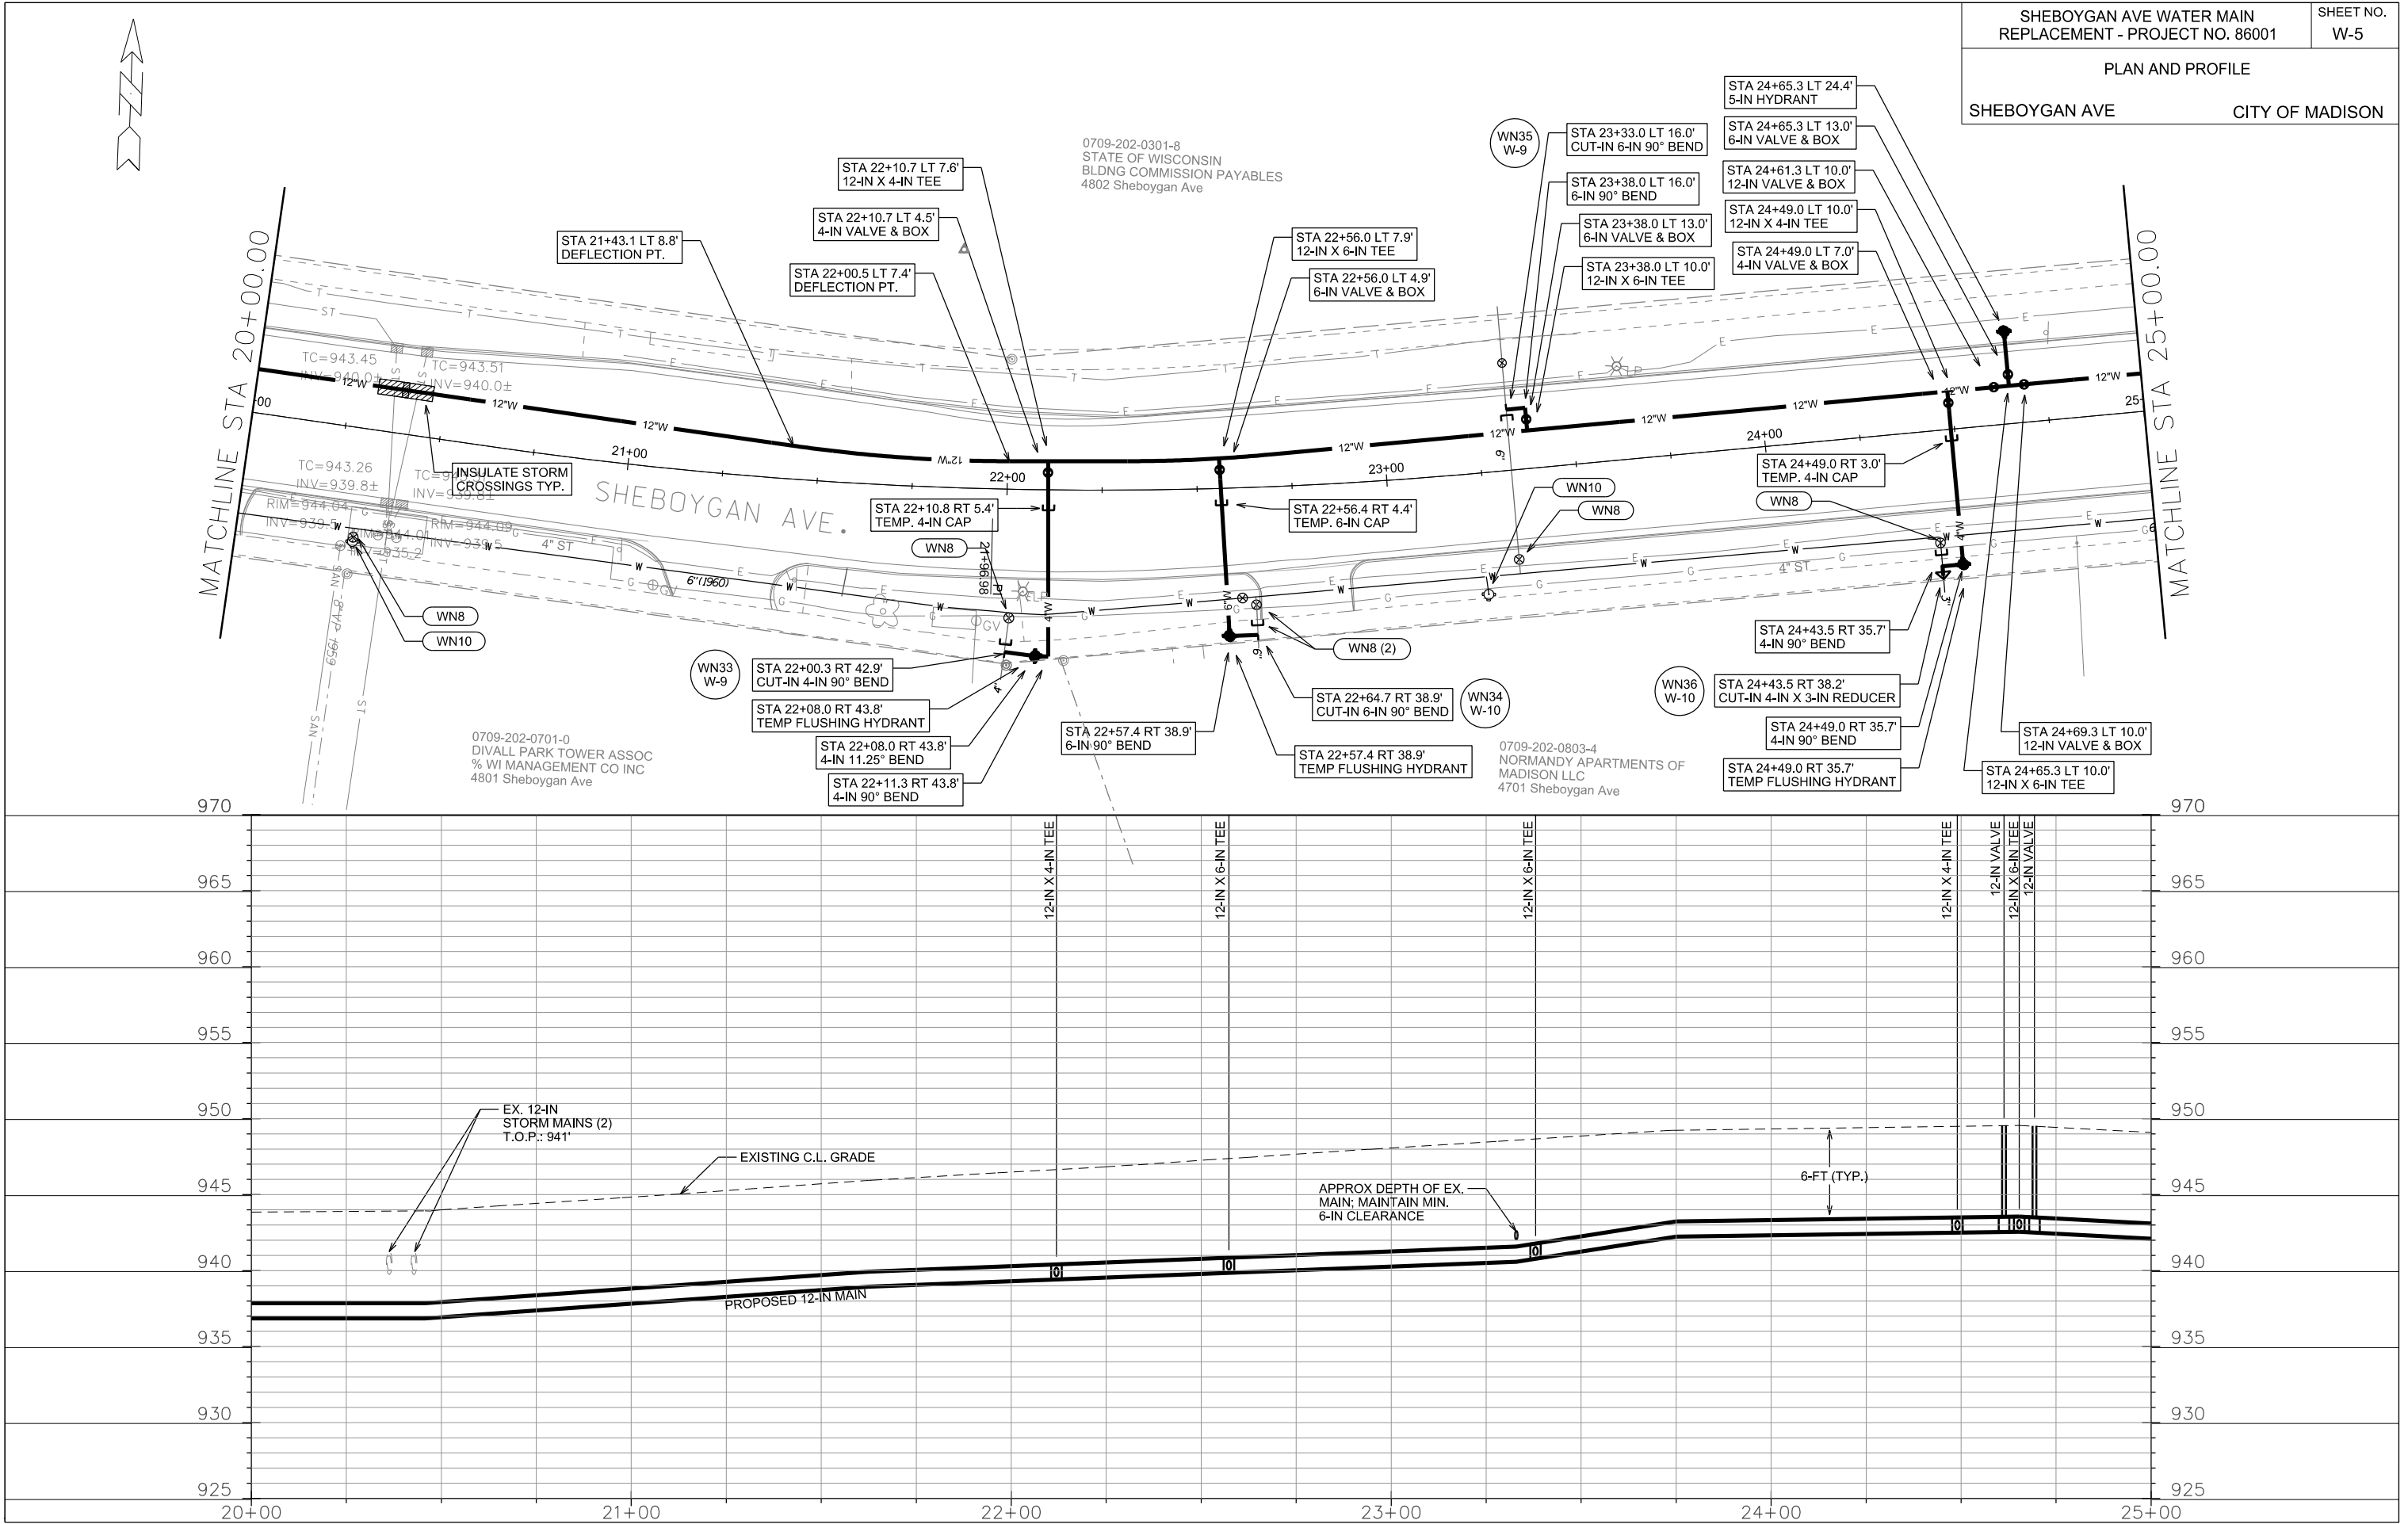

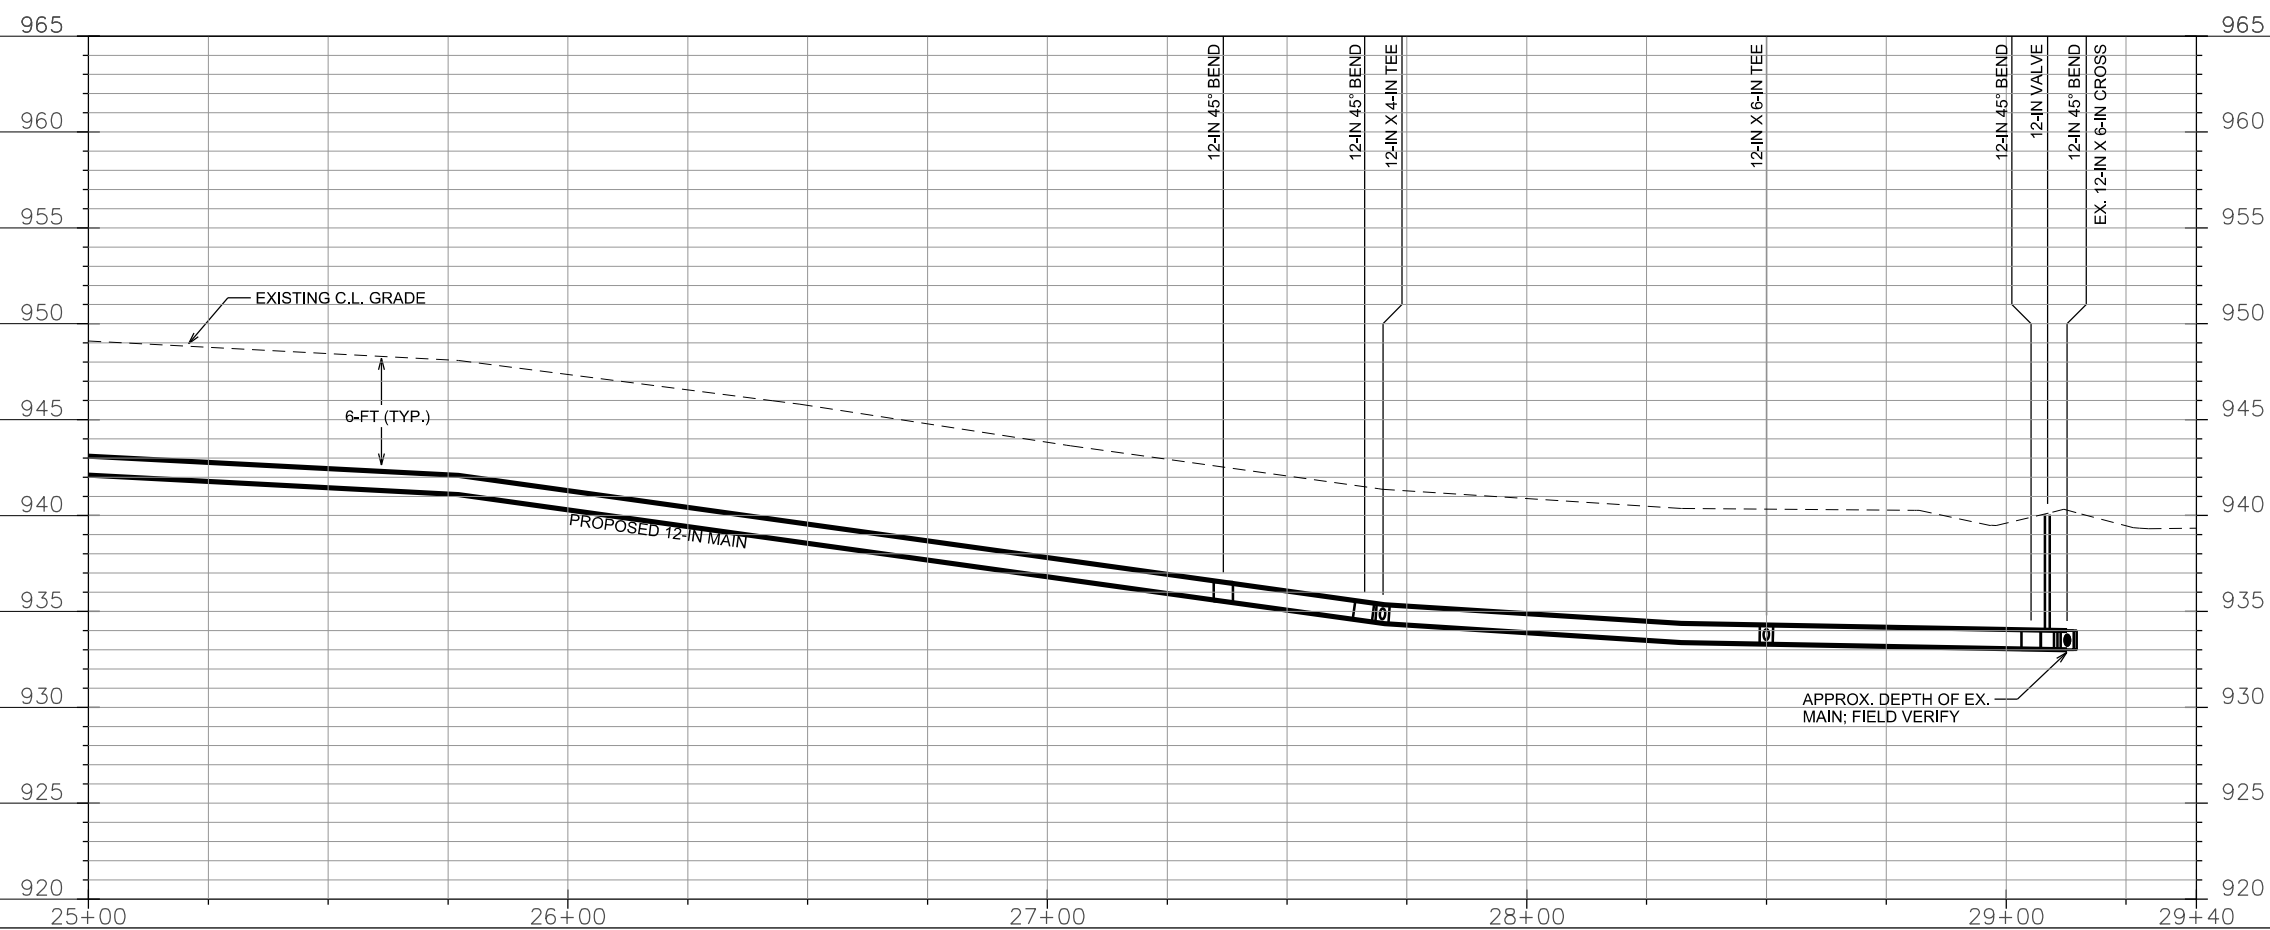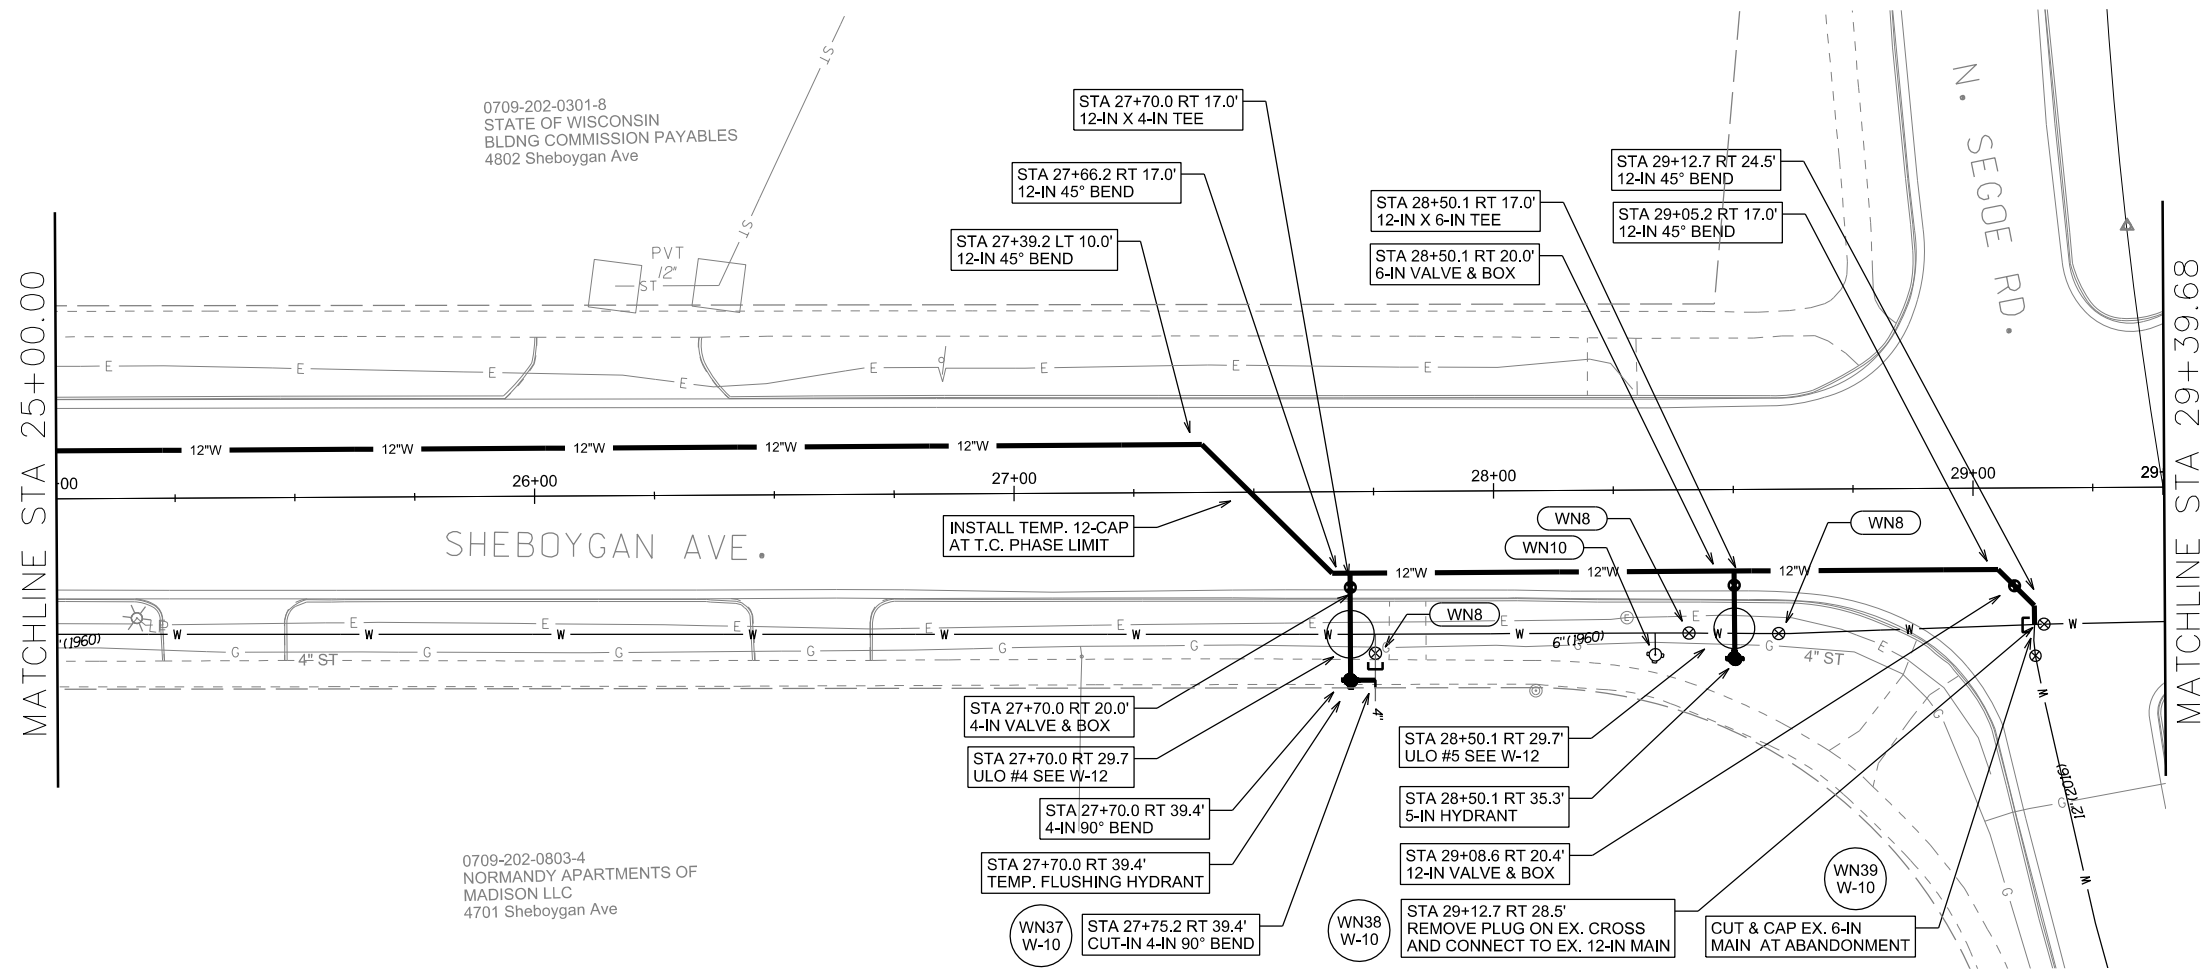

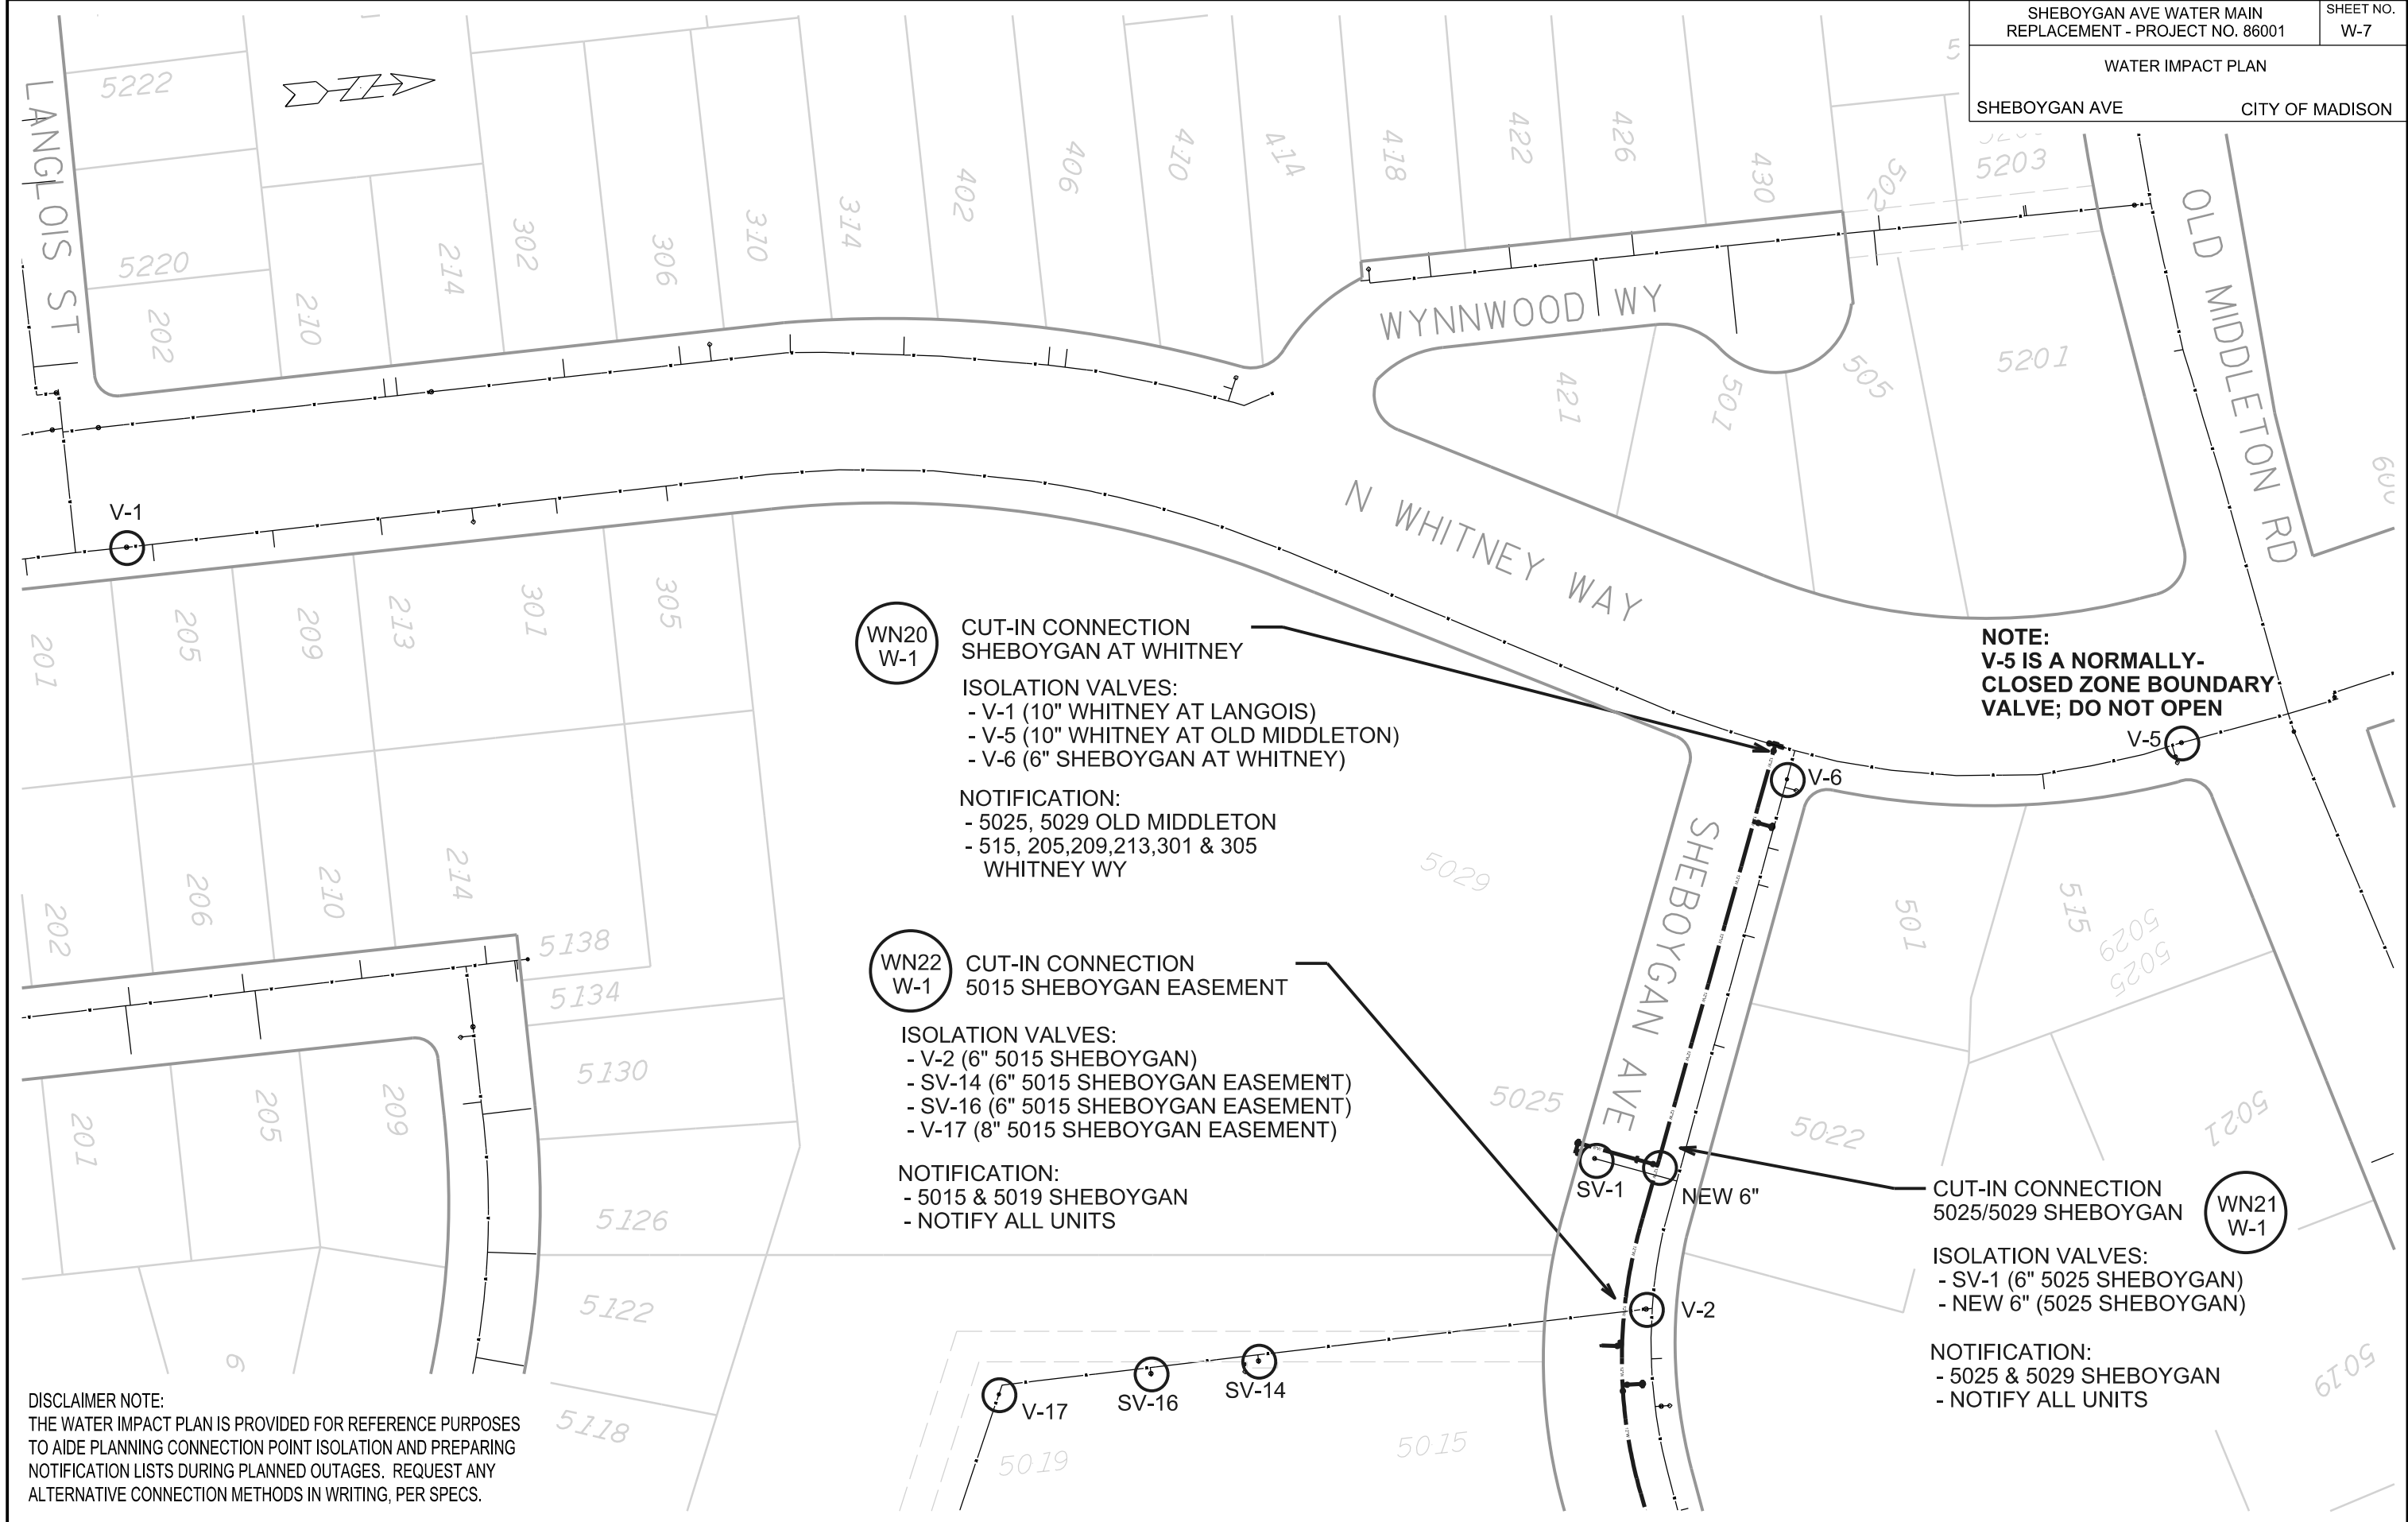

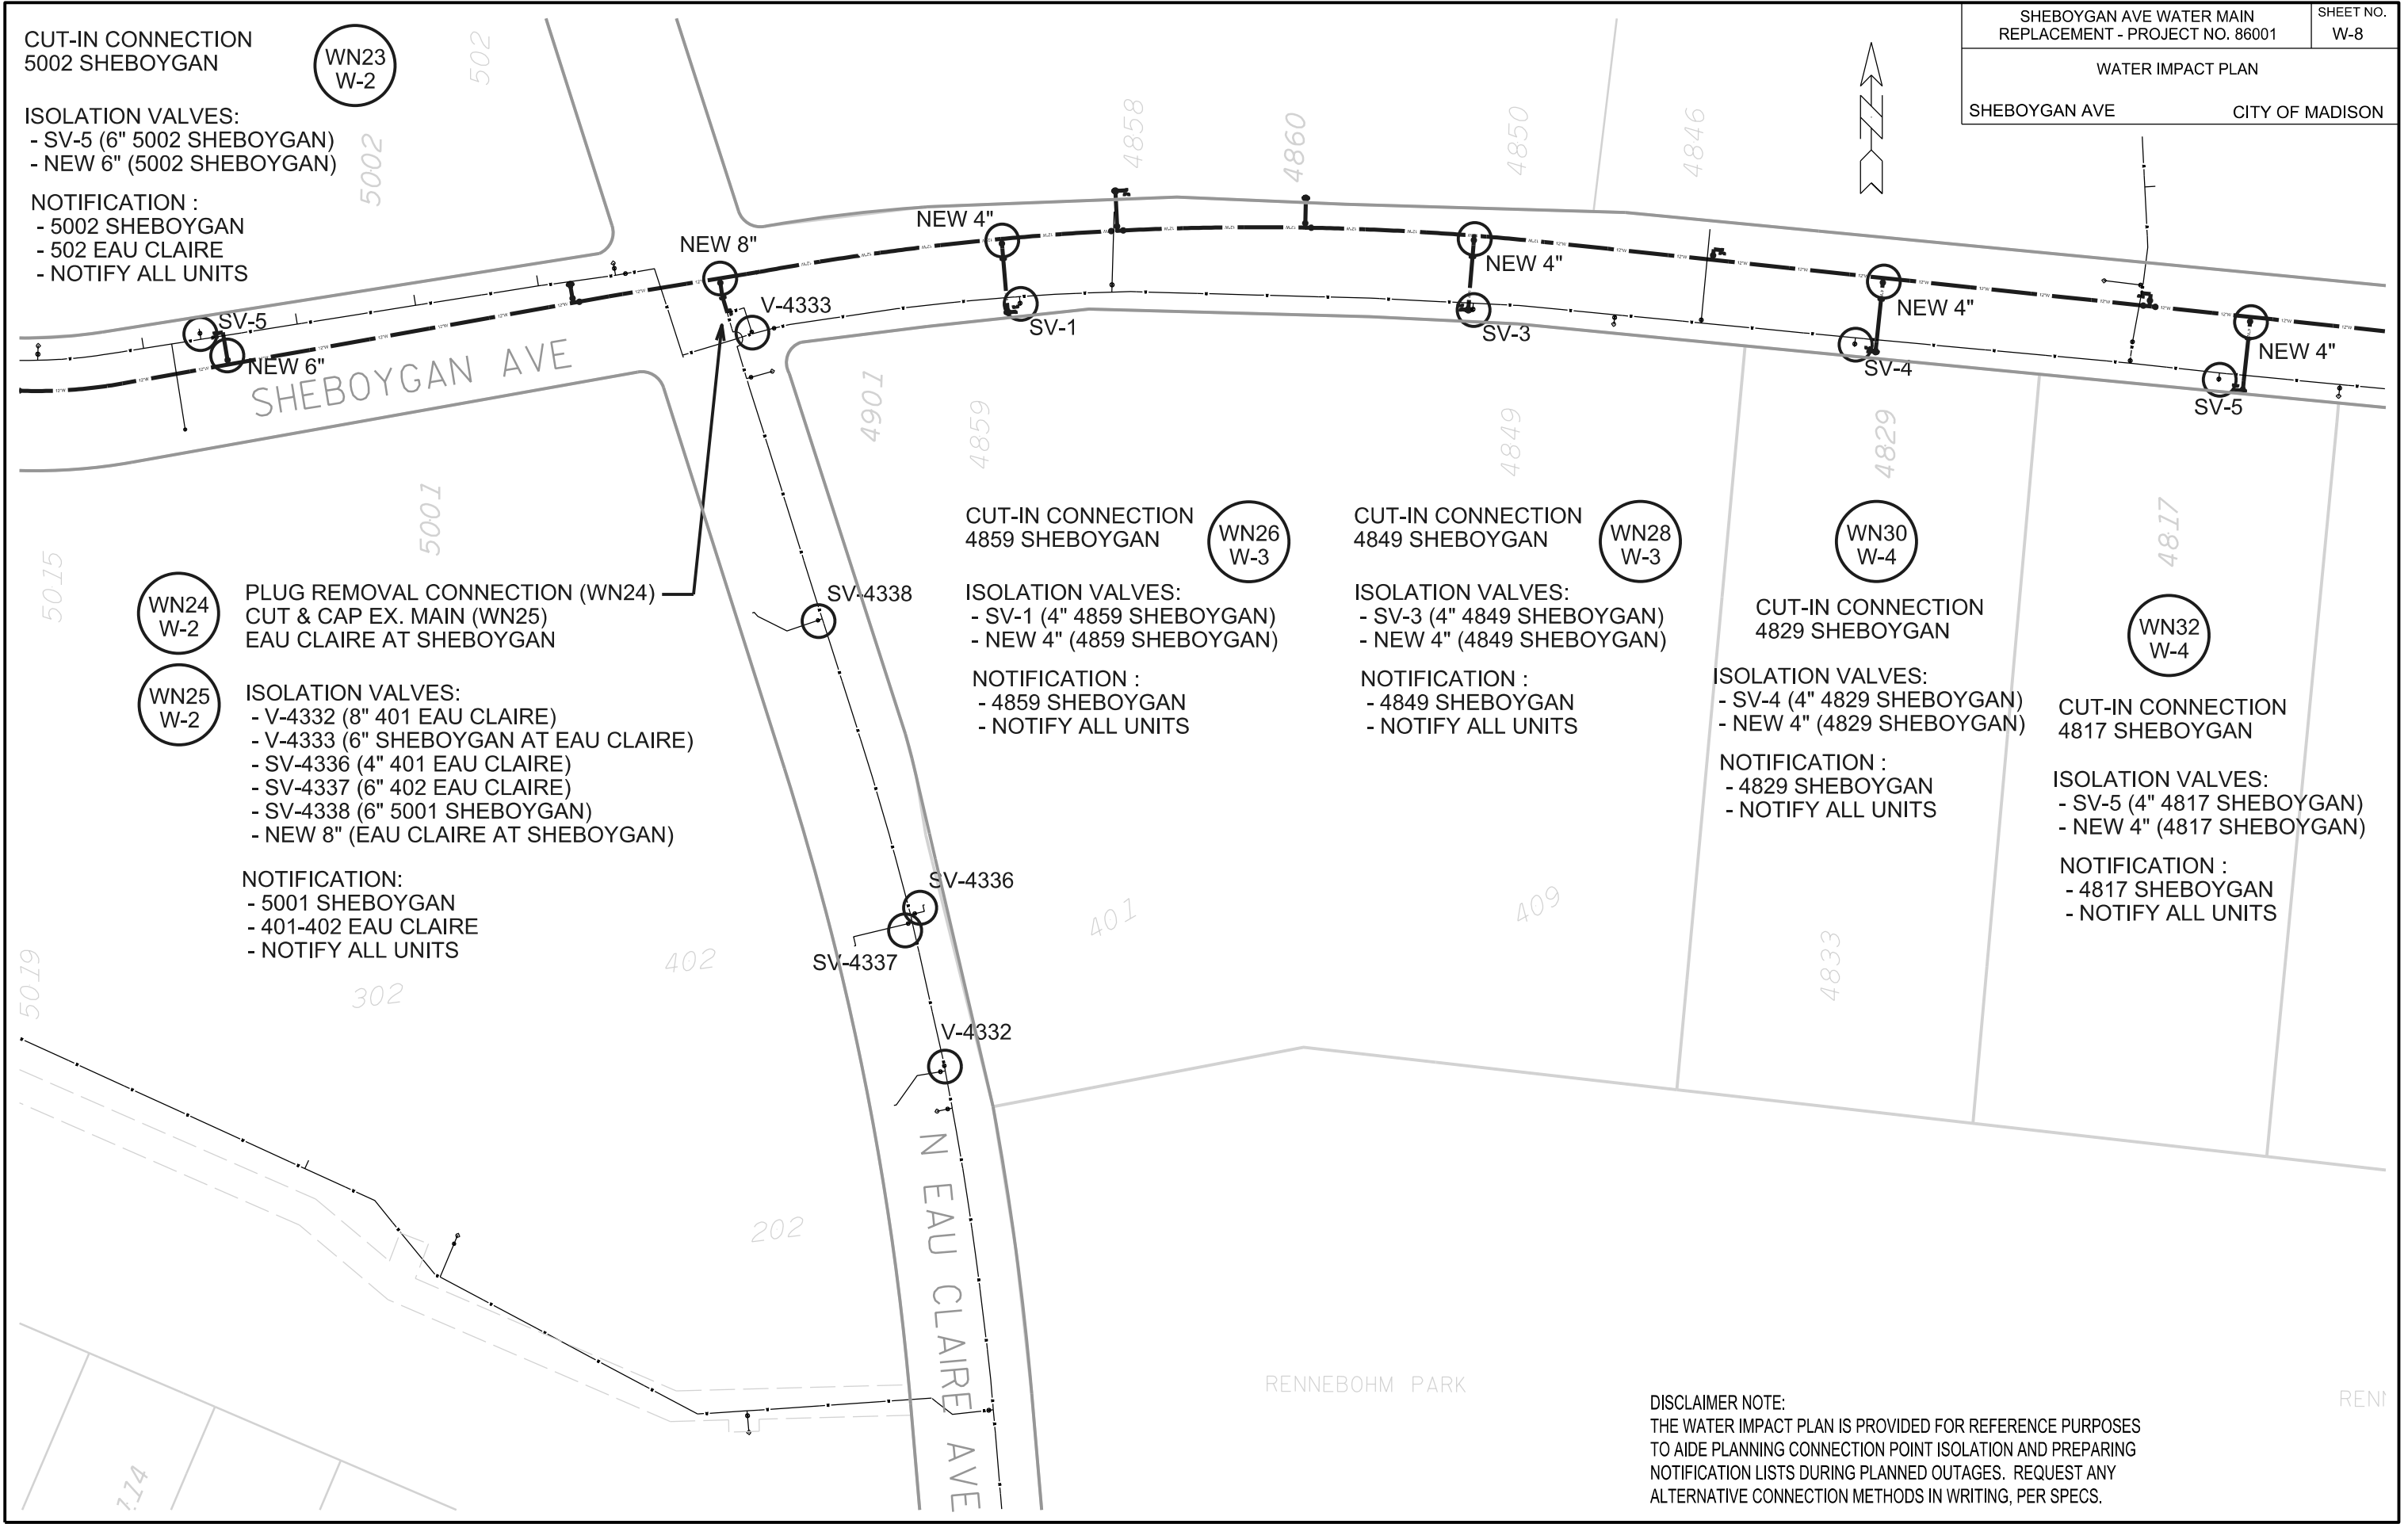

CUT-IN CONNECTION
5002 SHEBOYGAN

WN23
W-2

ISOLATION VALVES:
- SV-5 (6" 5002 SHEBOYGAN)
- NEW 6" (5002 SHEBOYGAN)

NOTIFICATION :
- 5002 SHEBOYGAN
- 502 EAU CLAIRE
- NOTIFY ALL UNITS

SHEBOYGAN AVE

NEW 8"

NEW 4"

NEW 4"

NEW 4"

NEW 4"

NEW 6"

WN24
W-2

PLUG REMOVAL CONNECTION (WN24)
CUT & CAP EX. MAIN (WN25)
EAU CLAIRE AT SHEBOYGAN

WN25
W-2

ISOLATION VALVES:
- V-4332 (8" 401 EAU CLAIRE)
- V-4333 (6" SHEBOYGAN AT EAU CLAIRE)
- SV-4336 (4" 401 EAU CLAIRE)
- SV-4337 (6" 402 EAU CLAIRE)
- SV-4338 (6" 5001 SHEBOYGAN)
- NEW 8" (EAU CLAIRE AT SHEBOYGAN)

NOTIFICATION:
- 5001 SHEBOYGAN
- 401-402 EAU CLAIRE
- NOTIFY ALL UNITS

CUT-IN CONNECTION
4859 SHEBOYGAN

WN26
W-3

ISOLATION VALVES:
- SV-1 (4" 4859 SHEBOYGAN)
- NEW 4" (4859 SHEBOYGAN)

NOTIFICATION :
- 4859 SHEBOYGAN
- NOTIFY ALL UNITS

CUT-IN CONNECTION
4849 SHEBOYGAN

WN28
W-3

ISOLATION VALVES:
- SV-3 (4" 4849 SHEBOYGAN)
- NEW 4" (4849 SHEBOYGAN)

NOTIFICATION :
- 4849 SHEBOYGAN
- NOTIFY ALL UNITS

CUT-IN CONNECTION
4829 SHEBOYGAN

WN30
W-4

ISOLATION VALVES:
- SV-4 (4" 4829 SHEBOYGAN)
- NEW 4" (4829 SHEBOYGAN)

NOTIFICATION :
- 4829 SHEBOYGAN
- NOTIFY ALL UNITS

CUT-IN CONNECTION
4817 SHEBOYGAN


WN32
W-4

ISOLATION VALVES:
- SV-5 (4" 4817 SHEBOYGAN)
- NEW 4" (4817 SHEBOYGAN)


NOTIFICATION :
- 4817 SHEBOYGAN
- NOTIFY ALL UNITS

RENNEBOHM PARK

DISCLAIMER NOTE:
THE WATER IMPACT PLAN IS PROVIDED FOR REFERENCE PURPOSES
TO AIDE PLANNING CONNECTION POINT ISOLATION AND PREPARING
NOTIFICATION LISTS DURING PLANNED OUTAGES. REQUEST ANY
ALTERNATIVE CONNECTION METHODS IN WRITING, PER SPECS.

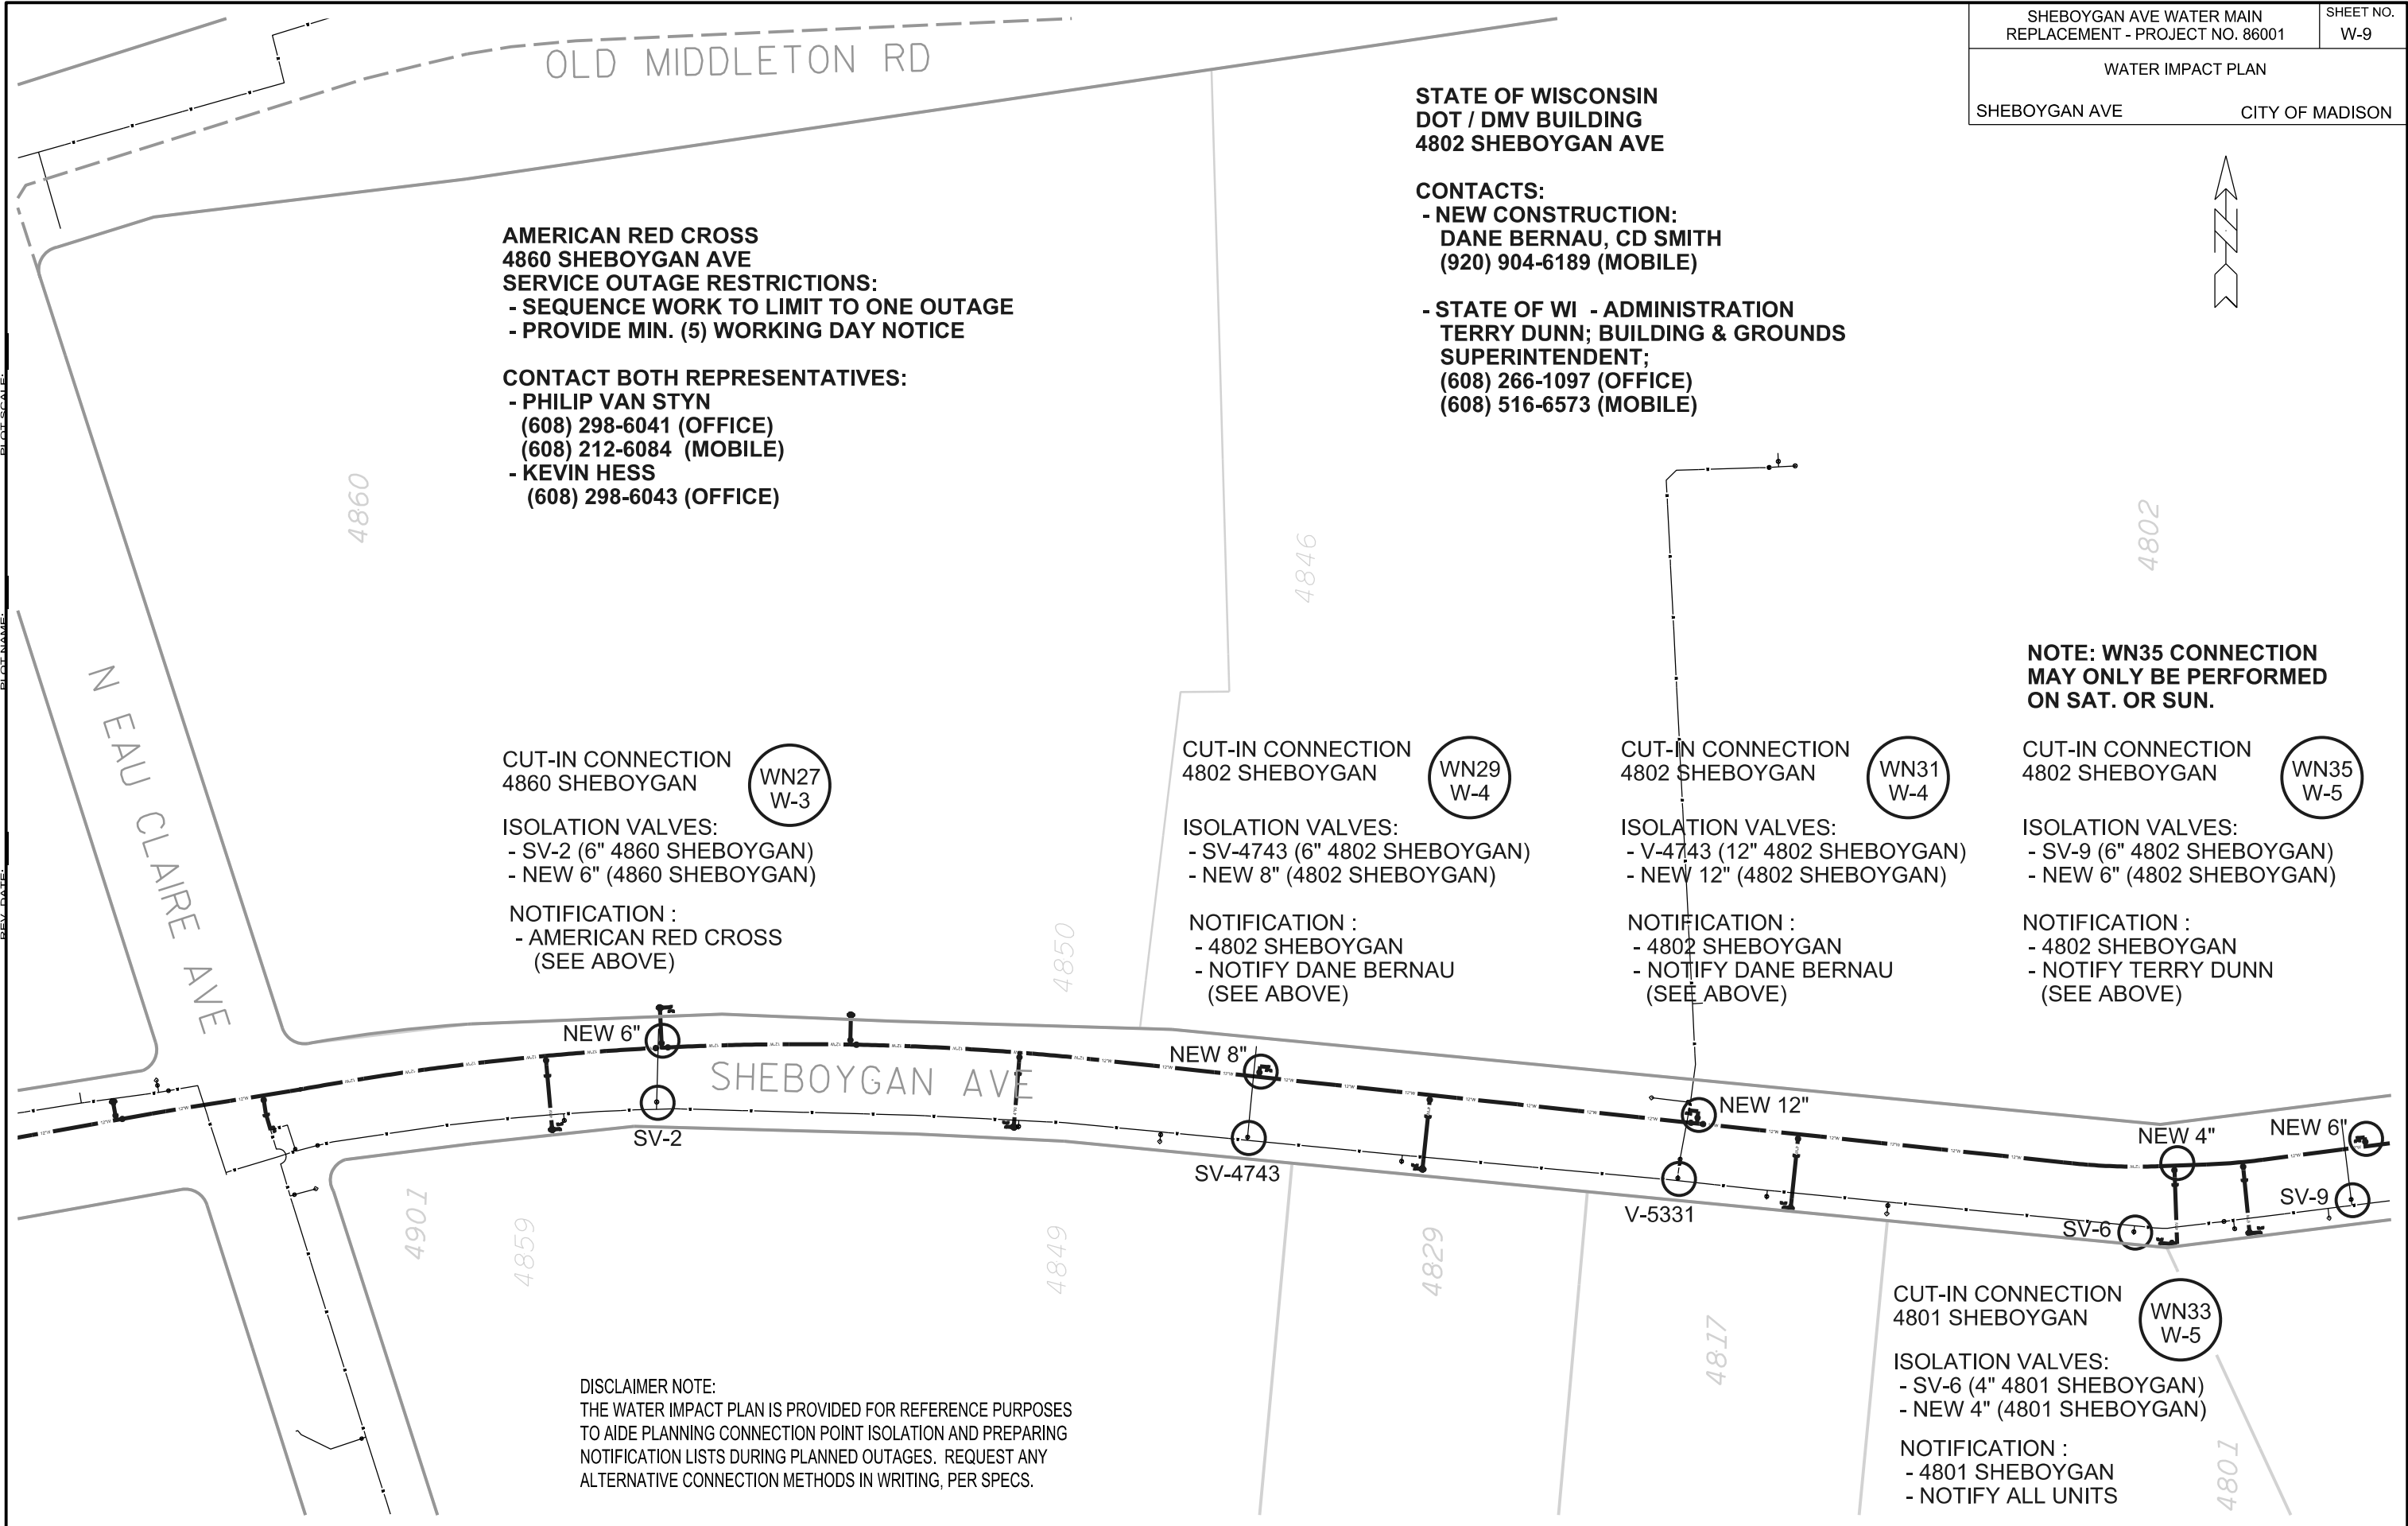

ORIGINATOR: CITY OF MADISON, STREETS DIVISION

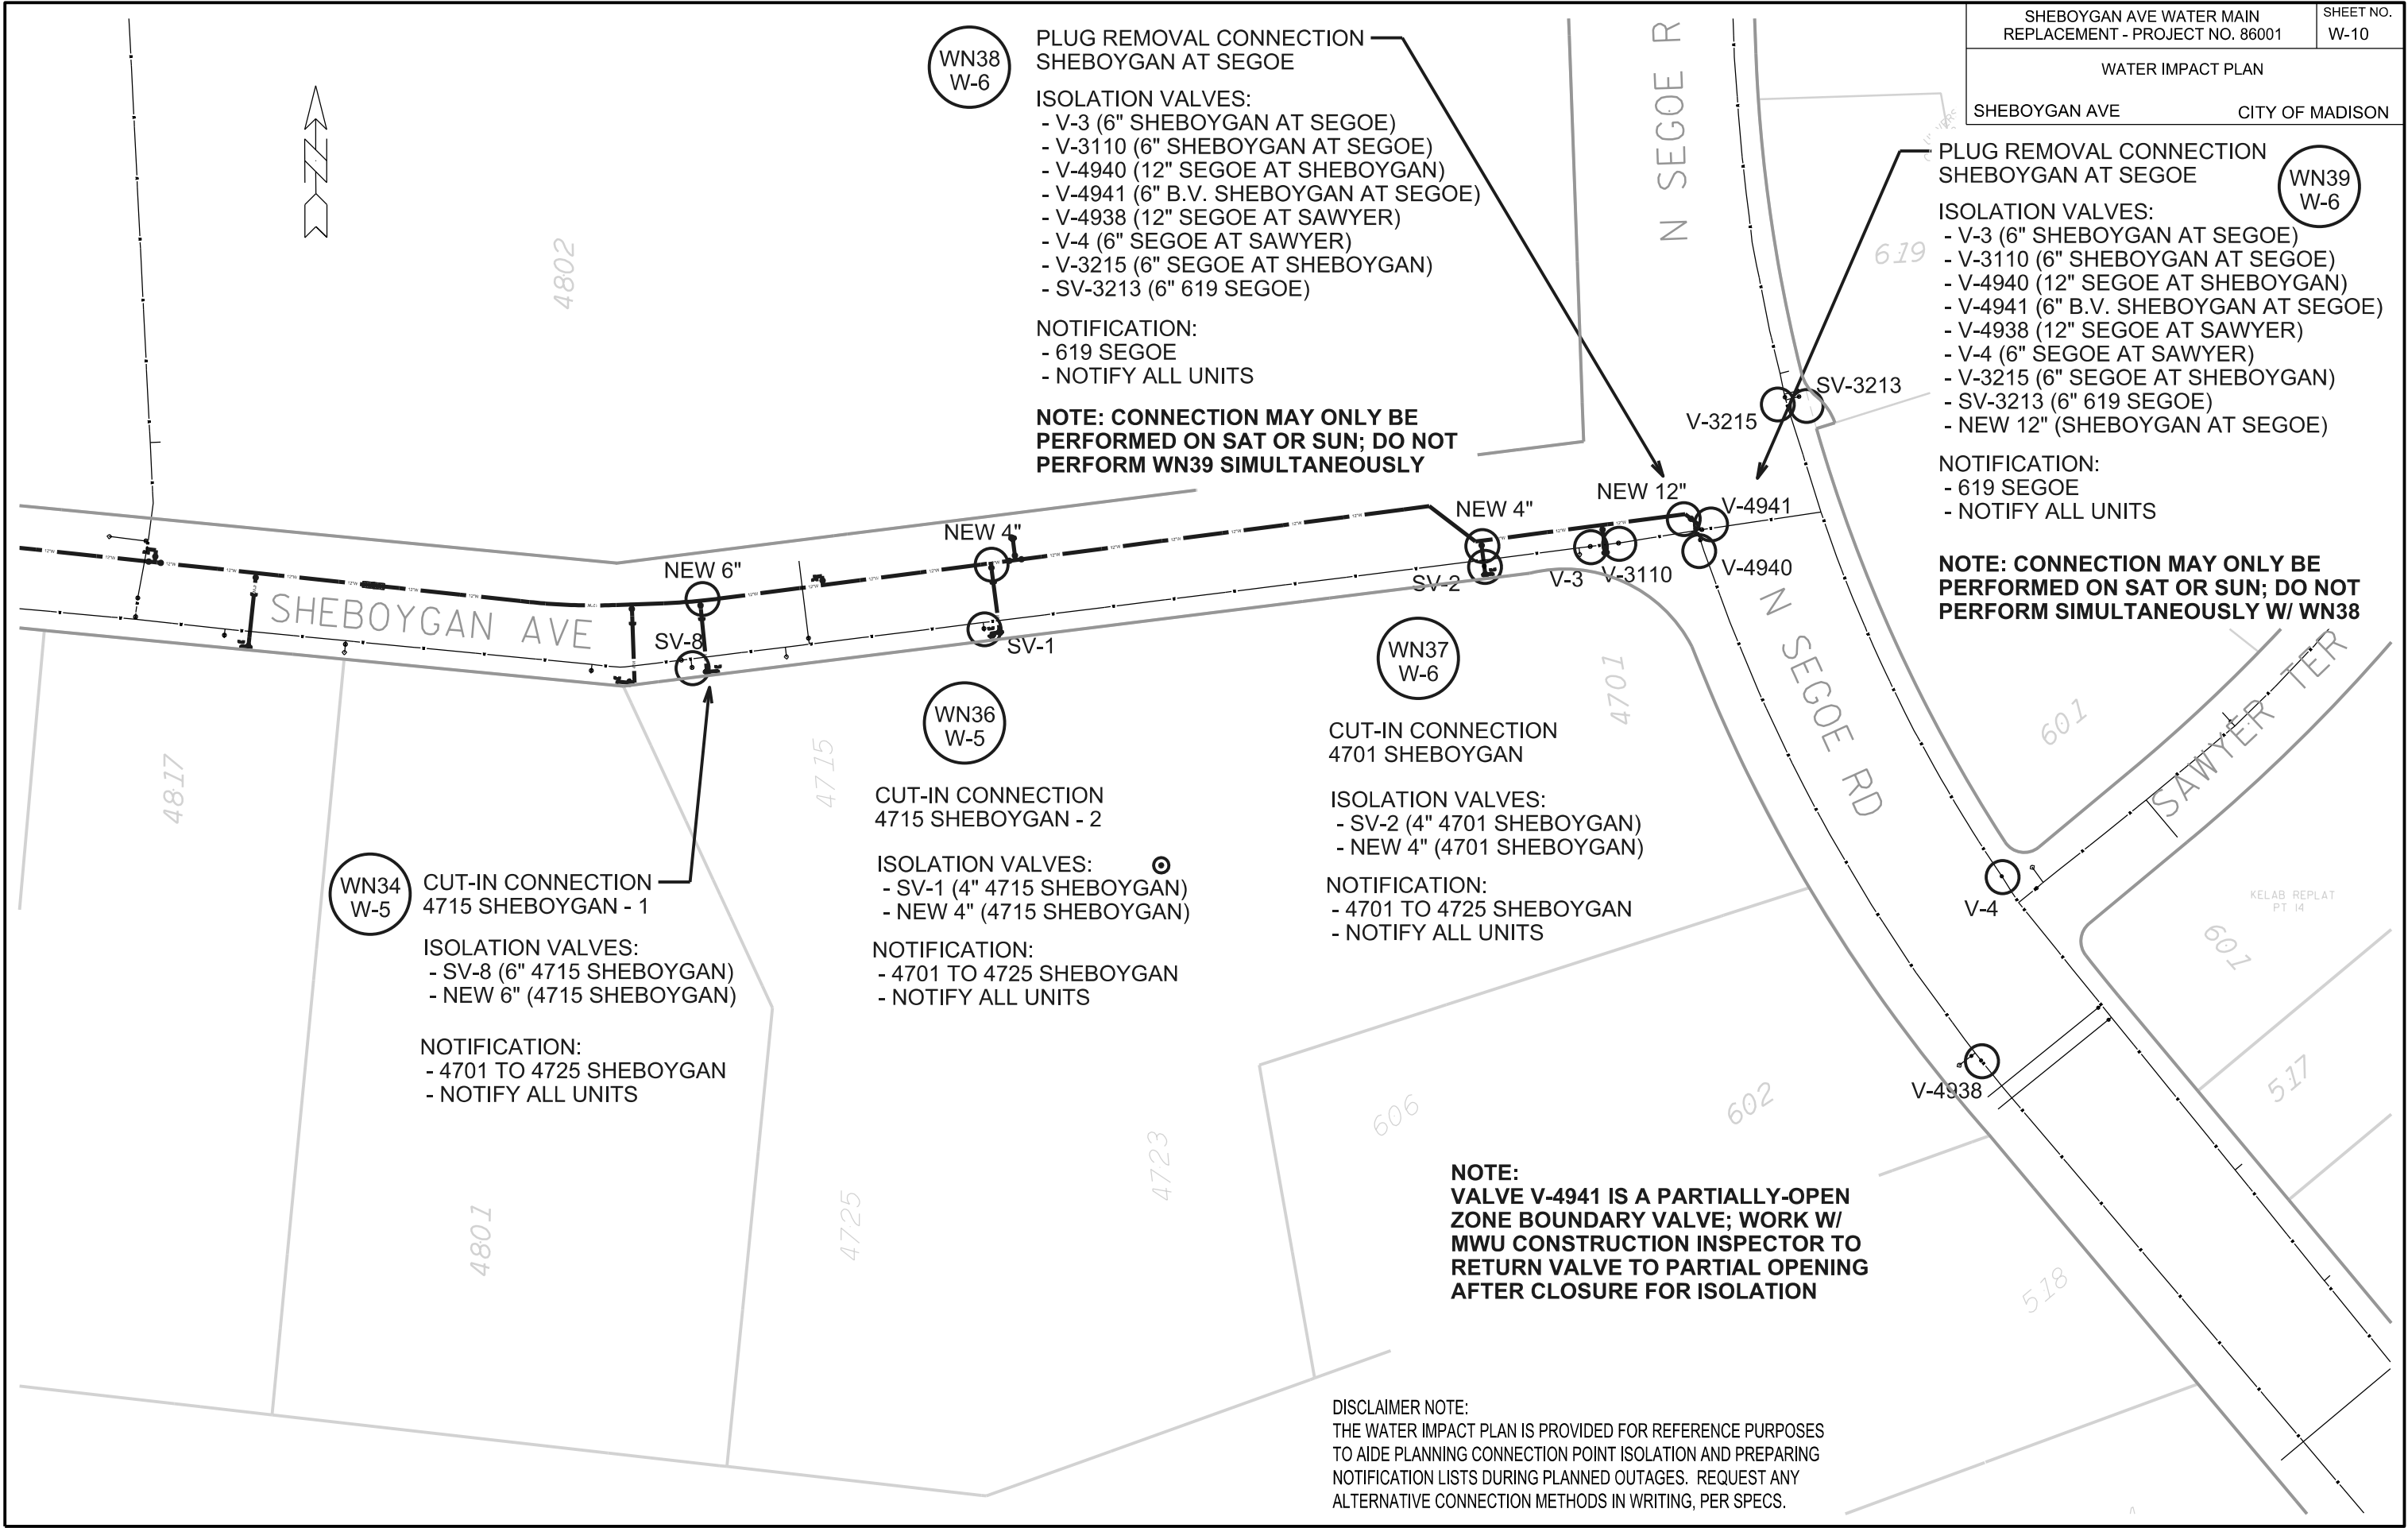

SHEBOYGAN AVE WATER MAIN REPLACEMENT - PROJECT NO. 86001		SHEET NO. W-10
WATER IMPACT PLAN		
SHEBOYGAN AVE		CITY OF MADISON

PLUG REMOVAL CONNECTION
SHEBOYGAN AT SEGOE

ISOLATION VALVES:

- V-3 (6" SHEBOYGAN AT SEGOE)
- V-3110 (6" SHEBOYGAN AT SEGOE)
- V-4940 (12" SEGOE AT SHEBOYGAN)
- V-4941 (6" B.V. SHEBOYGAN AT SEGOE)
- V-4938 (12" SEGOE AT SAWYER)
- V-4 (6" SEGOE AT SAWYER)
- V-3215 (6" SEGOE AT SHEBOYGAN)
- SV-3213 (6" 619 SEGOE)

NOTIFICATION:

- 619 SEGOE
- NOTIFY ALL UNITS

NOTE: CONNECTION MAY ONLY BE PERFORMED ON SAT OR SUN; DO NOT PERFORM WN39 SIMULTANEOUSLY

PLUG REMOVAL CONNECTION
SHEBOYGAN AT SEGOE

ISOLATION VALVES:

- V-3 (6" SHEBOYGAN AT SEGOE)
- V-3110 (6" SHEBOYGAN AT SEGOE)
- V-4940 (12" SEGOE AT SHEBOYGAN)
- V-4941 (6" B.V. SHEBOYGAN AT SEGOE)
- V-4938 (12" SEGOE AT SAWYER)
- V-4 (6" SEGOE AT SAWYER)
- V-3215 (6" SEGOE AT SHEBOYGAN)
- SV-3213 (6" 619 SEGOE)
- NEW 12" (SHEBOYGAN AT SEGOE)

NOTIFICATION:

- 619 SEGOE
- NOTIFY ALL UNITS

NOTE: CONNECTION MAY ONLY BE PERFORMED ON SAT OR SUN; DO NOT PERFORM SIMULTANEOUSLY W/ WN38

WN34
W-5

CUT-IN CONNECTION
4715 SHEBOYGAN - 1

ISOLATION VALVES:

- SV-8 (6" 4715 SHEBOYGAN)
- NEW 6" (4715 SHEBOYGAN)

NOTIFICATION:

- 4701 TO 4725 SHEBOYGAN
- NOTIFY ALL UNITS

WN36
W-5

CUT-IN CONNECTION
4715 SHEBOYGAN - 2

ISOLATION VALVES:

- SV-1 (4" 4715 SHEBOYGAN)
- NEW 4" (4715 SHEBOYGAN)

NOTIFICATION:

- 4701 TO 4725 SHEBOYGAN
- NOTIFY ALL UNITS

WN37
W-6

CUT-IN CONNECTION
4701 SHEBOYGAN

ISOLATION VALVES:

- SV-2 (4" 4701 SHEBOYGAN)
- NEW 4" (4701 SHEBOYGAN)

NOTIFICATION:

- 4701 TO 4725 SHEBOYGAN
- NOTIFY ALL UNITS

NOTE:
VALVE V-4941 IS A PARTIALLY-OPEN
ZONE BOUNDARY VALVE; WORK W/
MWU CONSTRUCTION INSPECTOR TO
RETURN VALVE TO PARTIAL OPENING
AFTER CLOSURE FOR ISOLATION


DISCLAIMER NOTE:
THE WATER IMPACT PLAN IS PROVIDED FOR REFERENCE PURPOSES
TO AIDE PLANNING CONNECTION POINT ISOLATION AND PREPARING
NOTIFICATION LISTS DURING PLANNED OUTAGES. REQUEST ANY
ALTERNATIVE CONNECTION METHODS IN WRITING, PER SPECS.

ORIGINATOR: CITY OF MADISON, STREETS DIVISION

REV. DATE: _____

PLOT NAME: _____

PLOT SCALE: _____

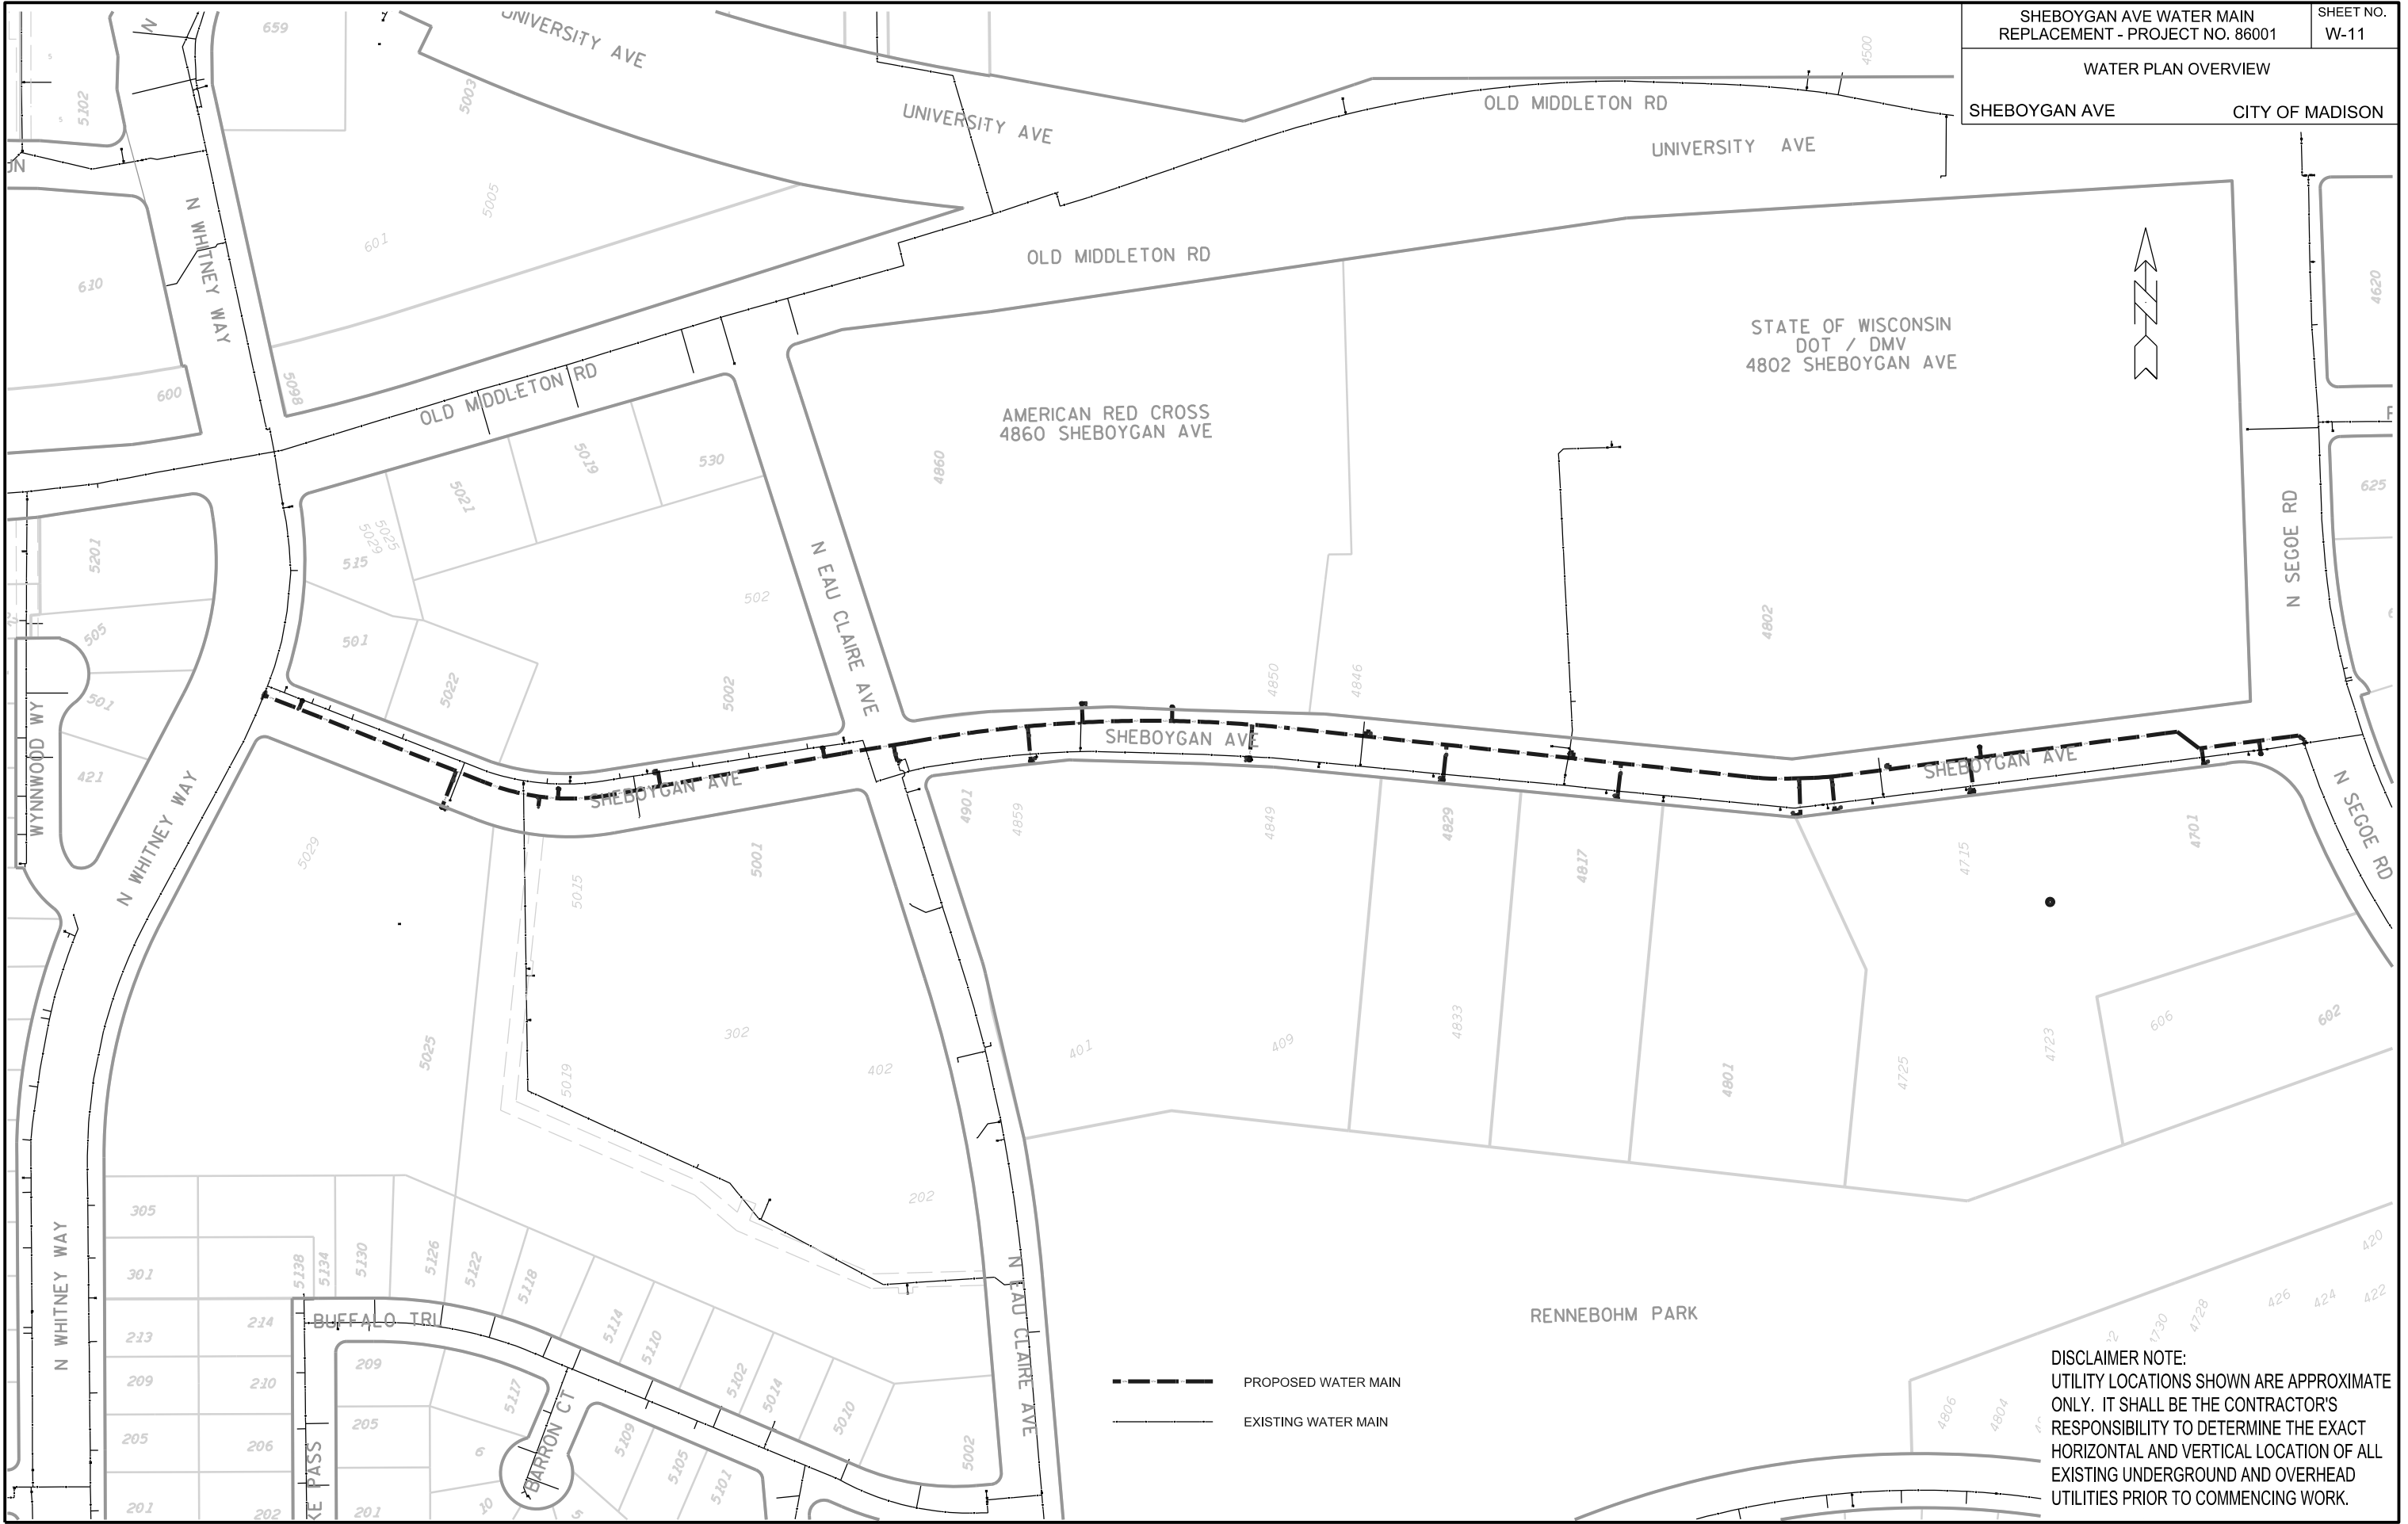

SHEBOYGAN AVE WATER MAIN REPLACEMENT - PROJECT NO. 86001		SHEET NO. W-11
WATER PLAN OVERVIEW		
SHEBOYGAN AVE		CITY OF MADISON

--- PROPOSED WATER MAIN
— EXISTING WATER MAIN

DISCLAIMER NOTE:
UTILITY LOCATIONS SHOWN ARE APPROXIMATE
ONLY. IT SHALL BE THE CONTRACTOR'S
RESPONSIBILITY TO DETERMINE THE EXACT
HORIZONTAL AND VERTICAL LOCATION OF ALL
EXISTING UNDERGROUND AND OVERHEAD
UTILITIES PRIOR TO COMMENCING WORK.

PLOT SCALE: _____

PLOT NAME: _____

REV. DATE: _____

ORIGINATOR: CITY OF MADISON, STREETS DIVISION

FILE NAME: \$\$....designfile....\$\$

DATE: \$\$...plottingdate...\$\$

CONSTRUCTION NOTES:

1. CONSTRUCT NEW WATER MAIN 6.0' BELOW FINISHED GRADE, UNLESS OTHERWISE NOTED. INSULATE MAIN WITH POLYSTYRENE BOARD AT UTILITY CROSSINGS OR OTHER AREAS IDENTIFIED BY ENGINEER AS HAVING INADEQUATE COVER.
2. VERIFY SIZE OF EXISTING WATER SERVICES AND RECONNECT SERVICES AS INDICATED.
3. MINIMIZE DISRUPTION OF SERVICE TO EXISTING CUSTOMERS. NOTIFY PER CONTRACT REQUIREMENTS OF ANY PLANNED WATER OUTAGE.
4. THE EXISTING UTILITIES SHOWN ON THIS PLAN REPRESENT THE BEST INFORMATION AVAILABLE TO THE WATER UTILITY AT THE TIME OF PLAN PREPARATION. CONTRACTOR IS RESPONSIBLE FOR HAVING EACH UTILITY LOCATED PRIOR TO COMMENCING WORK.

- WN1 REPLACE THE EXISTING LEAD SERVICE WITH A NEW COPPER SERVICE.
- WN2 EXTEND AND RECONNECT THE EXISTING COPPER SERVICE TO THE NEW WATER MAIN.
- WN3 EXISTING SERVICE TO BE ABANDONED WHEN THE WATER MAIN IS CUT OFF.
- WN4 DISCONNECT FROM THE OLD WATER MAIN AND RECONNECT THE EXISTING COPPER WATER SERVICE LATERAL TO THE NEW WATER MAIN.
- WN5 RELOCATE THE EXISTING FIRE HYDRANT.
- WN6 ABANDON WATER VALVE ACCESS STRUCTURE.
- WN7 FURNISH AND INSTALL THE NEW TOP SECTION FOR THE WATER ACCESS STRUCTURE.
- WN8 ABANDON THE VALVE BOX.
- WN9 FURNISH THE DITCH, COMPACTION, AND ALL MATERIALS AND LABOR FOR THE INSTALLATION OF NEW SERVICE LATERAL.
- WN10 REMOVE AND SALVAGE EXISTING HYDRANT
- WN11 REPLACE THE EXISTING COPPER SERVICE WITH A COPPER SERVICE
- WN20+ SEE WATER IMPACT PLAN FOR CONNECTION POINT ISOLATION AND WATER SHUT-OFF NOTFICATION INFORMATION.

SHEBOYGAN AVE WATER MAIN REPAACEMENT - PROJECT NO 86001	SHEET NO. W-12
WATER ESTIMATE OF MATERIALS	
SHEBOYGAN AVE	CITY OF MADISON

WATER UTILITY ULO SCHEDULE:

ULO	UTILITY	STATION	OFFSET	SHEET
#1	TEL/WAT	6+24.5	LT 23.8'	W-2
#2	TEL/STM	12+15.0	LT 24.5'	W-3
#3	TEL/STM	13+38.0	LT 23.0'	W-3
#4	ELEC/WAT/GAS	27+70.0	LT 29.7'	W-6
#5	ELEC/WAT/GAS	28+50.0	LT 29.7'	W-6

ESTIMATE OF MATERIALS SUPPLIED BY CONTRACTOR:

** ESTIMATE OF MATERIALS IS FOR INFORMATION ONLY. ENGINEER DOES NOT GUARANTEE ACCURACY OF MATERIAL TAKE-OFF.*

380-FT - 4-IN PIPE	1 - 4-IN 11.25° BEND
280-FT - 6-IN PIPE	14 - 4-IN 90° BEND
60-FT - 8-IN PIPE	
10-FT - 10-IN PIPE	10 - 6-IN 90° BEND
2900-FT - 12-IN PIPE	
7- 4-IN VALVE & BOX	2 - 8-IN 11.25° BEND
11 - 6-IN VALVE & BOX	2 - 8-IN 90° BEND
3 - 8-IN VALVE & BOX	
1 - 10-IN VALVE & BOX	4 - 12-IN 45° BEND
12 - 12-IN VALVE & BOX	2 - 12-IN 90° BEND
7 - 12-IN X 4-IN TEE	6 - 4-IN MJ CAP
11 - 12-IN X 6-IN TEE	3 - 6-IN MJ CAP
3 - 12-IN X 8-IN TEE	1 - 8-IN MJ CAP
1 - 12-IN X 12-IN TEE	
1 - 12-IN X 10-IN CROSS	2 - 6-IN MJ PLUG
	1 - 8-IN MJ PLUG
	1 - 12-IN MJ PLUG
1 - 4-IN X 3-IN REDUCER	6 - 5-IN HYDRANT
	10 - TEMP. FLUSHING HYDRANTS & REQ'D REDUCERS
	40-FT - 2-IN STYROFOAM INSULATION
	4175-FT - POLY WRAP
	1-IN - 2-IN COPPER (AS REQ'D)

MATERIALS SUPPLIED BY CITY:


** ESTIMATE OF MATERIALS IS FOR INFORMATION ONLY. ENGINEER DOES NOT GUARANTEE ACCURACY OF MATERIAL TAKE-OFF.*

NONE

TO OBTAIN LOCATION OF PARTICIPANTS' UNDERGROUND FACILITIES BEFORE YOU DIG IN WISCONSIN

CALL DIGGERS HOTLINE
TOLL FREE
811 OR 1-800-242-8511
FAX-A-LOCATE 1-800-338-3860
TDD (FOR HEARING IMPAIRED) 1-800-542-2289

WIS. STATUTE 182.0175 (1974)
REQUIRES MIN. OF 3 WORK DAYS
NOTICE BEFORE YOU EXCAVATE.

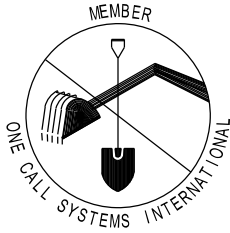


DISCLAIMER NOTE:
UTILITY LOCATIONS SHOWN ARE APPROXIMATE ONLY. IT SHALL BE THE CONTRACTOR'S RESPONSIBILITY TO DETERMINE THE EXACT HORIZONTAL AND VERTICAL LOCATION OF ALL EXISTING UNDERGROUND AND OVERHEAD UTILITIES PRIOR TO COMMENCING WORK.

PART VII - WATER MAINS AND SERVICE LATERALS

DETAIL DRAWING NO. 7.04

REVISED: 12/2015

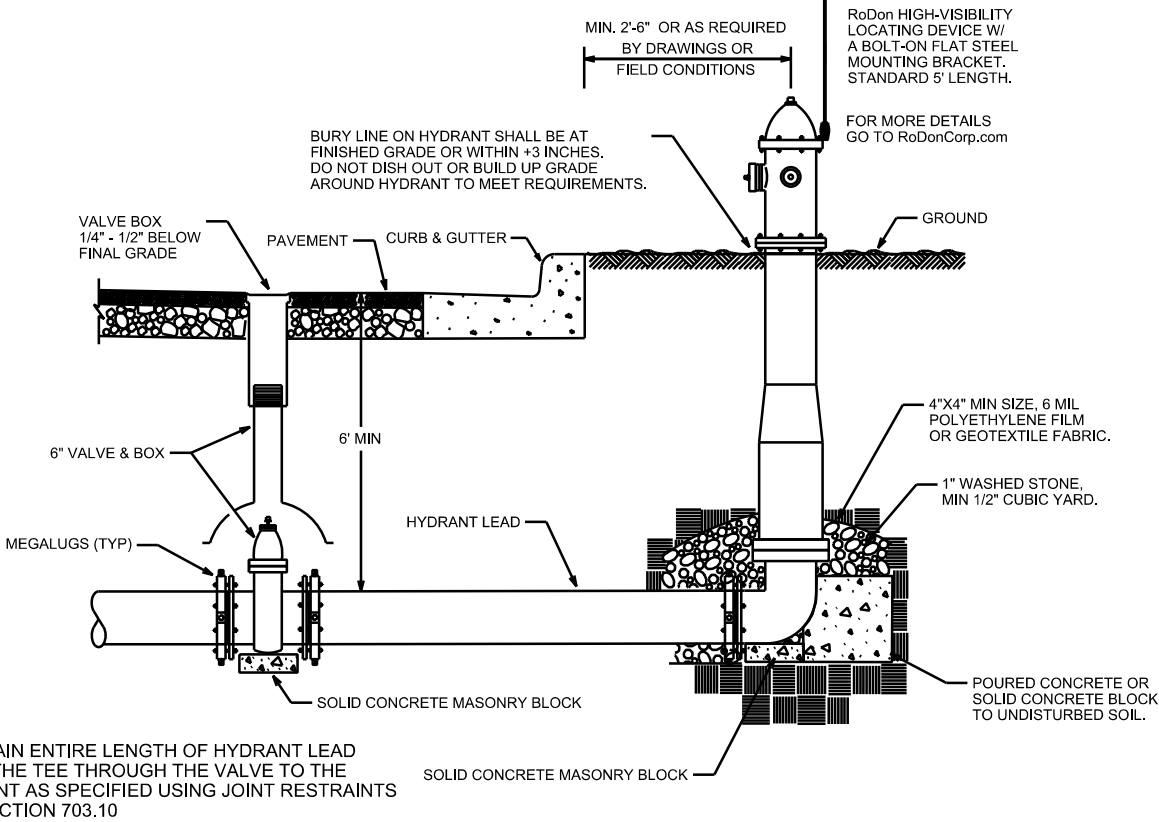

NOTE:

1. RESTRAIN ENTIRE LENGTH OF HYDRANT LEAD FROM THE TEE THROUGH THE VALVE TO THE HYDRANT AS SPECIFIED USING JOINT RESTRAINTS PER SECTION 703.10

CITY OF MADISON
WATER UTILITY

NOT TO SCALE



TYPICAL HYDRANT INSTALLATION

PLOT SCALE: _____

PLOT NAME: _____

REV. DATE: _____

ORIGINATOR: CITY OF MADISON, STREETS DIVISION

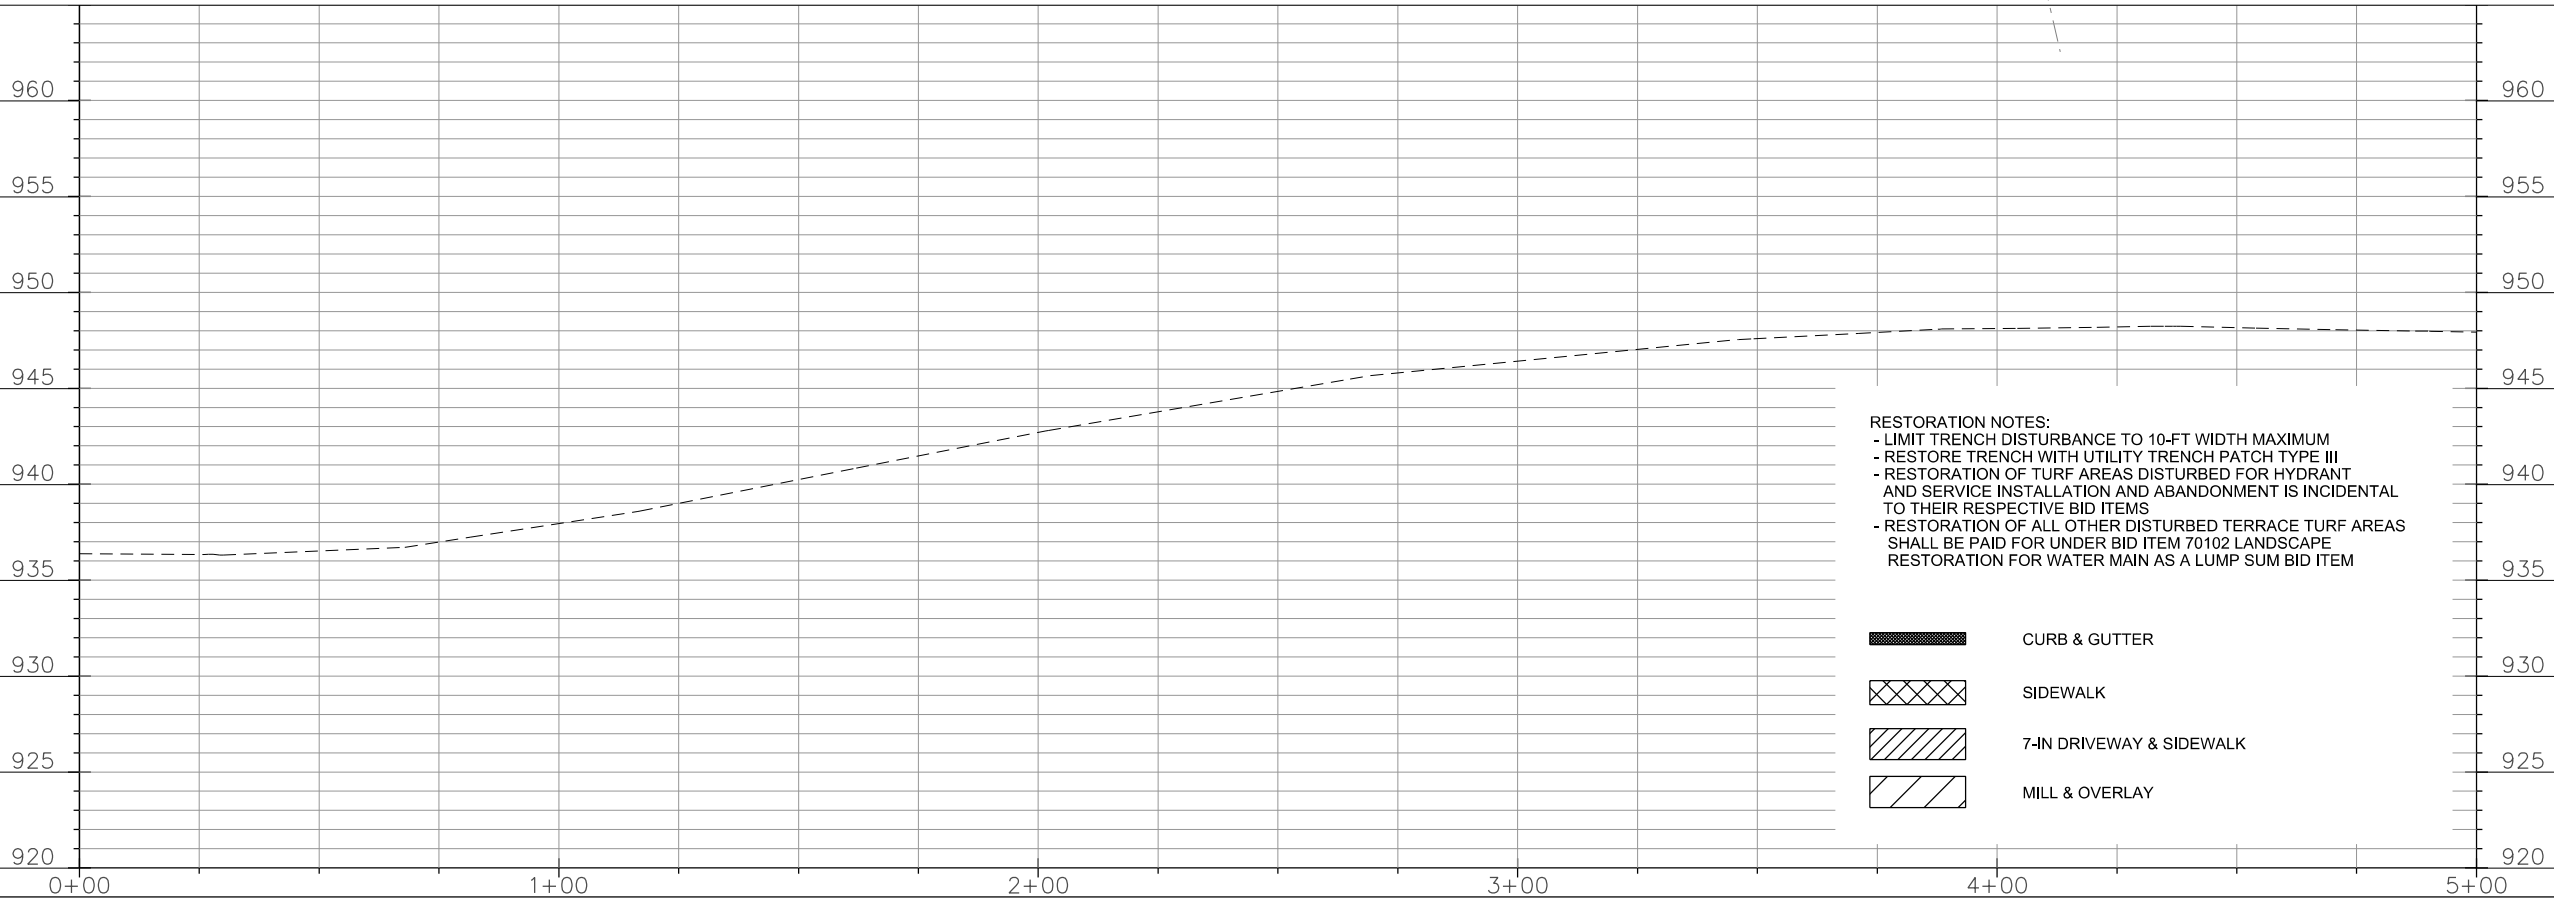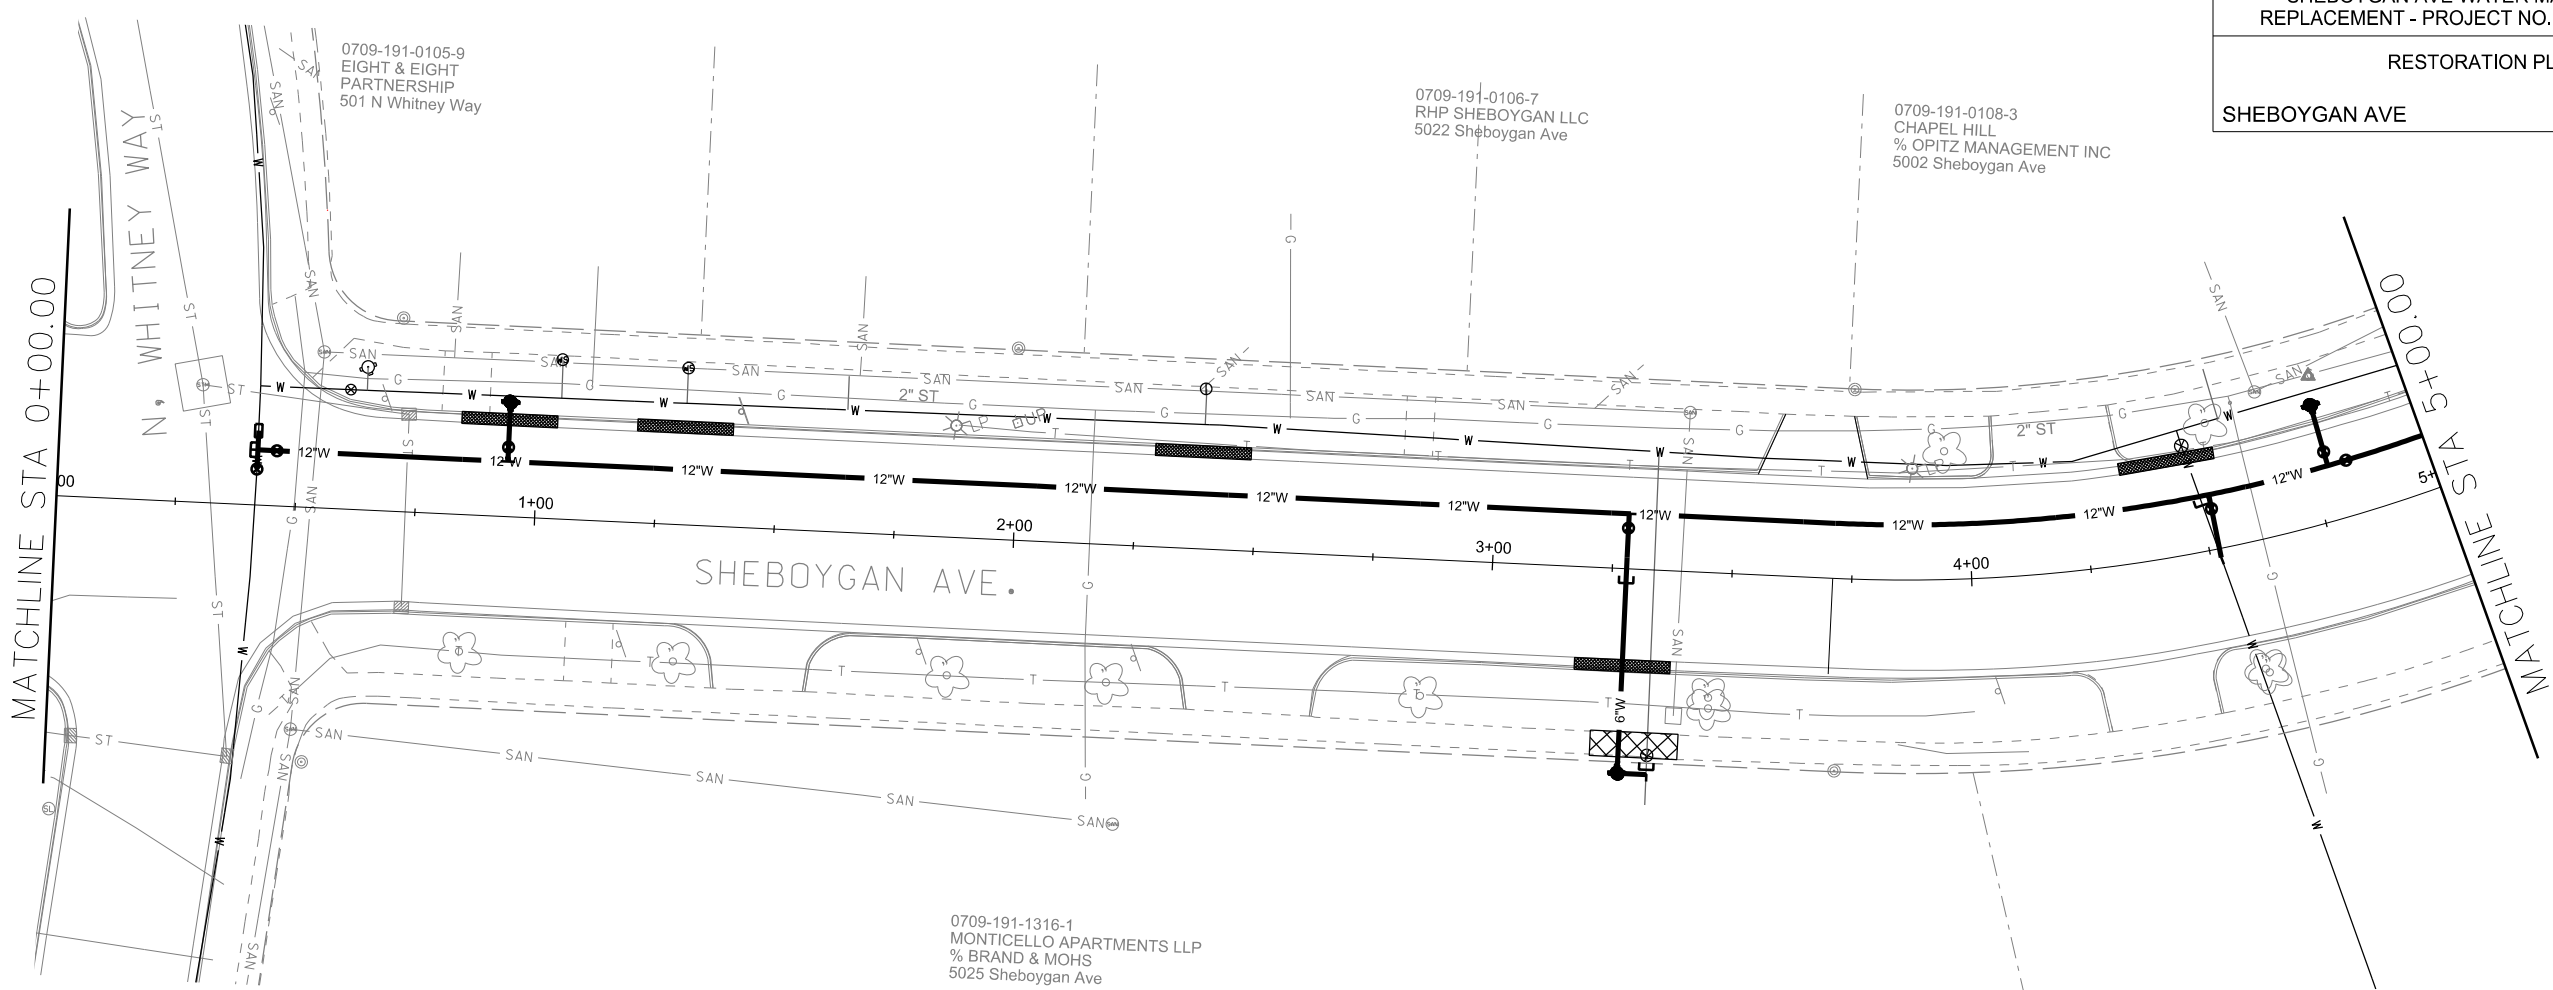

RESTORATION NOTES:
- LIMIT TRENCH DISTURBANCE TO 10-FT WIDTH MAXIMUM
- RESTORE TRENCH WITH UTILITY TRENCH PATCH TYPE III
- RESTORATION OF TURF AREAS DISTURBED FOR HYDRANT AND SERVICE INSTALLATION AND ABANDONMENT IS INCIDENTAL TO THEIR RESPECTIVE BID ITEMS
- RESTORATION OF ALL OTHER DISTURBED TERRACE TURF AREAS SHALL BE PAID FOR UNDER BID ITEM 70102 LANDSCAPE RESTORATION FOR WATER MAIN AS A LUMP SUM BID ITEM


- CURB & GUTTER
- SIDEWALK
- 7-IN DRIVEWAY & SIDEWALK
- MILL & OVERLAY

PLOT SCALE: _____

PLOT NAME: _____


REV. DATE: _____

ORIGINATOR: CITY OF MADISON, STREETS DIVISION

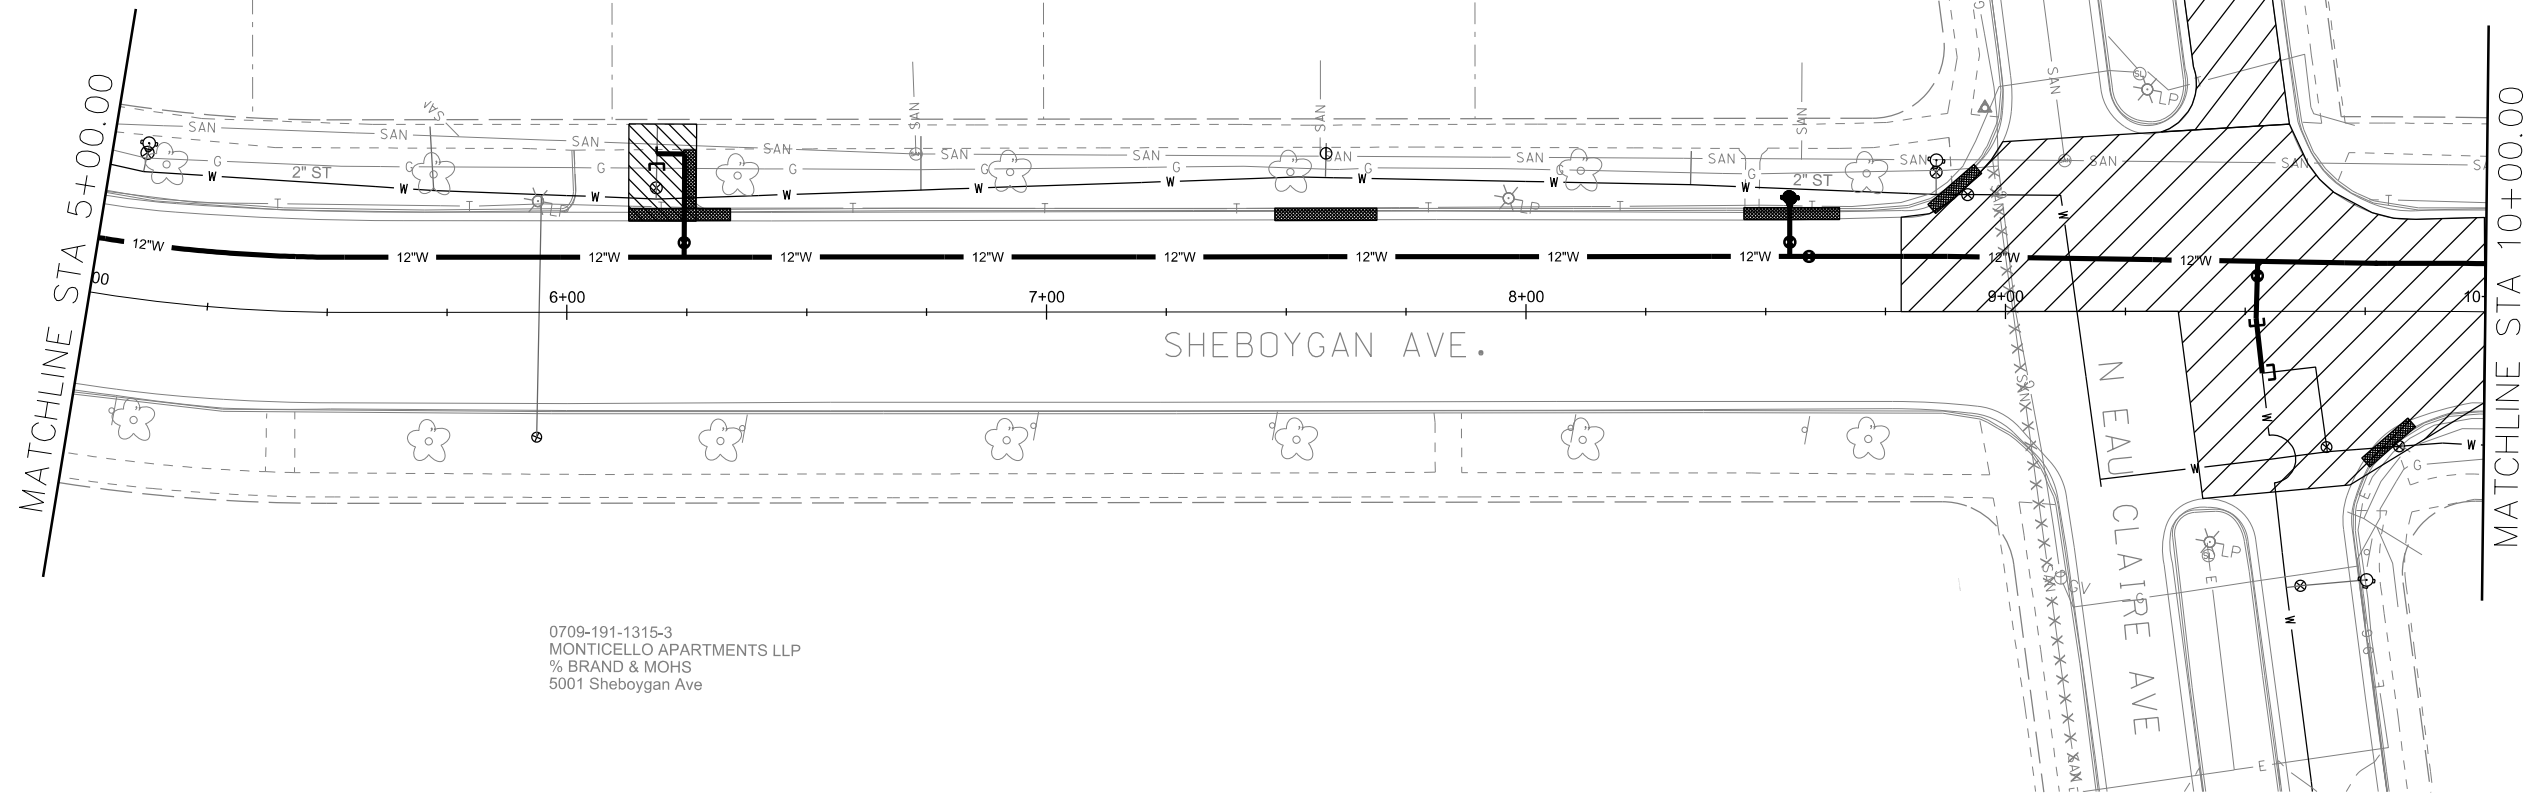


RESTORATION NOTES:
- LIMIT TRENCH DISTURBANCE TO 10-FT WIDTH MAXIMUM
- RESTORE TRENCH WITH UTILITY TRENCH PATCH TYPE III
- RESTORATION OF TURF AREAS DISTURBED FOR HYDRANT AND SERVICE INSTALLATION AND ABANDONMENT IS INCIDENTAL TO THEIR RESPECTIVE BID ITEMS
- RESTORATION OF ALL OTHER DISTURBED TERRACE TURF AREAS SHALL BE PAID FOR UNDER BID ITEM 70102 LANDSCAPE RESTORATION FOR WATER MAIN AS A LUMP SUM BID ITEM

- CURB & GUTTER
- SIDEWALK
- 7-IN DRIVEWAY & SIDEWALK
- MILL & OVERLAY

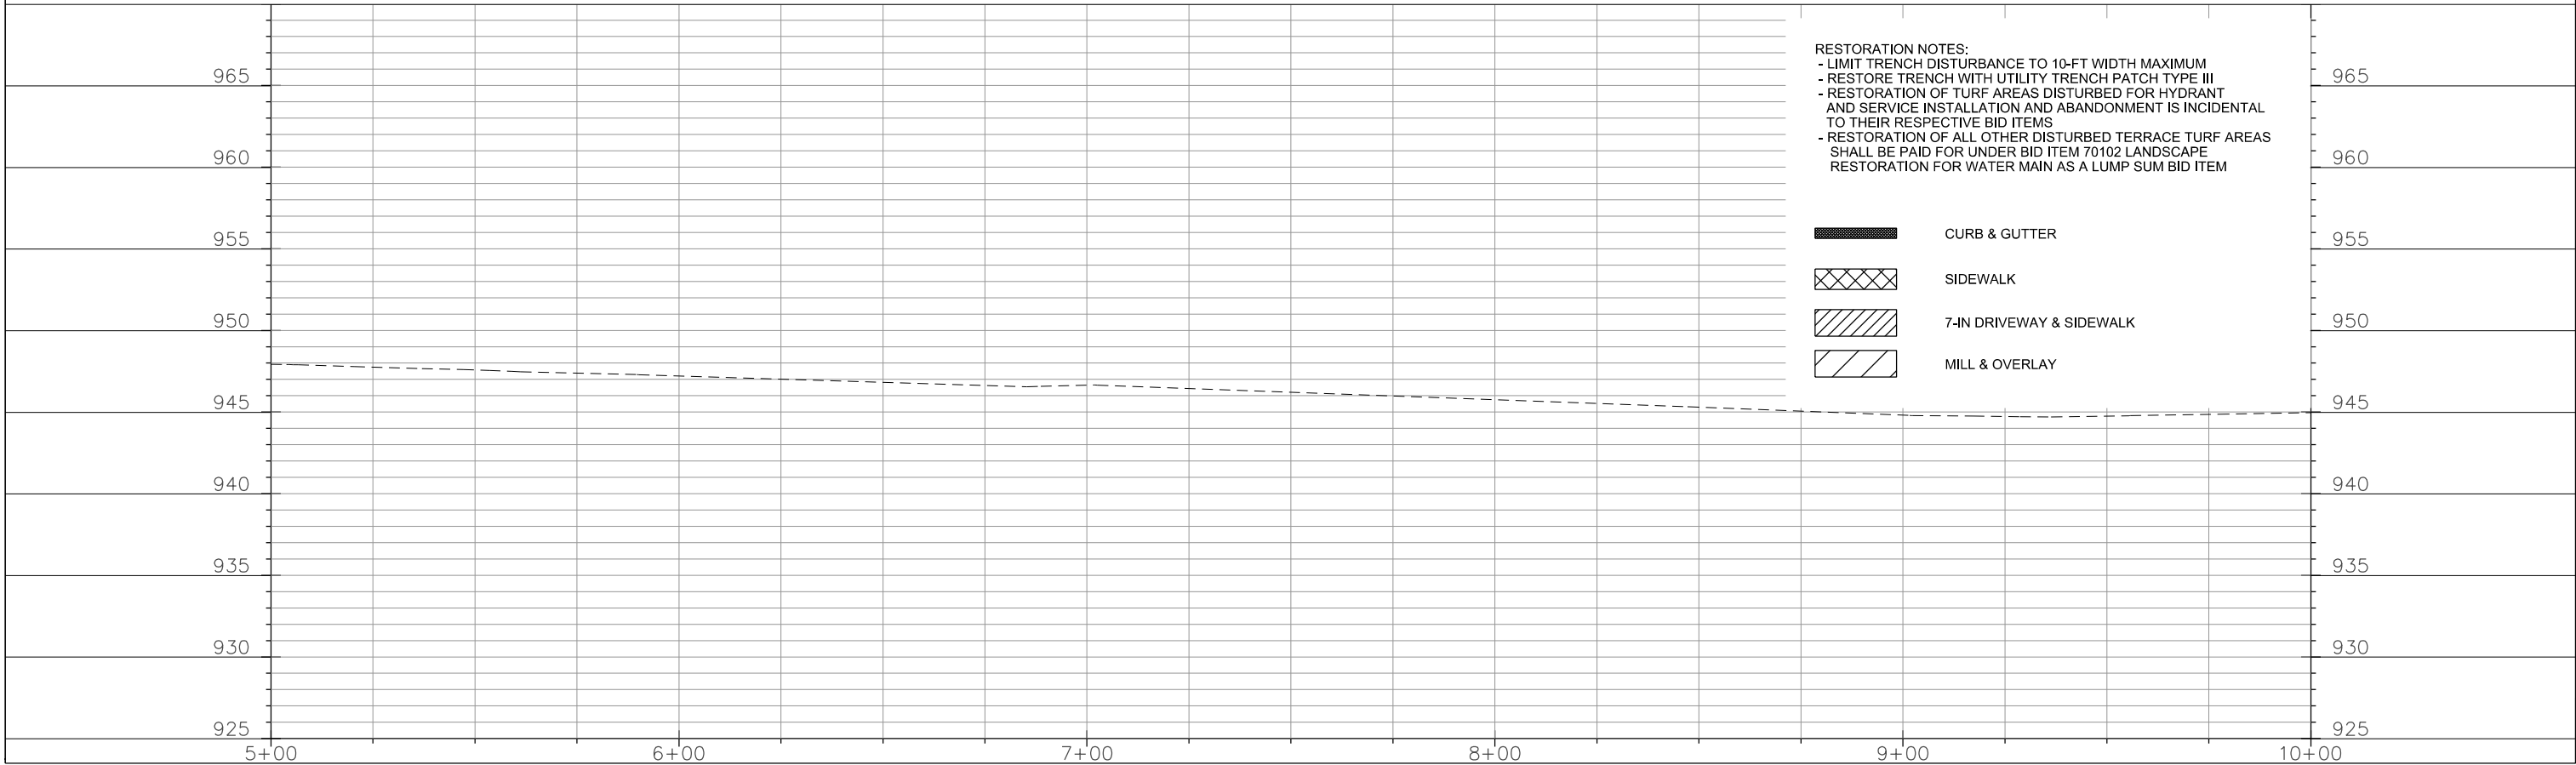


0709-202-0303-4
AMERICAN NATIONAL
RED CROSS
4860 Sheboygan Ave

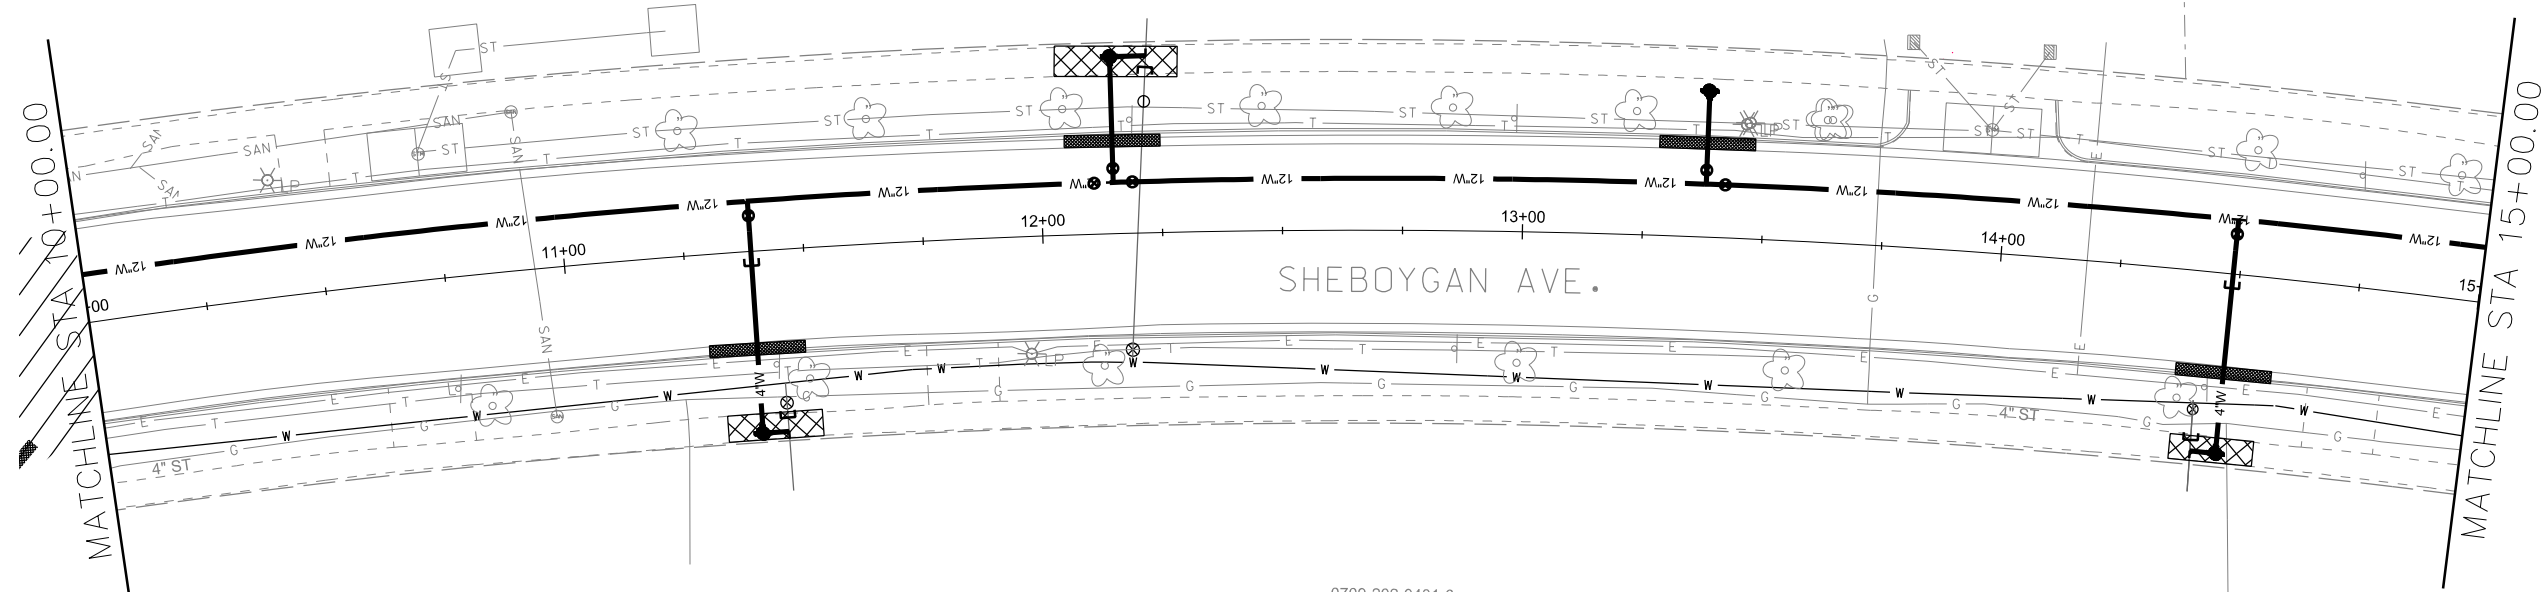


0709-202-0401-6
BRAND CAROLINA APTS LLC
MOHS CAROLINA APTS LLC
4901 Sheboygan Ave

- RESTORATION NOTES:
- LIMIT TRENCH DISTURBANCE TO 10-FT WIDTH MAXIMUM
 - RESTORE TRENCH WITH UTILITY TRENCH PATCH TYPE III
 - RESTORATION OF TURF AREAS DISTURBED FOR HYDRANT AND SERVICE INSTALLATION AND ABANDONMENT IS INCIDENTAL TO THEIR RESPECTIVE BID ITEMS
 - RESTORATION OF ALL OTHER DISTURBED TERRACE TURF AREAS SHALL BE PAID FOR UNDER BID ITEM 70102 LANDSCAPE RESTORATION FOR WATER MAIN AS A LUMP SUM BID ITEM

- | | |
|--|--------------------------|
| | CURB & GUTTER |
| | SIDEWALK |
| | 7-IN DRIVEWAY & SIDEWALK |
| | MILL & OVERLAY |

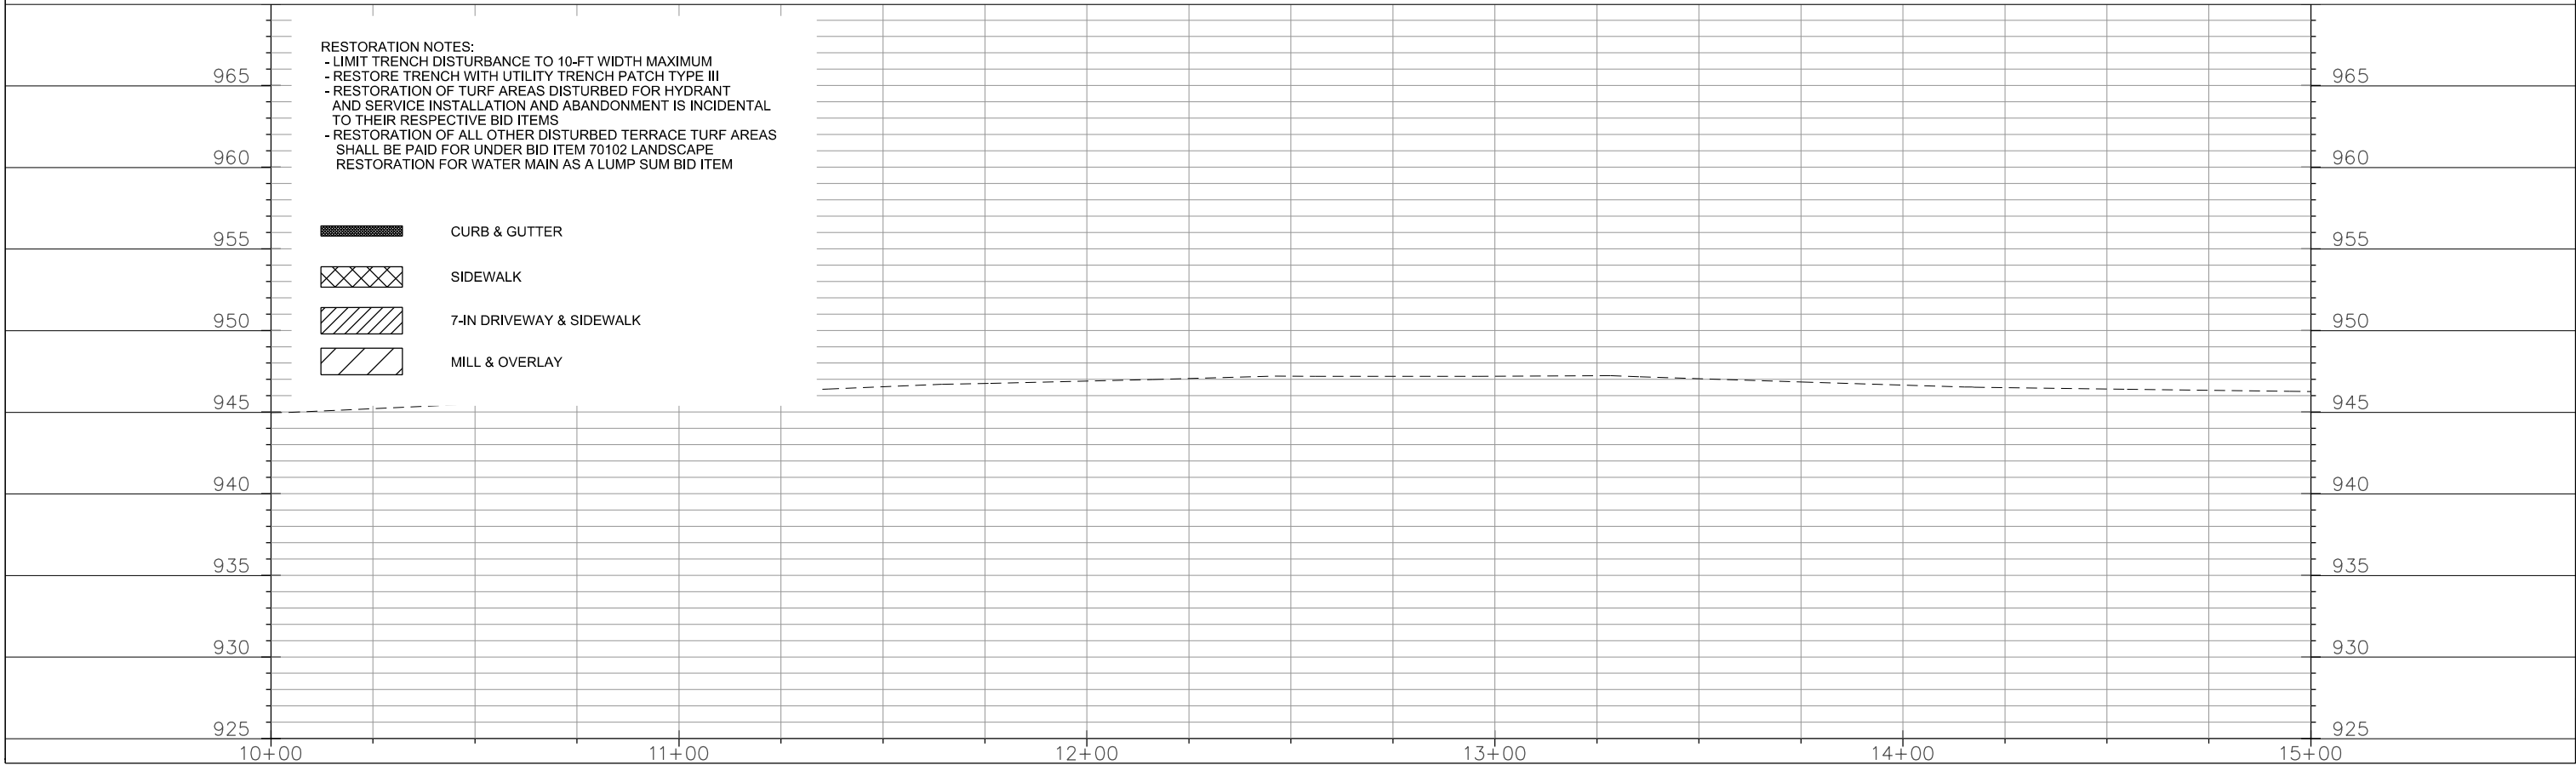




SHEBOYGAN AVE	CITY OF MADISON
---------------	-----------------

 



0709-202-0601-2
HILLDALE TOWERS
4817 Sheboygan Ave

	CURB & GUTTER
	SIDEWALK
	7-IN DRIVEWAY & SIDEWALK
	MILL & OVERLAY

 

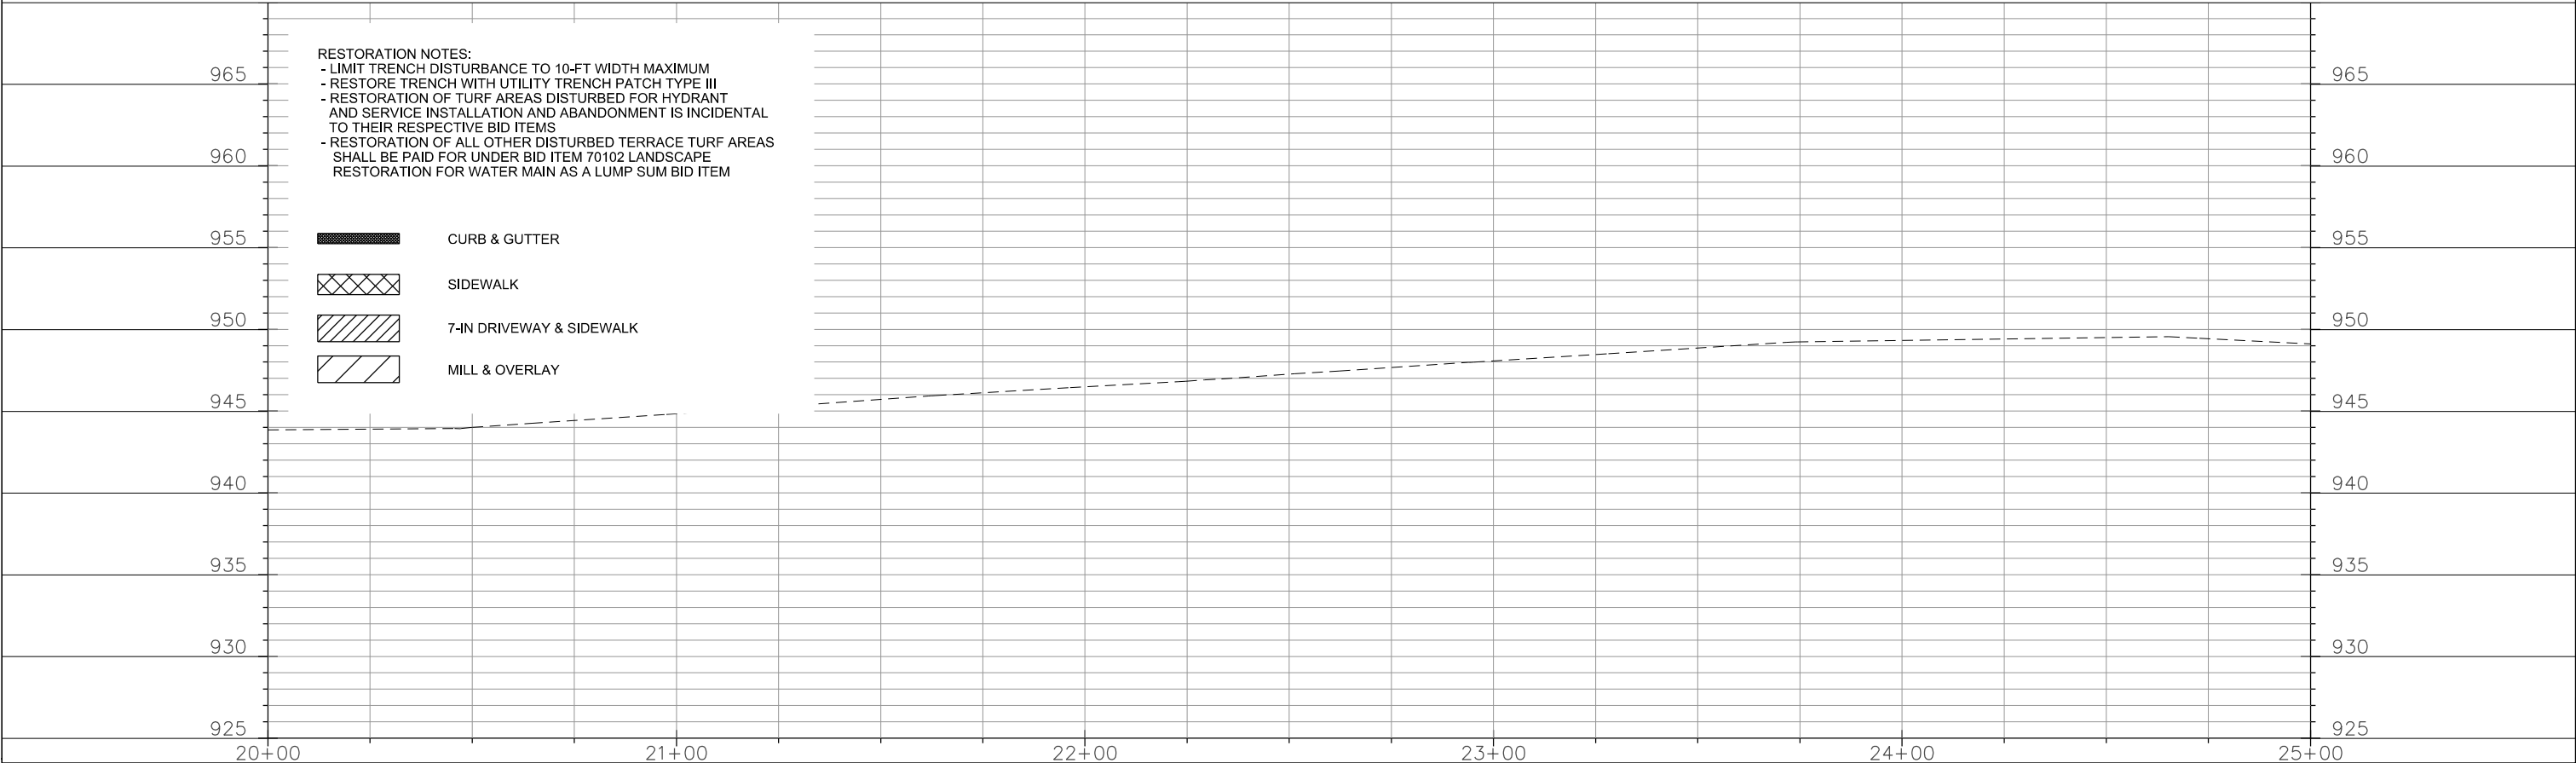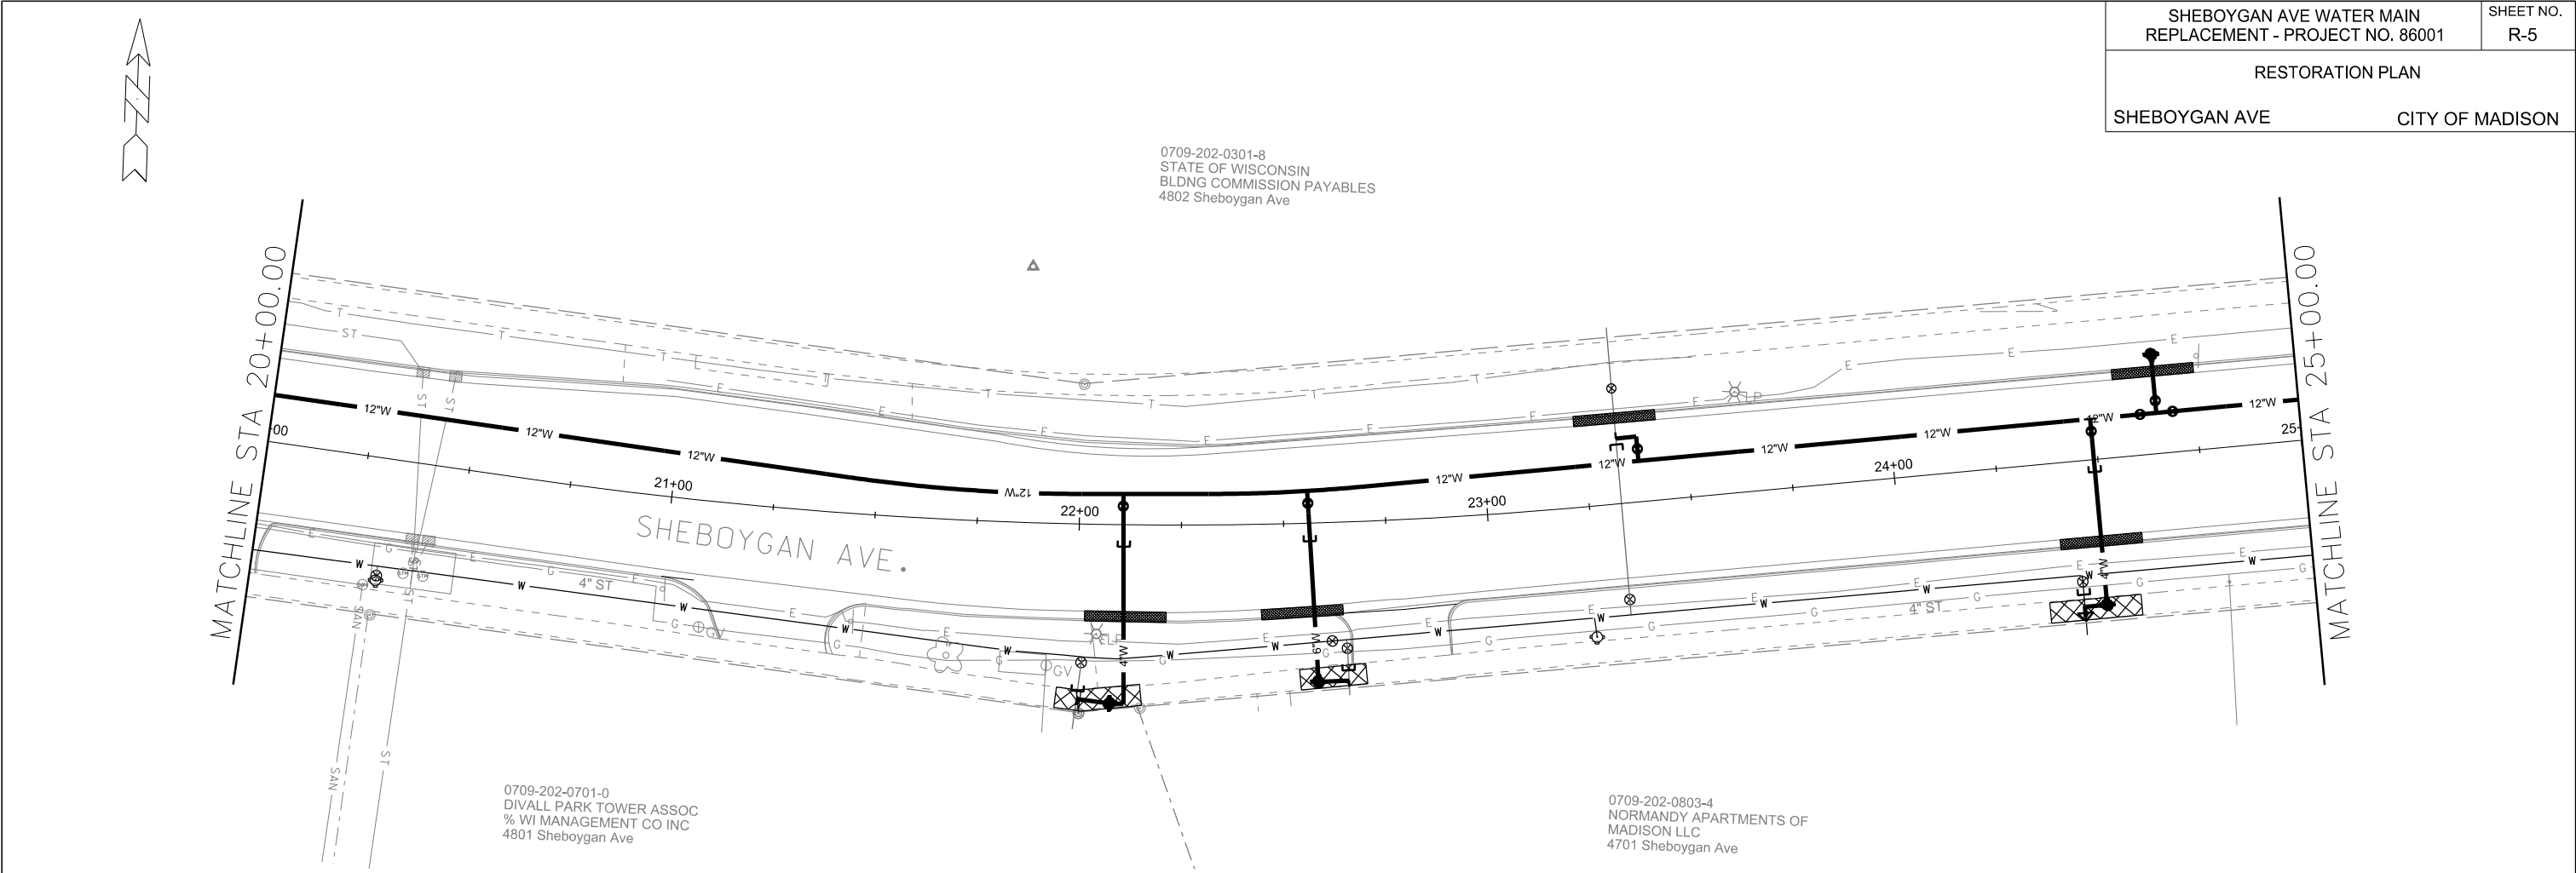

SHEBOYGAN AVE	CITY OF MADISON
---------------	-----------------

  

	CURB & GUTTER
	SIDEWALK
	7-IN DRIVEWAY & SIDEWALK
	MILL & OVERLAY

PLOT SCALE:

PLOT NAME:

REV. DATE:

ORIGINATOR: CITY OF MADISON, TRAFFIC ENG. DIV.



0709-202-0202-8
WESTON PLACE CONDO OWNRS
ASSC INC. ATTN APEX MNGMT
625 N Segoe Rd

0709-202-0205-2
VENTURE II PROPERTIES LLC
619 N Segoe Rd

0709-202-0203-6
COVENTRY CONDOMINIUM ASSC
601 N Segoe Rd

0709-202-0803-4
NORMANDY APARTMENTS OF
MADISON LLC
4701 Sheboygan Ave

LEGEND	
	Sign
	Traffic Flow
	Arrow Board
	Barrel
	Tubular Marker
	Work Zone
	Barricade
	Flagger

