


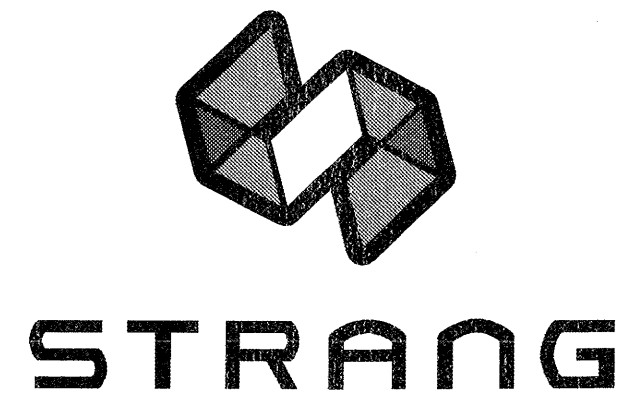


CITY OF MADISON FIRE STATION #2 ADDITION & REMODELING

421 Grand Canyon Drive
Madison, Wisconsin

Project No.: 2011009



Site Location Map

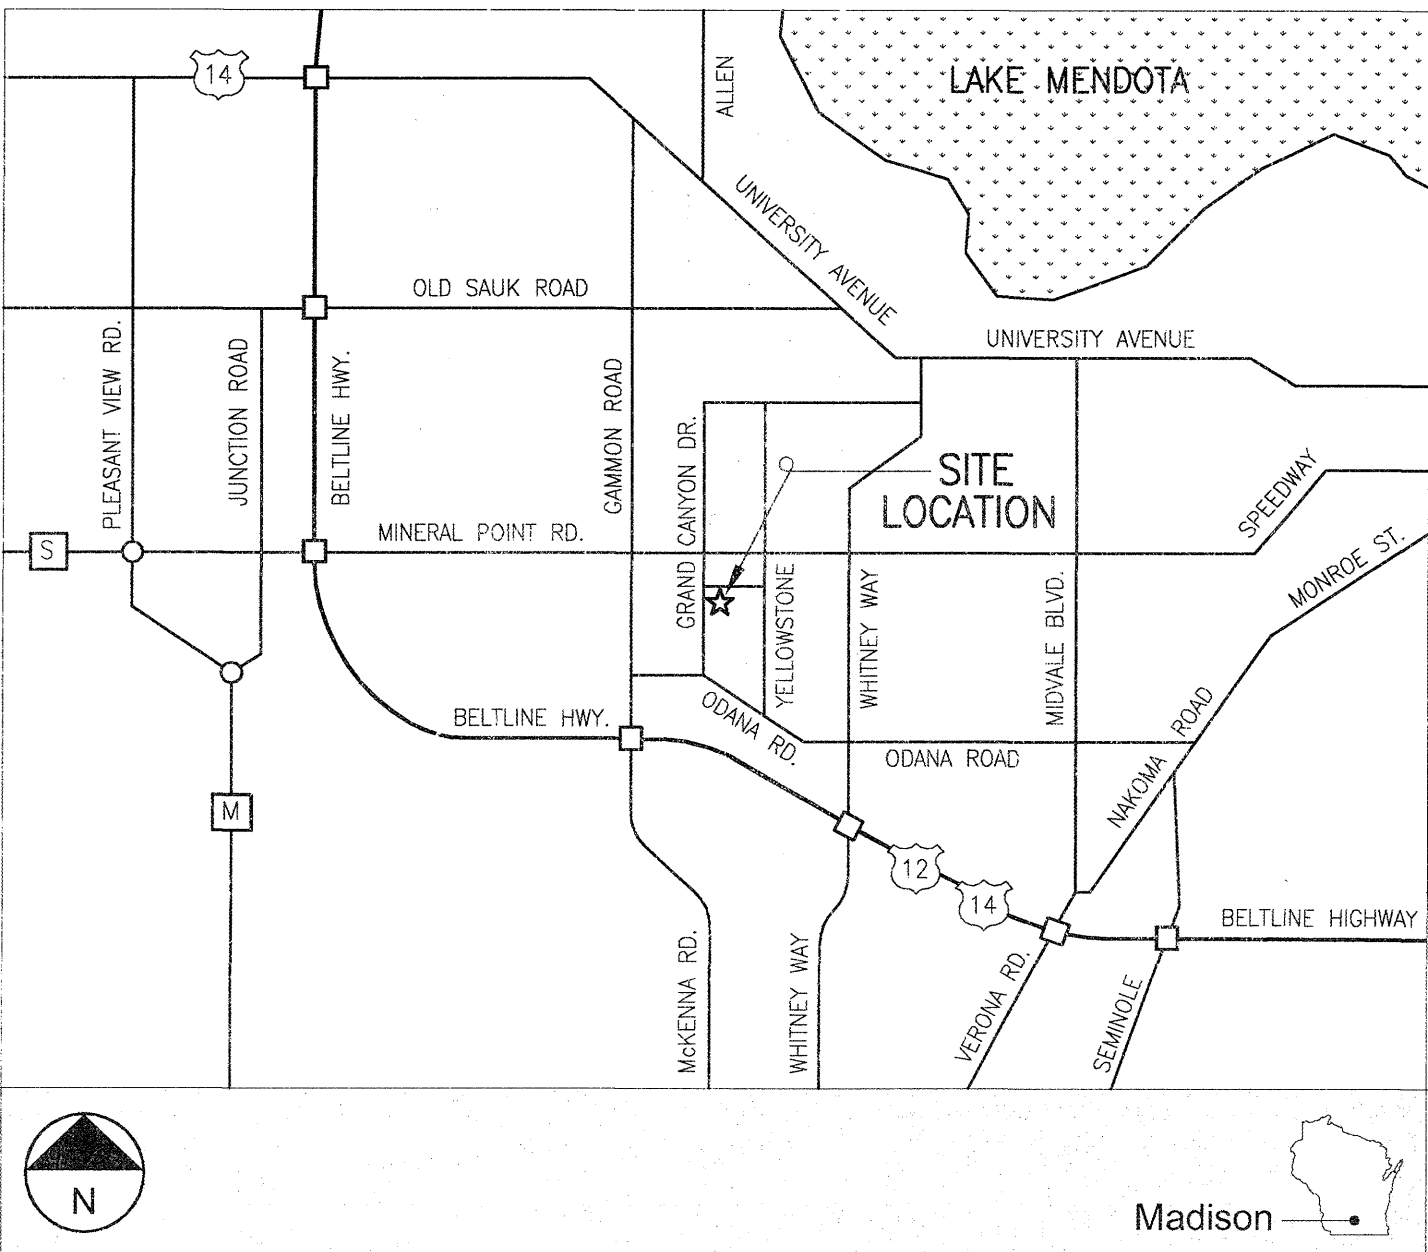

Design Team

Architectural Design
STRANG, INC.


Structural Design
ARNOLD & O'SHERIDAN

Plumbing Design
STRANG, INC.

HVAC Design
STRANG, INC.

Electrical Design
STRANG, INC.

Project Image

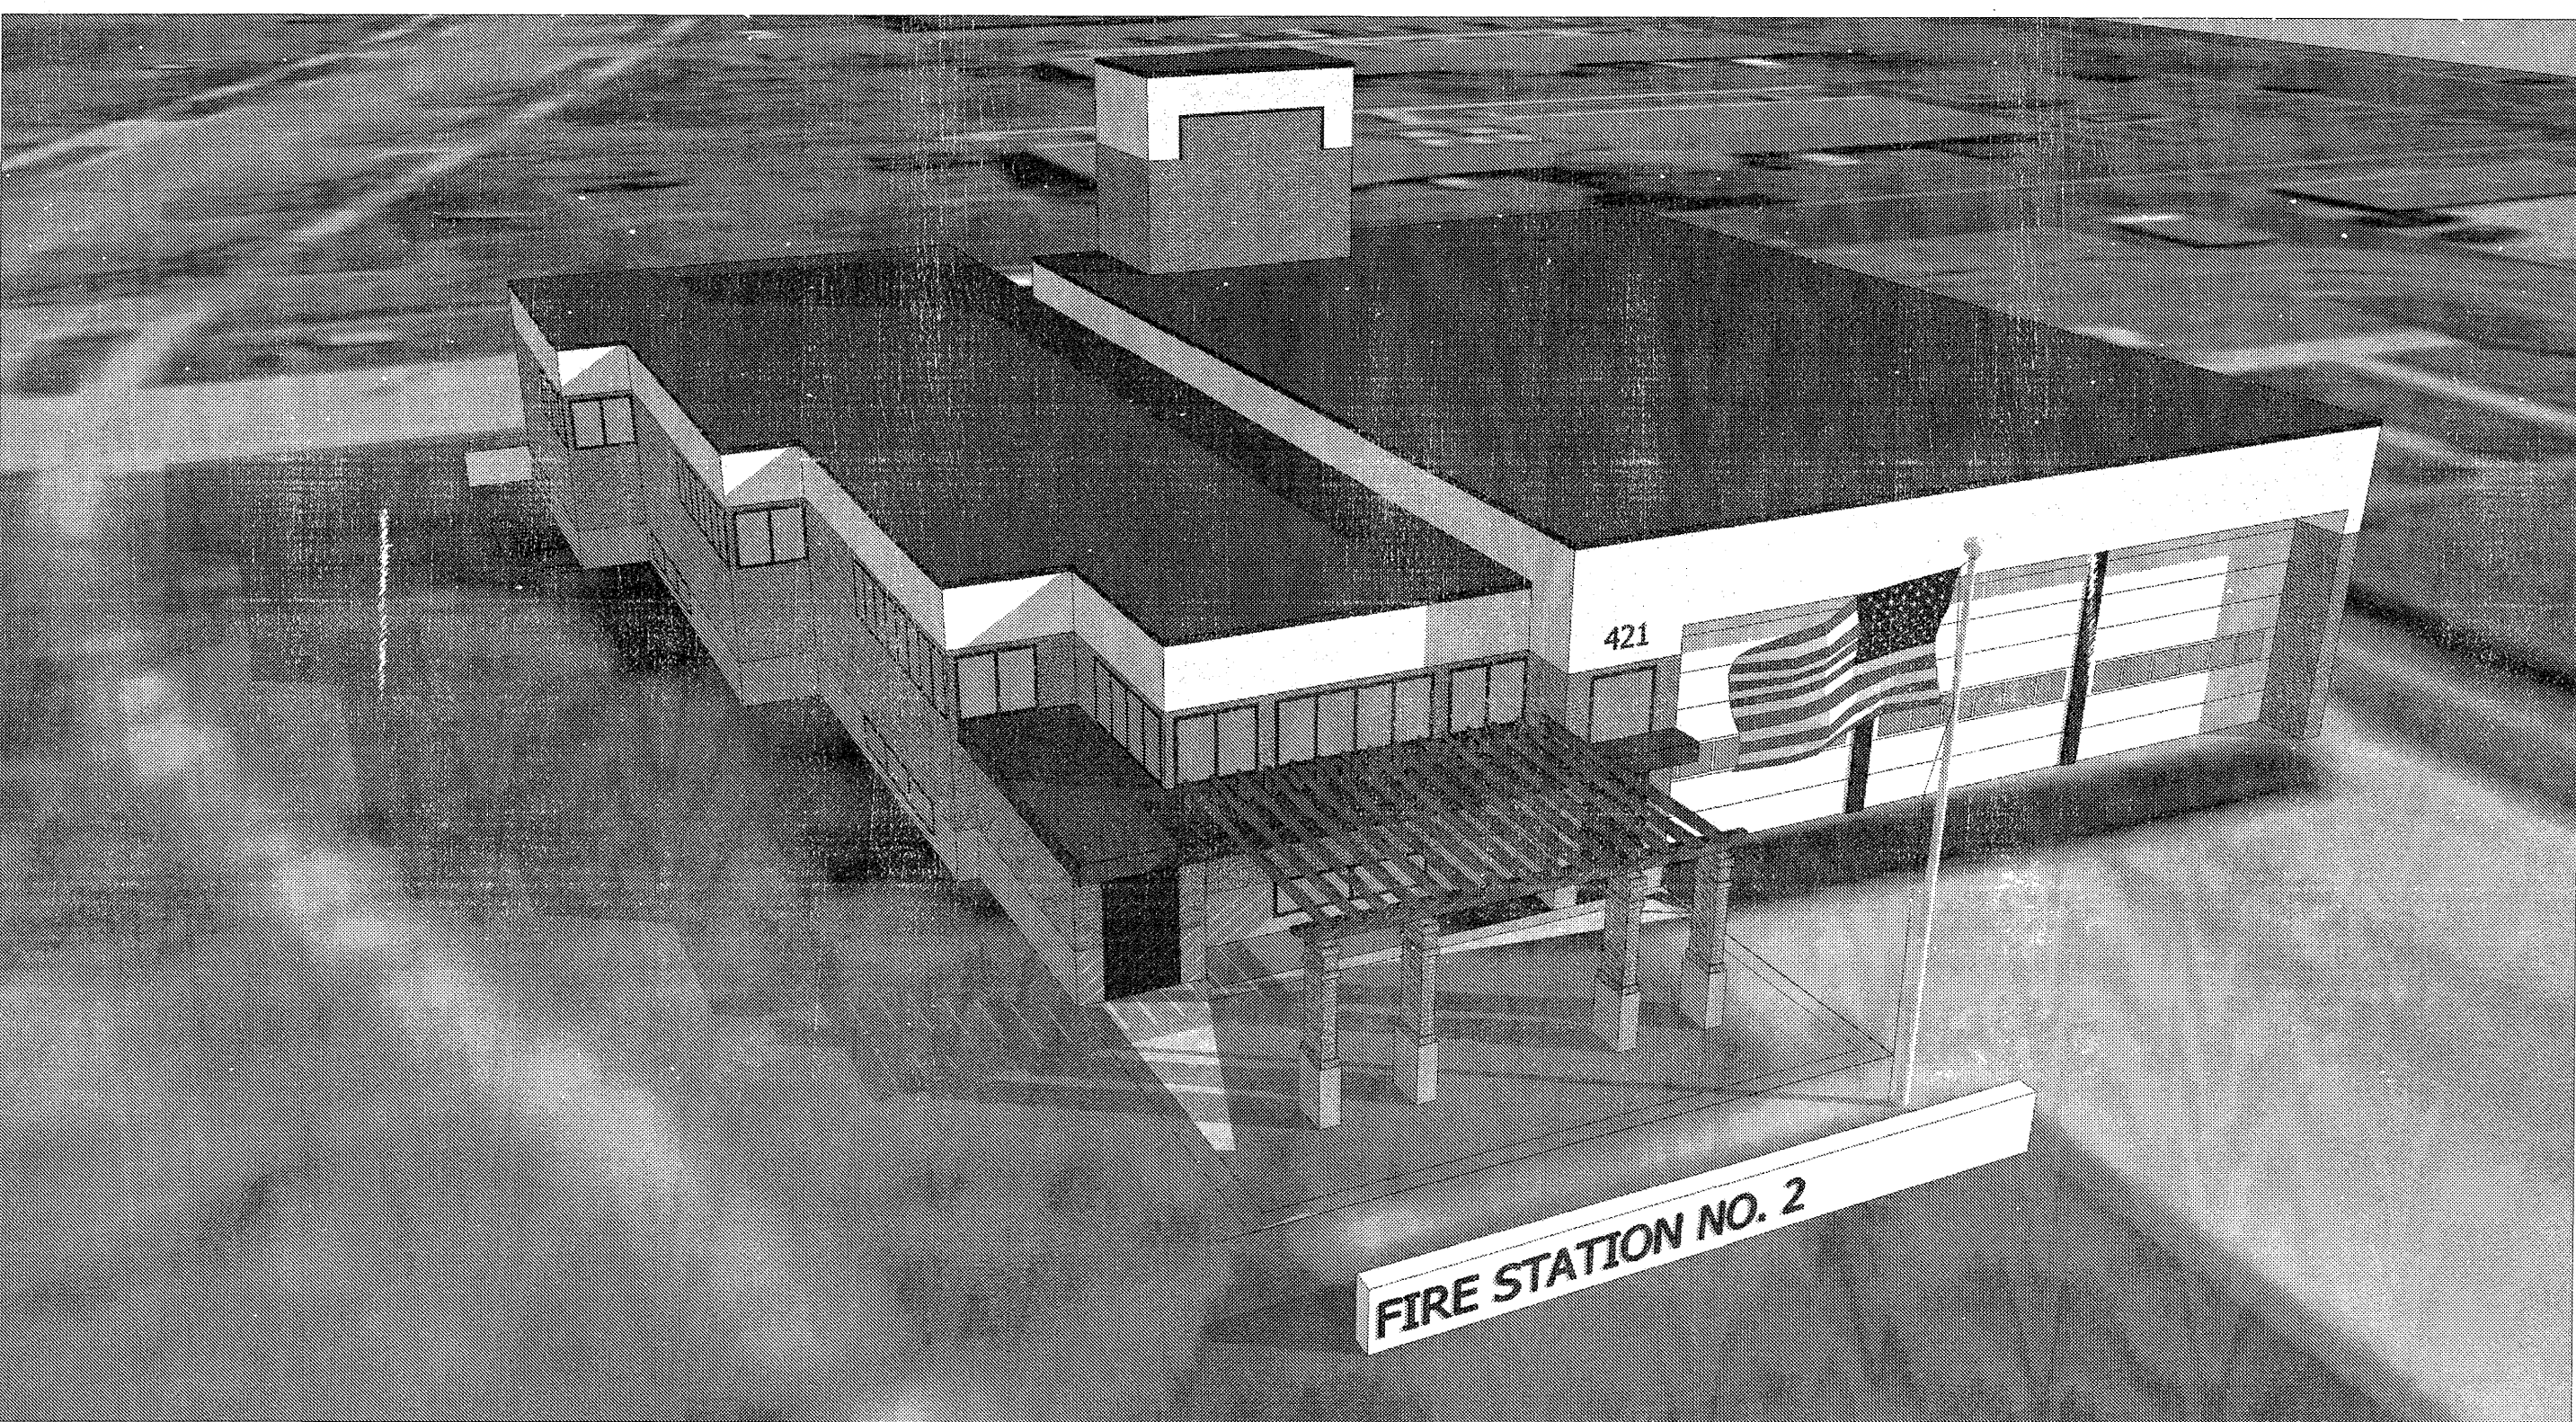

ARCHITECTURE
ENGINEERING
INTERIOR DESIGN


STRANG, INC.
5411 MINERAL POINT ROAD
MADISON, WI 53705-4395
T/ 608 275 9200
F/ 608 275 9204

Stamps


Architectural




Mechanical

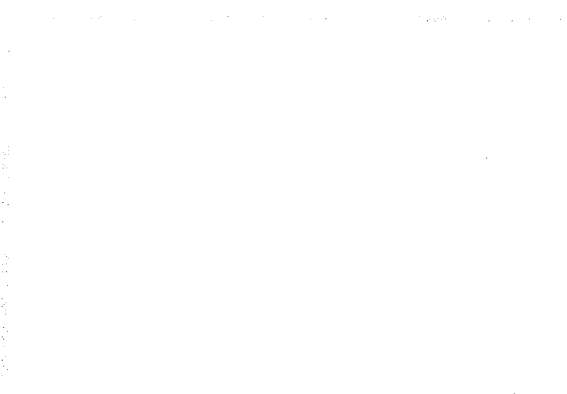

Civil

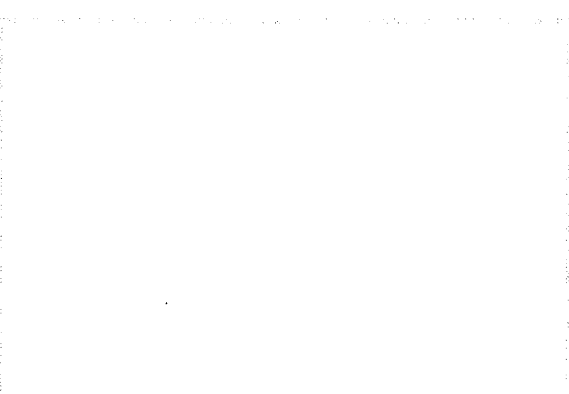

Plumbing

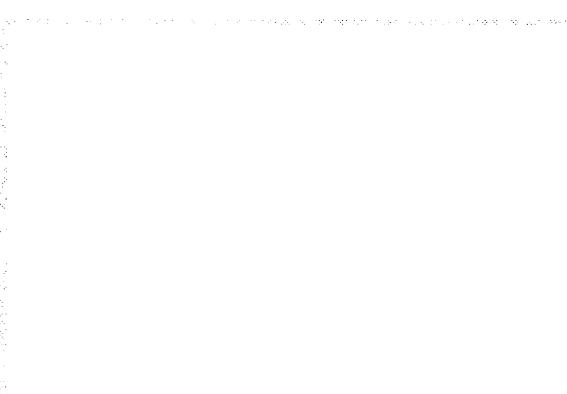

Structural



Electrical



Sheet Index

GENERAL	
T001	TITLE SHEET
T002	ABBREVIATIONS, CODES, SYMBOLS & LIFE SAFETY PLAN
CIVIL / SITE	
SITE SURVEY (FOR REFERENCE ONLY)	
C201	SITE PLANS
ARCHITECTURAL	
A001	SCHEDULES, PARTITION TYPES, & DOOR DETAILS
A101	DEMOLITION FLOOR PLANS
A201	ADDITION AND REMODELING FLOOR PLANS
A202	ROOF PLANS AND DETAILS
A301	REFLECTED CEILING PLANS
A401	BUILDING SECTIONS AND EXTERIOR ELEVATIONS
A501	WALL SECTIONS
A701	ENLARGED PLANS & INTERIOR ELEVATIONS
A801	EXTERIOR DETAILS
A901	INTERIOR DETAILS
STRUCTURAL	
S201	FOUNDATION PLAN AND FRAMING PLAN
S301	STRUCTURAL DETAILS
FIRE PROTECTION	
F201	FIRE PROTECTION PLANS
PLUMBING	
P101	PLUMBING DEMOLITION PLANS
P201	ADDITION AND REMODELING PLUMBING PLANS
P202	ADDITION AND REMODELING PLUMBING PLANS
P301	PLUMBING RISERS
P401	PLUMBING SYMBOLS AND DETAILS
HVAC	
M101	MECHANICAL DEMOLITION PLANS
M201	MECHANICAL REMODELING PLANS
M202	HVAC ROOF AND MECH ROOM REMODELING PLANS
M401	MECHANICAL DETAILS
M402	MECHANICAL DETAILS
M501	MECHANICAL SCHEDULES
ELECTRICAL	
E001	ELECTRICAL SYMBOLS AND FIXTURE SCHEDULE
E101	ELECTRICAL DEMOLITION FLOOR PLANS
E201L	LIGHTING ADDITION AND REMODELING FLOOR PLANS
E201P	POWER ADDITION AND REMODELING FLOOR PLANS
E201S	SYSTEMS ADDITION AND REMODELING FLOOR PLANS
E401	ELECTRICAL DETAILS
E501	ELECTRICAL PANELBOARDS
E601	ELECTRICAL ONE-LINE DIAGRAM AND SCHEDULES

DRAWING SET	OWNER REVIEW
COPYRIGHT STRANG, INC.	2012
FILE NAME	2011009-T001.DWG
REVISIONS	

DRAWN	DV
CHECKED	LB
DATE	03-09-12
PROJECT NO.	2011009
PROJECT TITLE	

CITY OF MADISON
FIRE STATION #2
ADDITION AND
REMODELING

421 GRAND CANYON DRIVE
MADISON, WISCONSIN

SHEET TITLE
**TITLE
SHEET**

SHEET NO.
T001