



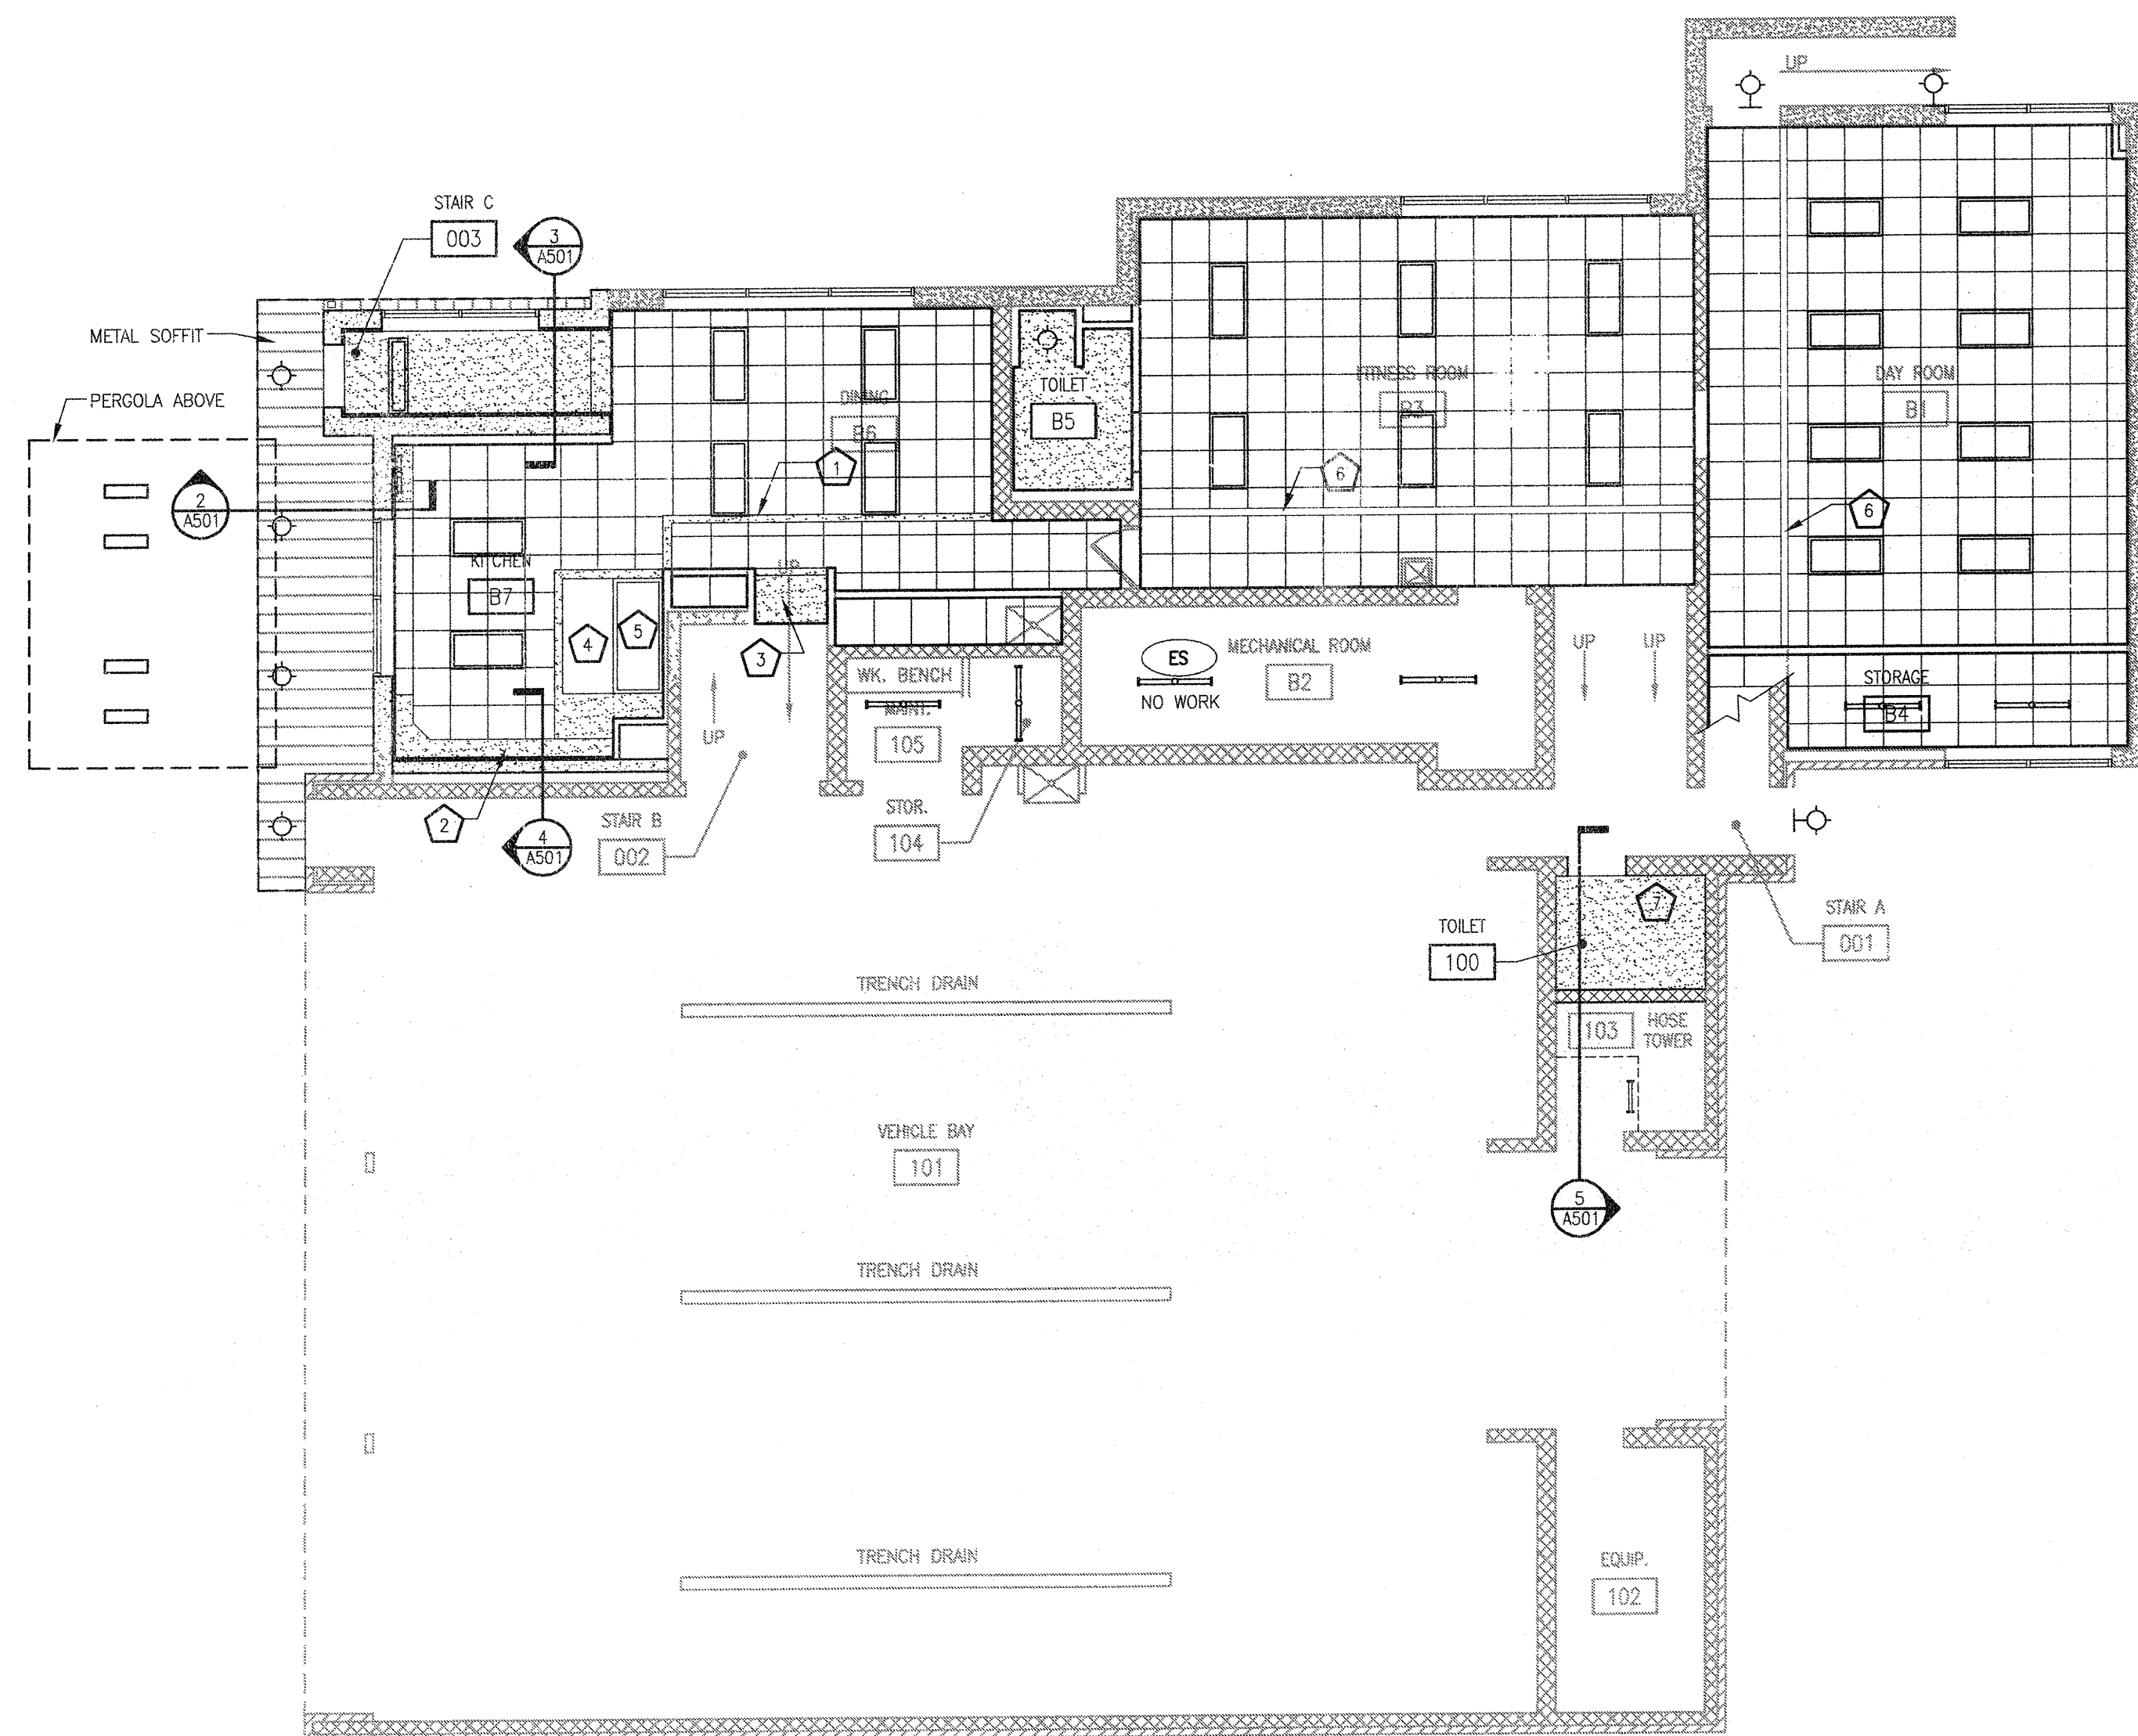


1
A301
LOWER LEVEL REFLECTED CEILING PLAN
SCALE: 1/8" = 1'-0"

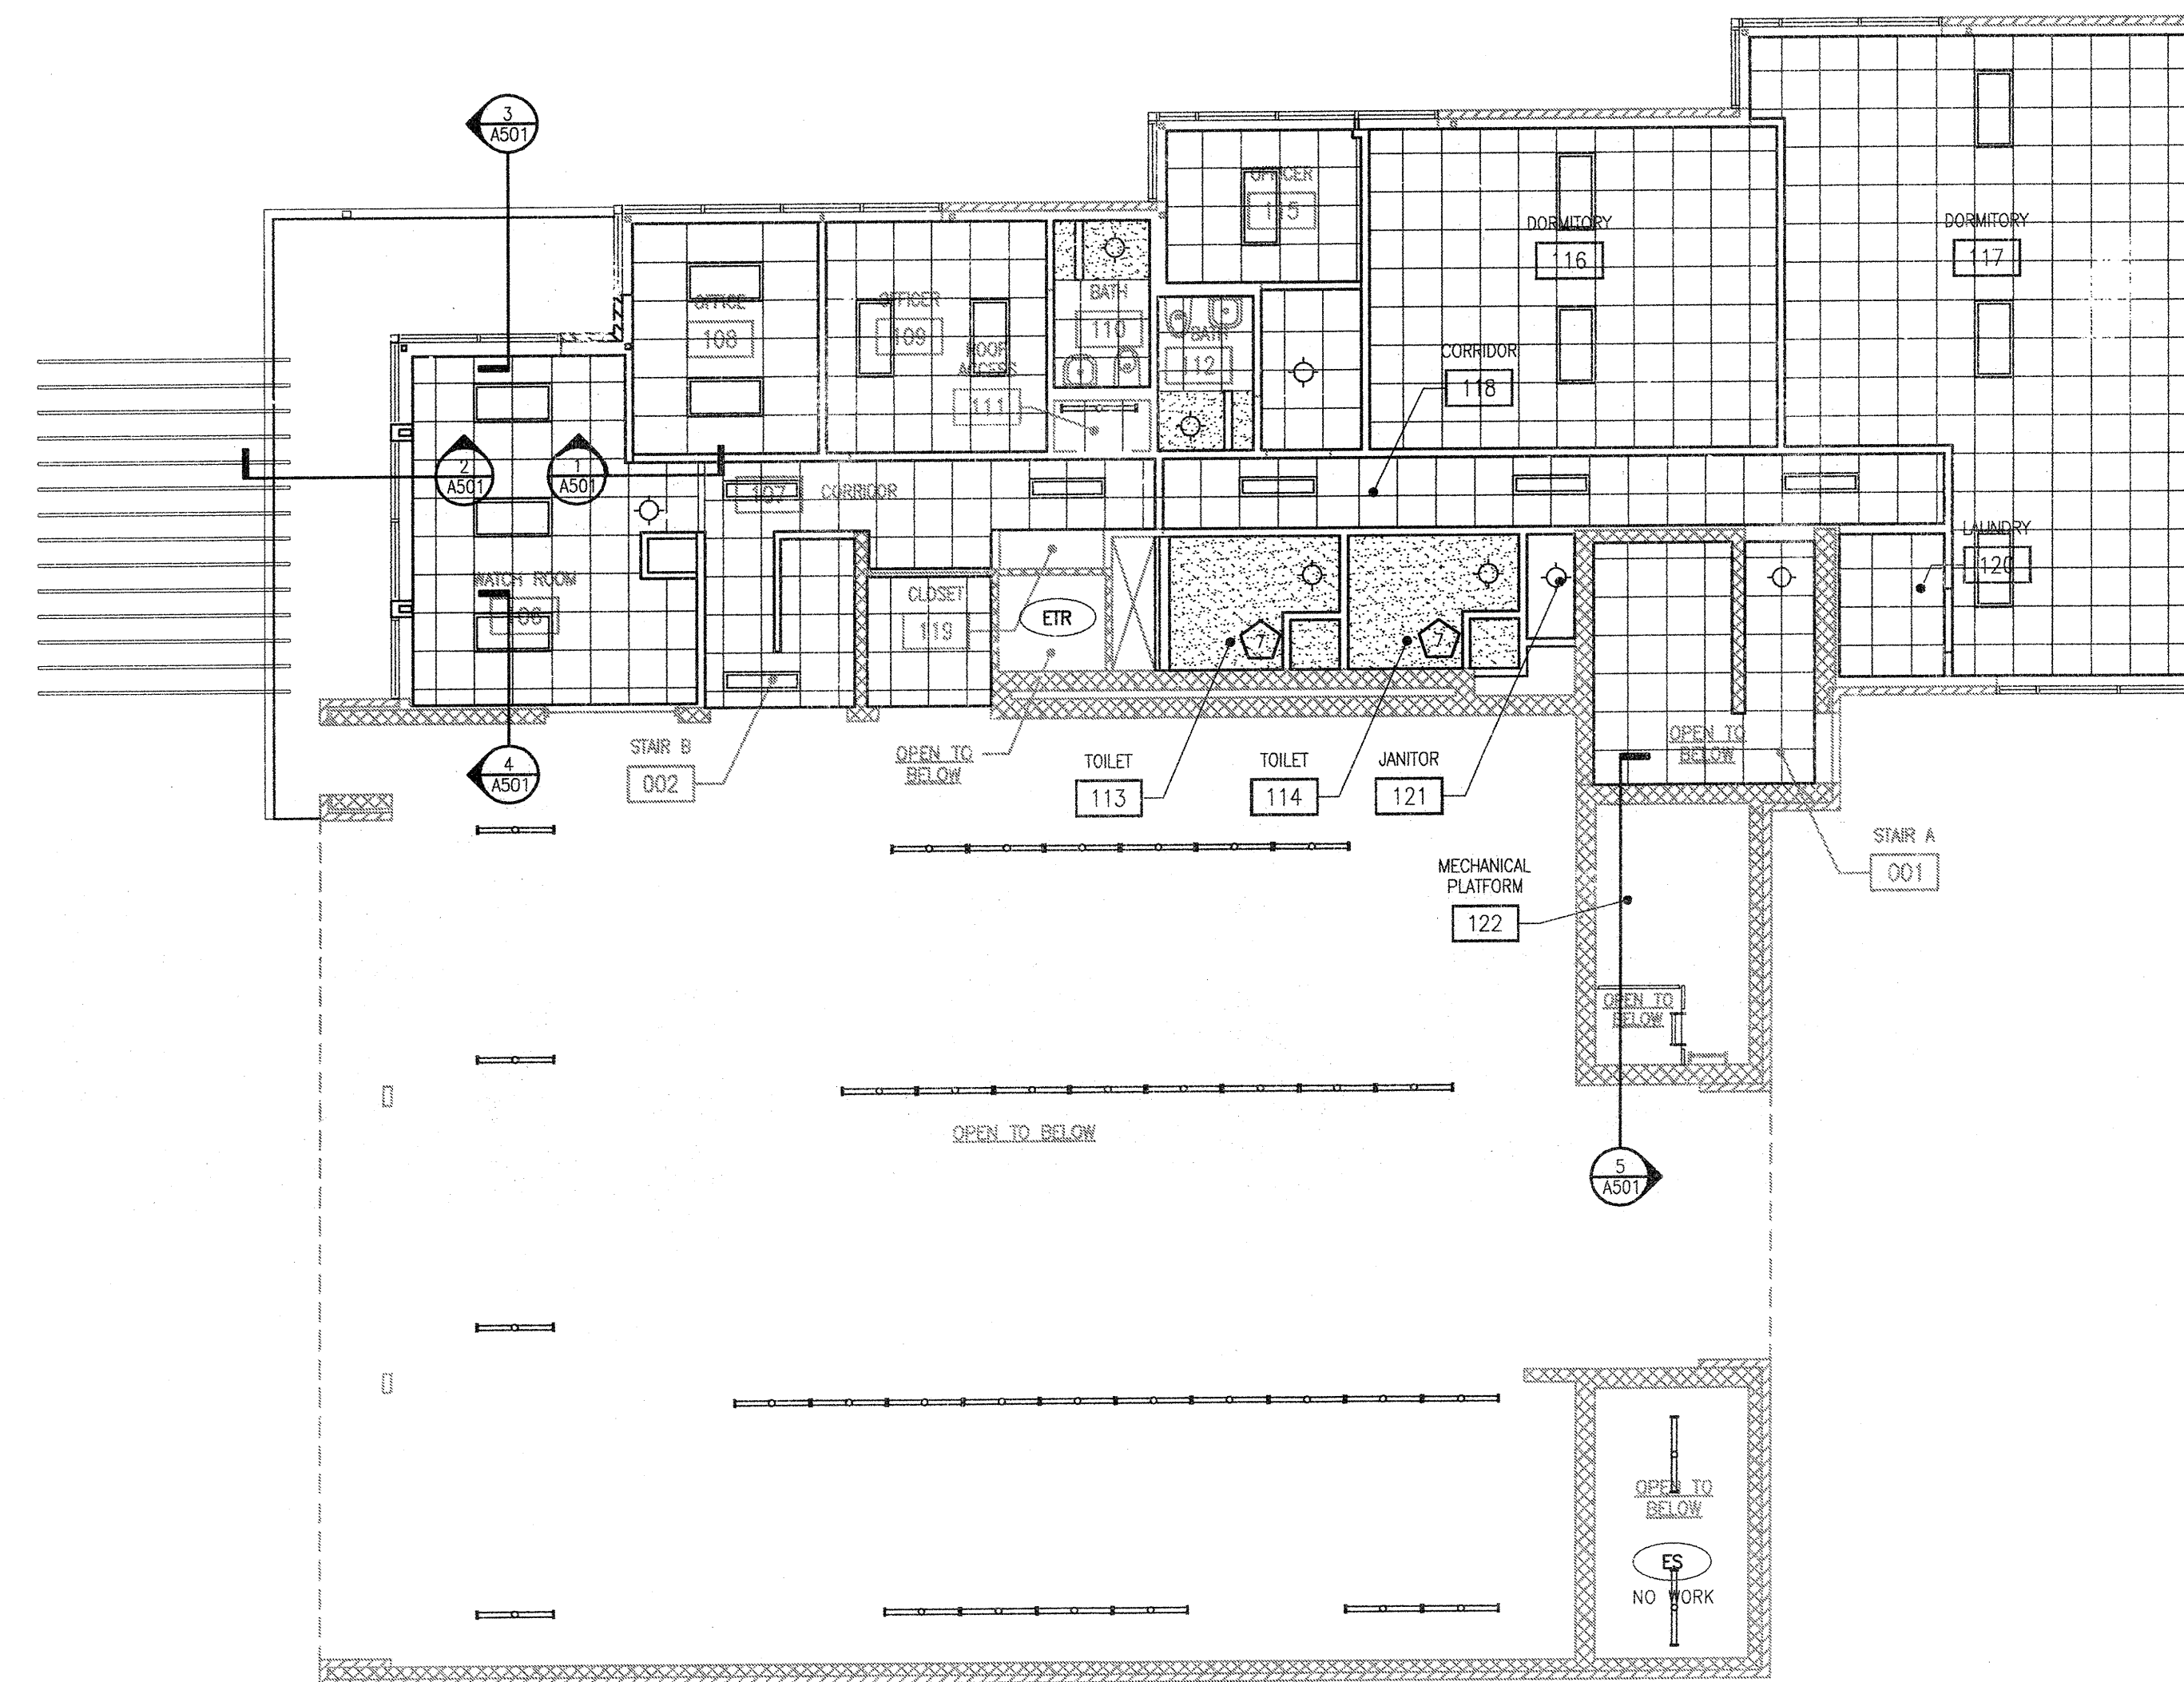


2
A301
UPPER LEVEL REFLECTED CEILING PLAN
SCALE: 1/8" = 1'-0"

REFLECTED CEILING PLAN LEGEND	
(NOTE: ALL SYMBOLS MAY NOT BE USED)	
	NEW: 2'x4' FLUORESCENT FIXTURE (RECESSED)
	EXISTING 2'x4' FLUORESCENT FIXTURE (RECESSED)
	4' FLUORESCENT
	RECESSED CAN
	EXIT LIGHT
	SPEAKER
	OCCUPANCY SENSOR
	RETURN AIR DUCT
	SUPPLY AIR DUCT
	GYPSUM WALLBOARD OR EXTERIOR PLASTER
	ACOUSTICAL CEILING (ACP)
	SURFACE MOUNTED TRACK LIGHT
	EXPOSED STRUCTURE
	EXISTING SUSPENDED CEILING TO REMAIN

GENERAL CEILING PLAN NOTES	
1.	SEE ROOM FINISH SCHEDULE FOR CEILING HEIGHTS.
2.	MECH. ELEC. PLUG. FIXTURES SHOWN FOR COORDINATION ONLY. SEE MECH. ELEC. & PLUG. DRAWINGS.
SPECIFIC CEILING PLAN NOTES	
1	PROVIDE SOFFIT - SEE DETAIL 4/A301.
2	PROVIDE GYPSUM DRYWALL BULKHEAD ABOVE KITCHEN CABINETS.
3	PROVIDE SLOPED GYPSUM DRYWALL SOFFIT SIMILAR TO DETAIL 4/A301.
4	PROVIDE SUSPENDED GYPSUM DRYWALL CEILING AT SAME ELEVATION AS ADJACENT ACOUSTICAL CEILING. PROVIDE AN OPENING FOR EGGRATE GRILLE PROVIDED BY HVAC CONTRACTOR.
5	KITCHEN HOOD BY HVAC CONTRACTOR.
6	EXISTING SOFFIT TO REMAIN
7	PROVIDE 16" x 16" CEILING ACCESS PANEL FOR ACCESS TO PLUMBING VALVES IN CEILING CAVITY. COORDINATE LOCATION OF ACCESS PANEL WITH ACTUAL INSTALLED LOCATION OF VALVES.

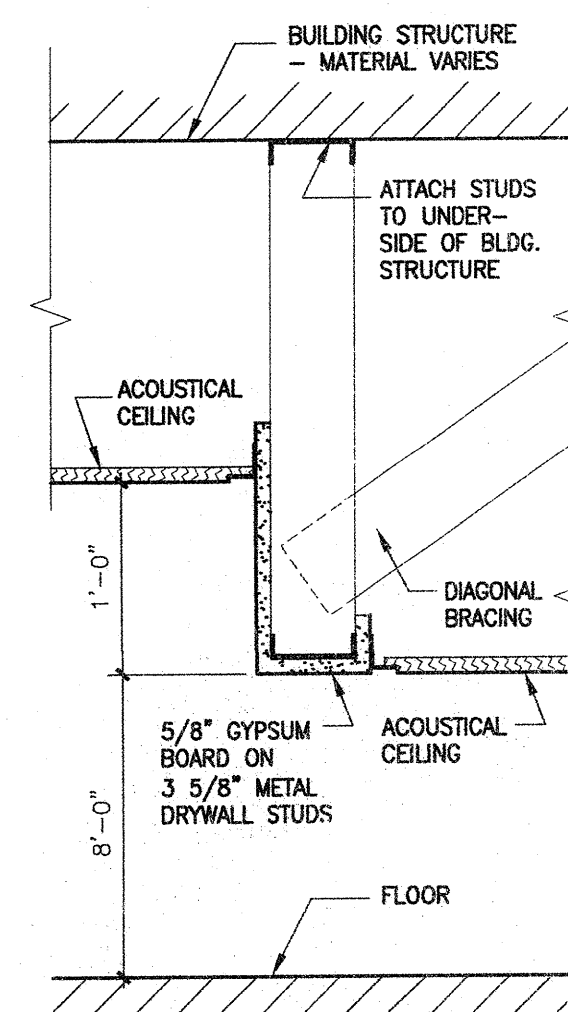

4
A301
SOFFIT SECTION
SCALE: 1 1/2" = 1'-0"

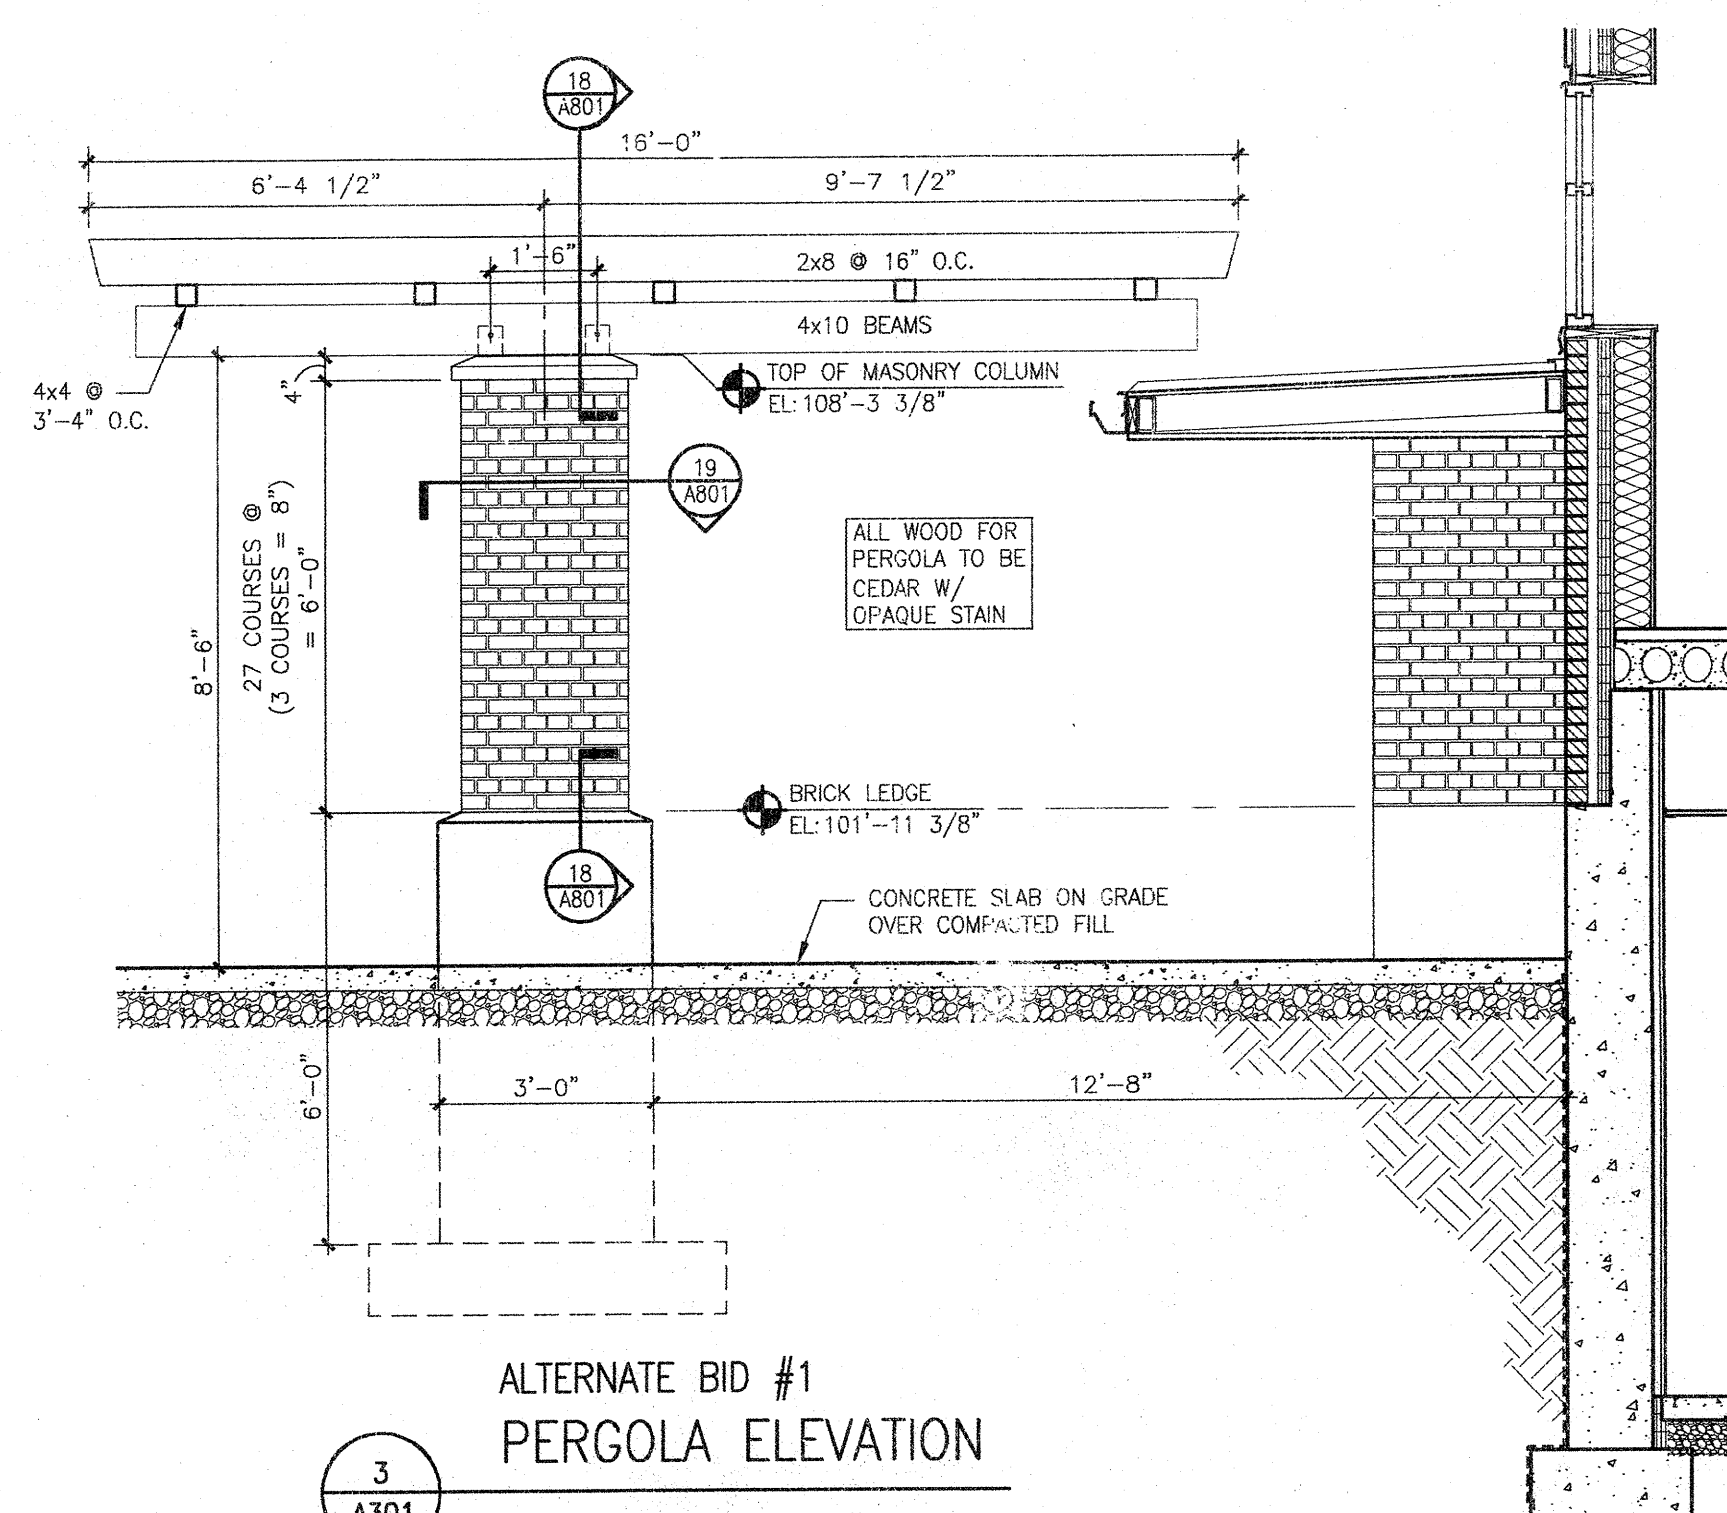

3
A301
ALTERNATE BID #1
PERGOLA ELEVATION
SCALE: 3/8" = 1'-0"

DRAWING SET	OWNER REVIEW
COPYRIGHT	2012
STRANG, INC.	
FILE NAME	2011009-A301.DWG
REVISIONS	

DRAWN	DV
CHECKED	AB, LB
DATE	03-09-12
PROJECT NO.	2011009
PROJECT TITLE	

**CITY OF MADISON
FIRE STATION #2
ADDITION AND
REMODELING**

421 GRAND CANYON DRIVE
MADISON, WISCONSIN

SHEET TITLE

**REFLECTED
CEILING PLANS**

SHEET NO.

A301