

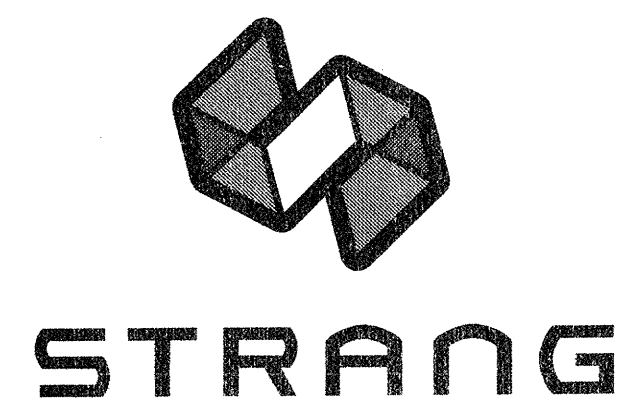
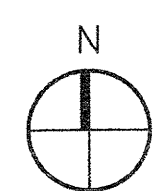


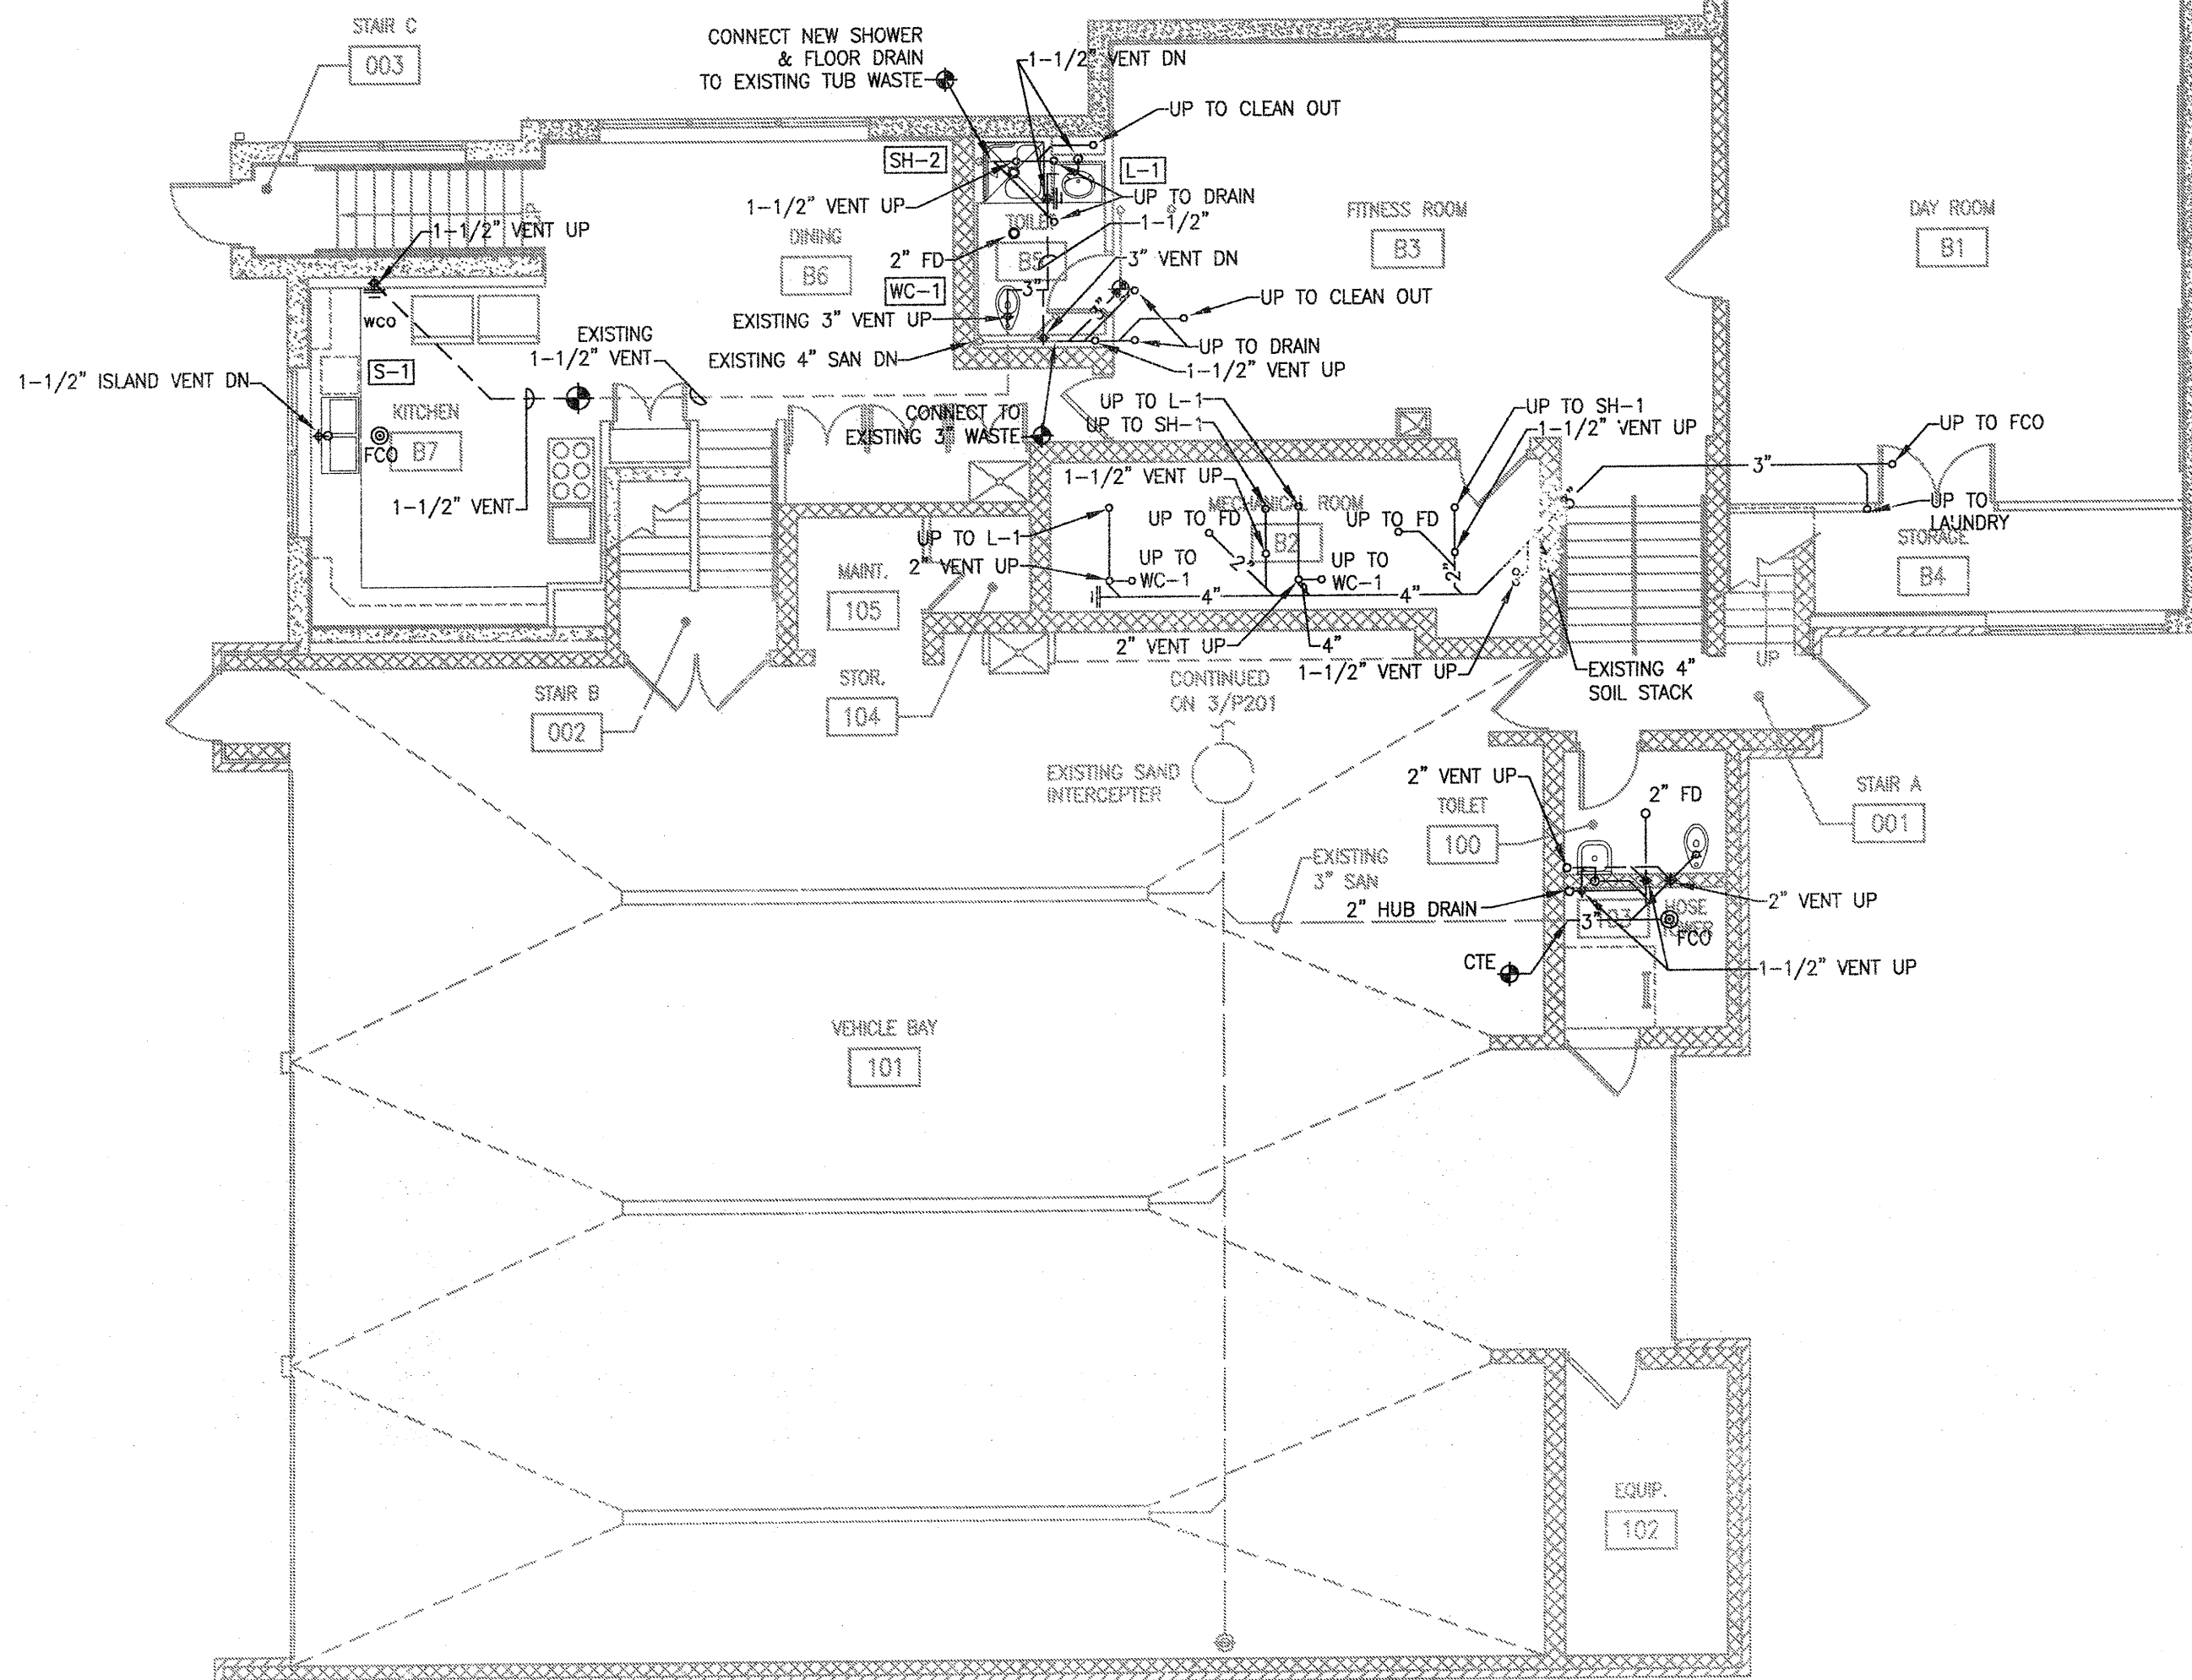

ARCHITECTURE
ENGINEERING
INTERIOR DESIGN

STRANG INC.
5411 MINERAL POINT ROAD
MADISON, WI 53705-4385
T/ 608 276 9200
F/ 608 276 9204



GCO w/ FROST SLEEVE

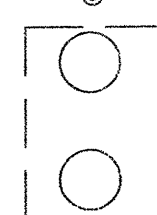

1
P201

LOWER LEVEL WASTE ADDITION AND REMODELING PLAN



SCALE: 1/8" = 1'-0"

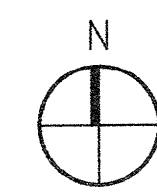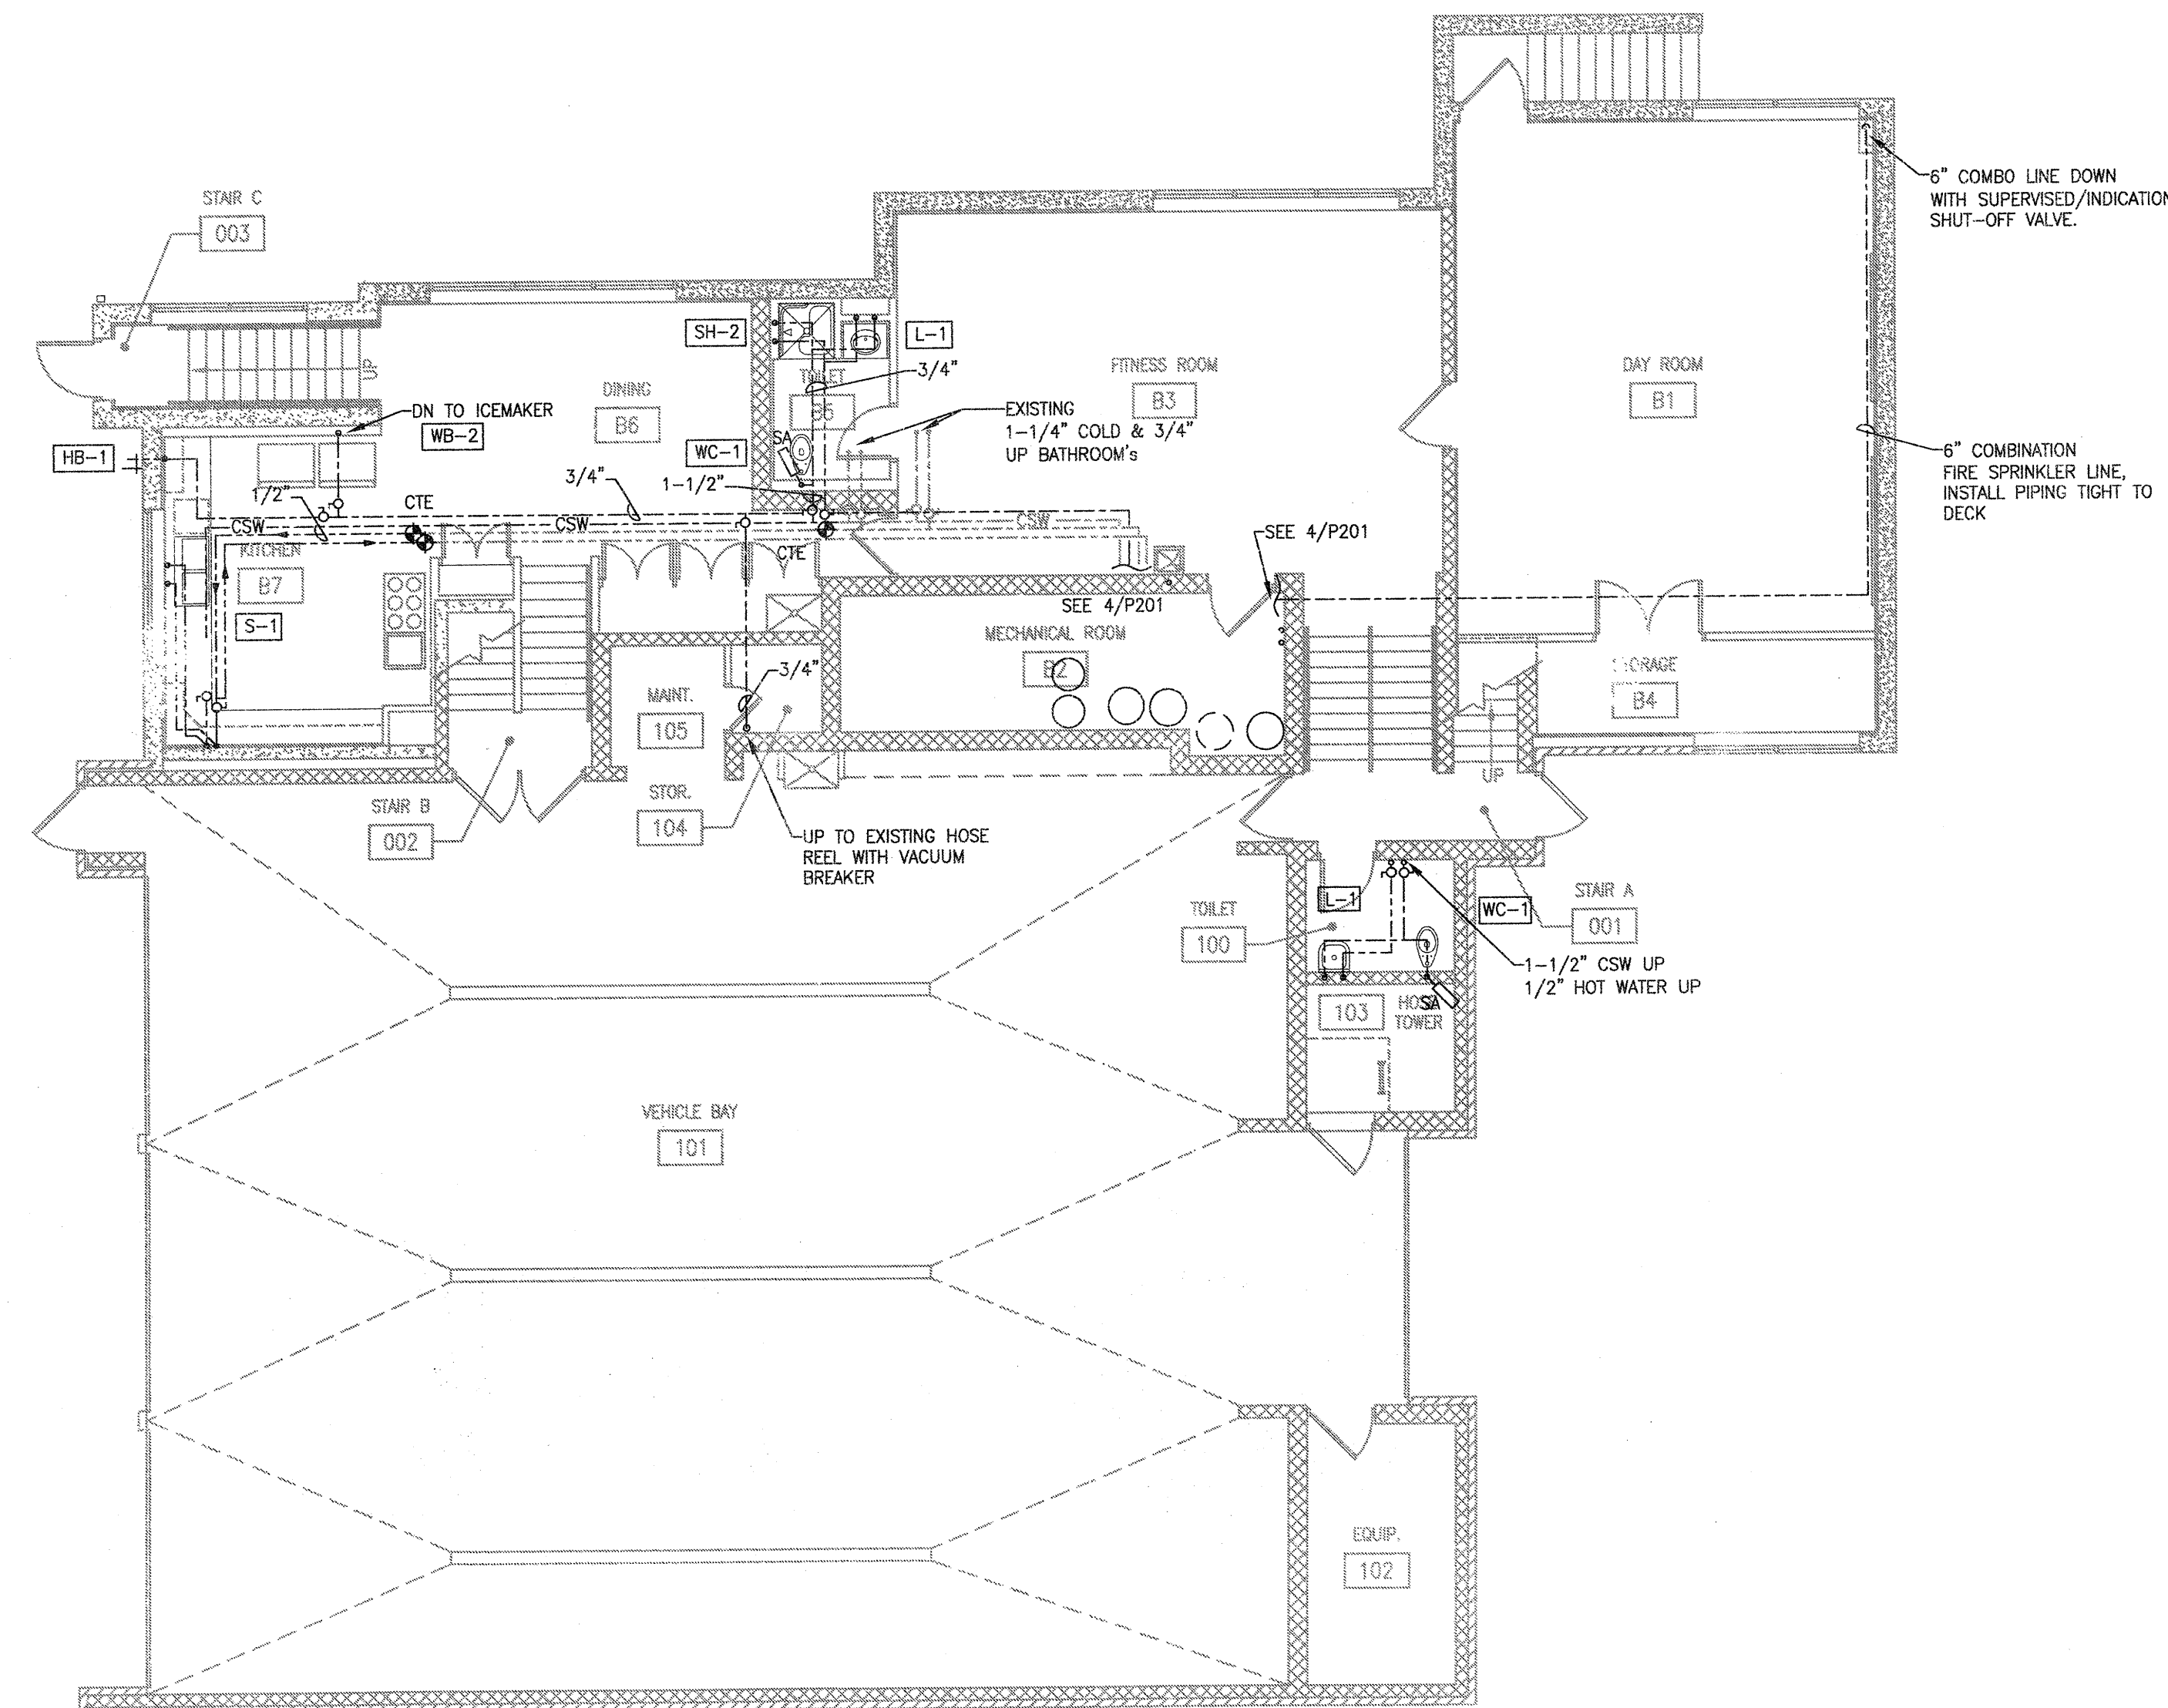

2
P201

LOWER LEVEL SUPPLY ADDITION AND REMODELING PLAN


SCALE: 1/8" = 1'-0"

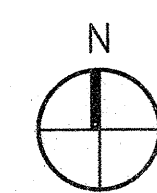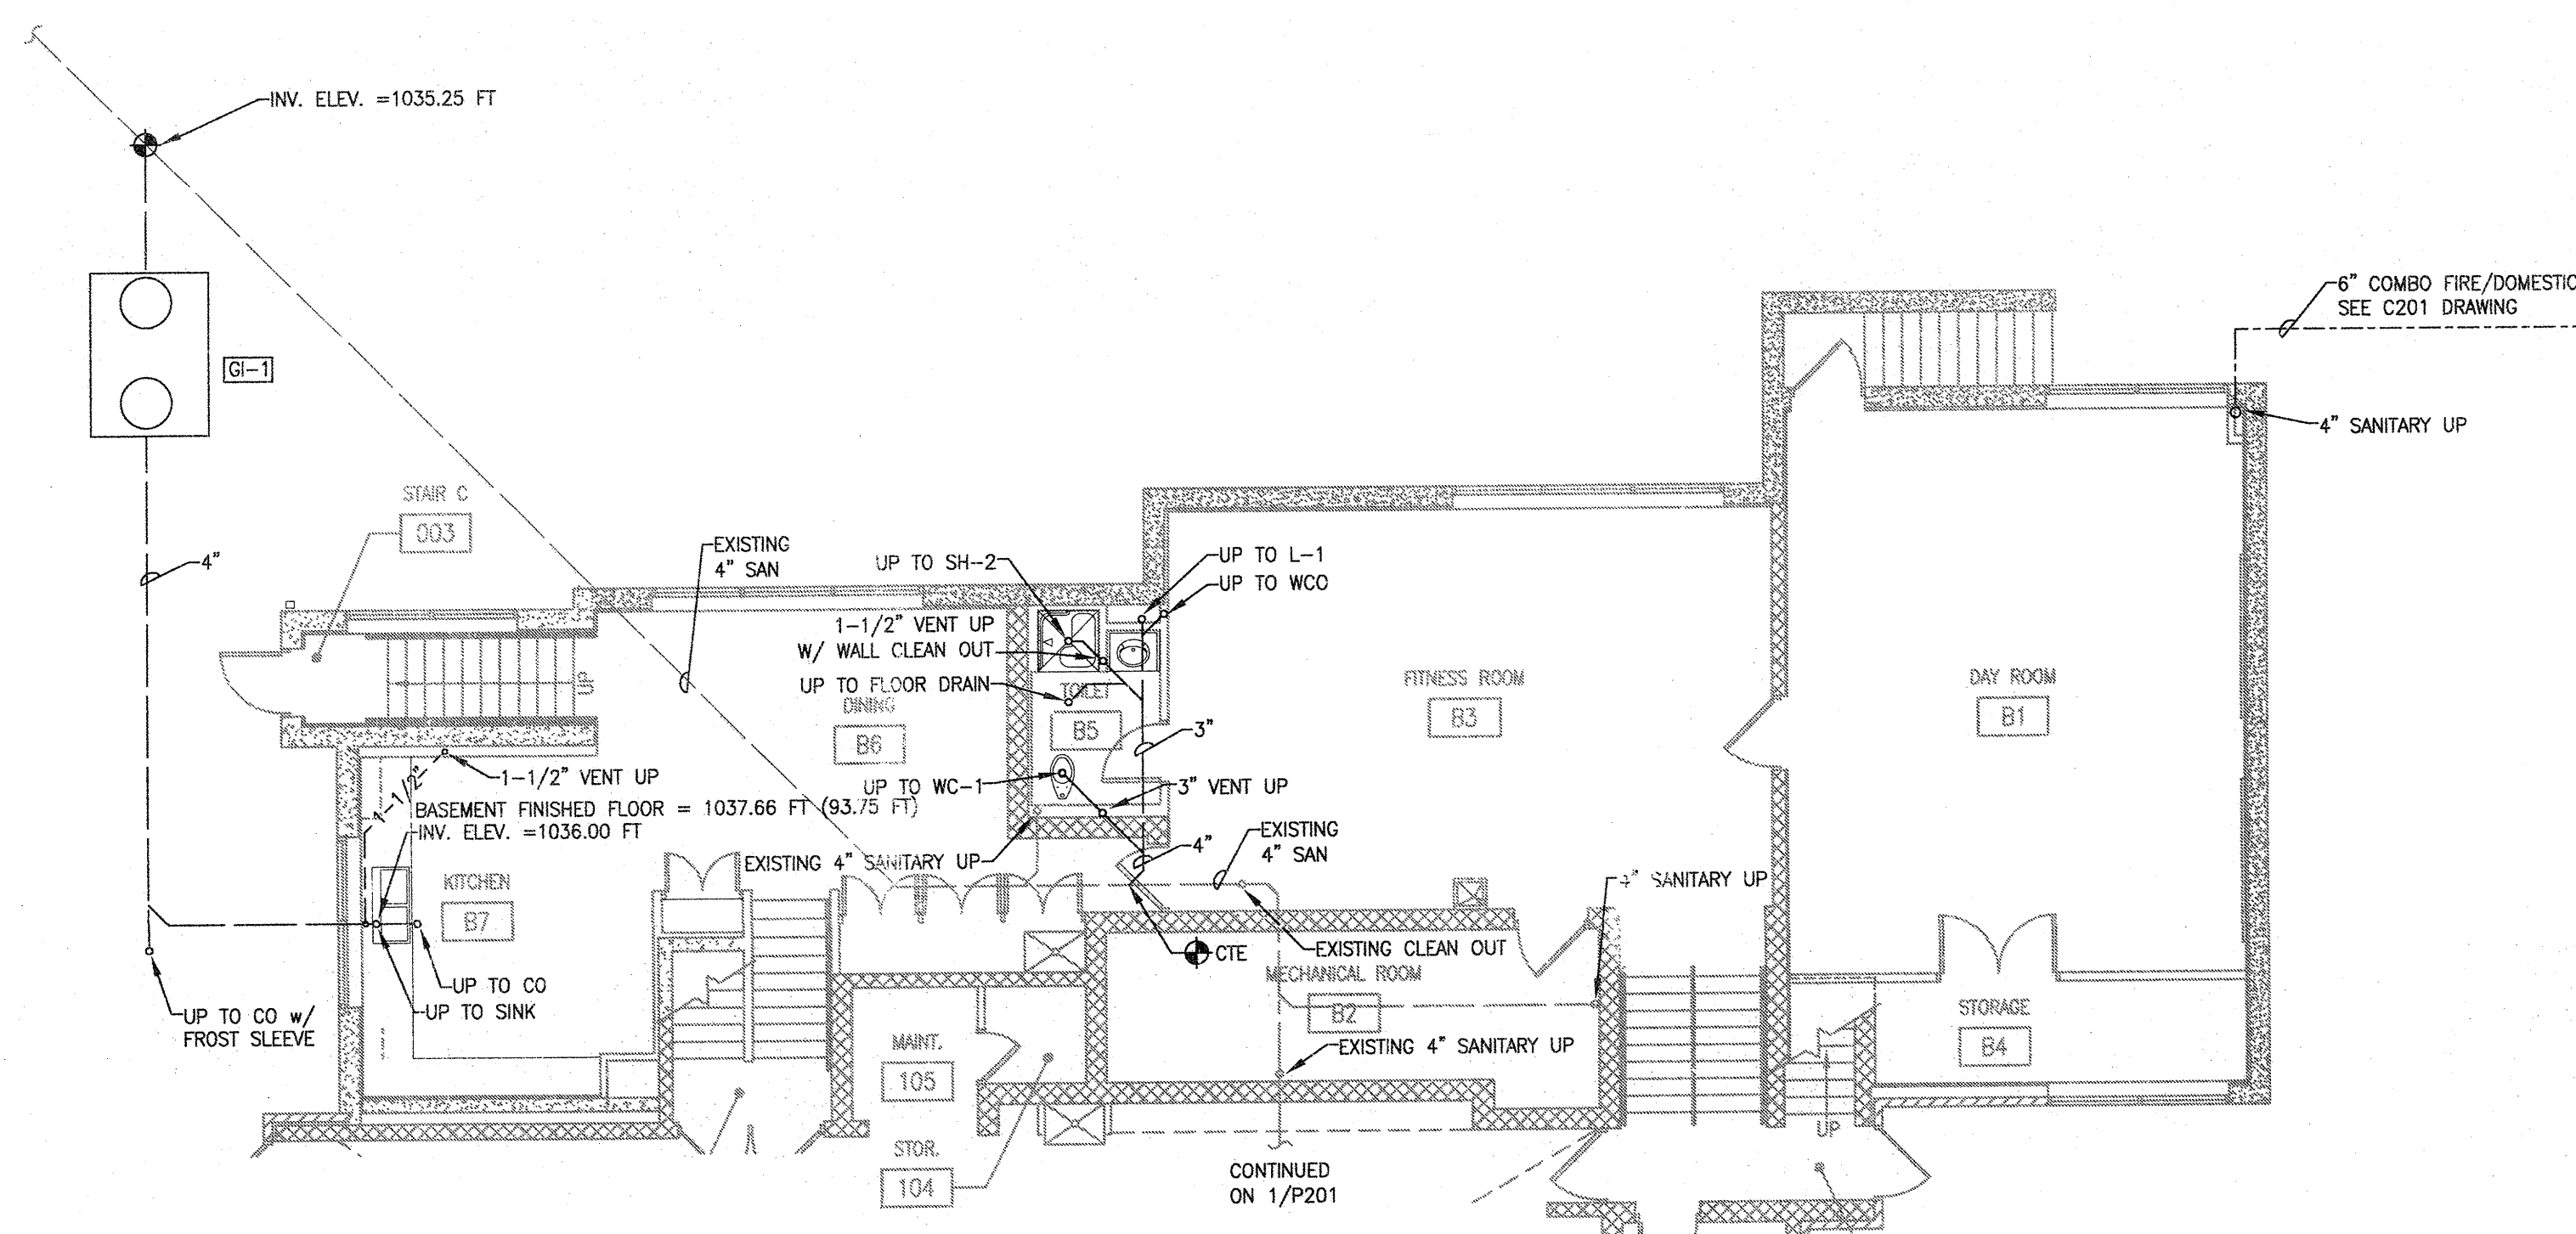

3
P201

LOWER LEVEL UNDERSLAB ADDITION AND REMODELING PLAN

SCALE: 1/8" = 1'-0"

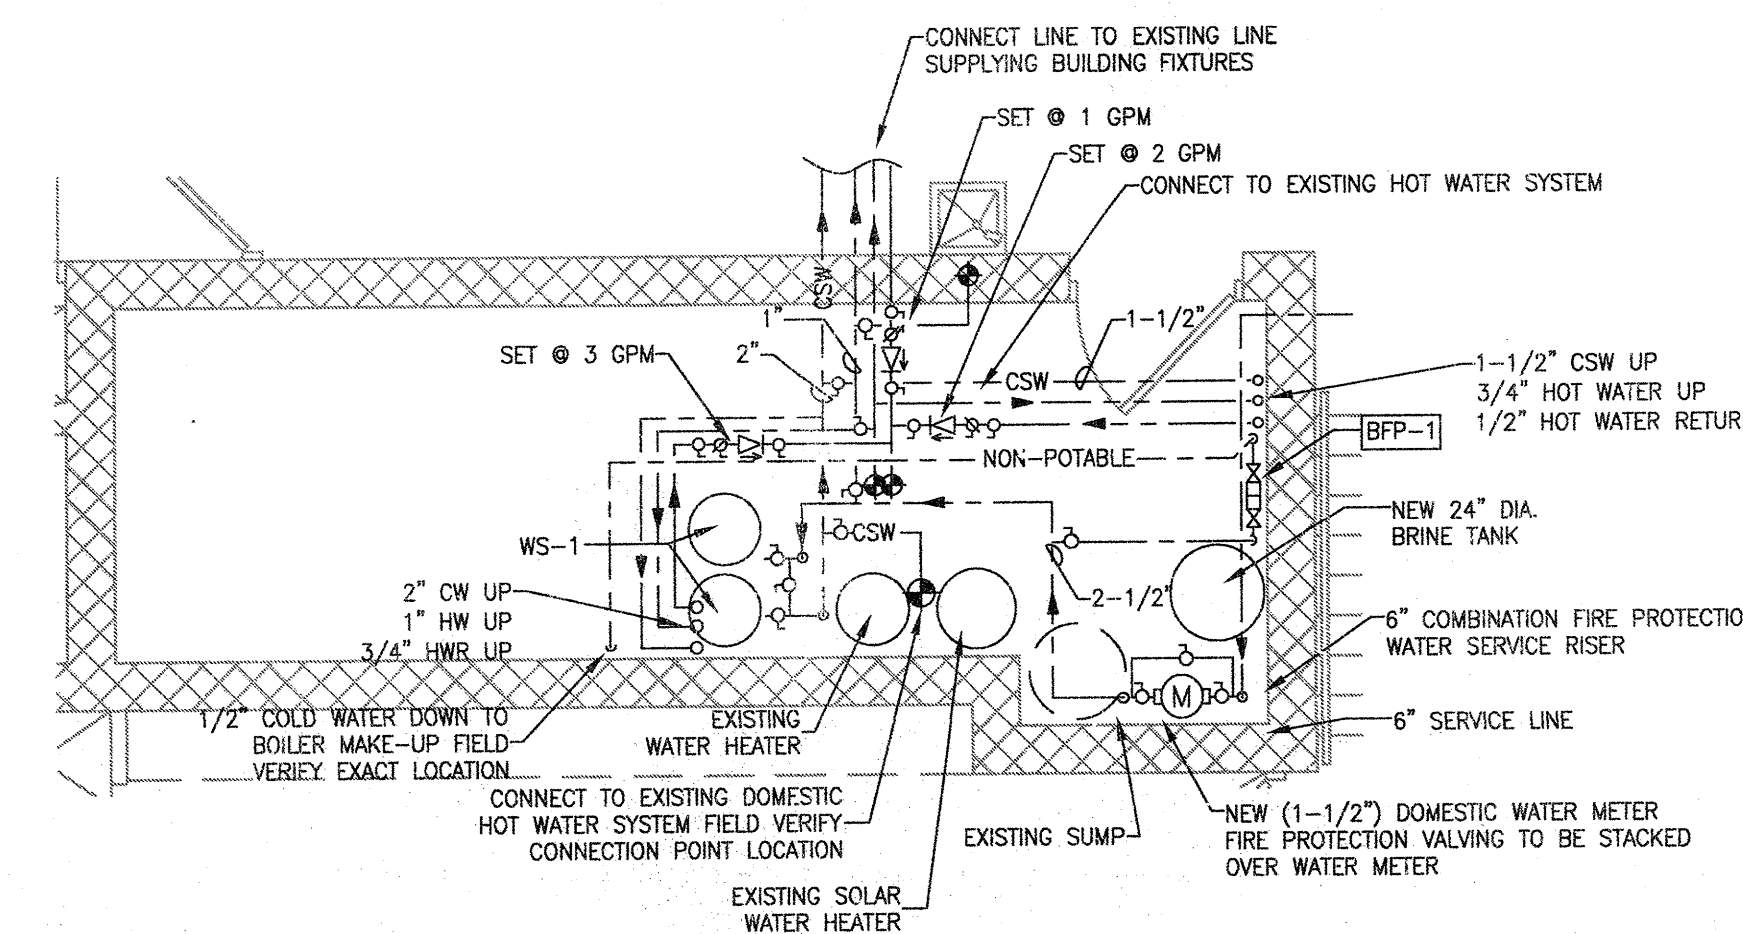

4
P201

LOWER LEVEL SUPPLY ADDITION AND REMODELING PLAN

SCALE: 1/8" = 1'-0"

DRAWING SET OWNER REVIEW

COPYRIGHT STRANG, INC. 2012

FILE NAME 2011006-P201.DWG

REVISIONS

DRAWN DJS

CHECKED BFK

DATE 03-09-12

PROJECT NO. 2011009

PROJECT TITLE

CITY OF MADISON
FIRE STATION #2
ADDITION AND
REMODELING

421 GRAND CANYON DRIVE
MADISON, WISCONSIN

SHEET TITLE

ADDITION AND
REMODELING
PLUMBING PLANS

SHEET NO.

P201