



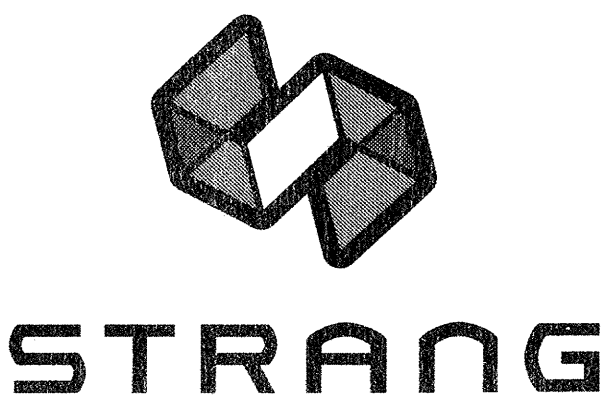


ARCHITECTURE
ENGINEERING
INTERIOR DESIGN

STRANG INC.
6411 MINERAL POINT ROAD
MADISON, WI 53705-4395
T/ 608 276 9200
F/ 608 276 9204

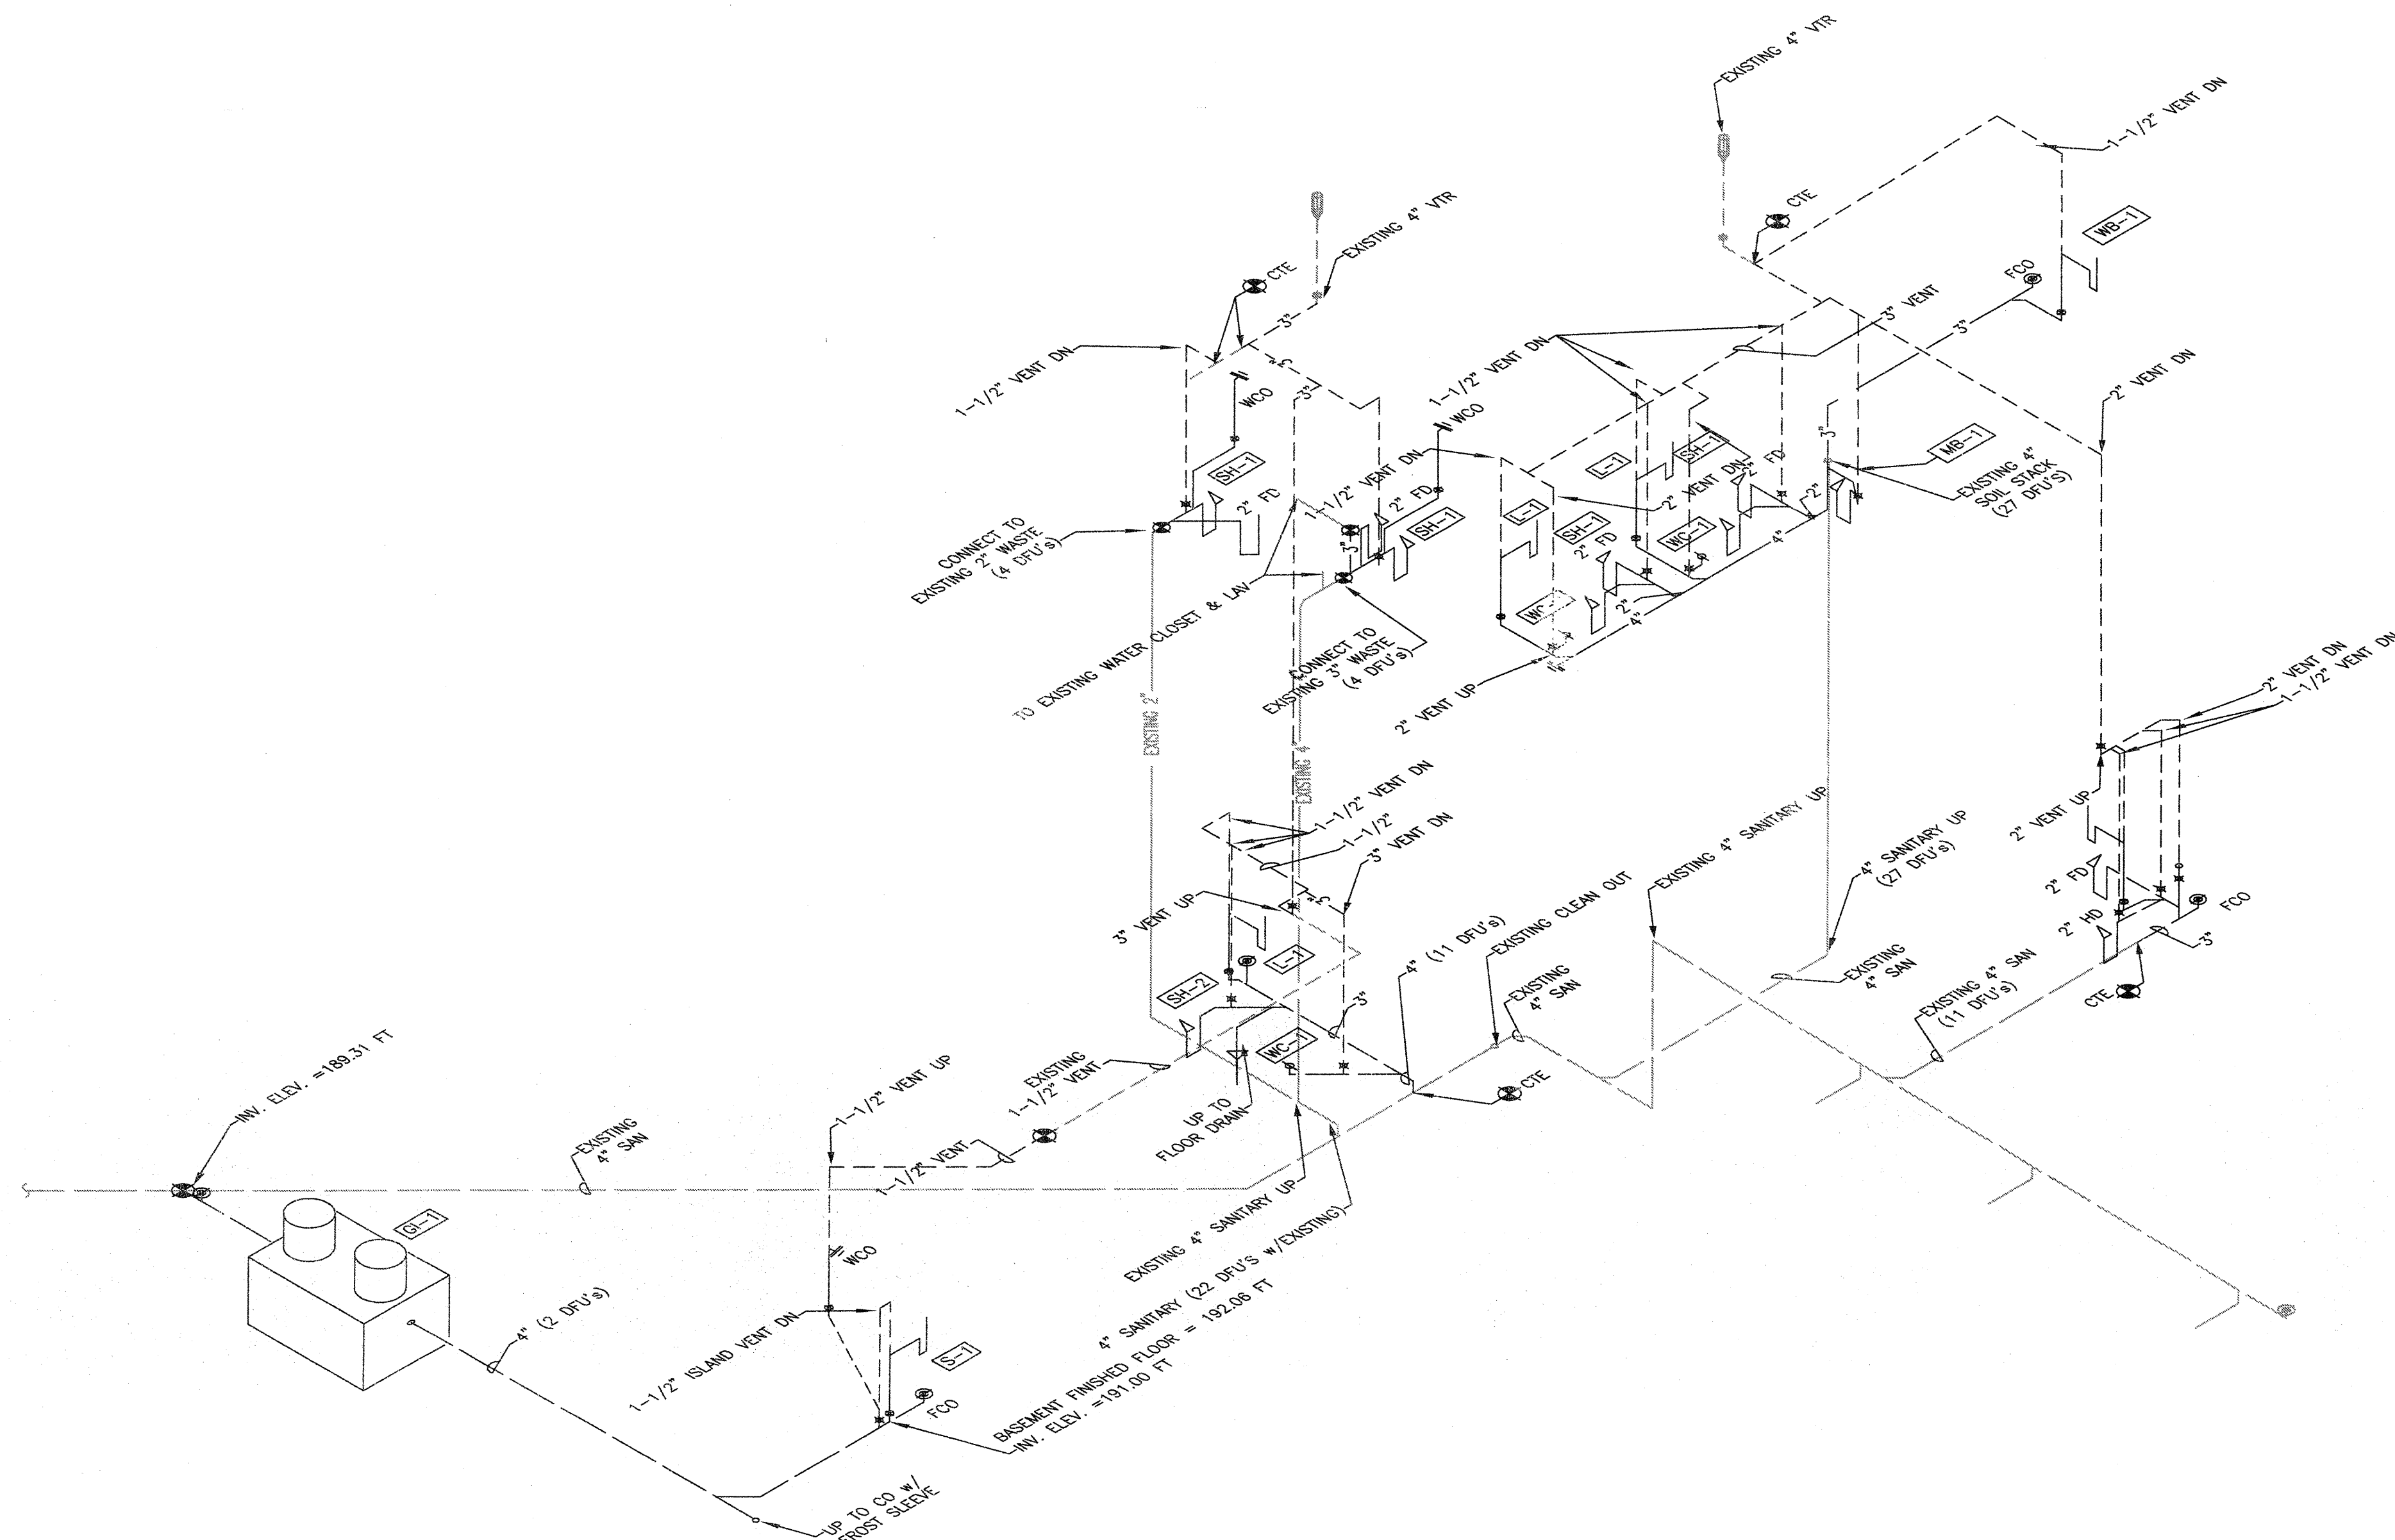

1
P301 PLUMBING WASTE RISER
SCALE: N.T.S.

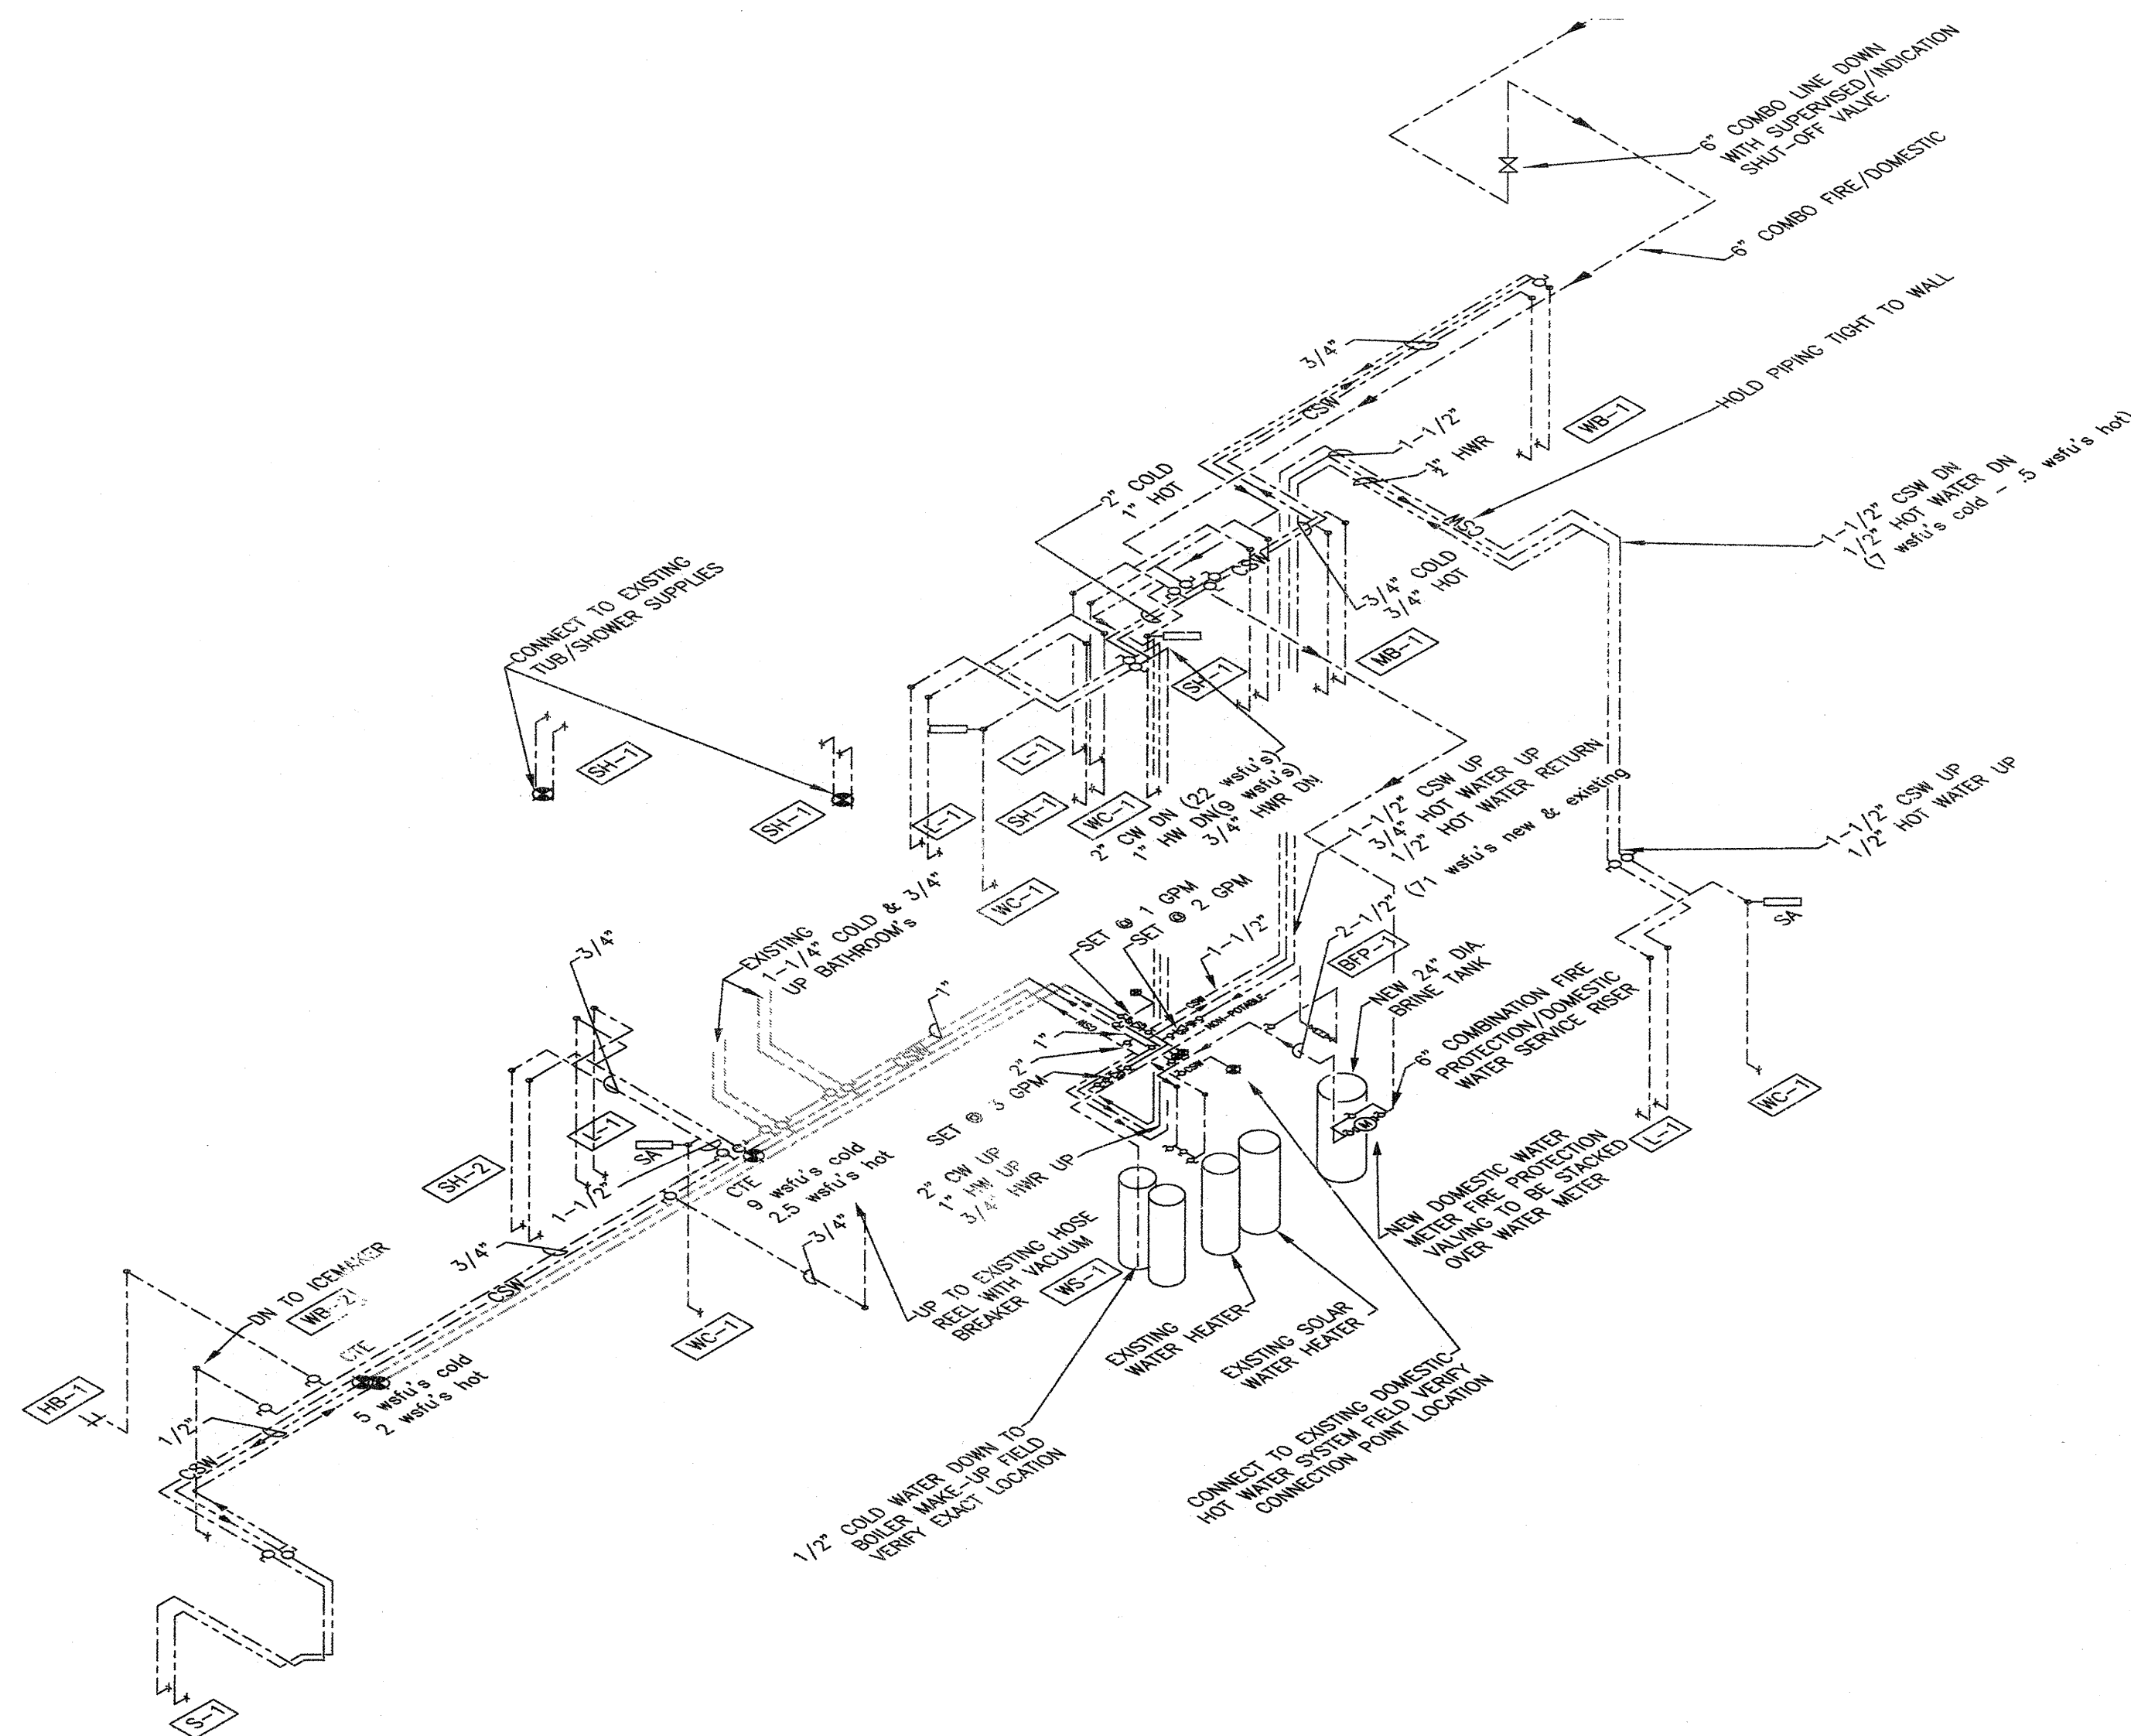

2
P301 PLUMBING SUPPLY RISER
SCALE: N.T.S.

DR/ WING SET	OWNER REVIEW
COPYRIGHT STRANG, INC.	2012
FILE NAME	2011009-P301.DWG
REVISIONS	

DRAWN	DF
CHECKED	BFK
DATE	03-09-12
PROJECT NO.	2011009

PROJECT TITLE

CITY OF MADISON
FIRE STATION #2
ADDITION AND
REMODELING

421 GRAND CANYON DRIVE
MADISON, WISCONSIN

SHEET TITLE

PLUMBING RISERS

SHEET NO.

P301