




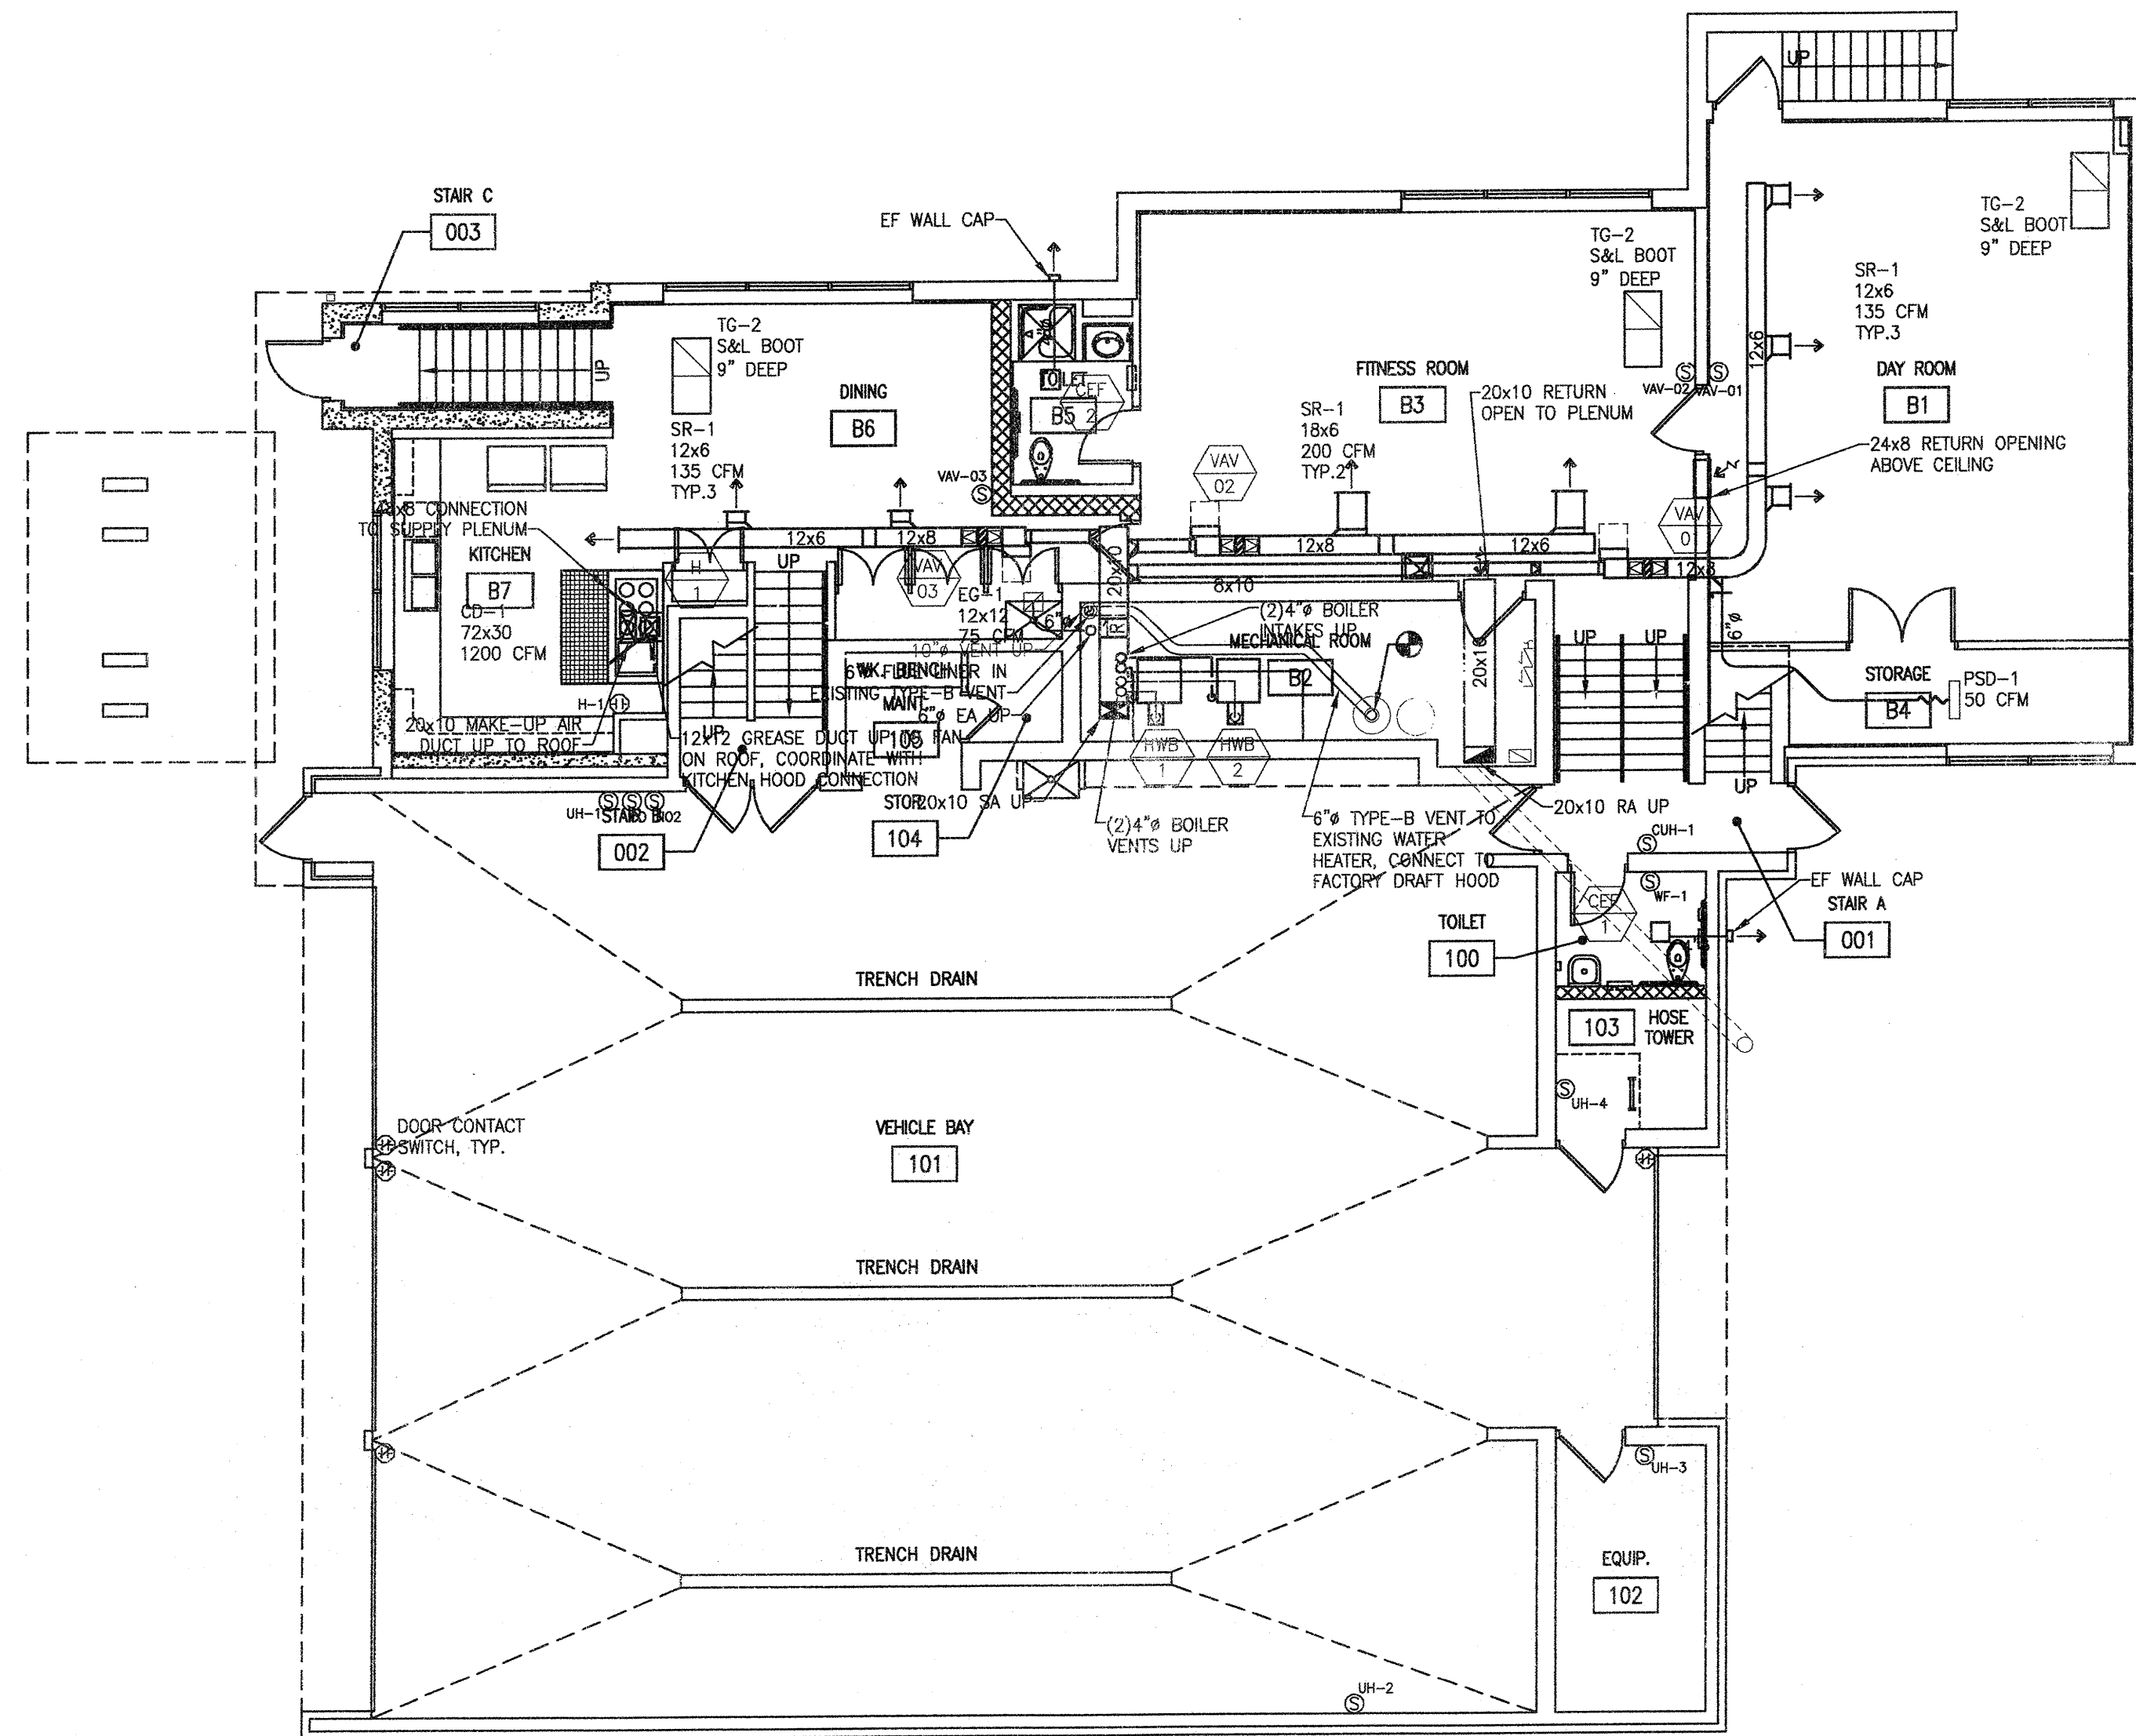


1 LOWER LEVEL HVAC REMODELING PLAN
SCALE: 1/8" = 1'-0"

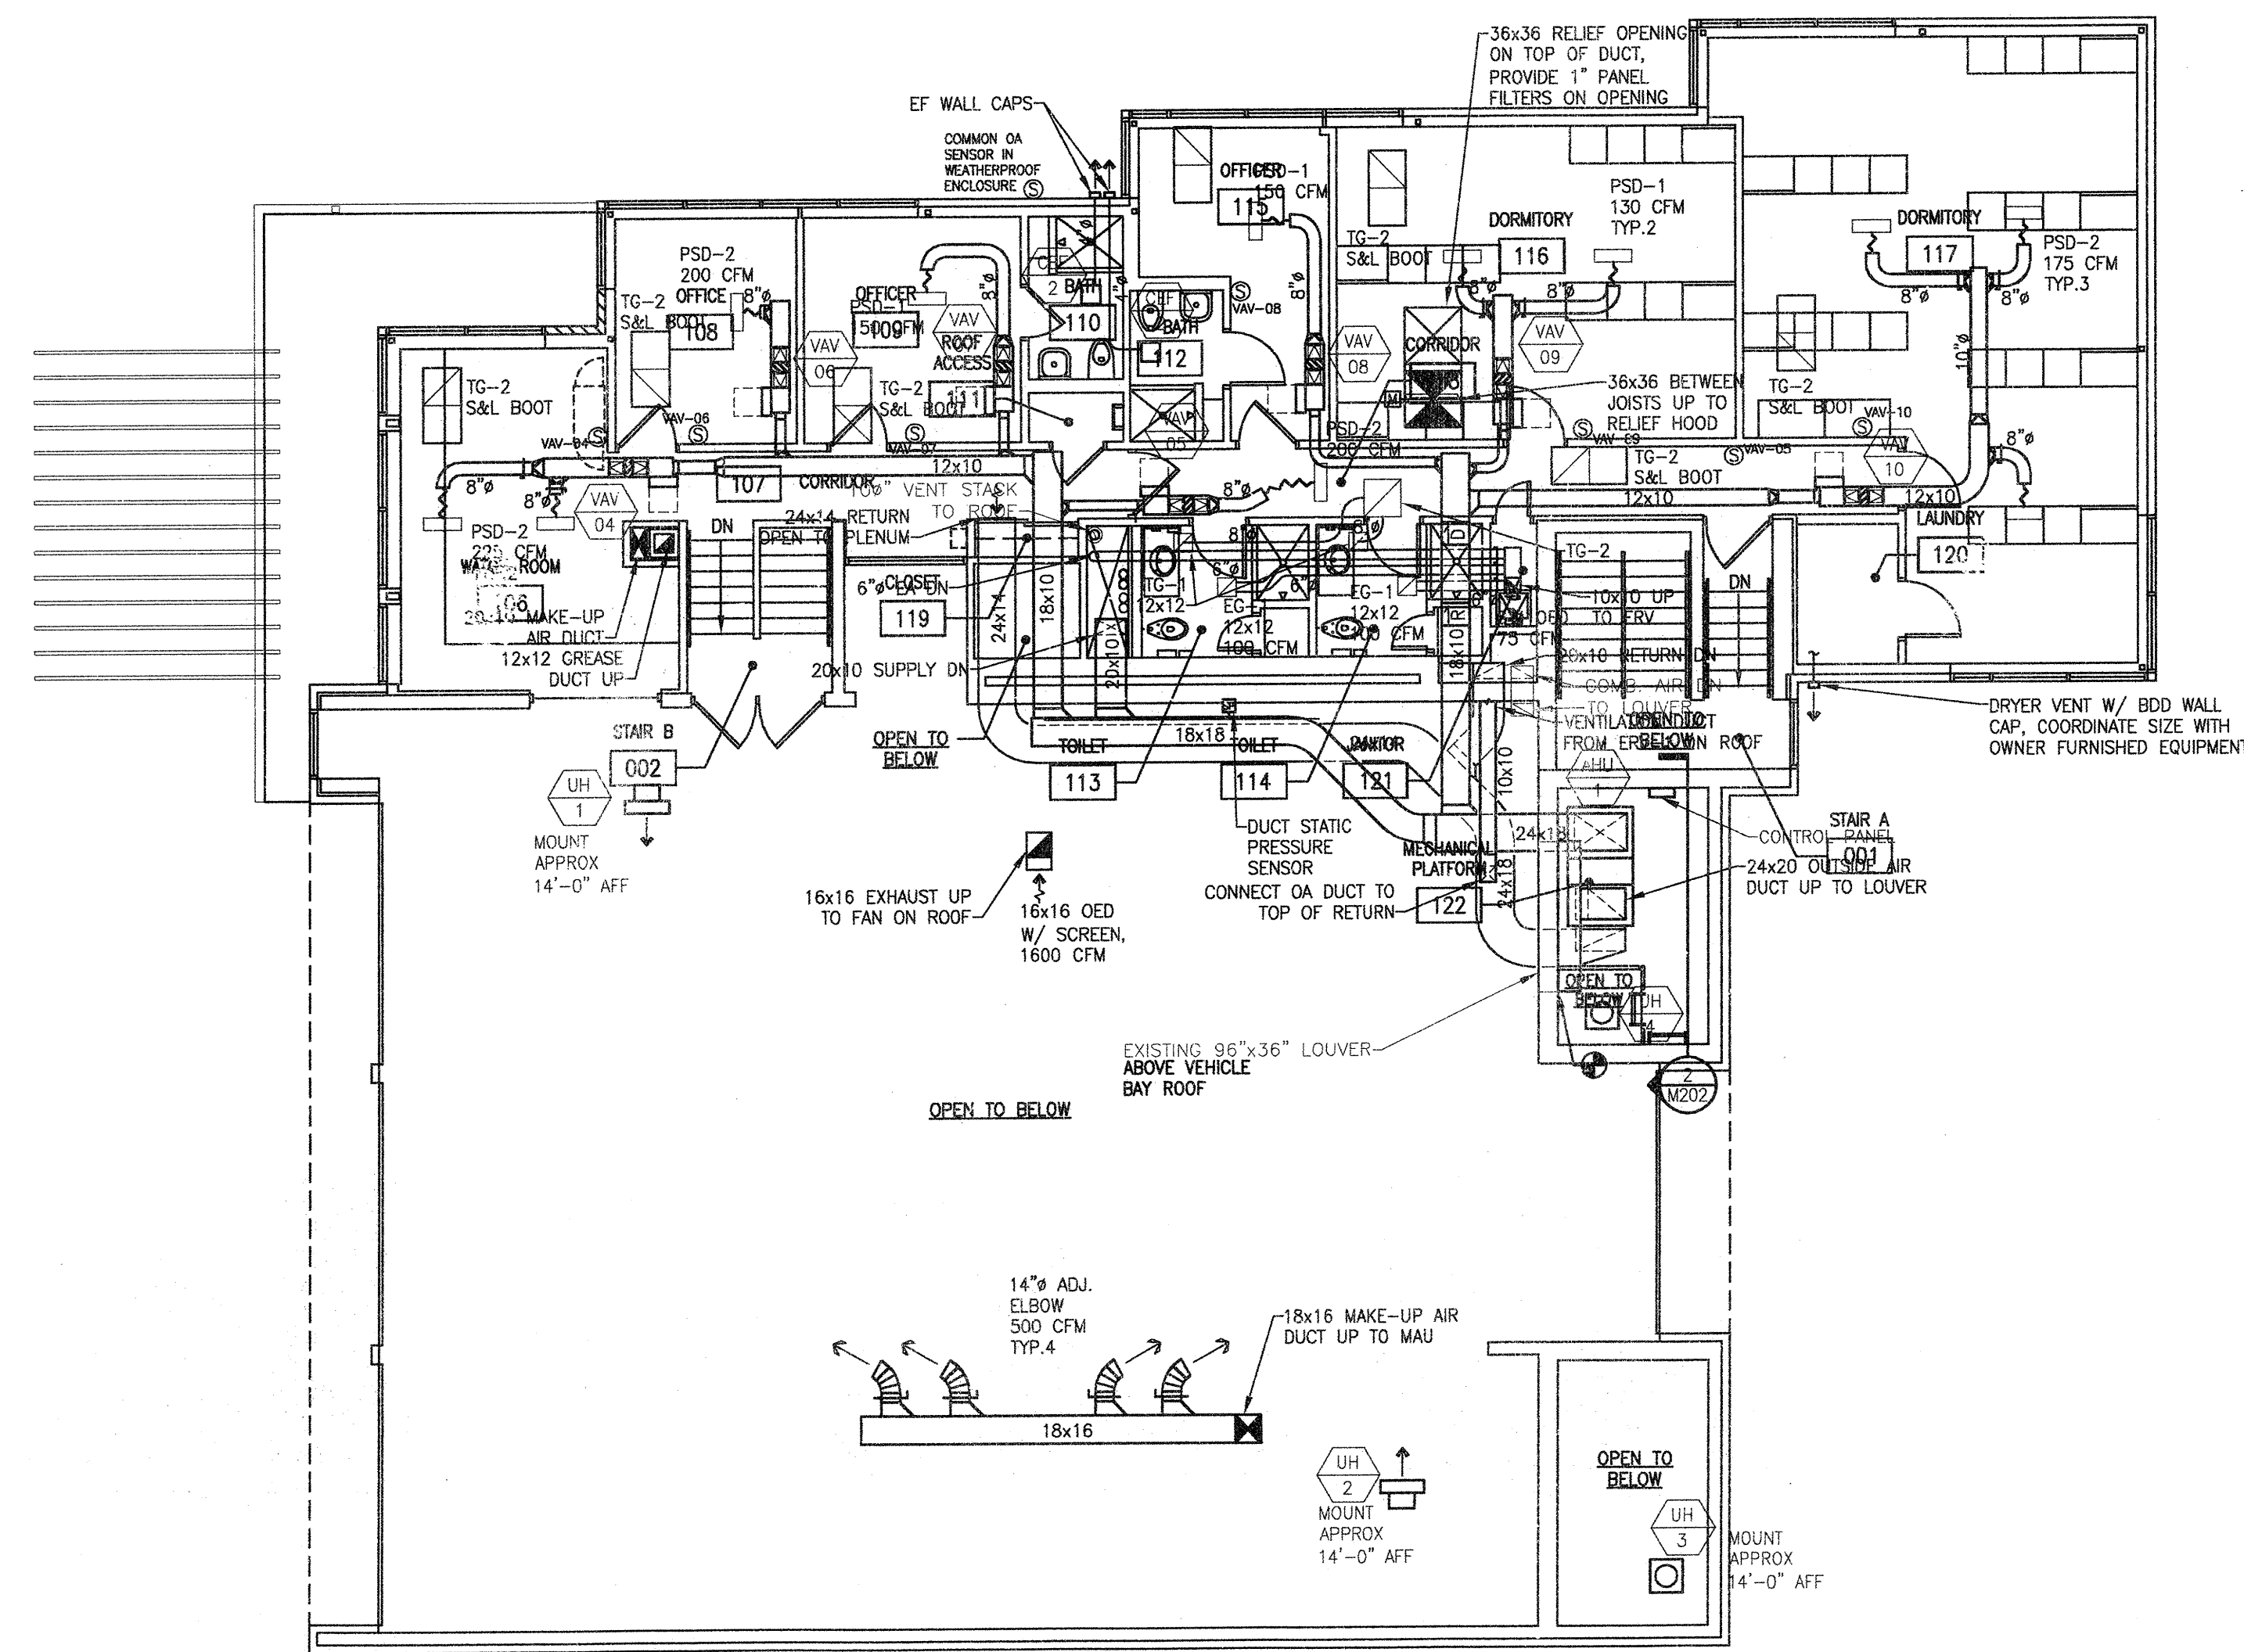

2 UPPER LEVEL HVAC REMODELING PLAN
SCALE: 1/8" = 1'-0"

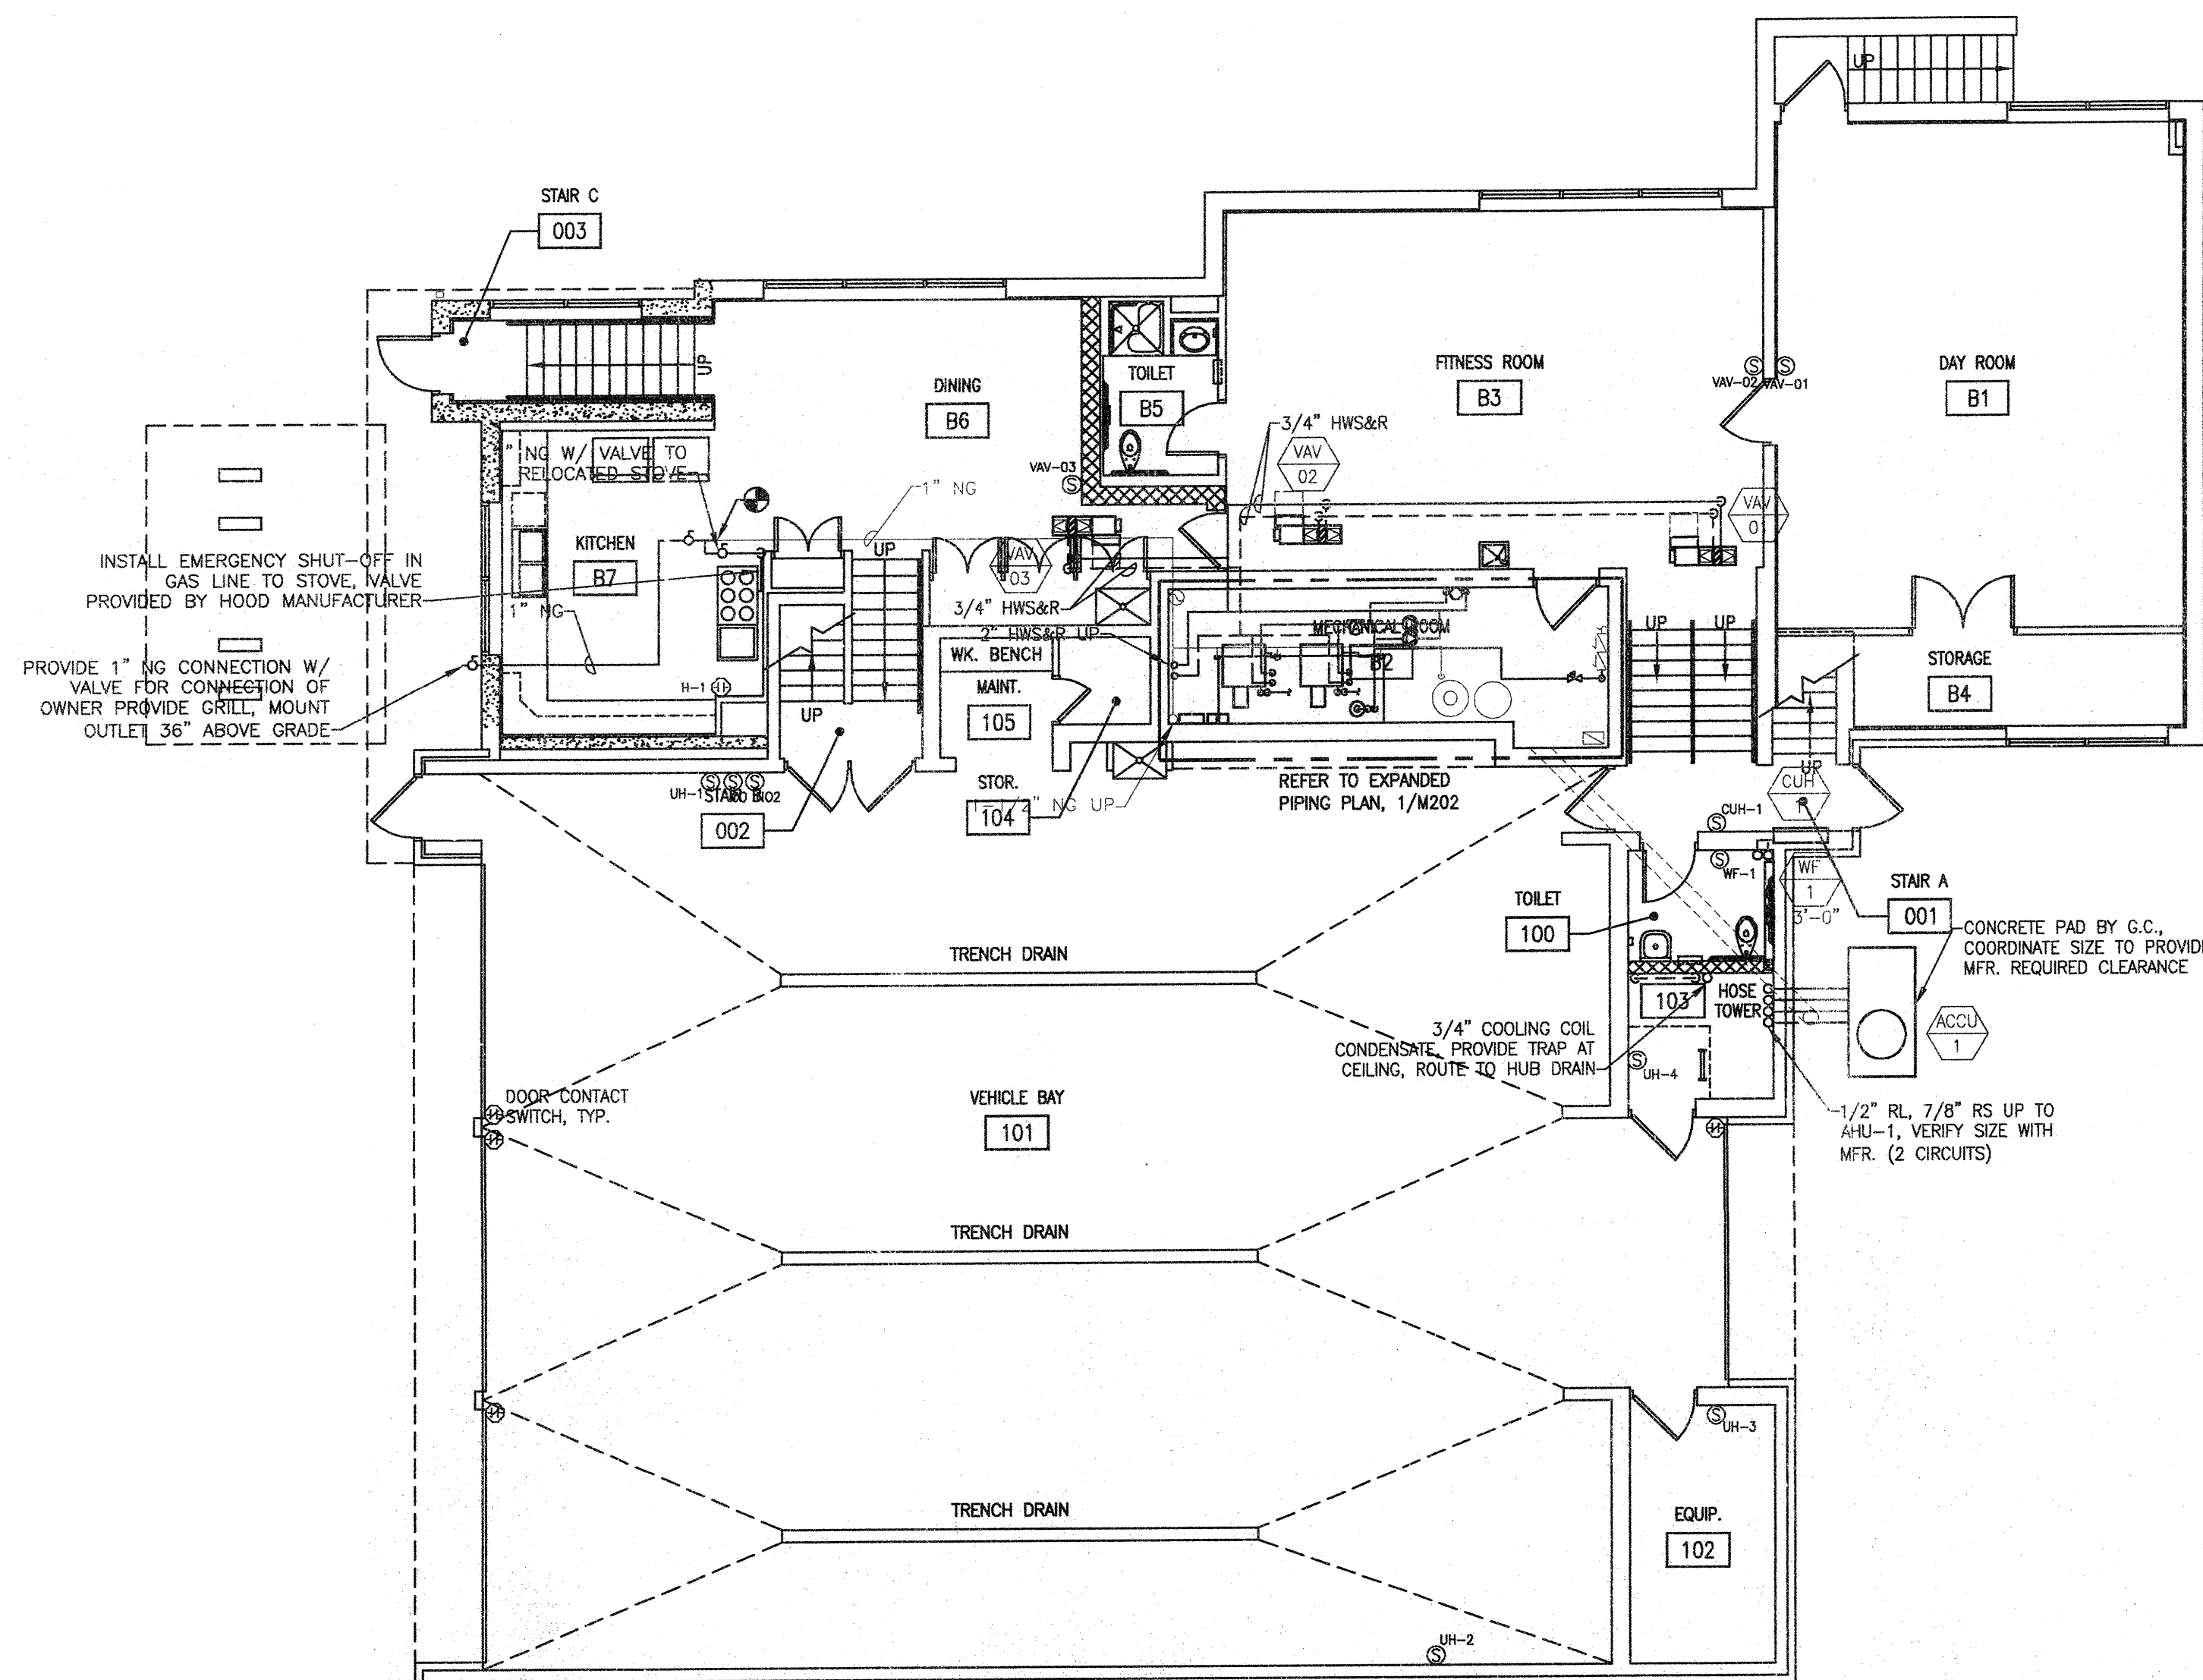

3 LOWER LEVEL HVAC PIPING PLAN
SCALE: 1/8" = 1'-0"

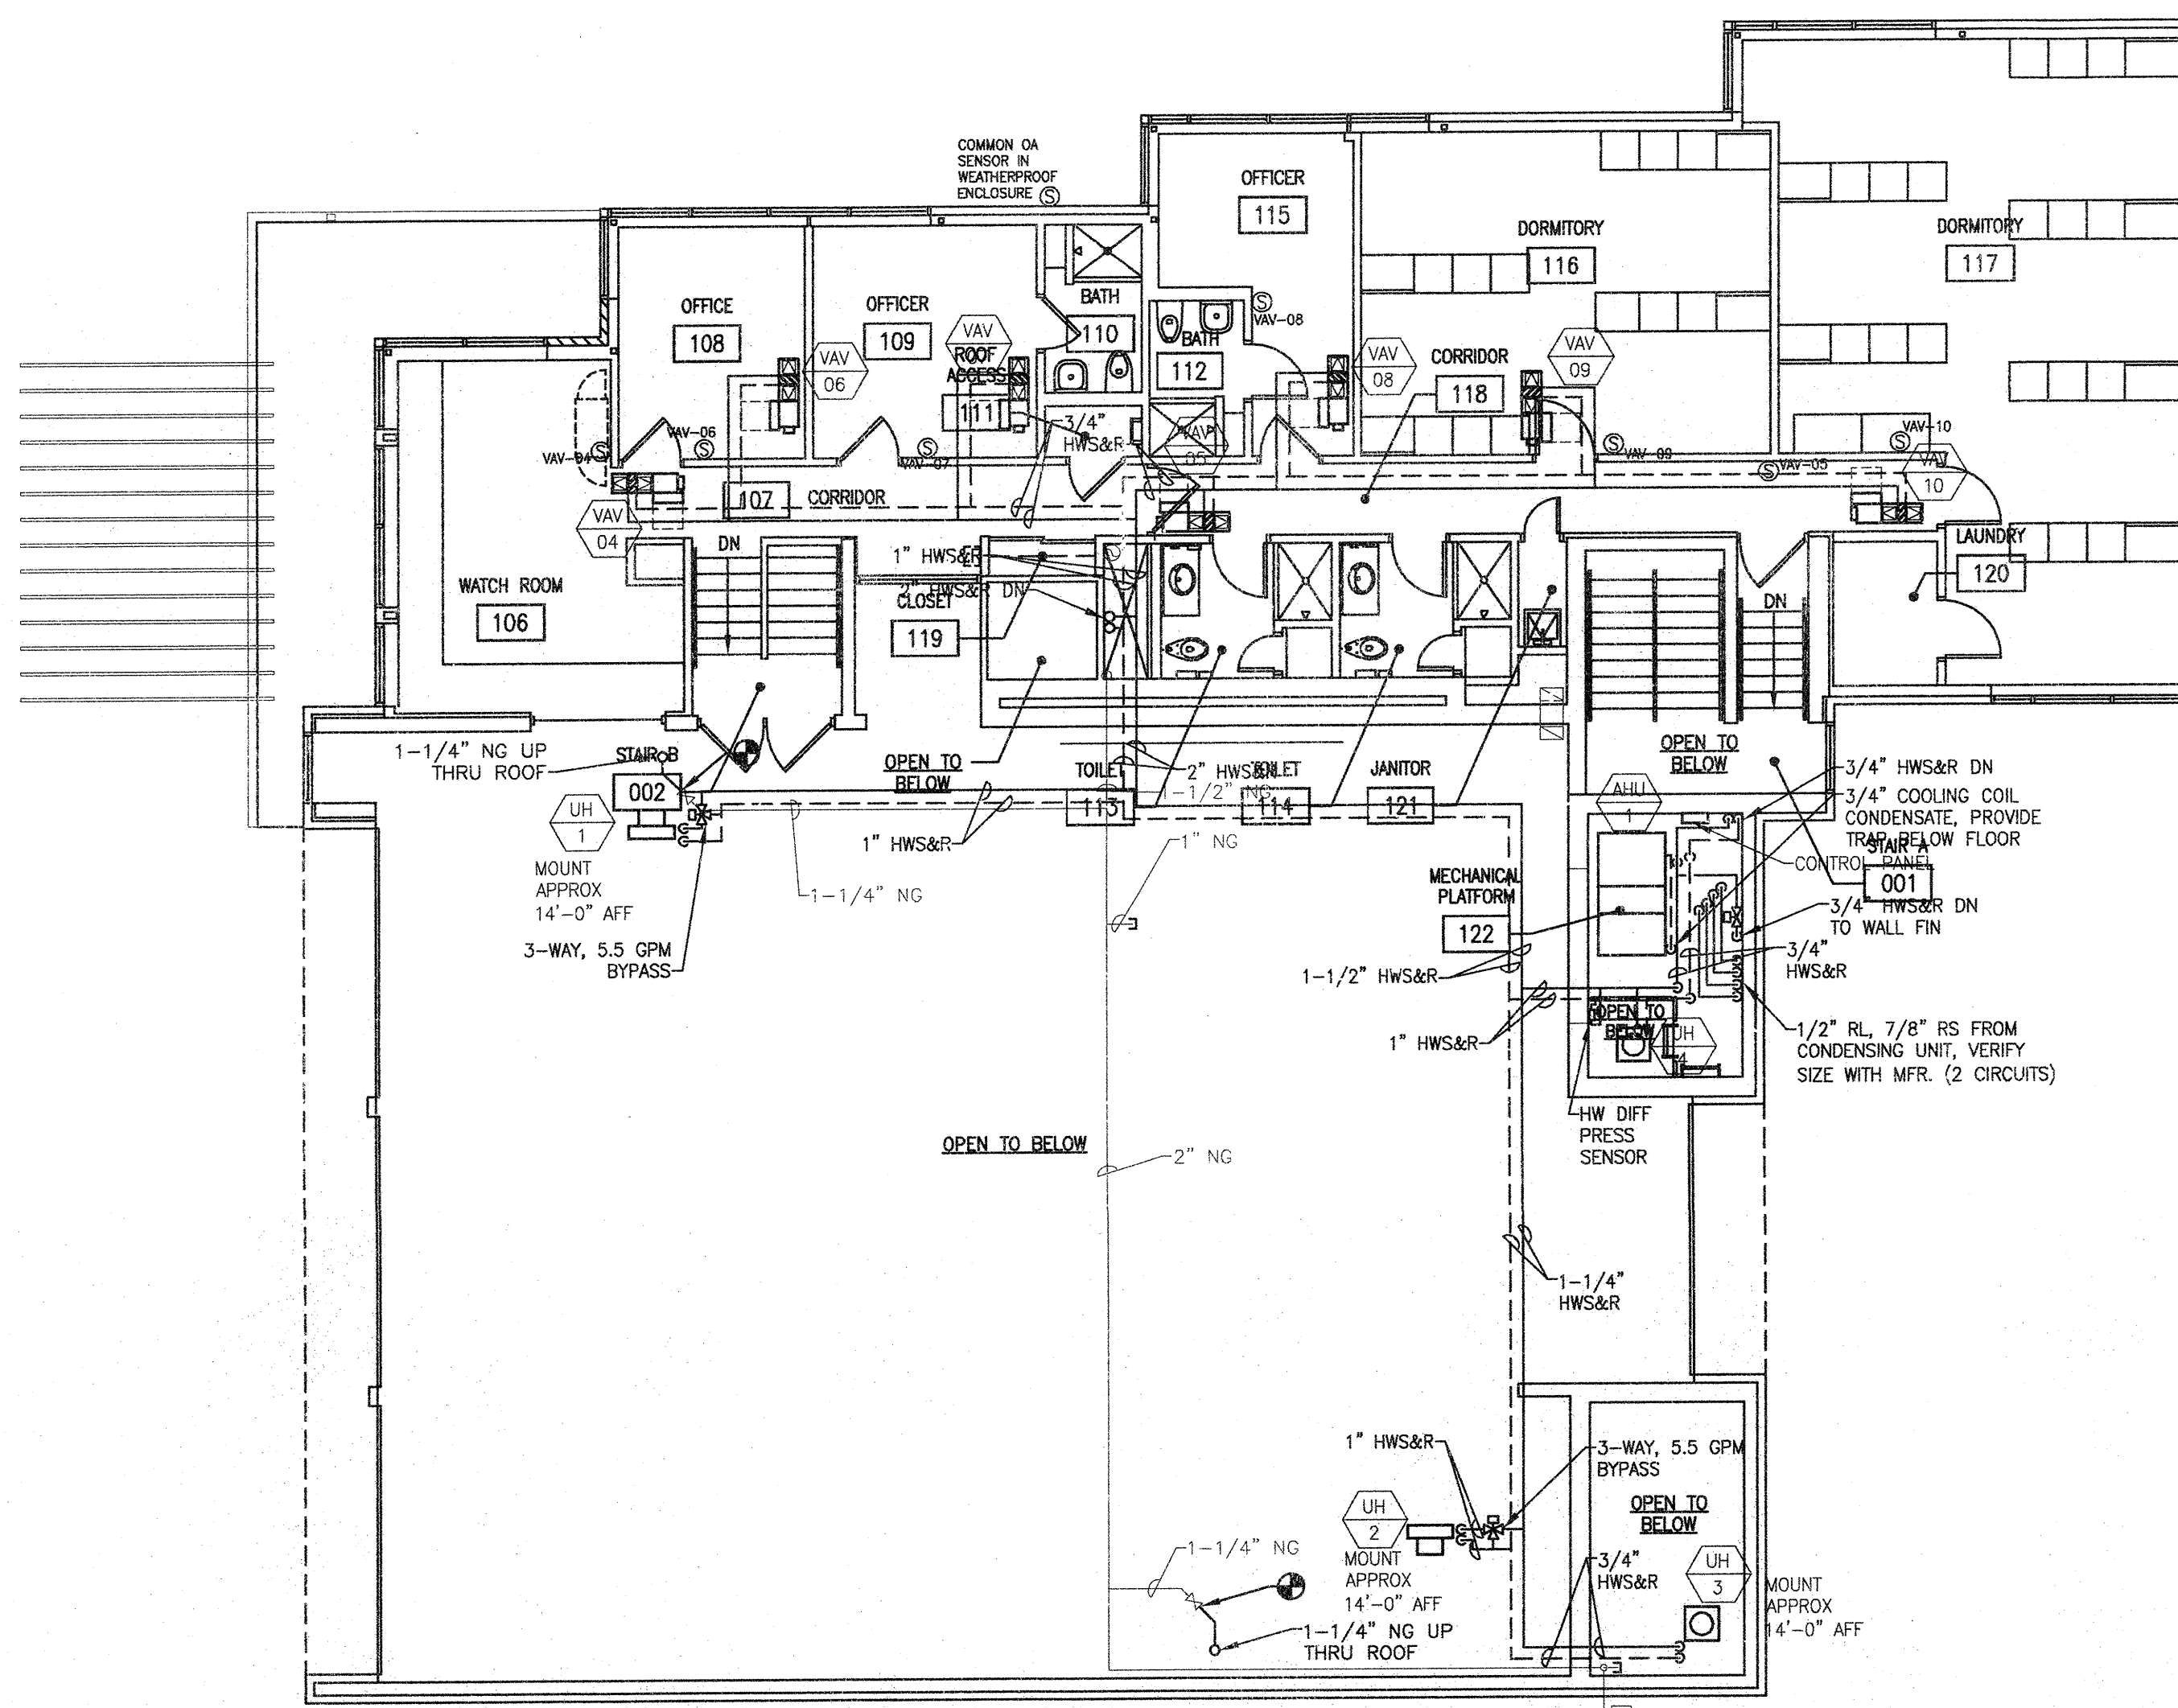

4 UPPER LEVEL HVAC PIPING PLAN
SCALE: 1/8" = 1'-0"

GENERAL NOTES

THIS BUILDING UTILIZES A RETURN AIR PLENUM. ALL MATERIALS INSTALLED ABOVE CEILING SHALL BE RATED FOR PLENUM USE. PIPE RUNOUTS TO EQUIPMENT ARE 3/4" UNLESS NOTED OTHERWISE.

DRAWING SET	OWNER REVIEW
COPYRIGHT	2012
FILE NAME	201109-M201.DWG
REVISIONS	
DRAWN	NJZ
CHECKED	BK
DATE	03-09-12
PROJECT NO.	2011009
PROJECT TITLE	

**CITY OF MADISON
FIRE STATION #2
ADDITION AND
REMODELING**

421 GRAND CANYON DRIVE
MADISON, WISCONSIN

SHEET TITLE

**MECHANICAL
REMODELING PLANS**

SHEET NO.
M201