



Madison, Wisconsin

CITY OF MADISON

CITY ENGINEERING DIVISION

DEPARTMENT OF PUBLIC WORKS

PLAN OF PROPOSED IMPROVEMENT

BIKEWAYS 2023

INDEX OF SHEETS


SHEET NO.	D1	NOTES AND DETAILS
SHEET NO.	D2	UW TREE PROTECTION DETAIL
SHEET NO.	EC1	EROSION CONTROL PLAN STREET
SHEET NO.	P1-P3A	PLAN & PROFILES
SHEET NO.	U1-U2	UTILITY PLAN & PROFILES
SHEET NO.	USTM	STORM SEWER SCHEDULE
SHEET NO.	M1-M8	PAVEMENT MARKING PLANS
SHEET NO.	X1-X2	CROSS SECTIONS
SHEET NO.	MN1	MAINTENANCE PLAN (CITY USE ONLY)

CITY PROJECT NO. 14336
CONTRACT NO. 8696

EARTHWORK SUMMARY:
EXCAVATION CUT (MEASURED PLAN QUANTITY)..... 422 CY
ESTIMATED UNDISTRIBUTED UNDERCUT..... 180 CY
TOTAL UNCLASSIFIED EXCAVATION CUT.....602 CY

REVISION #2- 7/11/2024
REVISED THE
FOLLOWING:
SHEET P-1
SHEETS U-1, U-STM

REVISION #3- 8/20/2024
REVISED THE
FOLLOWING:
SHEET M-1

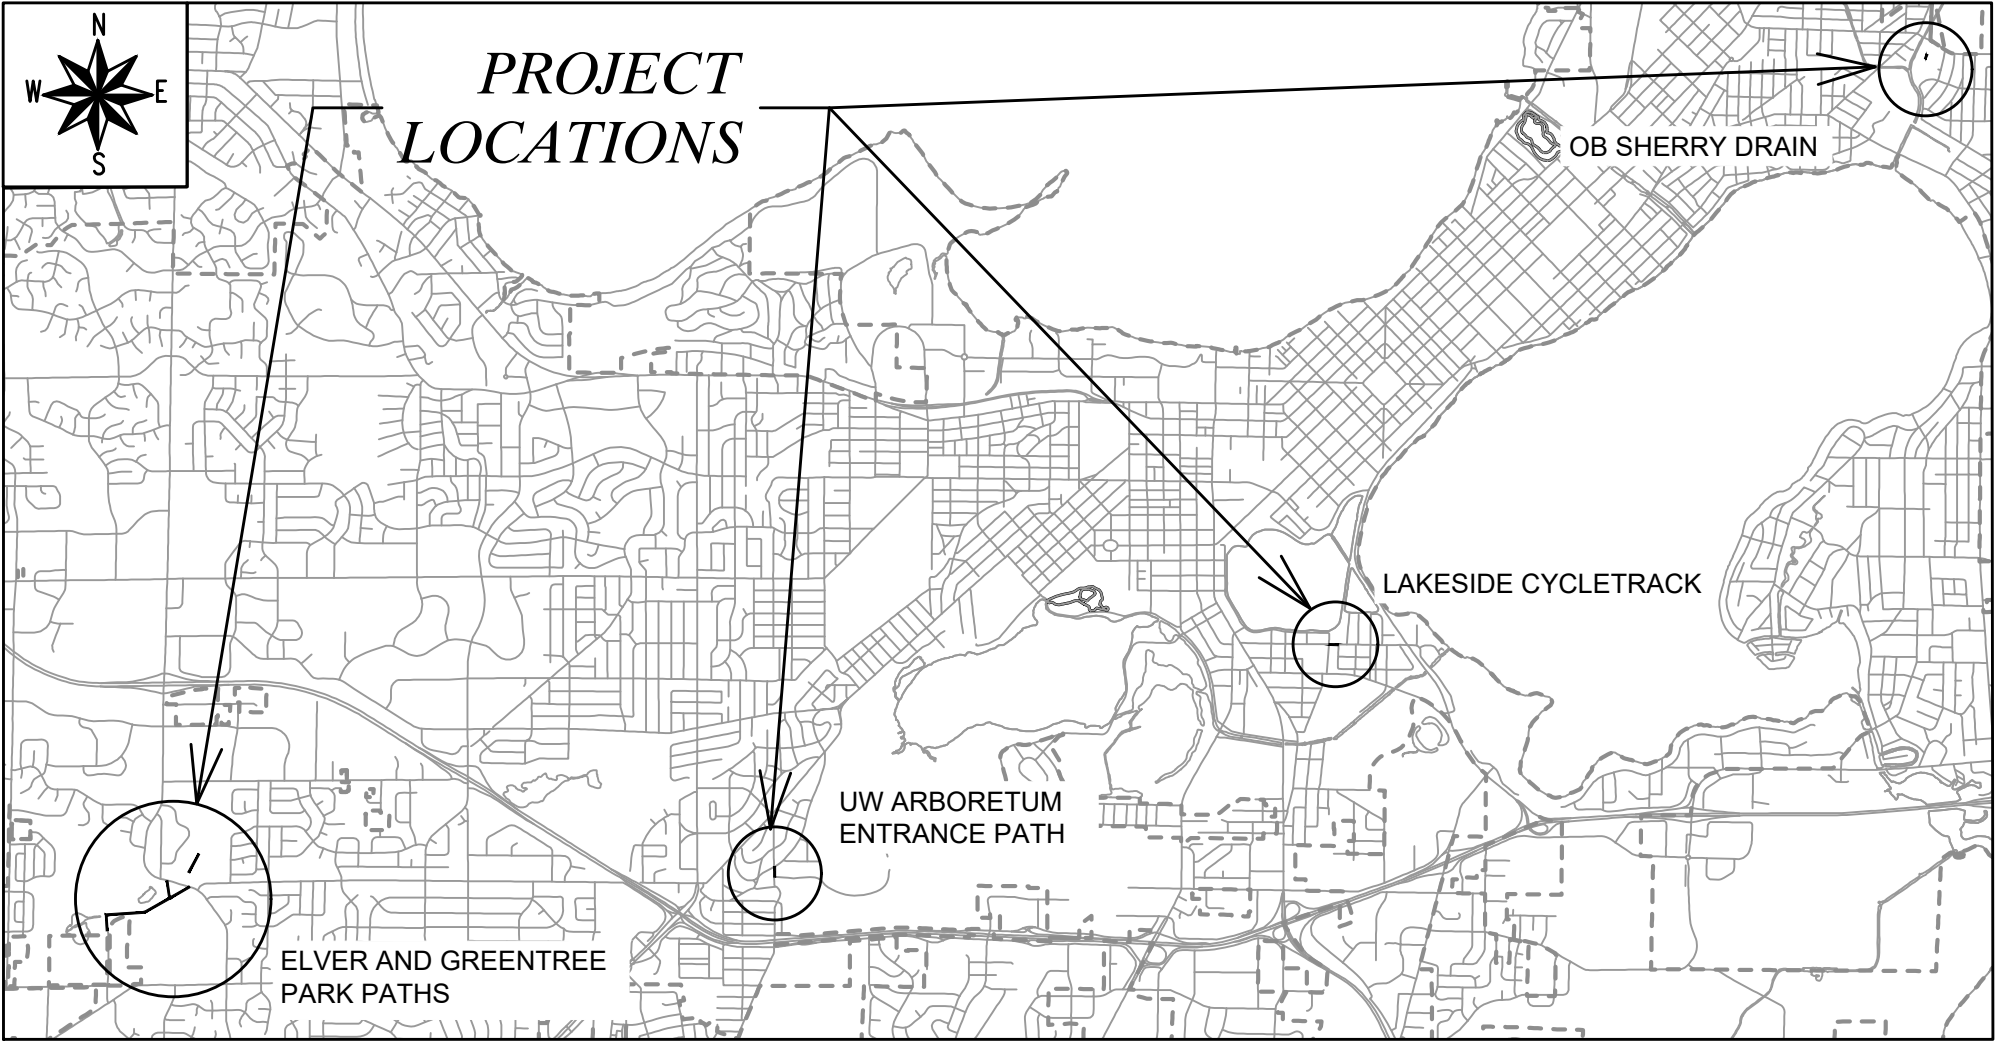

PUBLIC IMPROVEMENT PROJECT
APPROVED

JANUARY 9TH, 2024

BY THE COMMON COUNCIL
OF MADISON, WISCONSIN

PUBLIC IMPROVEMENT DESIGN
APPROVED BY:

[Signature] Jan 18, 2024

City Engineer Date

STREET
DESIGNED BY:




Jan 18, 2024

STORM SEWER
DESIGNED BY:



Jan 18, 2024

PAVEMENT MARKINGS
DESIGNED BY:

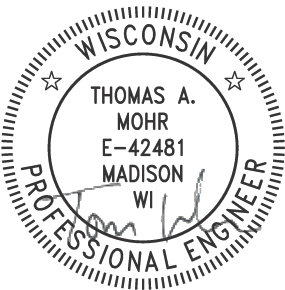

Jan 18, 2024


SANITARY SEWER
DESIGNED BY:




Jan 18, 2024

PLOT SCALE: 1 IN=1 FT_XREF
REV. DATE: 1/12/2024 12:29 PM
ORIGINATOR: CITY_OF_MADISON
FILE NAME: M:\DESIGN\Projects\14336\CAD\Streets\14336EN-TitleSheet.dwg

DATE: 1/12/2024 12:46 PM

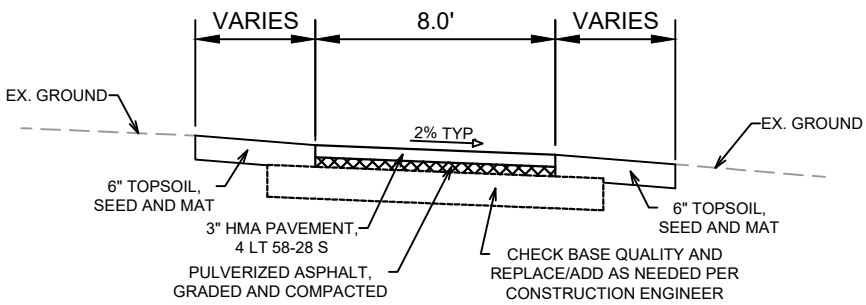

- ① POINT REFERRED TO ON PROFILE
- ② 2.00" HMA PAVEMENT, TYPE 4 LT 58-28 S (UPPER LAYER).
- ③ 3.50" HMA PAVEMENT, TYPE 3 LT 58-28 S (LOWER LAYER).
- ④ MODIFIED TYPE 'H' CURB & GUTTER, SEE DETAIL THIS SHEET
- ⑤ 5" CONCRETE TERRACE
- ⑥ 7" CONCRETE CYCLETRACK WITH SAWED JOINTS
- ⑦ 2" MILL & OVERLAY
- ⑧ 6" GRADATION 2 CRUSHED AGGREGATE BASE COURSE
- ⑨ 6" GRADATION 1 CRUSHED AGGREGATE BASE COURSE
- ⑩ FILL INCIDENTAL TO CURB AND GUTTER INSTALLATION
- ⑪ EXISTING TERRACE TO REMAIN. SELECT AREAS OF CONCRETE TERRACE AND DRIVEWAY TO BE REPLACED AS SHOWN ON PLANS
- ⑫ SPOT REPLACE 5" CONCRETE SIDEWALK AS SHOWN ON PLANS
- ⑬ CONCRETE CURB AND GUTTER TYPE 'A' TO REMAIN

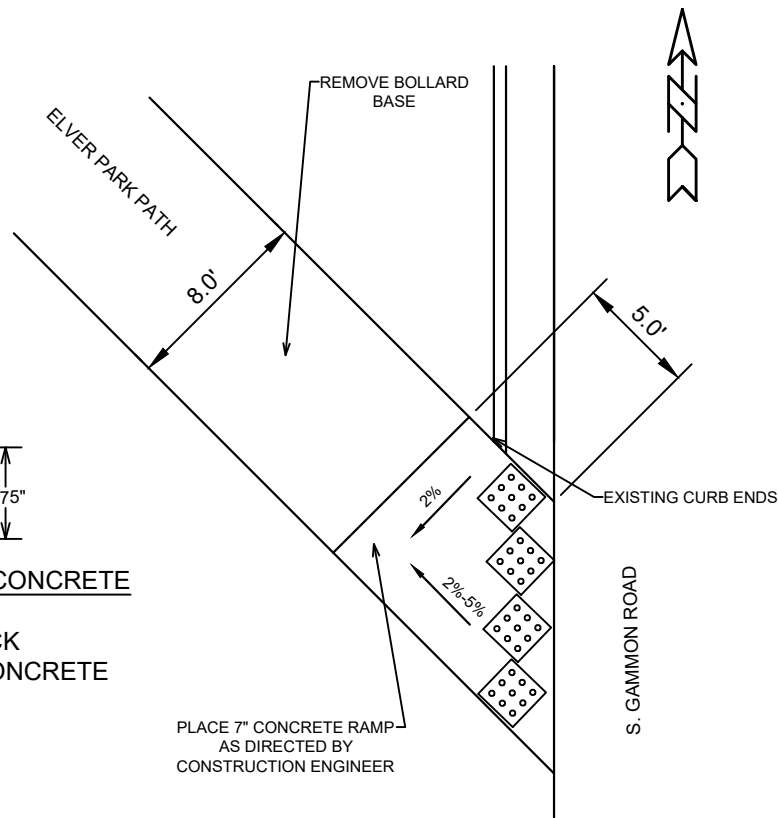


CONVENTIONAL SIGNS	
FIELD VERIFY ALL UTILITY LOCATIONS	
GAS	
STORM SEWER	
SANITARY SEWER	
WATER	
BURIED ELECTRIC	
OVERHEAD ELECTRIC	
POWER POLE	
ADA COMPLIANT RAMP W/ DETECTABLE WARNING FIELD	
COMBUSTIBLE FLUIDS	

MODIFIED TYPE 'H' CONCRETE
CURB AND GUTTER
LAKESIDE CYCLETRACK
SEE SHEET P-1

MODIFIED TYPE 'H' PEDESTRIAN CONCRETE
CURB AND GUTTER
LAKESIDE CYCLETRACK
PAY AS MODIFIED TYPE 'H' CONCRETE
CURB AND GUTTER
SEE SHEET P-1

MODIFIED TYPE 'H' DRIVEWAY CONCRETE
CURB AND GUTTER
LAKESIDE CYCLETRACK
PAY AS MODIFIED TYPE 'H' CONCRETE
CURB AND GUTTER
SEE SHEET P-1

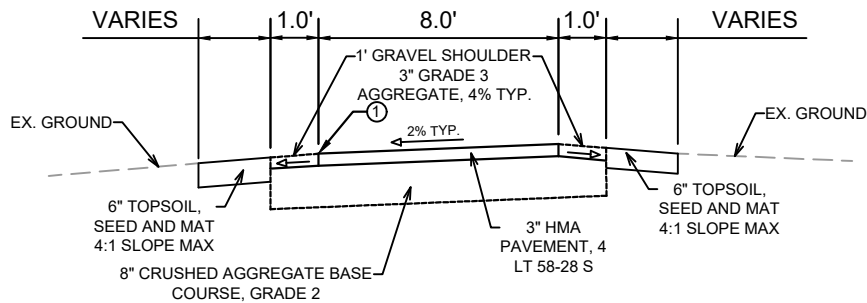

PATH TYPICAL SECTION
UW ARBORETUM ENTRANCE PATH
FACING NORTH
SEE SHEET P-2

NOTES:


ALL GUTTERS SHALL DRAIN WITH A MINIMUM GRADE OF 0.50% TOWARD STORM SEWER INLETS.

SIDEWALK RAMPS SHALL HAVE A MAXIMUM SLOPE OF 1" PER 12". SIDEWALK AND CURB RAMPS SHALL BE CONSTRUCTED WITH A SIDE SLOPE OF 2.00%. SIDEWALK SHALL HAVE A MINIMUM LONGITUDINAL SLOPE OF 0.50% AND A MAXIMUM LONGITUDINAL SLOPE OF 5.00% EXCEPT WHERE STREET GRADES EXCEED 5.00%.


SPECIAL NOTES:

- TYPICAL SECTIONS NOT TO SCALE
- SEE X-SHEETS FOR CROSS SLOPES, EDGE OF PAVEMENT ELEVATIONS, & TOP OF CURB ELEVATIONS
- ALL CONTROL JOINTS SHALL BE SAWCUT AS DIRECTED BY THE CONSTRUCTION ENGINEER

[illegible]

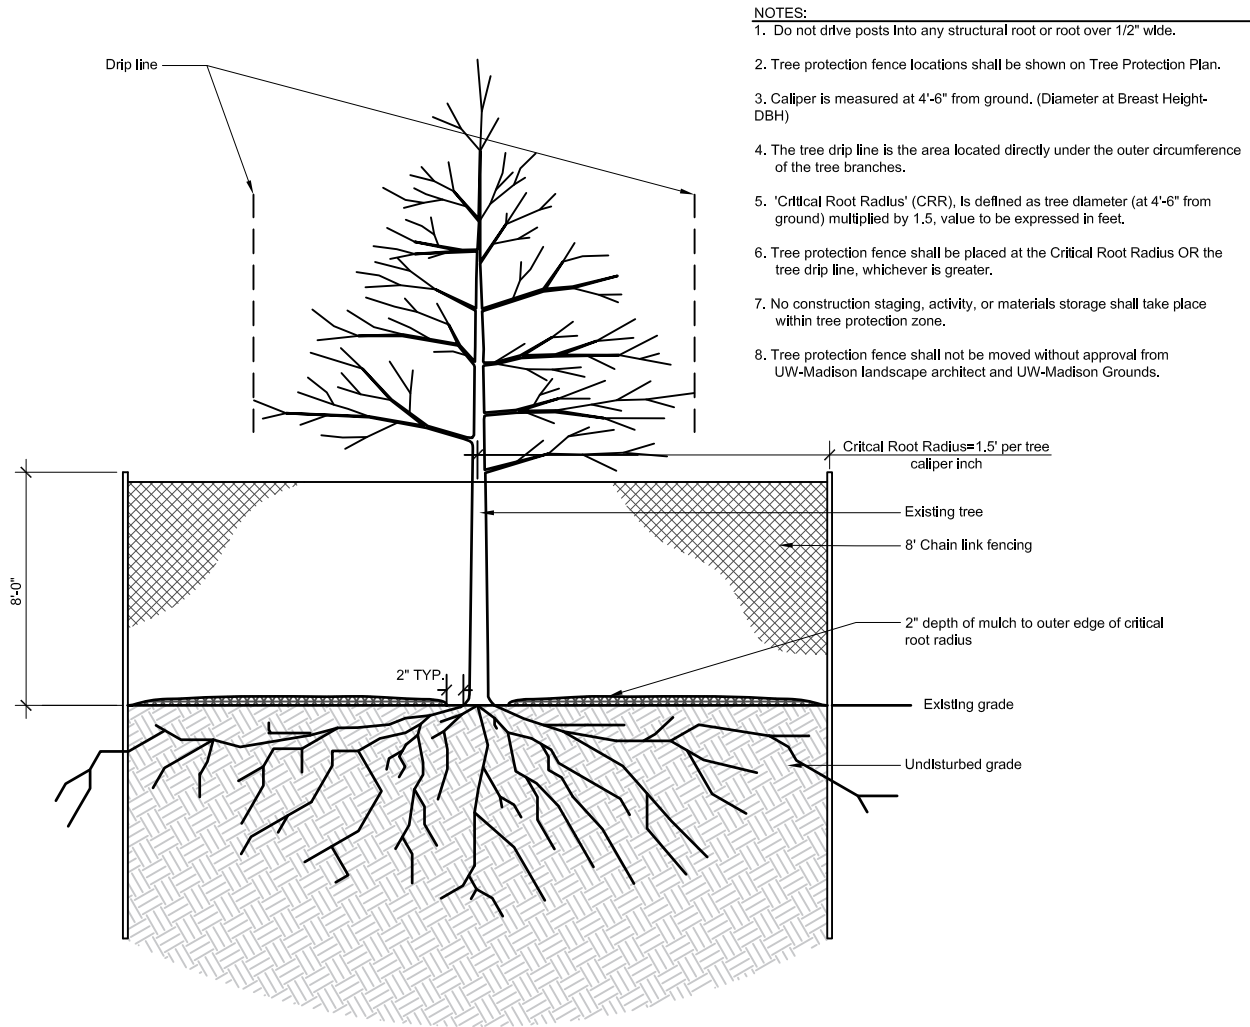

1
D-2 **TREE PROTECTION FENCE DETAIL**
SCALE: NOT TO SCALE


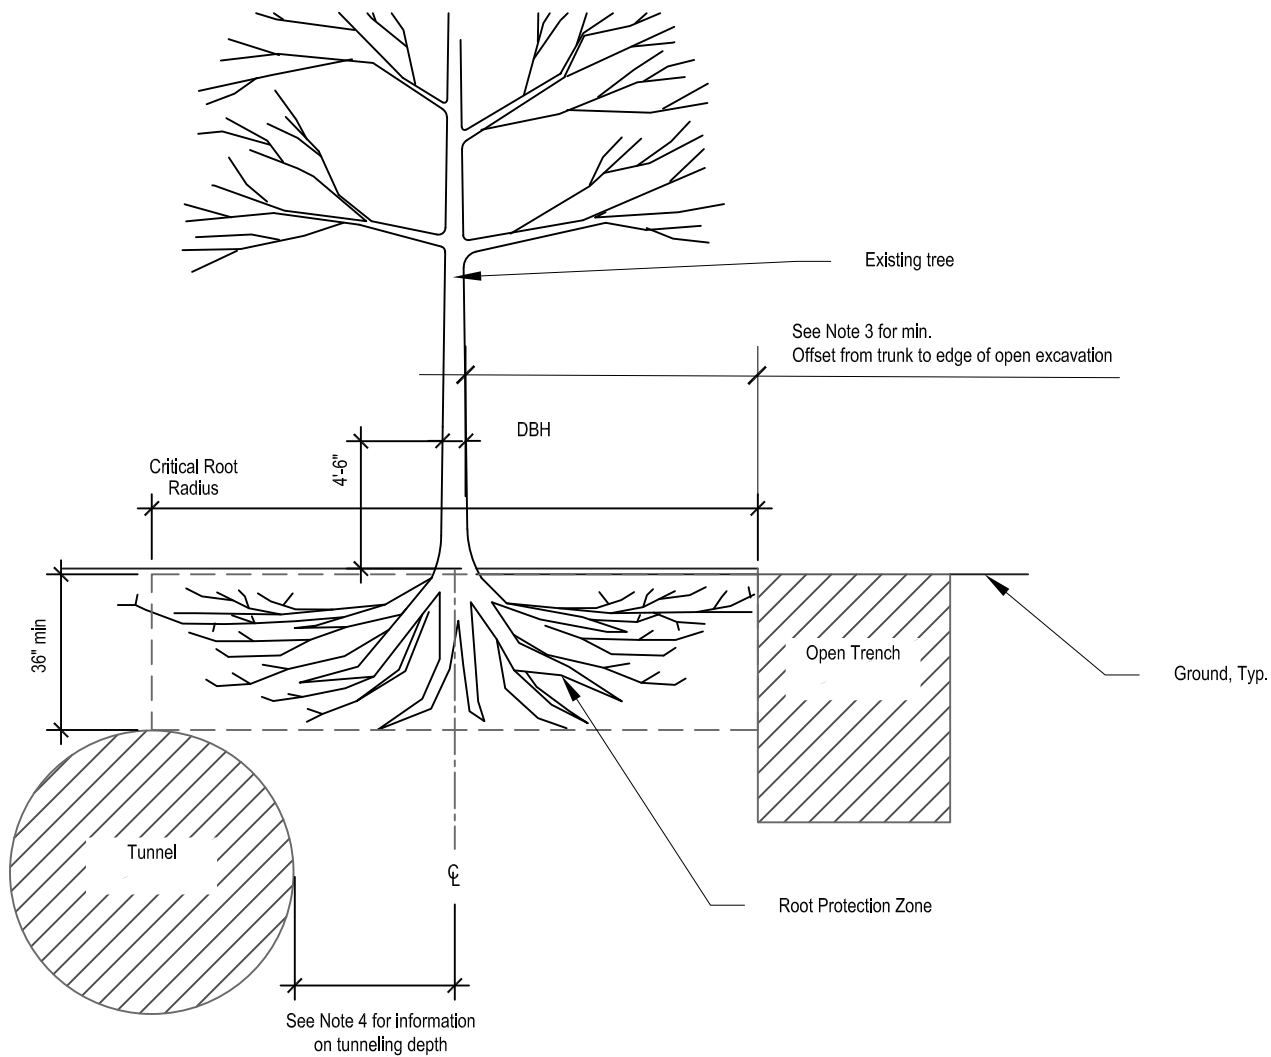


Tree diameter @ DBH	Min distance from tree trunk to open trench
Less than 6 inches	6-Feet
6-9 Inches	9-Feet
10-14 Inches	14-Feet
15-19 inches	19-Feet
More than 19 inches	Dia. @ DBH x 1-1.5 (Feet)

4. Tunnels within the CRR must be a minimum of 36" below surface grade and a minimum of 24" laterally away from trunk of tree.
5. Provide supplemental water for protected trees. 1" per week when no rainfall. Do not apply N-P-K fertilizers.

2
D-2 **TREE PROTECTION FENCE DETAIL**
SCALE: NOT TO SCALE

Project: Campus Standard Tree Protection			Details		
Drawing Title:					
Building Number:			File Location: L:\ACAD\PLANNING\Details, Title Blocks, Blocks\Details\Plants\Planting\PlantDetails_01.10.22.dwg		
Date: 10/05/2015					
Project Number:			Designed By: CPLA		
Drawn By: CPLA			Revision No.:		
Date:			By:		
1			06/30/2022		
Graphic Scale:					
North:			Sheet:		
			D-2		
			Of: 5		

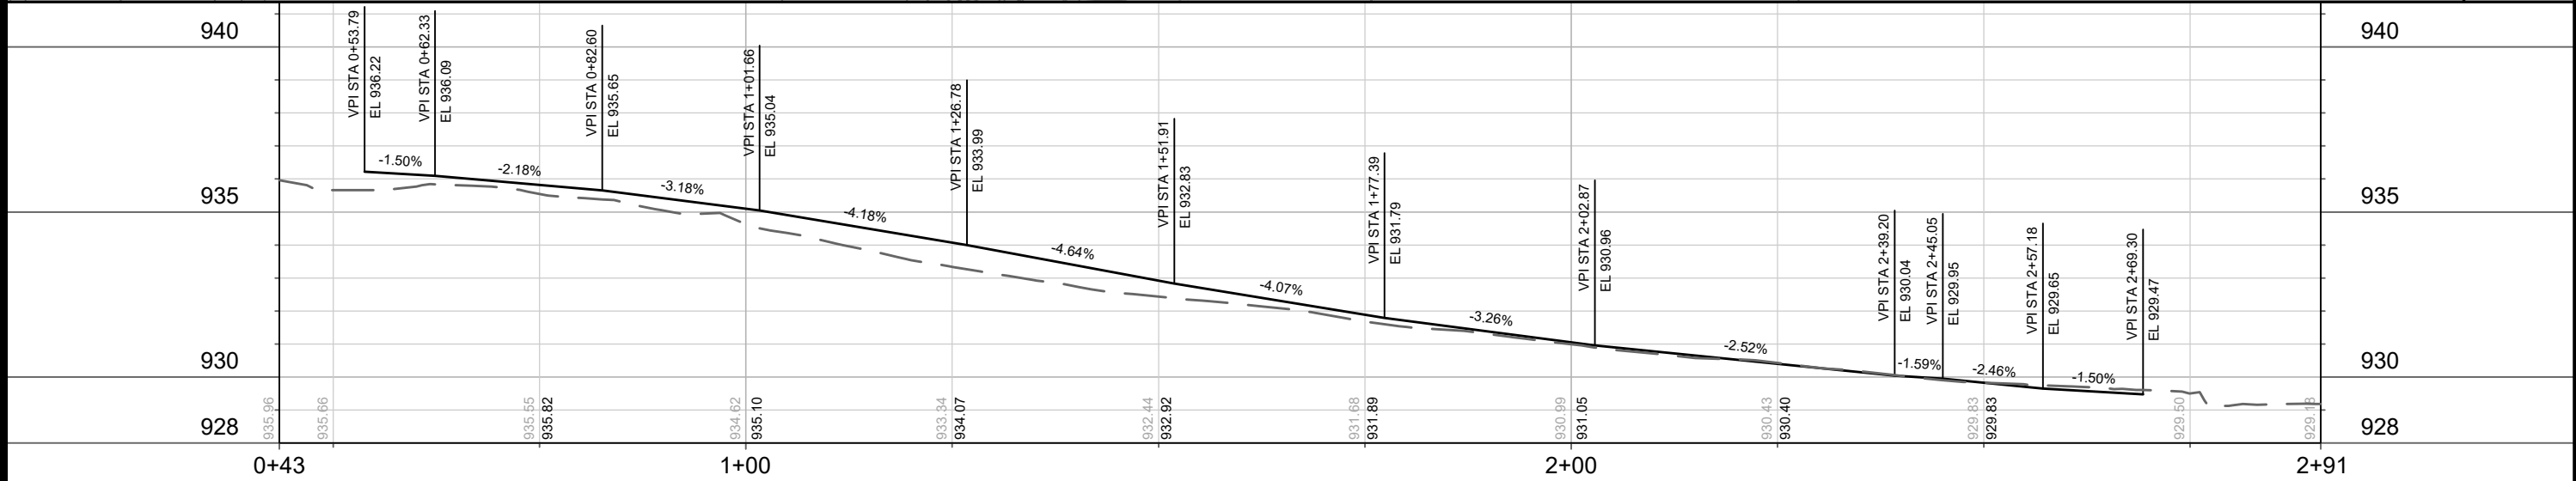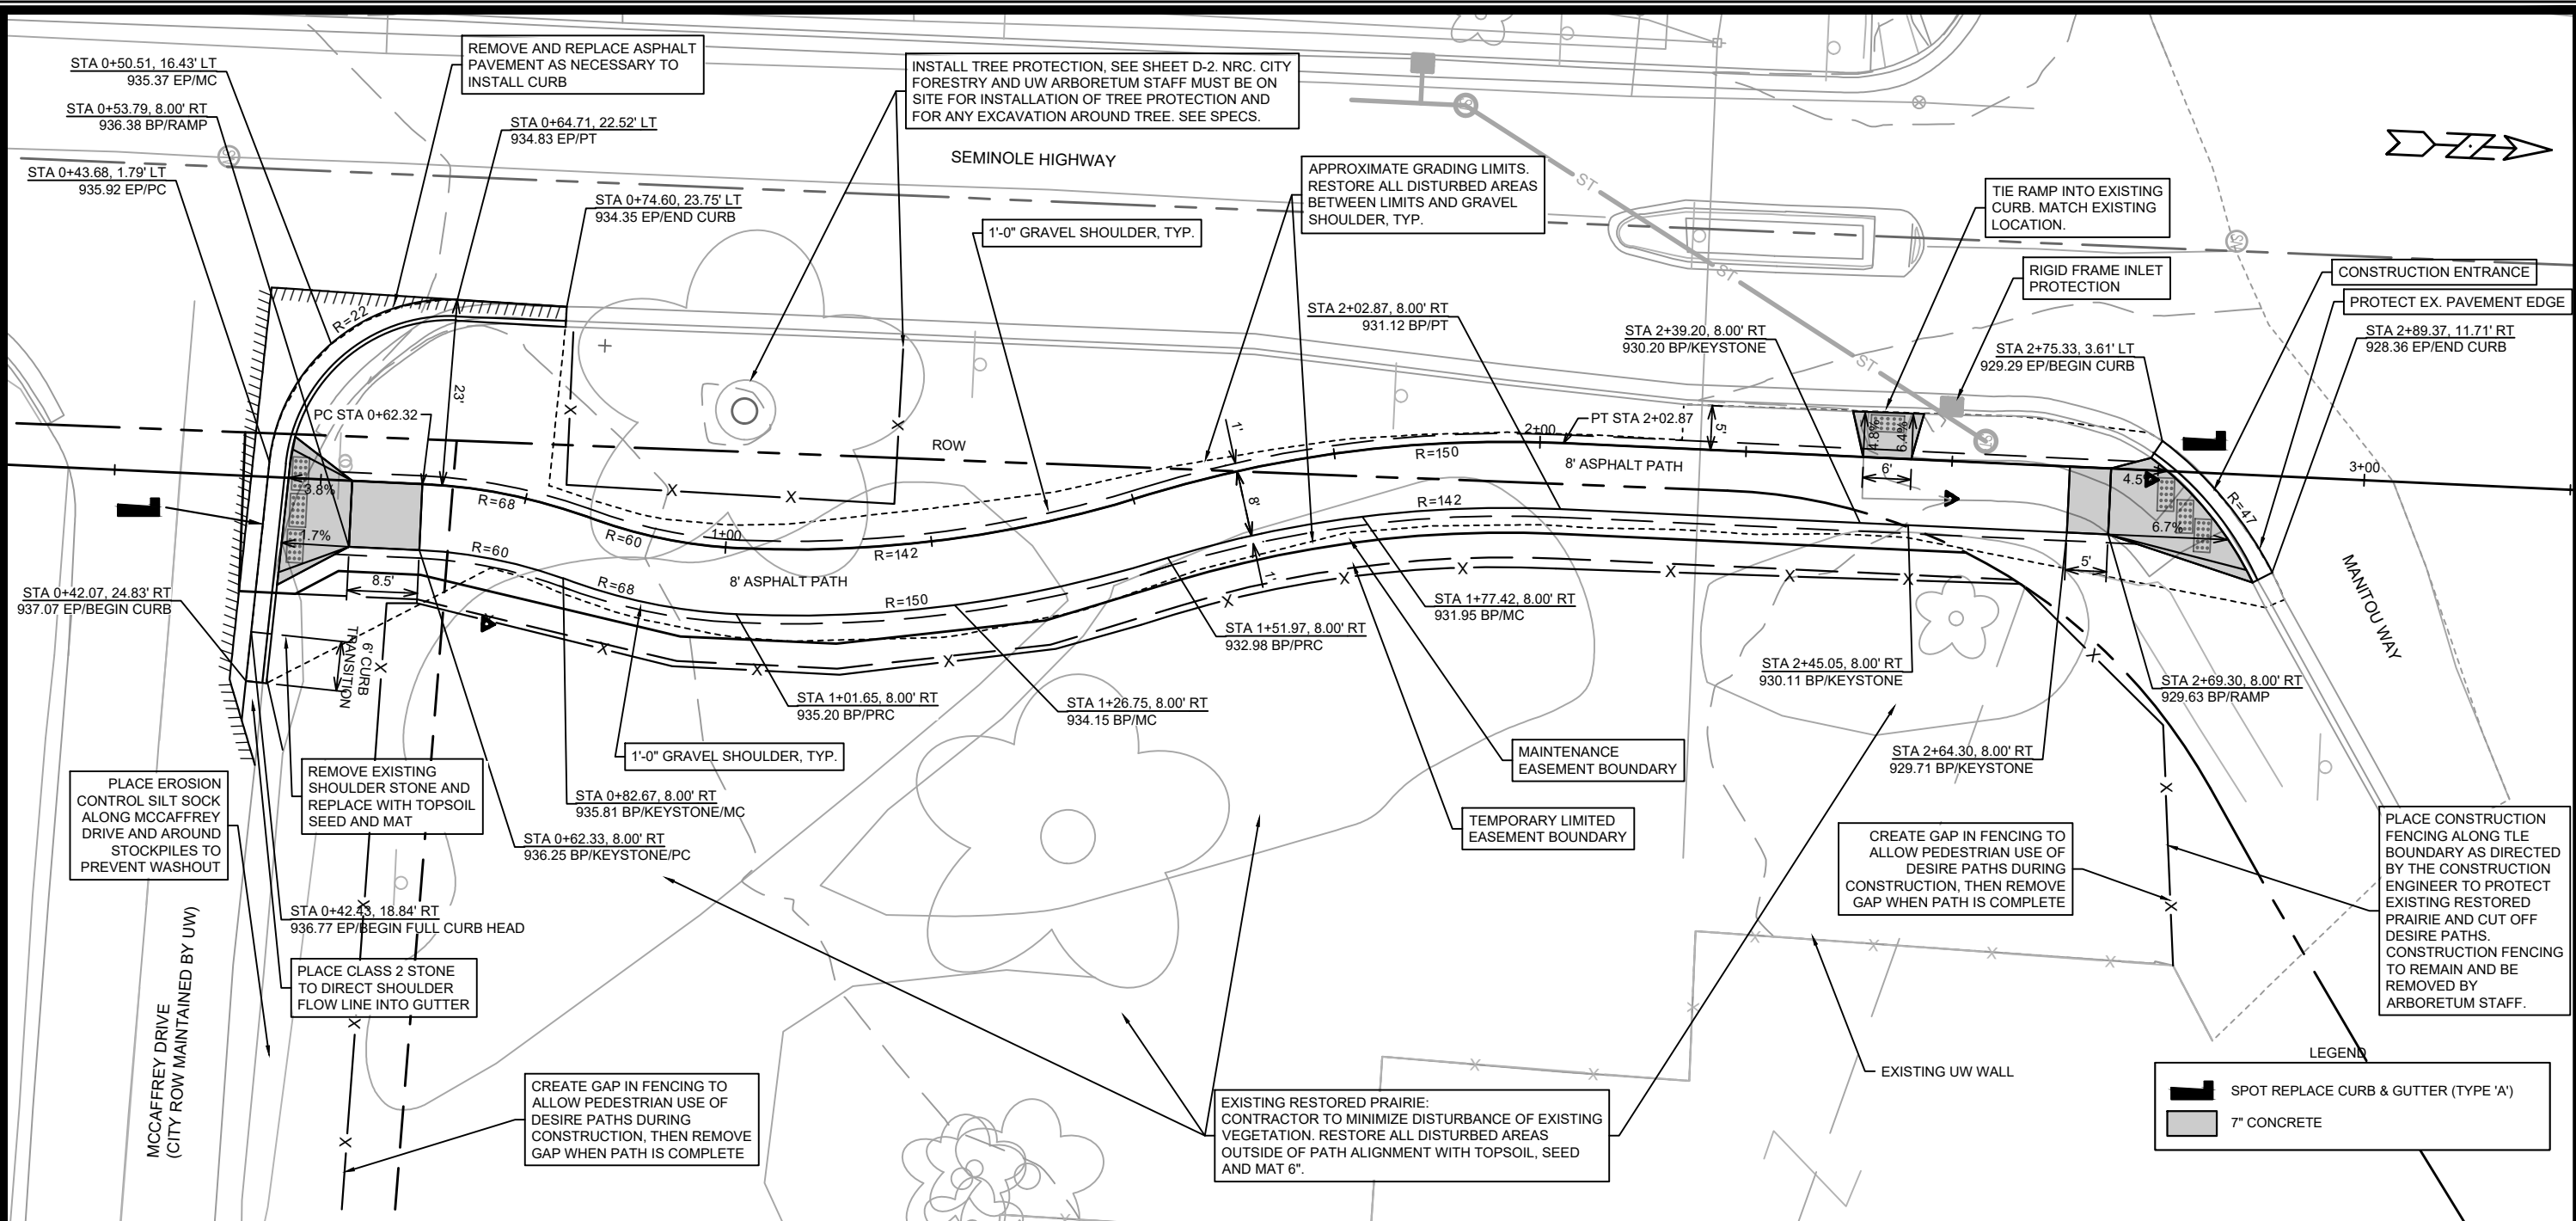

14336	MADISON, WI	8696	CONTRACT NO:
PLAN & PROFILE UW ARBORETUM ENTRANCE PATH			
BIKEWAYS 2023			
CITY OF MADISON WISCONSIN			
14336			
P-2			

M:\DESIGN\Projects\14336EN-PnP_UWArbEntrPath.dwg
Designed By: MFG
Date: 1/12/2024 12:47 PM
Scale: 1" = 20'
REVISION
DATE
BY
P-2




REMOVE BOLLARD BASE AND
PLACE CONCRETE SECTION WITH
DETECTABLE WARNING FIELD AT
GAMMON ROAD ENTRANCE. SEE
DETAIL #1 SHEET D-1

SLOPE PATH IN DIRECTION SHOWN, TYP.

SEE SHEET P-3A FOR GRADING AND
PLANS FOR THIS PATH SECTION


PROVIDE AT LEAST TWO (2) WEEKS' NOTICE TO
JACK BRODY, LANDFILL OPERATIONS MANAGER
JBRODY@CITYOFMADISON.COM (608) 267-9408
BEFORE COMMENCEMENT OF WORK AT THE
GREENTREE-CHAPEL HILLS PARK, WHICH
CONTAINS THE GREENTREE LANDFILL

	14336		P-3	
	BIKEWAYS 2023			
	ELVER AND GREENTREE PARK PATHS			
	MADISON, WI			
M:\DESIGN\Projects\14336\CAD\Streets\14336EN-Street_ElverPath.dwg		CONTRACT NO: 8696		P-3
				P-3
				P-3
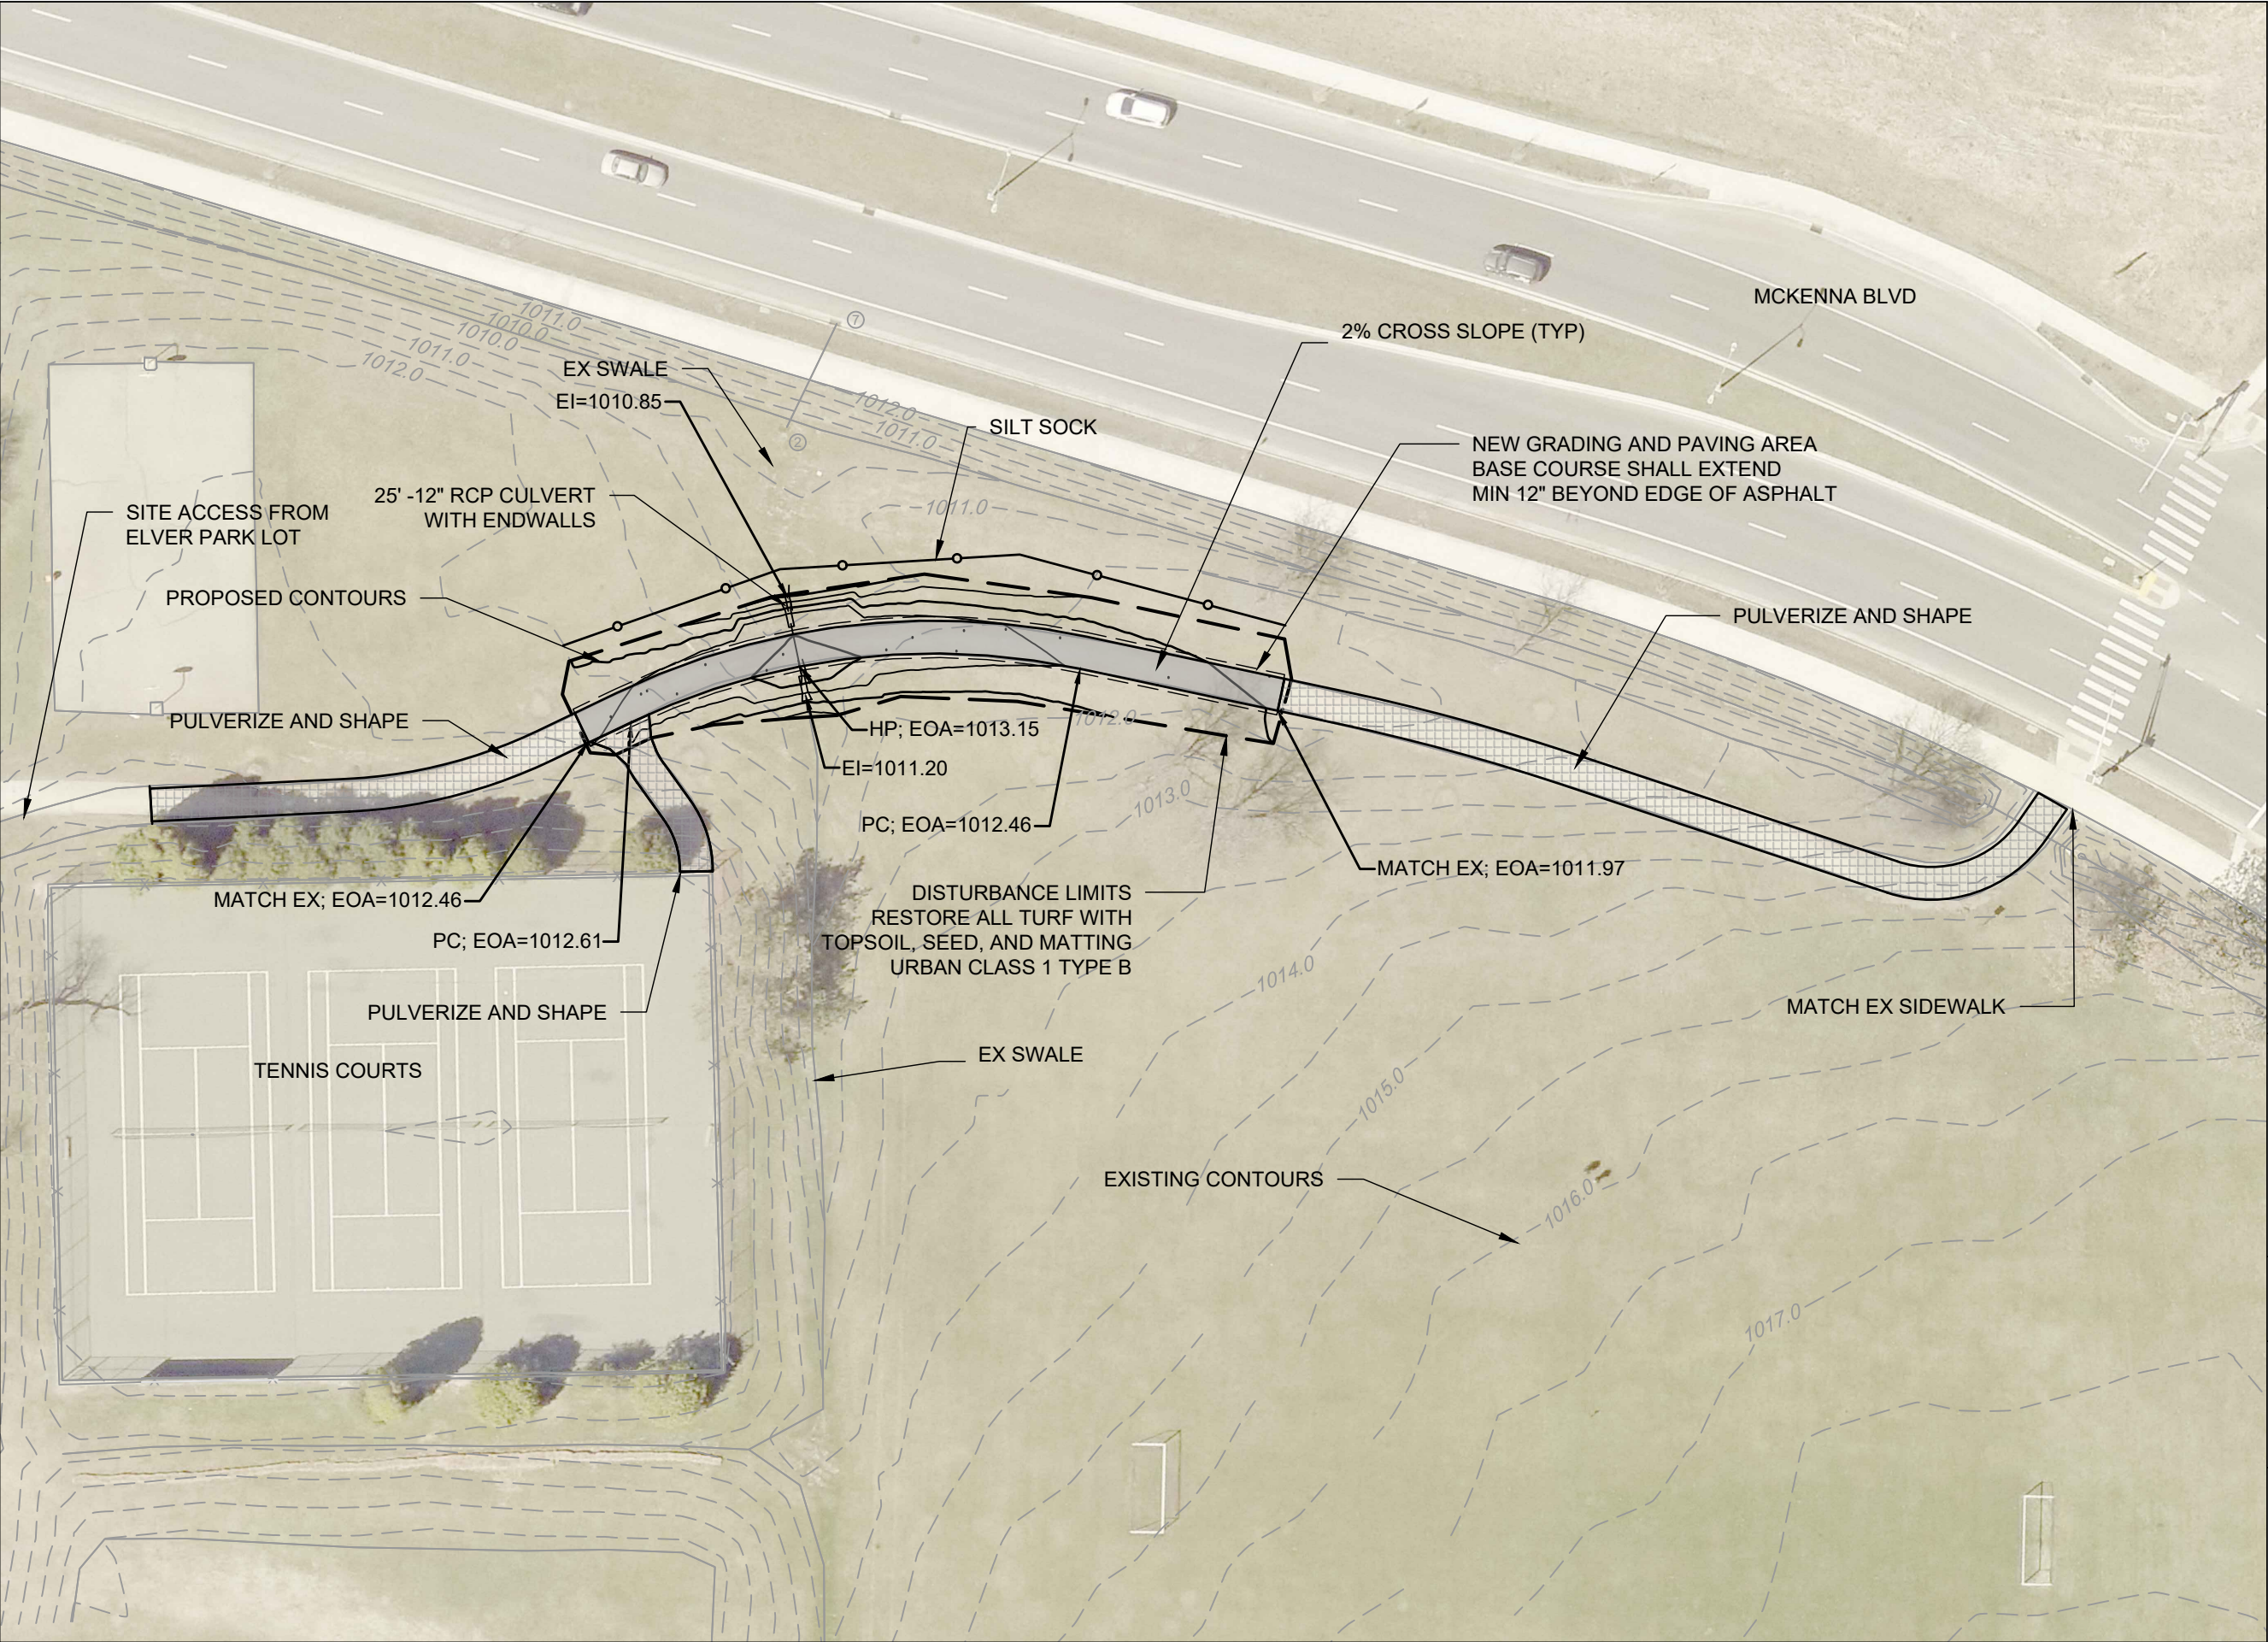

City of Madison
Department of Public Works
PARKS DIVISION
City-County Building, Suite 104
210 Martin Luther King, Jr. Blvd.
Madison, WI 53703

 play
MADISON
PARKS



PROJECT:

**BIKEWAYS
2023**

PROJECT ADDRESS:

**ELVER PARK
1250 MCKENNA BLVD
MADISON, WI 53719**

Although every effort has been made in preparing these plans and checking them for accuracy, the contractor and subcontractors must check all details and dimensions of their trade and be responsible for the same.

ITEM	DATE

PUBLIC WORKS PROJECT #:



14336

SHEET TITLE:

GRADING AND PAVING

SHEET NUMBER:

P-3A

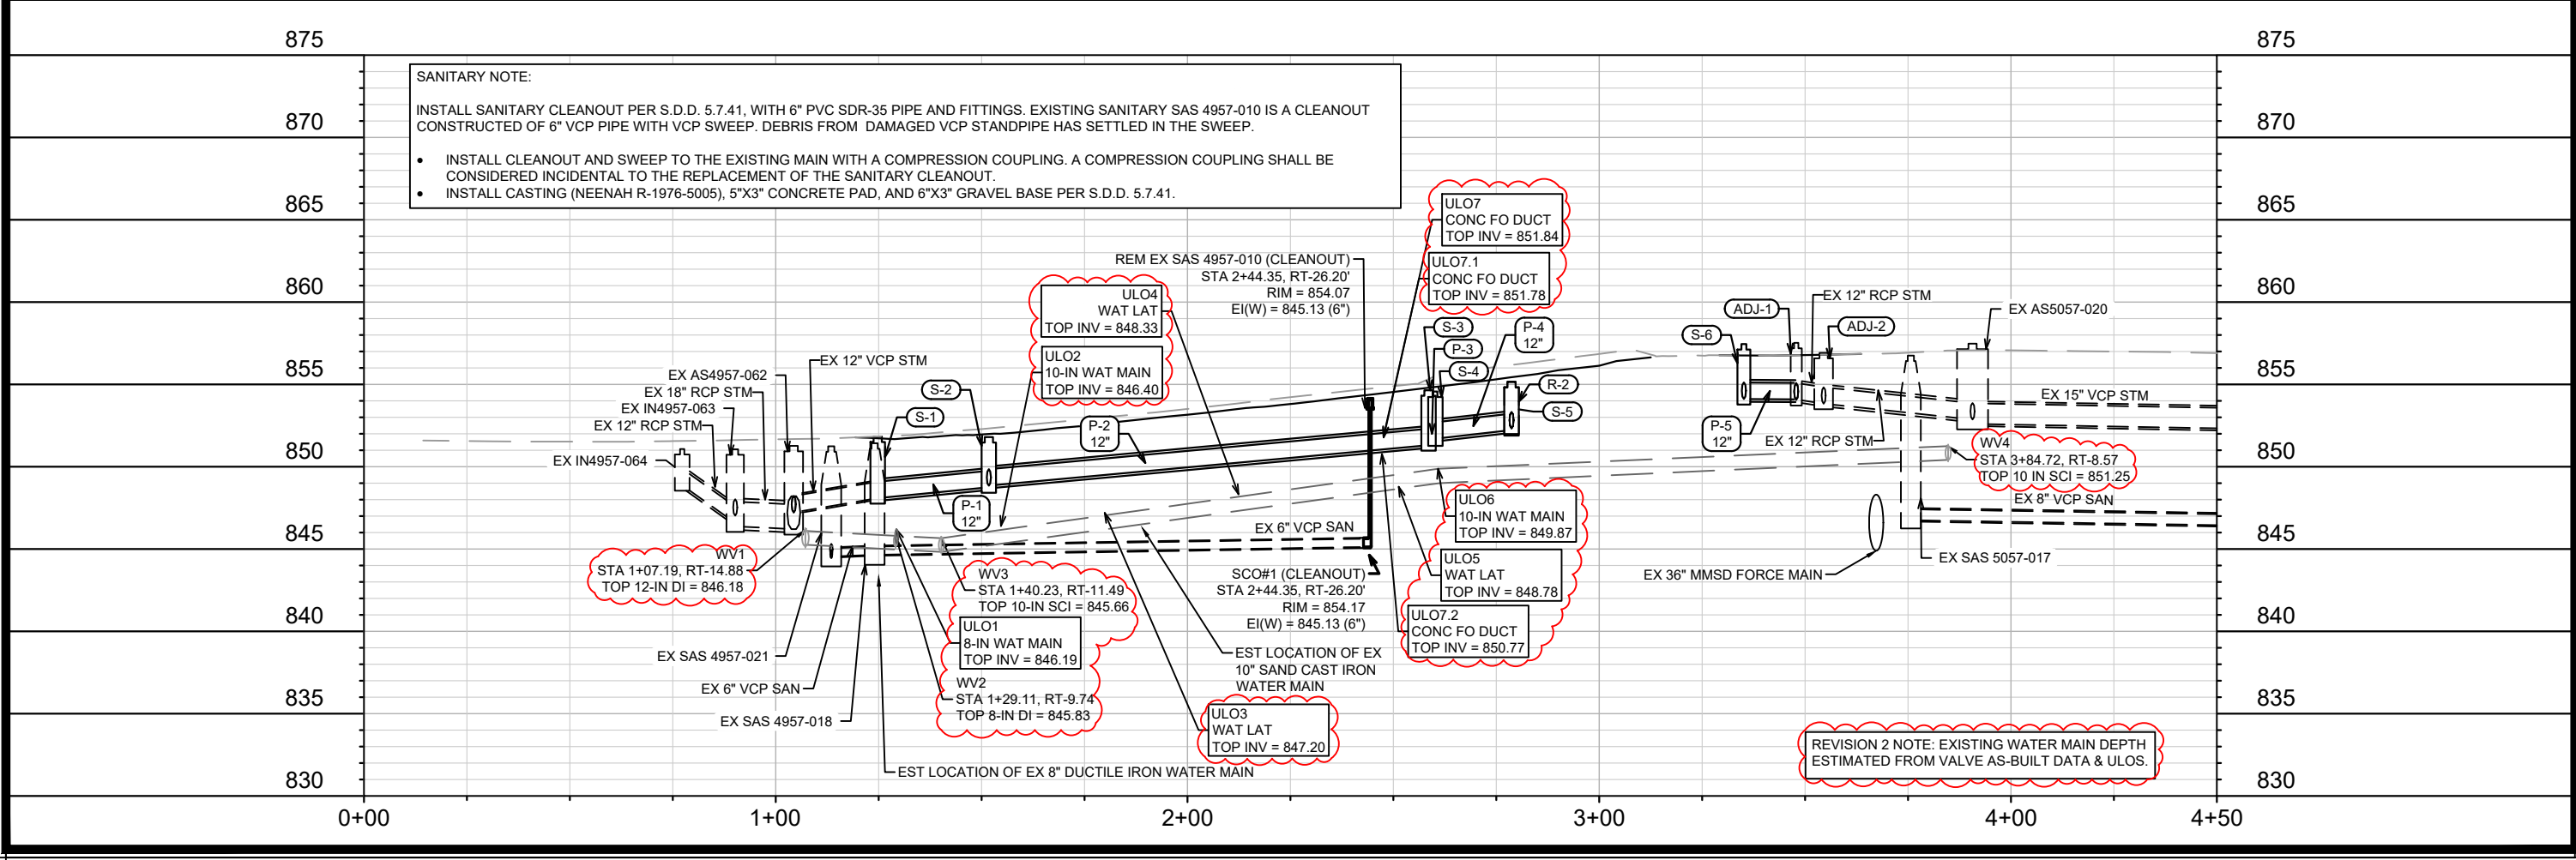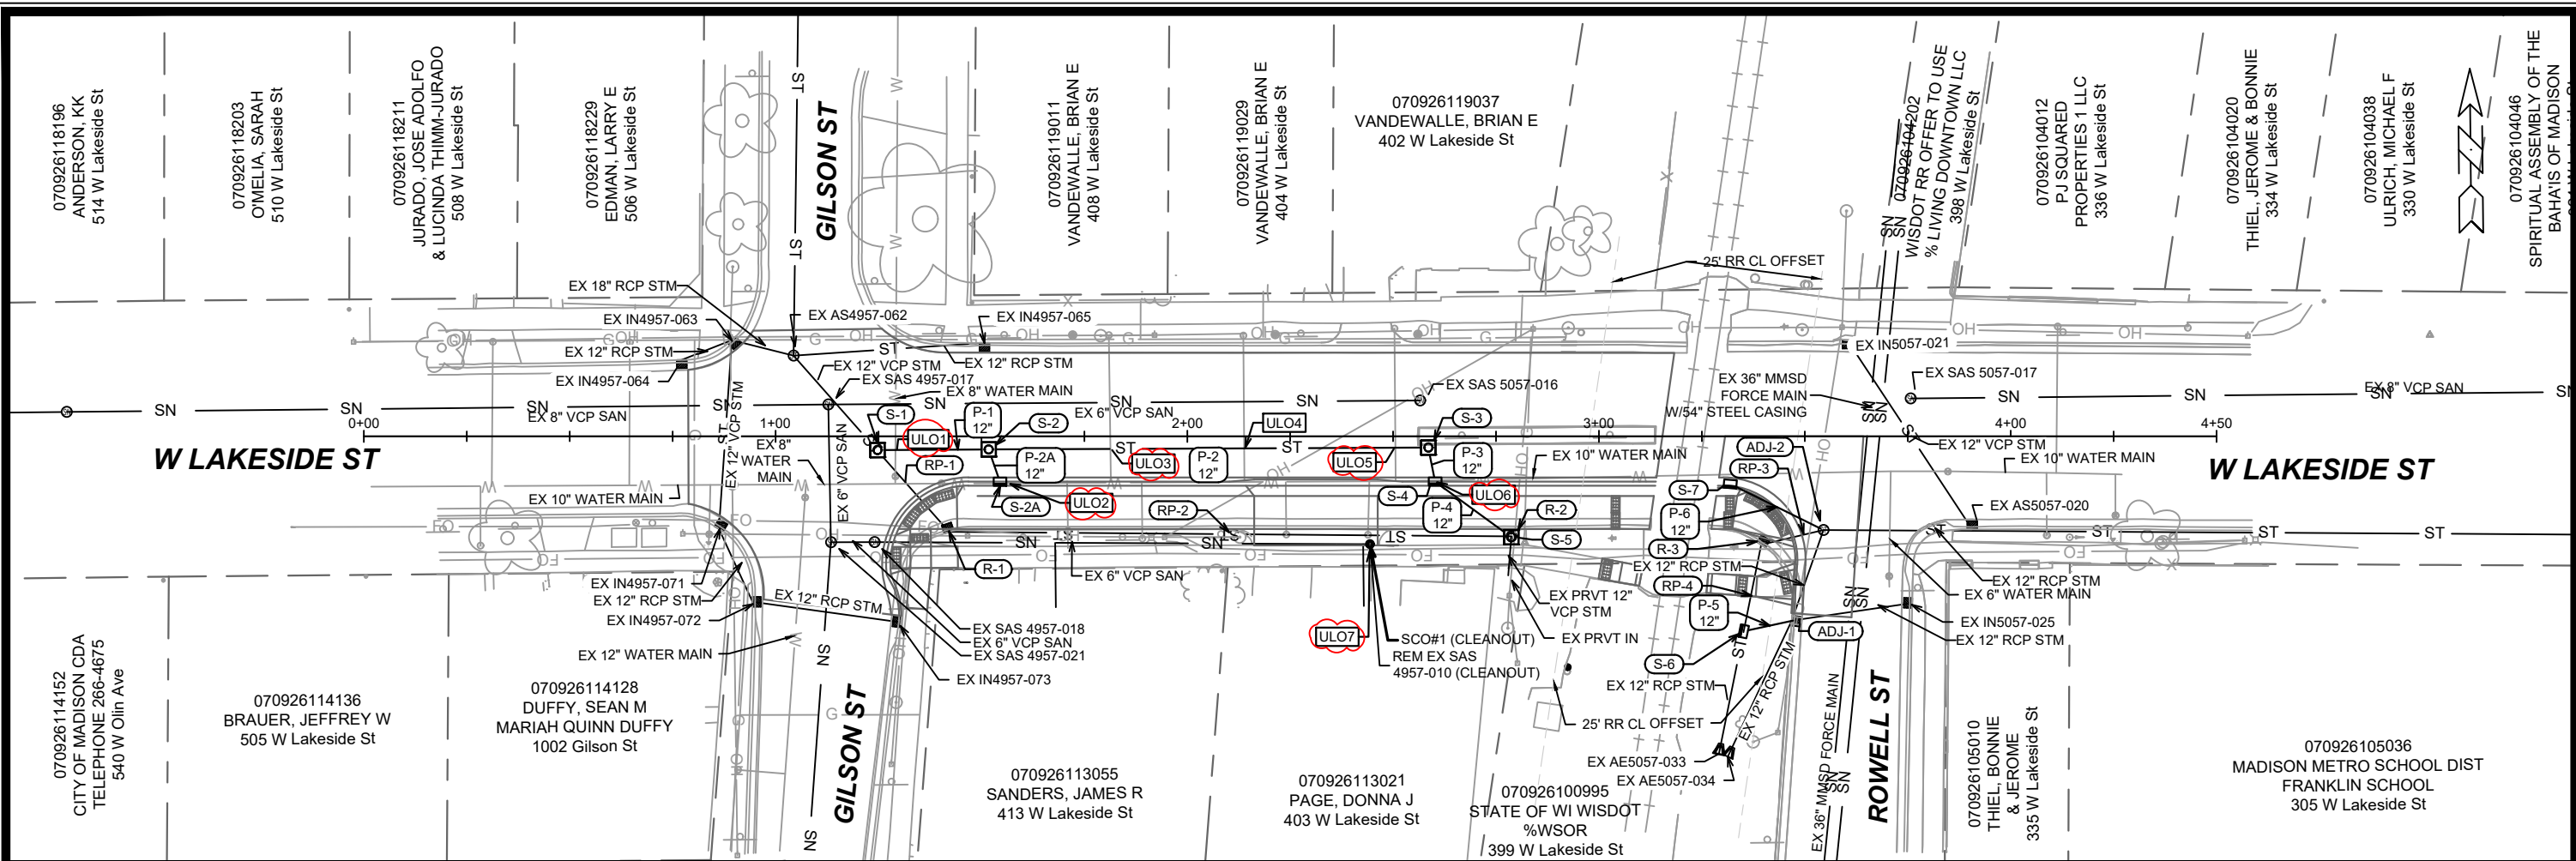

14336	Madison, WI	8696	U-1
CONTRACT NO:			
BIKEWAYS 2023			
M:\DESIGN\Projects\14336\CAD\Sewers\14336SWR-PnP.dwg			
CITY OF MADISON WISCONSIN			
14336			
U-1			

STORM & SANITARY SEWER SCHEDULE

* REVISION 2 - 7/11/2024 DAO

BIKEWAYS 2023 PROJECT NO. 14336	SHEET NO. U-2
STORM SEWER SCHEDULE	
W LAKESIDE ST	CITY OF MADISON

PROPOSED STORM STRUCTURES

PROPOSED STORM PIPES

STRUC. NO.	STATION	LOC (OFFSET)	TYPE	TOC	E.I.	DEPTH (FT)	NOTES
<u>W LAKESIDE ST</u>							
S-1	1+24.75	RT-3.34	3X3 STORM SAS	851.84	848.09	3.75	W/R-1550-0054
S-2	1+51.76	RT-3.19	3X3 STORM SAS	851.87	848.75	3.12	FP; W/R-1550-0054
S-2A	1+54.51	RT-11.04	H INLET	851.84	849.34	2.50	FP; W/R-3067-7004-V; [1]
S-3	2+58.54	RT-2.73	3X3 STORM SAS	854.64	851.31	3.33	W/R-1550-0054
S-4	2+60.20	RT-11.00	H INLET	854.56	851.60	2.96	FP; W/R-3067-7004-V; [1]
S-5	2+78.70	RT-24.51	3X3 STORM SAS	855.12	852.23	2.89	FP; W/R-1550-0054; [2]
S-6	3+35.13	RT-47.37	H INLET	857.45	854.11	3.34	W/R-1878-A10G; [3]
S-7	3+31.87	RT-11.58	H INLET	857.16	853.95	3.21	LP; FP; W/R-3067-7004-VB

PIPE NO.	FROM (DNSTM)	TO (UPSTM)	DISCH. E.I.	INLET E.I.	PLAN (PAY) LGTH (FT)	PIPE LGTH (FT)	SLOPE (%)	PIPE SIZE	TYPE	NOTES
<u>W LAKESIDE ST</u>										
P-1	S-1	S-2	848.09	848.75	27	24	2.75%	12"	RCP	-
P-2A	S-2	S-2A	848.85	849.34	8	6	8.55%	12"	RCP	-
P-2	S-2	S-3	848.85	851.31	107	104	2.37%	12"	RCP	-
P-3	S-3	S-4	851.41	851.60	8	6	3.22%	12"	RCP	-
P-4	S-4	S-5	851.70	852.23	23	19	2.77%	12"	RCP	-
P-5	ADJ-1	S-6	854.09	854.11	13	12	0.17%	12"	RCP	-
P-6	ADJ-2	S-8	853.83	853.95	25	24	0.51%	12"	RCP	-

STORM STRUCTURE ADJUSTMENTS

STORM PIPE REMOVALS & ABANDONMENTS

STRUC. NO.	ID NO.	STATION	LOC (OFFSET)	EX TOC	PROP TOC	ADJ (FT)	NOTES
<u>W LAKESIDE ST</u>							
ADJ-1	IN5047-026	3+47.85	RT-44.79	857.53	857.53	0.00	[4]
ADJ-2	AS5057-027	3+54.51	RT-22.76	856.92	856.92	0.00	[5]

PIPE REM NO.	REMOVE FROM	REMOVE TO	LGTH (FT)	PAID (Y/N)	REM LGTH PAID (FT)	ABN LGTH (FT)	SLURRY (CY)	PIPE SIZE	PIPE TYPE	NOTES
<u>W LAKESIDE ST</u>										
RP-1	S-1	R-1	26	Y	26	0	0.0	12"	VCP	-
RP-2	R-1	R-2	137	Y	137	0	0.0	12"	VCP	-
RP-3	ADJ-2	R-3	15	Y	15	0	0.0	12"	RCP	-
RP-4	R-3	S-6	22	Y	22	0	0.0	12"	RCP	-

STORM STRUCTURE REMOVALS & ABANDONMENTS

ULO SCHEDULE

STRUC. NO.	ID NO.	STATION	LOC (OFFSET)	TYPE	DEPTH (FT)	NOTES
<u>W LAKESIDE ST</u>						
R-1	IN4957-031	1+41.58	RT-22.27	H INLET	3.07	-
R-2	AS5057-024	2+78.71	RT-24.31	3X3 STM SAS	2.85	-
R-3	IN5057-028	3+39.87	RT-25.42	H INLET	3.63	-

ID NO. (OFFSET)	STATION	LOCATION (OFFSET)	TYPE	NOTES
<u>W LAKESIDE ST</u>				
* ULO1	1+29.13	RT-3.43	8" WAT	TOP @ 846.19, NO CONFLICT
* ULO2	1+56.52	RT-11.40	10" WAT	TOP @ 846.40, NO CONFLICT
* ULO3	1+81.34	RT-3.06	WAT LAT	TOP @ 847.20, NO CONFLICT
* ULO4	2+13.82	RT-3.13	WAT LAT	TOP @ 848.33, NO CONFLICT
* ULO5	2+50.54	RT-2.77	WAT LAT	TOP @ 848.78, NO CONFLICT
* ULO6	2+60.21	RT-11.00	10" WAT	TOP @ 849.87, NO CONFLICT
* ULO7	2+44.36	RT-27.55	FO	CONC DUCT, TOP @ 851.84, BOT @ 850.77, NO CONFLICT

PROPOSED SANITARY STRUCTURES

SAS NO.	STATION	LOC (OFFSET)	TOC	E.I.	DEPTH (FT)	NOTES
<u>W LAKESIDE ST</u>						
SCO#1	2+44.35	RT-26.20	854.15	845.13	9.02	[6]

SANITARY STRUCTURE REMOVALS

STRUC ID NO.	STATION	LOC (OFFSET)	TOC	E.I.	DEPTH(FT)	NOTES
<u>W LAKESIDE ST</u>						
SAS 4957-010	2+44.35	RT-26.20	854.07	845.13	8.94	[7]

SPECIFIC NOTES:

- [1] CASTING LOCATED AT MODIFIED TYPE B CURB; CURB OPENING LOWERED 2" (11" CASTING HEIGHT)
- [2] RECONNECT EX 12" ON SOUTH SIDE; KEEP PRIVATE STORM ACTIVE
- [3] RECONNECT EX 12" RCP STM; KEEP AE5057-033 ACTIVE
- [4] TAP (T-5) NEW 12" RCP TO WEST SIDE OF EX INLET
- [5] TAP (T-7) NEW 12" RCP TO WEST SIDE OF EX STM SAS
- [6] INSTALL SANITARY CLEANOUT PER S.D.D. 5.7.41. COMPRESSION COUPLING SHALL BE INCIDENTAL TO THE COST OF THE CLEANOUT. REPLACMENT OF VERTICAL PIPE & CASTING ARE REQUIRED. SEE ALSO NOTE 7
- [7] EX SANITARY CLEANOUT CONSTRUCTED OF 6" VCP WITH VCP SWEEP. TV SHOWS DEBRIS, LIKELY FROM DAMAGED VERTICAL PIPE. REMOVE CASTING, VERTICAL CLEANOUT STANDPIPE & SWEEP, THEN REPLACE WITH NEW SWEEP & PVC STANDPIPE.

STANDARD NOTES:

- PLAN LENGTH (PAY LENGTH) IS FROM CENTER OF STRUCTURE TO CENTER OF STRUCTURE. PIPE LENGTH IS ACTUAL LENGTH OF PIPE FROM STRUCTURE WALL TO STRUCTURE WALL. SLOPE CALCULATED USING PIPE LENGTH.
- ALL FIELD POURED SAS STORM STRUCTURES SHALL BE CONSTRUCTED IN ACCORDANCE WITH STANDARD DETAIL DRAWING 5.7.3. ALL PRECAST SAS STORM STRUCTURES SHALL BE CONSTRUCTED IN ACCORDANCE WITH STANDARD DETAIL DRAWING 5.7.5.
- ALL REBAR FOR FIELD POURED STRUCTURES SHALL BE EPOXY COATED. ANY EXPOSED STEEL SHALL BE TOUCHED UP OR RECOATED PRIOR TO USE.
- APPROXIMATE DISCHARGE E.I. GIVEN, ADJUST E.I. AND PIPE SLOPE IN THE FIELD.
- TOP OF CASTING GRADE GIVEN IS THE TOP OF CURB FOR INLET STRUCTURES AND THE FLOWLINE OF THE CLOSED CASTING FOR SAS's.

- ABBREVIATIONS: AE = APRON ENDWALL; RCP = REINFORCED CONCRETE PIPE; HERCP = HORIZONTAL ELLIPTICAL REINFORCED CONCRETE PIPE; DNA = DOES NOT APPLY; SAS = SEWER ACCESS STRUCTURE; LP = LOW POINT INLET STRUCTURE; FP = FIELD POURED STRUCTURE; TR = TOP OF CONCRETE ROOF; NCM = NO CROWN MATCH FOR PIPES; UD = UNDERDRAIN
- ALL REINFORCED CONCRETE PIPES TO BE CLASS 3 UNLESS OTHERWISE NOTED.
- SURVEYOR TO CONFIRM THAT ALL INLET STATION / OFFSETS LINE UP WITH PROPOSED CURB AND GUTTER.
- ALL STRUCTURES CALLED OUT AS FIELD POURED SHALL BE FIELD POURED. ALL OTHER STRUCTURES (NOT INDICATED AS FIELD POURED) SHALL BE SUBMITTED TO CITY ENGINEERING FOR APPROVAL IF PRECAST STRUCTURES ARE PREFERRED. CONTACT DANIEL OLIVARES OF CITY ENGINEERING AT (608) 261-9285 FOR PRECAST APPROVALS OR EMAIL SHOP DRAWINGS TO DAOLIVARES@CITYOFMADISON.COM.

STORM & SANITARY SEWER SCHEDULE

BIKEWAYS 2023	SHEET NO. U-STM
PROJECT NO. 14336	
STORM SEWER SCHEDULE	
W LAKESIDE ST	CITY OF MADISON

PROPOSED STORM STRUCTURES

STRUC. NO.	STATION	LOC (OFFSET)	TYPE	TOC	E.I.	DEPTH (FT)	NOTES
<u>W LAKESIDE ST</u>							
S-1	1+24.75	RT-3.34	3X3 STORM SAS	851.84	848.09	3.75	W/R-1550-0054
S-2	1+51.76	RT-3.19	3X3 STORM SAS	851.87	848.75	3.12	FP; W/R-1550-0054
S-2A	1+54.51	RT-11.04	H INLET	851.84	849.34	2.50	FP; W/R-3067-7004-V; [1]
S-3	2+58.54	RT-2.73	3X3 STORM SAS	854.64	851.31	3.33	W/R-1550-0054
S-4	2+60.20	RT-11.00	H INLET	854.56	851.60	2.96	FP; W/R-3067-7004-V; [1]
S-5	2+78.70	RT-24.51	3X3 STORM SAS	855.12	852.23	2.89	FP; W/R-1550-0054; [2]
S-6	3+35.13	RT-47.37	H INLET	857.45	854.11	3.34	W/R-1878-A10G; [3]
S-7	3+31.87	RT-11.58	H INLET	857.16	853.95	3.21	LP; FP; W/R-3067-7004-VB

PROPOSED STORM PIPES

PIPE NO.	FROM (DNSTM)	TO (UPSTM)	DISCH. E.I.	INLET E.I.	PLAN (PAY) LGTH (FT)	PIPE LGTH (FT)	SLOPE (%)	PIPE SIZE	TYPE	NOTES
<u>W LAKESIDE ST</u>										
P-1	S-1	S-2	848.09	848.75	27	24	2.75%	12"	RCP	-
P-2A	S-2	S-2A	848.85	849.34	8	6	8.55%	12"	RCP	-
P-2	S-2	S-3	848.85	851.31	107	104	2.37%	12"	RCP	-
P-3	S-3	S-4	851.41	851.60	8	6	3.22%	12"	RCP	-
P-4	S-4	S-5	851.70	852.23	23	19	2.77%	12"	RCP	-
P-5	ADJ-1	S-6	854.09	854.11	13	12	0.17%	12"	RCP	-
P-6	ADJ-2	S-8	853.83	853.95	25	24	0.51%	12"	RCP	-

STORM STRUCTURE ADJUSTMENTS

STRUC. NO.	ID NO.	STATION	LOC (OFFSET)	EX TOC	PROP TOC	ADJ (FT)	NOTES
<u>W LAKESIDE ST</u>							
ADJ-1	IN5047-026	3+47.85	RT-44.79	857.53	857.53	0.00	[4]
ADJ-2	AS5057-027	3+54.51	RT-22.76	856.92	856.92	0.00	[5]

STORM PIPE REMOVALS & ABANDONMENTS

PIPE REM NO.	REMOVE FROM	REMOVE TO	LGTH (FT)	PAID (Y/N)	REM LGTH PAID (FT)	ABN LGTH (FT)	SLURRY (CY)	PIPE SIZE	PIPE TYPE	NOTES
<u>W LAKESIDE ST</u>										
RP-1	S-1	R-1	26	Y	26	0	0.0	12"	VCP	-
RP-2	R-1	R-2	137	Y	137	0	0.0	12"	VCP	-
RP-3	ADJ-2	R-3	15	Y	15	0	0.0	12"	RCP	-
RP-4	R-3	S-6	22	Y	22	0	0.0	12"	RCP	-

STORM STRUCTURE REMOVALS & ABANDONMENTS

STRUC. NO.	ID NO.	STATION	LOC (OFFSET)	TYPE	DEPTH (FT)	NOTES
<u>W LAKESIDE ST</u>						
R-1	IN4957-031	1+41.58	RT-22.27	H INLET	3.07	-
R-2	AS5057-024	2+78.71	RT-24.31	3X3 STM SAS	2.85	-
R-3	IN5057-028	3+39.87	RT-25.42	H INLET	3.63	-

PROPOSED SANITARY STRUCTURES

SAS NO.	STATION	LOC (OFFSET)	TOC	E.I.	DEPTH (FT)	NOTES
<u>W LAKESIDE ST</u>						
SCO#1	2+44.35	RT-26.20	854.15	845.13	9.02	[6]

SANITARY STRUCTURE REMOVALS

STRUC ID NO.	STATION	LOC (OFFSET)	TOC	E.I.	DEPTH(FT)	NOTES
<u>W LAKESIDE ST</u>						
SAS 4957-010	2+44.35	RT-26.20	854.07	845.13	8.94	[7]

ULO SCHEDULE

ID NO. (OFFSET)	STATION	LOCATION (OFFSET)	TYPE	NOTES
<u>W LAKESIDE ST</u>				
ULO1	1+29.13	RT-3.43	WAT LAT	-
ULO2	1+56.52	RT-11.40	10" WAT	-
ULO3	1+81.34	RT-3.06	WAT LAT	-
ULO4	2+13.82	RT-3.13	WAT LAT	-
ULO5	2+50.54	RT-2.77	WAT LAT	-
ULO6	2+60.21	RT-11.00	10" WAT	-
ULO7	2+44.36	RT-27.55	FO	-


SPECIFIC NOTES:

- [1] CASTING LOCATED AT MODIFIED TYPE B CURB; CURB OPENING LOWERED 2" (11" CASTING HEIGHT)
- [2] RECONNECT EX 12" ON SOUTH SIDE; KEEP PRIVATE STORM ACTIVE
- [3] RECONNECT EX 12" RCP STM; KEEP AE5057-033 ACTIVE
- [4] TAP (T-5) NEW 12" RCP TO WEST SIDE OF EX INLET
- [5] TAP (T-7) NEW 12" RCP TO WEST SIDE OF EX STM SAS
- [6] INSTALL SANITARY CLEANOUT PER S.D.D. 5.7.41. COMPRESSION COUPLING SHALL BE INCIDENTAL TO THE COST OF THE CLEANOUT. REPLACMENT OF VERTICAL PIPE & CASTING ARE REQUIRED. SEE ALSO NOTE 7
- [7] EX SANITARY CLEANOUT CONSTRUCTED OF 6" VCP WITH VCP SWEEP. TV SHOWS DEBRIS, LIKELY FROM DAMAGED VERTICAL PIPE. REMOVE CASTING, VERTICAL CLEANOUT STANDPIPE & SWEEP, THEN REPLACE WITH NEW SWEEP & PVC STANDPIPE.

STANDARD NOTES:

- PLAN LENGTH (PAY LENGTH) IS FROM CENTER OF STRUCTURE TO CENTER OF STRUCTURE. PIPE LENGTH IS ACTUAL LENGTH OF PIPE FROM STRUCTURE WALL TO STRUCTURE WALL. SLOPE CALCULATED USING PIPE LENGTH.
- ALL FIELD POURED SAS STORM STRUCTURES SHALL BE CONSTRUCTED IN ACCORDANCE WITH STANDARD DETAIL DRAWING 5.7.3. ALL PRECAST SAS STORM STRUCTURES SHALL BE CONSTRUCTED IN ACCORDANCE WITH STANDARD DETAIL DRAWING 5.7.5.
- ALL REBAR FOR FIELD POURED STRUCTURES SHALL BE EPOXY COATED. ANY EXPOSED STEEL SHALL BE TOUCHED UP OR RECOATED PRIOR TO USE.
- APPROXIMATE DISCHARGE E.I. GIVEN, ADJUST E.I. AND PIPE SLOPE IN THE FIELD.
- TOP OF CASTING GRADE GIVEN IS THE TOP OF CURB FOR INLET STRUCTURES AND THE FLOWLINE OF THE CLOSED CASTING FOR SAS's.

- ABBREVIATIONS: AE = APRON ENDWALL; RCP = REINFORCED CONCRETE PIPE; HERCP = HORIZONTAL ELLIPTICAL REINFORCED CONCRETE PIPE; DNA = DOES NOT APPLY; SAS = SEWER ACCESS STRUCTURE; LP = LOW POINT INLET STRUCTURE; FP = FIELD POURED STRUCTURE; TR = TOP OF CONCRETE ROOF; NCM = NO CROWN MATCH FOR PIPES; UD = UNDERDRAIN
- ALL REINFORCED CONCRETE PIPES TO BE CLASS 3 UNLESS OTHERWISE NOTED.
- SURVEYOR TO CONFIRM THAT ALL INLET STATION / OFFSETS LINE UP WITH PROPOSED CURB AND GUTTER.
- ALL STRUCTURES CALLED OUT AS FIELD POURED SHALL BE FIELD POURED. ALL OTHER STRUCTURES (NOT INDICATED AS FIELD POURED) SHALL BE SUBMITTED TO CITY ENGINEERING FOR APPROVAL IF PRECAST STRUCTURES ARE PREFERRED. CONTACT DANIEL OLIVARES OF CITY ENGINEERING AT (608) 261-9285 FOR PRECAST APPROVALS OR EMAIL SHOP DRAWINGS TO DAOLIVARES@CITYOFMADISON.COM.

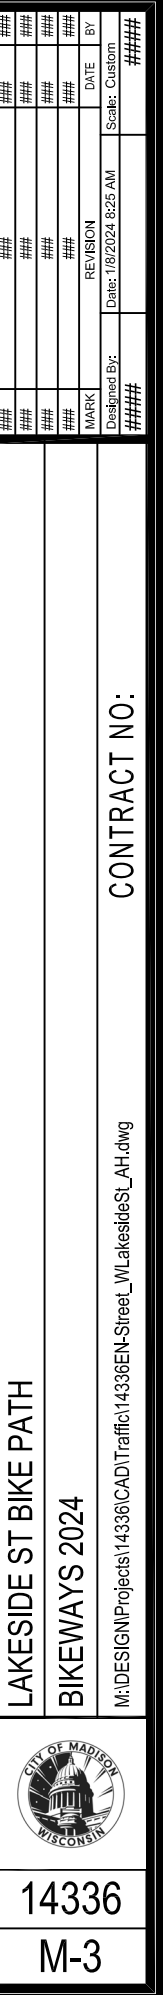


CH 3 MATCH 3



LAKE CT


VAN DEUSEN ST

Install
sharrows

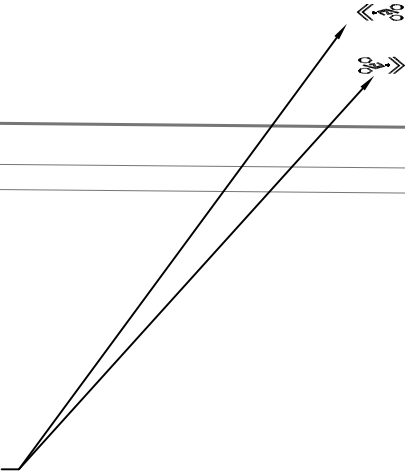

LAWRENCE ST

Install
sharrows

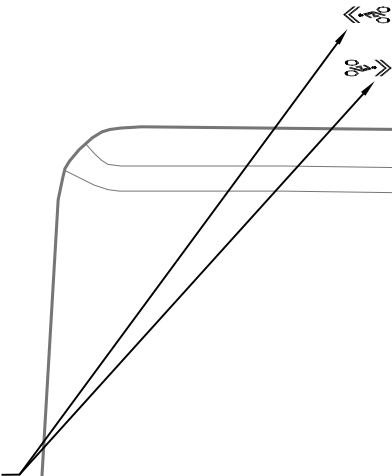


HOMER CT

MATCH 4



	14336	CONTRACT NO:	LAKESIDE ST BIKE PATH BIKEWAYS 2024	M:\DESIGN\Projects\14336\CAD\Traffic\14336EN-Street_W\LakesideSLAH.dwg	MARK ###	DESIGNED BY ###	DATE ###	BY ###	REVISION ###	DATE ###	BY ###	Scale: 1" = 40'	###
	M-4												

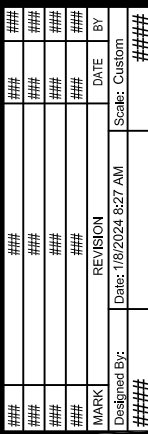

H 5

MATCH 5

Install sharrows

 
VAN DEUSEN ST

WINGRA CREEK BIKE PATH

Install Bike Right Arrow Sharrows

Install Sharrow -

SAYLE ST



14336

M-6




LAKESIDE ST BIKE PATH




BIKEWAYS 2024

M:\DESIGN\Projects\14336\CAD\Traffic\14336EN-Street_WLakesideSt_AH.dwg

CONTRACT NO:

[illegible]

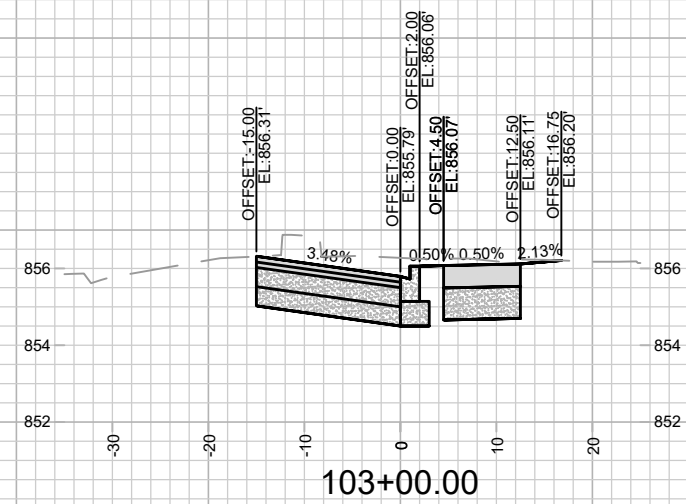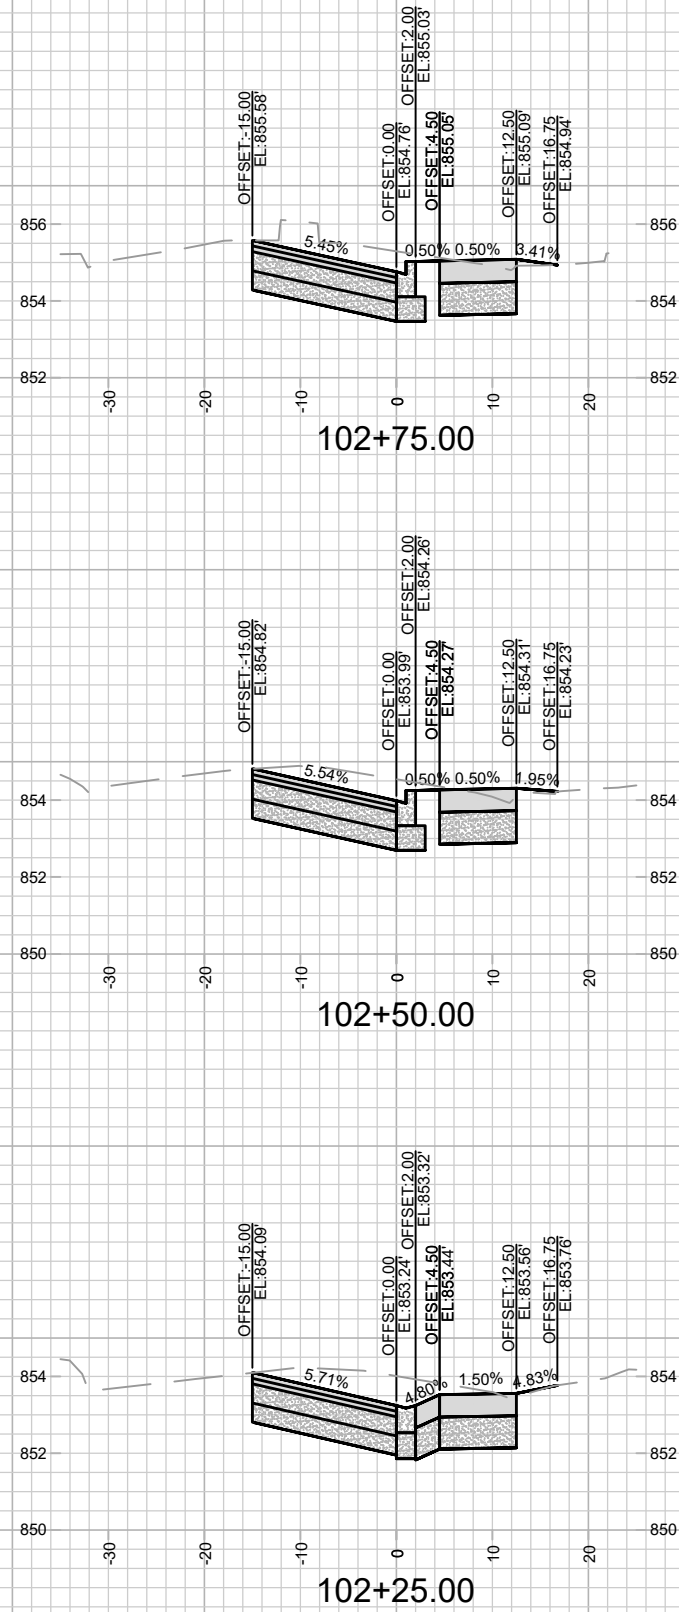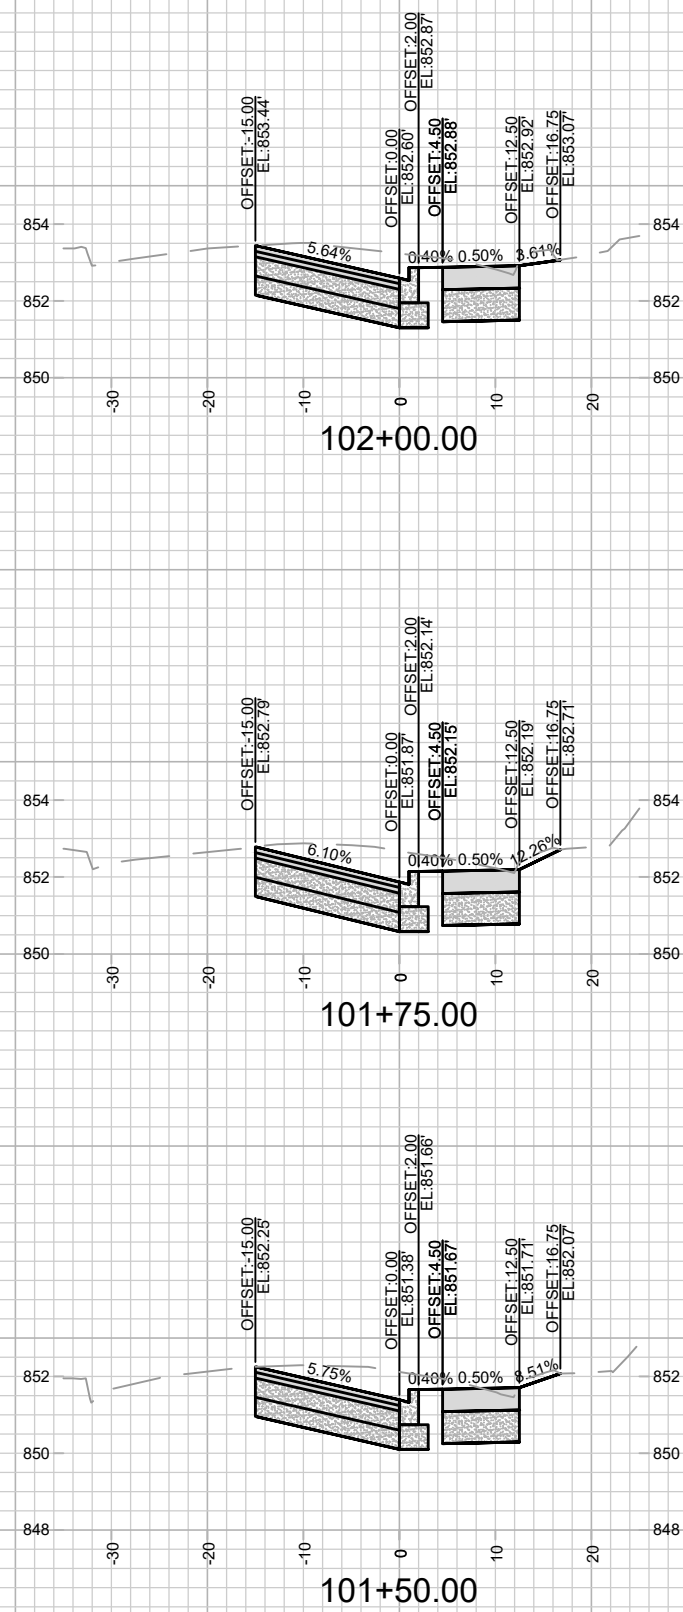

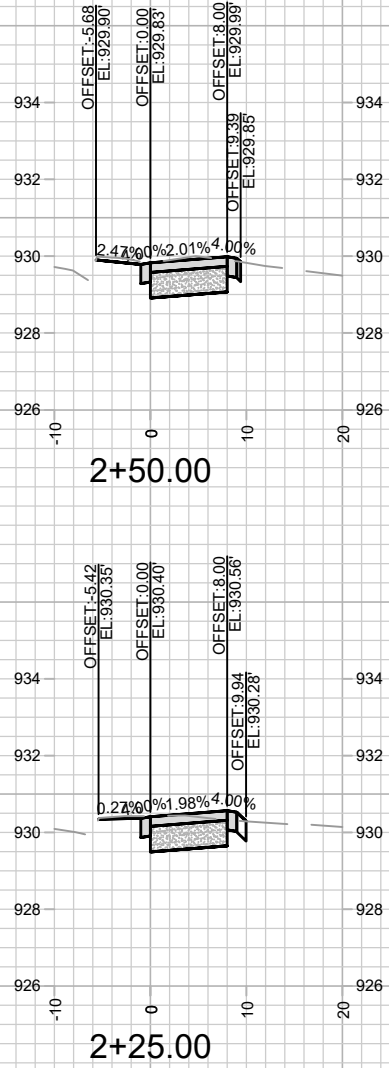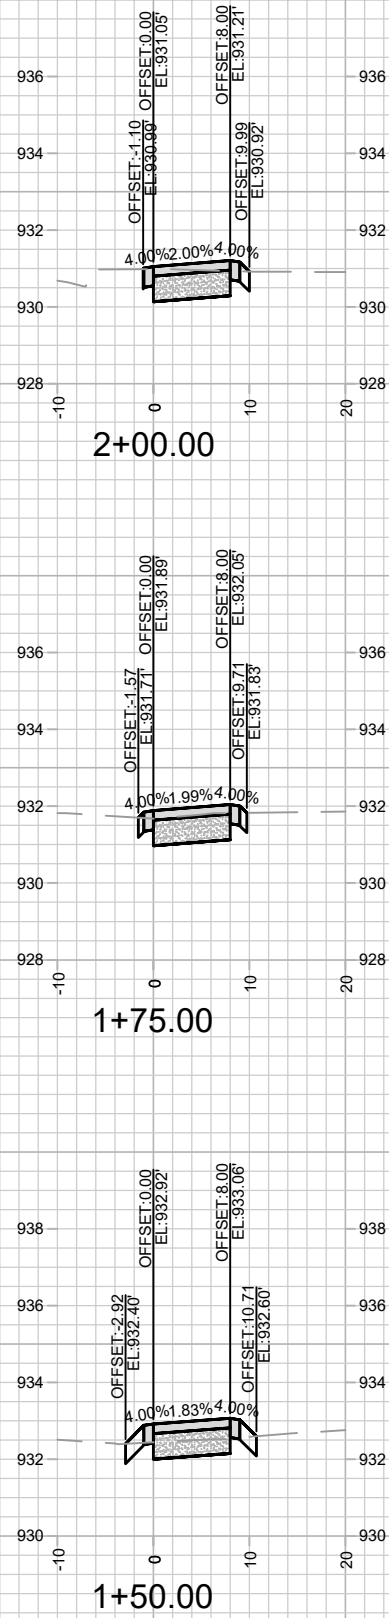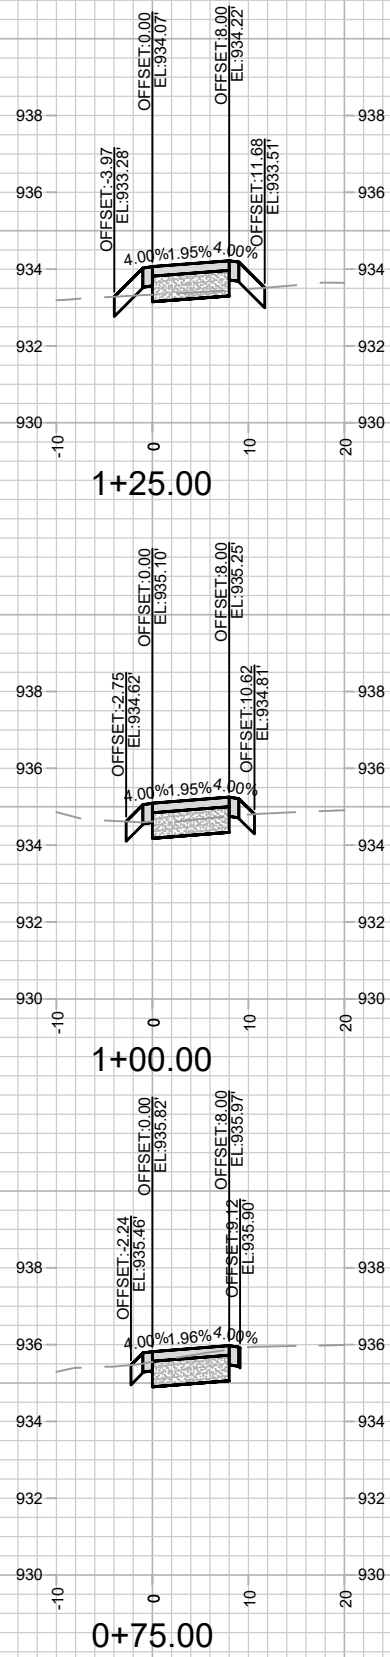

14336

X-2

CROSS SECTIONS UW ARBORETUM ENTRANCE PATH

BIKEWAYS 2023

M:\DESIGN\Projects\14336\CAD\Streets\14336EN-Xsec.dwg

14336

CONTRACT NO:

8696

MADISON, WI

DESIGNED BY: ###

DATE: 1/12/2024 12:48 PM

REVISION: ###

SCALE: 1" = 20'

BY: ###

X-2

