

Reference-5: Existing Conditions drawings

EXISTING CONDITION REFERENCE PLANS

REINDAHL PARK SHELTER

DATED 1978-FEB-14

REINDAHL PARK SHELTER PHASE II MADISON, WISCONSIN



INDEX TO DRAWINGS

NUMBER	DESCRIPTION
TITLE SHEET	TITLE; INDEX; SIGNATURES
S1	FOUNDATION PLAN
S2	ROOF FRAMING PLAN
S3	STRUCTURAL DETAILS
A1	FIRST FLOOR PLAN
A2	SECOND FLOOR PLAN
A3	ELEVATIONS
A4	ELEVATIONS
A5	SECTIONS
A6	SECTIONS; DETAILS
A7	DETAILS


APPROVED BY COUNCIL _____
CITY CLERK _____

OWNER:
CITY OF MADISON, PARKS DEPT.

ARCHITECT:
MARTINSONS ZECK, INC.



[Signature]
14 FEB 78



CONSULTANT:
DRIES - JACQUES ASSOCIATES, INC.

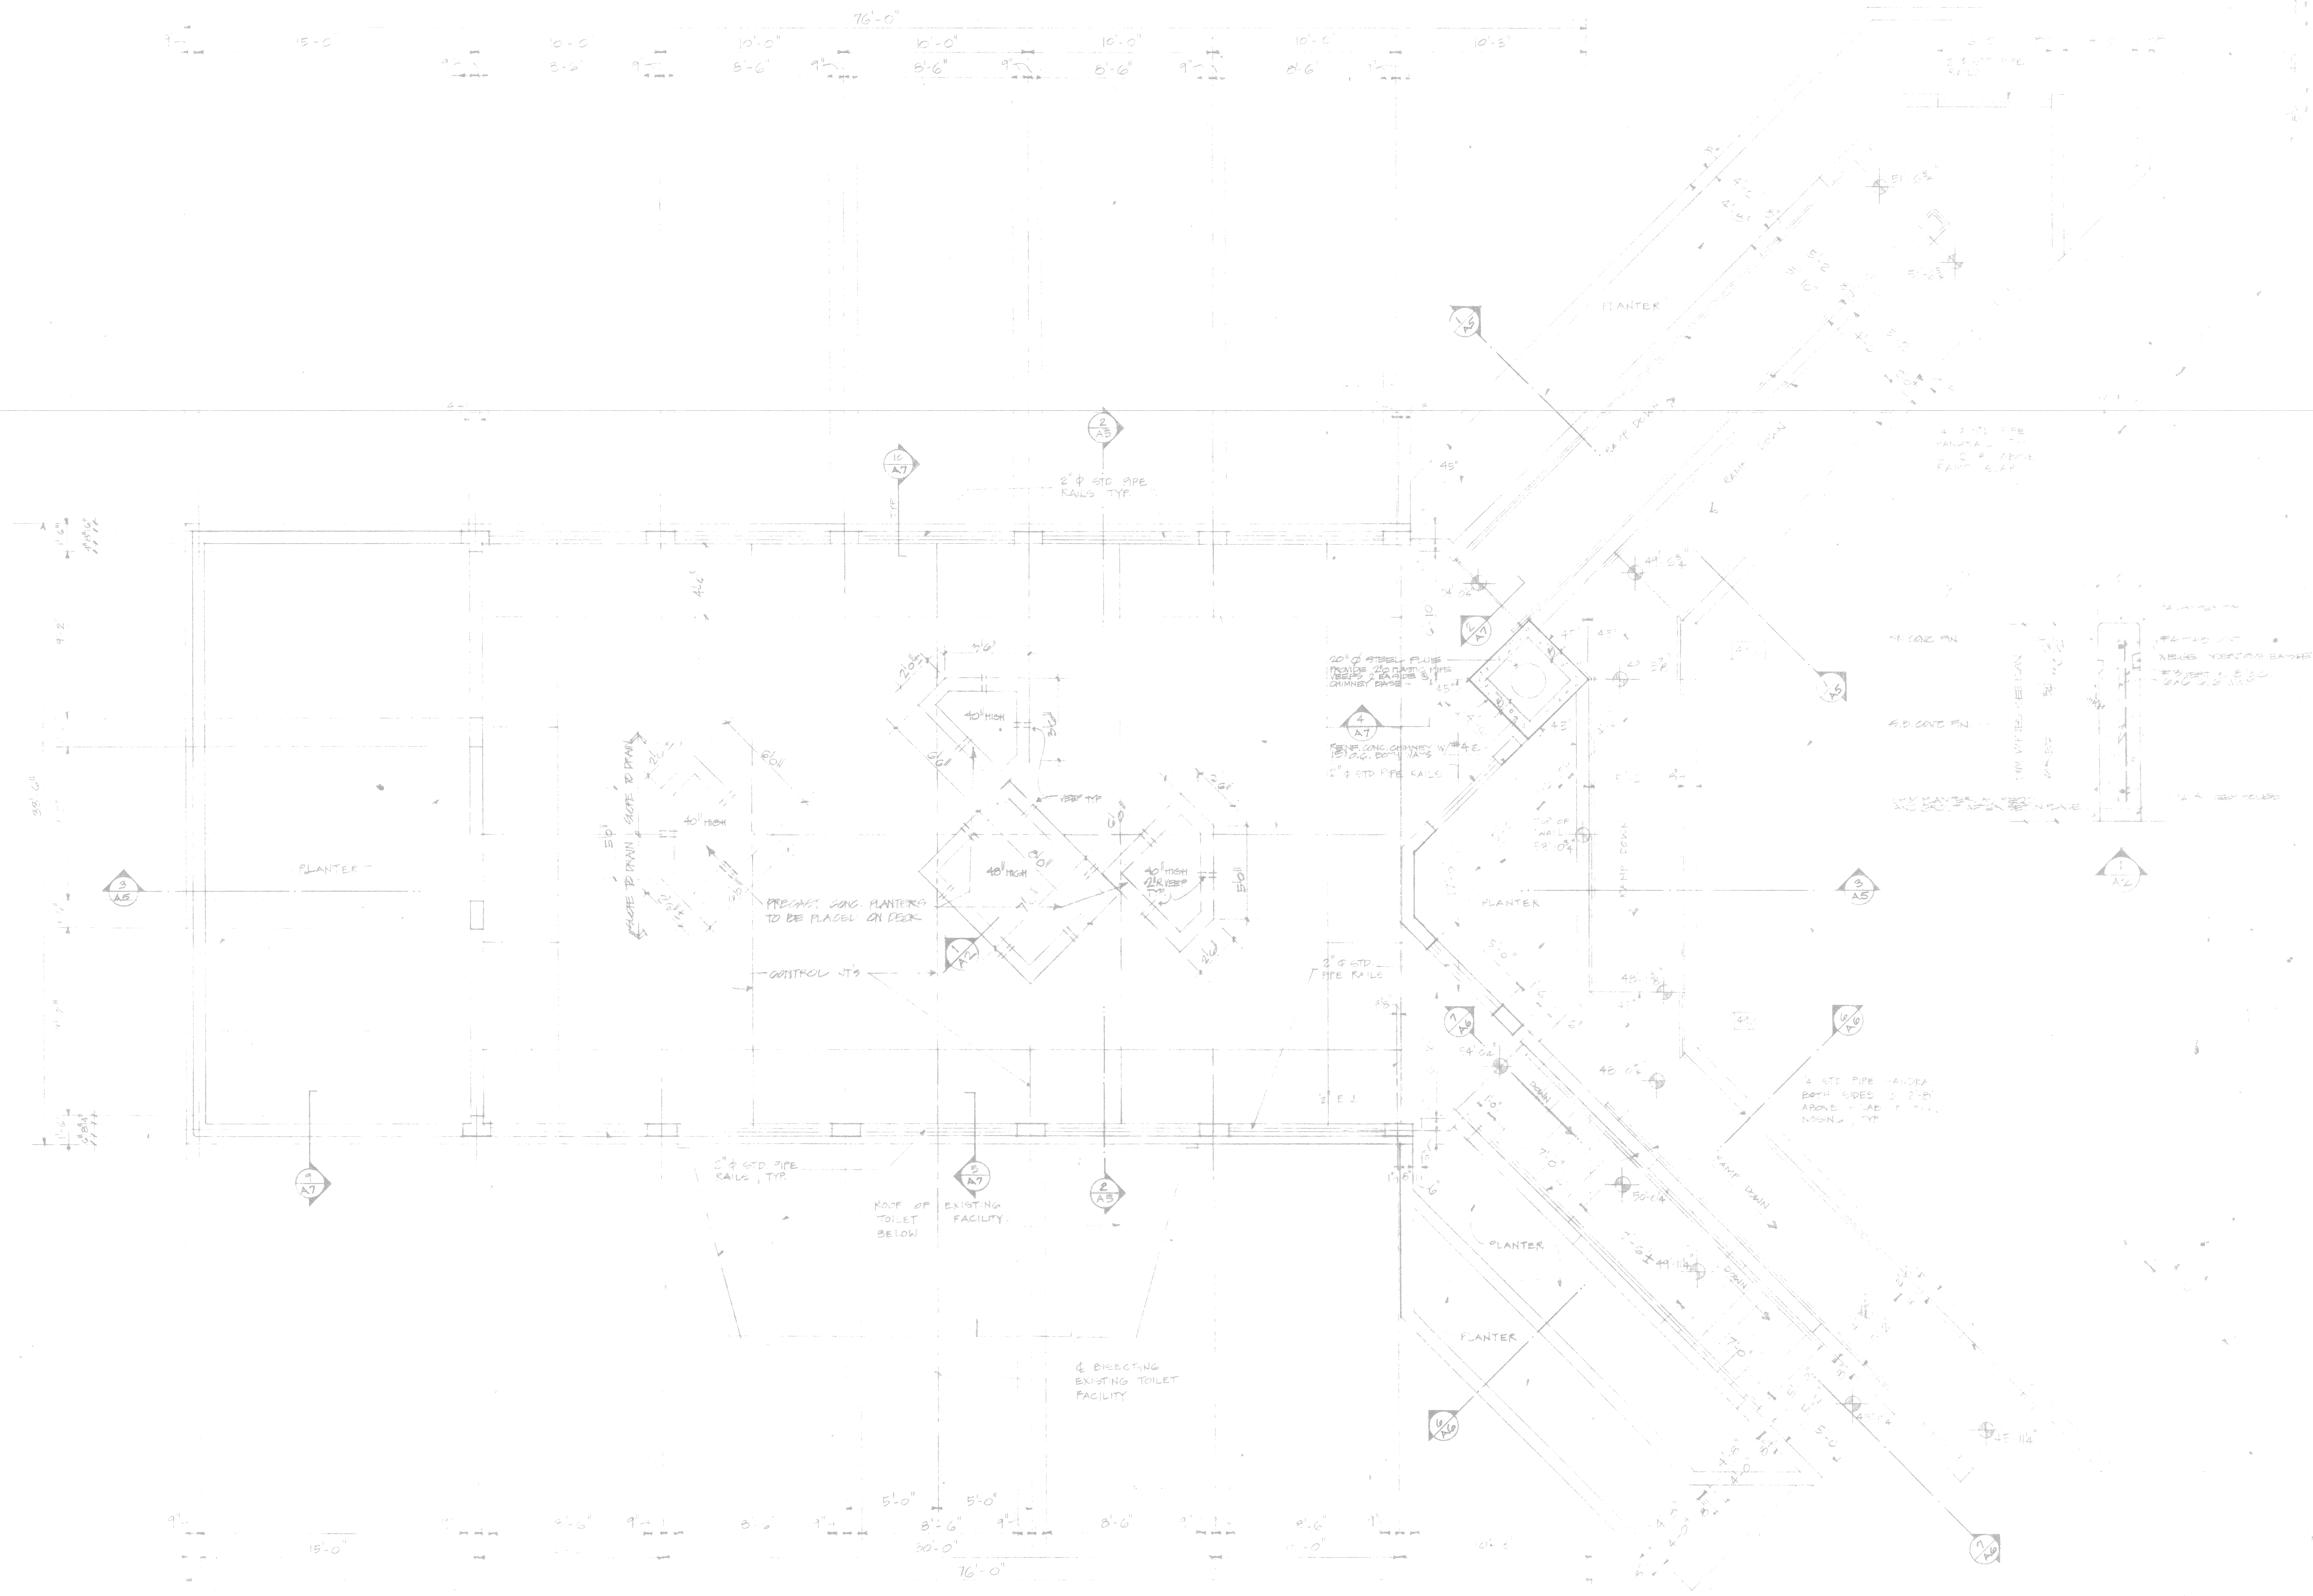


ROOF, RAMP, AND STAIR PLAN

1" = 1'-0"

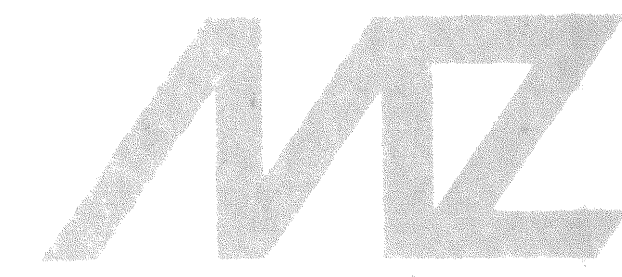
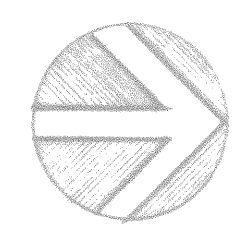


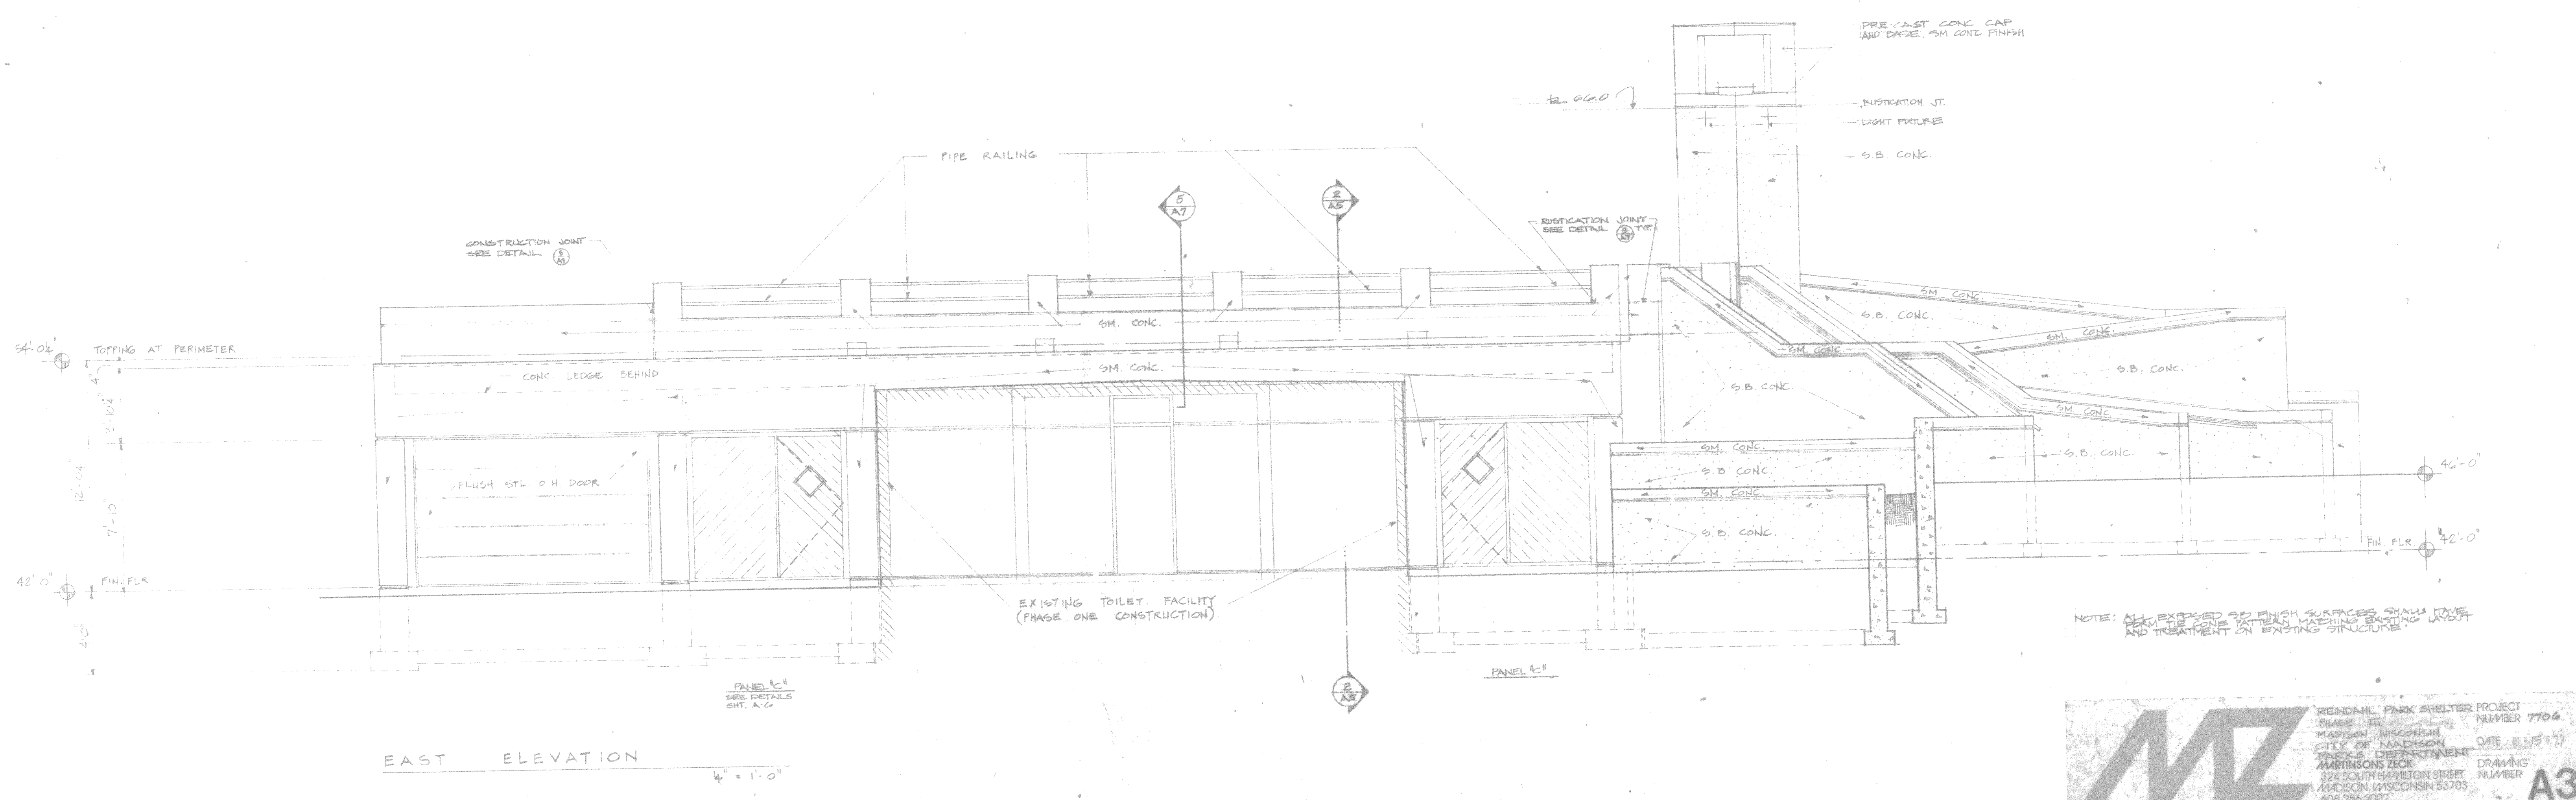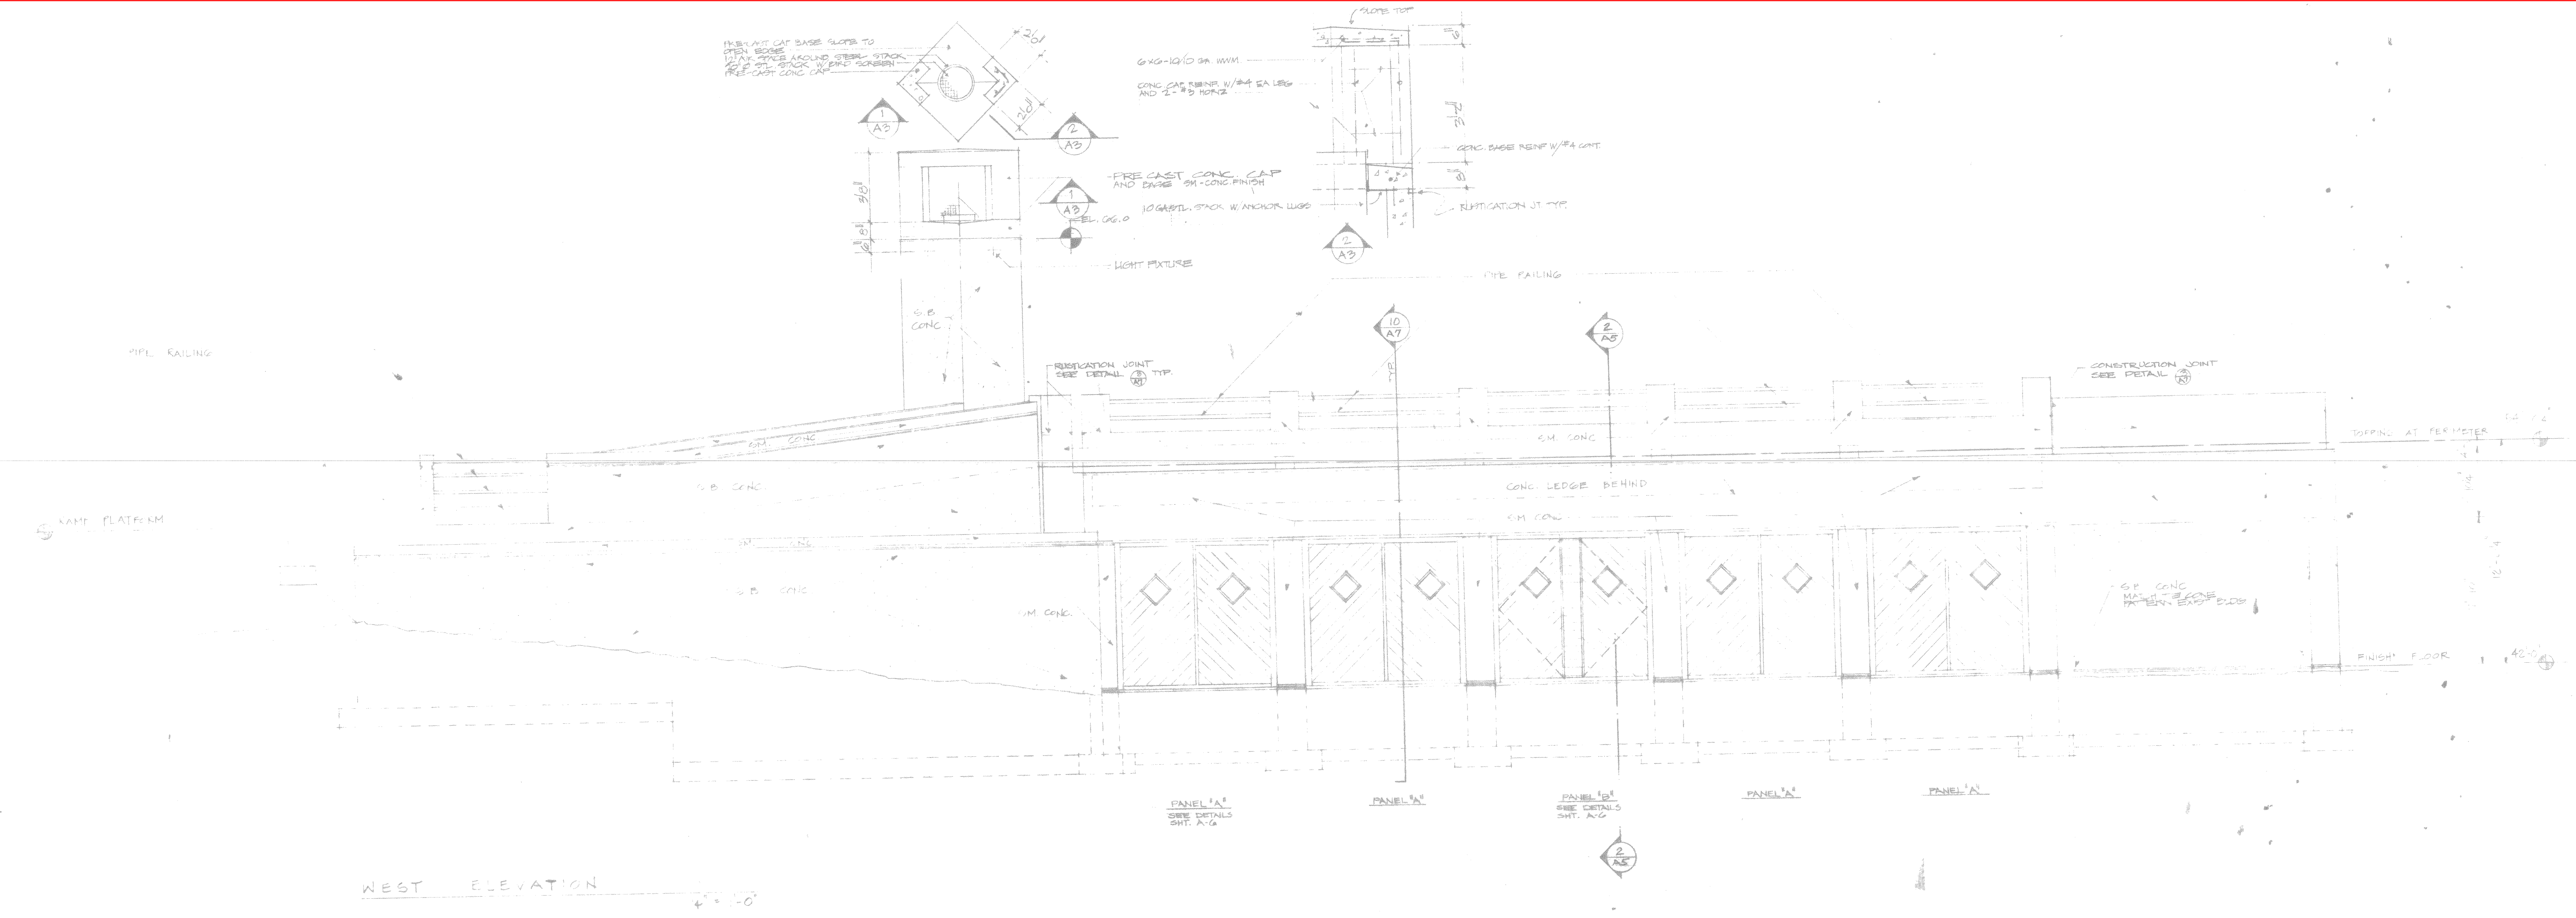


NOTE: ALL EXPOSED SP. FINISH SURFACES SHALL HAVE
CONCRETE PATTERN MAKING EXISTING LAYOUT
AND TREATMENT ON EXISTING STRUCTURE.

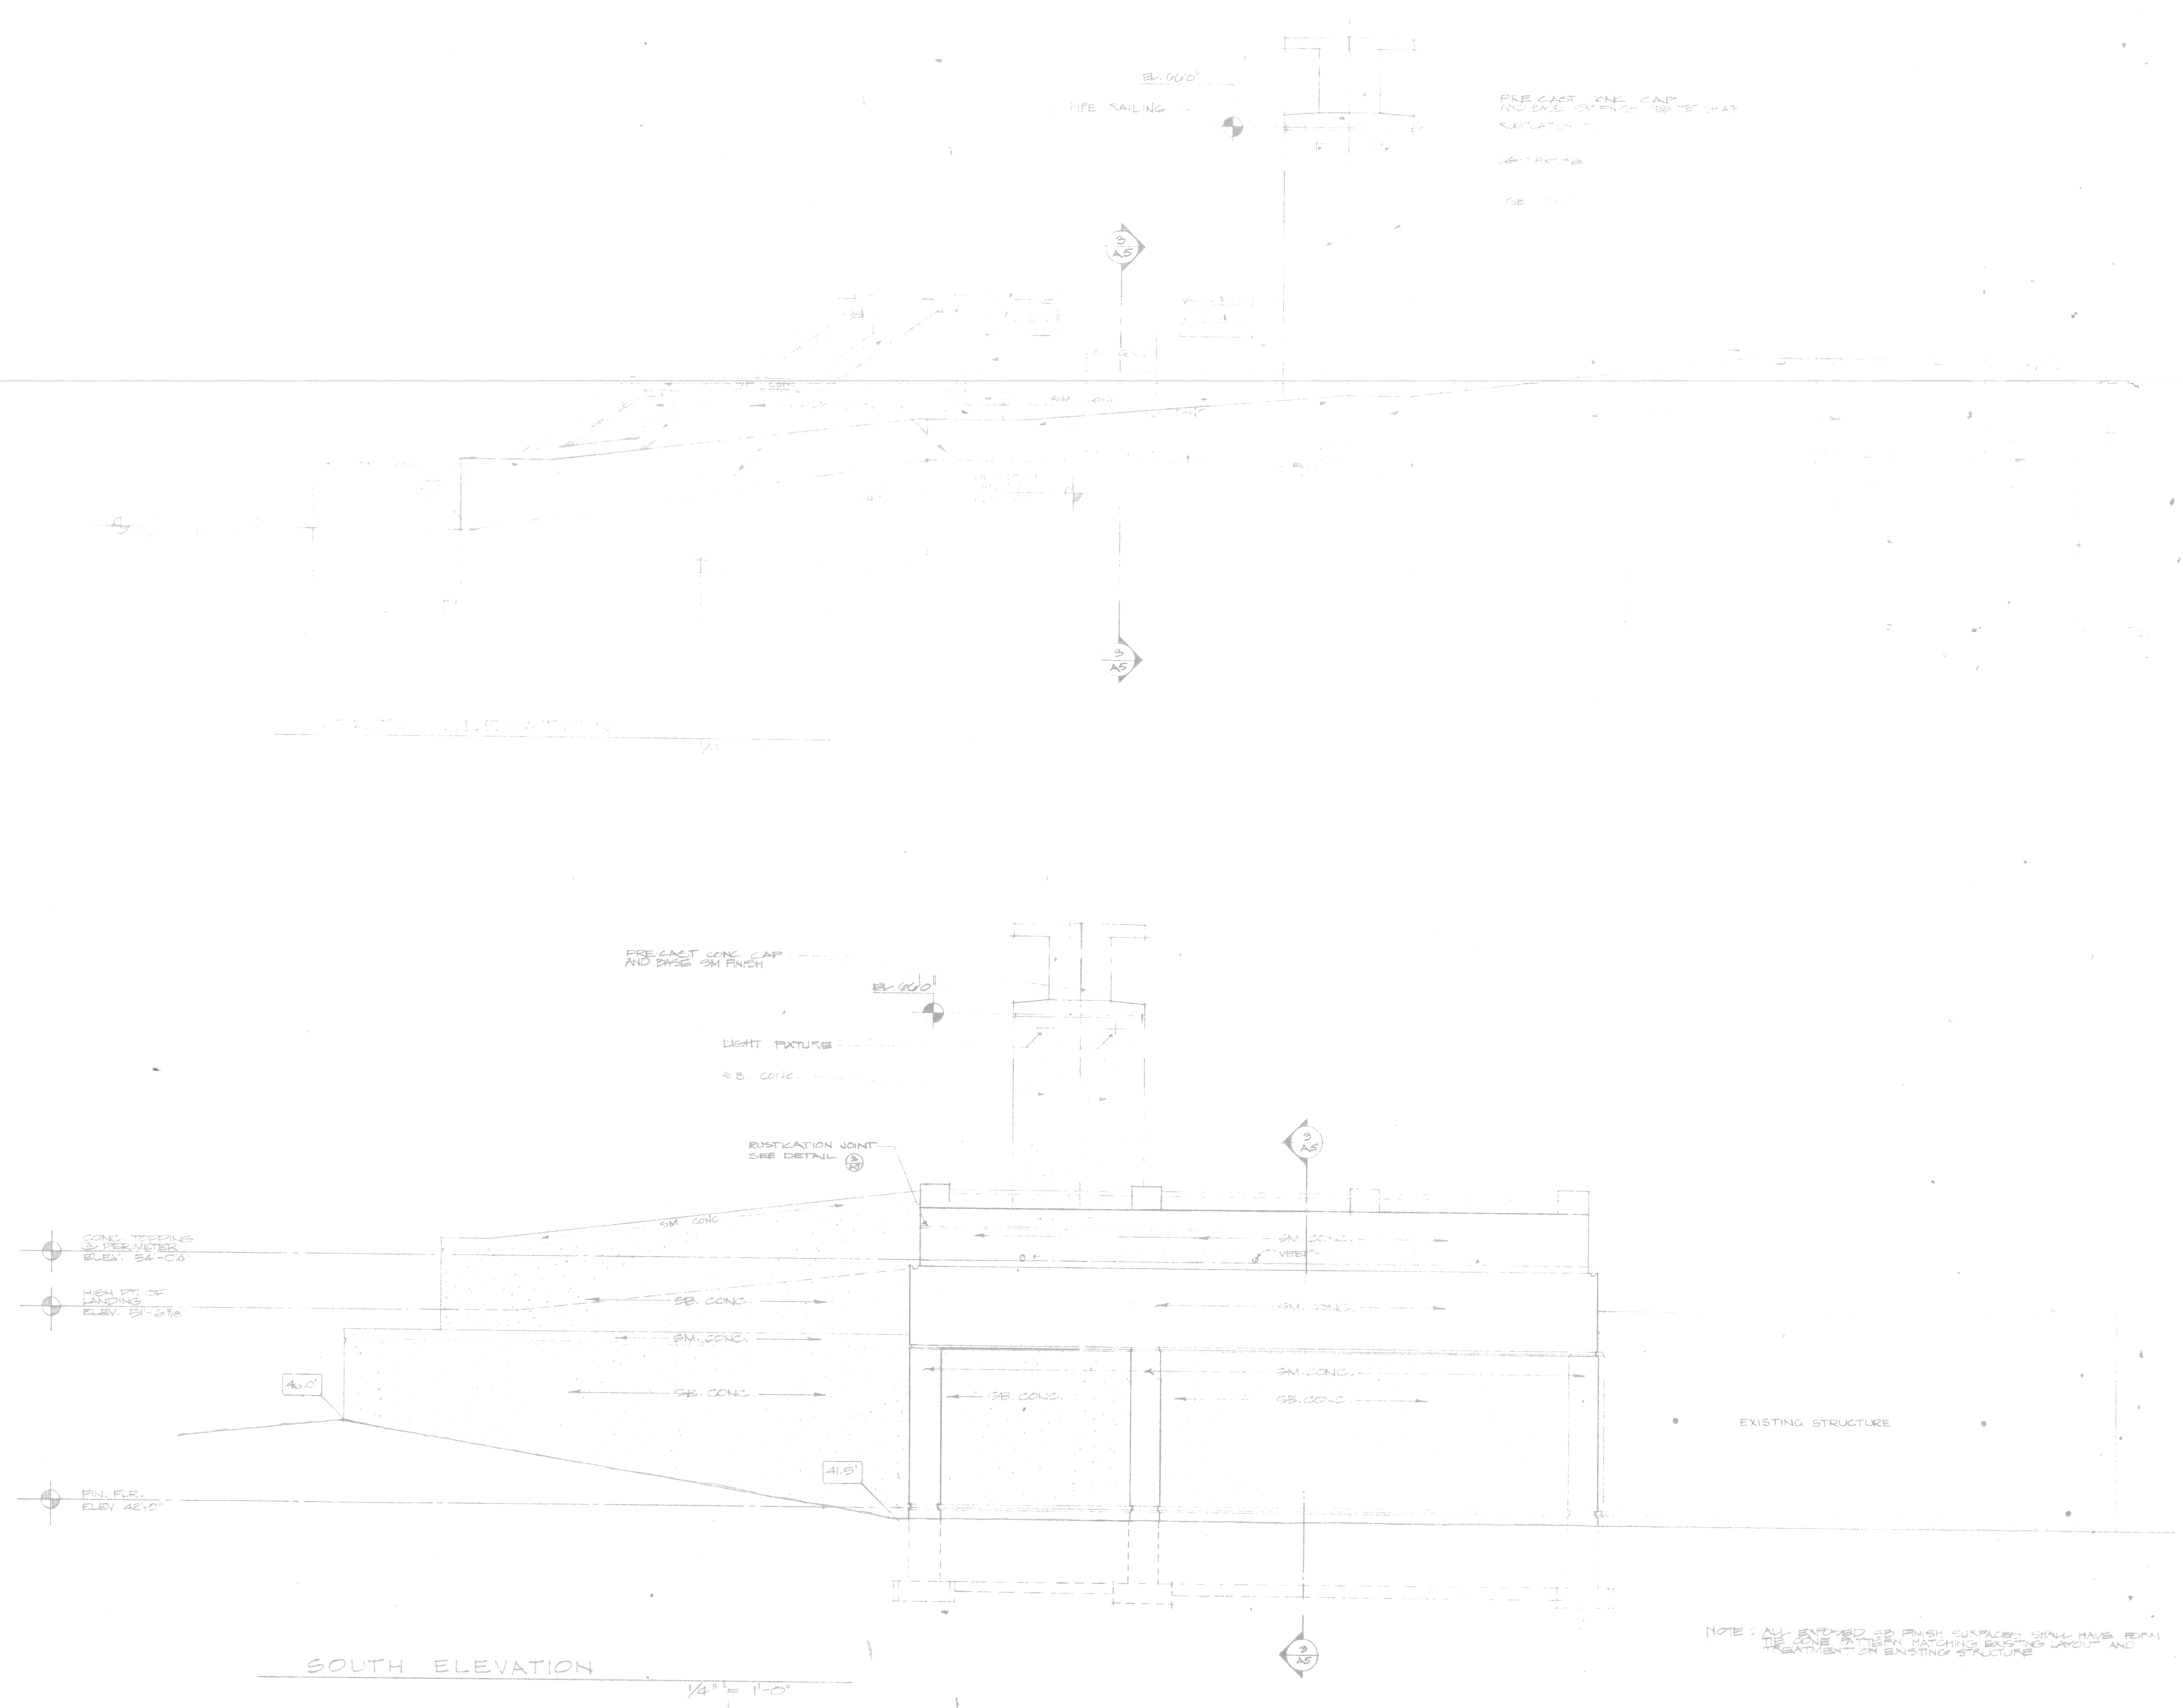


NOTE: ALL EXPOSED SB FINISH SURFACES SHALL HAVE FORM
IE CONE PATTERN PATCHING EXISTING LAYOUT AND
TREATMENT ON EXISTING STRUCTURE

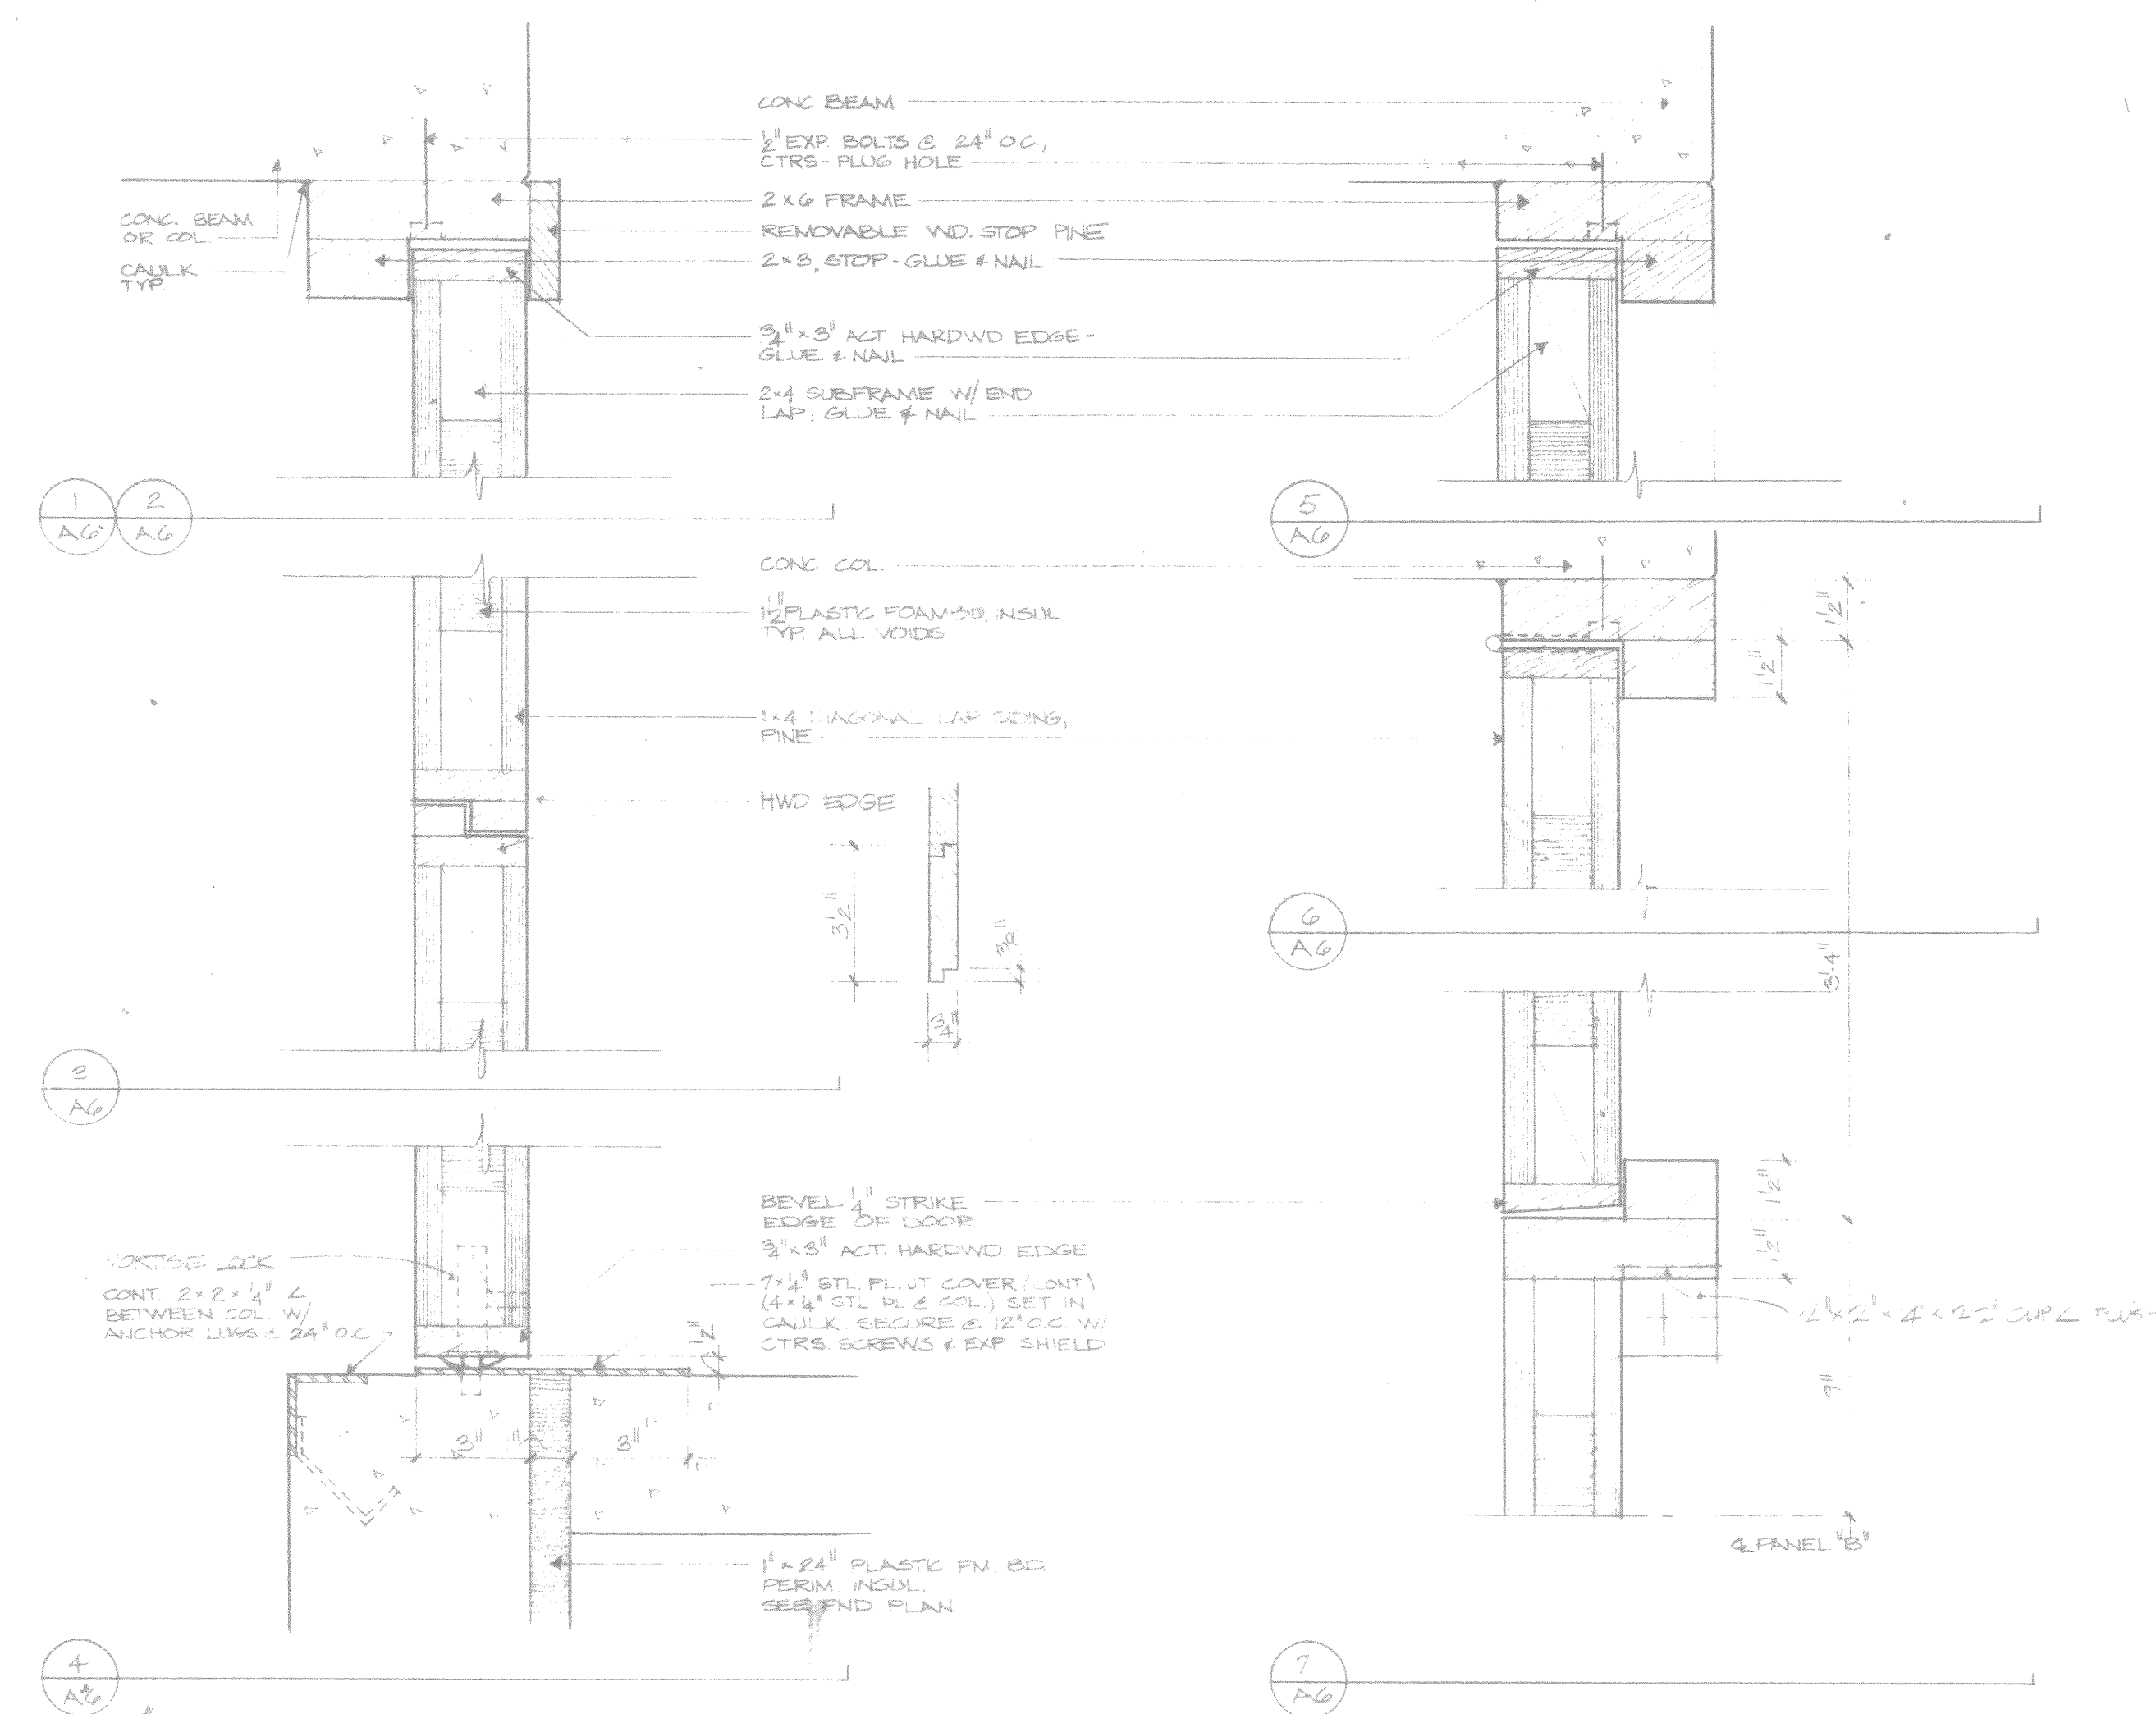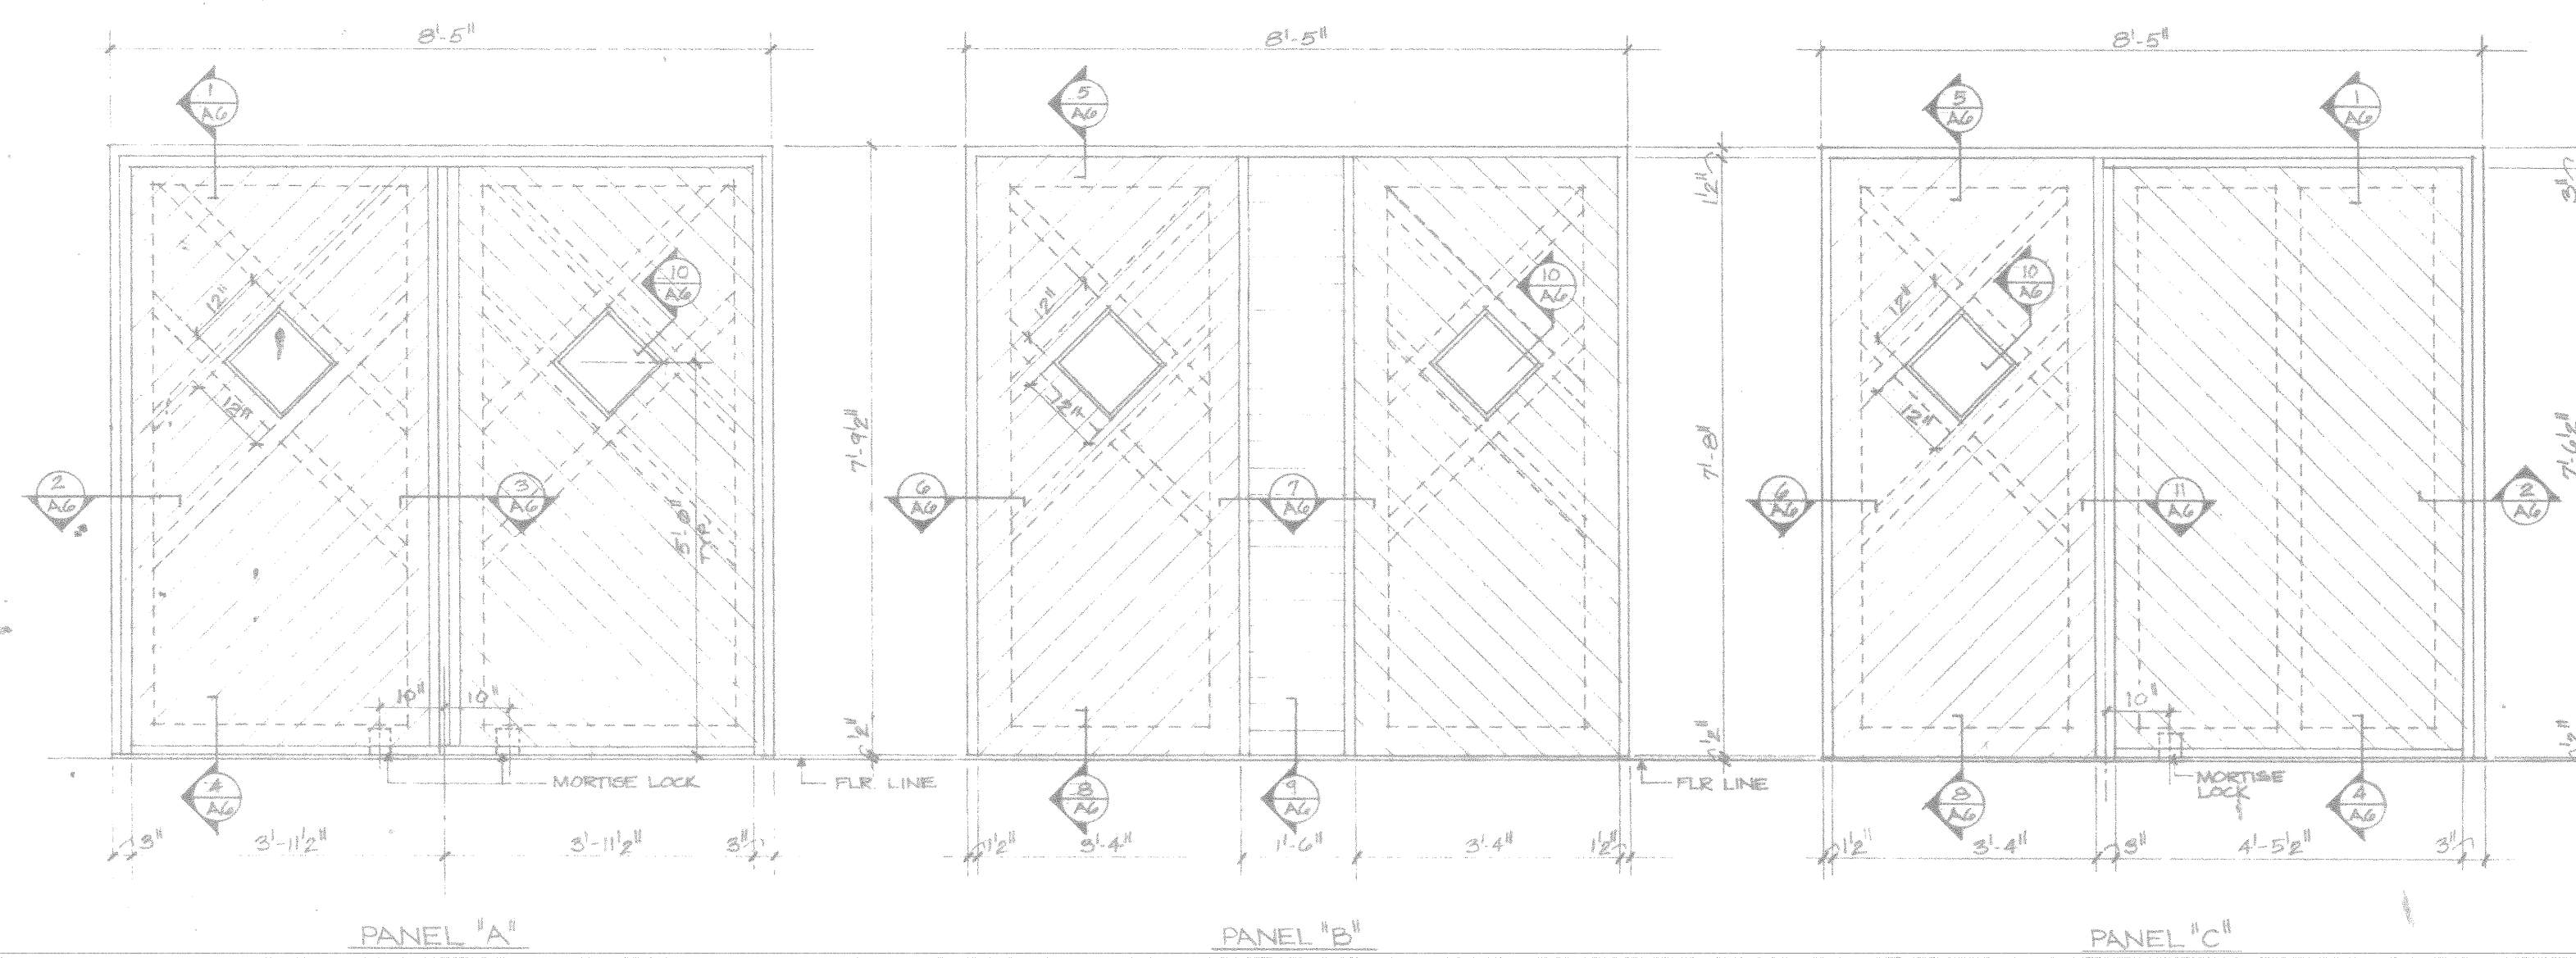


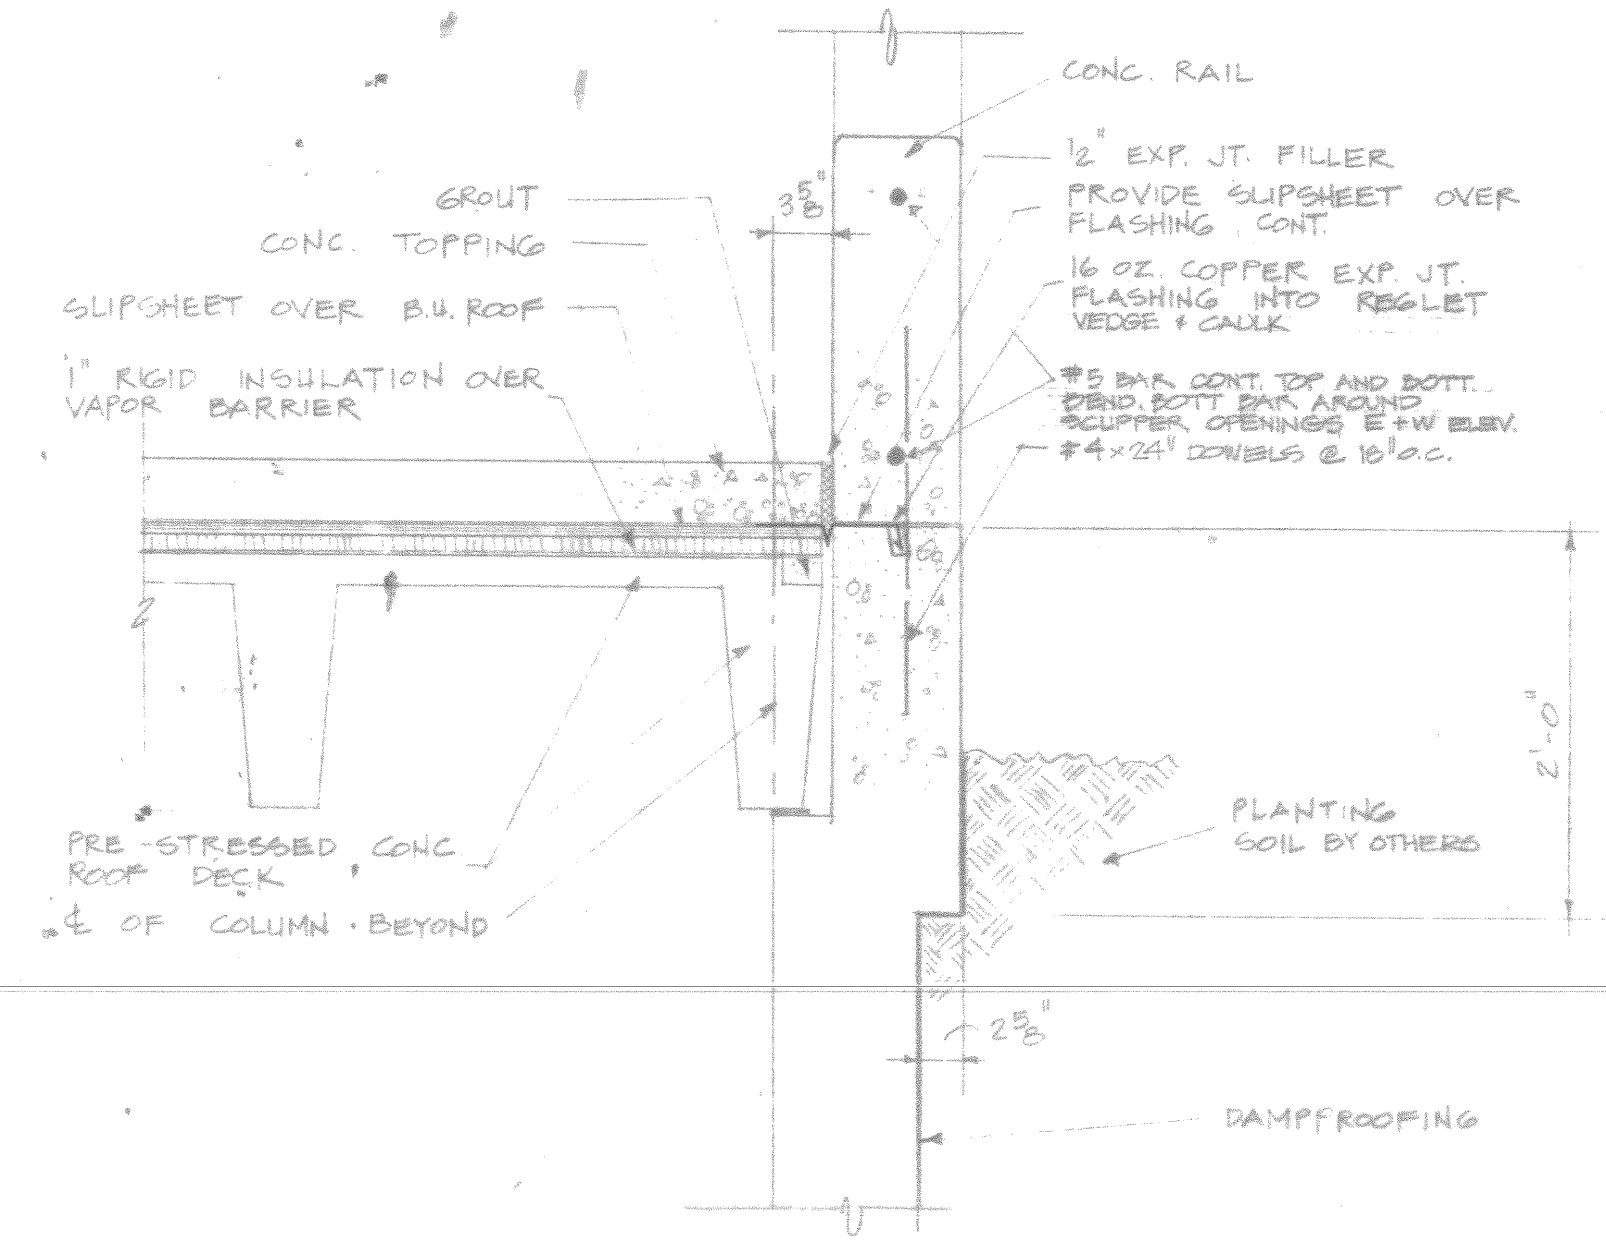


1
A7
1" = 1'-0"

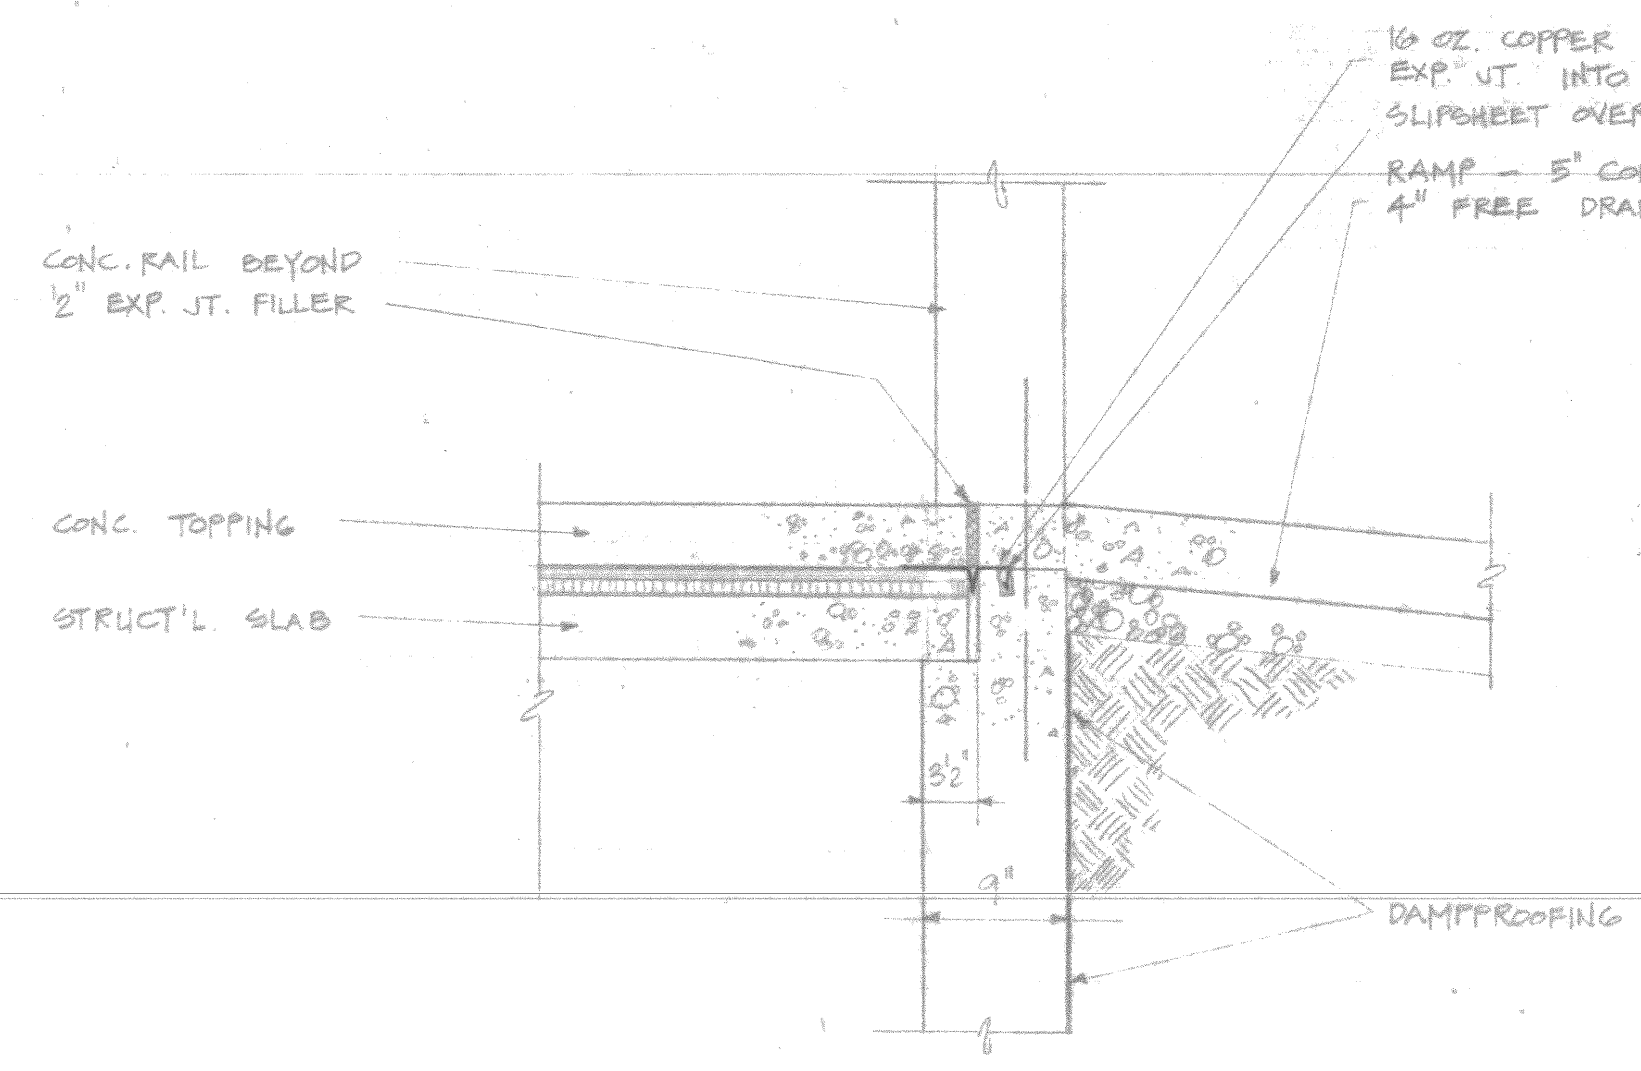


2
A7
1" = 1'-0"

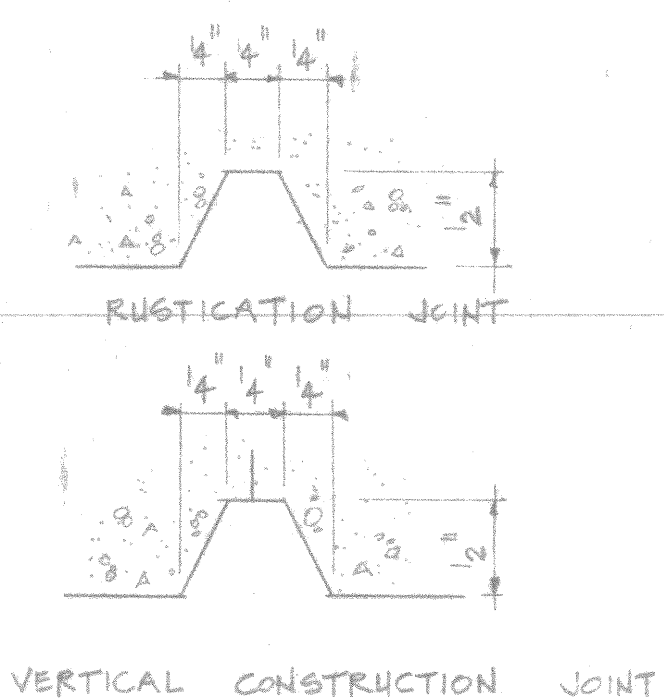


3
A7
FULL SIZE

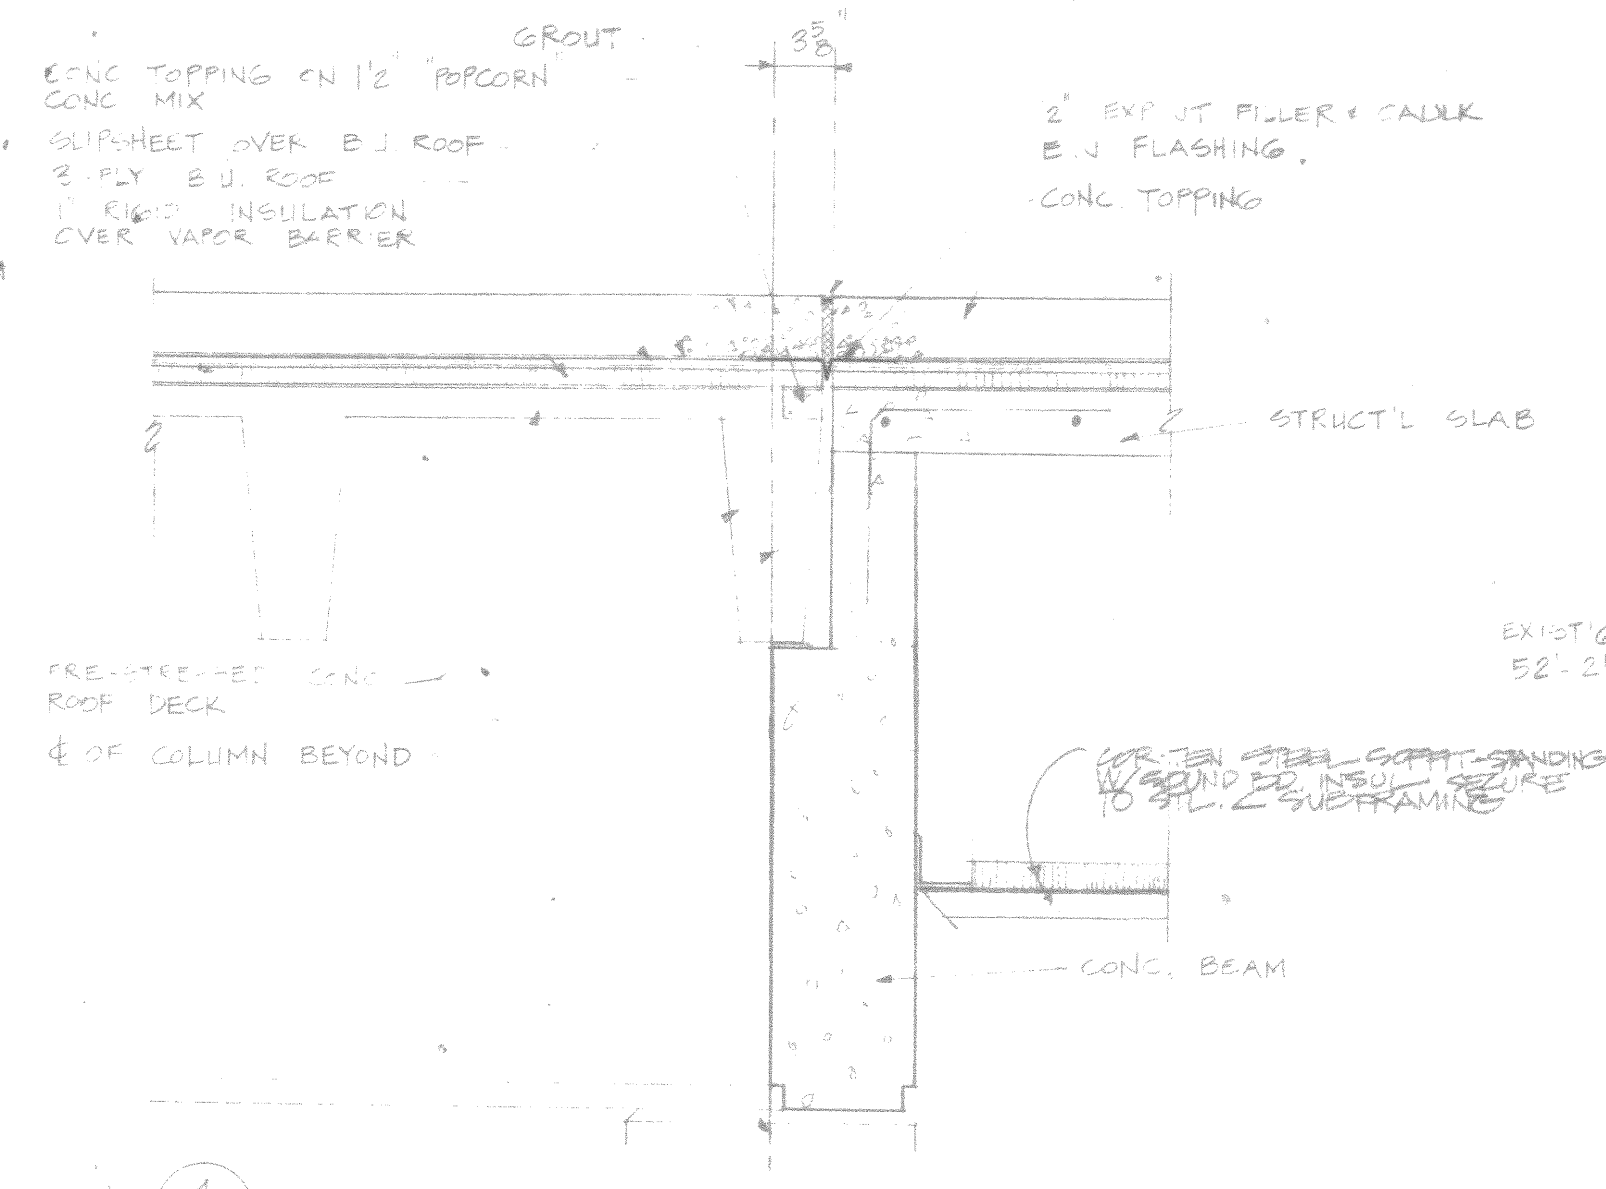


4
A7
1" = 1'-0"

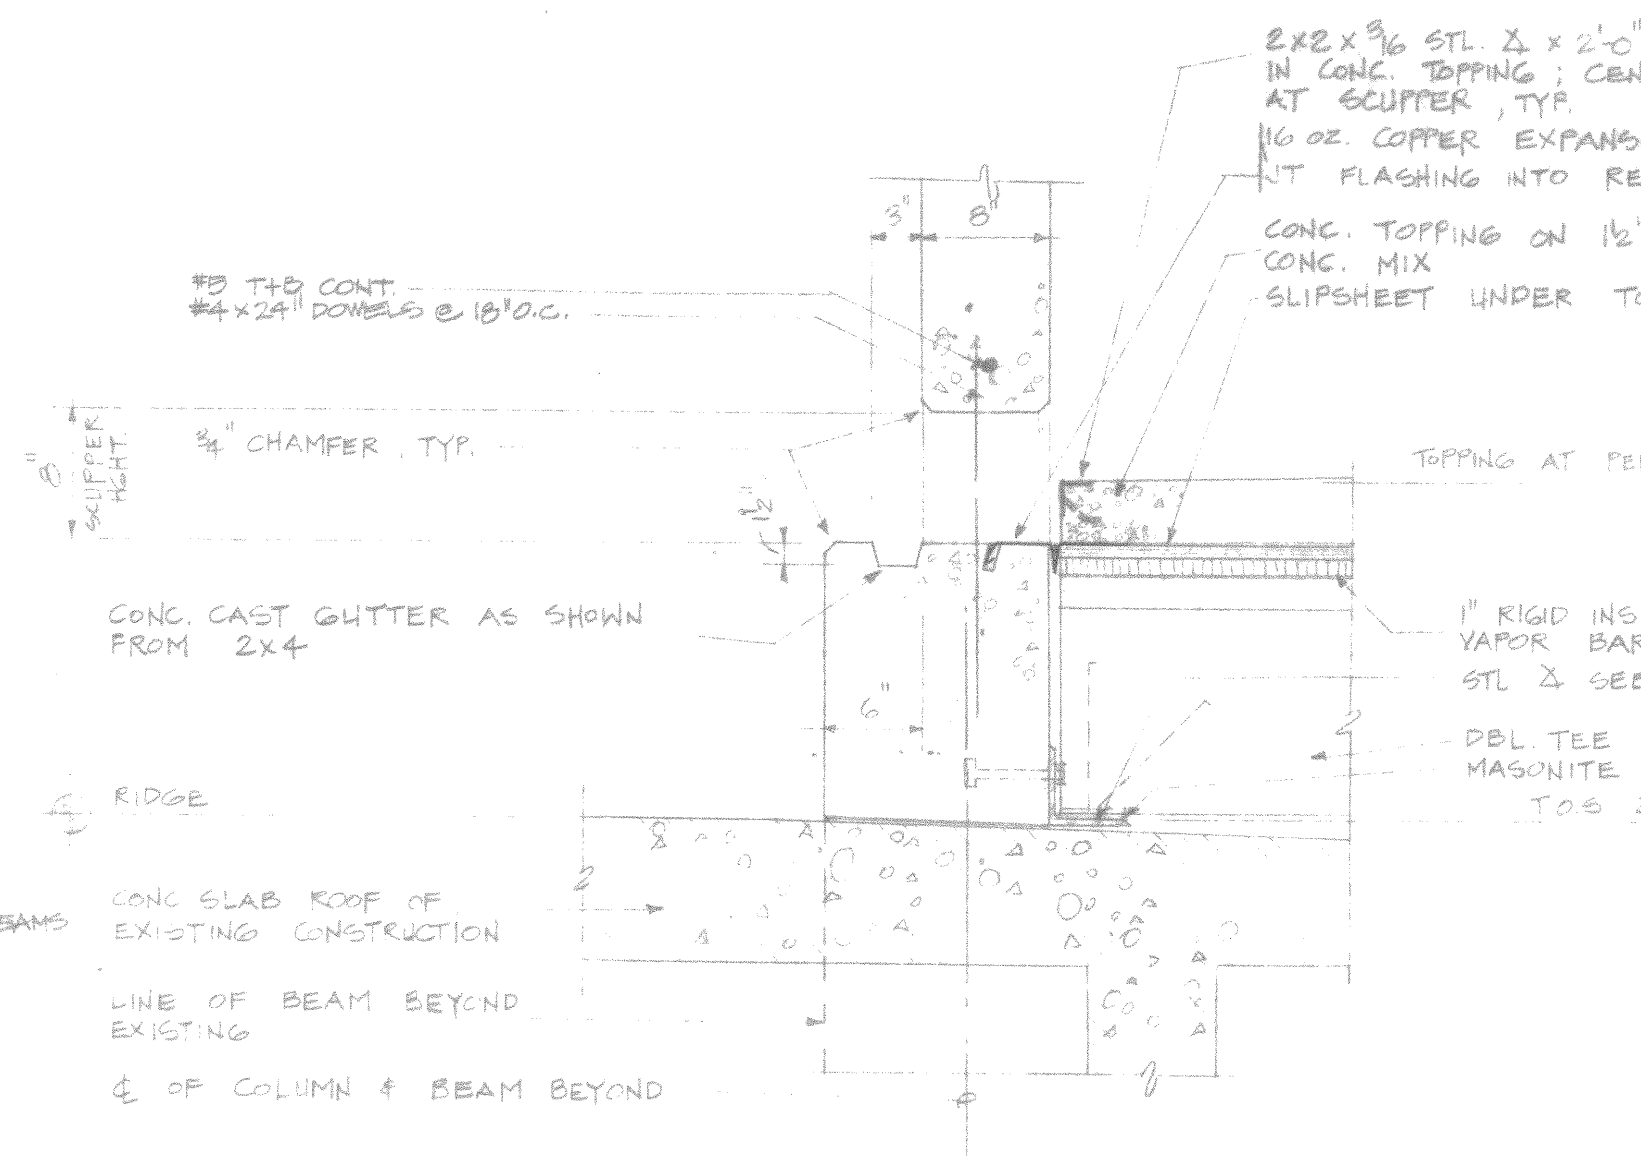


5
A7
1" = 1'-0"

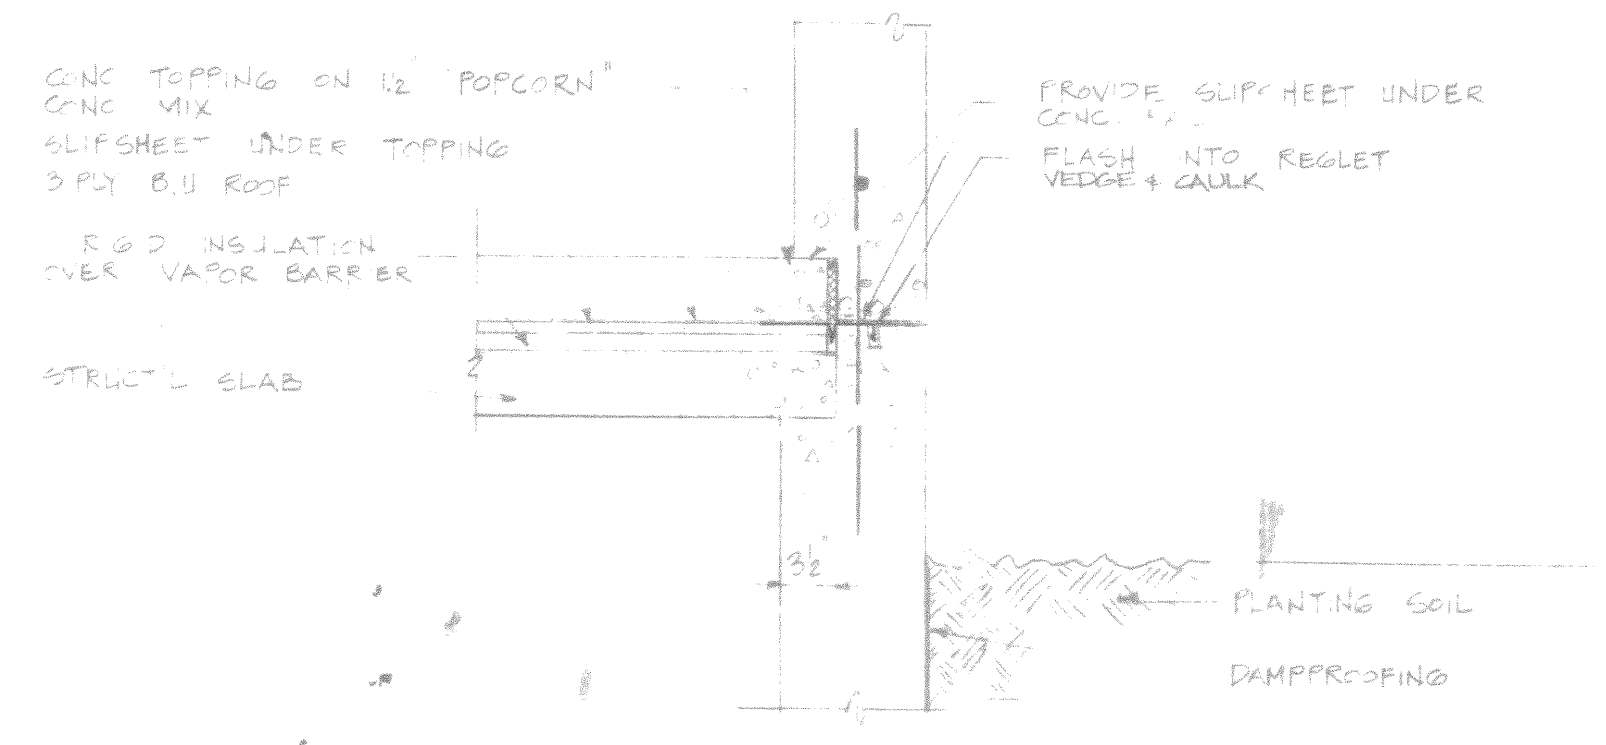


6
A7
1" = 1'-0"

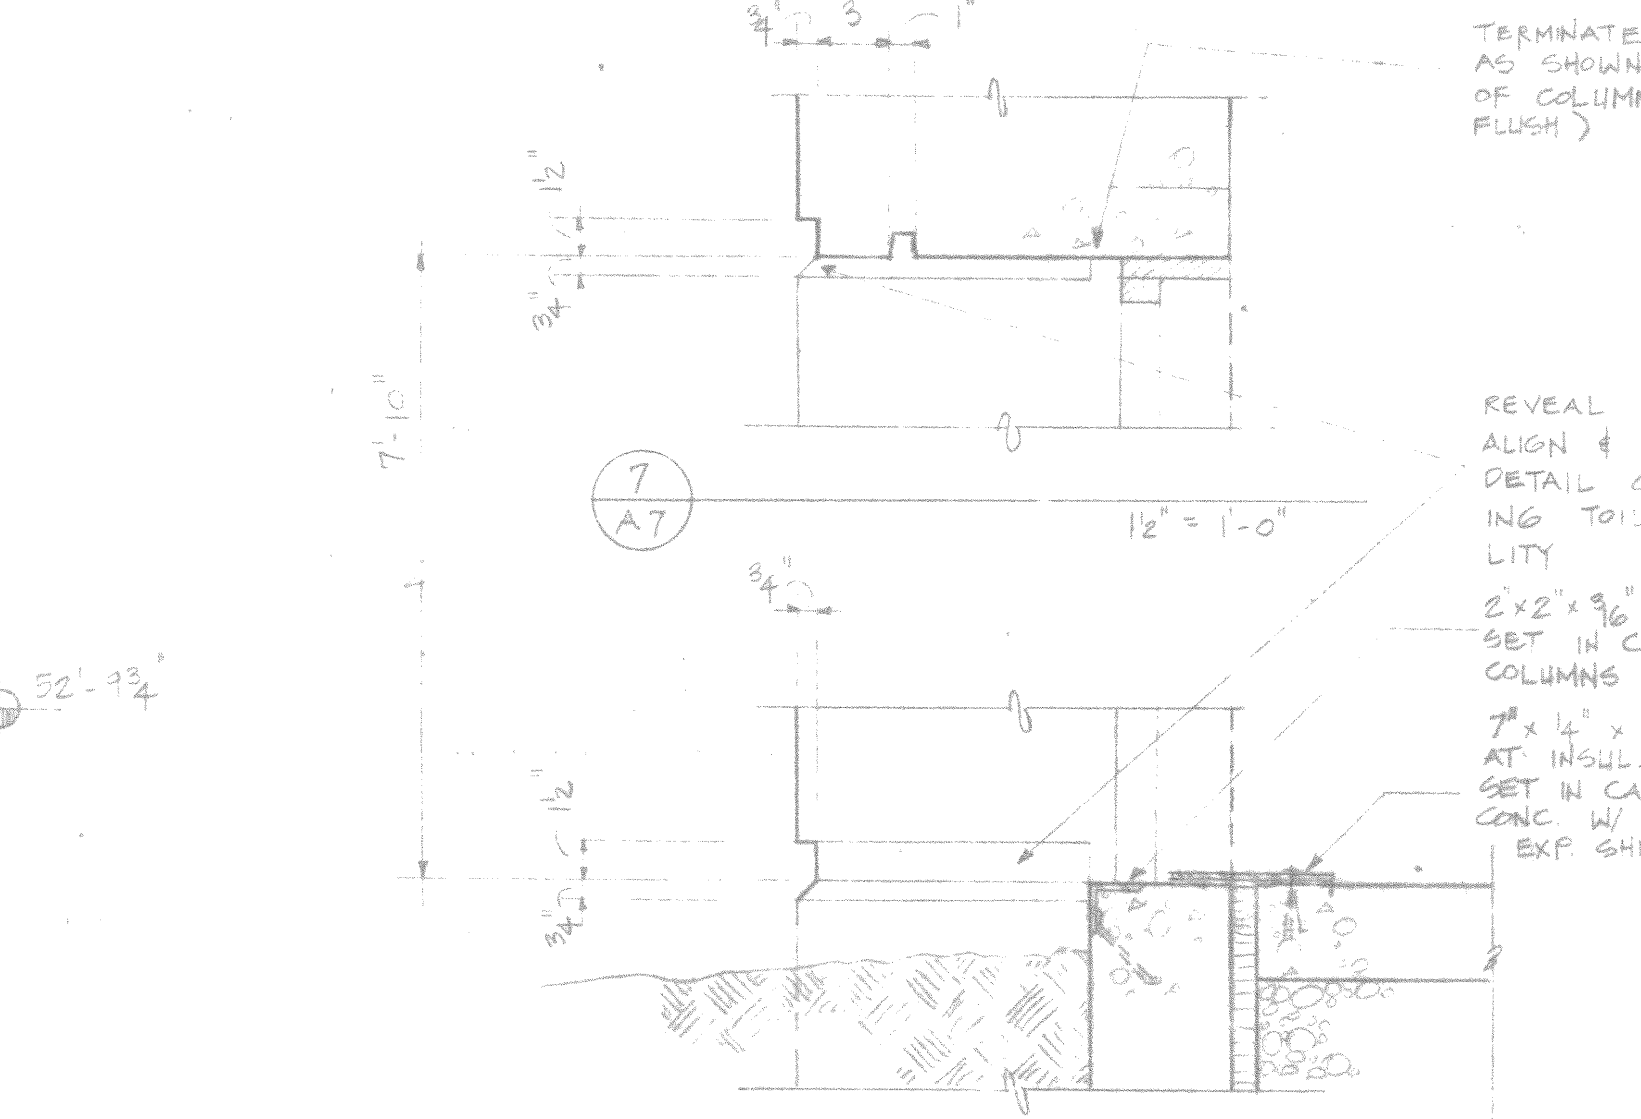

7
A7
1" = 1'-0"

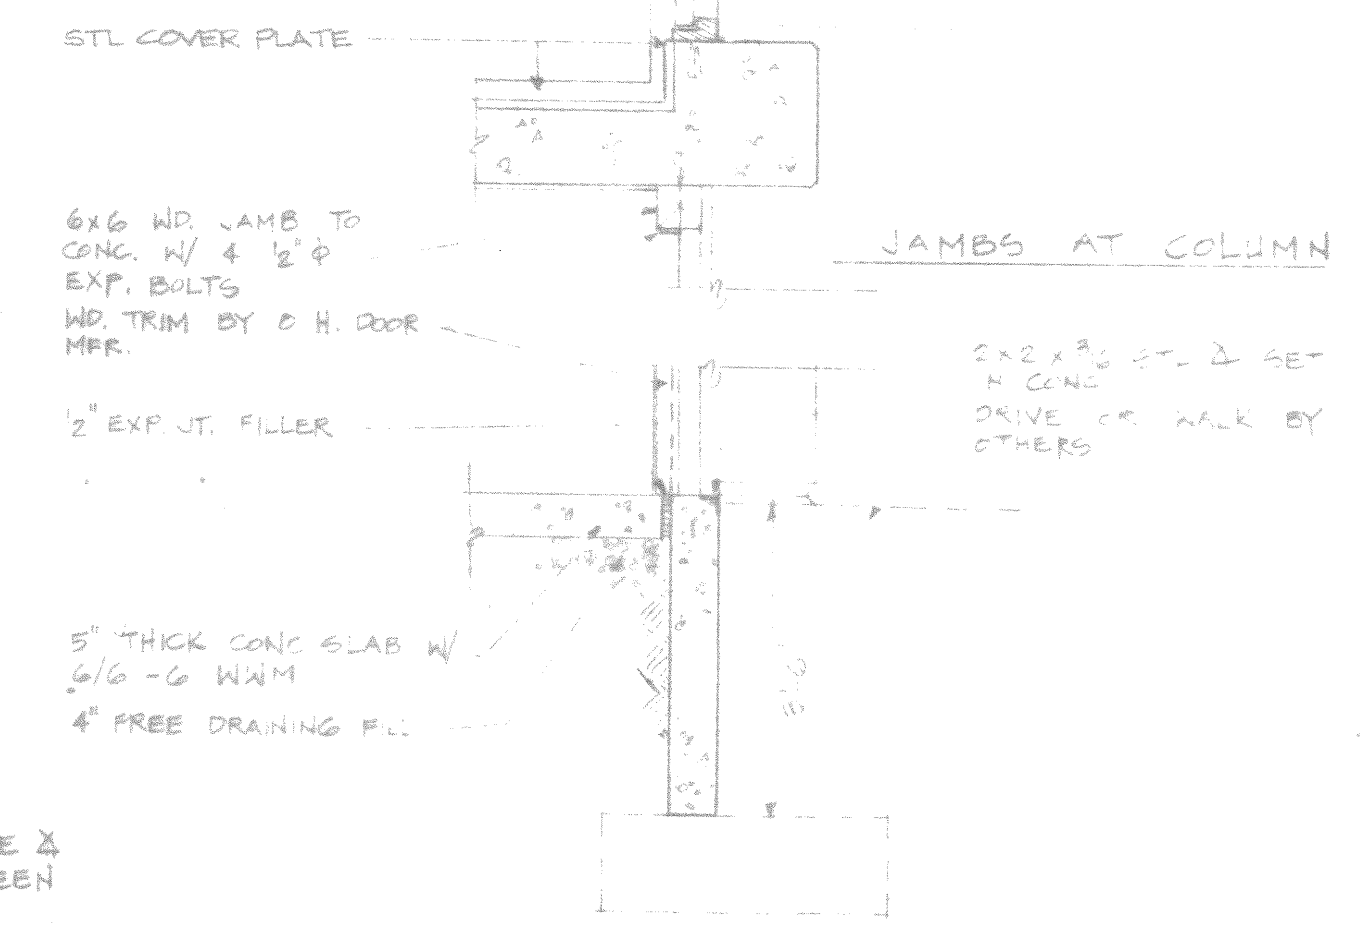

9
A7
1" = 1'-0"

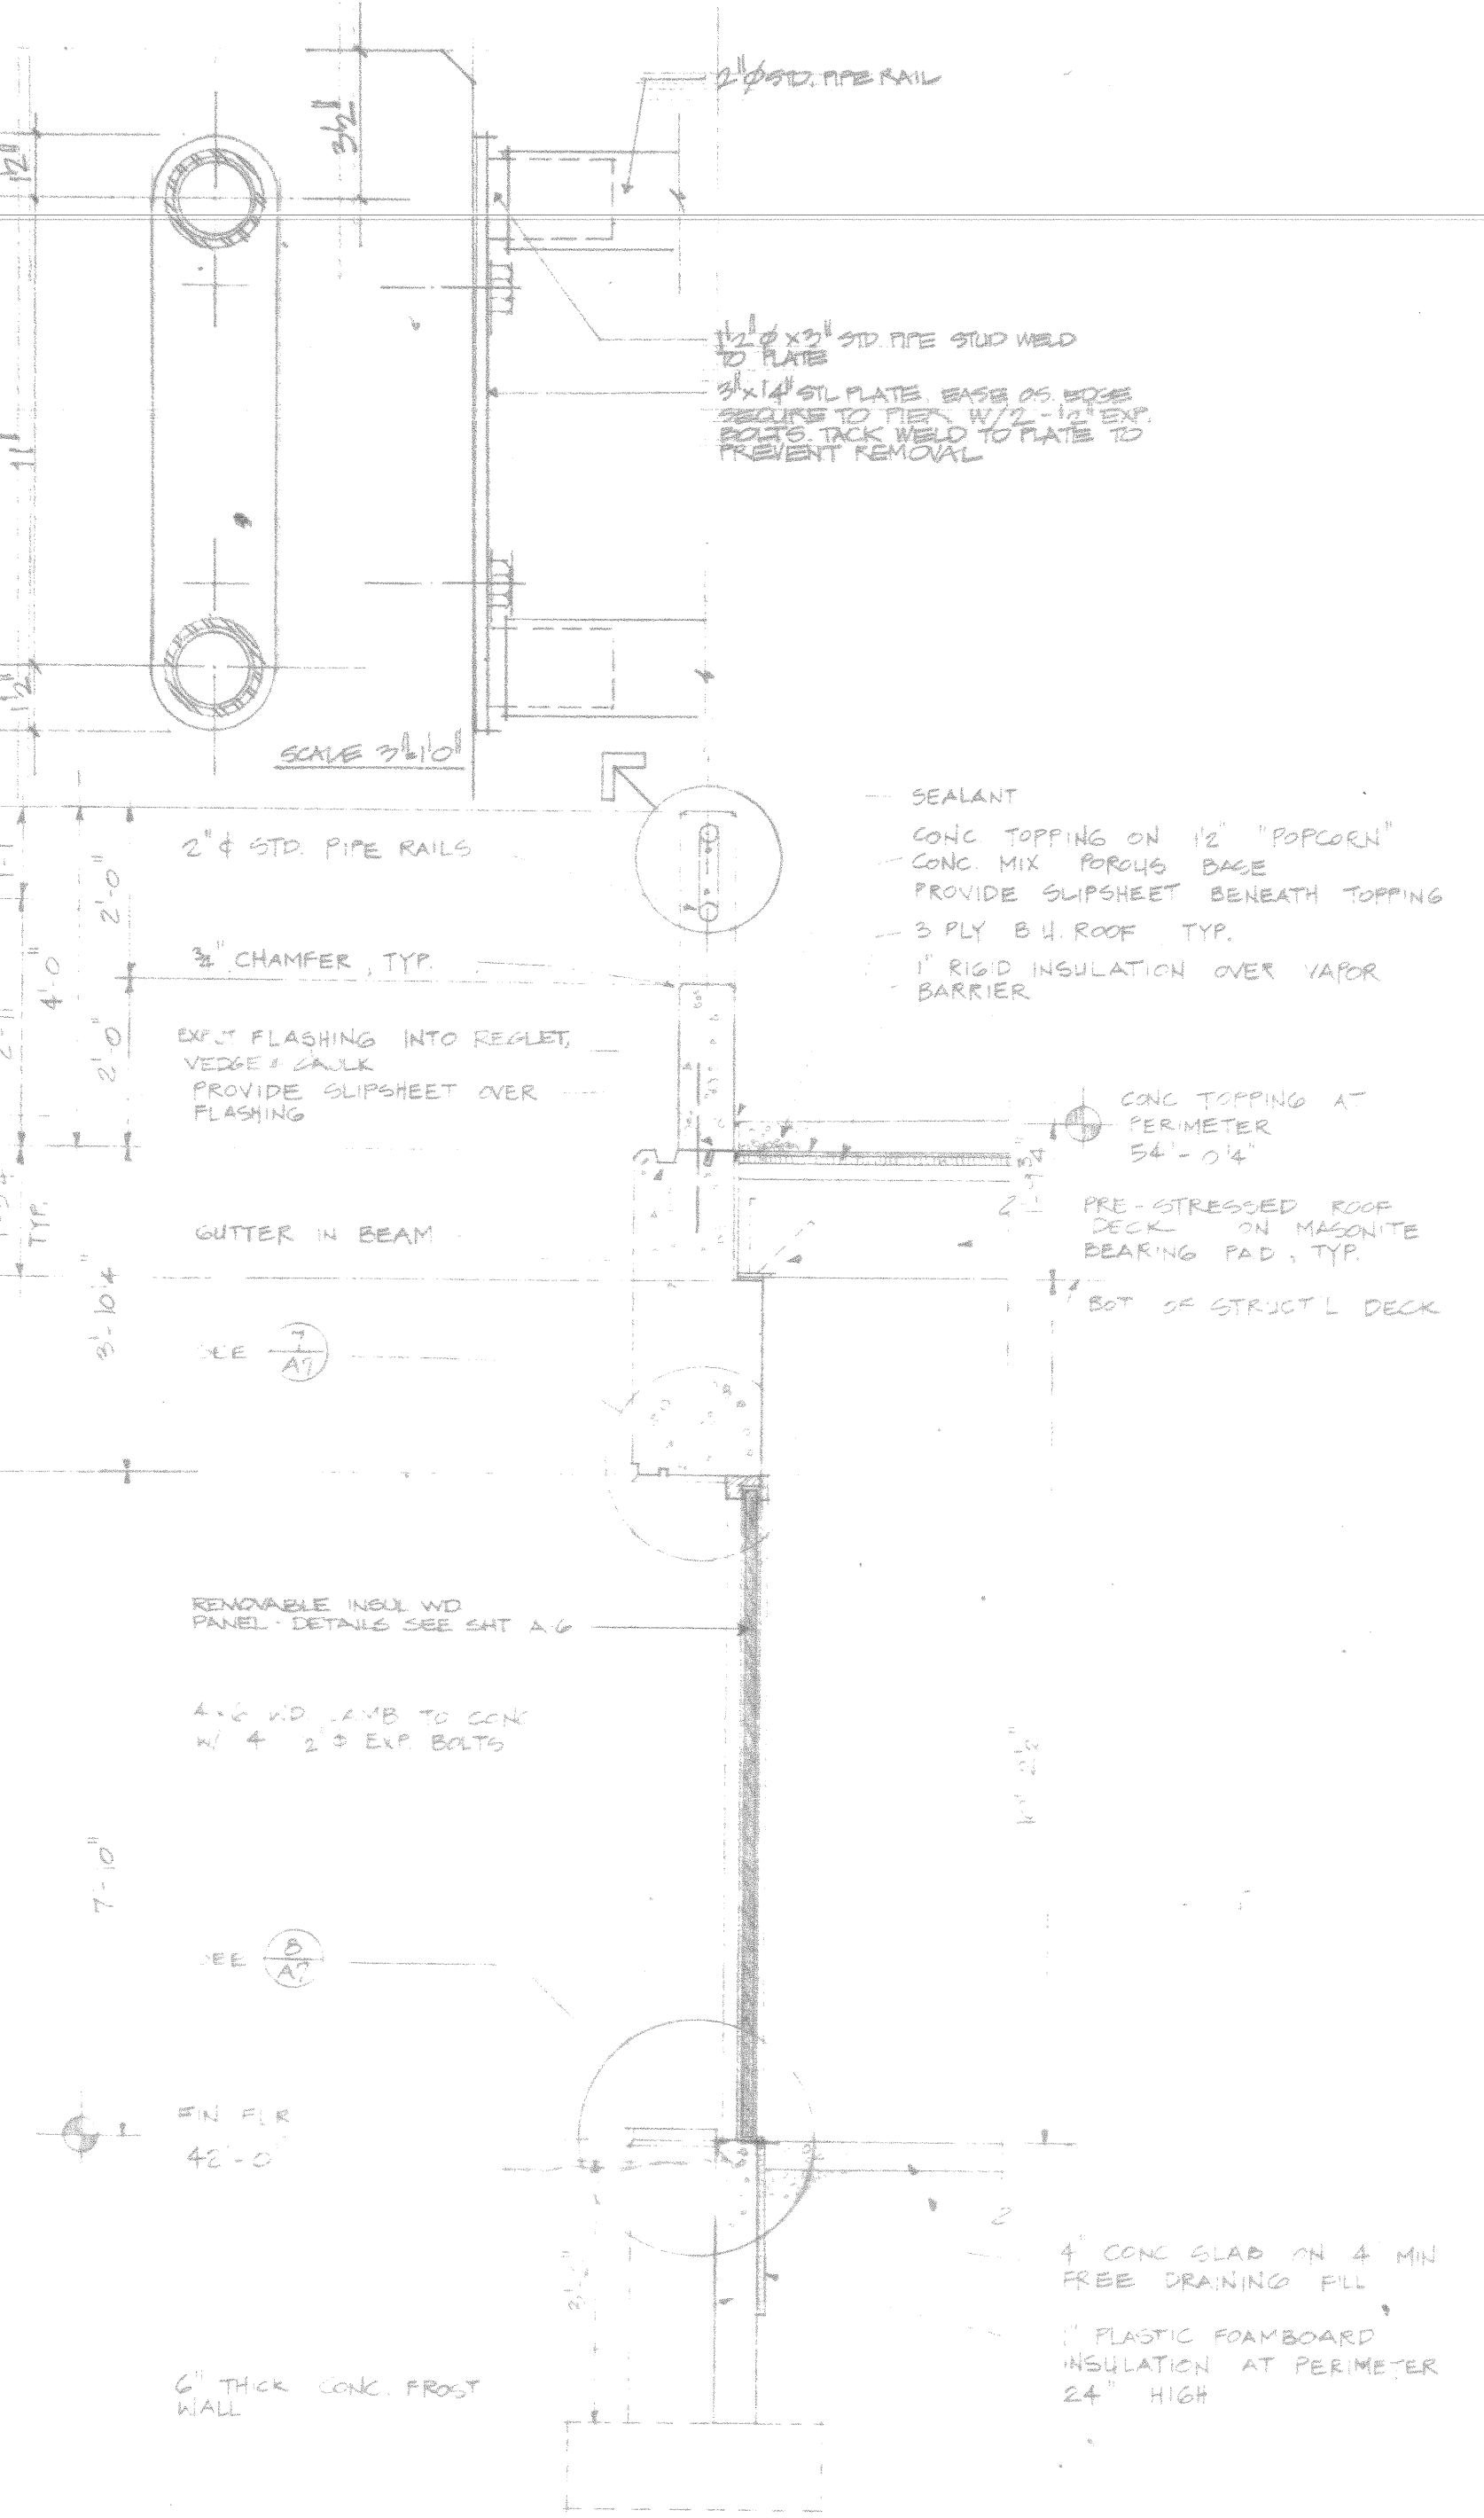

10
A7
1" = 1'-0"

DESIGN LIVE LOADS

ROOF PATIO 100 psf + 30 psf


DESIGN STRESSES

CONCRETE $f'_c = 3000 \text{ psi}$
 REINFORCING STEEL $f_y = 60,000 \text{ psi}$
 SOIL BEARING 4000 psf


COLUMN FOOTING SCHEDULE

MARK	SIZE	REINFORCING
F-1	2'-0" SQ x 10"	3#4 EA. WAY B.
F-2	3'-0" SQ x 10"	4#4 EA. WAY B.
F-3	3'-9" SQ x 12"	6#4 EA. WAY B.


NOTE: VERIFY ALL RAMP, STAIR AND LANTER DIMENSIONS IN THE FIELD
MAX. SLOPE 1:12 RAKING STAIRS 1:12 MAX. CROSSLAND

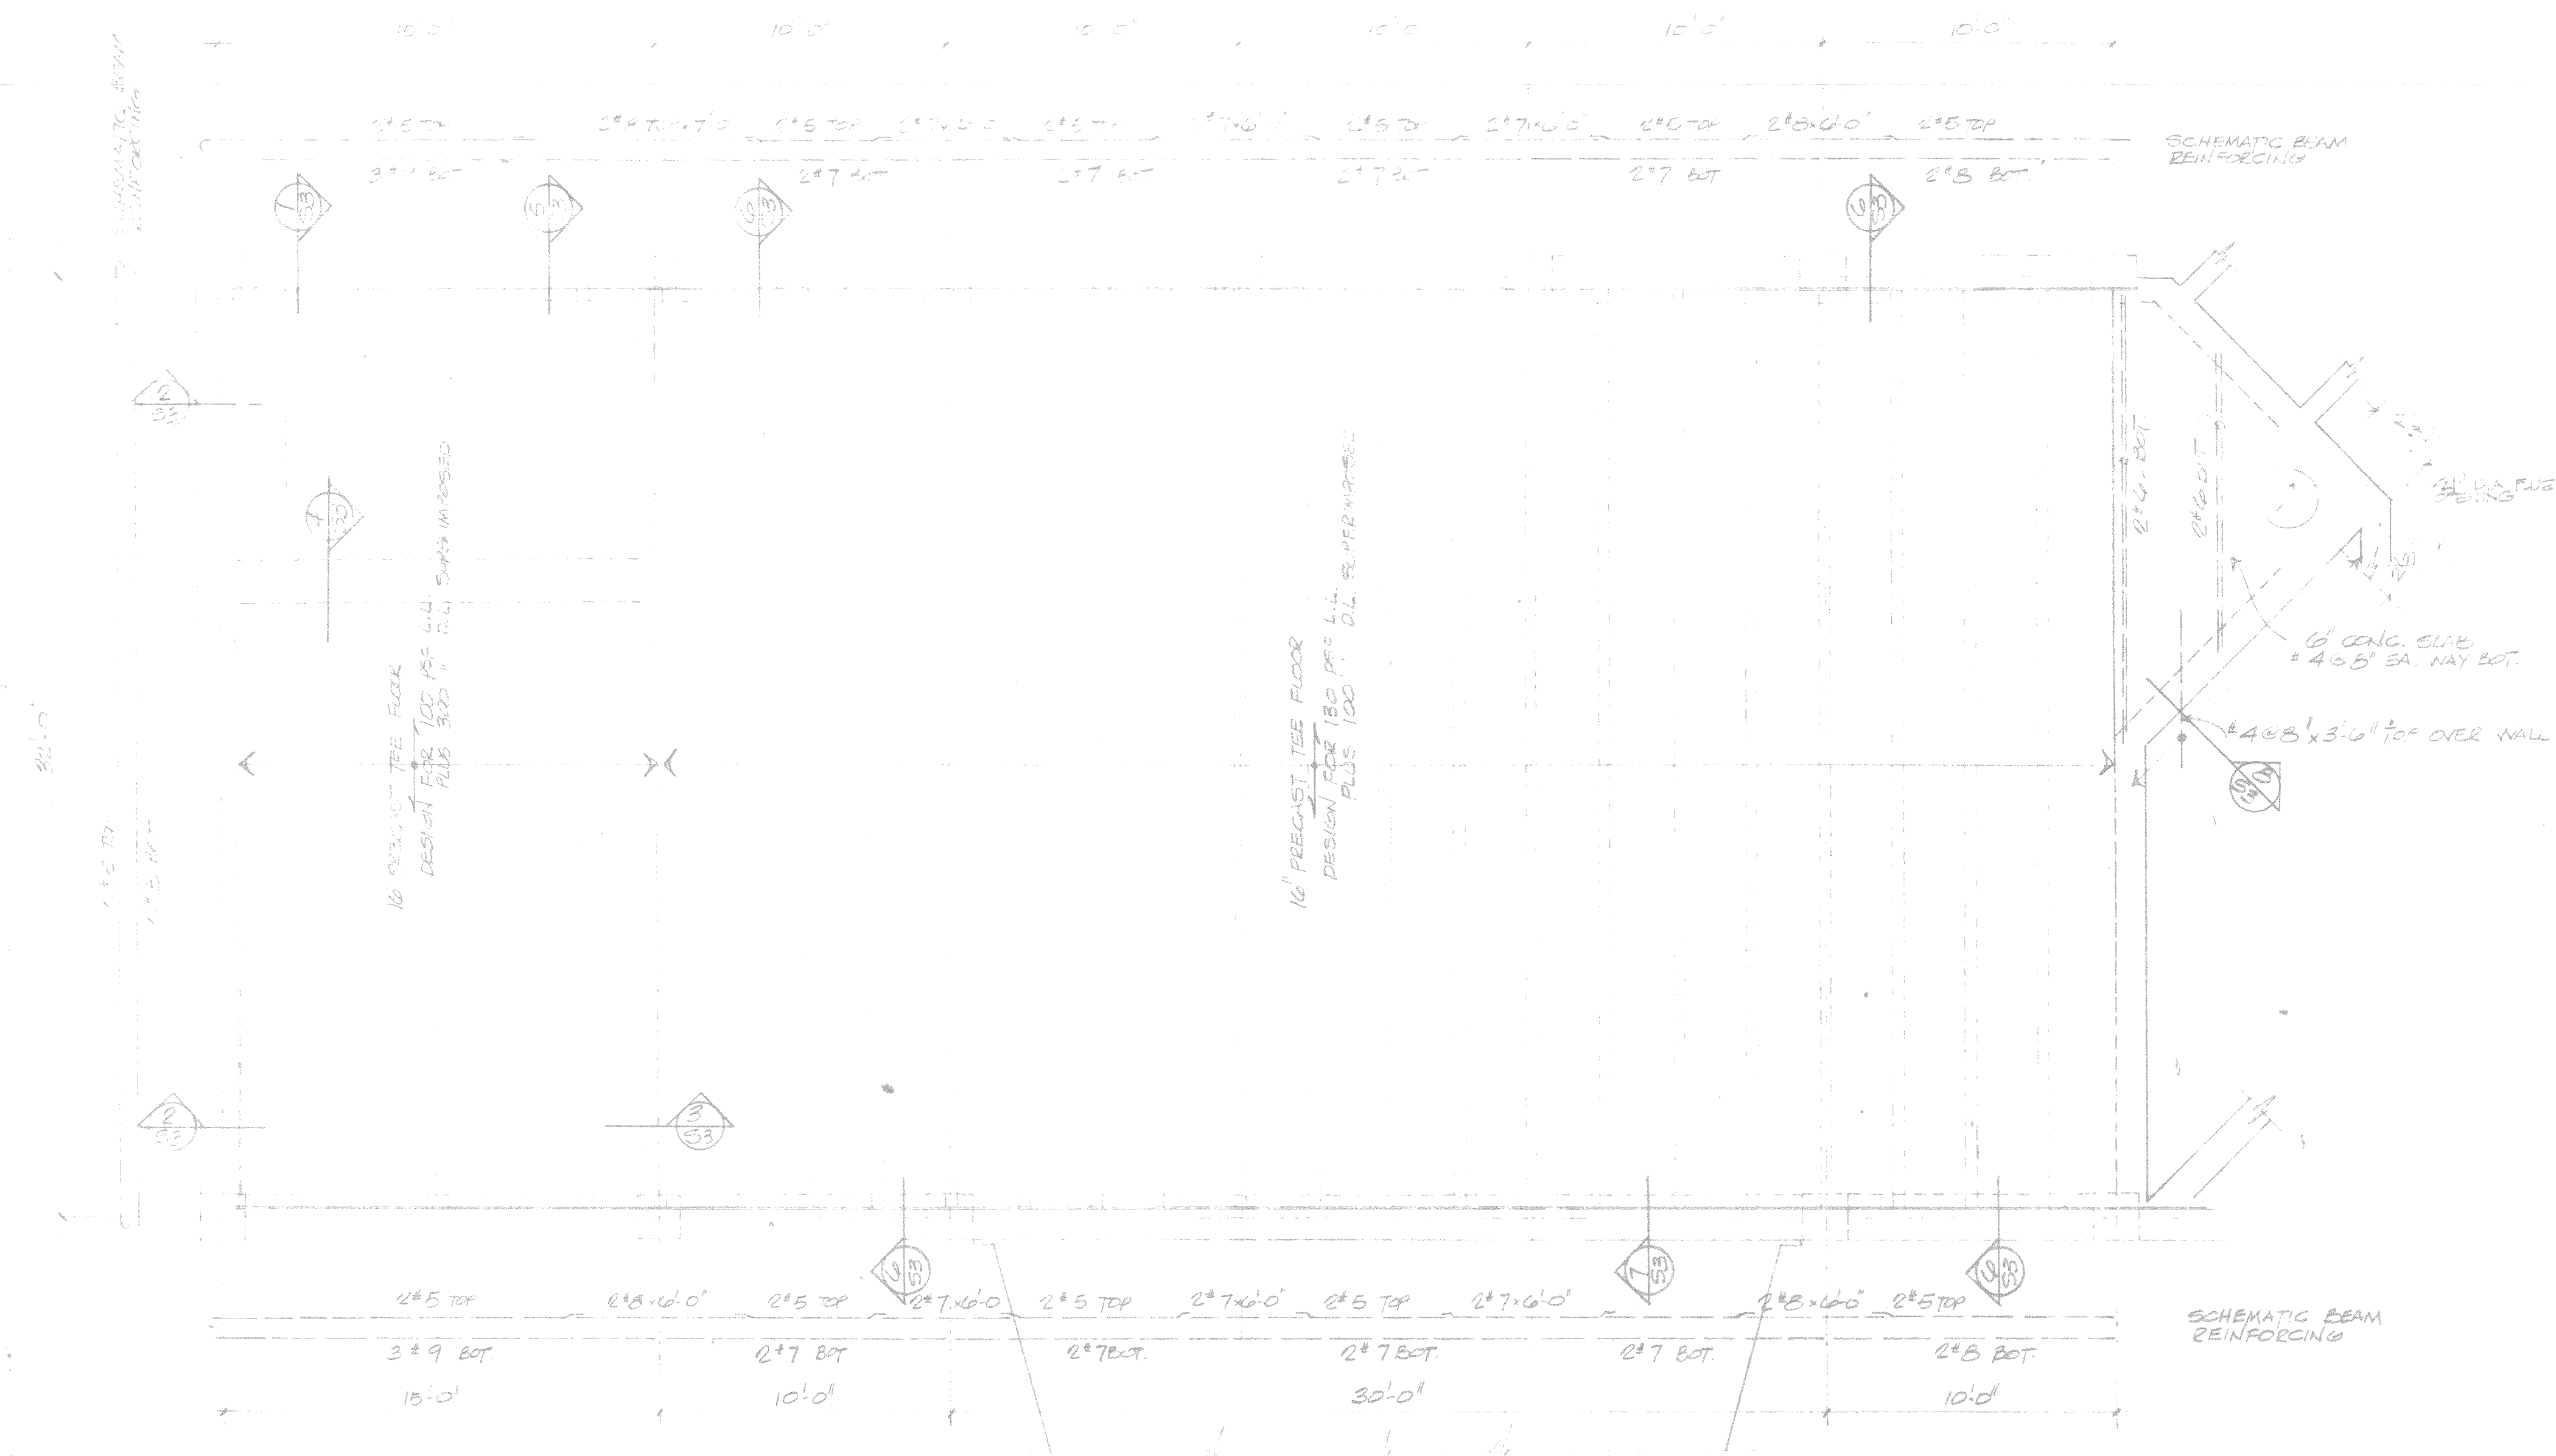

ROOF TERRACE FRAMING PLAN
 1/4" = 1'-0"

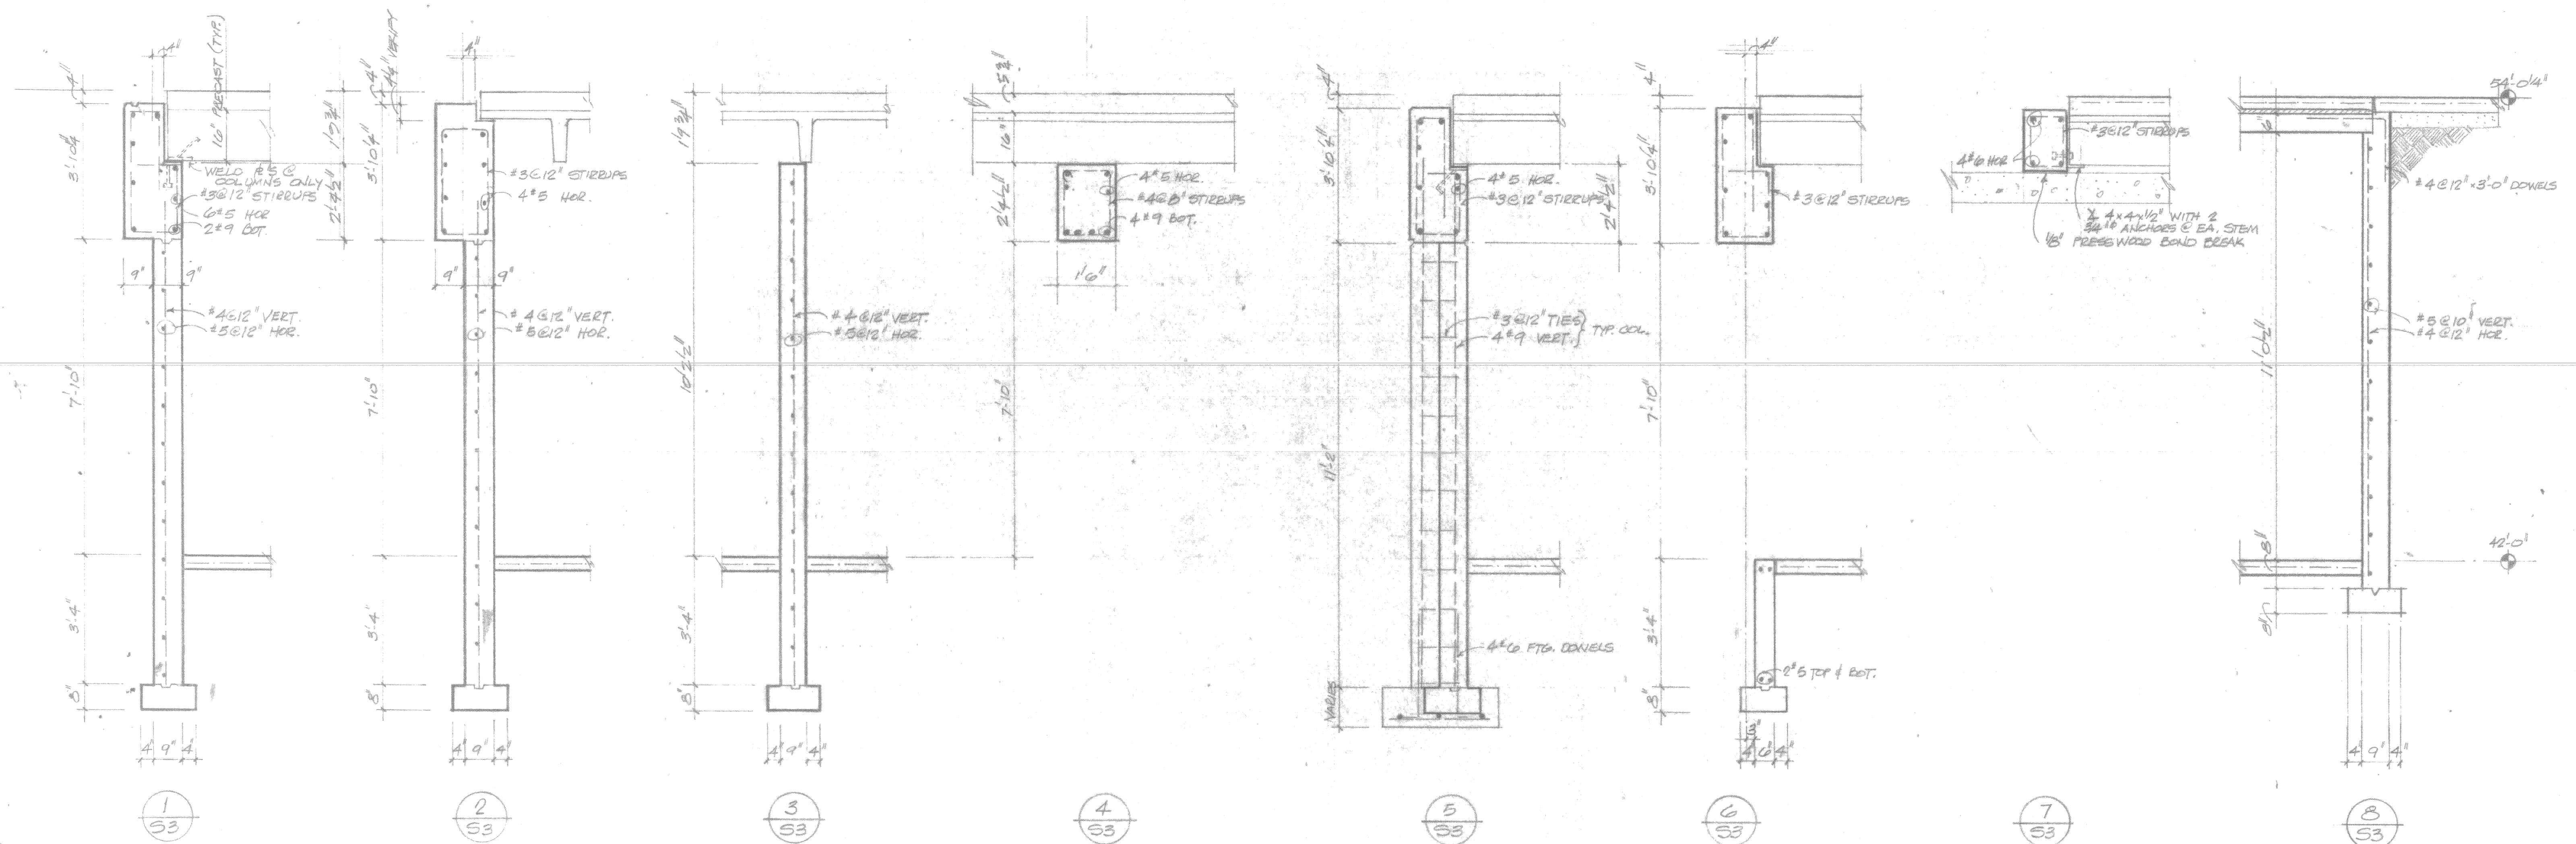

FIXTURE CONNECTION SCHEDULE						
SYMBOL	DESCRIPTION	PIPE SIZE (INCHES DIA.)				REMARKS
		C.W.	H.W.	WASTE	VENT	
P-1	DRINKING FOUNTAIN	1/2"	-	1/4"	1/4"	
P-2	HOSE HYDRANT	1/2"	-	-	-	LOCATE AS TIGHT UNDER DRINKING FOUNTAIN AS POSSIBLE

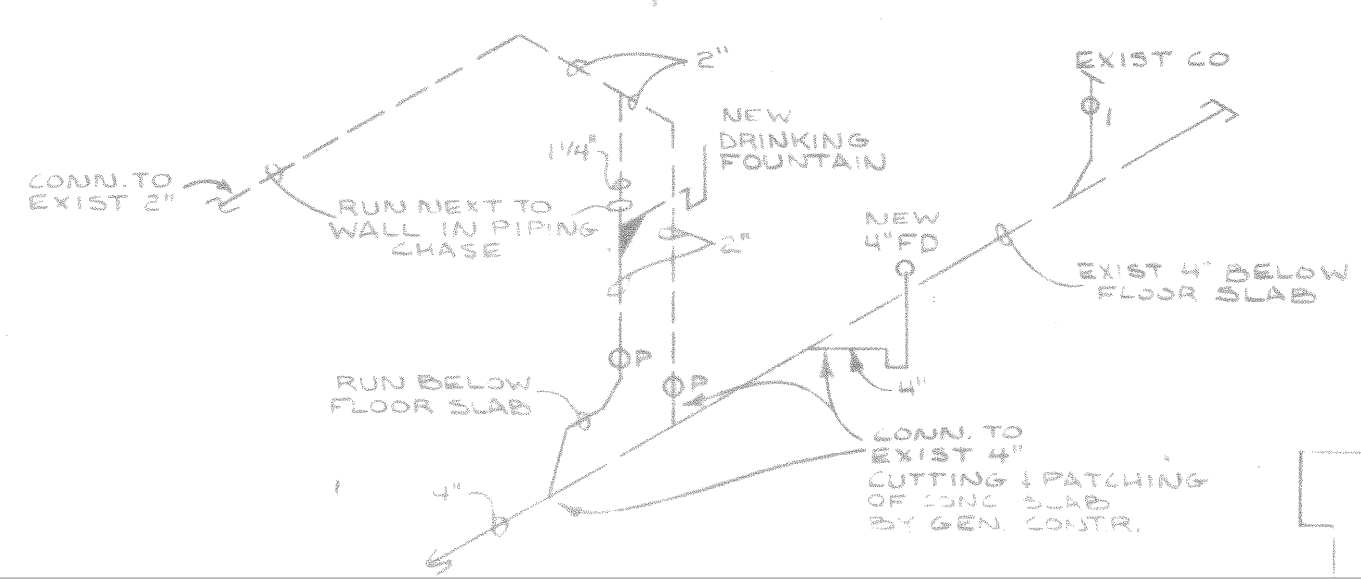

SYMBOL SCHEDULE - PLUMBING	
---	WASTE
---	VENT
---	COLD WATER
---	HEATED WATER
G	GAS
L	GAS DRIP LEAK
V	GAS PLUG VALVE
U	UNION
C	CAPPED OR PLUGGED PIPE
G	GATE VALVE
S	SHOCK ARRESTOR
CO	CLEAN OUT


SHOCK ARRESTOR SCHEDULE				
SYMBOL	MFG.	MODEL NO.	P.D. RATING	MAX. F.U. CAP.
A	WADE	W-5	A	11
B	WADE	W-10	B	32

FIXTURE SCHEDULE - ELECTRICAL						
SYMBOL	MANUFACTURE	CATALOG NO.	WATTAGE	MOUNTING	FIN.	REMARKS
A	SPERO ELECTRIC	100-ENV	100 W-MV	SURFACE	CAST ALUMINUM	①
B	P.E.S.	110	100 W	SURFACE	PORCELAIN	①
C	PRESCOLITE	93020	175 W-MV	WALL SURFACE	TEXTURED BLACK ENAMEL	②



- ① MOUNT BETWEEN TEES OF PRECAST CONC. DECK
- ② SEE ARCH. DWGS. FOR LOCATION ON CHIMNEY, RUN SEPARATE CIRCUIT TO PANEL, CONTROL WITH TIME CLOCK

- SYMBOL LIST - ELECTRICAL
- SURFACE FIXTURE - INCANDESCENT OR MERCURY
 - SINGLE POLE SWITCH
 - SURFACE MOUNTED MERCURY VAPOR LAMP
 - MOTOR
 - MOTOR DISCONNECT
 - PANEL
 - HOME RUN CONNECTION
 - EQUIPMENT CONNECTION






- SYMBOLS - HEATING
- SUPPLY DUCT
 - RETURN AIR DUCT
 - M.V.D. MANUAL VOLUME DAMPER
 - S.A.R. SUPPLY AIR REGISTER
 - THERMOSTAT

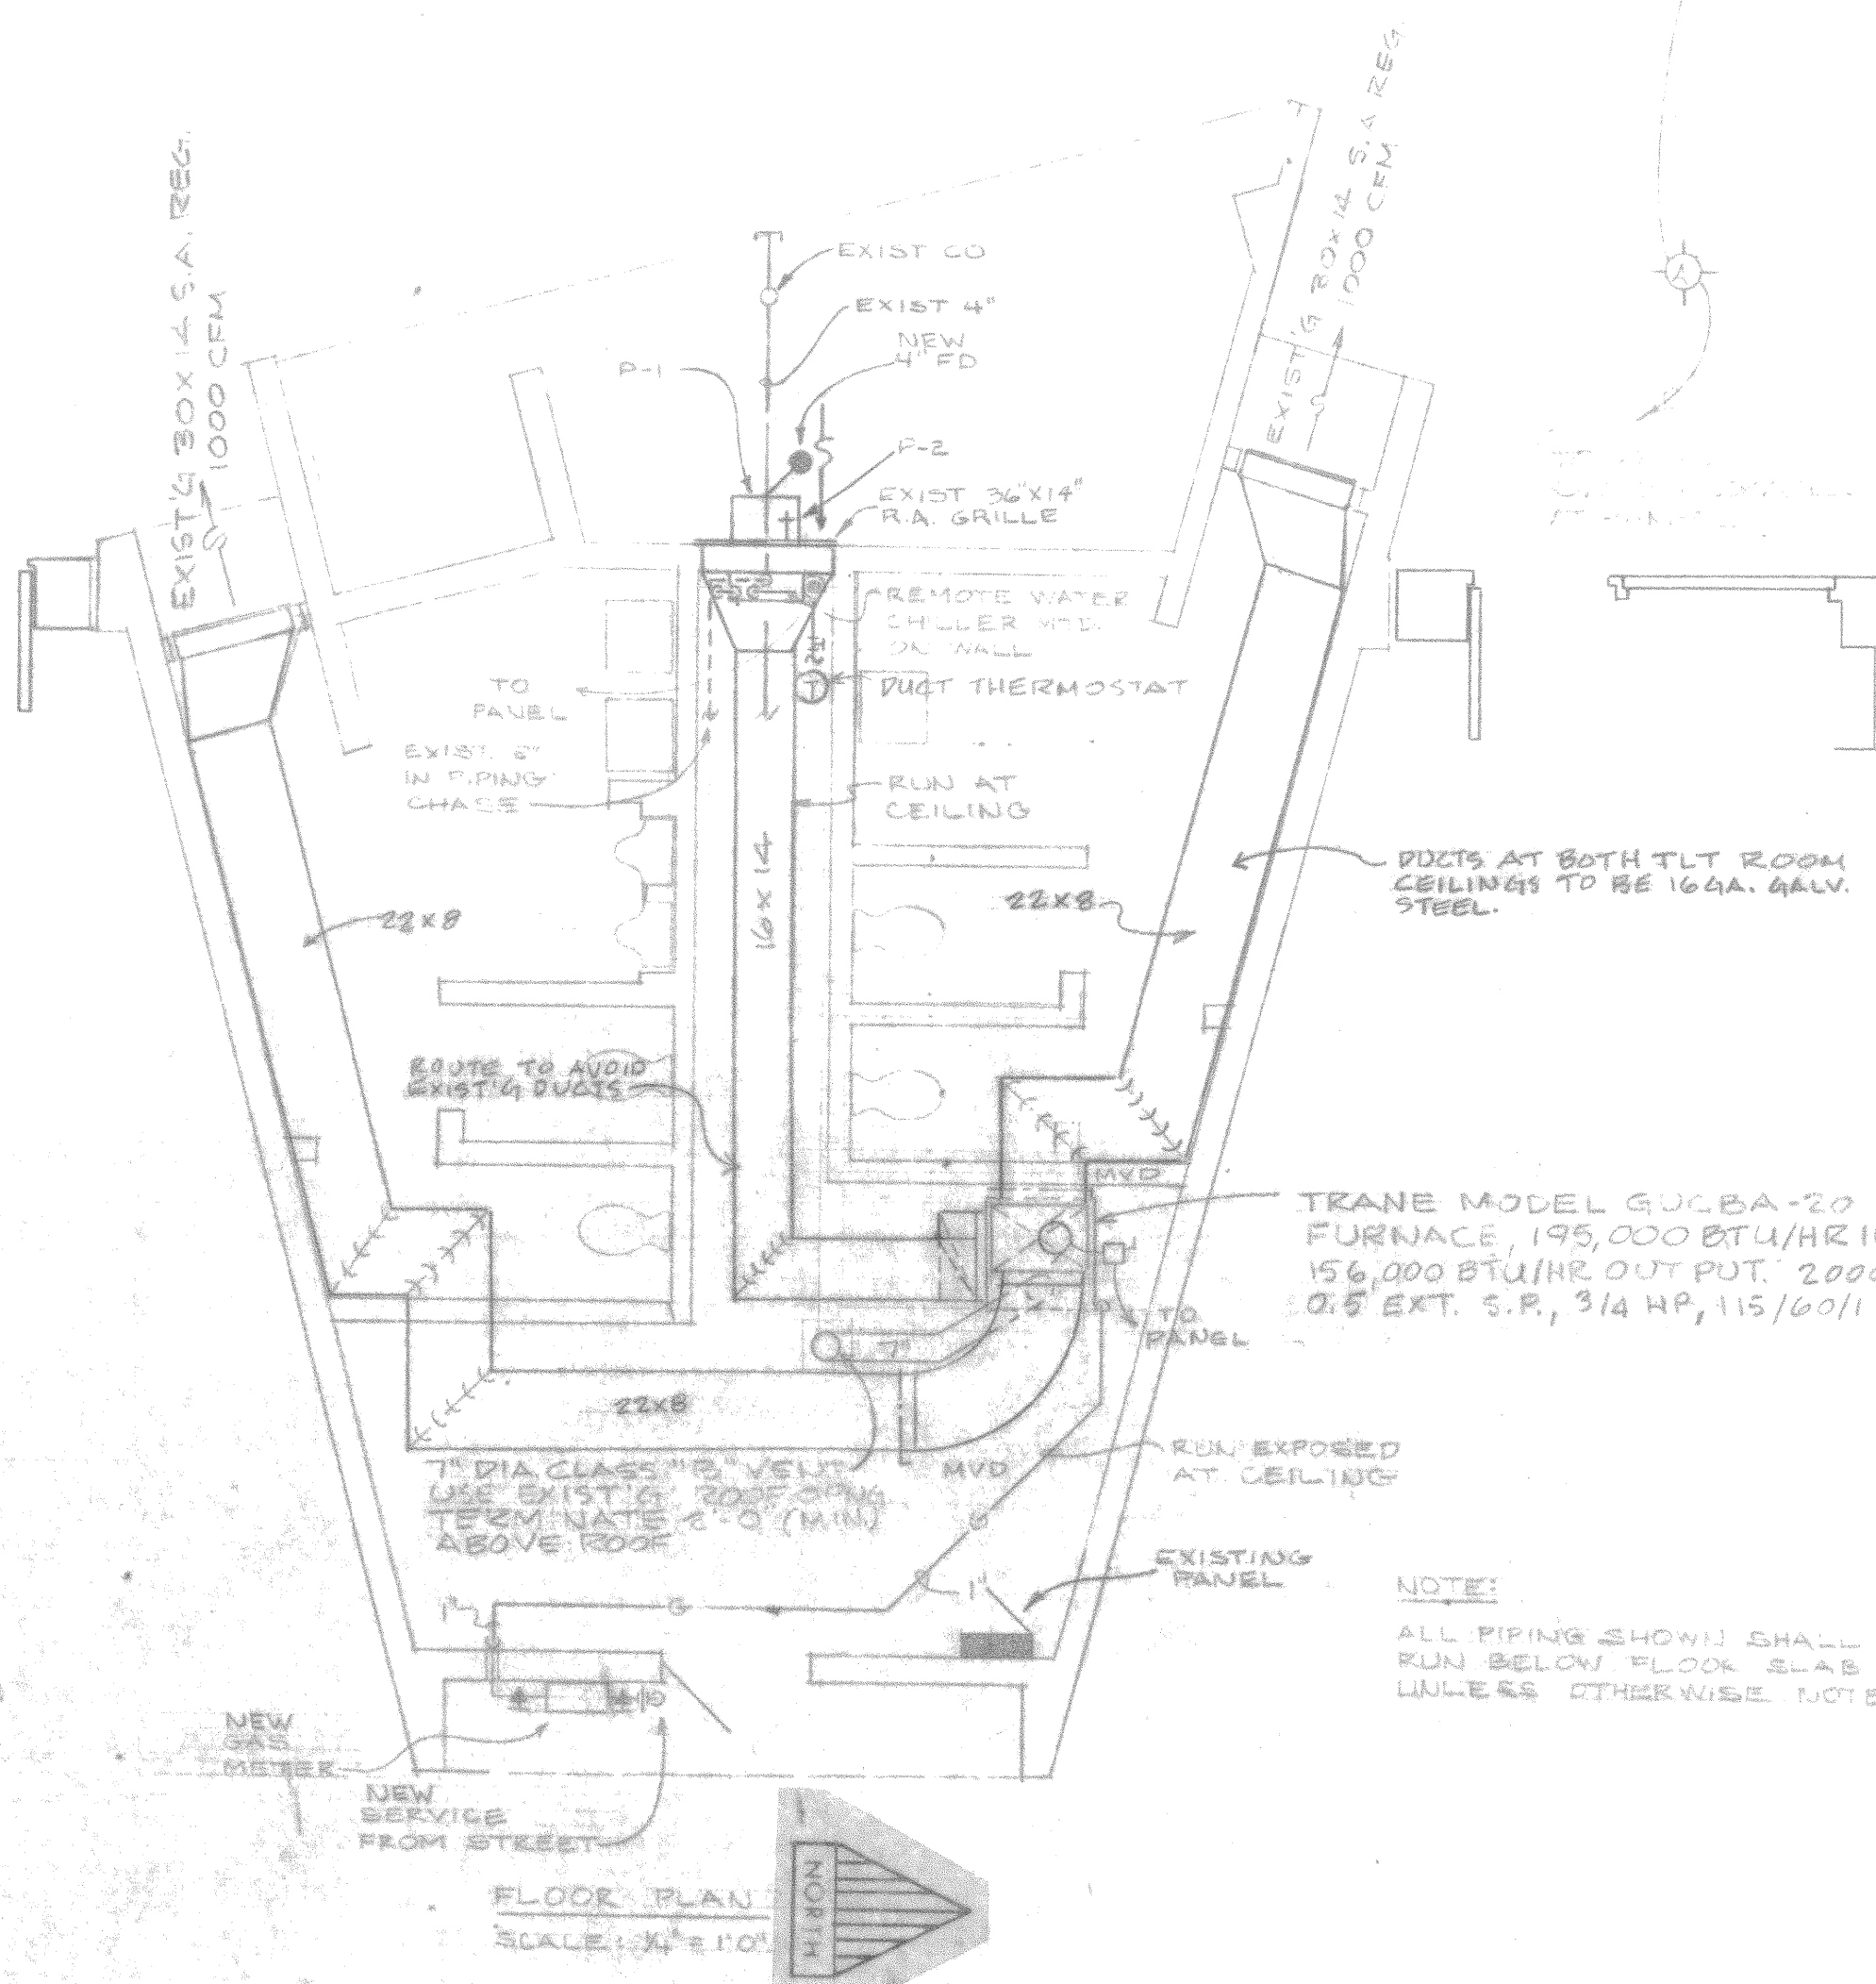

NOTE:
ALL PIPING SHOWN SHALL BE RUN BELOW FLOOR SLAB UNLESS OTHERWISE NOTED.

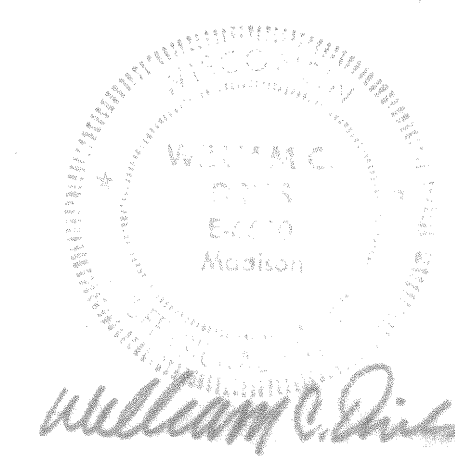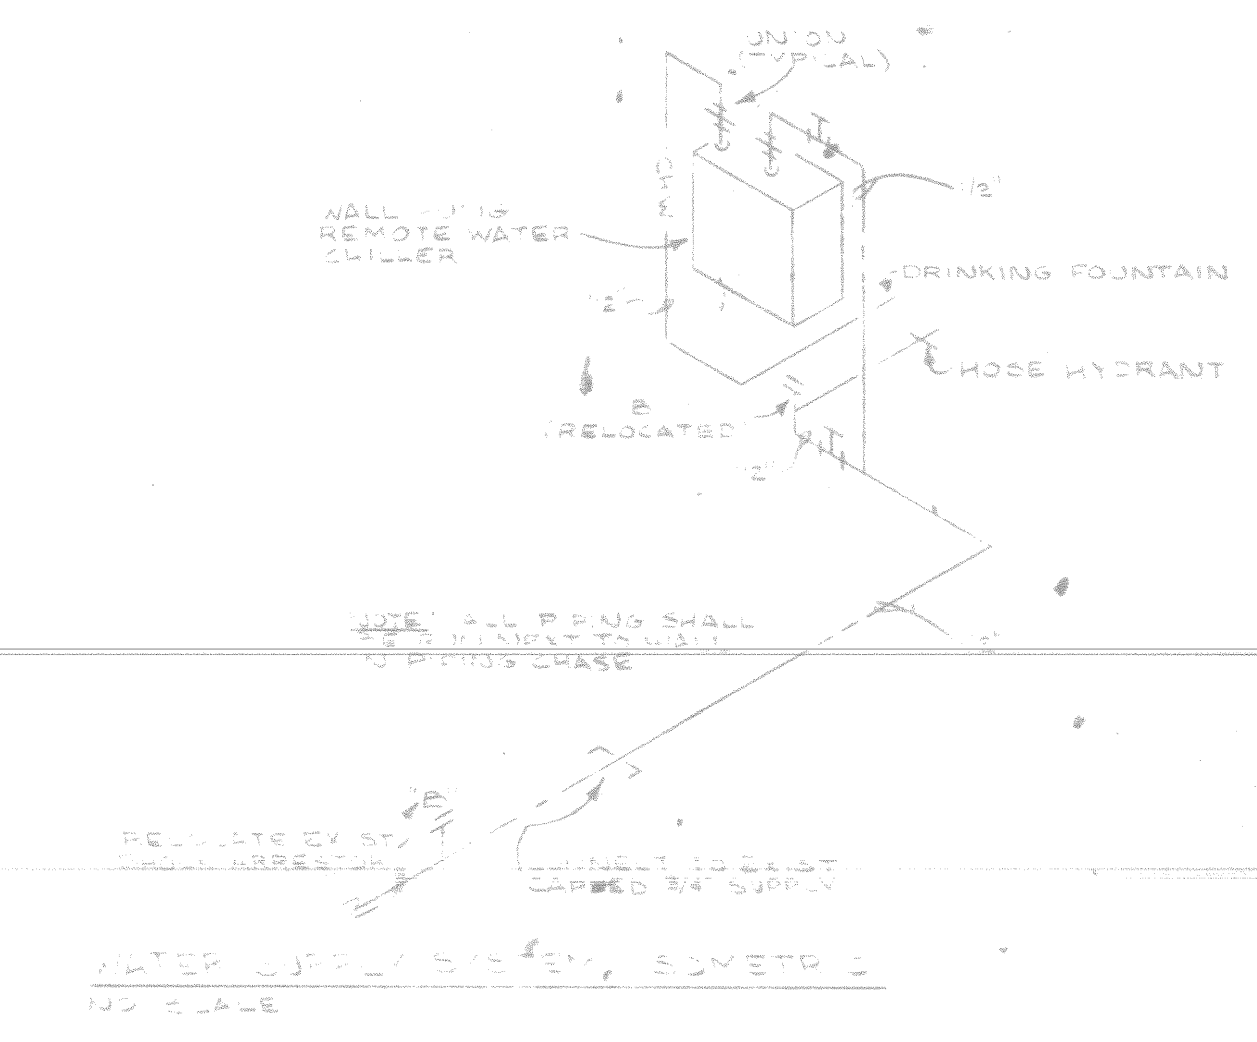

EXISTING CONDITION REFERENCE PLANS
REINDAHL PARK SPLASH PAD - RESTROOM REMODEL
DATED 2021-MAY-19

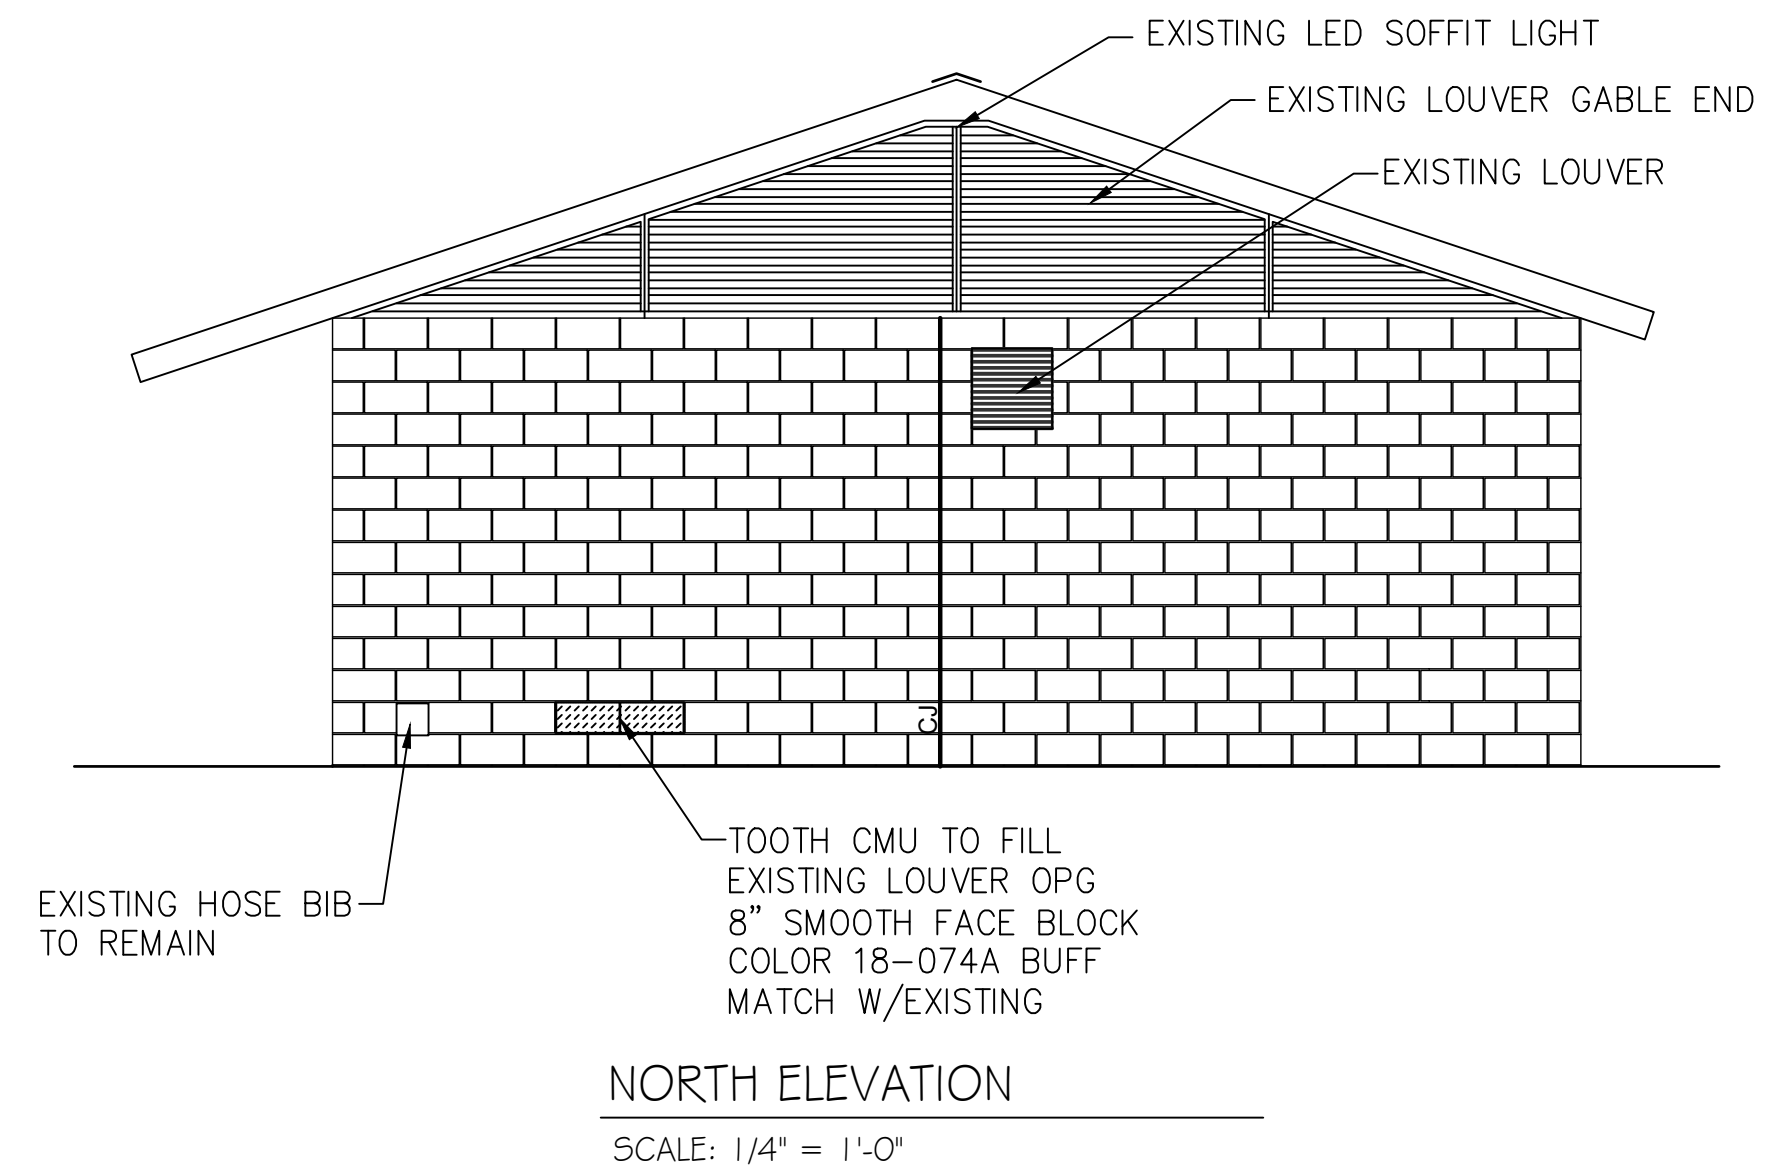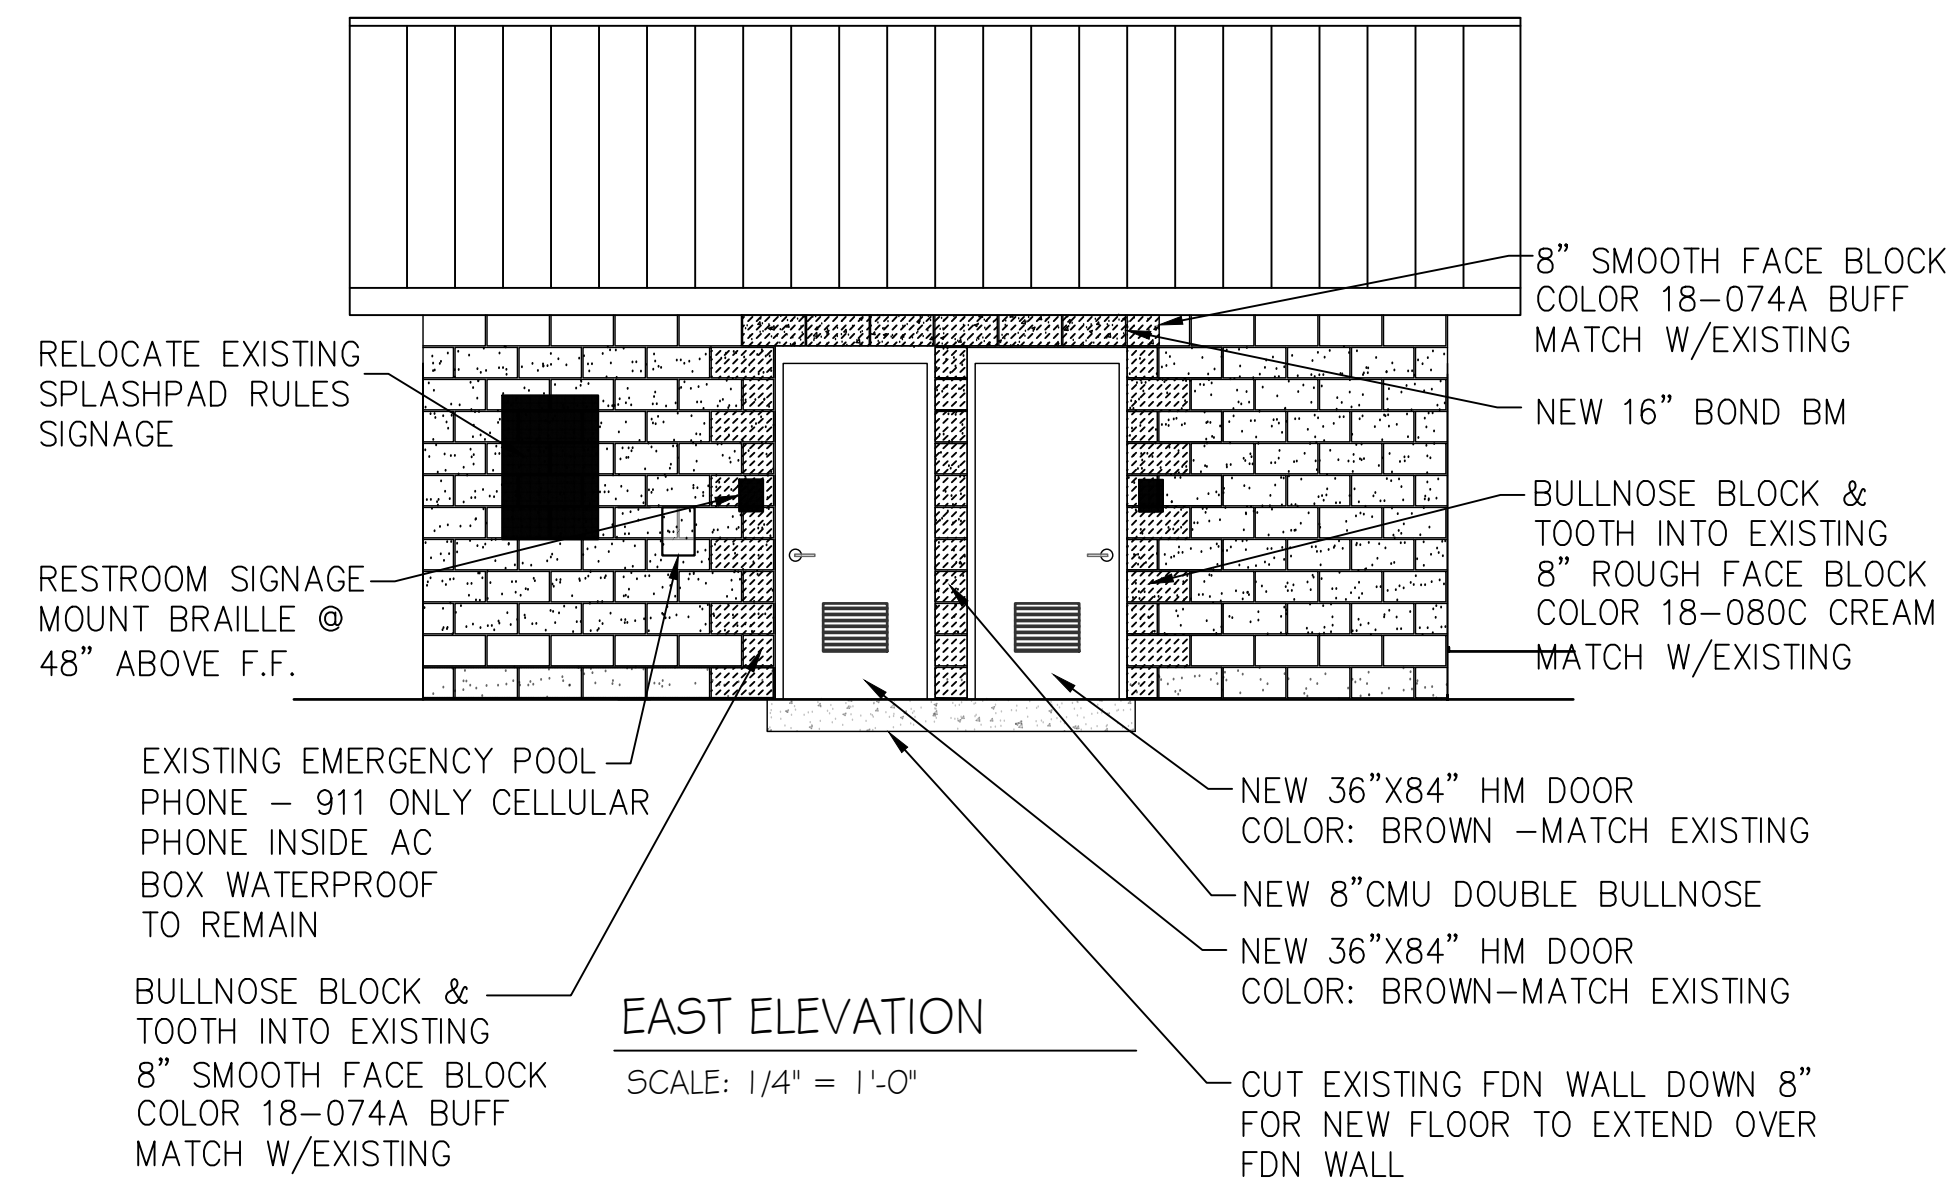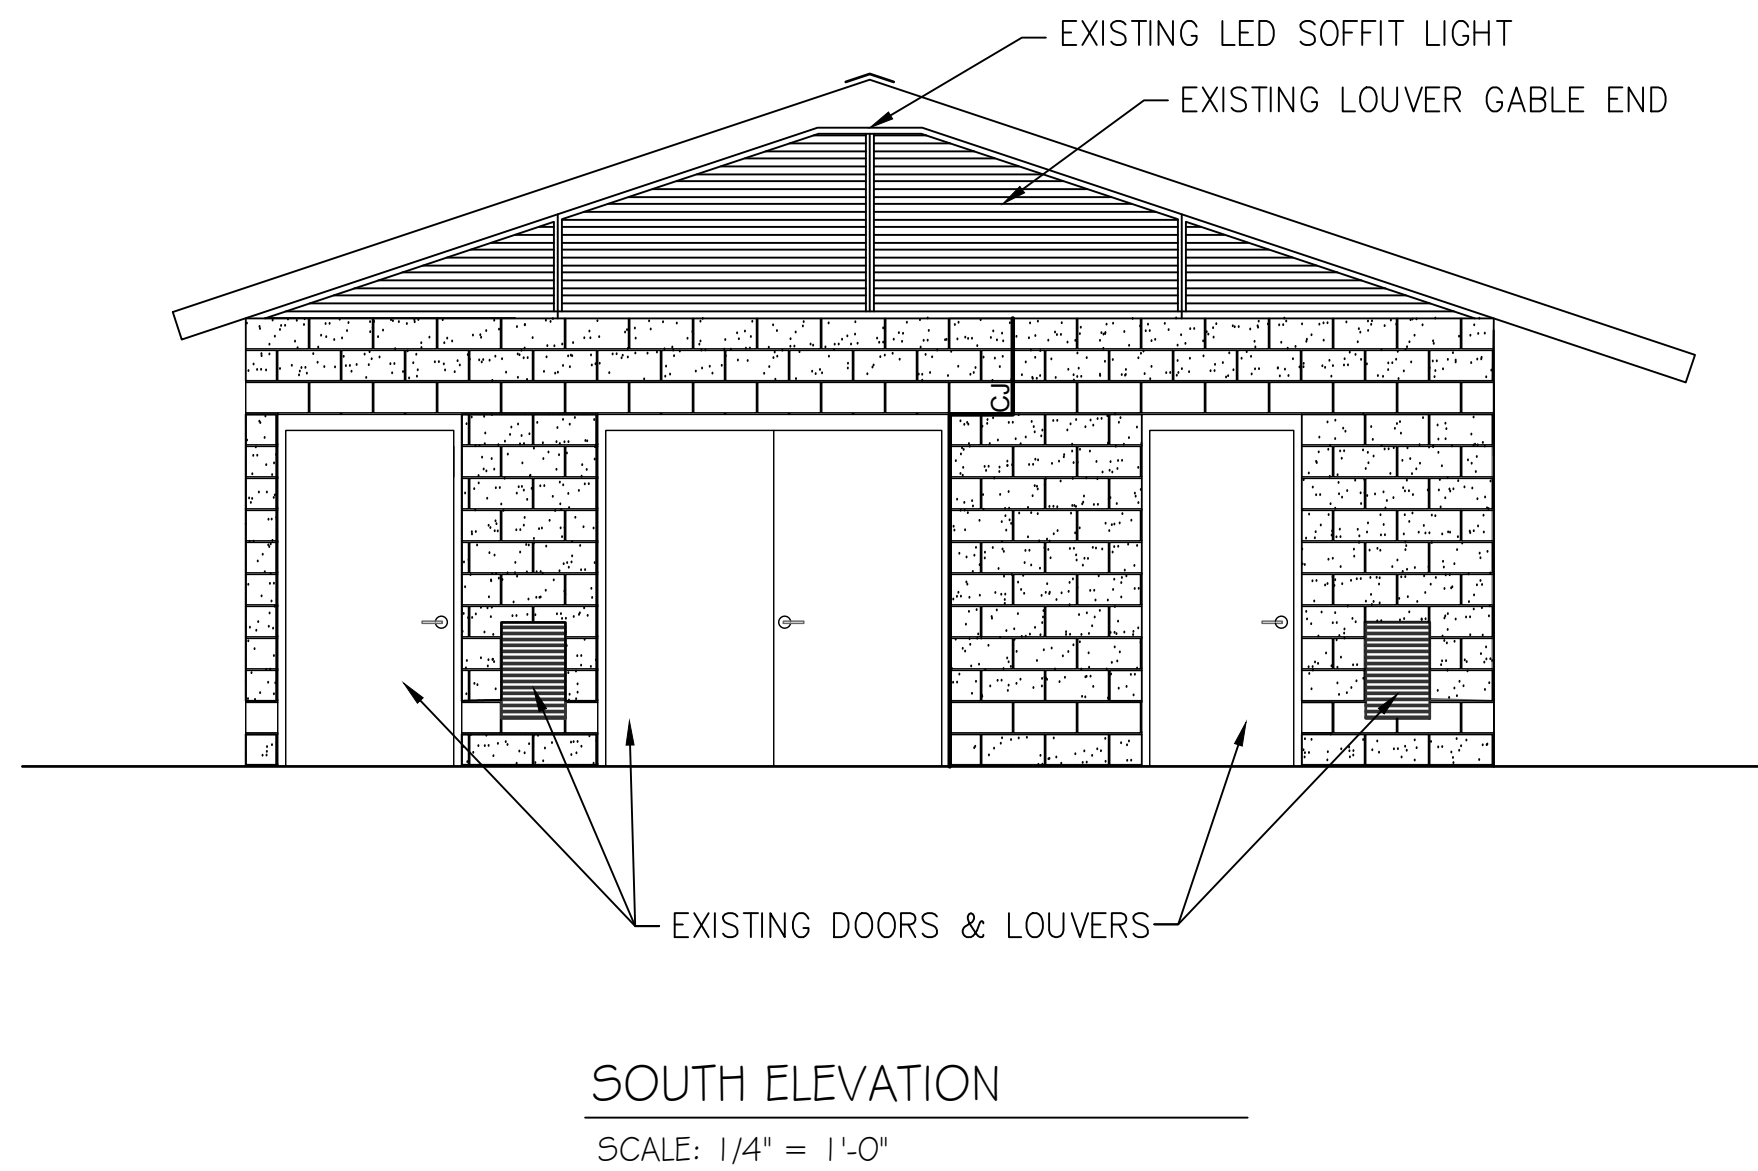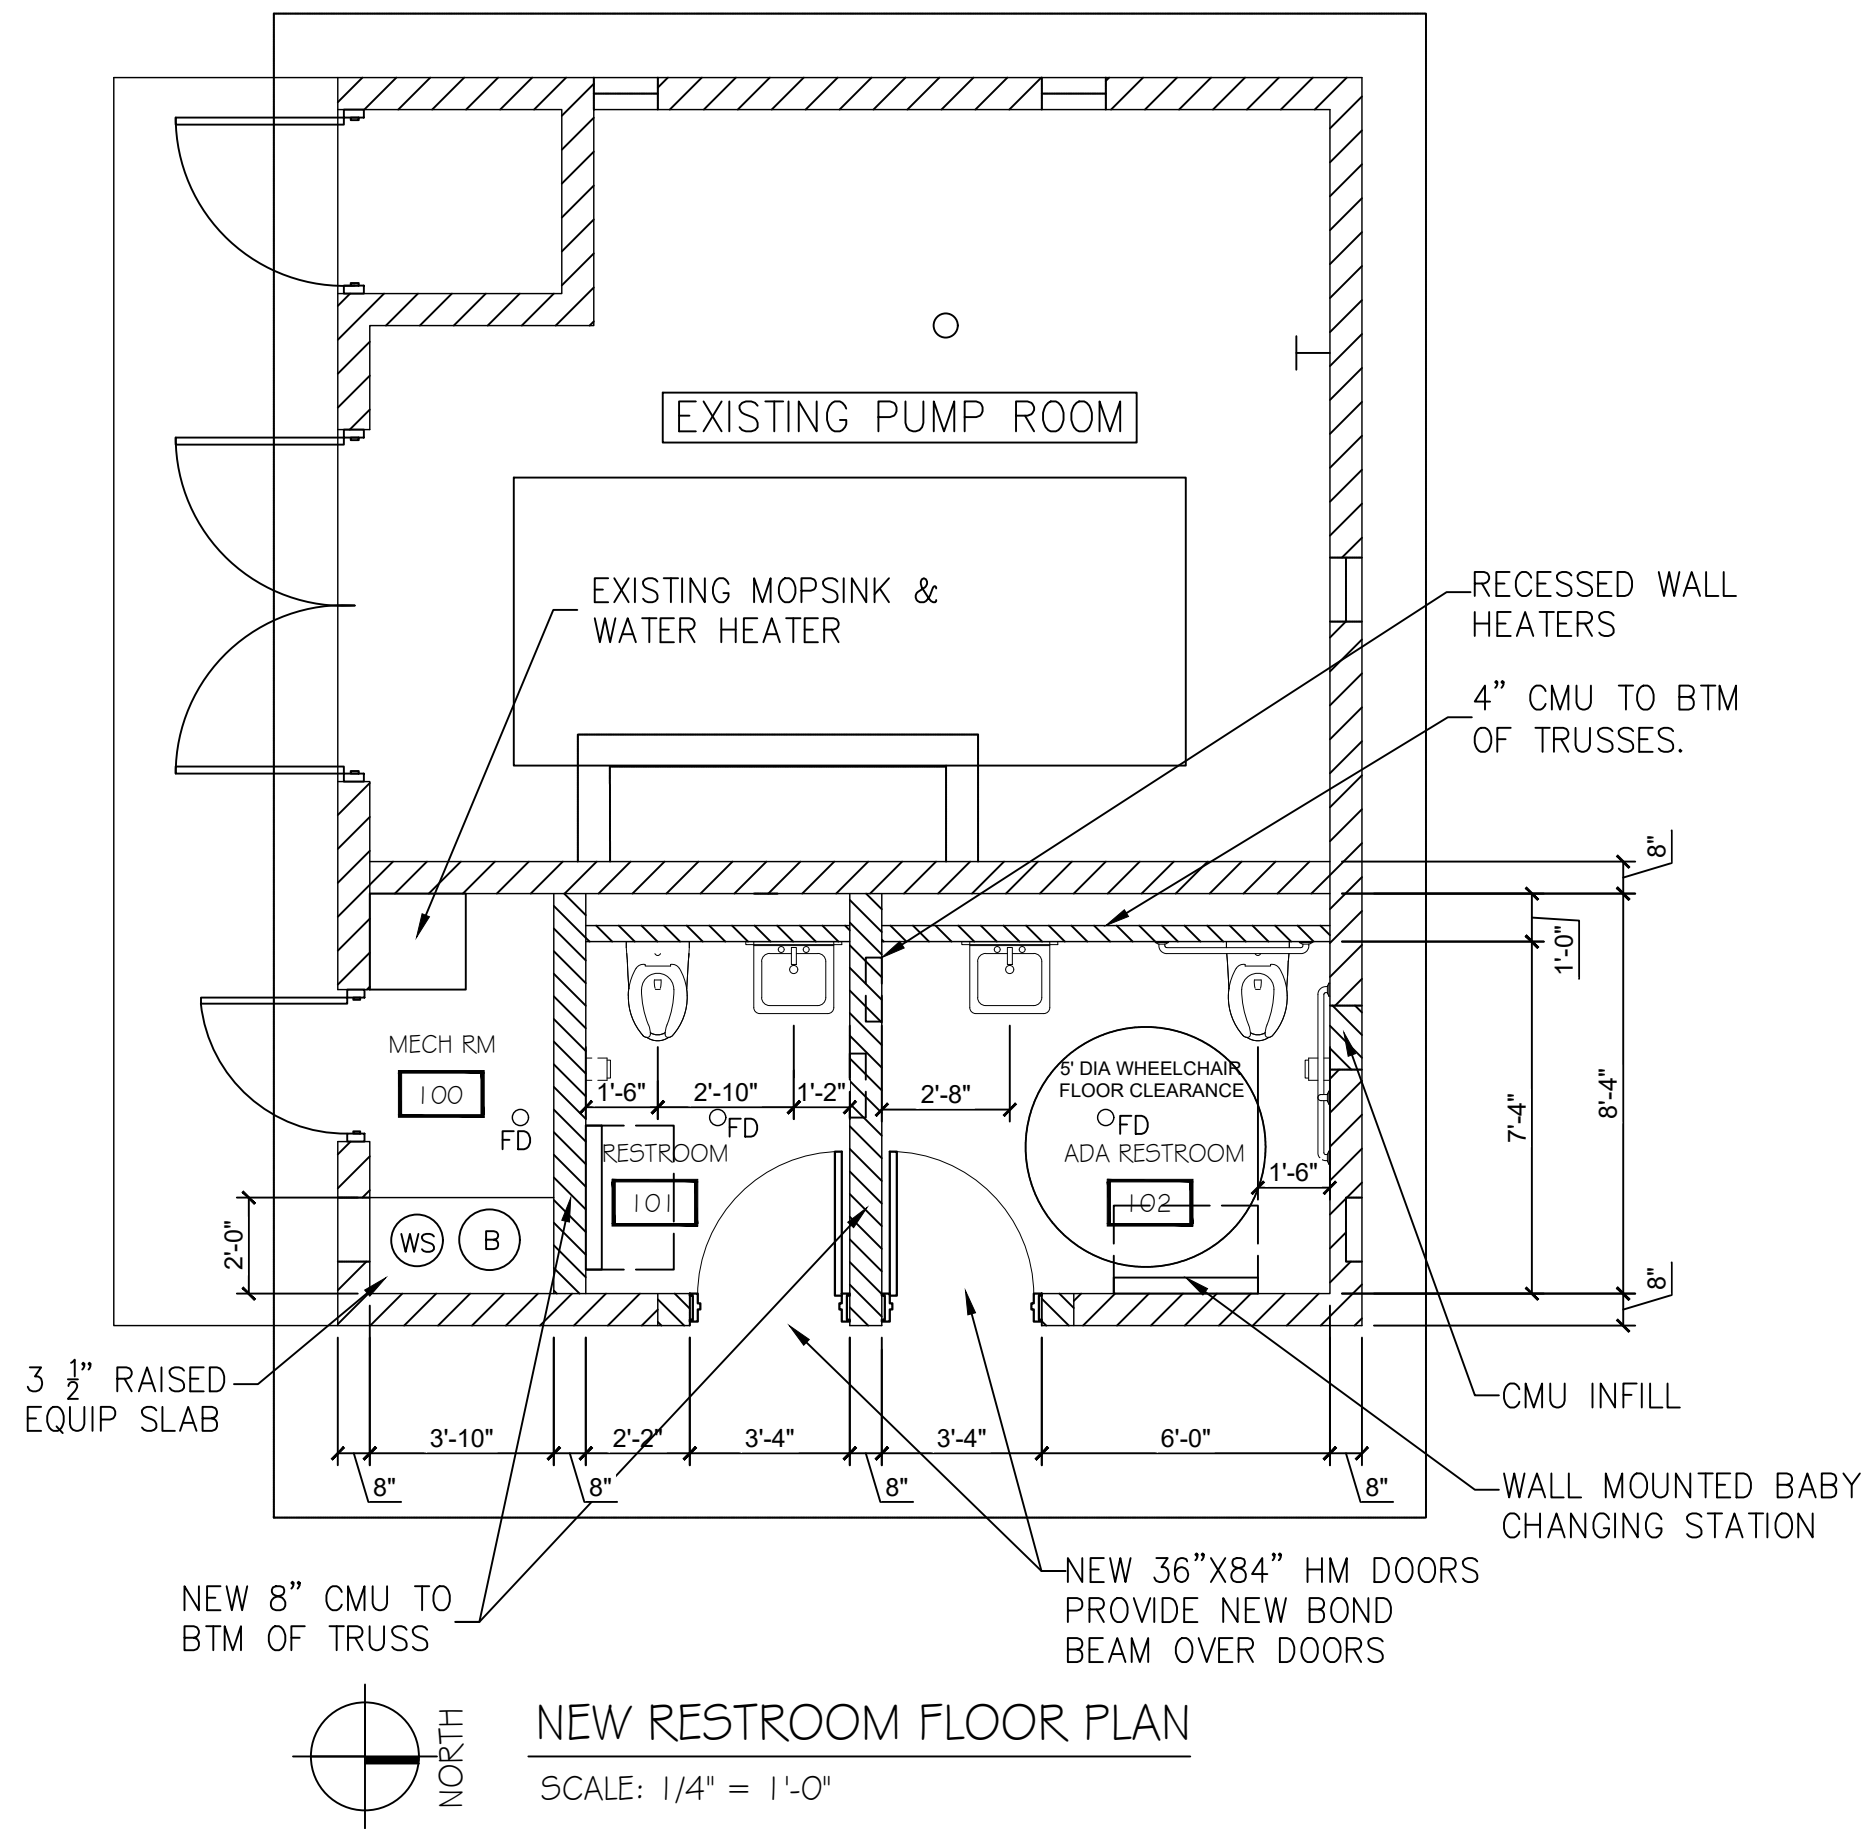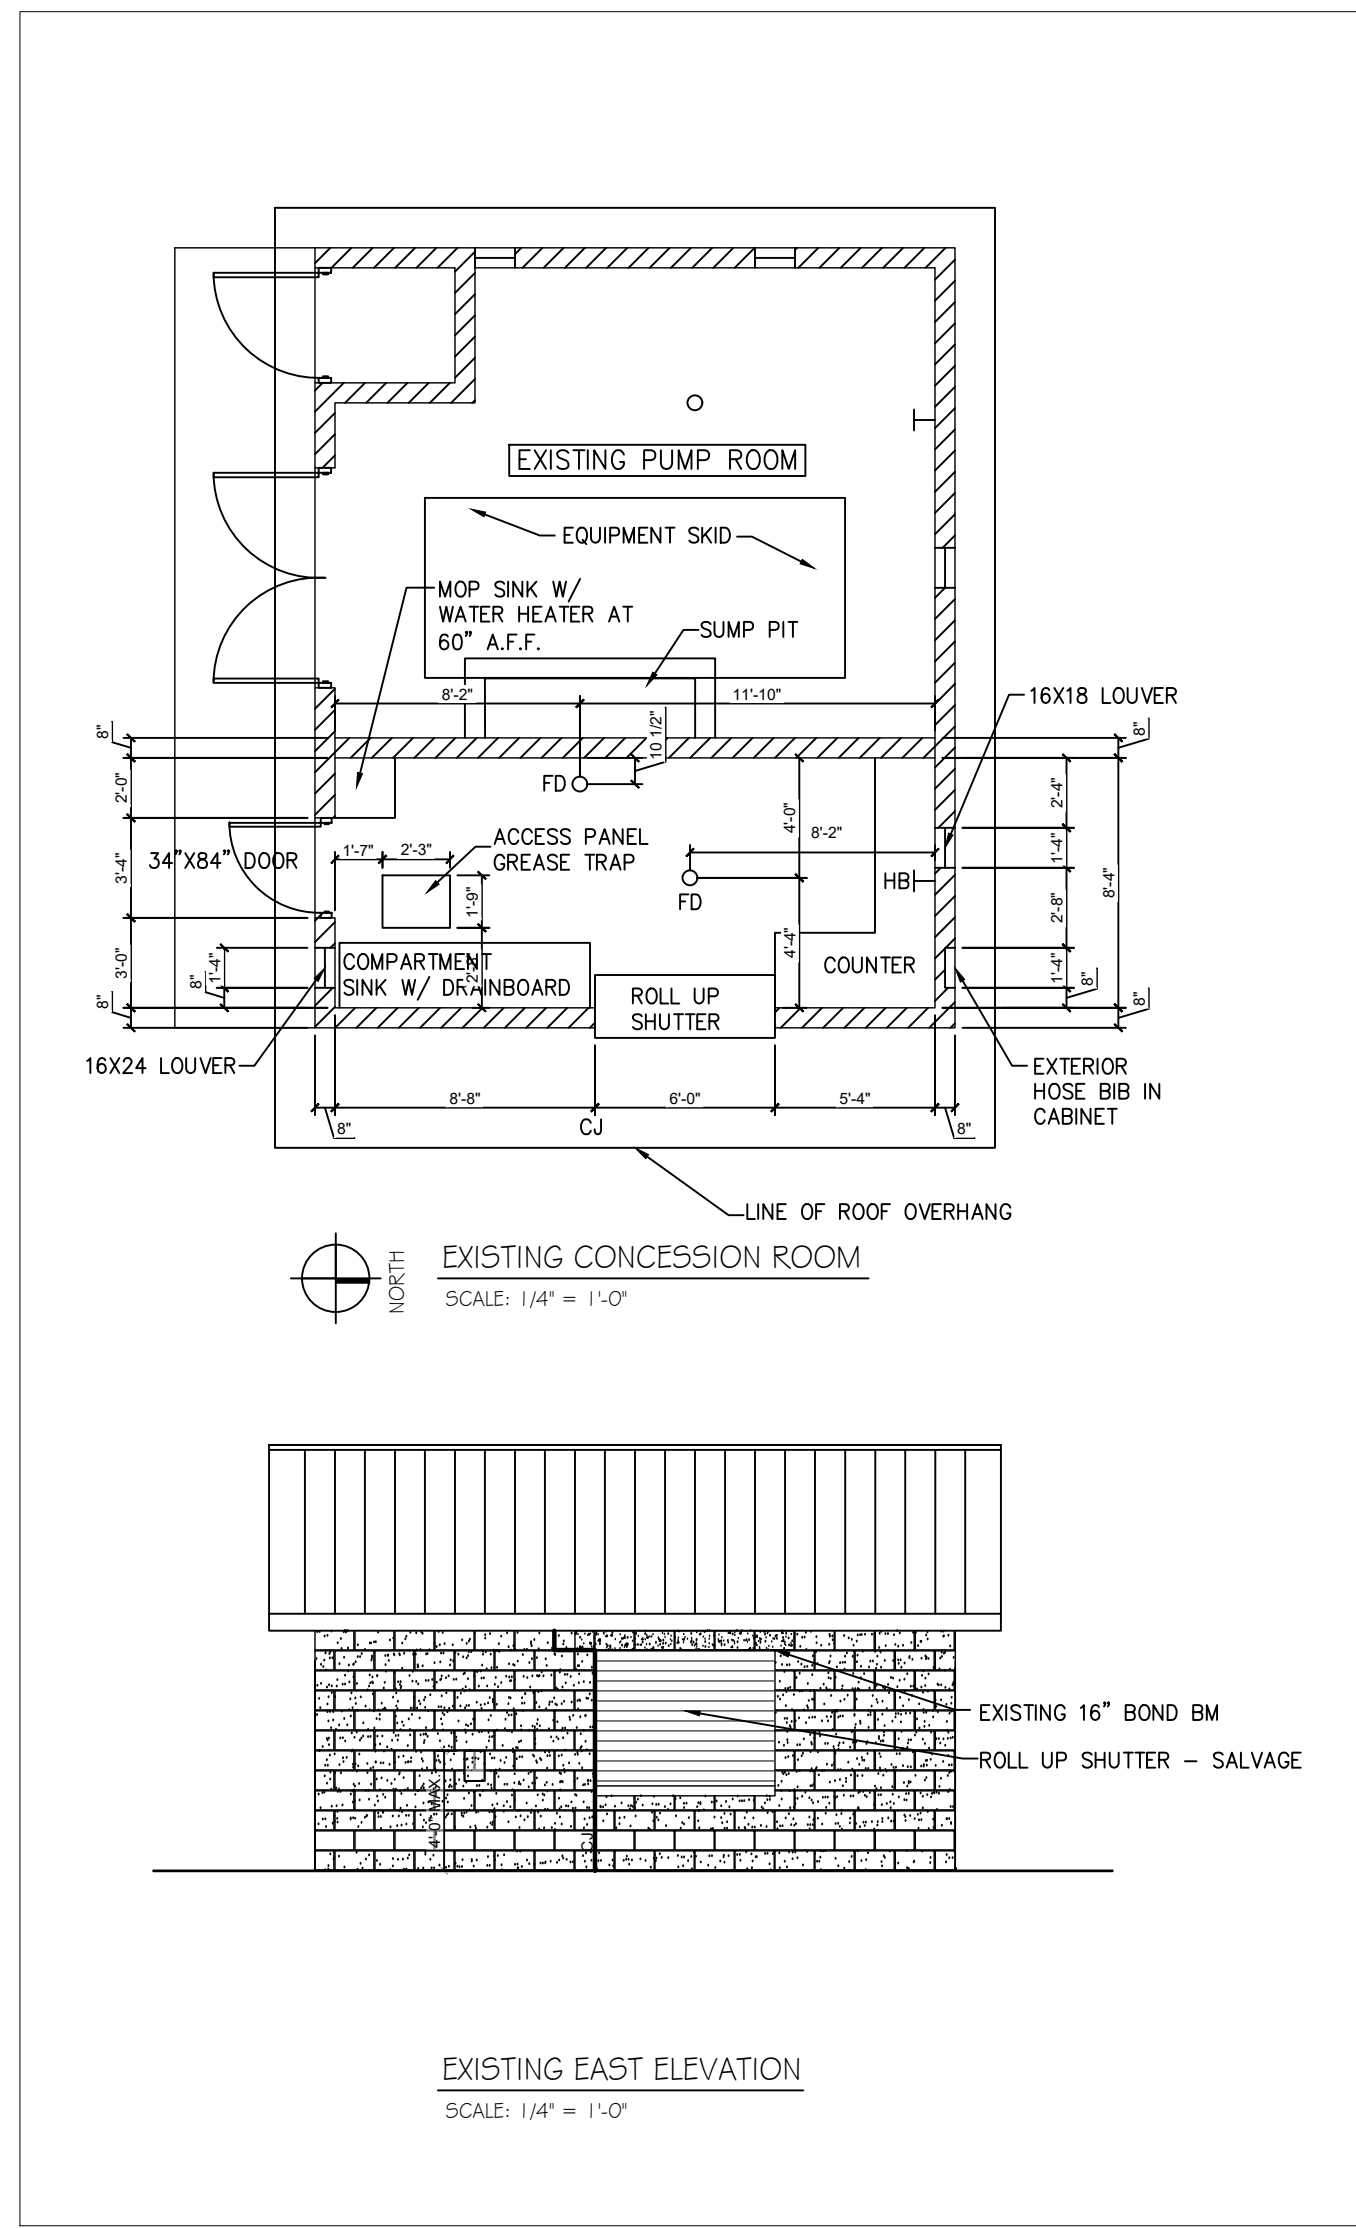

CITY OF MADISON
DEPT OF PUBLIC WORKS
ENGINEERING DIVISION
CITY COUNTY BLDG RM 115
210 MARTIN LUTHER KING JR BLVD
MADISON, WI 53703
PHONE: 608-266-4751

REINDAHL RESTROOM REMODEL
1818 PORTAGE RD.
MADISON, WI 53704

CONTRACT
#8586
MUNIS
#12789
DRWN BY: LKA
DATE 05/19/21
REV: XX/XX/XX

SHT

EXISTING CONDITION REFERENCE PLANS

NORTHEAST INTERCEPTOR - TRUAX EXTENSION RELIEF PROJECT

NOT DATED

Path: S:\MAD1000-1099\1021021\Drawings\GIS\Preferred Alignment 11x17.mxd

User: danc

Date: 9/17/2018

Time: 2:50:36 PM



RELIEF SEWER

**NORTHEAST INTERCEPTOR - TRUAX EXTENSION RELIEF PROJECT
MADISON METROPOLITAN SEWERAGE DISTRICT
CITY OF MADISON
DANE COUNTY, WISCONSIN**