




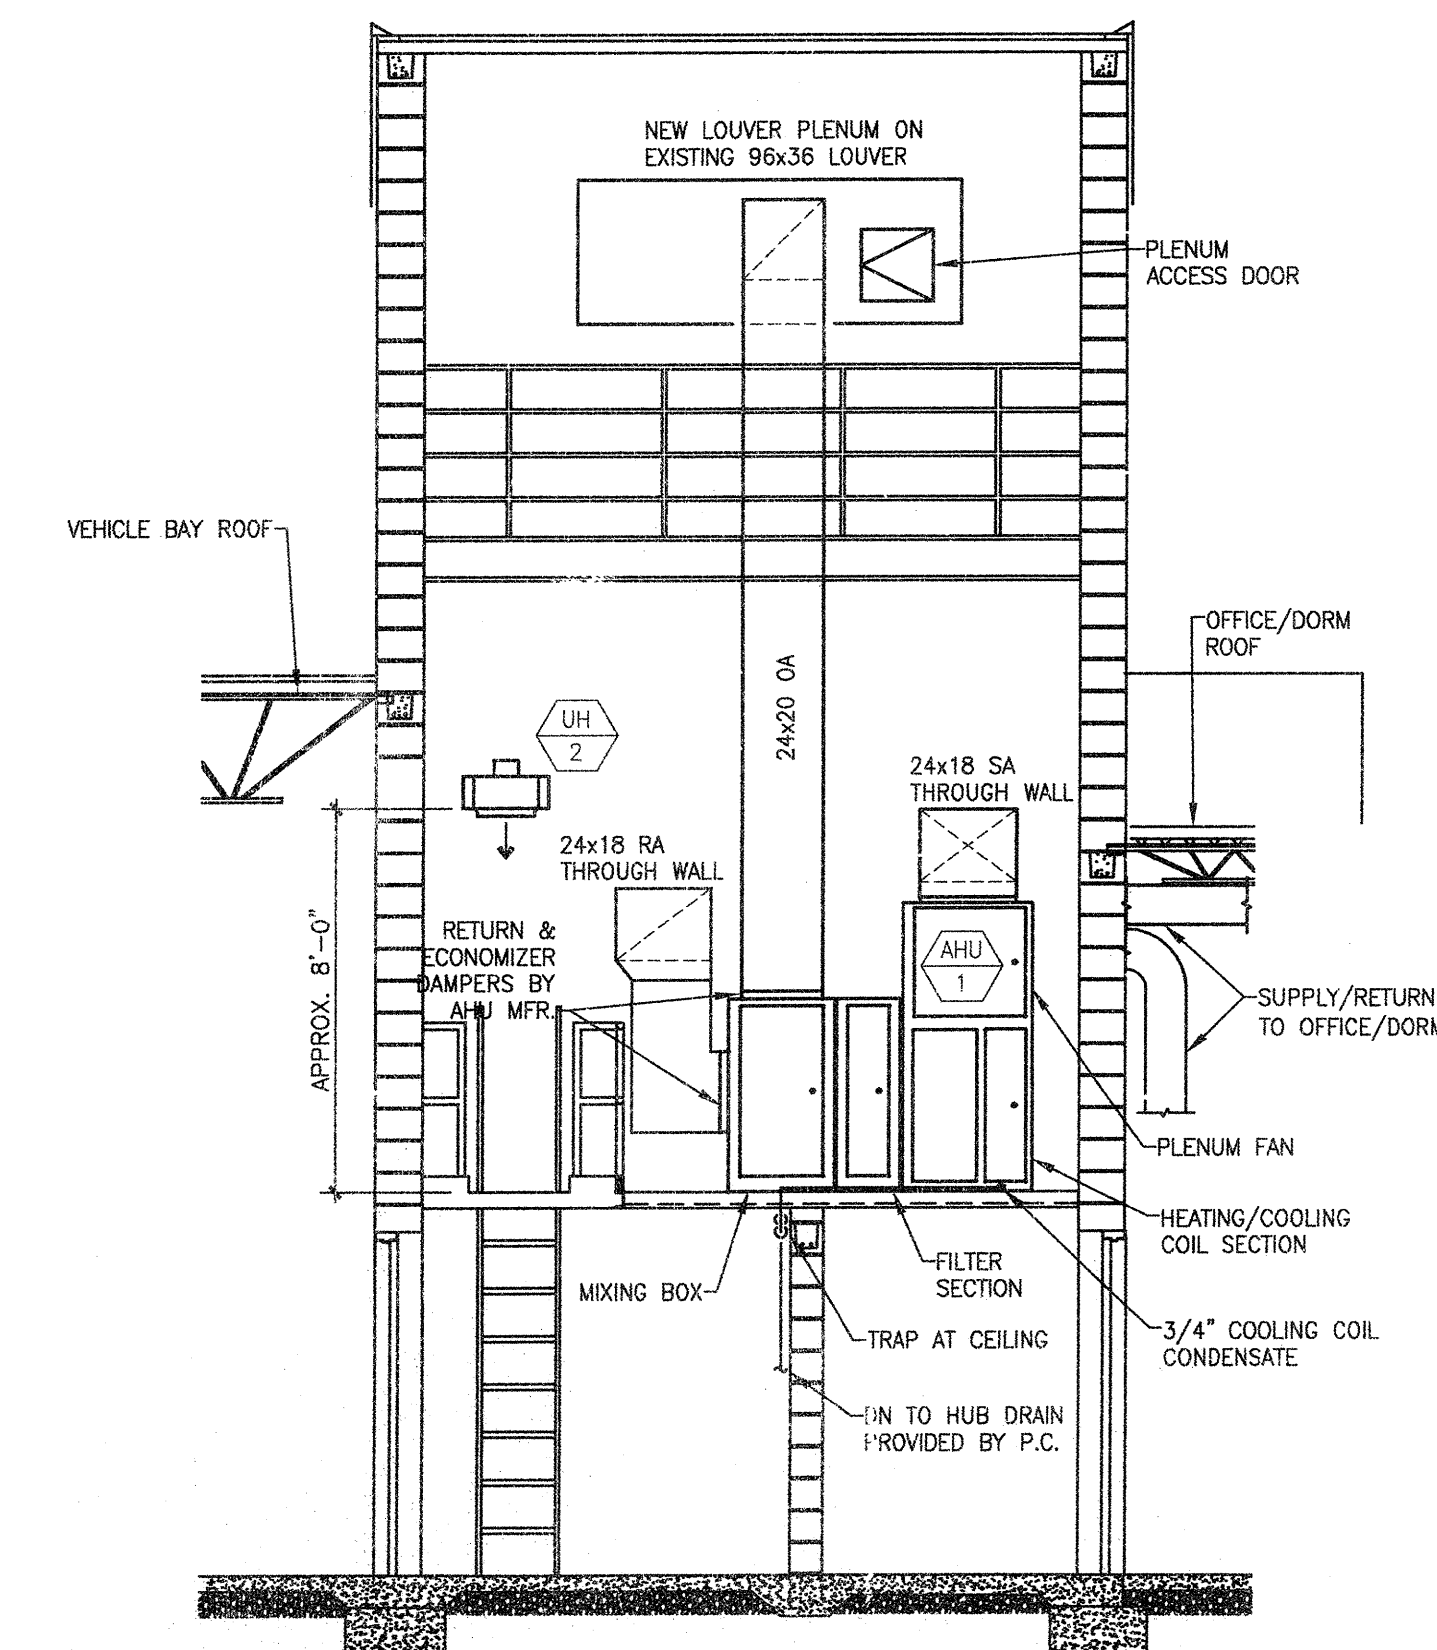

2
M202
HOSE TOWER AHU SECTION - LOOKING WEST
SCALE: 1/4" = 1'-0"

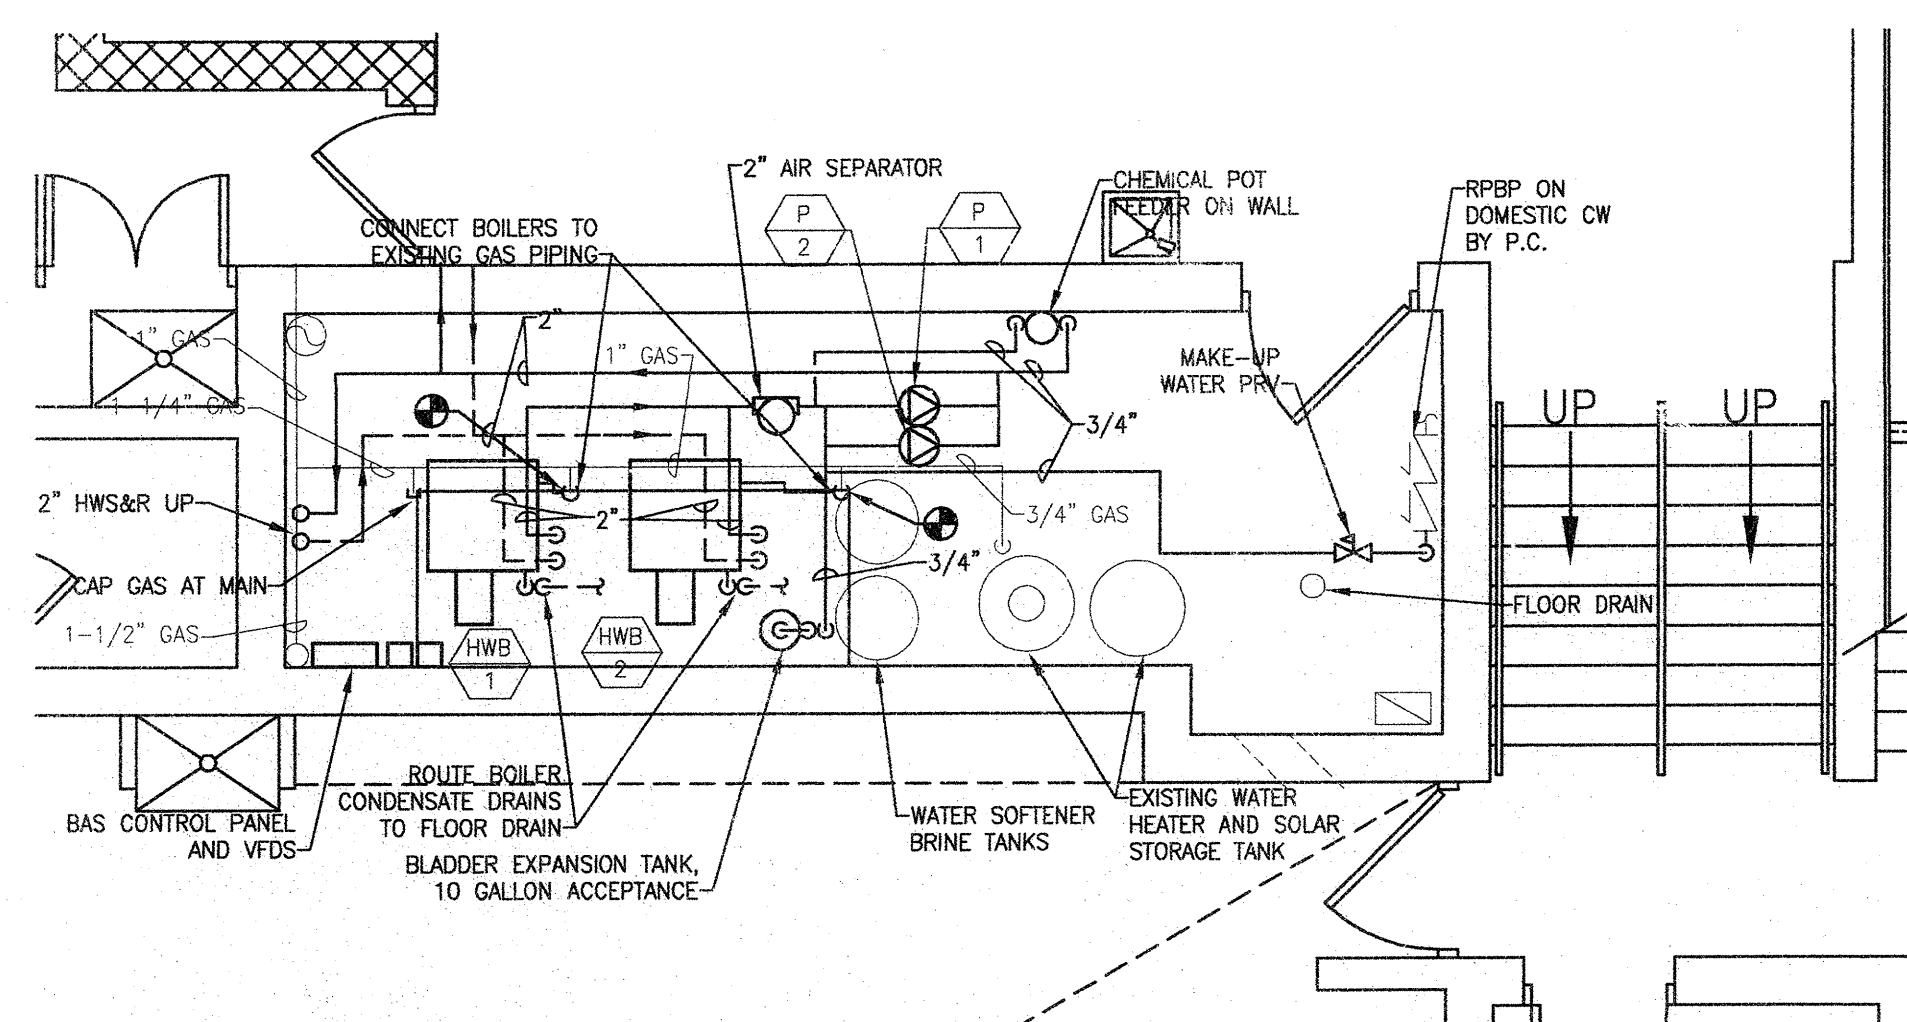

1
M202
MECH ROOM EXPANDED PIPING PLAN
SCALE: 1/4" = 1'-0"

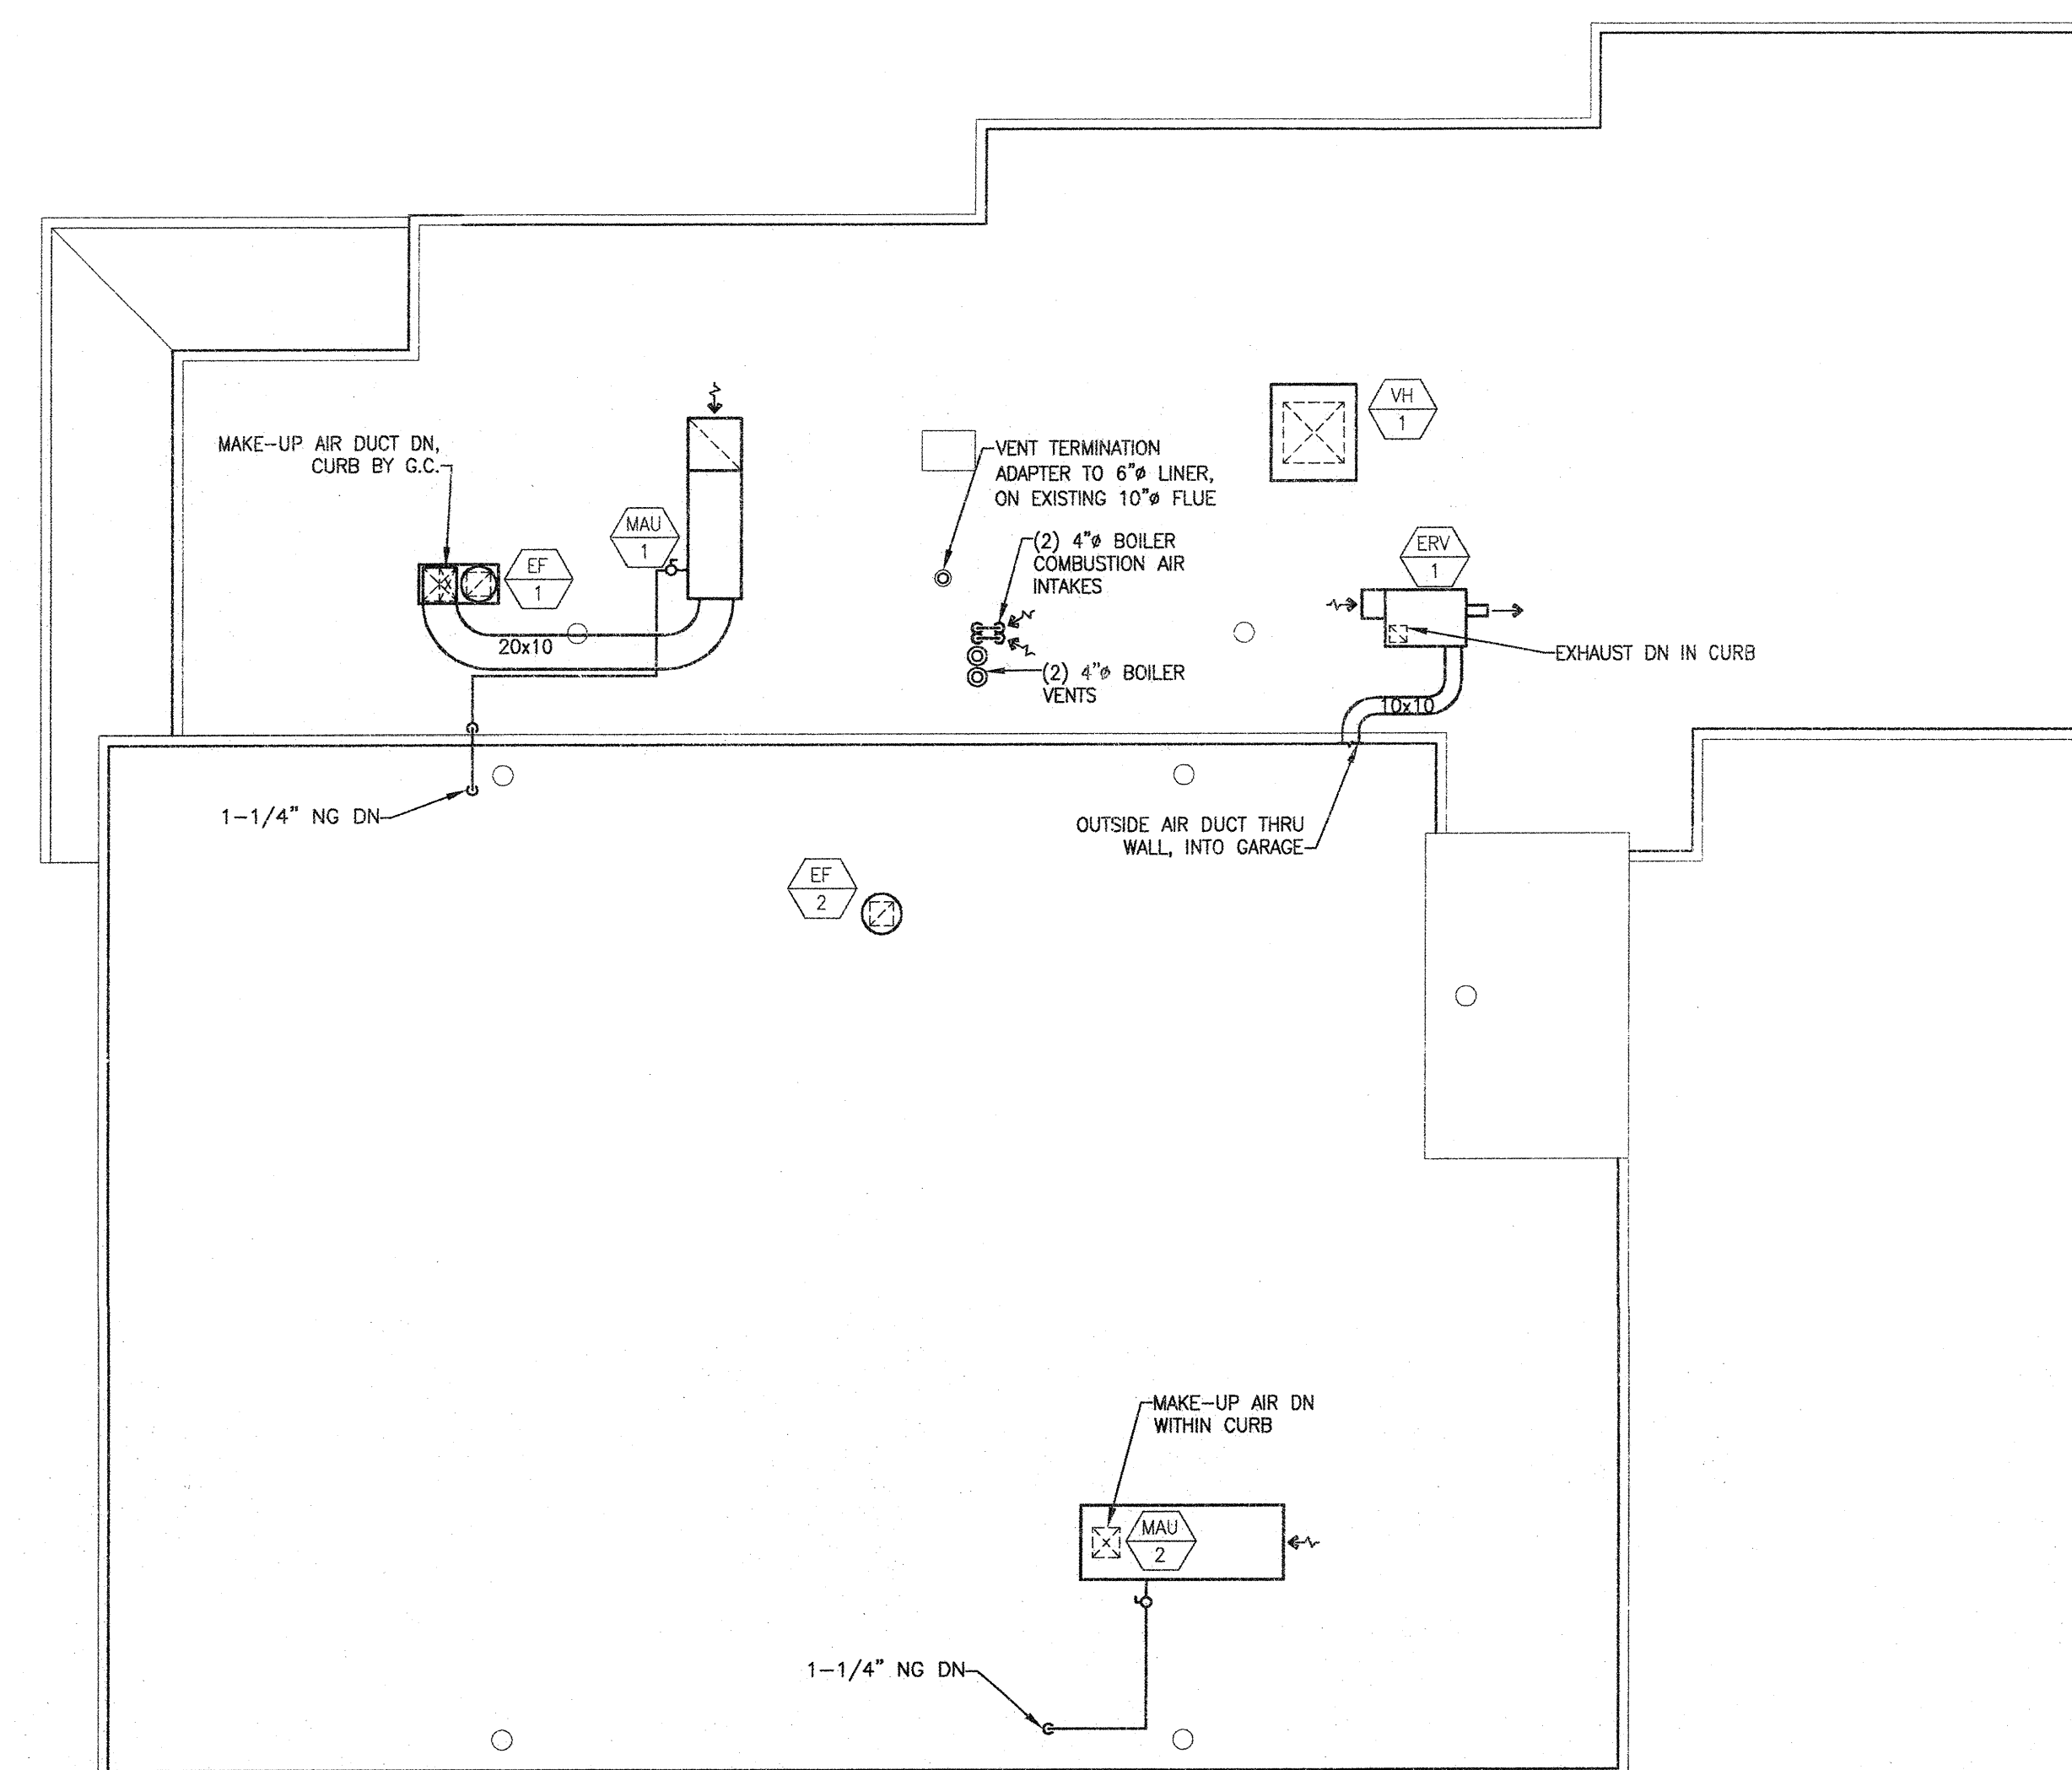

3
M202
ROOF HVAC REMODELING PLAN
SCALE: 1/8" = 1'-0"

DRAWING SET	OWNER REVIEW
COPYRIGHT	2012
STRANG, INC.	
FILE NAME	2011009-M202.DWG
REVISIONS	

DRAWN	NJZ
CHECKED	BK
DATE	03-09-12
PROJECT NO.	2011009

PROJECT TITLE
**CITY OF MADISON
FIRE STATION #2
ADDITION AND
REMODELING**

421 GRAND CANYON DRIVE
MADISON, WISCONSIN

SHEET TITLE
**HVAC ROOF AND
MECH ROOM
REMODELING PLANS**

SHEET NO.
M202