

W61 N617 Mequon Ave
Cedarburg, Wisconsin 53005
tel: 262.377.6039
fax: 262.377.2954
email: studio@utkwa.com

**ALICIA ASHMAN
BRANCH**
MADISON PUBLIC LIBRARY
733 North High Point Road
Madison, Wisconsin

MADISON PUBLIC
LIBRARY

201 West Mifflin Street
Madison, WI 53703

CONSULTANTS)

**PLUMBING, HVAC AND
ELECTRICAL ENGINEERING**

IBC Engineering Services, Inc.
217 Wisconsin Avenue, Suite 400
Waukegan, WI 53186
Tel. (414) 549-1190
Fax: (414) 549-1620

REASONS

DATE

12 November, 1999

PROJECT NUMBER




118099.01

SEAL

SHEET TITLE

Roof Plan

A3

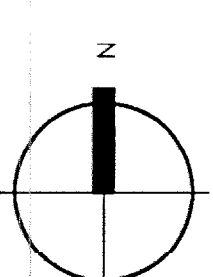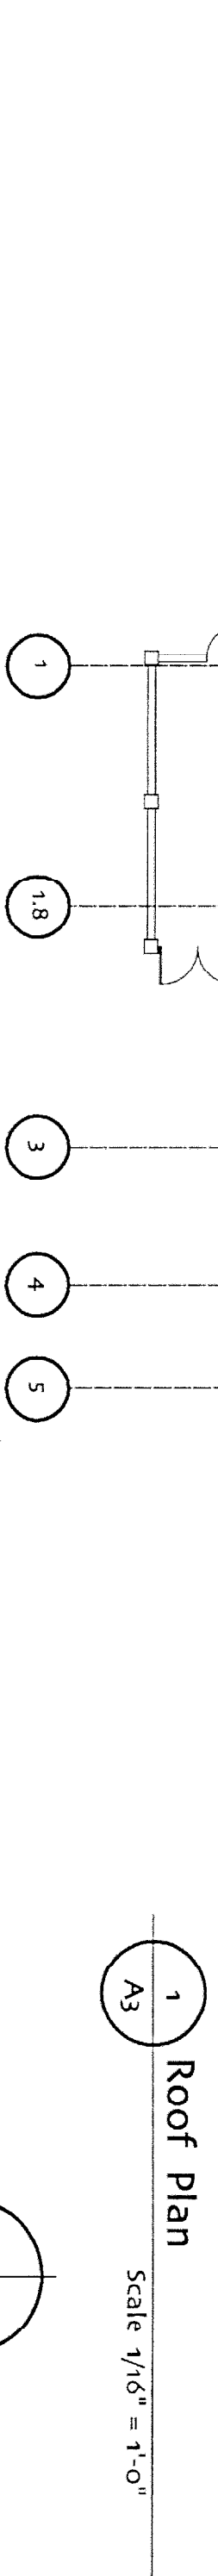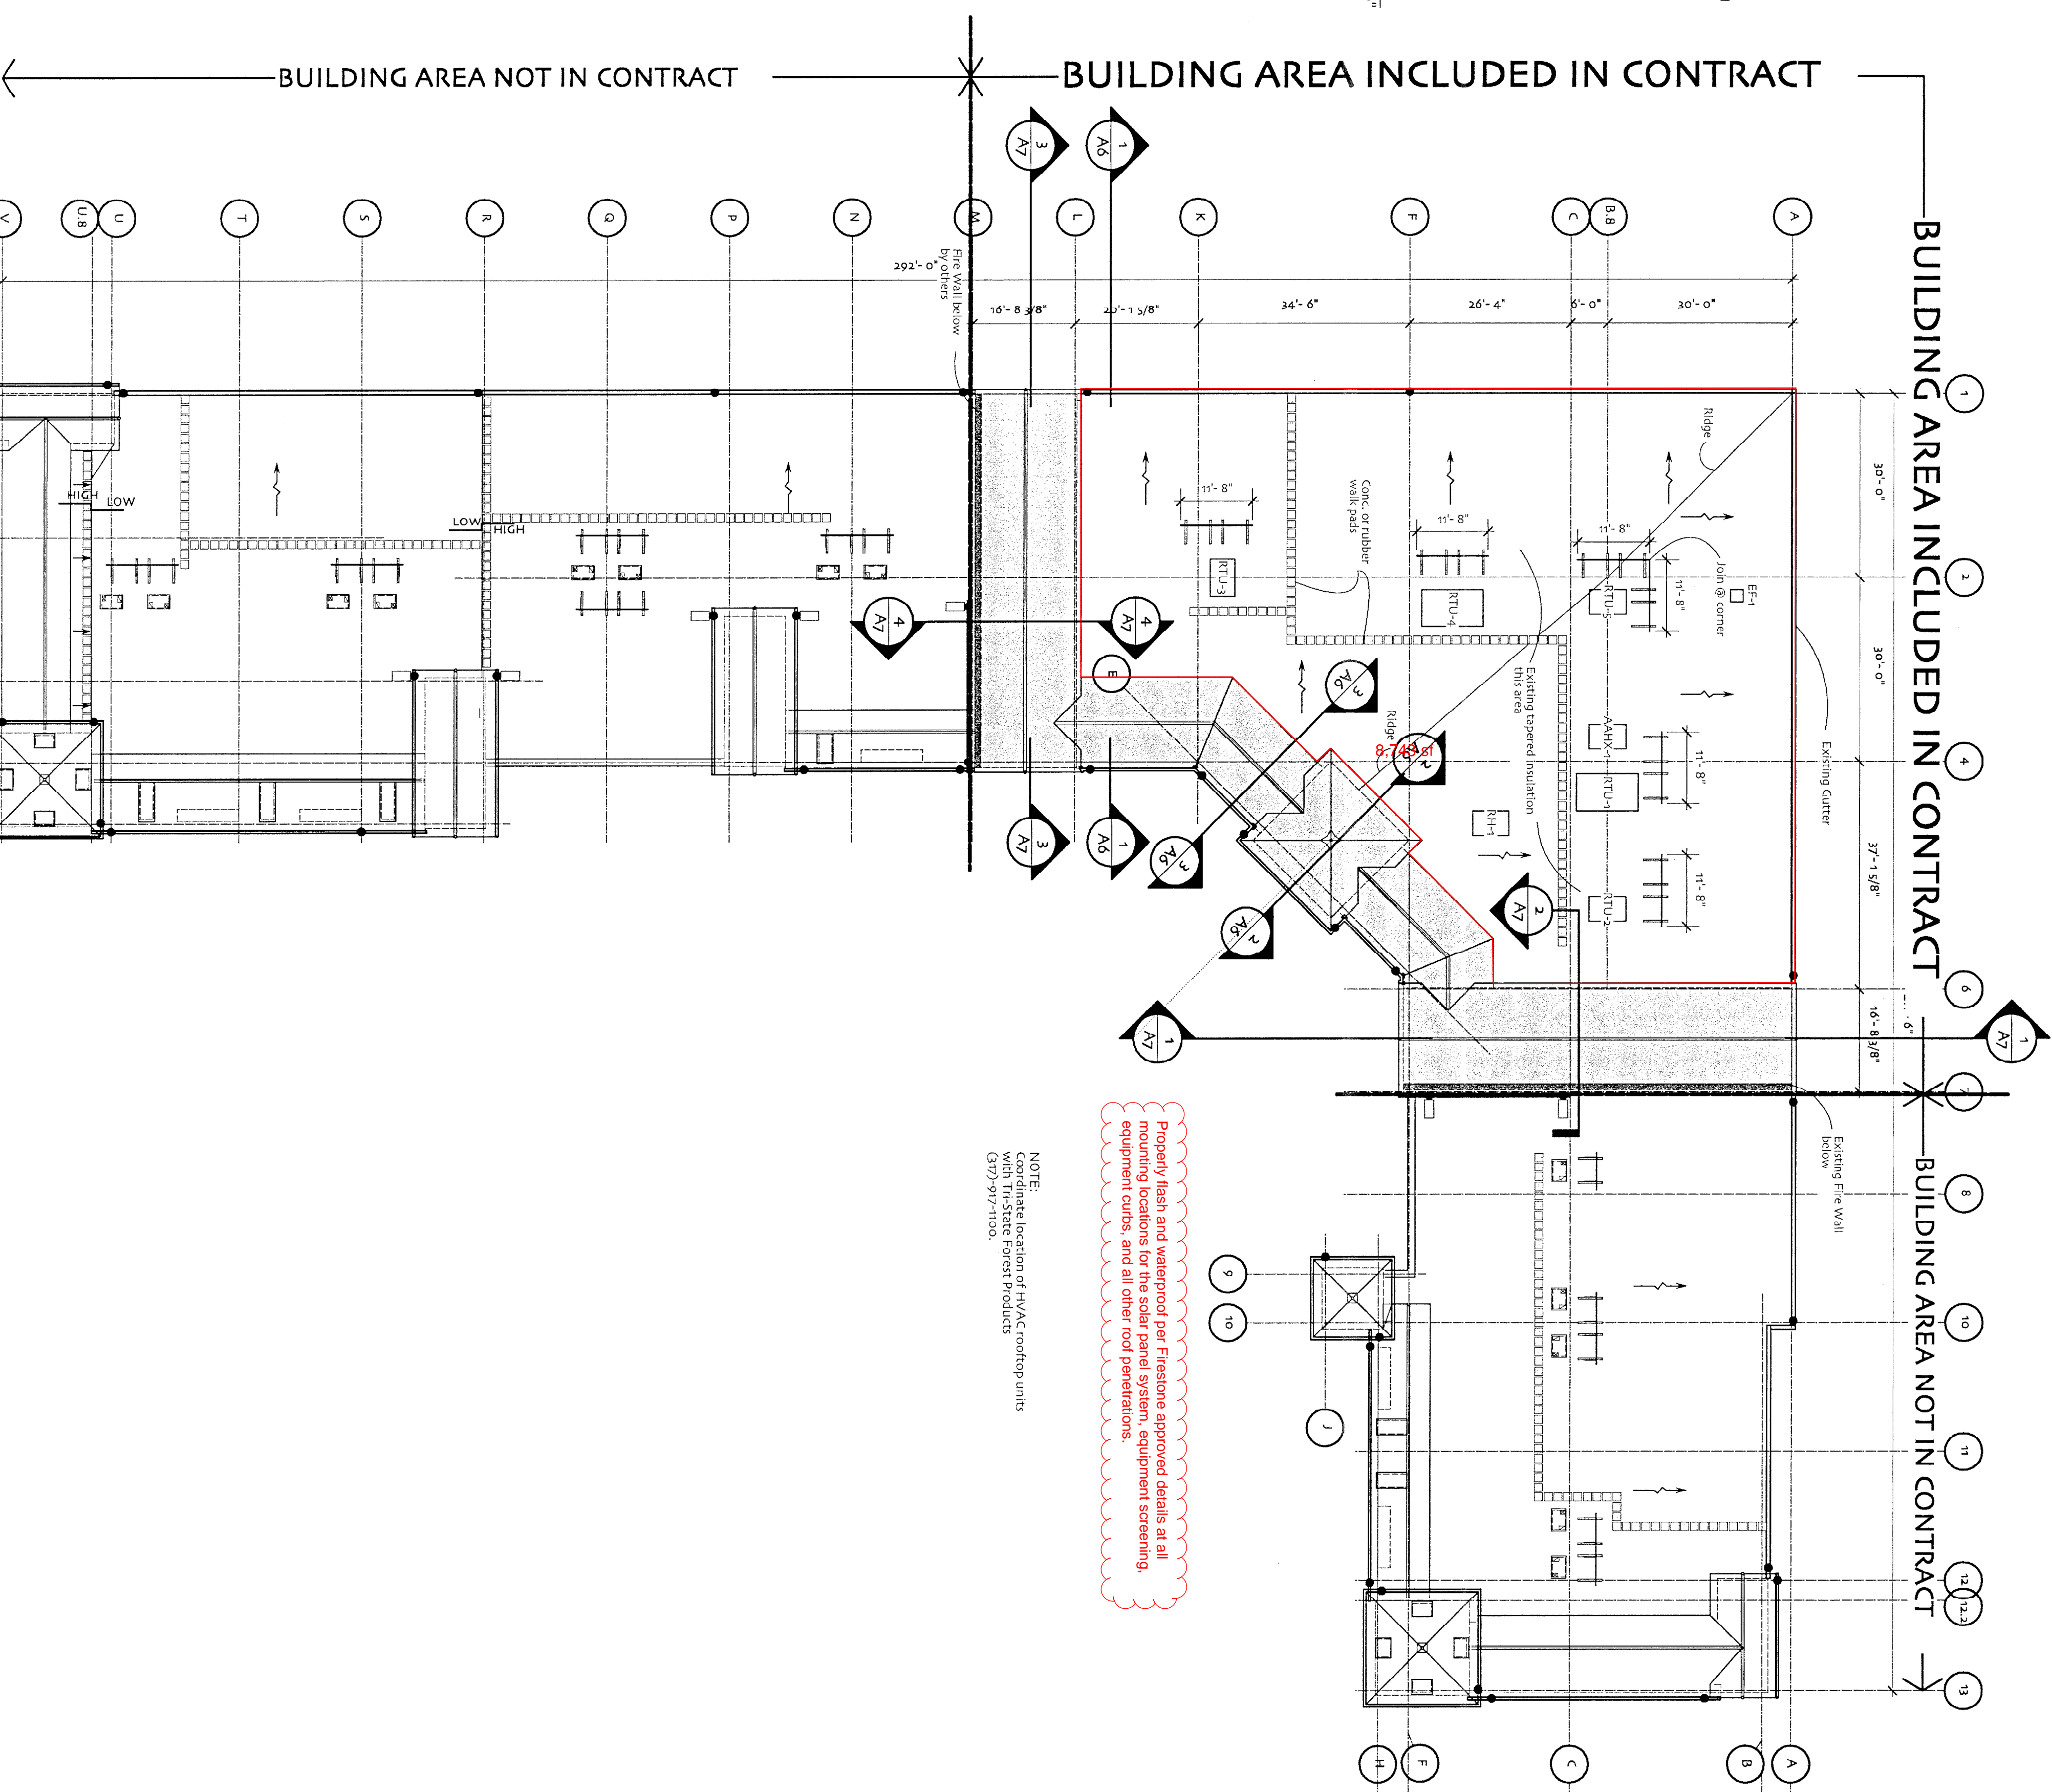

Copyright © 1999
The Kubala Washatko Architects, Inc.
All Rights Reserved