

Madison, Wisconsin

CITY OF MADISON

CITY ENGINEERING DIVISION

DEPARTMENT OF PUBLIC WORKS

PLAN OF PROPOSED IMPROVEMENT


INDEX OF SHEETS

SHEET NO. D1-D2	DETAIL SHEETS
SHEET NO. EC1-EC2	EROSION CONTROL PLANS
SHEET NO. P1-P3	STREET PLAN & PROFILES
SHEET NO. U1-U4	UTILITY PLAN & PROFILES
SHEET NO. U5-U6	STORM SEWER SCHEDULE
SHEET NO. W1-W4	WATER PLANS
SHEET NO. W5-W6	WATER IMPACT PLAN
SHEET NO. W7	WATER ESTIMATE OF MATERIALS
SHEET NO. E1	ELECTRICAL PLANS
SHEET NO. PM1-PM4	PAVEMENT MARKING PLANS
SHEET NO. TC1-TC2	TRAFFIC CONTROL PLANS

ADDENDUM #1: 5/20/2025
REVISED THE FOLLOWING: PM1-PM4

CONVENTIONAL SIGNS	
FIELD VERIFY ALL UTILITY LOCATIONS	
GAS	— G —
STORM SEWER	— ST —
SANITARY SEWER	— SN —
WATER	— W —
BURIED ELECTRIC	— E —
OVERHEAD ELECTRIC	— OH —
POWER POLE	
ADA COMPLIANT RAMP W/ DETECTABLE WARNING FIELD	
COMBUSTIBLE FLUIDS	

PROJECT
LOCATION

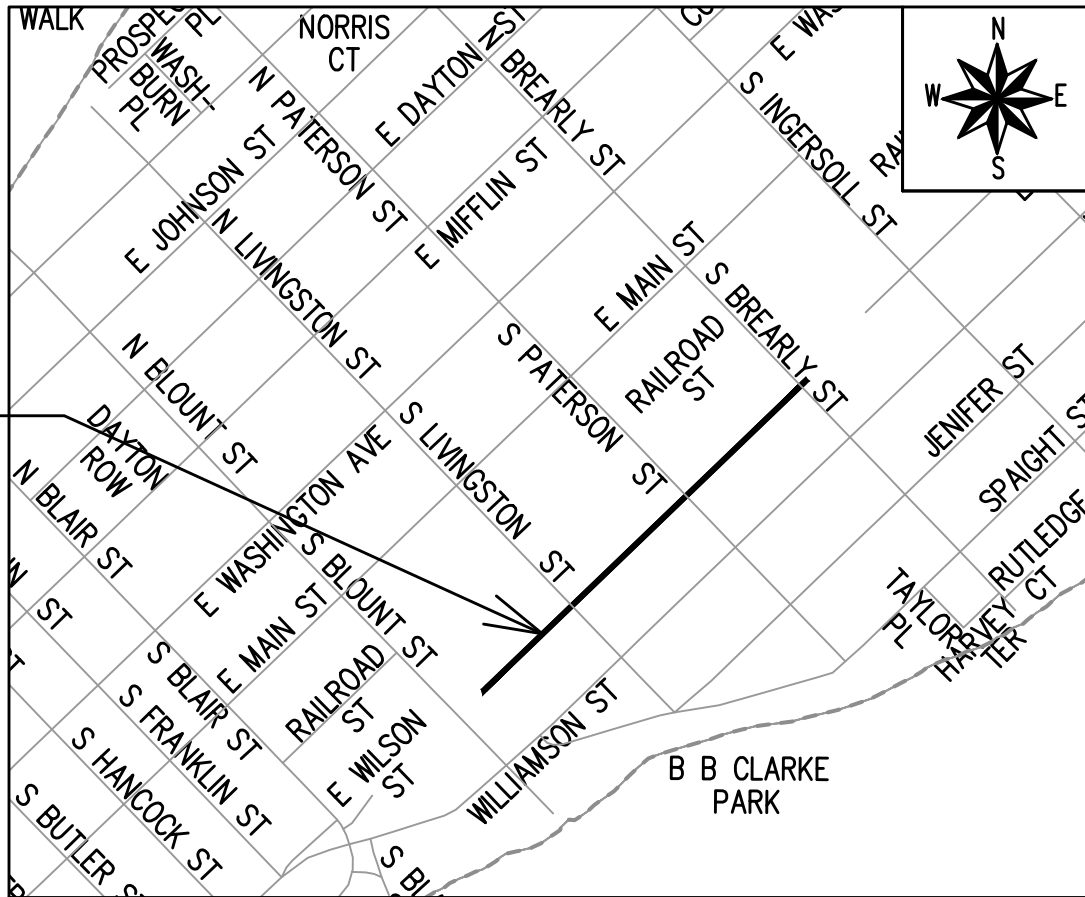

EARTH WORK SUMMARY:
EXCAVATION CUT (MEASURED PLAN QUANTITY) = 805 C.Y.
ESTIMATED UNDISTRIBUTED UNDERCUT = 0 C.Y.
TOTAL UNCLASSIFIED EXCAVATION CUT = 805 C.Y.

PUBLIC IMPROVEMENT PROJECT
APPROVED

APRIL 15, 2025

BY THE COMMON COUNCIL
OF MADISON, WISCONSIN

PUBLIC IMPROVEMENT DESIGN
APPROVED BY:


ENG- Greg Fries 05/09/2025

ENG- Greg Fries (May 9, 2025 08:37 CDT)

City Engineer

Date

STORM SEWER
DESIGNED BY:

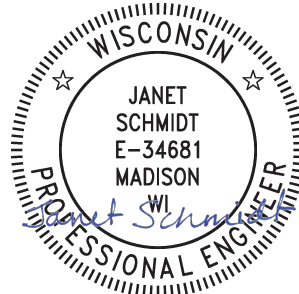


05/09/2025

STREET
DESIGNED BY:




05/09/2025

PAVEMENT MARKING
DESIGNED BY:

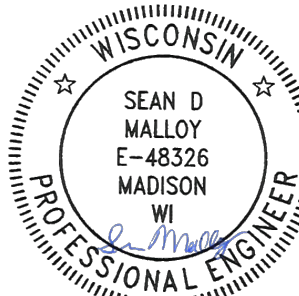


05/09/2025

WATER
DESIGNED BY:

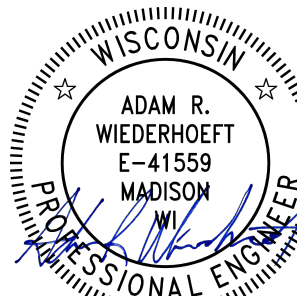

05/09/2025

TRAFFIC CONTROL
DESIGNED BY:

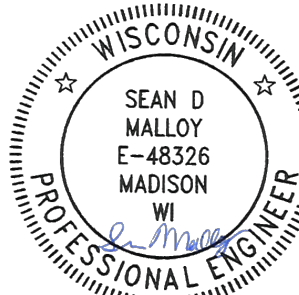

05/09/2025

ELECTRICAL
DESIGNED BY:



05/09/2025

PLOT SCALE: 1 IN. = 1 FT. XREF


PLOT NAME: ---

REV. DATE: 5/8/2025 3:36 PM


ORIGINATOR: CITY_OF_MADISON

S Blount St

- Notes: All dimensions are to center of marking and face of curb, for layout questions, contact Ali Heinritz, aheinritz@cityofmadison.com 608.267.1102

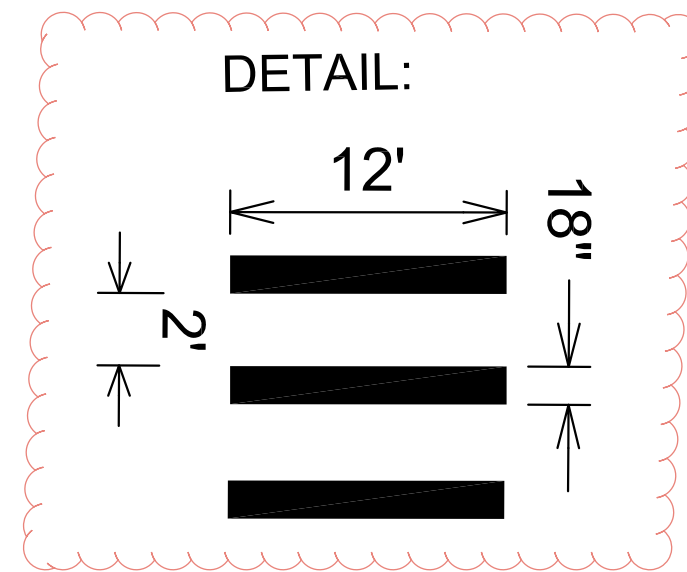


ML - (11)

	15271	15271	15271
	PM-1	15271	15271
	15271TE-PAVEMENT MARKING PLANS		
	CAPITAL CITY TRAIL BOX CULVERT REPLACEMENT		
	MADISON, WI		
CONTRACT NO: 9591			
M:\DESIGN\Projects\15271\CAD\Traffic\15271TE-Pavement\Marking plan continental.dwg			
Date: 5/20/2025 10:44 AM			
Scale: 1" = 40'			
Designed By: DAO			
MARK			
REVISION			
BY			
DATE			
PM-1			

ML - (11)



S Livingston St

ADDENDUM 5/20/2025

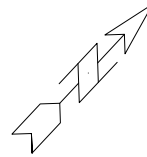

PAVEMENT MARKINGS	
1	PAVEMENT MARKING EPOXY, 4-INCH YELLOW SKIPS (3' LINE, 9' GAP)
2	PAVEMENT MARKING EPOXY, 6-INCH YELLOW SKIPS (10' LINE, 30' GAP)
3	PAVEMENT MARKING EPOXY, 4-INCH DOUBLE YELLOW
4	PAVEMENT MARKING EPOXY, 8-INCH WHITE
5	PAVEMENT MARKING EPOXY, STOP LINE, 24 -INCH
6	PAVEMENT MARKING EPOXY, YELLOW CURB
7	PAVEMENT MARKING EPOXY, CONTINENTAL CROSSWALK 18-INCH

Notes: All dimensions are to center of marking and face of curb, for layout questions, contact Ali Heinritz, aheinritz@cityofmadison.com 608.267.1102

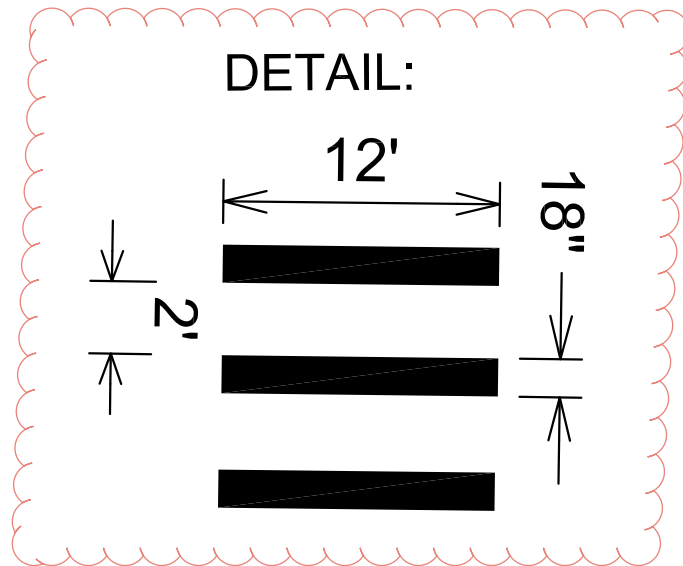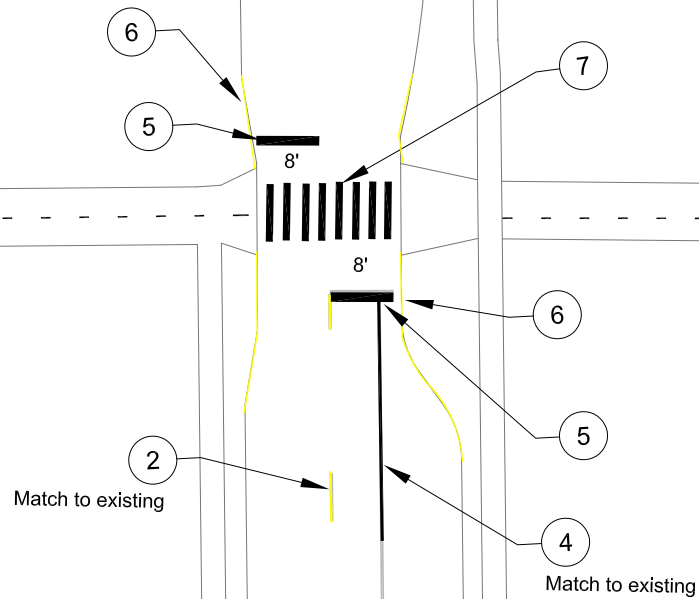

ML - (12)

15271TE-PAVEMENT MARKING PLANS

15271



CAPITAL CITY TRAIL BOX CULVERT REPLACEMENT

MADISON, WI

MARK	REVISION	DATE	BY
15271			


15271
PM-2

M:\DESIGN\Projects\15271\CAD\Traffic\15271TE-PavementMarking plan continentals.dwg

CONTRACT NO: 9591

PM-2

ML - (12)

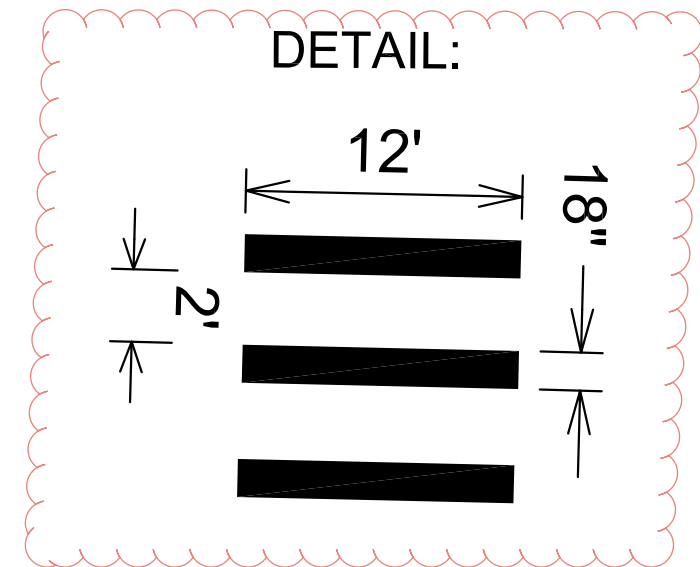

PAVEMENT MARKINGS	
1	PAVEMENT MARKING EPOXY, 4-INCH YELLOW SKIPS (3' LINE, 9' GAP)
2	PAVEMENT MARKING EPOXY, 6-INCH YELLOW SKIPS (10' LINE, 30' GAP)
3	PAVEMENT MARKING EPOXY, 4-INCH DOUBLE YELLOW
4	PAVEMENT MARKING EPOXY, 8-INCH WHITE
5	PAVEMENT MARKING EPOXY, STOP LINE, 24 -INCH
6	PAVEMENT MARKING EPOXY, YELLOW CURB
7	PAVEMENT MARKING EPOXY, CONTINENTAL CROSSWALK 18-INCH

Notes: All dimensions are to center of marking and face of curb, for layout questions, contact Ali Heinritz, aheinritz@cityofmadison.com 608.267.1102

1

Cap City Path

5

6

S Paterson St

8'


8'

7

6

5

ADDENDUM 5/20/2025

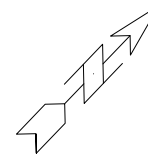

ML - (13)



15271
PM-3

15271TE-PAVEMENT MARKING PLANS

CAPITAL CITY TRAIL BOX CULVERT REPLACEMENT

M:\DESIGN\Projects\15271\CAD\Traffic\15271TE-PavementMarking plan continentals.dwg

15271

MADISON, WI

9591

CONTRACT NO:

MARK
Designed By: DAO

15271

REVISION

DATE

BY


PM-3

ADDENDUM 5/20/2025

PAVEMENT MARKINGS	
1	PAVEMENT MARKING EPOXY, 4-INCH YELLOW SKIPS (3' LINE, 9' GAP)
2	PAVEMENT MARKING EPOXY, 6-INCH YELLOW SKIPS (10' LINE, 30' GAP)
3	PAVEMENT MARKING EPOXY, 4-INCH DOUBLE YELLOW
4	PAVEMENT MARKING EPOXY, 8-INCH WHITE
5	PAVEMENT MARKING EPOXY, STOP LINE, 24 -INCH
6	PAVEMENT MARKING EPOXY, YELLOW CURB
7	PAVEMENT MARKING EPOXY, CONTINENTAL CROSSWALK 18-INCH

Notes: All dimensions are to center of marking and face of curb, for layout questions, contact Ali Heinritz, aheinritz@cityofmadison.com 608.267.1102

ML - (13)

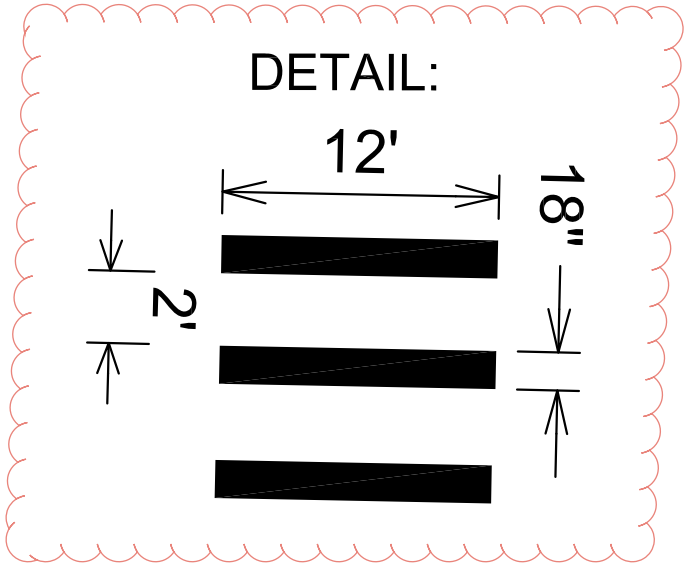

1

Cap City Path

6

5

7

5

6

3

Match to existing

S Brearly St

ML - (14)



15271
PM-4

15271TE-PAVEMENT MARKING PLANS

CAPITAL CITY TRAIL BOX CULVERT REPLACEMENT

M:\DESIGN\Projects\15271\CAD\Traffic\15271TE-PavementMarking plan continentals.dwg

15271

MADISON, WI

9591

CONTRACT NO:

MARK
Designd By: DAO
15271

REVISION
Date: 5/20/2025 10:49 AM
Scale: 1" = 40'

DATE
BY
PM-4