



Madison, Wisconsin

CITY OF MADISON

CITY ENGINEERING DIVISION

DEPARTMENT OF PUBLIC WORKS

PLAN OF PROPOSED IMPROVEMENT


INDEX OF SHEETS

SHEET NO. D1	GENERAL NOTES
SHEET NO. D2-D4	TYPICAL SECTIONS
SHEET NO. E1	ELECTRICAL PLAN
SHEET NO. ST2	DETAILED BIOFILTER LAYOUT & ELEVATION PLAN
SHEET NO. ST4-ST5	BIOFILTER DETAILS
SHEET NO. O1	PROJECT OVERVIEW
SHEET NO. P1-P3	STREET PLAN & PROFILE
SHEET NO. U1-U2	UTILITIES PLAN & PROFILE
SHEET NO. U3	SANITARY SEWER SCHEDULE
SHEET NO. U4	STORM SEWER SCHEDULE
SHEET NO. W1	WATER PLAN & PROFILE
SHEET NO. W2	WATER IMPACT PLAN
SHEET NO. W3	WATER ESTIMATE OF MATERIALS
SHEET NO. X1-X8	CROSS SECTIONS
SHEET NO. L1	STREET TREE PLANTING PLAN
SHEET NO. MN1	MAINTENANCE PLAN

4649 VERONA ROAD

CITY PROJECT NO. 14774
CONTRACT NO. 9231

PROJECT
LOCATION

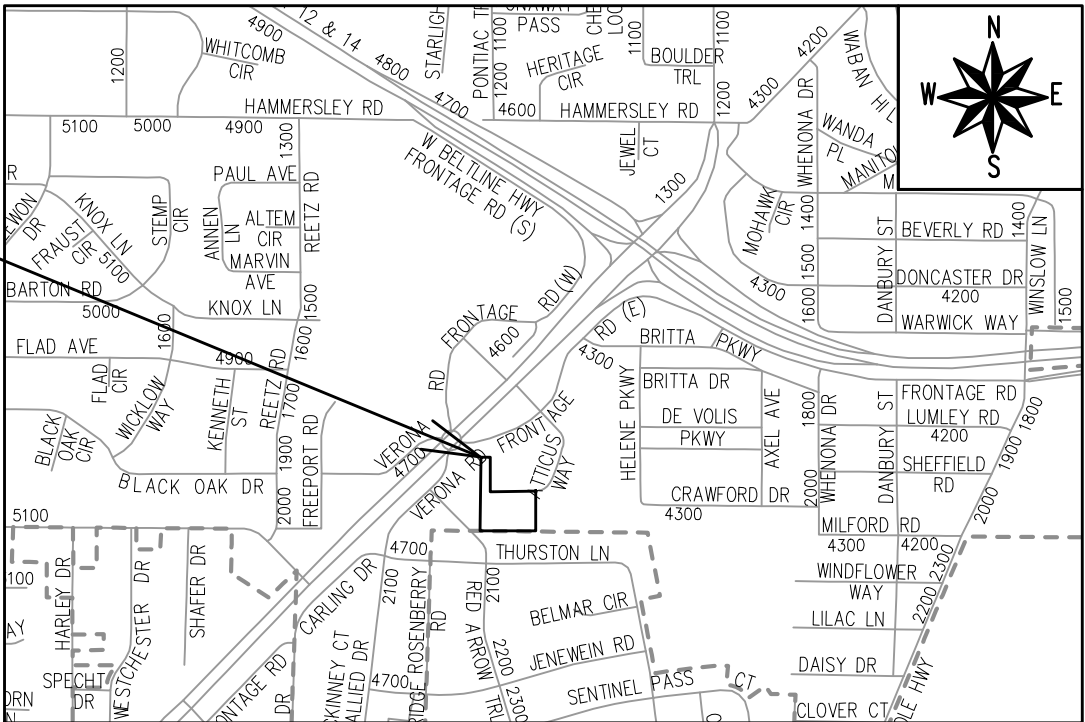

PUBLIC IMPROVEMENT PROJECT
APPROVED

NOVEMBER 22, 2022

BY THE COMMON COUNCIL
OF MADISON, WISCONSIN

PUBLIC IMPROVEMENT DESIGN
APPROVED BY:

Julie

Jul 18, 2023

City Engineer

Date

ELECTRICAL
DESIGNED BY:




Jul 18, 2023

STREET
DESIGNED BY:




Jul 18, 2023

SANITARY SEWER
DESIGNED BY:

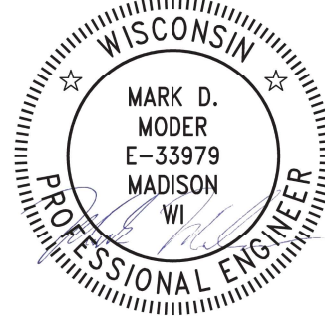

Jul 18, 2023

STORM SEWER
DESIGNED BY:

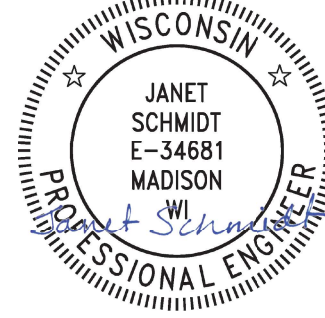

Jul 18, 2023

STREET GEOMETRICS
DESIGNED BY:




Jul 19, 2023

STORM WATER FEATURES
DESIGNED BY:



Jul 18, 2023

WATER
DESIGNED BY:

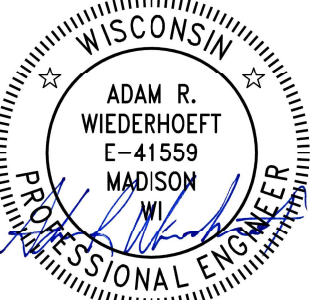



Jul 18, 2023

DEVELOPER MUST SUBMIT A TRAFFIC CONTROL PLAN TO CITY TRAFFIC ENGINEERING AT LEAST 14 DAYS PRIOR TO THE START OF WORK. WORK SHALL NOT PROCEED UNTIL AN APPROVED TRAFFIC CONTROL PLAN IS IN PLACE.

ALL UTILITY VERIFICATIONS AND ACCURACY OF THE DRAWINGS ARE THE RESPONSIBILITY OF THE DEVELOPER. ANY CONFLICTS THAT ARISE FROM MISSING OR ERRONEOUS INFORMATION WILL BE AT THE EXPENSE OF THE DEVELOPER. NO PRECAST STRUCTURES WILL BE APPROVED FOR STORM OR SANITARY SEWER UNTIL ALL POTENTIAL UTILITY CONFLICTS ARE RESOLVED.




COMBUSTIBLE FLUIDS



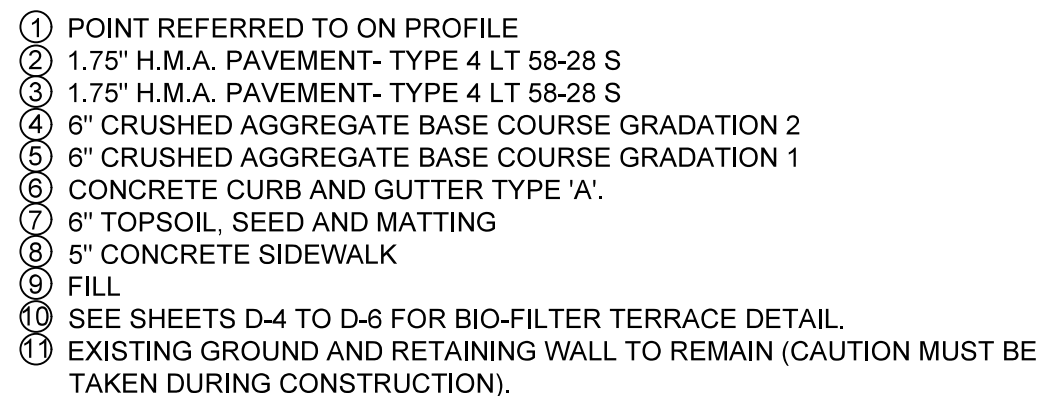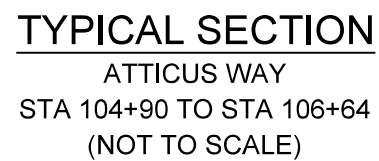

* SEE P AND X SHEETS FOR SLOPES.

[illegible]

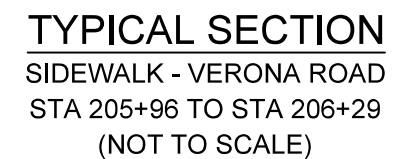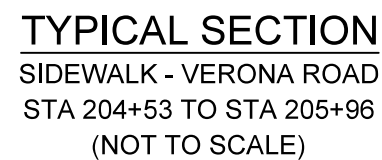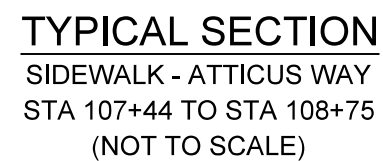

* SEE P AND X SHEETS FOR SLOPES.


- ① POINT REFERRED TO ON PROFILE
- ② 5" CONCRETE SIDEWALK
- ③ 6" TOPSOIL, SEED AND MATTING
- ④ EXISTING GROUND TO REMAIN.
- ⑤ DITCH FLOW LINE
- ⑥ ALLEY GUTTER PER S.D.D. 4.07
- ⑦ EXISTING PAVEMENT TO REMAIN
- ⑧ ASPHALTIC CURB AND GUTTER
- ⑨ 5" CONCRETE TERRACE
- ⑩ CONCRETE CURB & GUTTER TYPE 'G'
- ⑪ 2" H.M.A. PAVEMENT- TYPE 4 LT 58-28 S

TYPICAL SECTIONS	14774
4649 VERONA ROAD	MADISON, WI
M:\DESIGN\Projects\14774\CAD\Streets\14774EN-Details.dwg	
CONTRACT NO:	9231



14774
D-4


1. ALL LOCATIONS ARE APPROXIMATE. TRAFFIC ENGINEER SHALL APPROVE FINAL LOCATIONS INCLUDING SETBACK IN THE FIELD. AFTER CONTRACTOR SURVEYS STAKING, THE CONTRACTOR SHALL NOTIFY GRETCHEN AVILES PINEIRO (266-4899), AT LEAST 24-HOURS IN ADVANCE OF NEEDING BASE LOCATION MARKED.
2. THE CONTRACTOR SHALL DO ALL WORK IN ACCORDANCE WITH CITY OF MADISON STANDARD SPECIFICATIONS FOR PUBLIC WORKS CONSTRUCTION 2023 EDITION AND ALL ADDENDUMS THERETO.
WWW.CITYOFMADISON.COM/ENGINEERING/DOCUMENTS/STANDARD-SPECIFICATIONS/COMPLETESPECBOOK.PDF
3. ALL CONDUIT SHALL BE PVC SCHEDULE 80 UNDER PAVEMENT OR SCHEDULE 40 OTHERWISE. PULL WIRE REQUIRED AS PER STANDARD SPECIFICATIONS.
4. THE CONTRACTOR SHALL CALL TROY VANT (395-1975) AT THE TRAFFIC ENGINEERING SHOP AT LEAST 24-HOURS IN ADVANCE OF INSTALLING STREETLIGHT UNITS AND BURYING CONDUIT TO ARRANGE FOR INSPECTION.
5. THE CONTRACTOR SHALL CALL TROY VANT (395-1975) PRIOR TO REMOVING OR CONNECTING TO EXISTING CONDUITS OR HANDHOLES. CONTRACTOR SHALL FIELD VERIFY CONDUIT MATERIAL & SIZE.
6. THE CONTRACTOR SHALL ARRANGE FOR PICKUP OF THE FOLLOWING CITY MATERIALS:
(2) STREET LIGHTING UNITS: 29' CONCRETE POLE, ARM & FIXTURE (GCM2-30H-MV-VWV-2R-GY-530-PCR7-WL-SC)

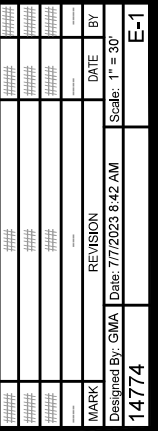




ELECTRICAL PLAN

4649 VERONA ROAD

 M:\DESIGN\Projects\14774\CAD\Traffic\14774TE-Electrical.dwg





File: I:\2021\10805\DWG\Civil Sheets - Public\10 Site and Grading Plan.dwg Layout: ST-2 User: newman Plotted: Jun 20, 2023 4:02pm Xref:

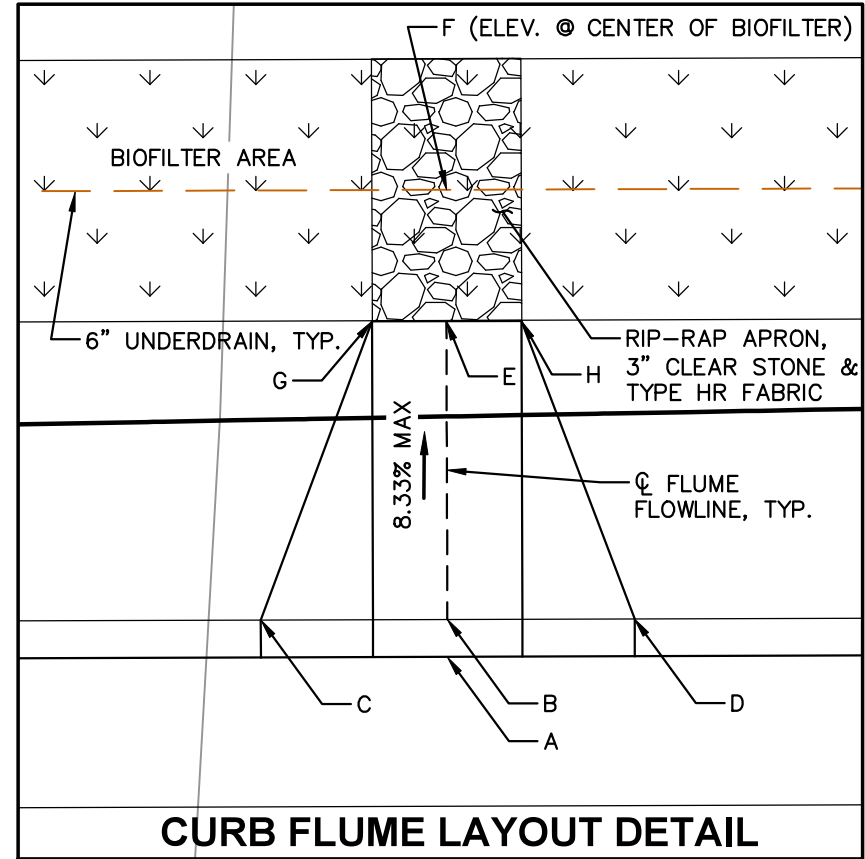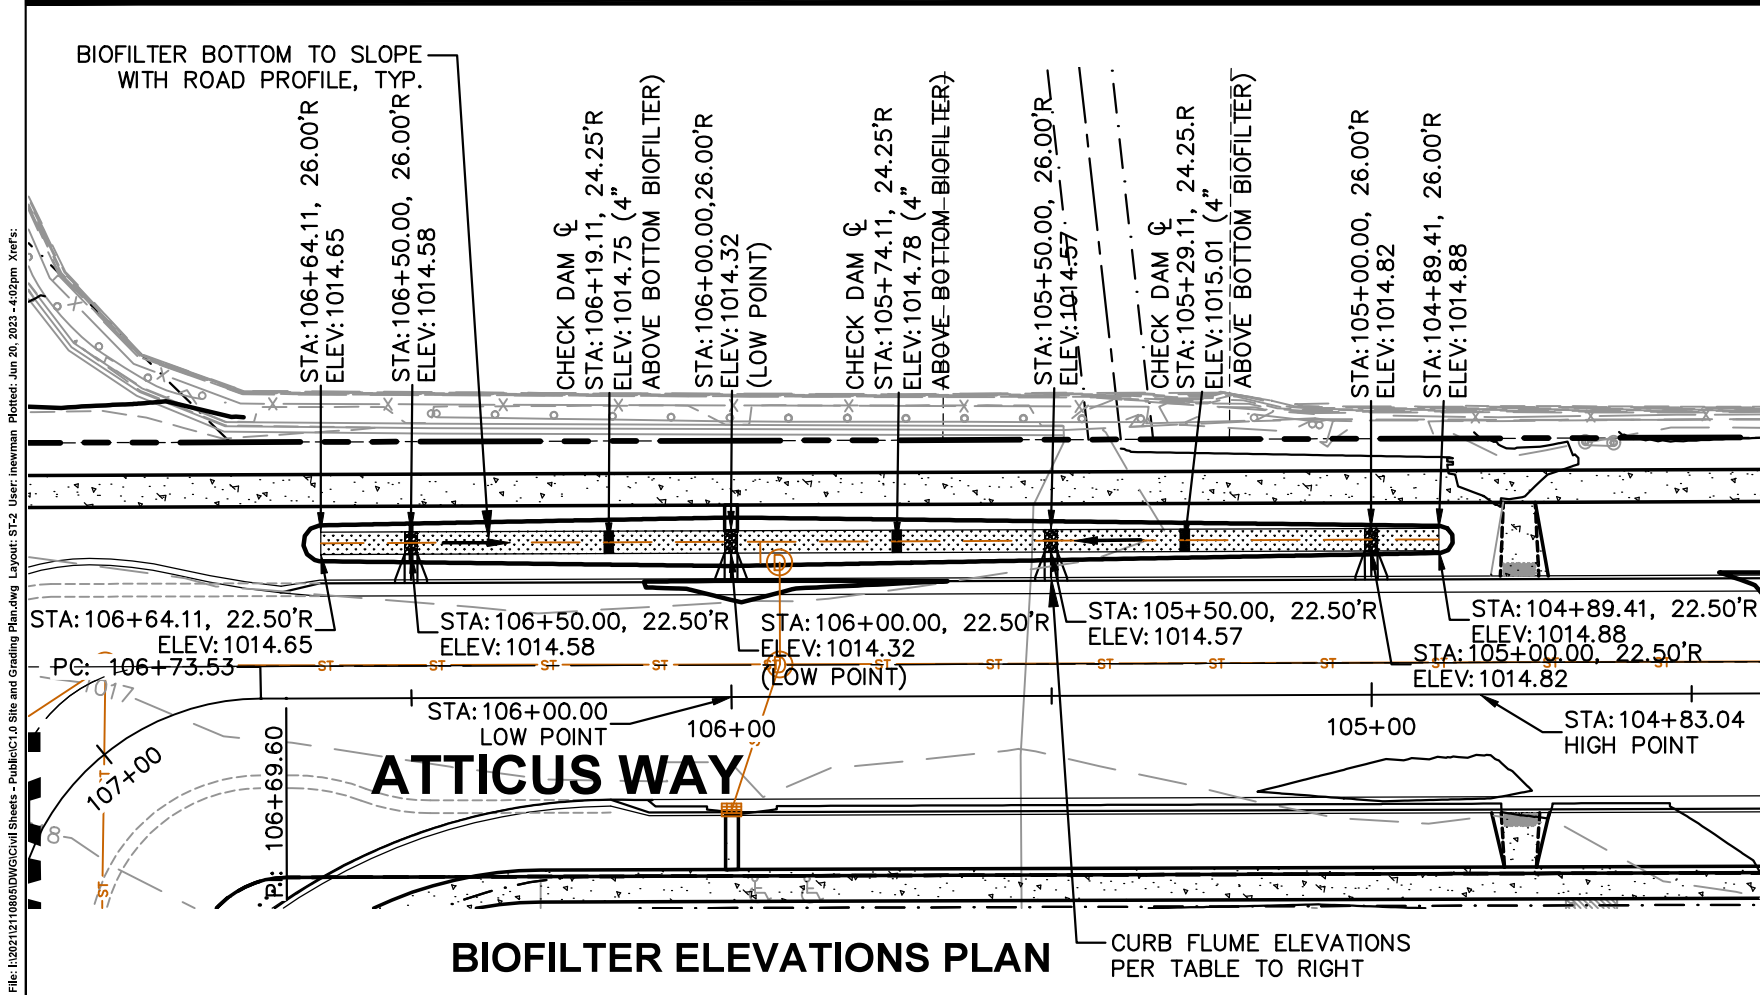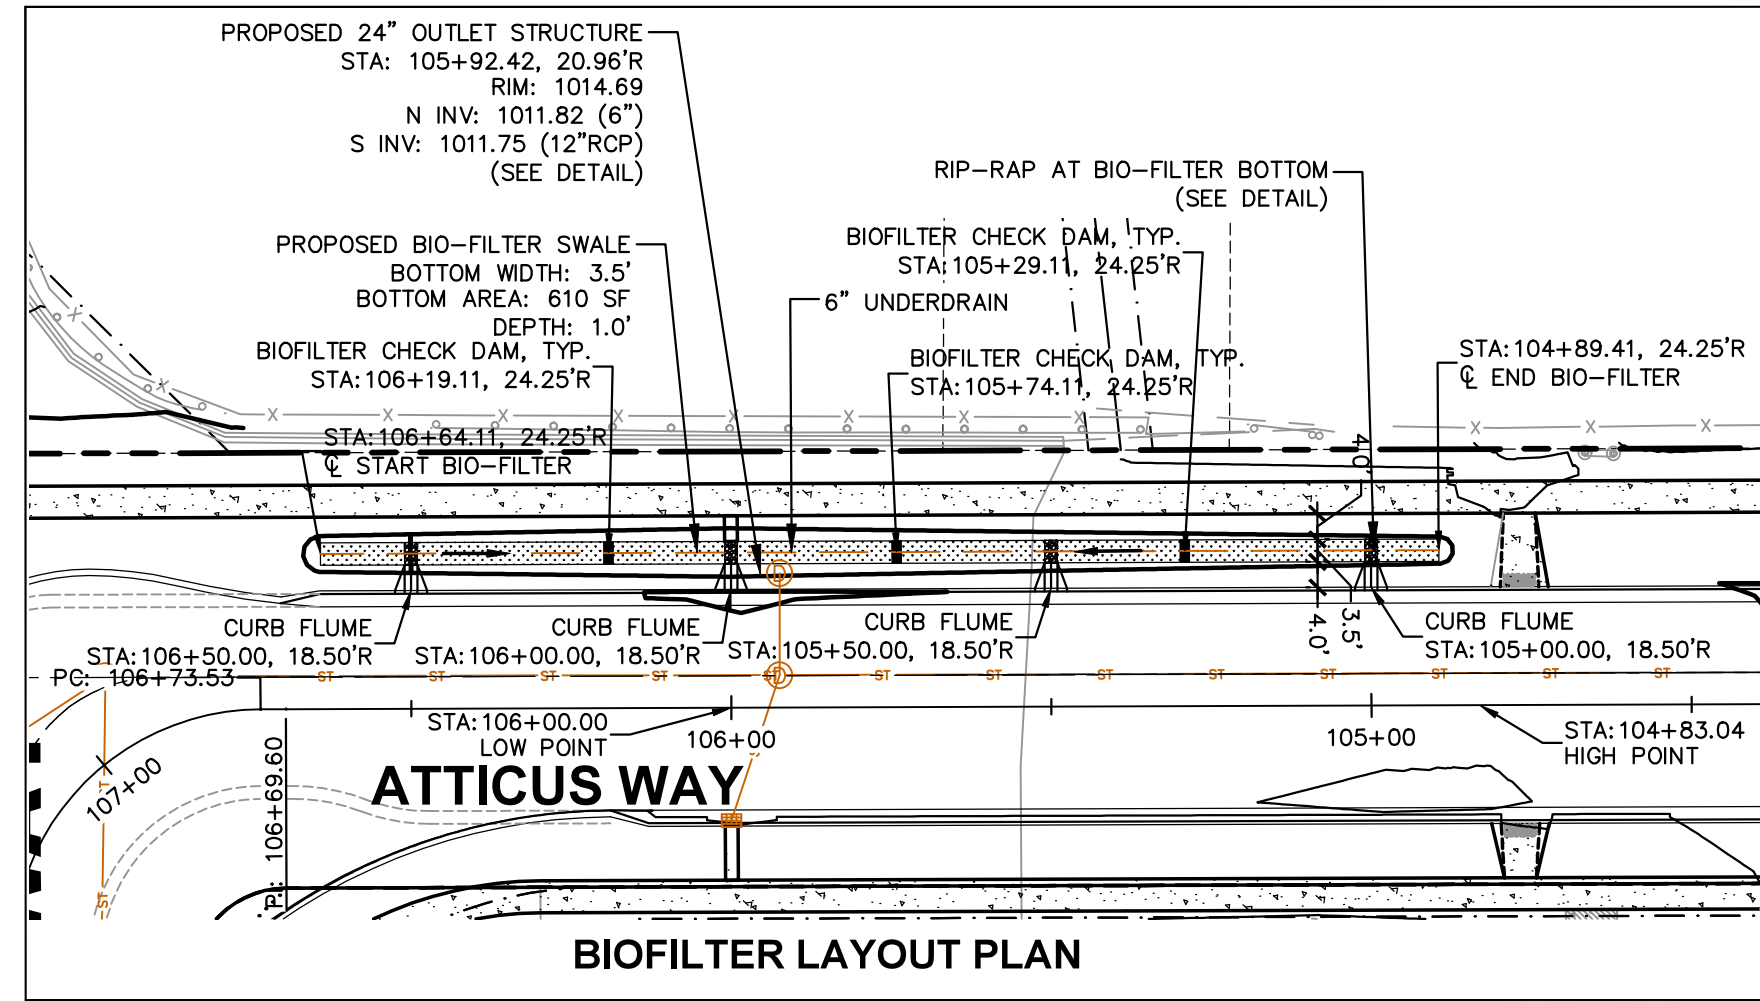

NOTE: LETTERS CORRESPOND TO TABLE BELOW WITH DESCRIPTIONS AND ELEVATIONS OF POINTS.

CURB FLUME ELEVATIONS						
DETAIL POINT ELEVATIONS/DESCRIPTIONS						
			STA: 106+50	STA: 106+00	STA: 105+50	STA: 105+00
Point	Point Description	Required Target Vertical Distance From Existing Flowing (ft)(in)	Elevation	Elevation	Elevation	Elevation
	Ex. EOG at CL of Flume	B + 0.125	1015.21	1014.96	1015.20	1015.45
A	Ex. Flow Line at CL of Flume	0	1015.08	1014.83	1015.07	1015.32
B	Pro. Gutter Flow Line at CL of Flume	B - 0.17'("2")	1014.91	1014.66	1014.90	1015.15
C	Edge of Flume @ Gutter (Uphill)	varies	1014.92	1014.67	1014.91	1015.16
D	Edge of Flume @ Gutter (Downhill)	varies	1014.90	1014.65	1014.89	1015.14
E	Bottom of Flume at CL	B - .3332'(4")	1014.75	1014.50	1014.74	1014.99
F	Bottom of Stone/Pond	E - 0.833'(10")	1013.91	1013.66	1013.90	1014.15
G	Edge of Flume @ Outfall (Upgradient along street)	E + 0.17'(2")	1014.92	1014.67	1014.91	1015.16
H	Edge of Flume @ Outfall (Downgradient along street)	E - 0.17'(2")	1014.58	1014.33	1014.57	1014.82

NOTE: LOCATION OF CURB FLUMES ARE BASED ON THE CENTRELINE FLOW LINE OF FLUME.

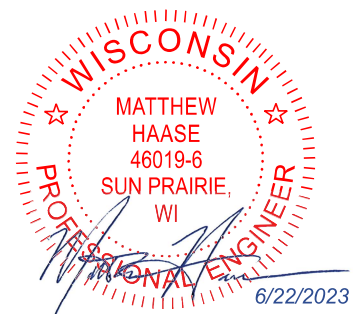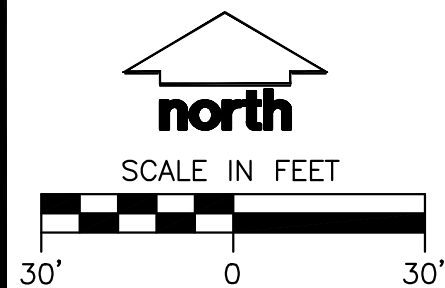

CREATE THE VISION TELL THE STORY

jsdinc.com

IDAHO REGIONAL OFFICE
418 EAST LAKE SIDE AVENUE
COEUR D'ALENE, ID 83814
P. 847.682.9420

CLIENT:
LINCOLN AVENUE
CAPITAL MANAGEMENT
LLC

CLIENT ADDRESS:
401 WILSHIRE BLVD #1070
SANTA MONICA, CA 90401

PROJECT:
ATTICUS WAY
CITY PROJECT #14774
CONTRACT #9231

PROJECT LOCATION:
4649 VERONA RD
MADISON, WI 53711

PLAN MODIFICATIONS:

#	Date	Description
1	04/20/23	PERMIT REVIEW
2	05/18/2023	NFC PLAN SET
3	06/21/2023	IFC PLAN SET
4		
5		
6		
7		
8		
9		
10		
11		
12		
13		
14		
15		

Designed By:
Reviewed By:
Approved By:

SHEET TITLE:
DETAILED BIO-FILTER
LAYOUT & ELEVATIONS
PLAN



SHEET NUMBER:

ST-2

JSD PROJECT NO:

21-10805

THESE PLANS AND DESIGNS ARE COPYRIGHT PROTECTED AND MAY NOT BE USED IN WHOLE OR IN PART WITHOUT THE WRITTEN CONSENT OF JSD PROFESSIONAL SERVICES, INC.

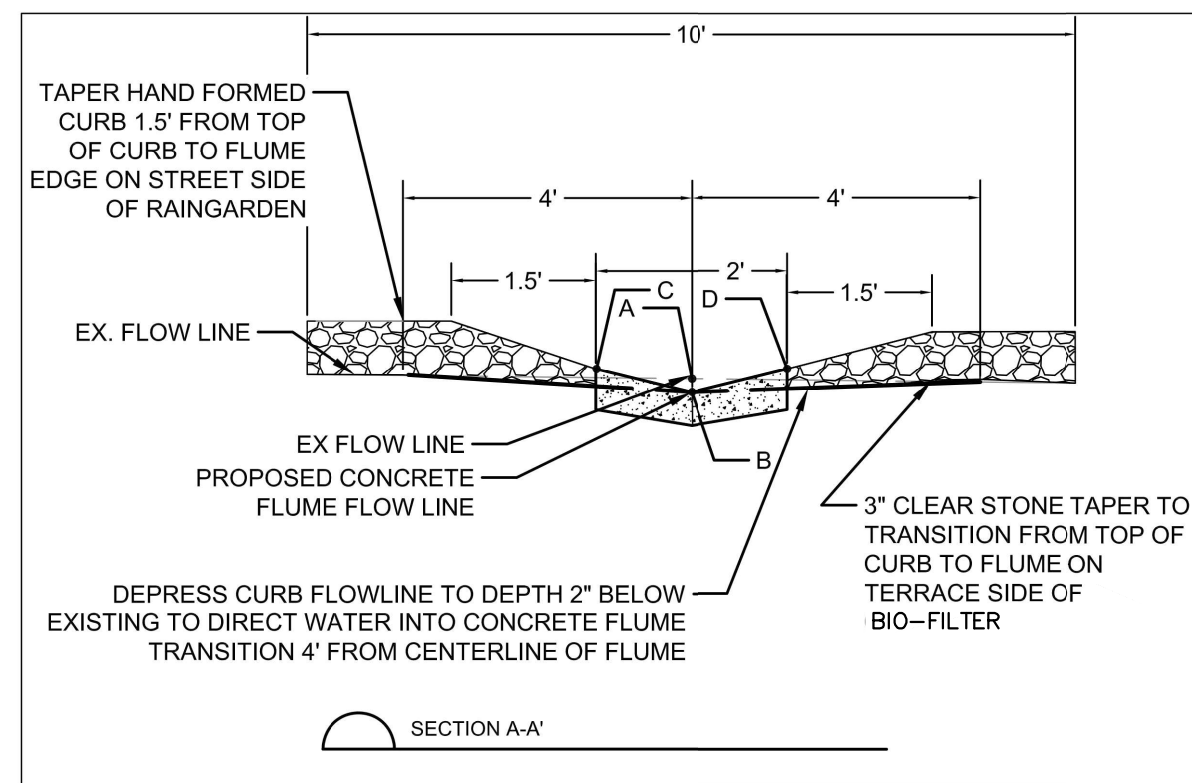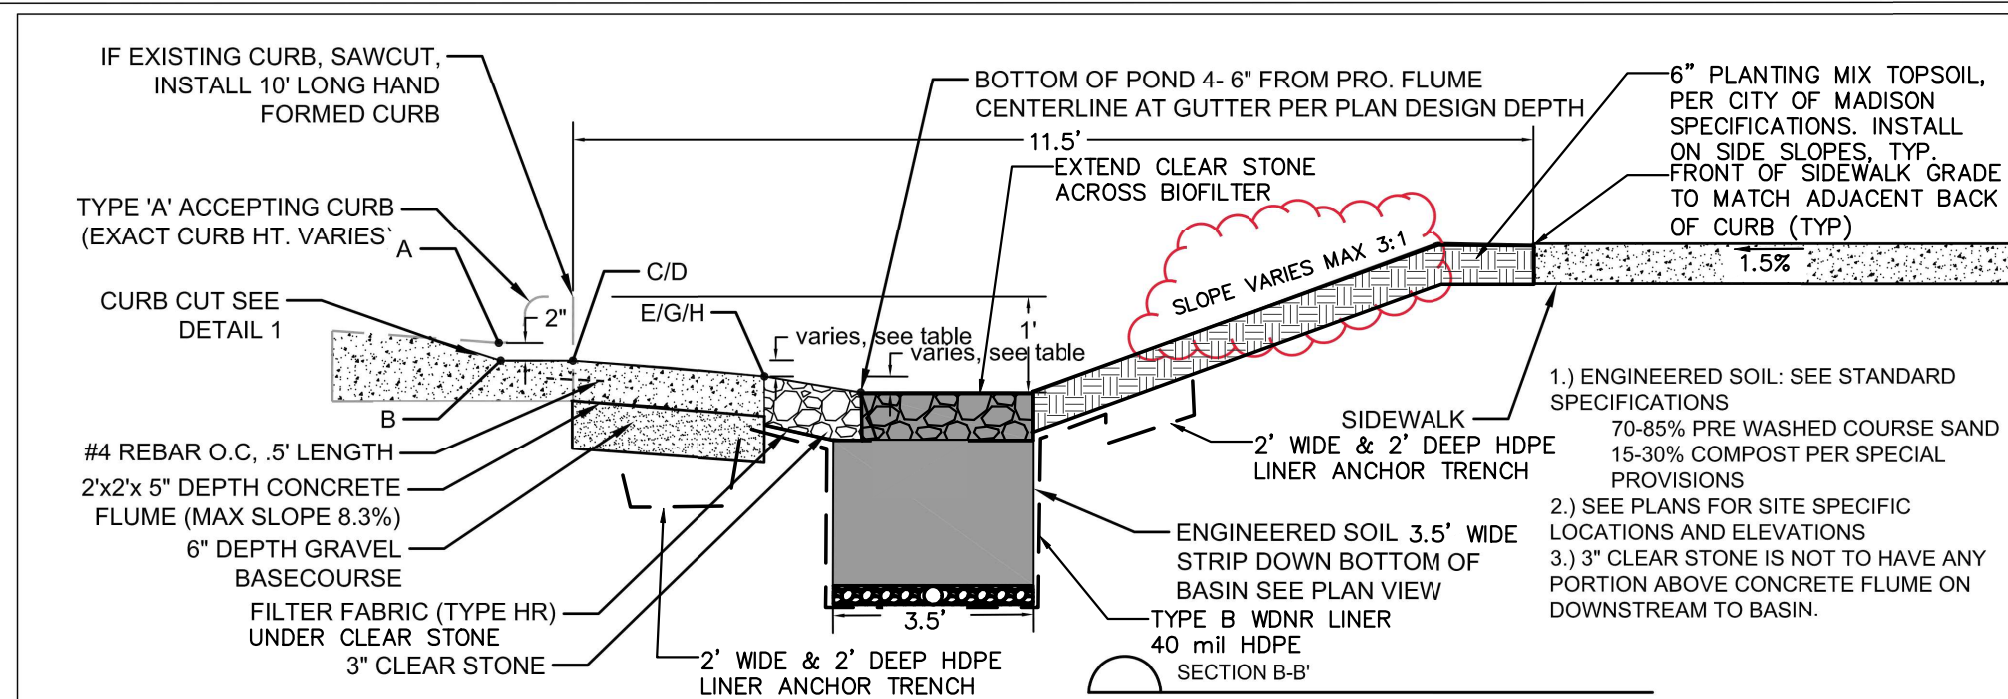

CREATE THE VISION  TELL THE STORY

jsdinc.com

IDAHO REGIONAL OFFICE
418 EAST LAKE SIDE AVENUE
COEUR D'ALENE, ID 83814
P. 847.682.9420

CLIENT:
**LINCOLN AVENUE
CAPITAL MANAGEMENT
LLC**

CLIENT ADDRESS:
401 WILSHIRE BLVD #1070
SANTA MONICA, CA 90401

PROJECT:
ATTICUS WAY
CITY PROJECT #14774
CONTRACT #9231

PROJECT LOCATION:
4649 VERONA RD
MADISON, WI 53711

PLAN MODIFICATIONS:		
#	Date:	Description:
1	04/20/23	PERMIT REVIEW
2	05/18/2023	NFC PLAN SET
3	06/21/2023	JFC PLAN SET
4		
5		
6		
7		
8		
9		
10		
11		
12		
13		
14		
15		

Designed By: _____
Reviewed By: _____
Approved By: _____

SHEET TITLE:
BIO-FILTER DETAILS


SHEET NUMBER:

ST-5


JSD PROJECT NO:

21-10805

File: I:\2024\2410805\DW\Civil\Shante - Public\00 BLOTTED DETAILS.dwg | Layout: ST-5 | User: inouman | Plotted: Jun 20, 2023 - 4:14pm | Page:

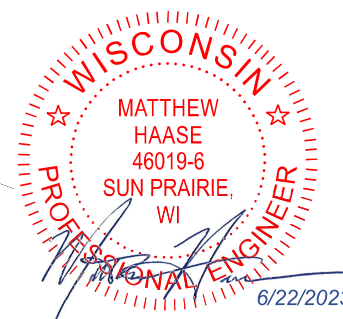

THESE PLANS AND DESIGNS ARE COPYRIGHT PROTECTED AND MAY NOT BE USED IN WHOLE OR IN PART WITHOUT THE WRITTEN CONSENT OF JSD PROFESSIONAL SERVICES, INC.

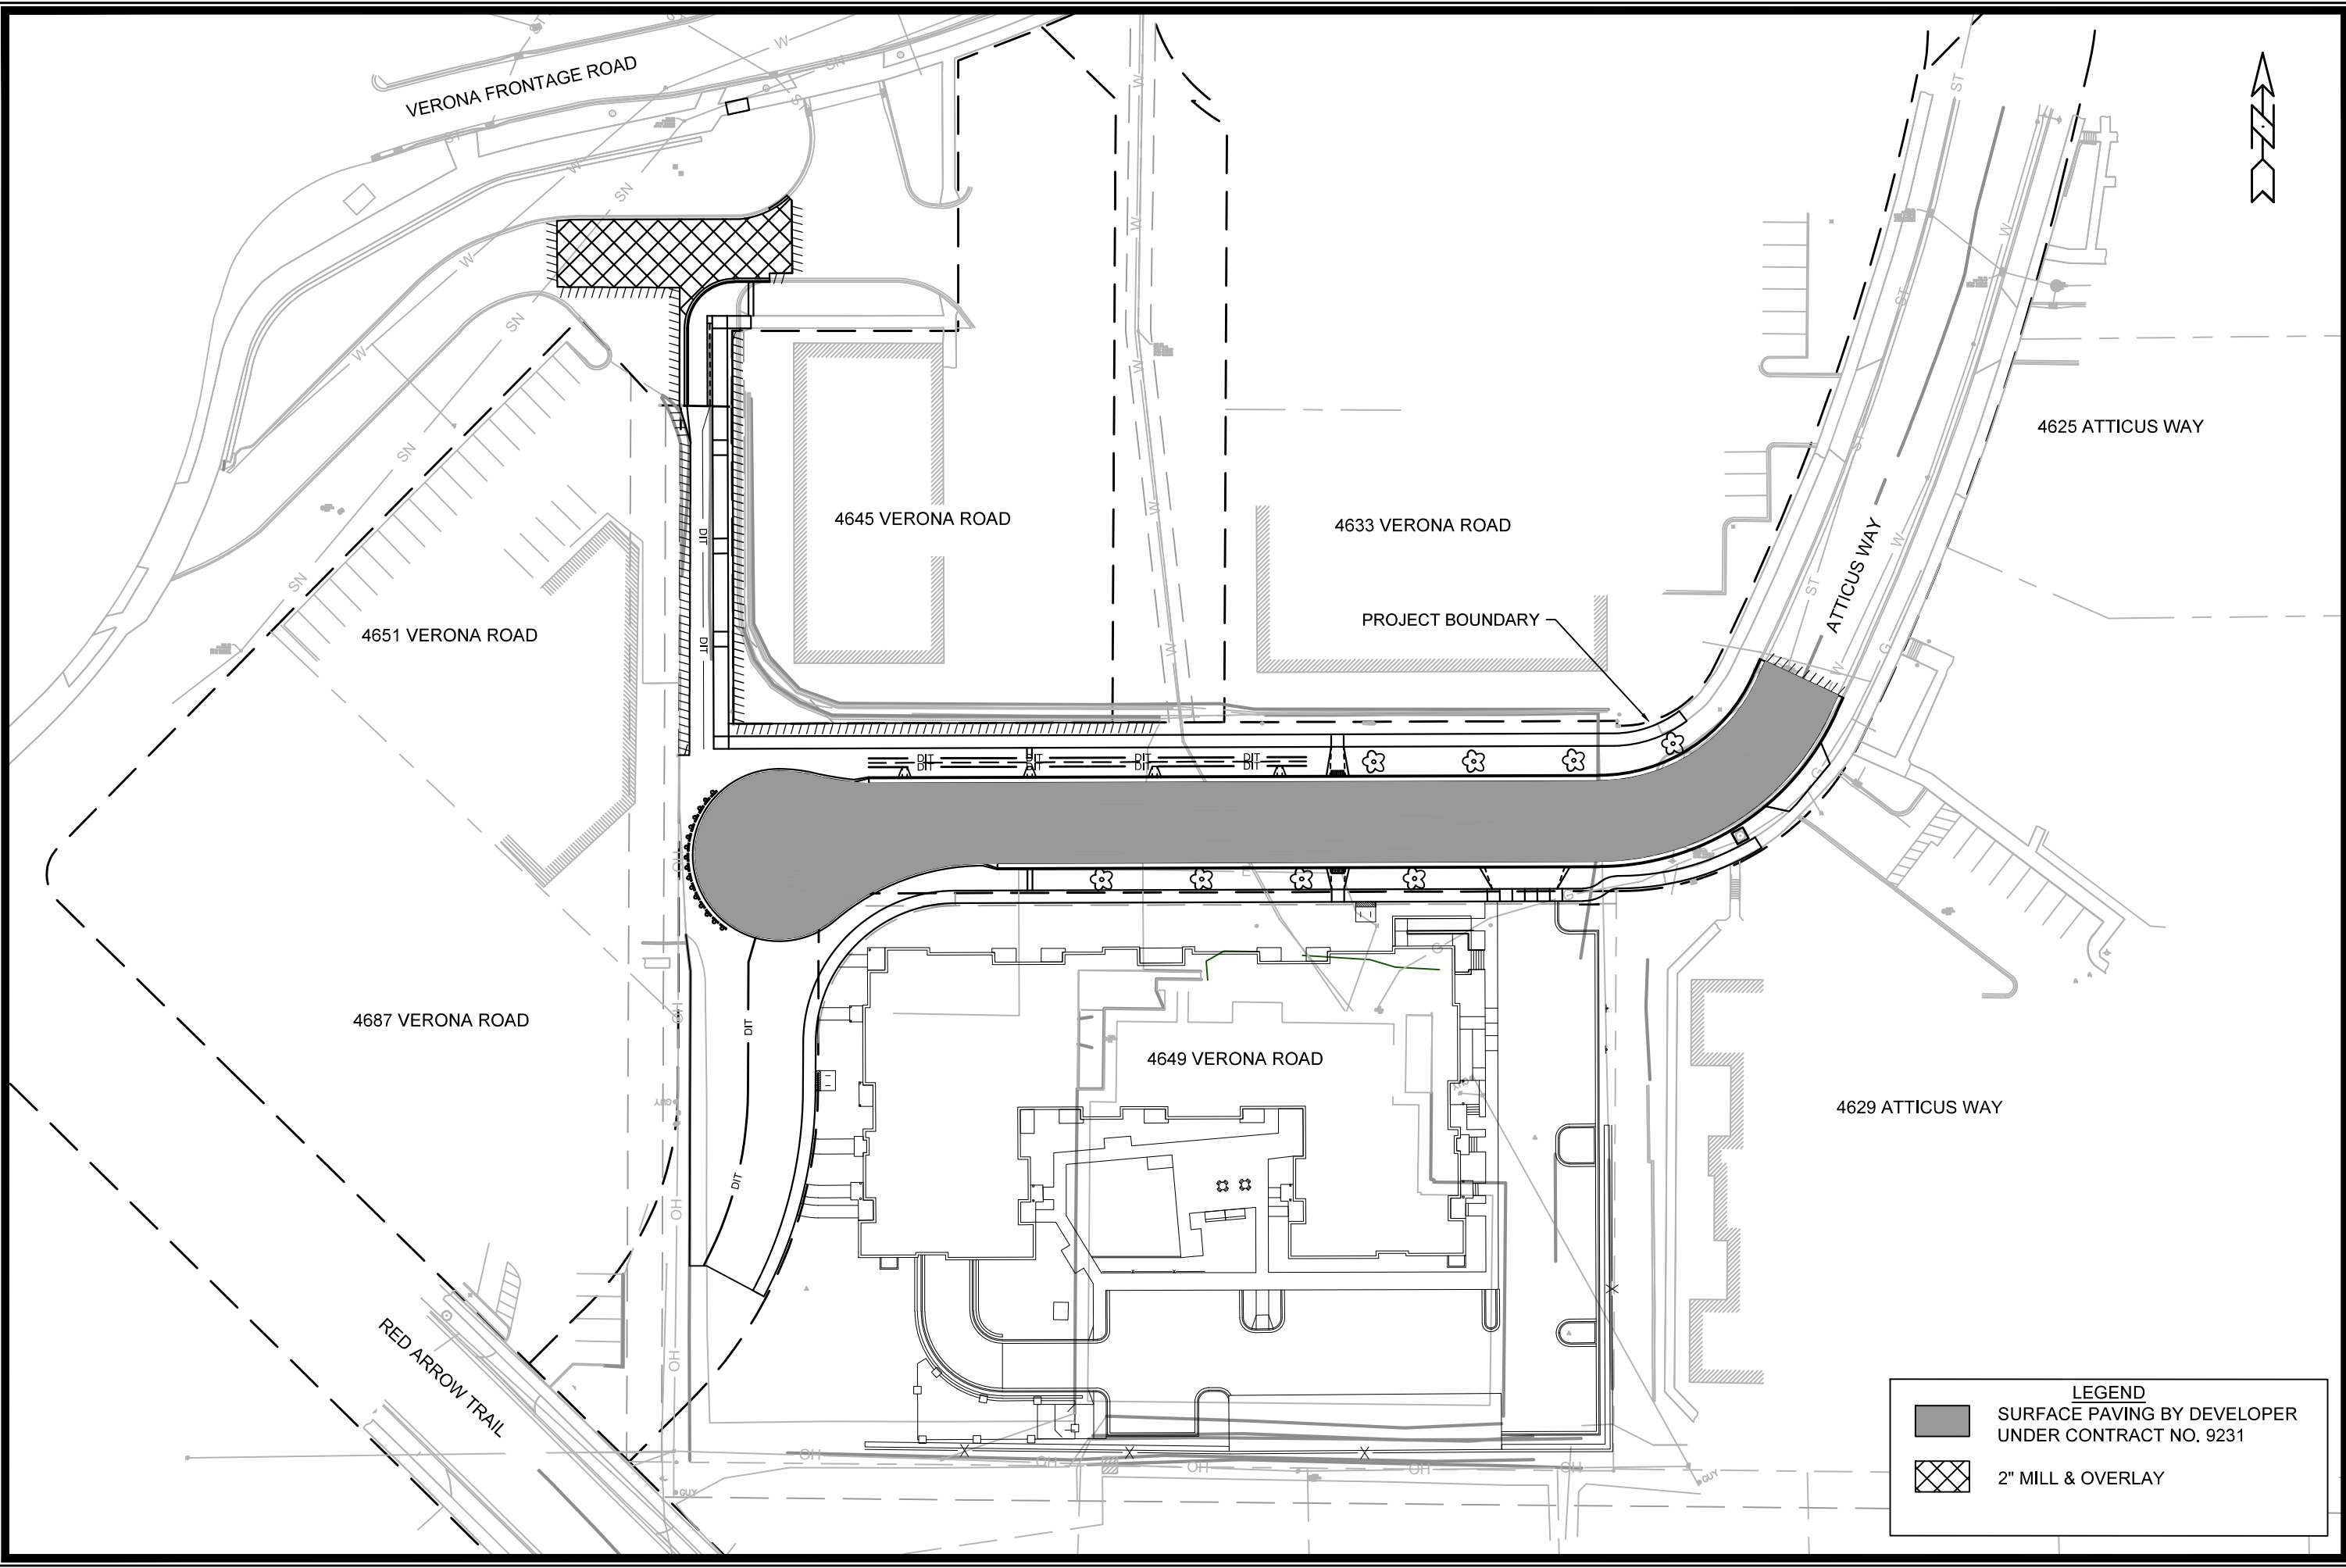



LEGEND

SURFACE PAVING BY DEVELOPER
UNDER CONTRACT NO. 9231

2" MILL & OVERLAY

PROJECT OVERVIEW

14774

MADISON, WI

M:\DESIGN\Projects\14774\CAD\Streets\14774EN-Street\Network.dwg

4649 VERONA ROAD

CONTRACT NO: 9231



14774



O-1

MARK	DESIGNED BY: ID	REVISION	DATE	BY
###	###	###	###	###
###	###	###	###	###
###	###	###	###	###
###	###	###	###	###

Date: 7/6/2023 8:54 AM

Scale: 1:60

O-1

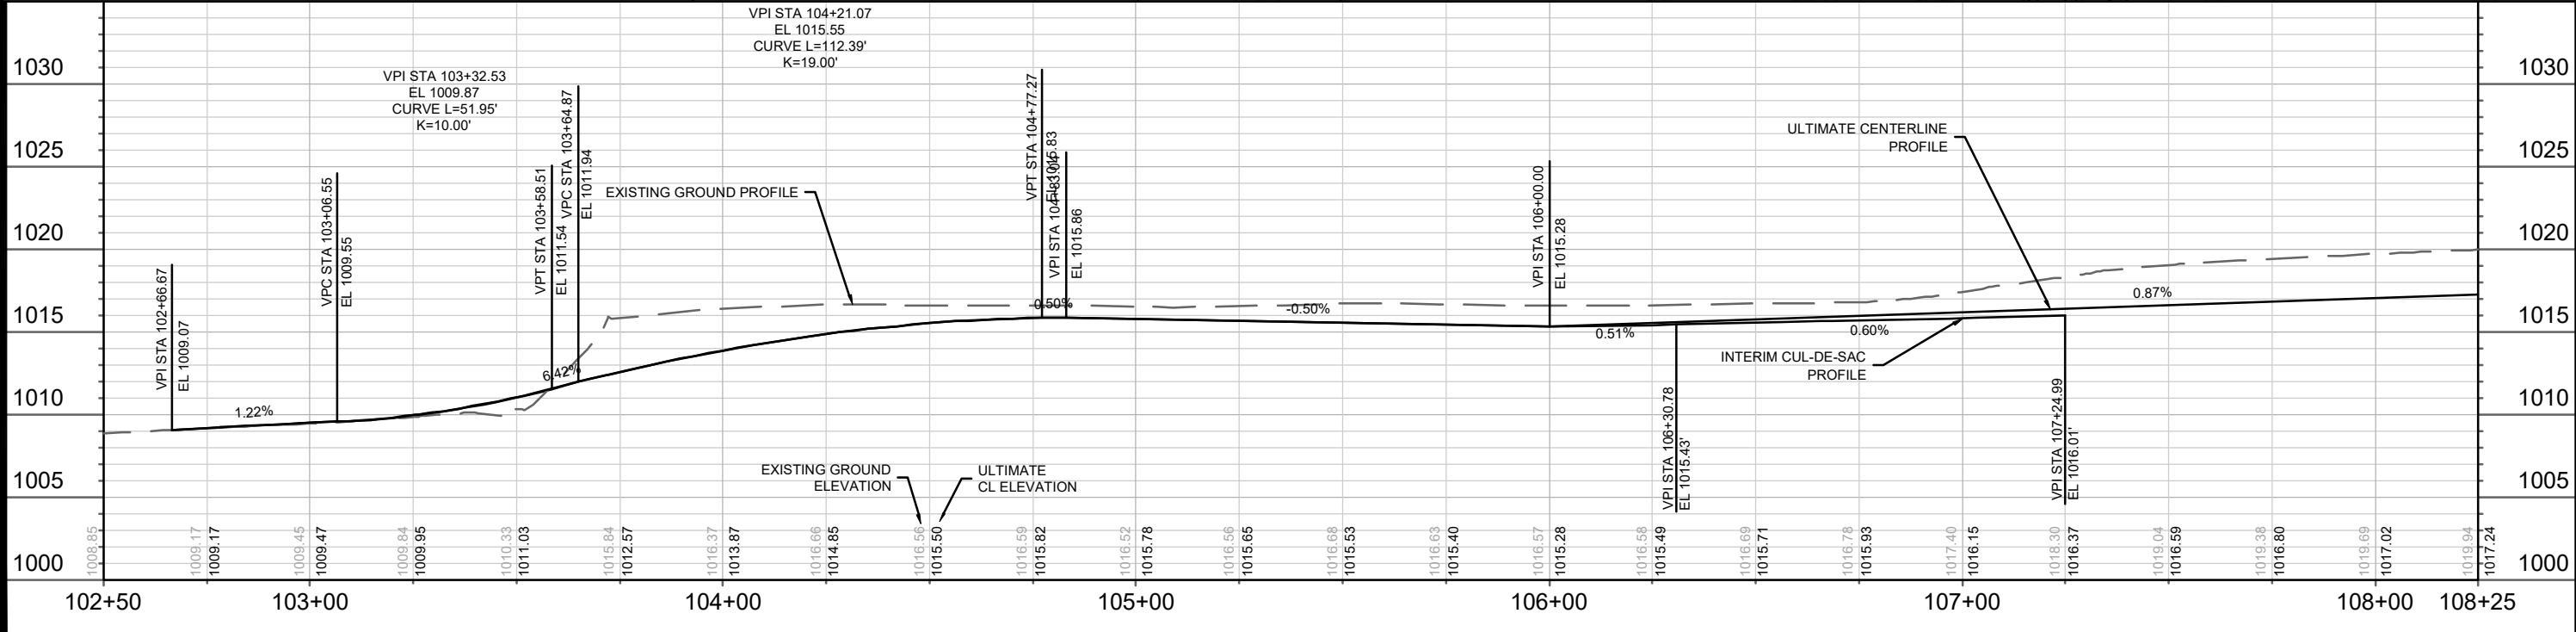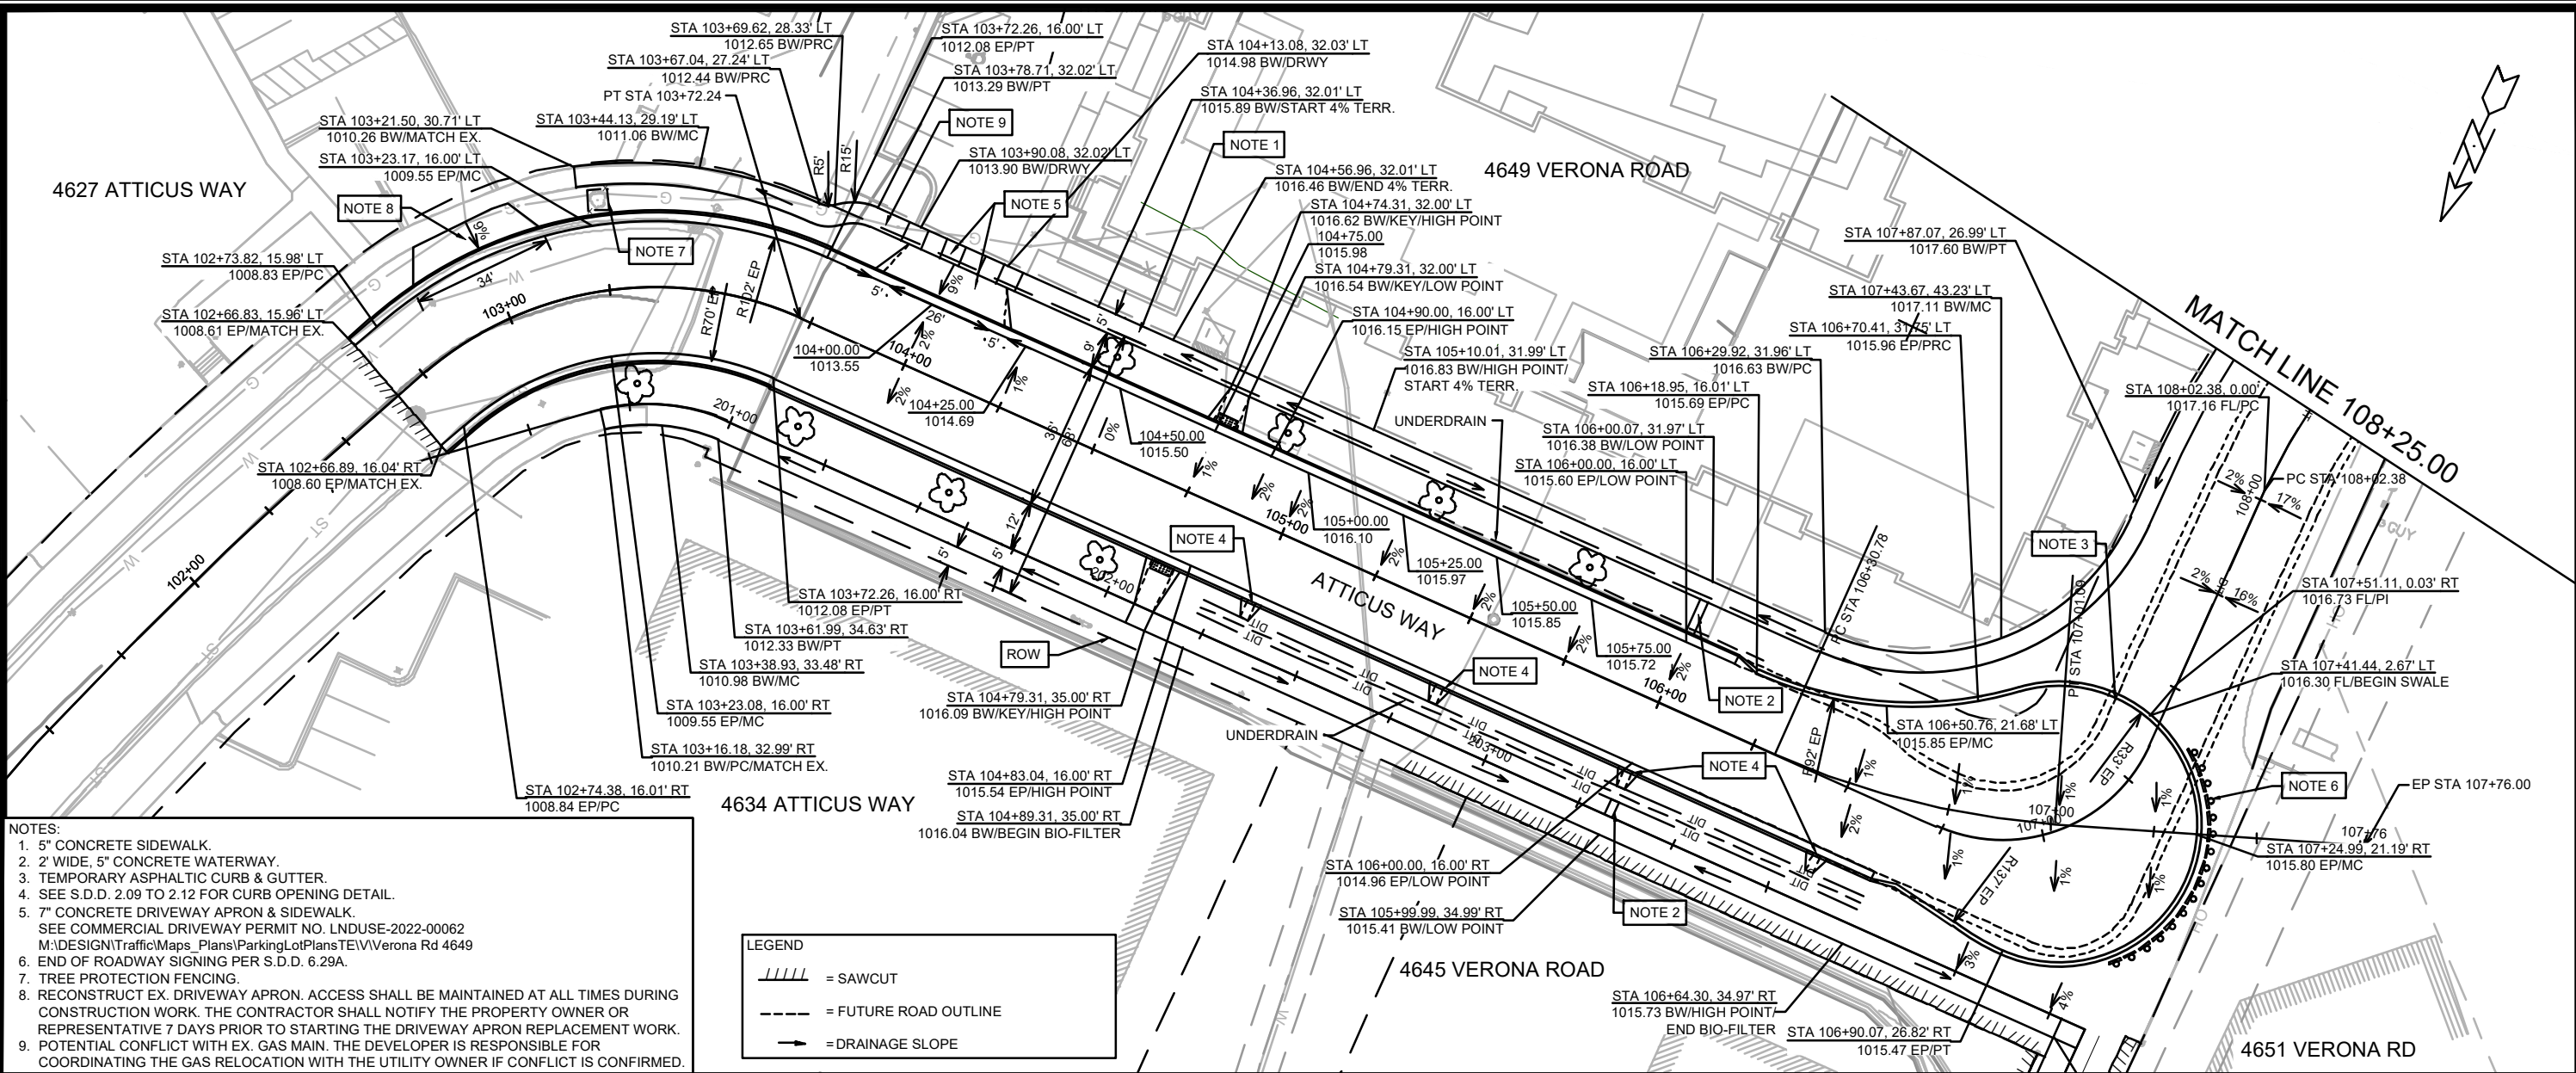

14774	MADISON, WI	9231	CONTRACT NO:
STREET PLAN & PROFILE - ATTICUS WAY			
4649 VERONA ROAD			
M:\DESIGN\Projects\14774\CAD\Streets\14774EN-PnP.dwg			
14774			
P-1			

SANITARY SEWER SCHEDULE

PROPOSED SANITARY STRUCTURES

SAS NO.	STATION	LOCATION (OFFSET)	TOP OF CASTING	E.I.	DEPTH	NOTES
ATTICUS WAY						
SAS #1	207+18.66'	RT-10.69	999.35	992.39	6.96	-
SAS #2	206+56.82'	LT-2.40	1004.33	993.00	11.33	-
SAS #3	206+57.00'	LT-55.93	1005.38	993.33	12.05	-
SAS #4	107+20.02'	RT-35.00	1016.16	999.93	16.23	-
SAS #5	105+42.76'	RT-13.49	1015.29	1002.27	13.02	-

SANITARY STRUCTURE ABANDONMENTS

STRUCTURE ID NO.	STATION	LOCATION (OFFSET)	TOP OF CASTING	E.I.	DEPTH	NOTES
ATTICUS WAY						
3667-006	207+10.46'	LT-10.90	999.13	992.48	6.65	-

PROPOSED SANITARY PIPES

FROM (DNSTM)	TO (UPSTM)	DWNSTRM E.I.	UPSTRM E.I.	PLAN (PAY) LGTH (FT)	SLOPE (%)	PIPE SIZE	PVC TYPE	NOTES
ATTICUS WAY								
SAS #1	SAS #2	992.49	993.00	64	0.80%	8"	SDR-26	-
SAS #2	SAS #3	993.10	993.33	54	0.43%	8"	SDR-26	-
SAS #2	SAS #4	993.10	999.93	214	3.20%	8"	SDR-26	-
SAS #4	SAS #5	1000.03	1002.27	187	1.20%	8"	SDR-26	-

SANITARY PIPES ABANDONMENTS

REMOVE FROM	REMOVE TO	LGTH (FT)	PIPE SIZE	PIPE TYPE	NOTES
ATTICUS WAY					
SAS #1	3667-006	24	8"	VCP	SLURRY, 0.31 CY
3667-006	SAS #3	70	8"	VCP	SLURRY, 0.90 CY

STORM SEWER SCHEDULE

4649 VERONA ROAD
PROJECT NO. 14774

SHEET NO.
U-4

STORM SEWER SCHEDULE

CITY OF MADISON

PROPOSED STORM STRUCTURES

STRUC. NO.	STATION	LOCATION (OFFSET)	TYPE	TOP OF CASTING	E.I.	DEPTH	NOTES
ATTICUS WAY (RIGHT-OF-WAY)							
S-30	103+26.72'	RT-17.50	3X3 SAS	1010.04	1005.63	4.41	FP; W/R-3067-7004-V; [3]
S-30A	103+44.11'	LT-14.62	18" PIPE COLLAR	-	1006.32	-	[4]
S-30B	103+45.30'	LT-17.51	H-INLET	1010.81	1006.37	4.44	FP; W/R-3067-7004-V; [5]
S-10	104+02.33'	RT-4.97	4X4 SAS	1013.88	1006.21	7.67	W/R-1550-0054
S-10A	104+02.45'	LT-29.02	3X3 SAS	1014.34	1006.58	7.76	W/R-1550-0054
S-11	105+92.42'	RT-5.08	3X3 SAS	1015.21	1009.89	5.32	W/R-1550-0054
S-11A	105+92.42'	RT-20.97	2' CIRCULAR SAS	-	-	-	[1]
S-11B	106+00.01'	LT-17.50	H INLET	1015.97	1012.50	3.47	LP; W/R-3067-7004-VB
S-12	106+93.89'	RT-15.88	3X3 SAS	1015.63	1011.37	4.26	W/R-1550-0054
S-13	107+25.97'	RT-8.28	3X3 SAS	1015.76	1012.20	3.56	W/R-1550-0054; [2]
S-13A	107+30.92'	LT-81.60	3X3 SAS	1017.39	1013.53	3.86	W/R-1550-0054; [2]
S21	206+46.88'	RT-20.94	H INLET	1004.49	1000.29	4.20	W/R-3067-7004-V
S22	206+30.91'	LT-0.99	3X3 SAS	1004.64	1000.47	4.17	W/R 1878-B7G

STORM STRUCTURE REMOVALS & ABANDONMENTS

STRUC. NO.	ID NO.	STATION	LOCATION (OFFSET)	TYPE	DEPTH (FT)	NOTES
ATTICUS WAY (RIGHT-OF-WAY)						
RS-30A	IN3667-022	103+26.25'	RT-18.96	INLET	3.88	
RS-30B	IN3667-023	103+44.11'	LT-14.62	INLET	4.88	

SPECIFIC NOTES

- [1] STRUCTURE GRATE: 24" HAALA CONE (PART # CG24TM) - SEE 4649 VERONA ROAD PRIVATE DEVELOPMENT STORM WATER MANAGEMENT PLAN FOR STRUCTURE INFORMATION AND DETAILS.
- [2] GRATE TO BE REPLACED WITH H-INLET CASTING DURING THE FUTURE ATTICUS WAY PROJECT.
- [3] CONNECT EX 18" RCP TO CUTOUTS WITH COLLARS, EI(NE) = 1005.63, EI(S) = 1005.86.
- [4] PLACE ELECTRONIC MARKER BALL ABOVE COLLAR
- [5] CONNECT EX 12" RCP PRIVATE STORM WITH COLLARS, APPROX EI(S) = 1006.50.

PROPOSED STORM PIPES

PIPE NO.	FROM (DNSTM)	TO (UPSTM)	DISCH. E.I.	INLET E.I.	PLAN (PAY) LGTH (FT)	PIPE LGTH (FT)	SLOPE (%)	PIPE SIZE	TYPE	NOTES
ATTICUS WAY (RIGHT-OF-WAY)										
P-30A	S-30A	S-30B	1006.32	1006.37	4	4	1.25%	18"	RCP	
P-10	S-30	S-10	1005.63	1006.21	69	65	0.89%	18"	RCP	-
P-10A	S-10	S-10A	1006.46	1006.58	34	31	0.39%	15"	RCP	-
P-11	S-10	S-11	1006.21	1009.89	191	187	1.97%	18"	RCP	-
P-11A	S-11	S-11A	1011.25	1011.75	16	14	3.57%	12"	RCP	-
P-11B	S-11	S-11B	1012.02	1012.50	24	22	2.18%	12"	RCP	-
P-12	S-11	S-12	1009.89	1011.37	106	103	1.44%	18"	RCP	-
P-13	S-12	S-13	1011.87	1012.20	34	30	1.10%	12"	RCP	-
P-13A	S-12	S-13A	1011.62	1013.53	105	102	1.87%	15"	RCP	-
P20	IN3667-104	S21	996.40	1000.29	69	67	5.81%	12"	RCP	-
P21	S21	S22	1000.29	1000.47	28	24	0.75%	12"	RCP	-



STORM PIPE REMOVALS & ABANDONMENTS

PIPE REMOVAL NO.	REMOVE FROM	REMOVE TO	LGTH (FT)	PAID (Y/N)	REM LGTH PAID (FT)	ABN LGTH (FT)	SLURRY (CY)	PIPE SIZE	PIPE TYPE	NOTES
ATTICUS WAY (RIGHT-OF-WAY)										
RP-30A	S-30A	S-30B	4	Y	4	0	0.00	12"	RCP	

NOTE: PLAN LENGTH (PAY LENGTH) IS FROM CENTER OF STRUCTURE TO CENTER OF STRUCTURE. PIPE LENGTH IS ACTUAL LENGTH OF PIPE FROM STRUCTURE WALL TO STRUCTURE WALL. SLOPE CALCULATED USING PIPE LENGTH.

STANDARD NOTES:

 - ABBREVIATIONS: AE = APRON ENDWALL; RCP = REINFORCED CONCRETE PIPE; HERCP = HORIZONTAL ELLIPTICAL REINFORCED CONCRETE PIPE; DNA = DOES NOT APPLY; SAS = SEWER ACCESS STRUCTURE; LP = LOW POINT INLET STRUCTURE; FP = FIELD POURED STRUCTURE; TR = TOP OF CONCRETE ROOF; NCM = NO CROWN MATCH FOR PIPES; UD = UNDERDRAIN
- TOP OF CASTING GRADE GIVEN IS THE TOP OF CURB FOR INLET STRUCTURES AND THE FLOWLINE OF THE CLOSED CASTING FOR SASS.
- TOP OF CONCRETE ROOF (TR) IS 1.25 BELOW TOP OF CASTING UNLESS OTHERWISE NOTED.
- ALL REINFORCED CONCRETE PIPES TO BE CLASS III UNLESS OTHERWISE NOTED.
- SURVEYOR TO CONFIRM THAT ALL INLET STATION / OFFSETS LINE UP WITH PROPOSED CURB AND GUTTER.
- ALL REBAR FOR FIELD POUR STRUCTURES SHALL BE EPOXY COATED. ANY EXPOSED STEEL SHALL BE TOUCHED UP OR RECOATED PRIOR TO USE.
- ALL FIELD POURED SAS STORM STRUCTURES SHALL BE CONSTRUCTED IN ACCORDANCE WITH STANDARD DETAIL DRAWING 5.7.3.
- ALL PRECAST SAS STORM STRUCTURES SHALL BE CONSTRUCTED IN ACCORDANCE WITH STANDARD DETAIL DRAWING 5.7.5.
- ALL STRUCTURES CALLED OUT AS FIELD POURED SHALL BE FIELD POURED. ALL OTHER STRUCTURES (NOT INDICATED AS FIELD POURED) SHALL BE SUBMITTED TO CITY ENGINEERING FOR APPROVAL IF PRECAST STRUCTURES ARE PREFERRED. CONTACT ERIC CEFALU OF CITY ENGINEERING AT (608) 243-5894 FOR PRECAST APPROVALS, FAX SHOP DRAWINGS TO (608) 264-9275, OR EMAIL SHOP DRAWINGS TO ECEFALU@CITYOFMADISON.COM.

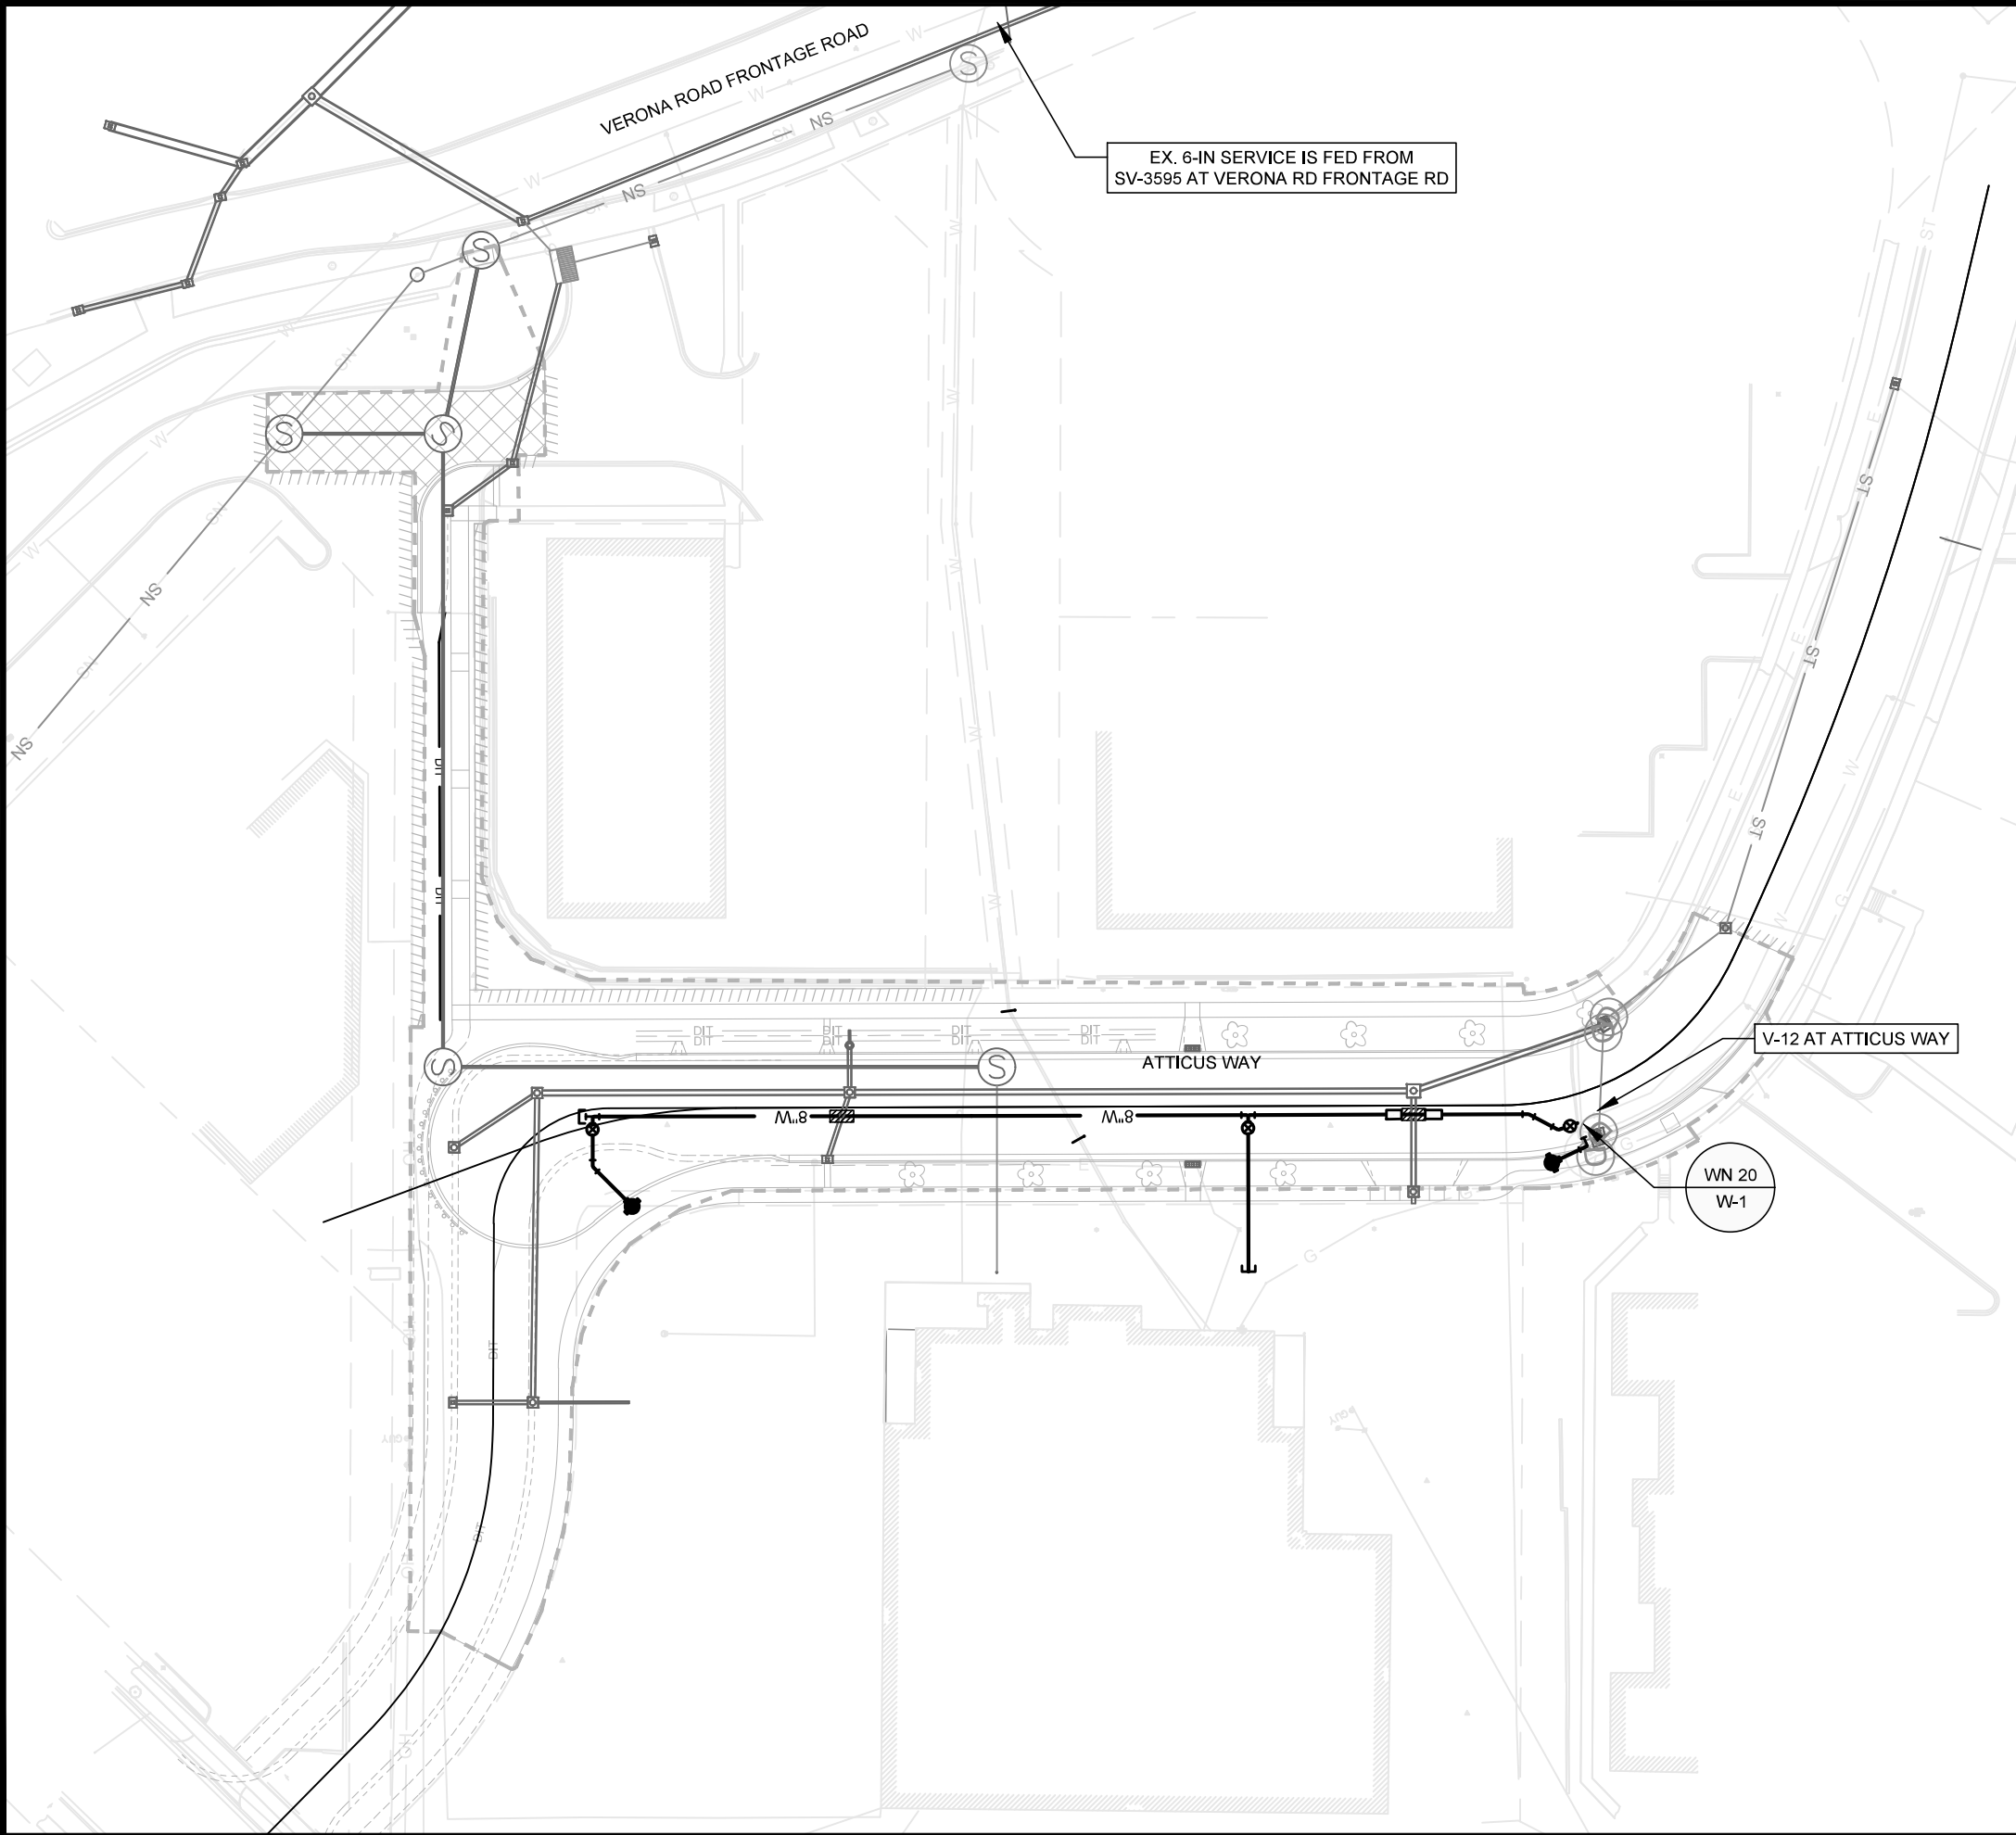

1" = 60'



WN20 W-1 CONNECT TO EX. TEE AT ATTICUS WAY
ISOLATION VALVE: V-12 AT ATTICUS WAY
NOTIFY: NONE REQUIRED

DISCLAIMER NOTE:
THE WATER IMPACT PLAN IS PROVIDED FOR REFERENCE PURPOSES
TO AID PLANNING CONNECTION POINT ISOLATION AND PREPARING
NOTIFICATION LISTS DURING PLANNED OUTAGES. REQUEST ANY
ALTERNATIVE CONNECTION METHODS IN WRITING, PER SPECS.

4649 VERONA ROAD
WATER IMPACT PLAN ATTICUS WAY
CITY OF MADISON, WISCONSIN



14774
W-2

SCALE: 1" = 60'
DESIGNED BY: TDP
MADISON WATER UTILITY
119 E OLIN AVE, MADISON, WI 53713
PRINTING DATE: 1/05/23

CONTRACT NO: 9231



CONSTRUCTION NOTES:

1. CONSTRUCT NEW WATER MAIN 6.0' BELOW FINISHED GRADE, UNLESS OTHERWISE NOTED. INSULATE MAIN WITH POLYSTYRENE BOARD AT UTILITY CROSSINGS OR OTHER AREAS IDENTIFIED BY ENGINEER AS HAVING INADEQUATE COVER.
2. VERIFY SIZE OF EXISTING WATER SERVICES AND RECONNECT SERVICES AS INDICATED.
3. MINIMIZE DISRUPTION OF SERVICE TO CUSTOMERS. NOTIFY PER CONTRACT REQUIREMENTS OF ANY PLANNED WATER OUTAGE.

- WN1 REPLACE THE EXISTING LEAD SERVICE WITH A NEW COPPER SERVICE.
- WN-2 EXTEND AND RECONNECT THE EXISTING COPPER SERVICE TO THE NEW WATER MAIN.
- WN-3 EXISTING SERVICE TO BE ABANDONED WHEN THE WATER MAIN IS CUT OFF.
- WN-4 DISCONNECT FROM THE OLD WATER MAIN AND RECONNECT THE EXISTING COPPER WATER SERVICE LATERAL TO THE NEW WATER MAIN.
- WN-5 RELOCATE THE EXISTING FIRE HYDRANT.
- WN-6 ABANDON WATER VALVE ACCESS STRUCTURE.
- WN-7 FURNISH AND INSTALL THE NEW TOP SECTION FOR THE WATER ACCESS STRUCTURE.
- WN-8 ABANDON THE VALVE BOX.
- WN-9 FURNISH THE DITCH, COMPACTION, AND ALL MATERIALS AND LABOR FOR THE INSTALLATION OF NEW SERVICE LATERAL.
- WN-10 REMOVE AND SALVAGE EXISTING HYDRANT
- WN-11 REPLACE THE EXISTING COPPER SERVICE WITH A COPPER SERVICE
- WN-20+ SEE WATER IMPACT PLAN FOR CONNECTION POINT ISOLATION AND WATER SHUT-OFF NOTIFICATION INFORMATION.

WATER UTILITY ULO SCHEDULE

ULO	UTILITY	STATION	OFFSET	SHEET
-----	---------	---------	--------	-------

*ESTIMATE OF MATERIALS SUPPLIED BY CONTRACTOR:

PAY ITEM ID	DESCRIPTION	QUANTITY	UNIT
70002	FURNISH AND INSTALL 6-INCH PIPE & FITTINGS	120	LNFT
70003	FURNISH AND INSTALL 8-INCH PIPE & FITTINGS	360	LNFT
70031	FURNISH AND INSTALL 6-INCH WATER VALVE	2	EACH
70032	FURNISH AND INSTALL 8-INCH WATER VALVE	1	EACH
70040	FURNISH AND INSTALL AND SALVAGE HYDRANT	2	EACH
70101	FURNISH AND INSTALL STYROFOAM	2	EACH
71001	6-IN MJ CAP	3	EACH
71014	8-IN MJ PLUG	1	EACH
71110	6-IN 90° BEND	1	EACH
71122	6-IN 45° BEND	1	EACH
71123	8-IN 45° BEND	1	EACH
71135	8-IN 22-1/2° BEND	1	EACH
71210	8X6-IN TEE	2	EACH
71342	8X24-IN OFFSET	2	EACH

*ESTIMATE OF MATERIALS SUPPLIED BY WATER UTILITY:

--	--	--	--

*ESTIMATE OF MATERIALS SALVAGED:


	HYDRANT	1	EACH
	8-IN MJ PLUG	1	EACH

* ESTIMATE OF MATERIALS IS FOR INFORMATION ONLY. ENGINEER DOES NOT GUARANTEE ACCURACY OF MATERIAL TAKE-OFF.

TO OBTAIN LOCATION OF PARTICIPANTS' UNDERGROUND FACILITIES BEFORE YOU DIG IN WISCONSIN

CALL DIGGERS HOTLINE
TOLL FREE
811 OR 1-800-242-8511
FAX-A-LOCATE 1-800-338-3860
TDD (FOR HEARING IMPAIRED) 1-800-542-2289


WIS. STATUTE 182.0175 (1974)
REQUIRES MIN. OF 3 WORK DAYS
NOTICE BEFORE YOU EXCAVATE.

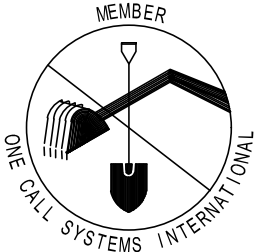

DISCLAIMER NOTE: UTILITY LOCATIONS SHOWN ARE APPROXIMATE ONLY. IT SHALL BE THE CONTRACTOR'S RESPONSIBILITY TO DETERMINE THE EXACT HORIZONTAL AND VERTICAL LOCATION OF ALL EXISTING UNDERGROUND AND OVERHEAD UTILITIES PRIOR TO COMMENCING WORK.

PART VII - WATER MAINS AND SERVICE LATERALS

DETAIL DRAWING NO. 7.04
REVISED: 11/2022

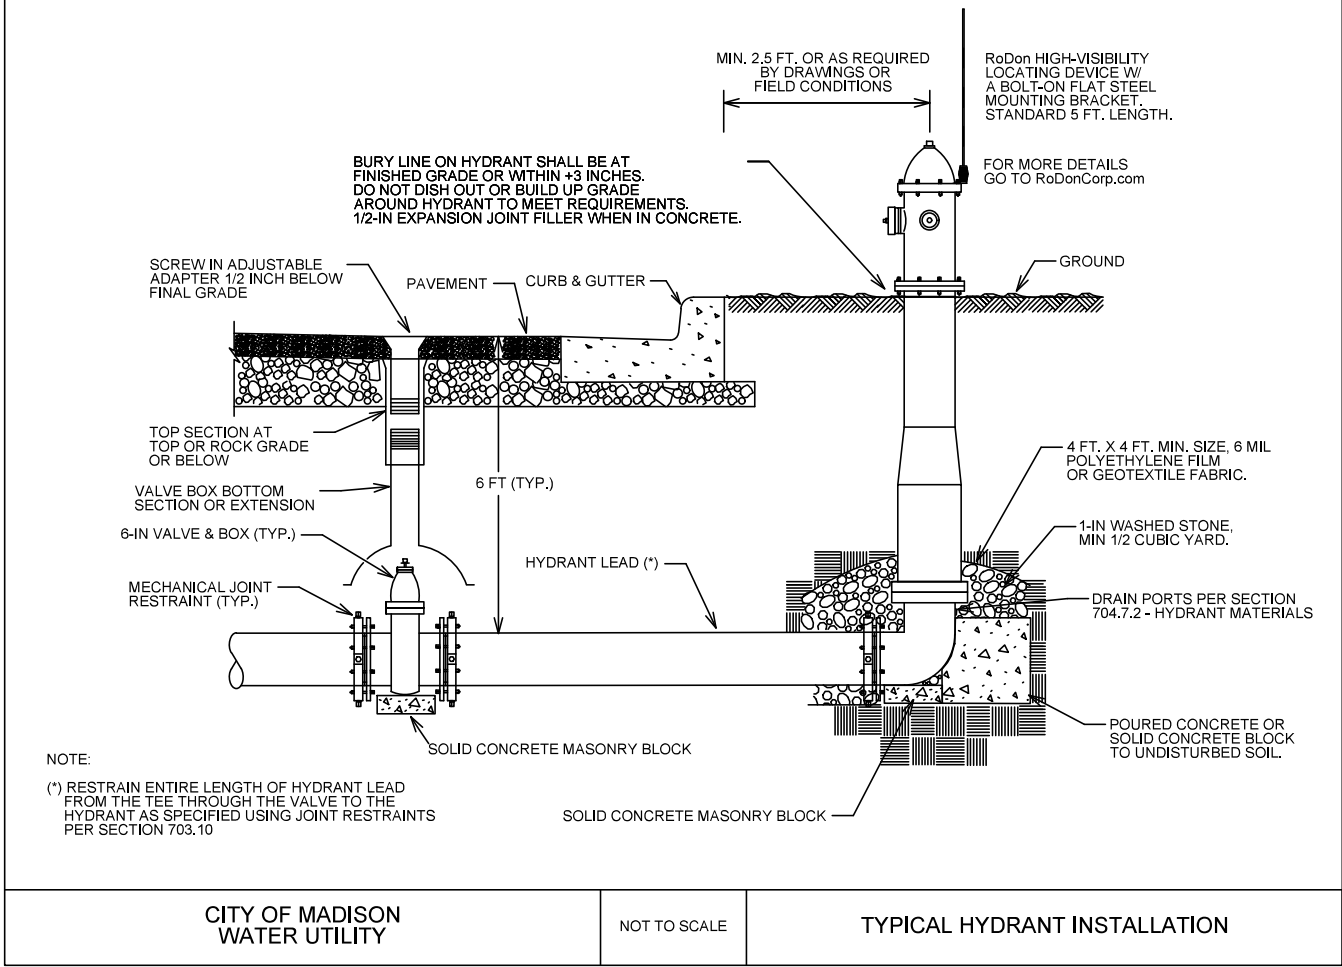





4649 VERONA ROAD CSM
WATER ESTIMATE OF MATERIALS
CITY OF MADISON, WISCONSIN






14774
W-3

SCALE: N/A
DESIGNED BY: TDP
MADISON WATER UTILITY
119 E OLIN AVE, MADISON, WI 53713
PRINTING DATE: 7/7/23

 CONTRACT NO: 9231

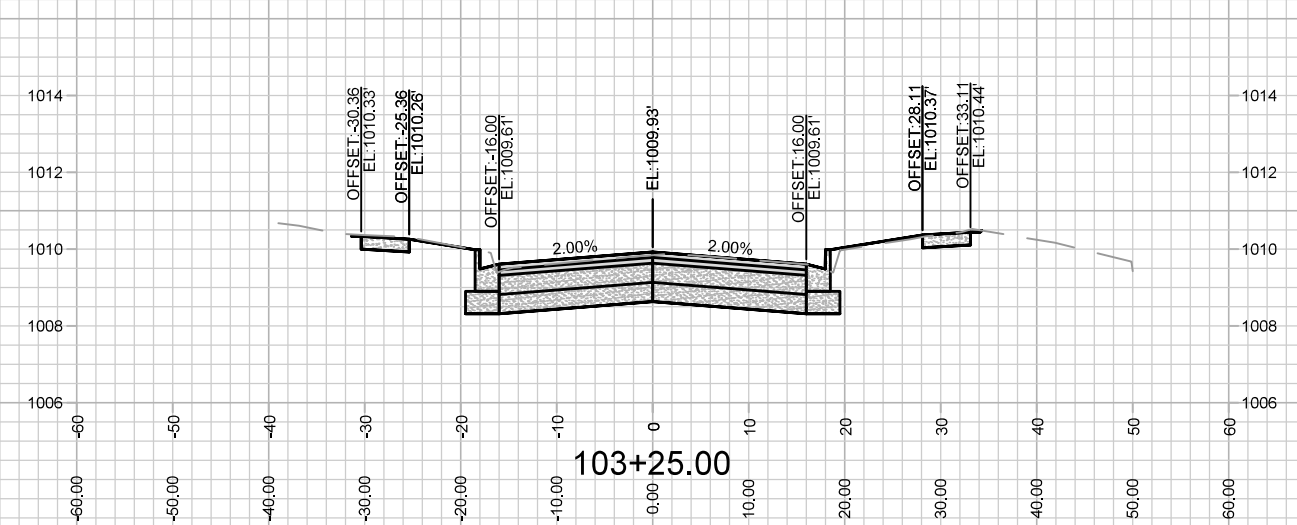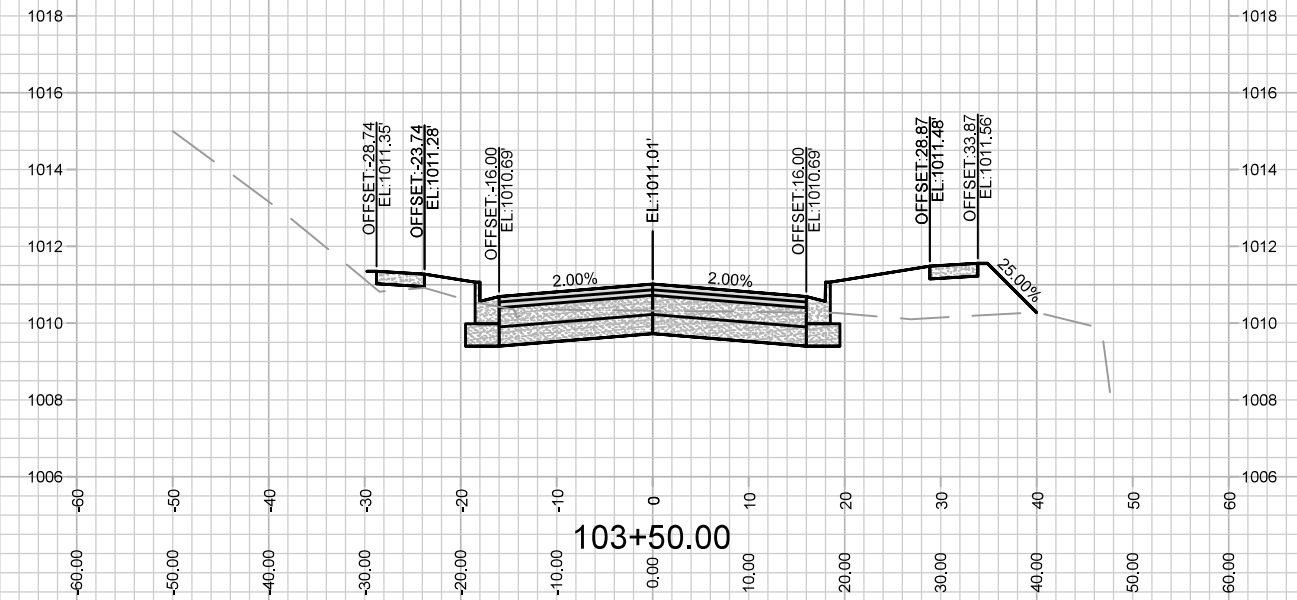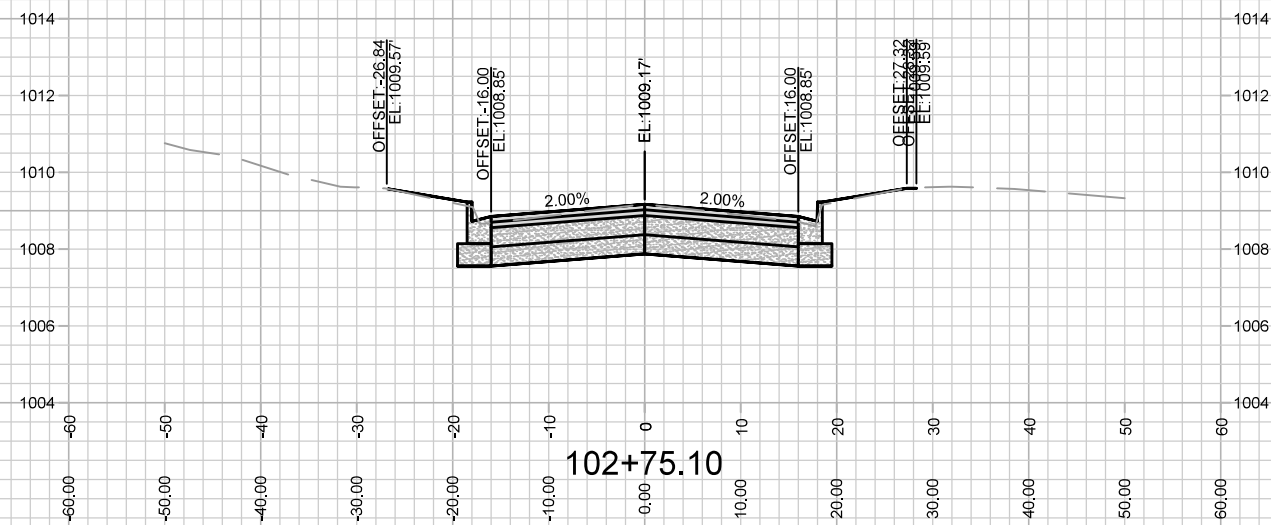
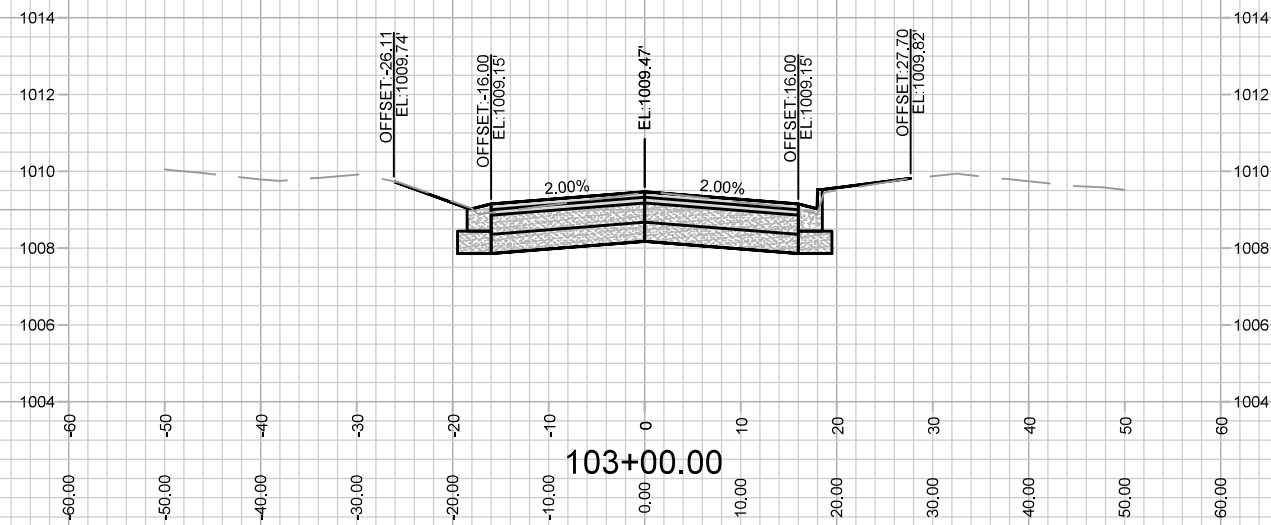


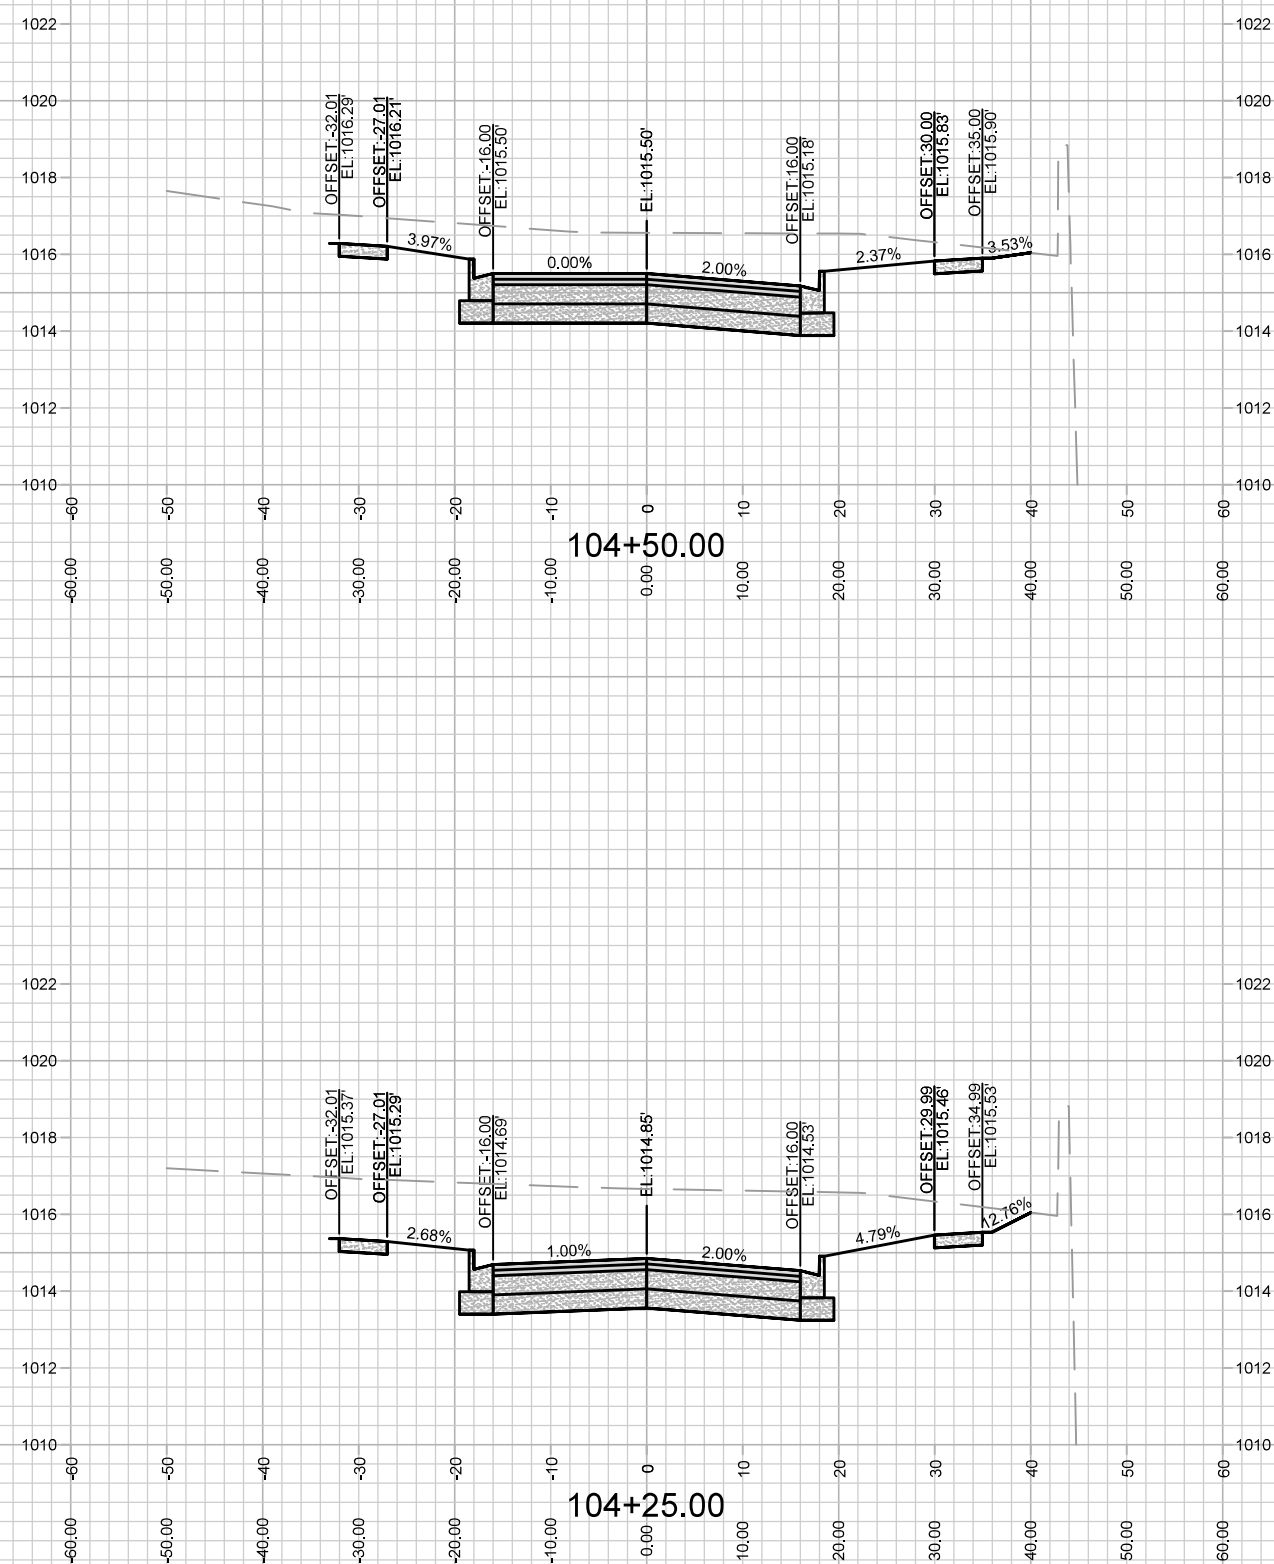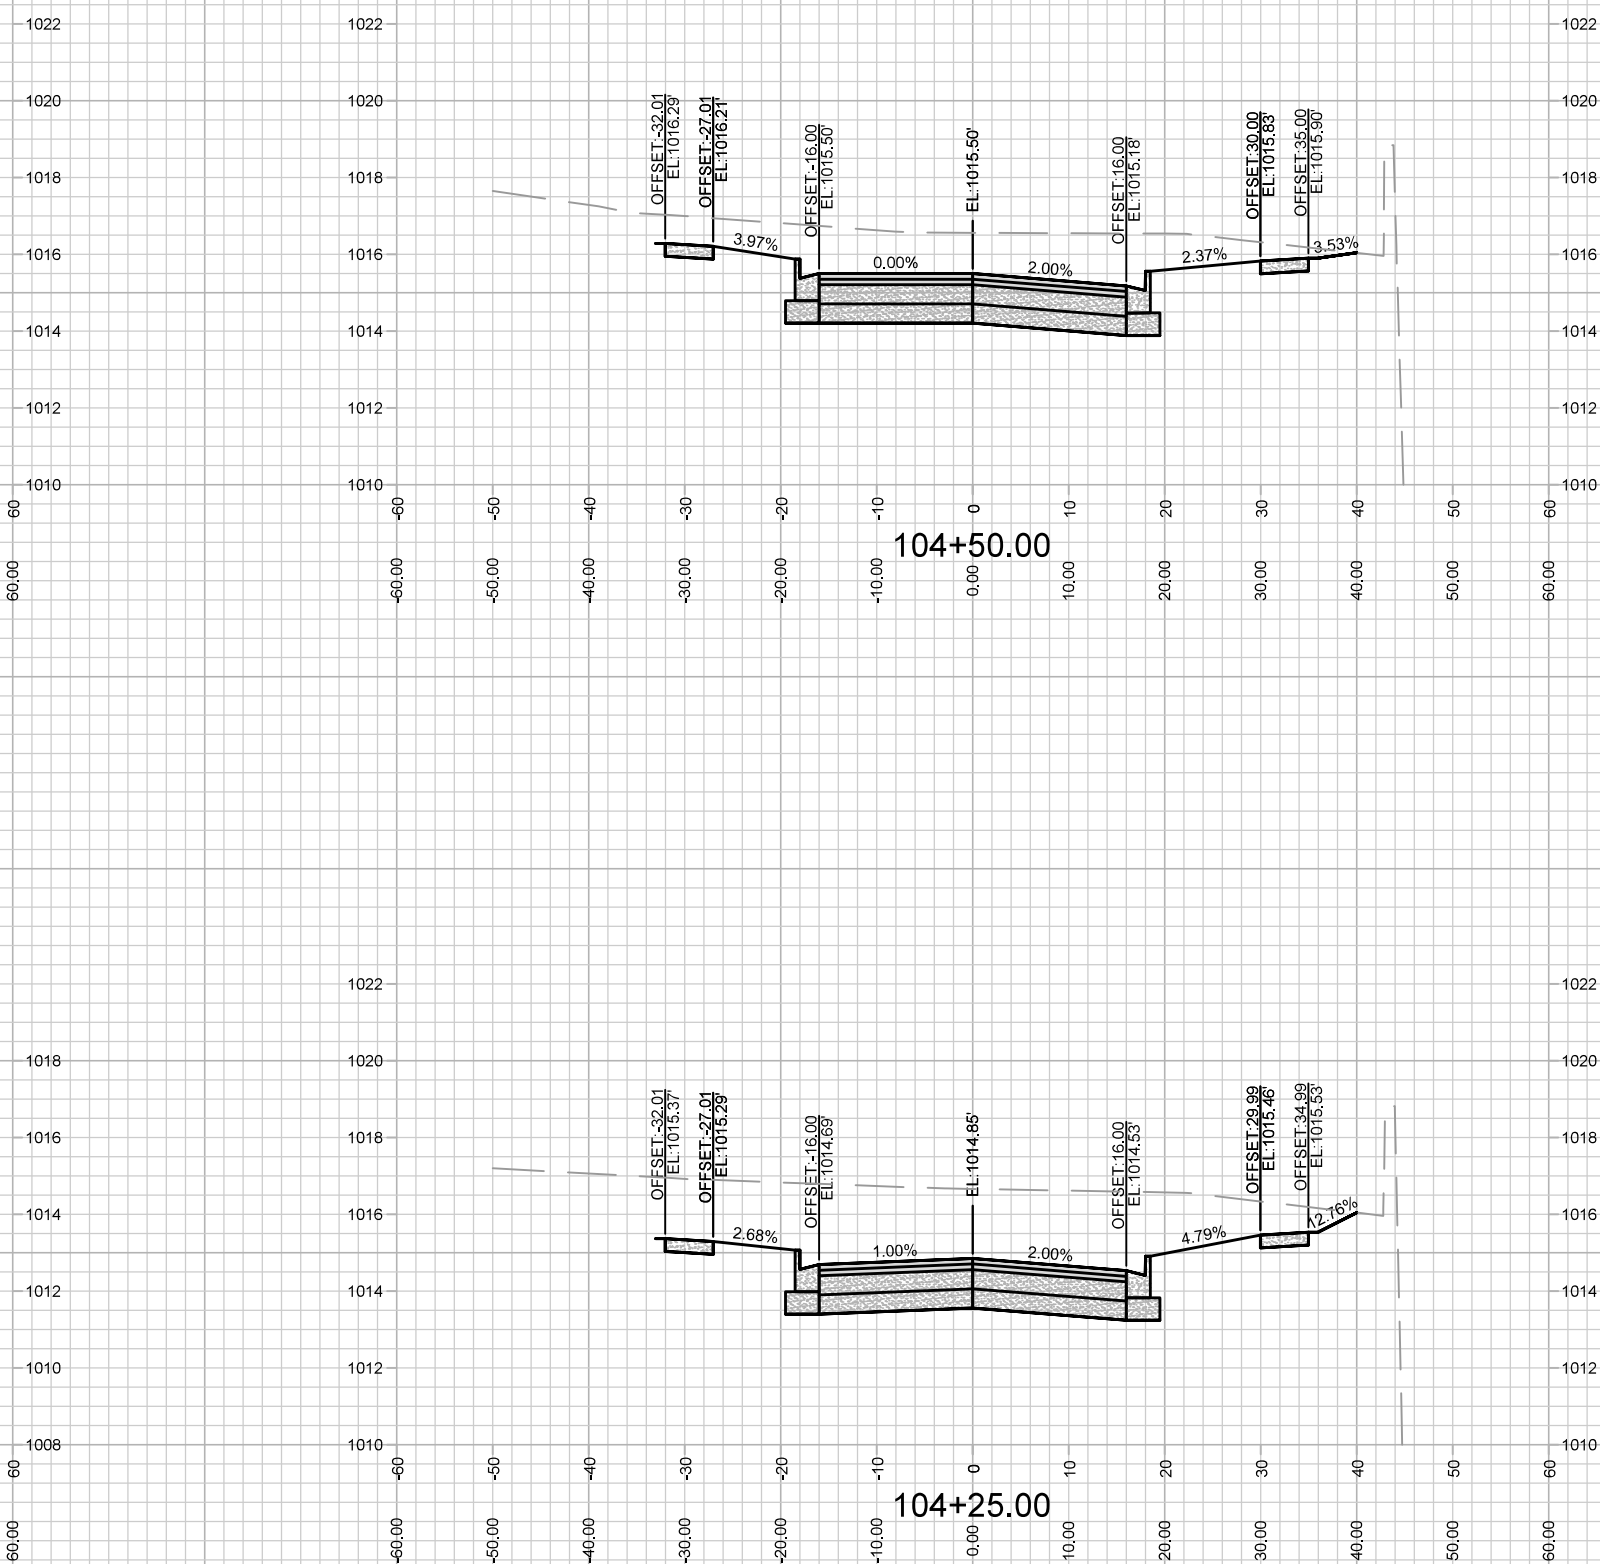

M:\DESIGN\Projects\14774\CAD\Streets\14774EN-AllProf&Corridor_Setup.dwg




CONTRACT NO: 9231

 [illegible]

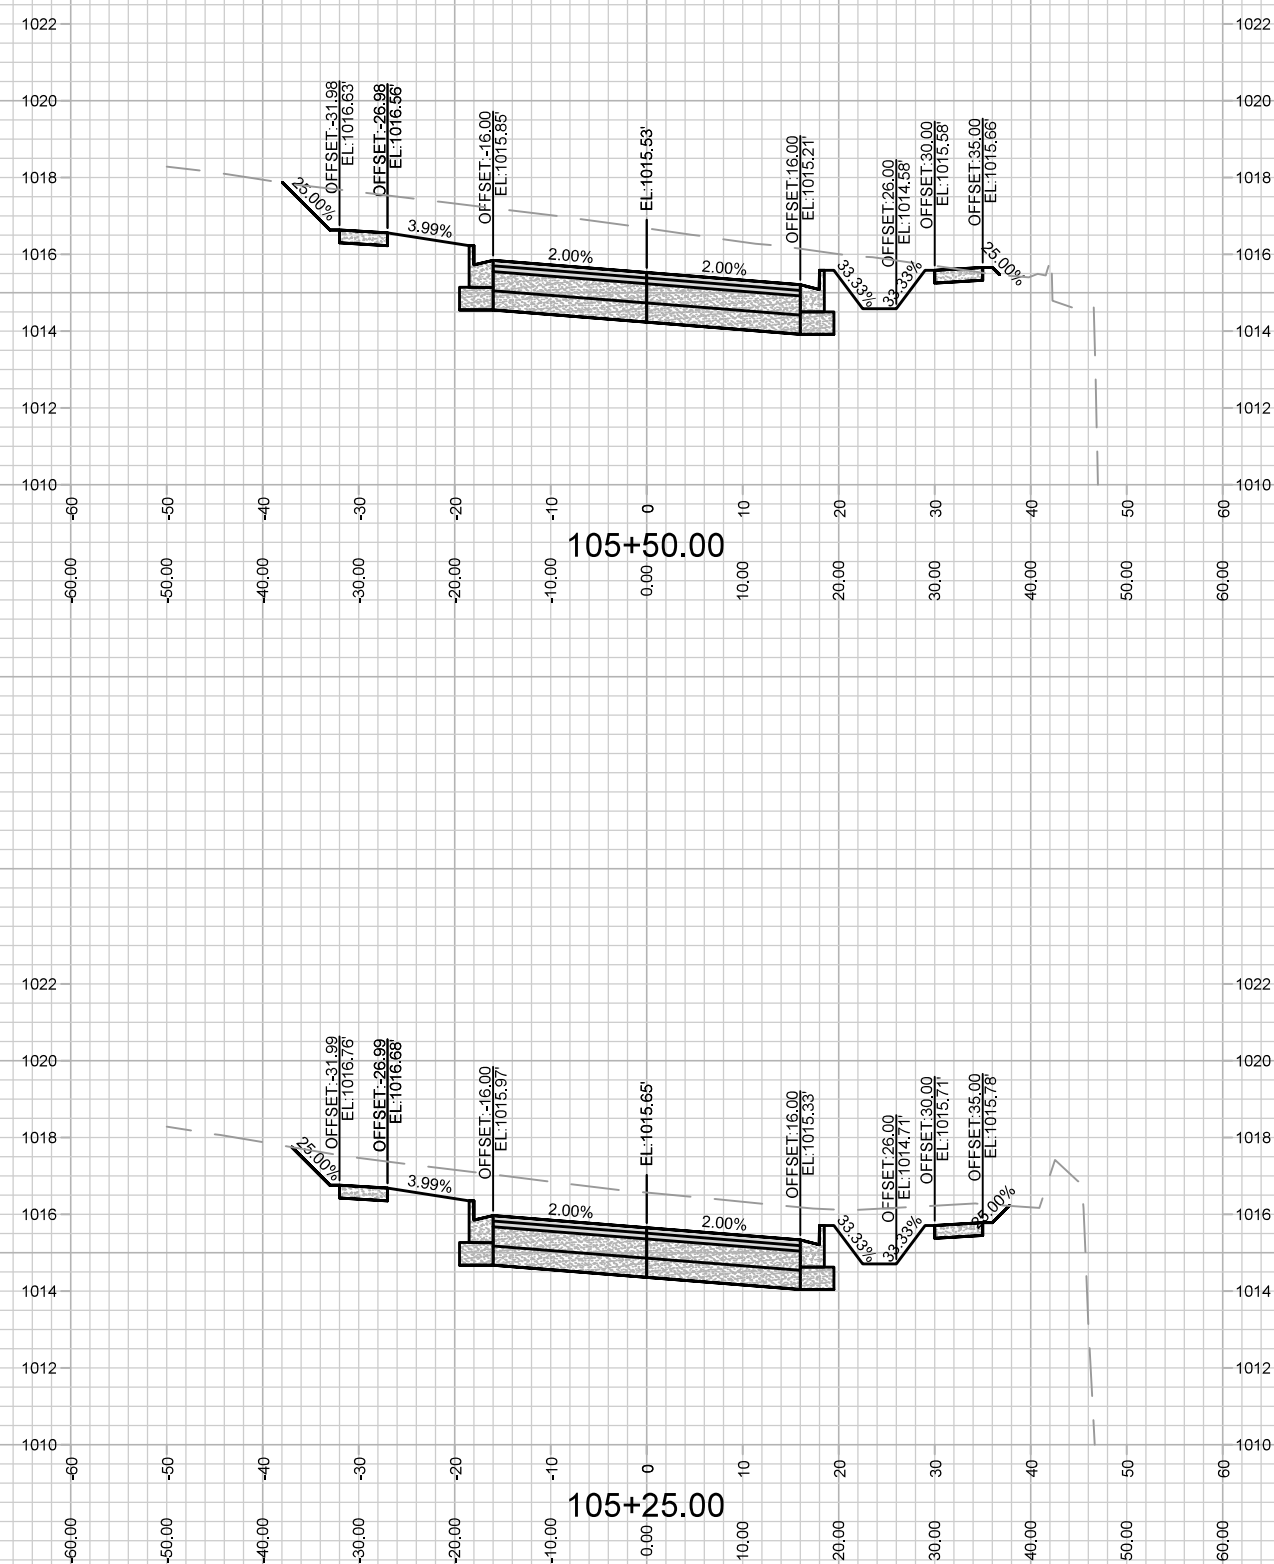

X-3

 X-3



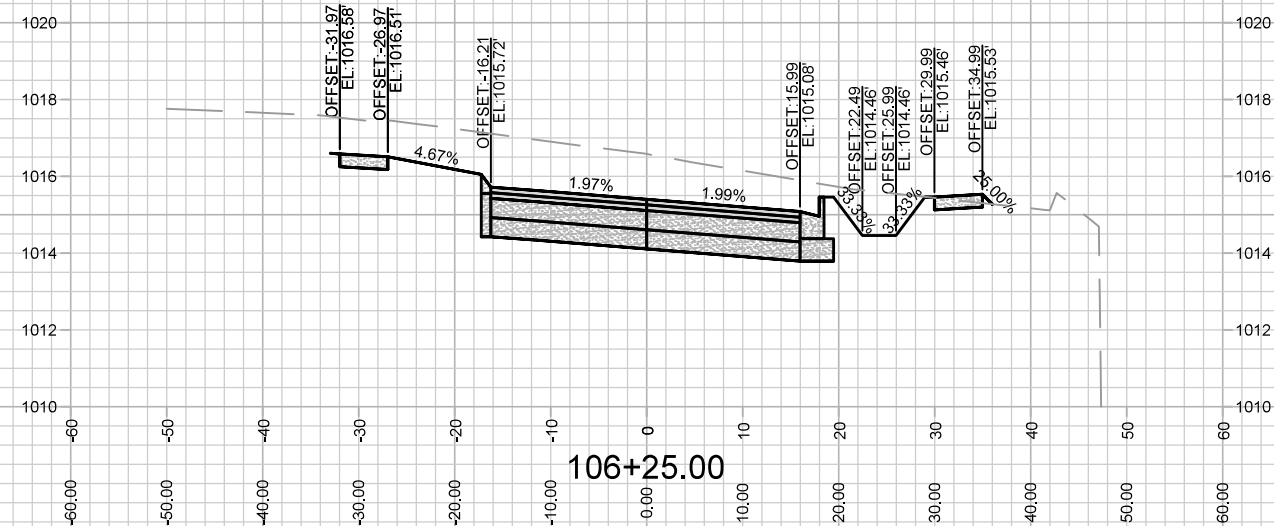
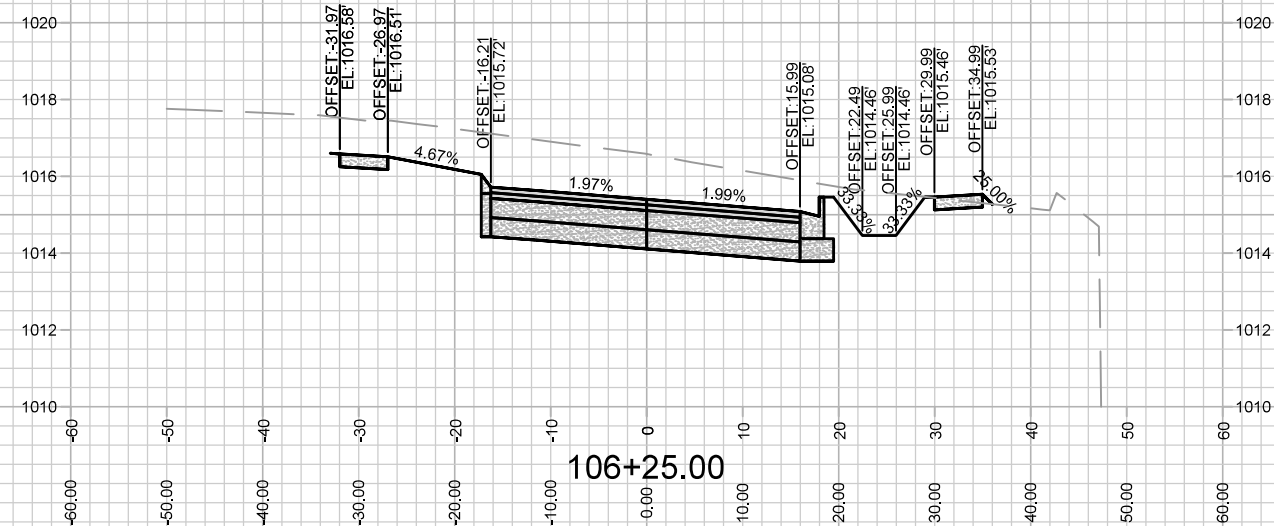




4649 VERONA ROAD


MADISON, WI

CONTRACT NO: 9231


[illegible]

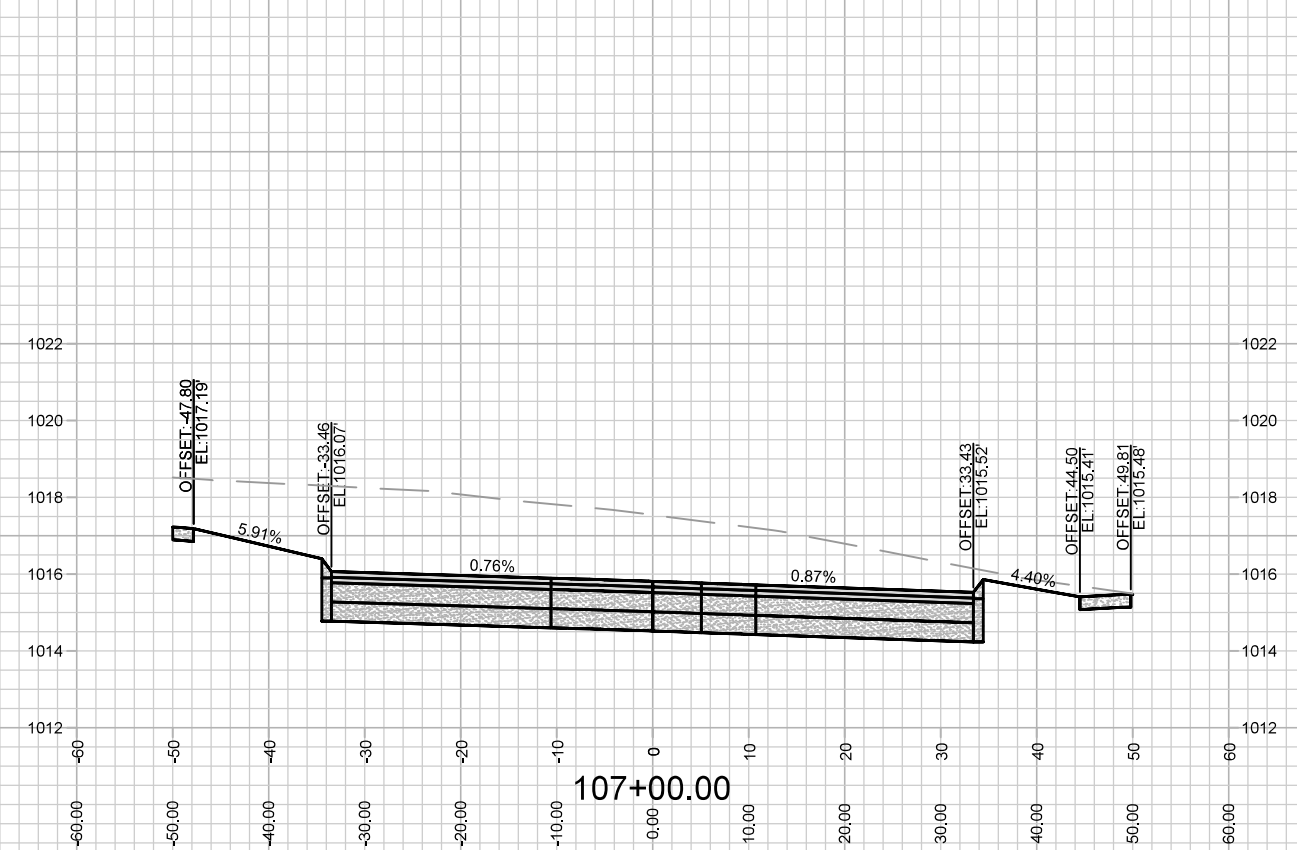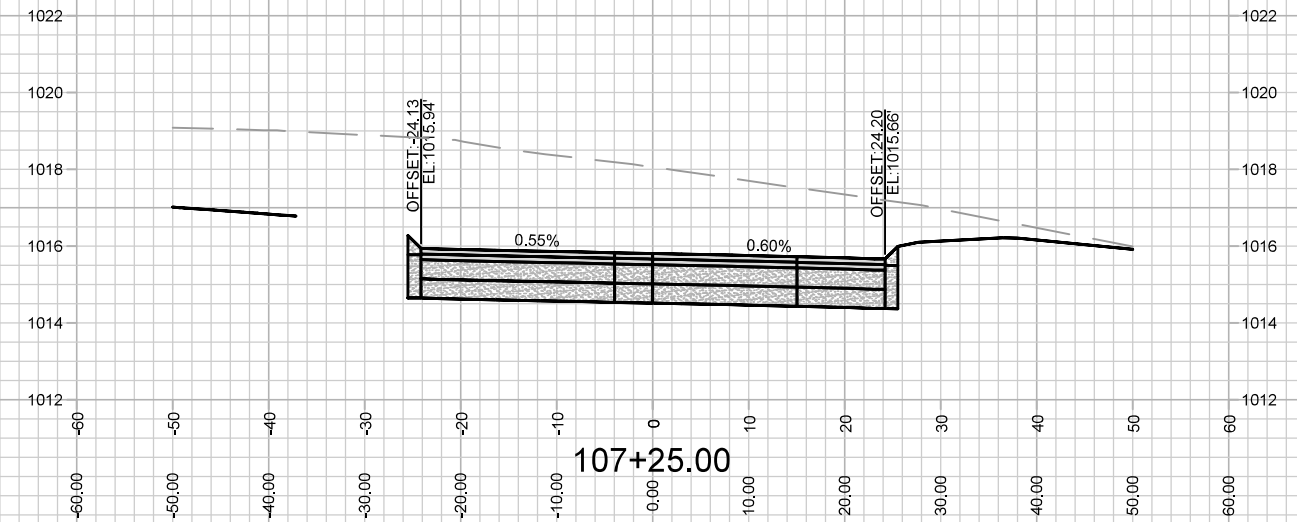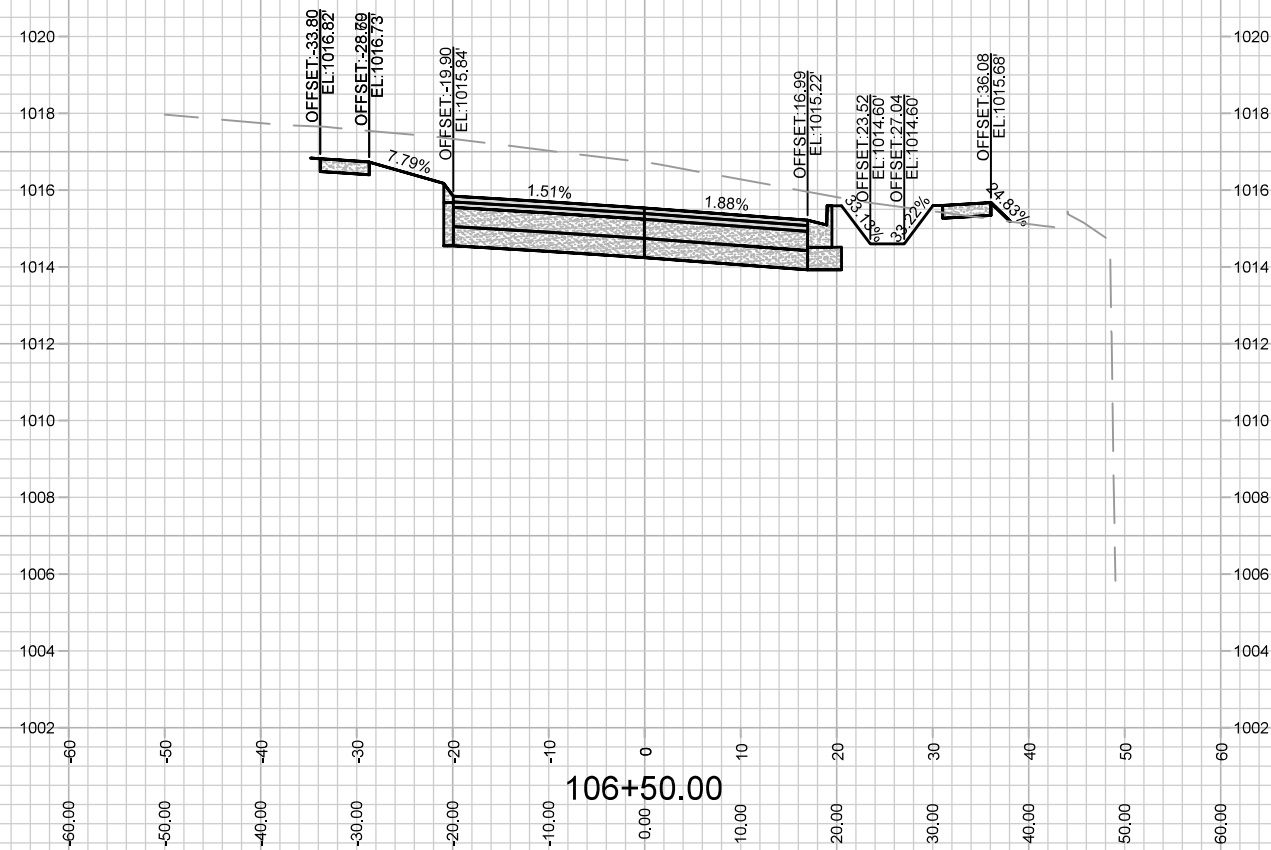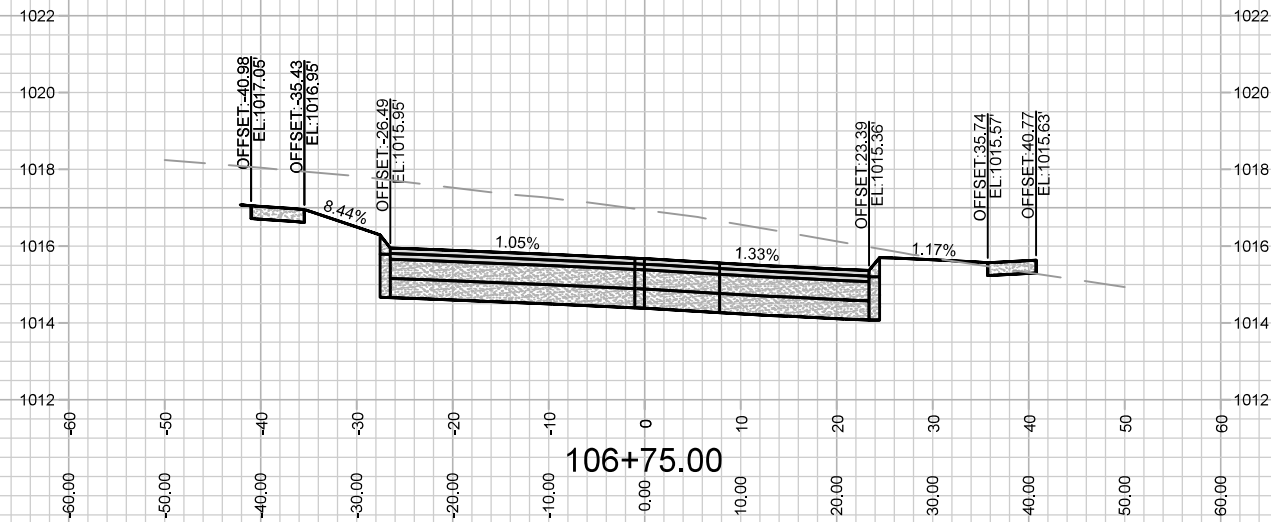

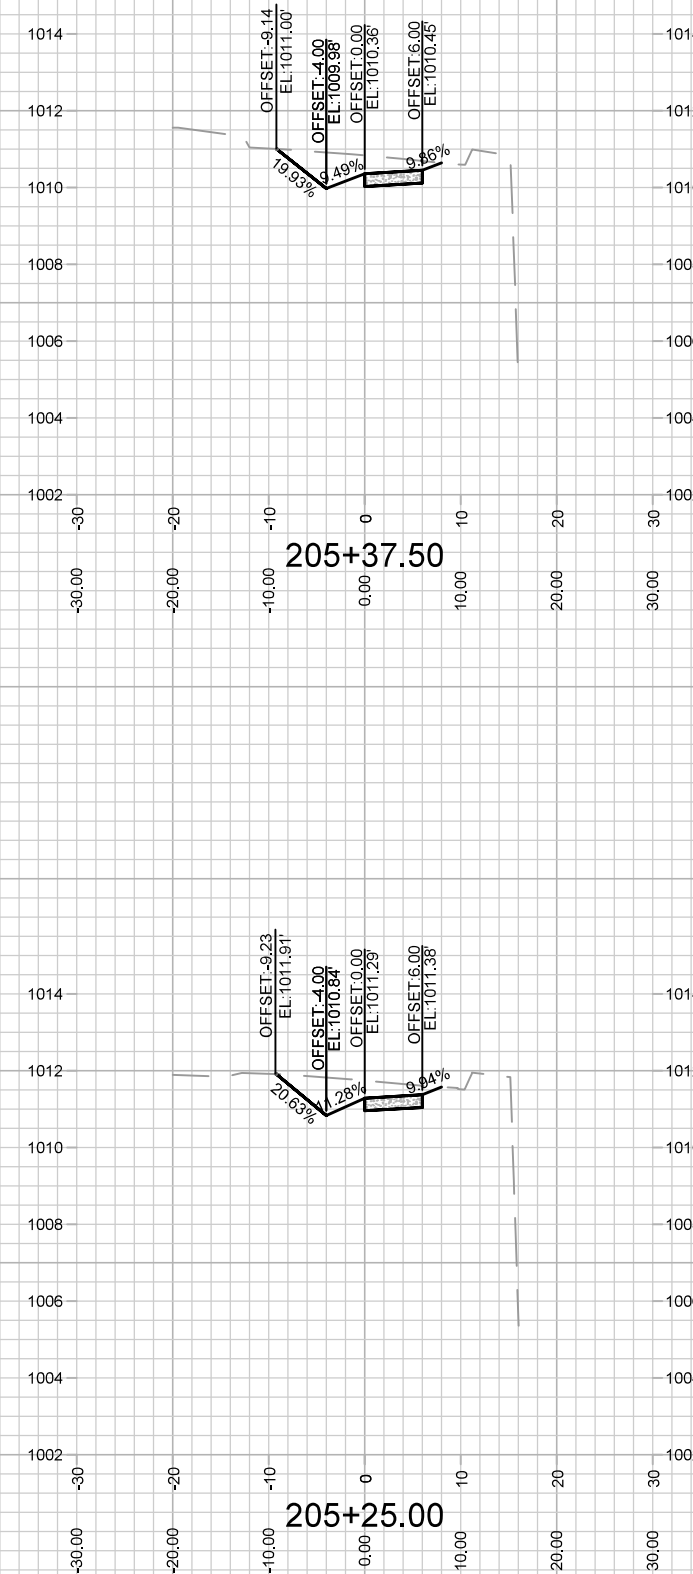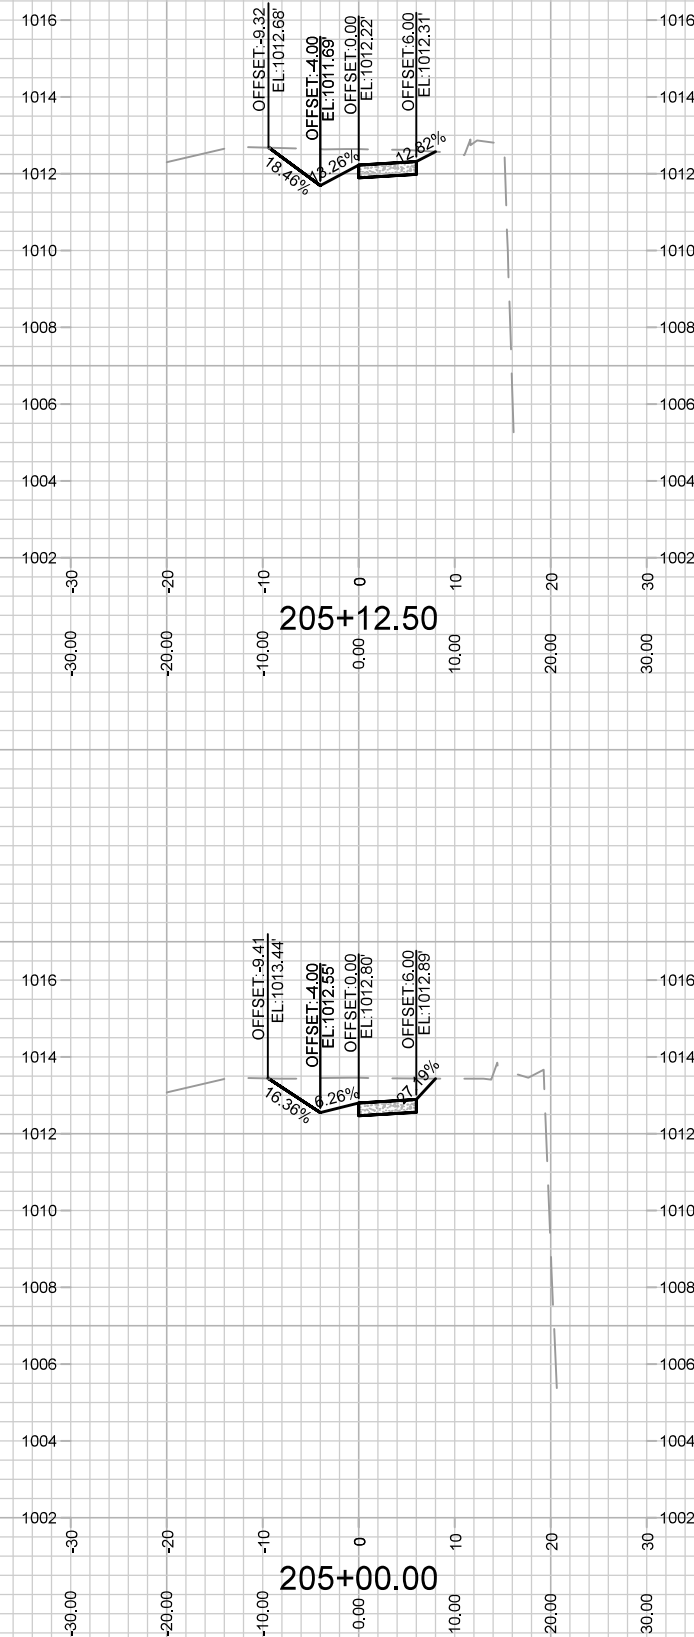


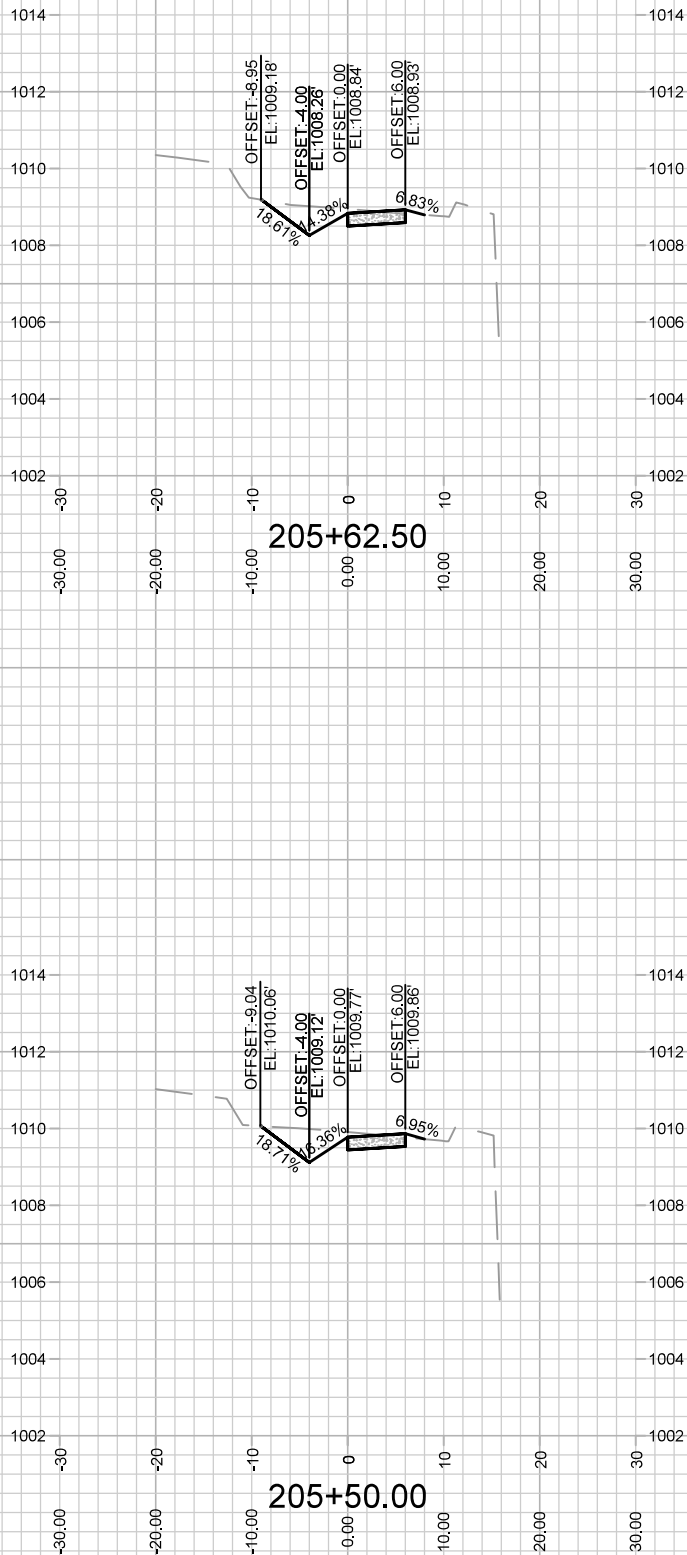


205+50.00

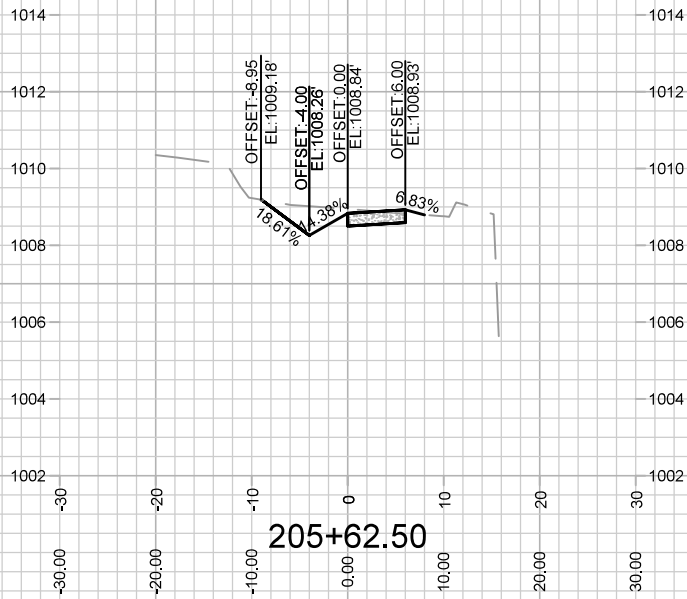


205+62.50

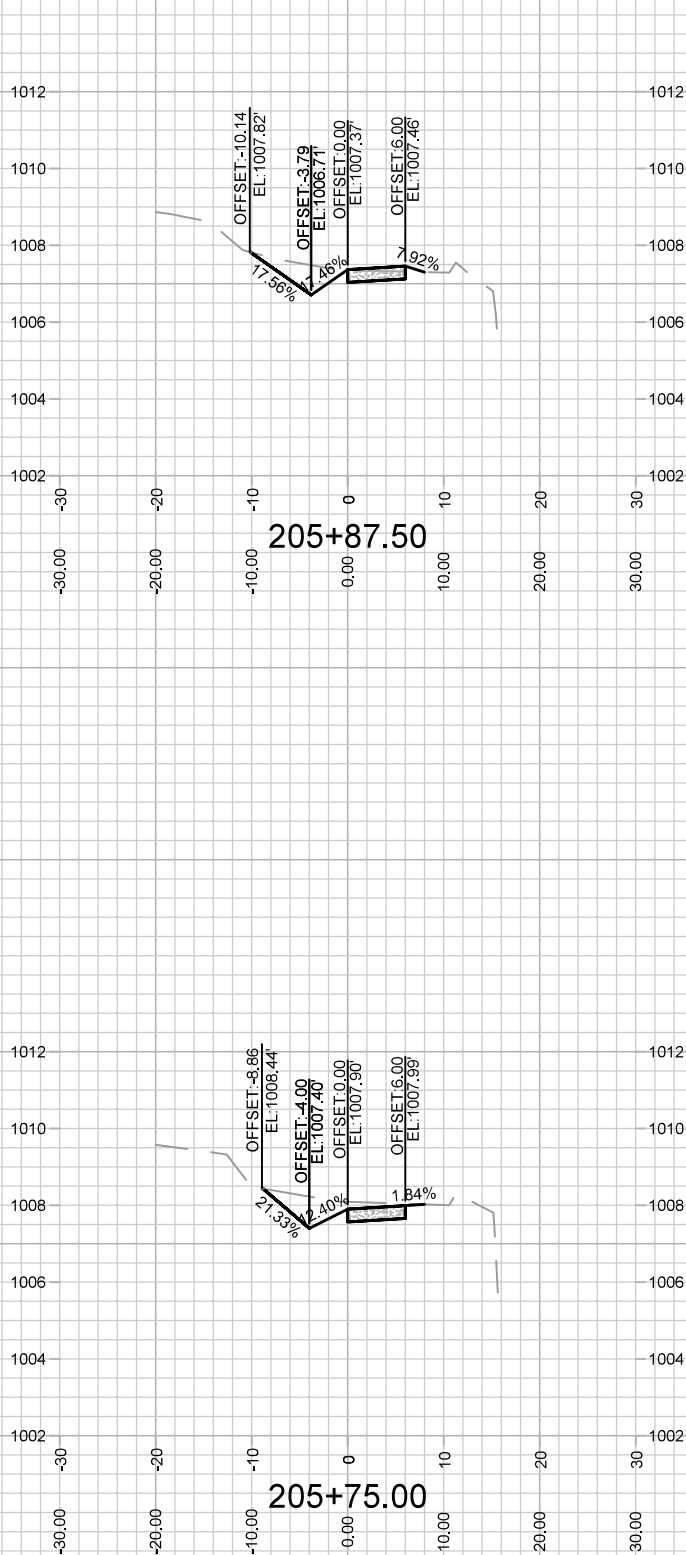


205+75.00

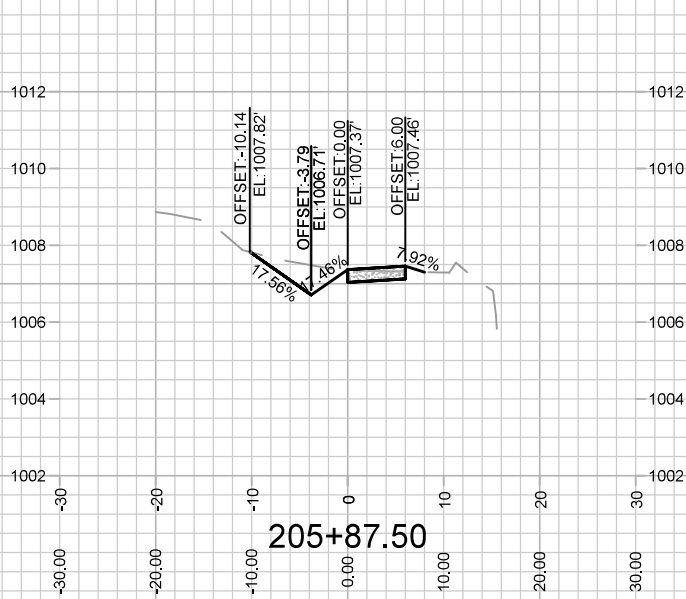

205+87.50

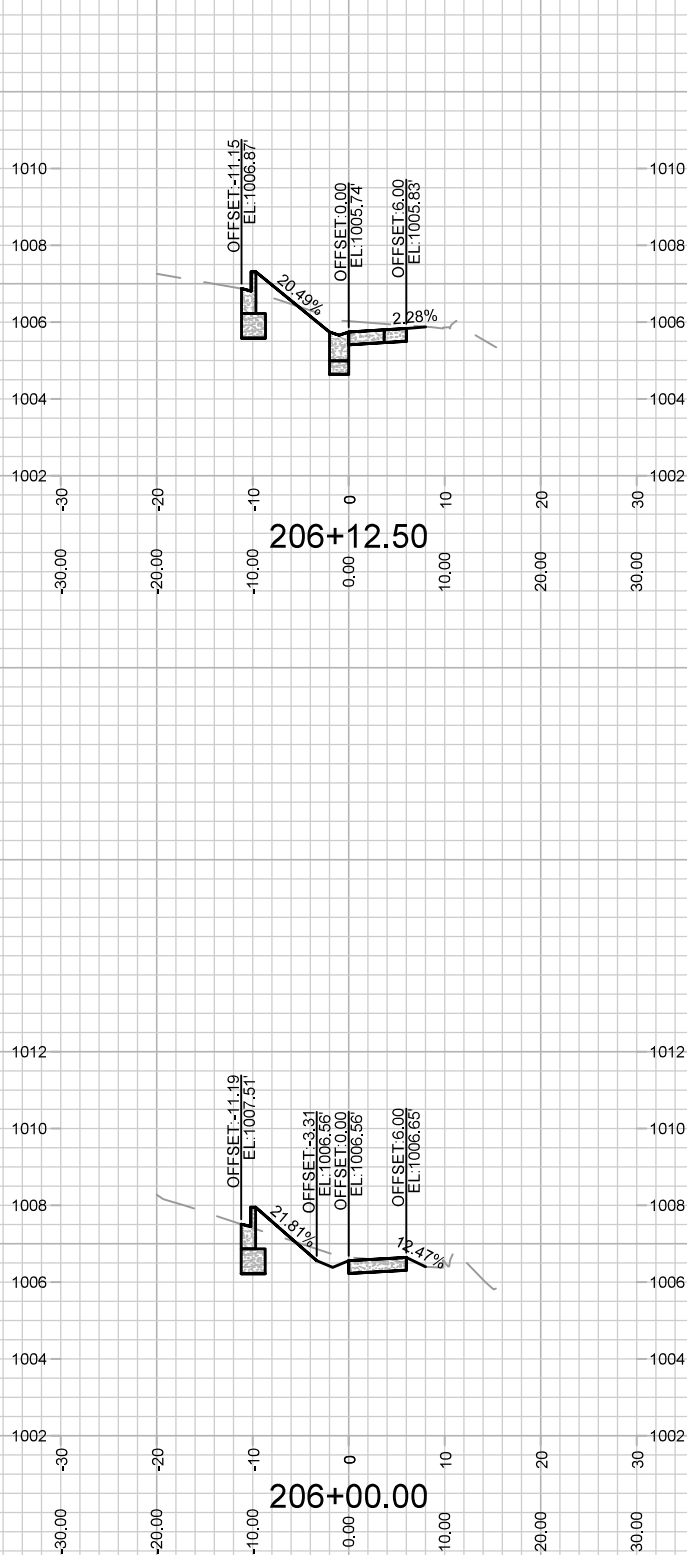

206+00.00

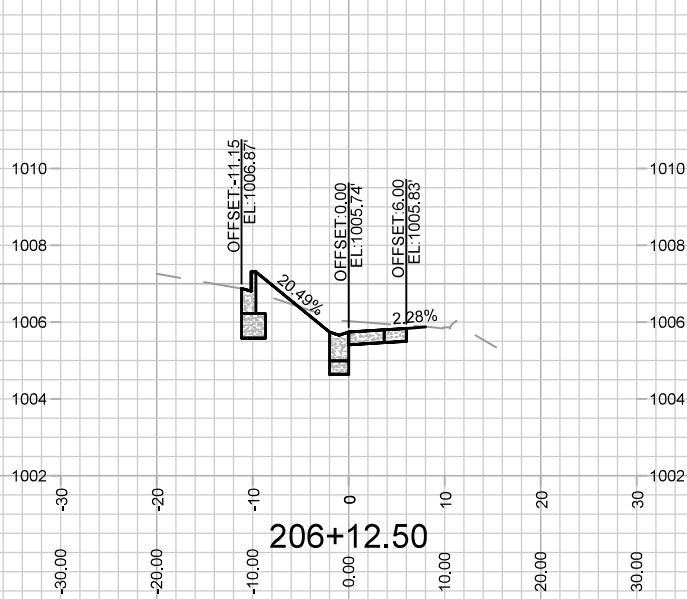

206+12.50



14774
X-7




CROSS SECTIONS - VERONA ROAD SIDEWALK
4649 VERONA ROAD

14774
MADISON, WI
CONTRACT NO: 9231

M:\DESIGN\Projects\14774\CAD\Streets\14774EN-AI\Prof&Corridor_Setup.dwg
Designed By: ID 14774
Scale: 1" = 20'

MARK	REVISION	DATE	BY
###	###	###	###
###	###	###	###
###	###	###	###

X-7

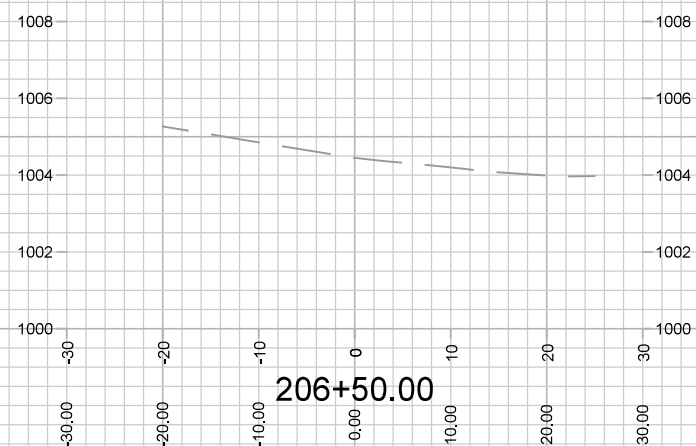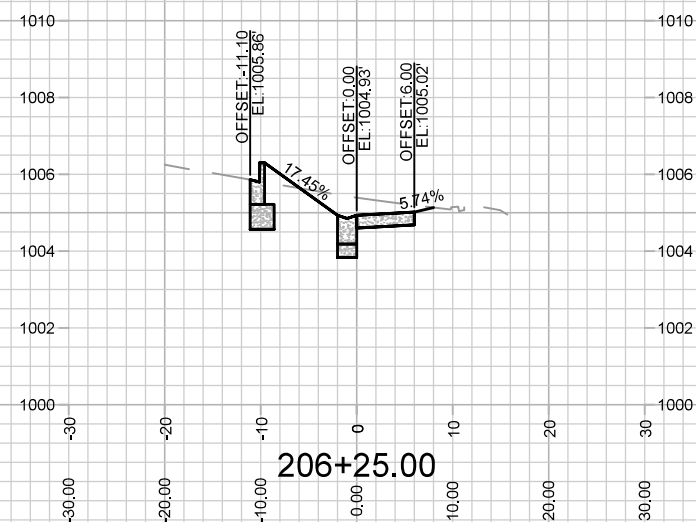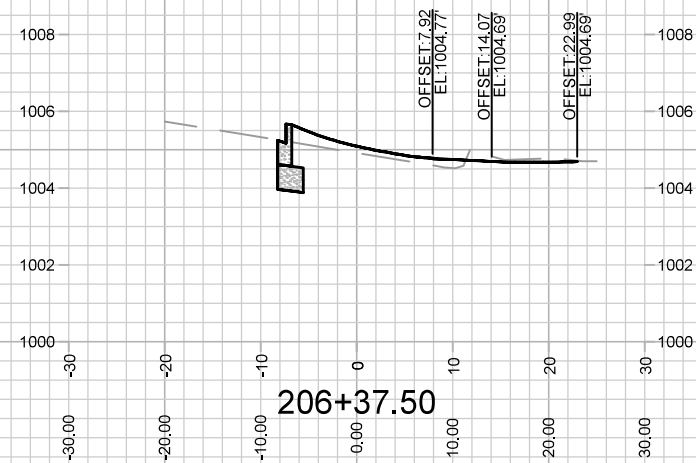

14774

X-8

CROSS SECTIONS - VERONA ROAD SIDEWALK

4649 VERONA ROAD

M:\DESIGN\Projects\14774\CAD\Streets\14774EN-AllProf&Corridor_Setup.dwg

14774

MADISON, WI

CONTRACT NO:	9231
--------------	------

MARK	REVISION	DATE	BY
####	###	###	###
####	###	###	###
####	###	###	###
####	###	###	###
####	###	###	###

Date: 7/7/2023 8:11 AM Scale: 1" = 20'

X-8

Disassembled By: IO
14774

