

Madison, Wisconsin

CITY OF MADISON
CITY ENGINEERING DIVISION
DEPARTMENT OF PUBLIC WORKS
PLAN OF PROPOSED IMPROVEMENT


INDEX OF SHEETS

SHEET NO. D 1	GENERAL NOTES
SHEET NO. D 2	TYPICAL SECTIONS
SHEET NO. P 1-P 3	STREET PLAN & PROFILE
SHEET NO. U 1	UTILITIES PLAN & PROFILE
SHEET NO. U STM	STORM SEWER SCHEDULE
SHEET NO. E 1	ELECTRICAL PLAN
SHEET NO. PM 1	PAVEMENT MARKING PLAN
SHEET NO. L 1	LANDSCAPING PLAN
SHEET NO. X 1-X 4	CROSS SECTIONS
NO MAINTENANCE PLAN REQUIRED	

6624 OLD SAUK ROAD

CITY PROJECT NO. 15514
CONTRACT NO. 9614

PROJECT
LOCATION

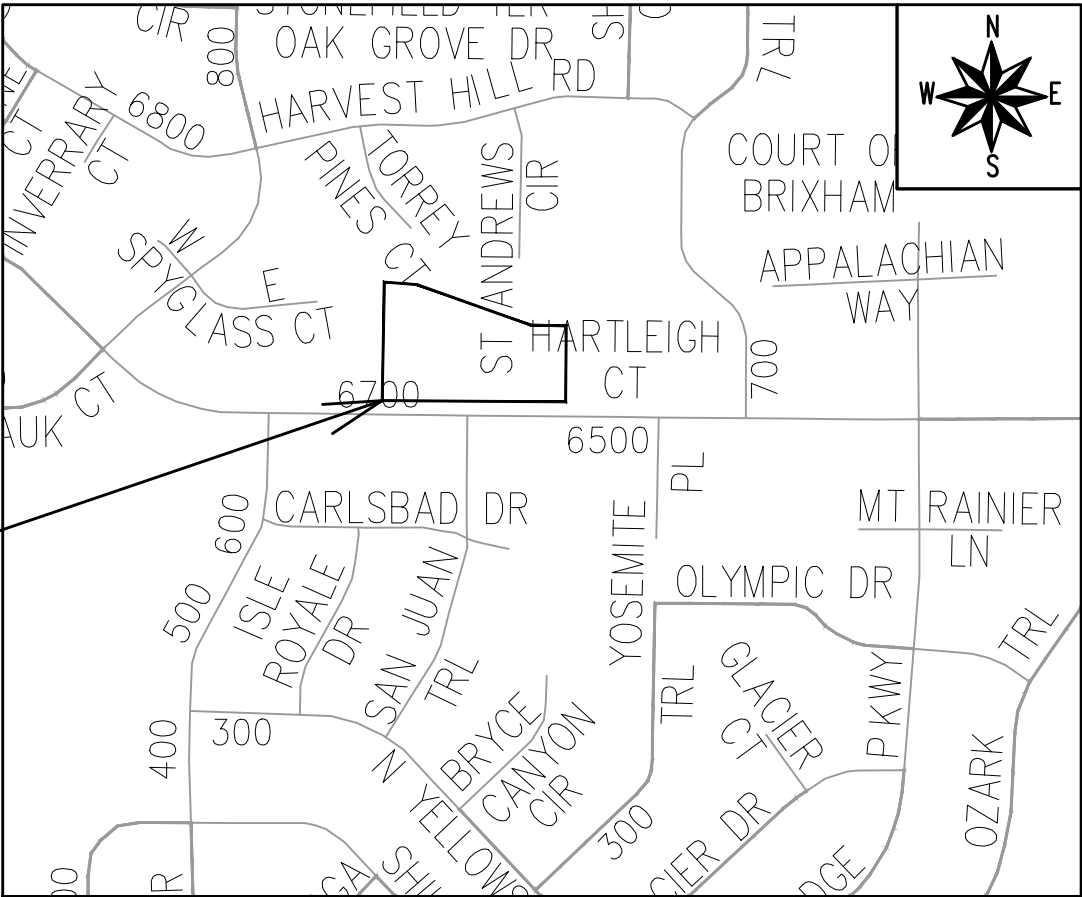

PUBLIC IMPROVEMENT PROJECT
APPROVED

APPROVED DATE:
MAY 6, 2025

BY THE COMMON COUNCIL
OF MADISON, WISCONSIN

PUBLIC IMPROVEMENT DESIGN
APPROVED BY:

09/09/2025

City Engineer

Date

STREET
DESIGNED BY:



09/11/2025

ELECTRICAL
DESIGNED BY:




09/09/2025

SANITARY SEWER
DESIGNED BY:




09/09/2025

PAVEMENT MARKING
DESIGNED BY:

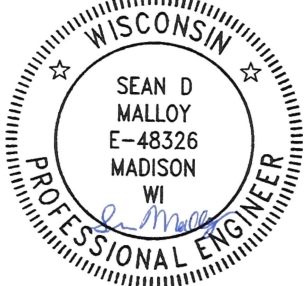

09/09/2025

STORM SEWER
DESIGNED BY:

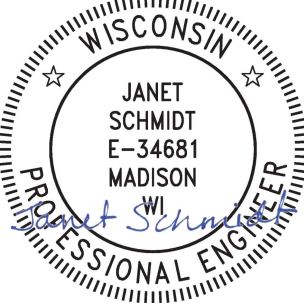

09/09/2025

PLOT SCALE: 1"=1' XREF

PLOT NAME: ----

REV. DATE: 8/21/2025 3:19 PM

ORIGINATOR: CITY_OF_MADISON

AS DEFINED BY SECTION 107.13 OF THE CITY OF MADISON STANDARD SPECIFICATIONS FOR PUBLIC WORKS CONSTRUCTION, LATEST EDITION: NO EXCAVATION IS PERMITTED WITHIN 5 FEET OF THE TRUNK OF THE STREET TREE OR WHEN CUTTING ROOTS OVER 3 INCHES IN DIAMETER. IF EXCAVATION IS NECESSARY, THE CONTRACTOR SHALL CONTACT MADISON CITY FORESTRY (266-4816) PRIOR TO EXCAVATION. CITY OF MADISON FORESTRY PERSONNEL SHALL ASSESS THE IMPACT TO THE TREE AND TO ITS ROOT SYSTEM PRIOR TO WORK COMMENCING. TREE PROTECTION SPECIFICATIONS CAN BE FOUND ON THE FOLLOWING WEBSITE:

www.cityofmadison.com/engineering/developers-contractors/standard-specifications

NO TREES IN THE RIGHT OF WAY OR ON PUBLIC LANDS SHALL BE TRIMMED, PRUNED, REMOVED OR ADVERSELY AFFECTED IN ANY WAY UNTIL THE DEVELOPER HAS RECEIVED WRITTEN PERMISSION FROM THE CITY ENGINEER OR CITY FORESTER. SAID WRITTEN PERMISSION SHALL INCLUDE LANGUAGE INDICATING THAT SECTION 10.101 OF THE MADISON GENERAL ORDINANCES AND ADMINISTRATIVE PROCEDURE MEMORANDUM NO. 6-2, REFERRING TO NOTIFICATION OF PROPERTY OCCUPANTS AND/OR OWNERS, HAS BEEN COMPLIED WITH.

DEVELOPER MUST SUBMIT A TRAFFIC CONTROL PLAN TO CITY TRAFFIC ENGINEERING AT LEAST 14 DAYS PRIOR TO THE START OF WORK. WORK SHALL NOT PROCEED UNTIL AN APPROVED TRAFFIC CONTROL PLAN IS IN PLACE.

CONTACT THE PROJECT ENGINEER AND DESIGNER, IKE OKAFOR, AT IOKAFOR@CITYOFMADISON.COM FOR CAD FILES AND ALIGNMENT DATA PRIOR TO STAKING.

CONTACT THE CITY CONSTRUCTION ENGINEER, KYLE FRANK, AT KFRANK@CITYOFMADISON.COM FOR
PRECONSTRUCTION SCHEDULING, COORDINATION, AND INSPECTION.

UNDERDRAINS SHALL BE INSTALLED PER STANDARD DETAIL DRAWING 4.05 FOR 75' ON EACH SIDE OF THE LOW POINT, OR TO THE NEAREST CURB HIGH POINT. ALL UNDERDRAIN SHALL BE WRAPPED.

ALL GUTTERS SHALL DRAIN WITH A MINIMUM GRADE OF 0.5% TOWARD STORM SEWER INLETS.

ALL DITCHES SHALL DRAIN WITH A MINIMUM GRADE OF 0.5%

THE CROSS SLOPE OF SIDEWALKS AND BARRIER FREE SIDEWALK CURB RAMPS SHALL TYPICALLY BE 1.5%. THE LONGITUDINAL GRADE OF BARRIER FREE SIDEWALK CURB RAMPS SHALL NOT EXCEED 8.33%. ALL SIDEWALK RAMPS SHALL BE CONSTRUCTED ACCORDING TO S.D.D. 3.04. AT ALL OTHER LOCATIONS THE LONGITUDINAL GRADE OF SIDEWALKS SHALL NOT EXCEED 5.0 % OR THE ADJACENT STREET GRADE WHICHEVER IS GREATER NOR BE LESS THAN 0.5% AND SHALL DRAIN TOWARD STORM SEWER INLETS. SIDE SLOPES WITHIN TEN FEET OF A PUBLIC SIDEWALK SHALL NOT EXCEED 4:1. ALL SIDEWALK AND SIDEWALK RAMP ELEVATIONS AND GRADES SHALL BE FIELD VERIFIED AND SET TO COMPLY WITH THE CITY OF MADISON STANDARD SPECIFICATIONS AND THE A.D.A. GUIDELINES.

CURB STATION AND OFFSETS SHALL BE TO THE EDGE OF PAVEMENT UNLESS OTHERWISE INDICATED. CURB ELEVATIONS SHALL BE TO THE EDGE OF PAVEMENT UNLESS OTHERWISE INDICATED.

POWER POLES AND OTHER OBSTRUCTIONS SHALL BE MOVED TO PROVIDE 2 FEET MINIMUM OF CLEAR DISTANCE FROM ANY FACE OF CURB OR EDGE OF SIDEWALK UNLESS OTHERWISE INDICATED ON THE PLANS.

ANY INFORMATION SHOWN ON THIS PLAN, WHICH IS NOT PART OF THIS RIGHT-OF-WAY PROJECT, IS PRELIMINARY AND NOT FOR CONSTRUCTION.

THERE MAY BE EXISTING UTILITIES OR OTHER FEATURES WHICH ARE EITHER NOT SHOWN OR SHOWN INCORRECTLY ON THIS PLAN. IT IS THE RESPONSIBILITY OF THE DEVELOPER TO LOCATE AND IDENTIFY ALL UTILITIES AND TOPOGRAPHY WHICH MAY AFFECT THE CONSTRUCTION OF THESE IMPROVEMENTS.

ALL PERMANENT SIGNING AND POSTING WILL BE DETERMINED AND PROVIDED BY THE TRAFFIC ENGINEERING DIVISION, FOLLOWING CONSTRUCTION OF THESE IMPROVEMENTS.

THE DEVELOPER SHALL PROVIDE, INSTALL AND MAINTAIN ALL STREET END BARRICADES, SIGNING AND TRAFFIC CONTROL, AS REQUIRED BY THE CITY TRAFFIC ENGINEER.

PAVEMENT SAWCUTS SHALL BE AS DIRECTED BY THE CITY CONSTRUCTION ENGINEER. SAWCUTS SHOWN ON THE PLAN ARE APPROXIMATE.

CURB ON CUL DE SACS SHALL BE INSTALLED ACCORDING TO S.D.D. 3.05.

ALL WORK IN THE RIGHT OF WAY AND PUBLIC EASEMENTS SHALL BE IN ACCORDANCE WITH THE CITY OF MADISON STANDARD SPECIFICATIONS FOR PUBLIC WORKS CONSTRUCTION LATEST EDITION.

ALL PROPOSED IMPROVEMENTS IN THE RIGHT-OF-WAY ARE BASED ON SURVEY DATA PROVIDED BY THE DEVELOPER OR ITS CONSULTANT. IN THE CASE THAT THE PROPOSED IMPROVEMENTS CAN NOT BE INSTALLED PER THESE PLANS OR THE CITY OF MADISON STANDARD SPECIFICATION FOR PUBLIC WORKS CONSTRUCTION, LATEST EDITION, THE DEVELOPER SHALL BE RESPONSIBLE FOR THE COST OF EXTRA WORK DUE TO INACCURACIES OF THE SURVEY.

ALL UTILITY VERIFICATIONS AND ACCURACY OF THE DRAWINGS ARE THE RESPONSIBILITY OF THE DEVELOPER. ANY CONFLICTS THAT ARISE FROM MISSING OR ERRONEOUS INFORMATION WILL BE AT THE EXPENSE OF THE DEVELOPER. NO PRECAST STRUCTURES WILL BE APPROVED FOR STORM OR SANITARY SEWER UNTIL ALL POTENTIAL UTILITY CONFLICTS ARE RESOLVED.

CONVENTIONAL SIGNS

FIELD VERIFY ALL UTILITY LOCATIONS

_____ G _____

_____ ST _____


—SAN—

_____ W _____

_____ E _____

_____ OH _____



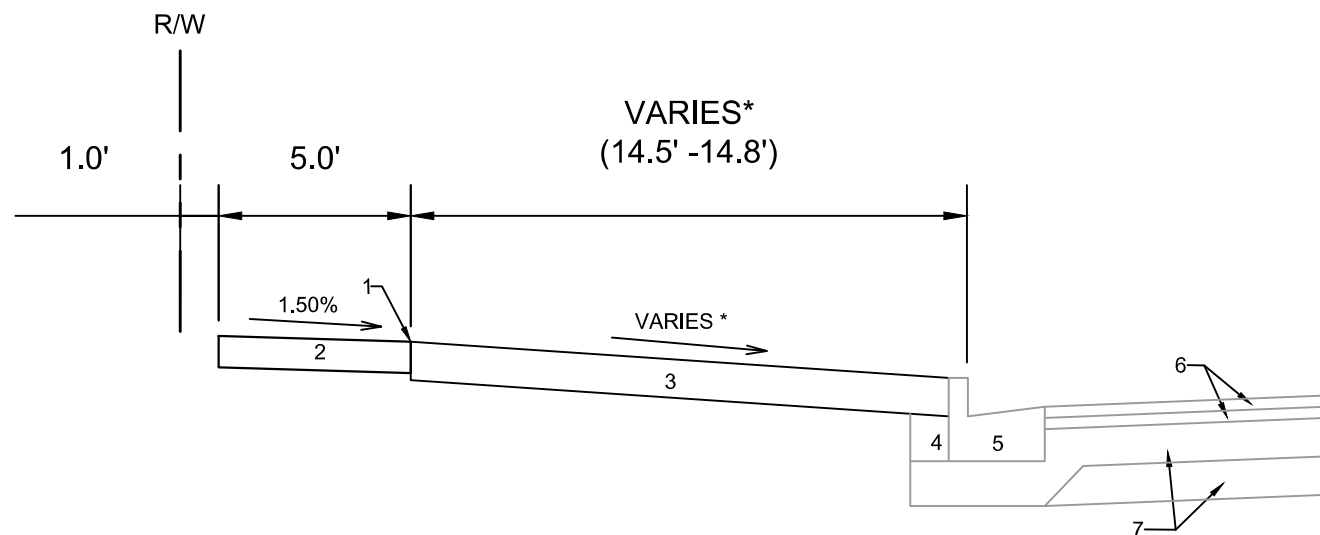

TYPICAL SECTION
OLD SAUK ROAD

SPECIAL NOTES:

*SEE X SHEETS FOR PROPOSED SURFACE SLOPES.

1. POINT REFERRED TO ON PROFILE.
2. 5" CONCRETE SIDEWALK.
3. 6" TOPSOIL, SEED, AND MATTING.
4. EX. FILL TO REMAIN
5. EX. CONCRETE CURB AND GUTTER TYPE 'A' TO REMAIN, REPLACE IN LOCATIONS IDENTIFIED IN P SHEETS OR AS DIRECTED BY THE CITY CONSTRUCTION ENGINEER.
6. EX. H.M.A. PAVEMENT TO REMAIN.
7. EX. CRUSHED AGGREGATE BASE COURSE TO REMAIN.





15514


D-2

TYPICAL SECTIONS	15514
6624 OLD SAUK ROAD	MADISON, WI
M:\DESIGN\Projects\15514\CAD\Streets\15514EN-Details.dwg	CONTRACT NO: 9614

MARK	REVISION	DATE	BY
15514	10/22 AM	10/22 AM	D-2

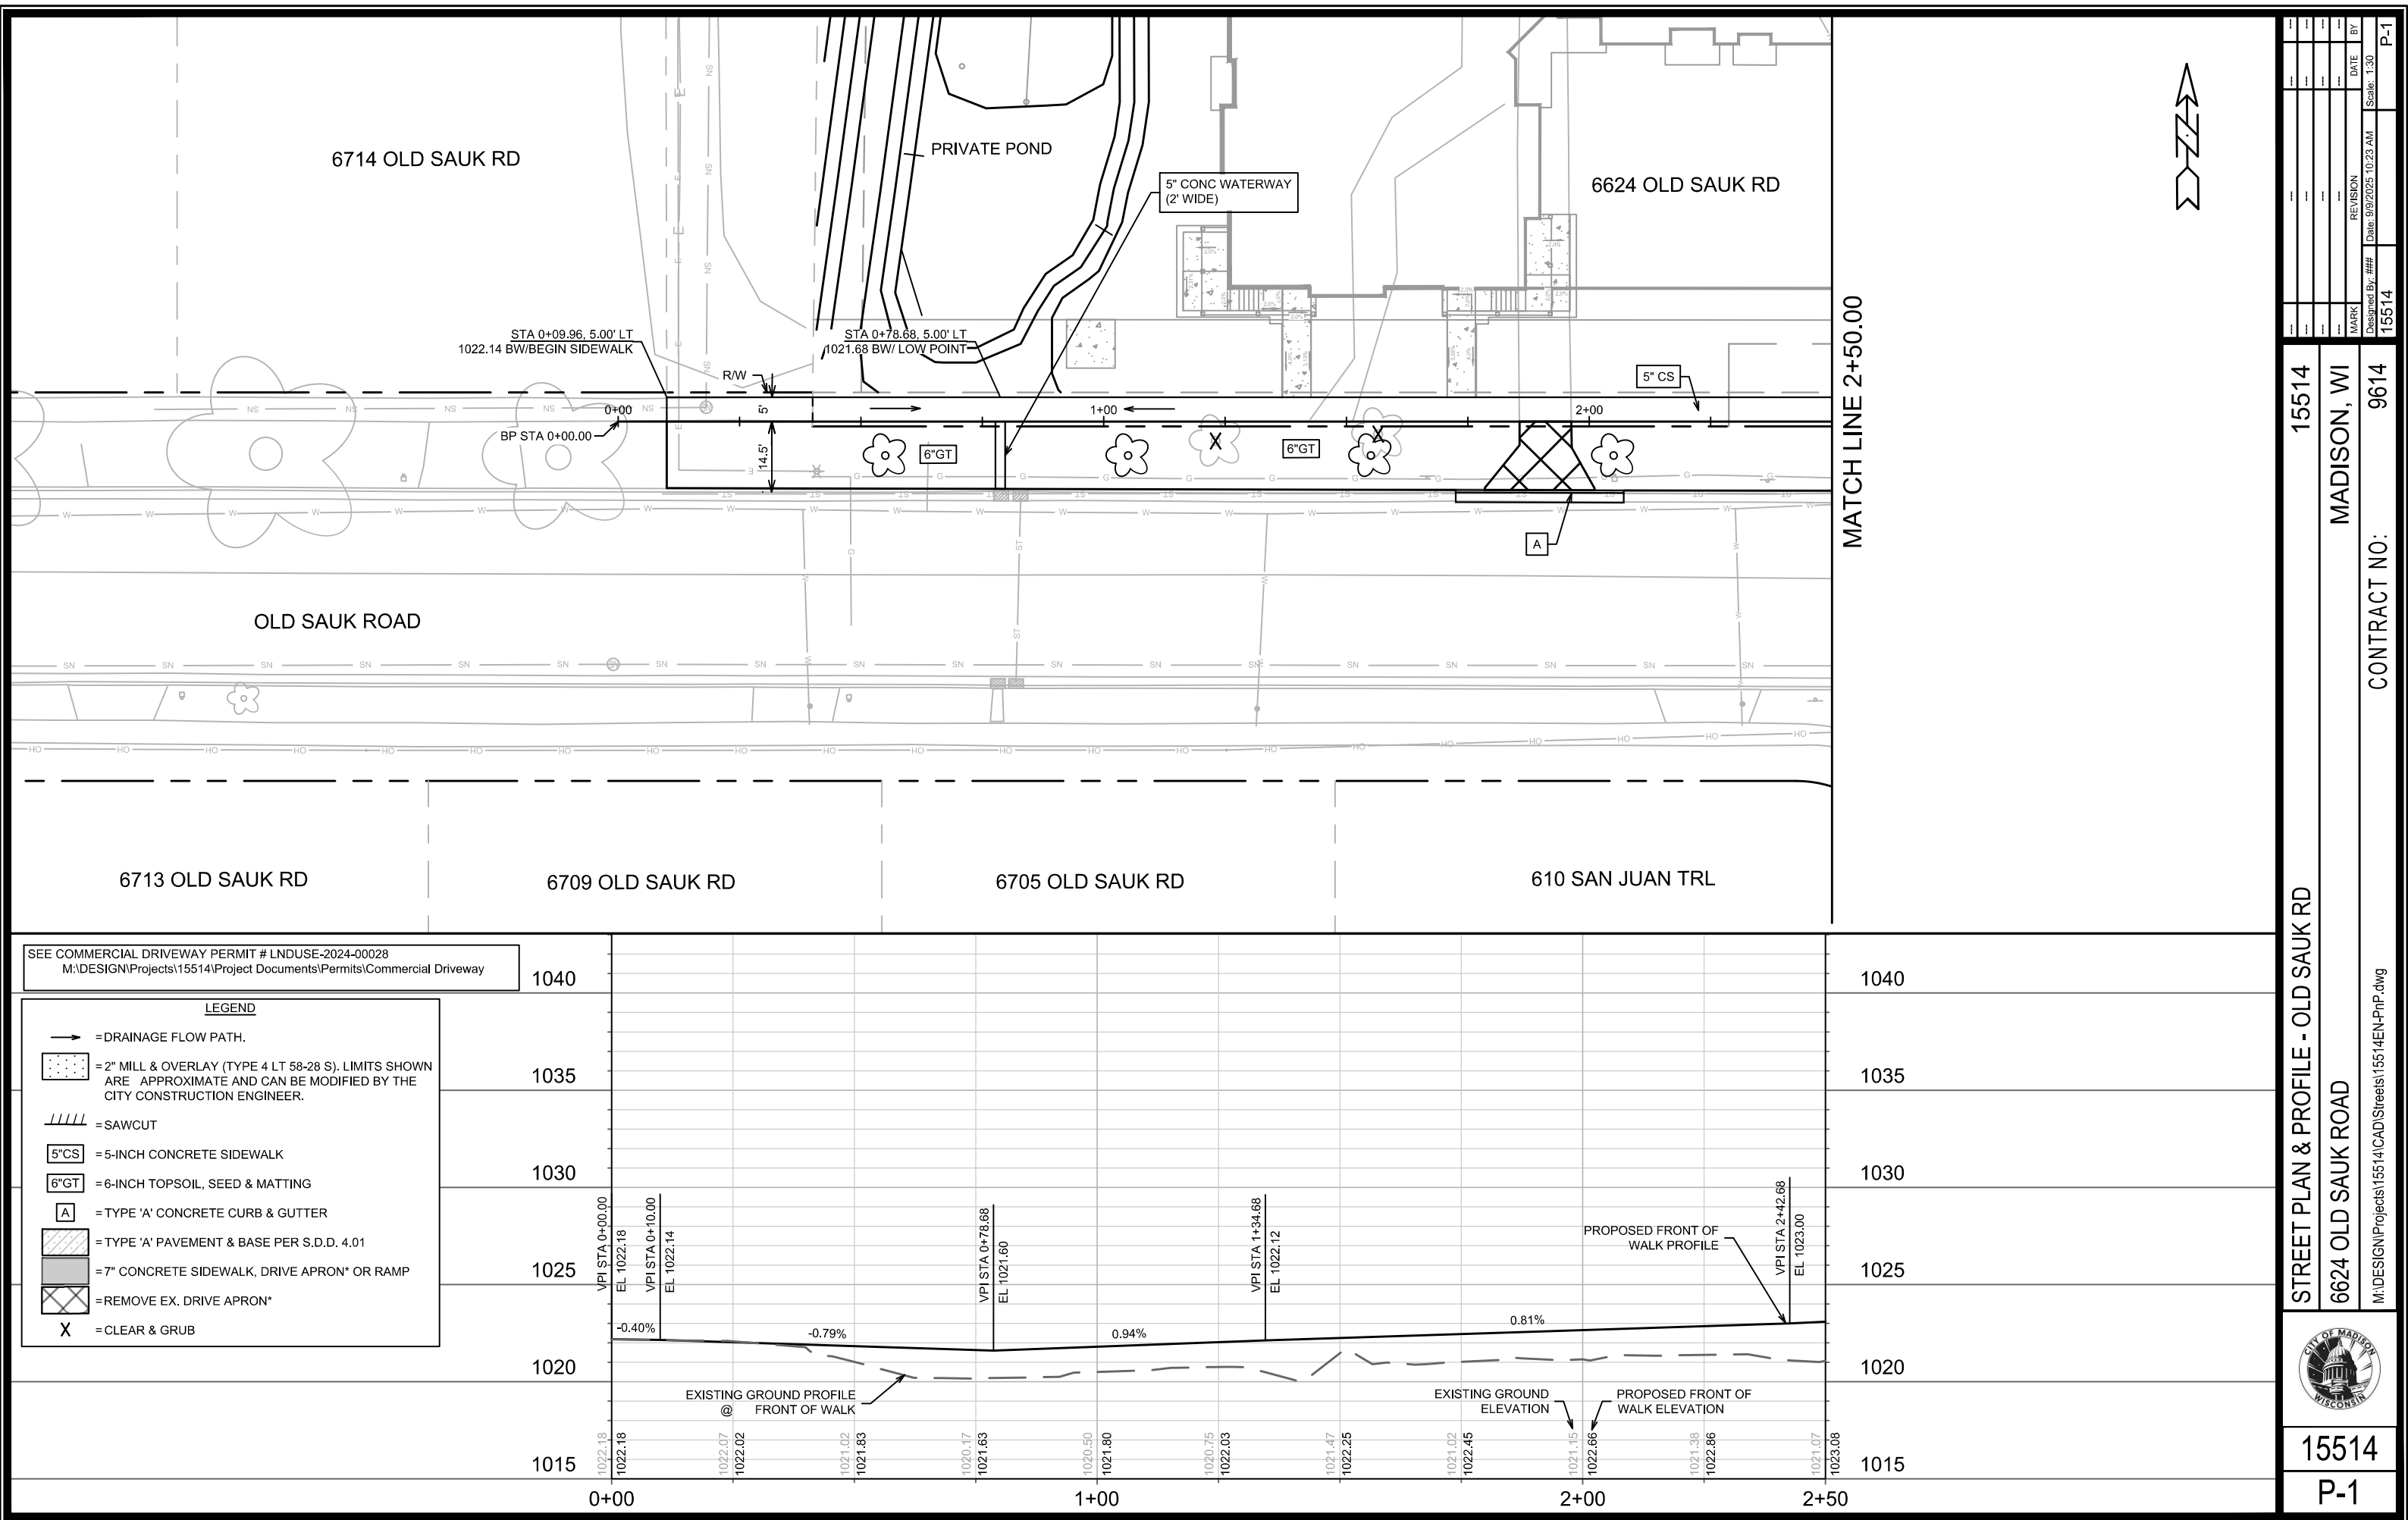

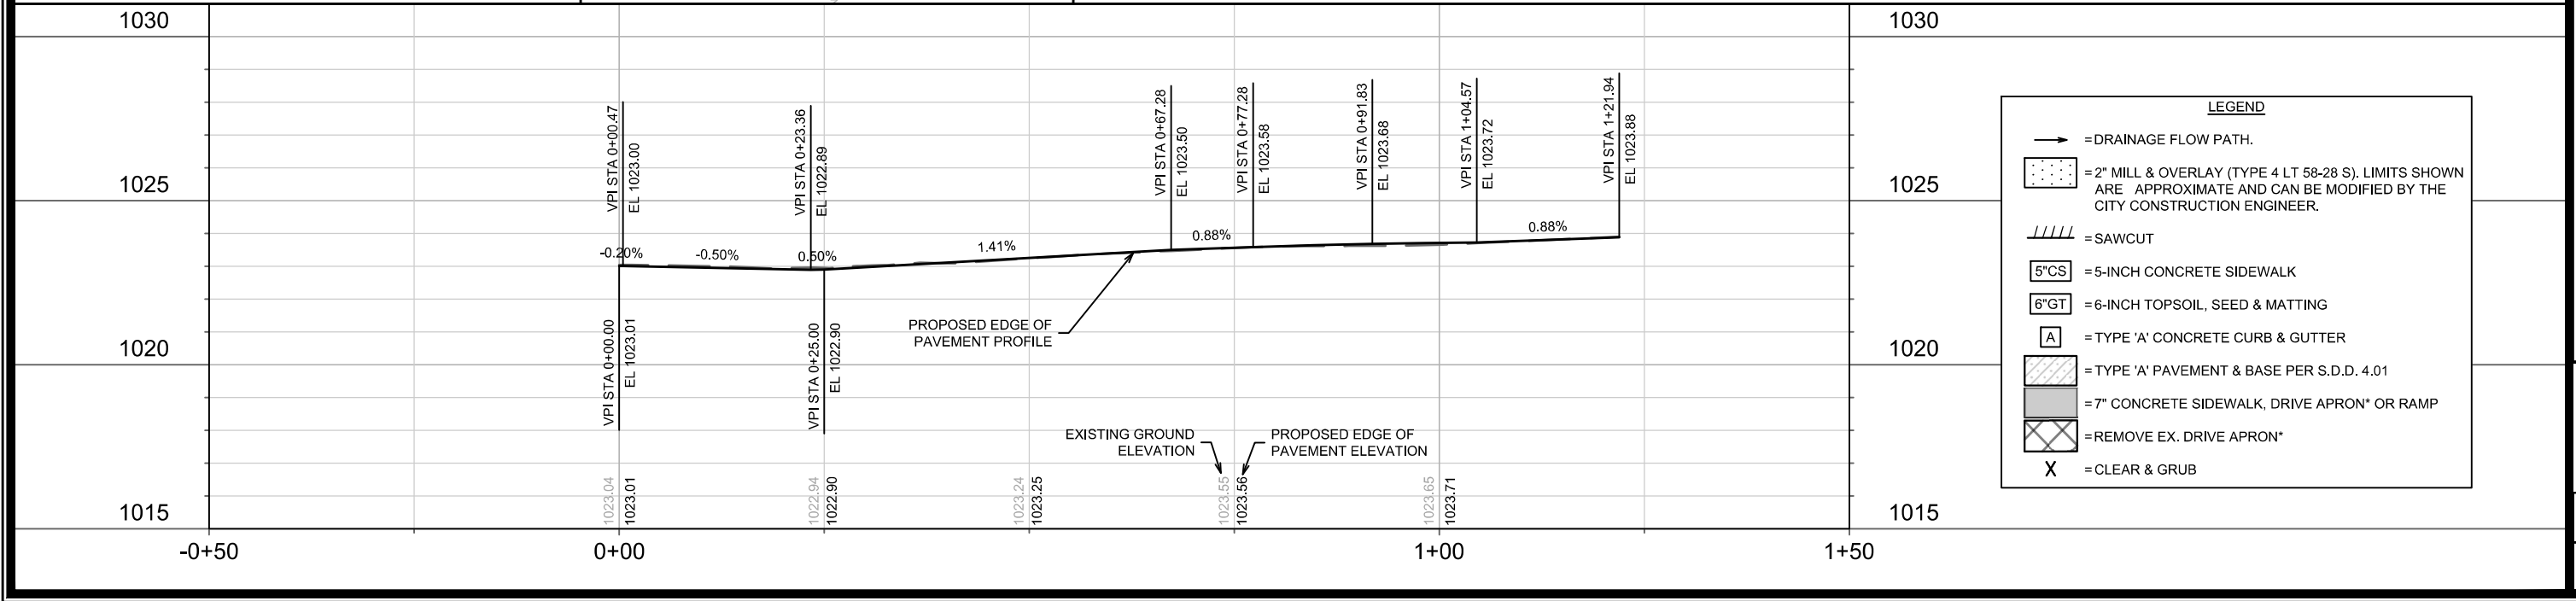

 	15514	
P-3		
STREET PLAN & PROFILE - OLD SAUK & SAN JUAN INTERSECTION		
15514		
6624 OLD SAUK ROAD		
MADISON, WI		
M:\DESIGN\Projects\15514\CAD\Streets\15514EN-PnP.dwg		
CONTRACT NO:		
9614		
MARK REVISION DATE BY		
Designed By JO Date: 9/9/2025 10:23 AM Scale: 1:20		
15514		P-3

INSERT A
168' NORTH OF
SAS 2849-018
ON OLD SAUK RD

REMOVE SIDEWALK FOR
SANITARY SEWER INSTALLATION,
SEE P-SHEETS FOR SIDEWALK
GRADES

070813301010
6714 Old Sauk Rd
MAKKENA, YASHASWINI
ASHUTOSH ARYAL

INSTALL ELECTRONIC
MARKER BALL
ABOVE LATERAL
AT PROPERTY LINE

8" SAN LATERAL
EI = 1013.66
COORDINATE WITH
INTERIOR PLUMBING
PLANS

6624 OLD SAUK RD

INSTALL TEMP PLUG
SEE PLUG PERMIT
ENGSRP-2025-01982-

SAS#2
STA 5+30.49, LT-13.73'
RIM = 1025.25
EI(NW) = 1014.40 (8") - LAT
EI(S) = 1014.30 (8") - EX 8" VP

8" SAN LATERAL
EI = 1014.67
COORDINATE WITH
INTERIOR PLUMB
PLANS

INSTALL TEMP PLUG
SEE PLUG PERMIT
ENGSRP-2025-01982

REMOVE
EX SAS
2849-020

EX SAS
2849-018

SAS#1
NOTE 1

36' - 8" L
@ 1.04%

REMOVE
EX SAS
2849-019

ABANDON EX 8" VP SAN

Diagram illustrating the area calculation of a trapezoid using three parallel horizontal lines. The lines are labeled a , b , and c from top to bottom. The height of the trapezoid is labeled h .

EX 8" SAN

OLD SAUK RD

P-1
12"

CONNECT 8" DI
WATER/LATERAL
TO EX 12" DI MAIN PIPE

070824220118
6709 Old Sauk Rd
GREEN, MICHAEL ANTHONY
AND LYNN MARY GREEN

070824220100
6705 Old Sauk Rd
GREEN, MICHAEL A & LYNN M

070824220093
610 San Juan Trl
JORANLIEN, ERIK
GRACE RIEDLE

REM EX
12" STM

070824204310
6621 Old Sauk Rd
ROELKE IRREV TRUST, C M
RFM FX IN 2850-011

070824204328
6617 Old Sauk Rd
SCHUCK, HOWARD & DIANE

070824204336
6613 Old Sauk Rd
NIESEN TRUST

NOTES

1. DO NOT INSTALL NEW PUBLIC SANITARY SEWER MAIN AND STRUCTURE UNTIL A WDNR SANITARY SEWER EXTENSION PERMIT IS OBTAINED BY CITY ENGINEERING AND PROVIDED TO THE CONTRACTOR. FUTURE SANITARY SEWER IS SHOWN FOR REFERENCE ONLY.

EX SAS
2849-018
STA 0+18.06, LT-2.91'
RIM = 1022.14
EI(E) = 1012.85 (8") - STUB
EI(N) = 1012.74 (8")
EI(W) = 1012.78 (8")

RECONSTRUCT BENCH & FLOWLINES

83' - 8" PVC @ 0.40%

SAN TAP	
EI = 1012.85	

SAS#1
STA 1+00.55, RT-1.00'
RIM = 1021.79
EI(W) = 1013.18 (8")
EI(NE) = 1013.28 (8") - LA

INSERT RIGID
INTERNAL CHIMNEY SEAL

INSTALL EXTERNAL
SAS WRAP IN
CONFORMANCE WITH
SDD 5.7.2

INSERT A
168' NORTH OF SAS 2849-018
ON OLD SAUK RD

INSTALL PERMANENT PLUG
SEE PLUG PERMIT
ENGSRP-2025-01982

070813309014
25 E Spyglass Ct
UMBECK JR, PAUL F
& MARY ACKERMAN UMBECK

070813301127
17 E Spyglass Ct
BURNS, TIMOTHY
SARAH ELIZABETH ROBINSON

070813301010
6714 Old Sauk Rd
MAKKENA, YASHASWINI
ASHUTOSH ARYAL

EX SAS
2849-017

EX 8" SAN

[illegible]

STORM SEWER SCHEDULE

6624 OLD SAUK ROAD	SHEET NO.
PROJECT NO. 15514	U-STM
STORM SEWER SCHEDULE	
CITY OF MADISON	

PROPOSED STORM STRUCTURES

STRUC. NO.	STATION	LOCATION (OFFSET)	TYPE	TOP OF CASTING	E.I.	DEPTH	NOTES
SAN JUAN TRAIL							
S-1	0+23.37	RT-1.50	3X3 SAS	1023.27	1019.95	3.32	LP; W/ R-3067-7004-VB; (1)
S-2	0+59.98	RT-1.50	H INLET	1023.77	1020.74	3.03	W/ R-3067-7004-V

PROPOSED STORM PIPES

PIPE NO.	FROM (DNSTM)	TO (UPSTM)	DISCH. E.I.	INLET E.I.	PLAN (PAY) LGTH (FT)	PIPE LGTH (FT)	SLOPE (%)	PIPE SIZE	TYPE	NOTES
SAN JUAN TRAIL										
P-1	S-1	S-2	1020.36	1020.74	29	32	1.19%	12"	TYPE I	-
P-2	S-1	EX IN 2850-012	1020.37	1020.77	9	10	4.00%	12"	TYPE I	-

STORM STRUCTURE REMOVALS

ID NO.	STATION	LOCATION (OFFSET)	TYPE	NOTES
SAN JUAN TRAIL				
IN 2850-011	0+23.84	RT-3.00	STRUCTURE	-
IN 2850-013	0+56.00	RT-8.50	H INLET	-

STORM PIPE REMOVALS

REMOVE FROM	REMOVE TO	LENGTH (FT)	SIZE	TYPE	NOTES
SAN JUAN TRAIL					
IN 2850-011	IN 2850-013	25	12"	RCP	-
IN 2850-011	IN 2850-012	11	12"	RCP	-

NOTES:

(1) RECONNECT EX 15" RCP PIPE TO WEST

STANDARD NOTES:

- PLAN LENGTH (PAY LENGTH) IS FROM CENTER OF STRUCTURE TO CENTER OF STRUCTURE. PIPE LENGTH IS ACTUAL LENGTH OF PIPE FROM STRUCTURE WALL TO STRUCTURE WALL. SLOPE CALCULATED USING PIPE LENGTH.
- ABBREVIATIONS: AE = APRON ENDWALL; RCP = REINFORCED CONCRETE PIPE; HERCP = HORIZONTAL ELLIPTICAL REINFORCED CONCRETE PIPE; DNA = DOES NOT APPLY; SAS = SEWER ACCESS STRUCTURE; LP = LOW POINT INLET STRUCTURE; FP = FIELD POURED STRUCTURE; TR = TOP OF CONCRETE ROOF; NCM = NO CROWN MATCH FOR PIPES; UD = UNDERDRAIN
- APPROXIMATE DISCHARGE E.I. GIVEN, ADJUST E.I. AND PIPE SLOPE IN THE FIELD.
- TOP OF CASTING GRADE GIVEN IS THE TOP OF CURB FOR INLET STRUCTURES AND THE FLOWLINE OF THE CLOSED CASTING FOR SAS's.
- ALL REINFORCED CONCRETE PIPES TO BE CLASS III UNLESS OTHERWISE NOTED.
- SURVEYOR TO CONFIRM THAT ALL INLET STATION / OFFSETS LINE UP WITH PROPOSED CURB AND GUTTER.
- ALL FIELD POURED SAS STORM STRUCTURES SHALL BE CONSTRUCTED IN ACCORDANCE WITH STANDARD DETAIL DRAWING 5.7.3. ALL PRECAST SAS STORM STRUCTURES SHALL BE CONSTRUCTED IN ACCORDANCE WITH STANDARD DETAIL DRAWING 5.7.5.
- ALL STRUCTURES CALLED OUT AS FIELD POURED SHALL BE FIELD POURED. ALL OTHER STRUCTURES (NOT INDICATED AS FIELD POURED) SHALL BE SUBMITTED TO CITY ENGINEERING FOR APPROVAL IF PRECAST STRUCTURES ARE PREFERRED. CONTACT ELIA E ACOSTA OF CITY ENGINEERING AT (608) 266-4096 FOR STORM SEWER PRECAST APPROVALS, FAX SHOP DRAWINGS TO (608)264-9275, OR EMAIL SHOP DRAWINGS TO EACOSTA@CITYOFMADISON.COM.
- FOR SWM PRECAST APPROVALS CONTACT PHIL GAEBLER AT (608) 266-4059 OR EMAIL SWM SHOP DRAWINGS TO PGAEBLER@CITYOFMADISON.COM



M:\DESIGN\Traffic\Maps_Plans\SM-Plans\Sign-Mark Basemap.dwg

M:\DESIGN\Traffic\Maps_Plans\SM-Plans\Sign-Mark Basemap.dwg

M:\DESIGN\Traffic\Maps_Plans\SM-Plans\Sign-Mark Basemap.dwg

M:\DESIGN\Traffic\Maps_Plans\SM-Plans\Sign-Mark Basemap.dwg

LEGEND

X CLEAR & GRUB

[Symbol] TREE PROTECTION ZONE FENCE

- STREET TREE NOTE:
- 1. TERRACE EXCAVATION FOR PLANTING PER S.D.D. 2.18
 - 2. CONTRACTOR SHALL CONTACT CITY FORESTRY (608) 266-4816 AT LEAST ONE WEEK PRIOR TO PLANTING TO SCHEDULE INSPECTING THE NURSERY STOCK AND REVIEW PLANTING SPECIFICATIONS WITH THE LANDSCAPER.

STREET TREE PLANTING LIST

Symbol	Qty	Botanical Name	Common Name	Size	Stock
CO	3	Celtis occidentalis	Common Hackberry	2" CAL.	B&B
OV	2	Ostrya virginiana	Ironwood	2" CAL.	B&B
QM	2	Quercus muehlenbergii	Chinkapin Oak	2" CAL.	B&B
UNH	3	Ulmus americana 'New Harmony'	New Harmony American Elm	2" CAL.	B&B

01
ass
R,
CK

Y
TH

10
Sak
A,
SH

10
uk Rd
YASHASWINI
ARYAL

070824220118
6709 Old Sauk Rd
GREEN, MICHAEL ANTHONY
AND LYNN MARY GREEN


070824220100
6705 Old Sauk Rd
GREEN, MICHAEL A & LYNN M

070824220093
610 San Juan Trl
JORANLIEN, ERIK
GRACE RIEDLE

070824204310
6621 Old Sauk Rd
ROELKE IRREV TRUST, C M

070824204328
6617 Old Sauk Rd
SCHUCK, HOWARD & DIANE

070824204336
6613 Old Sauk Rd
NIESEN TRUST

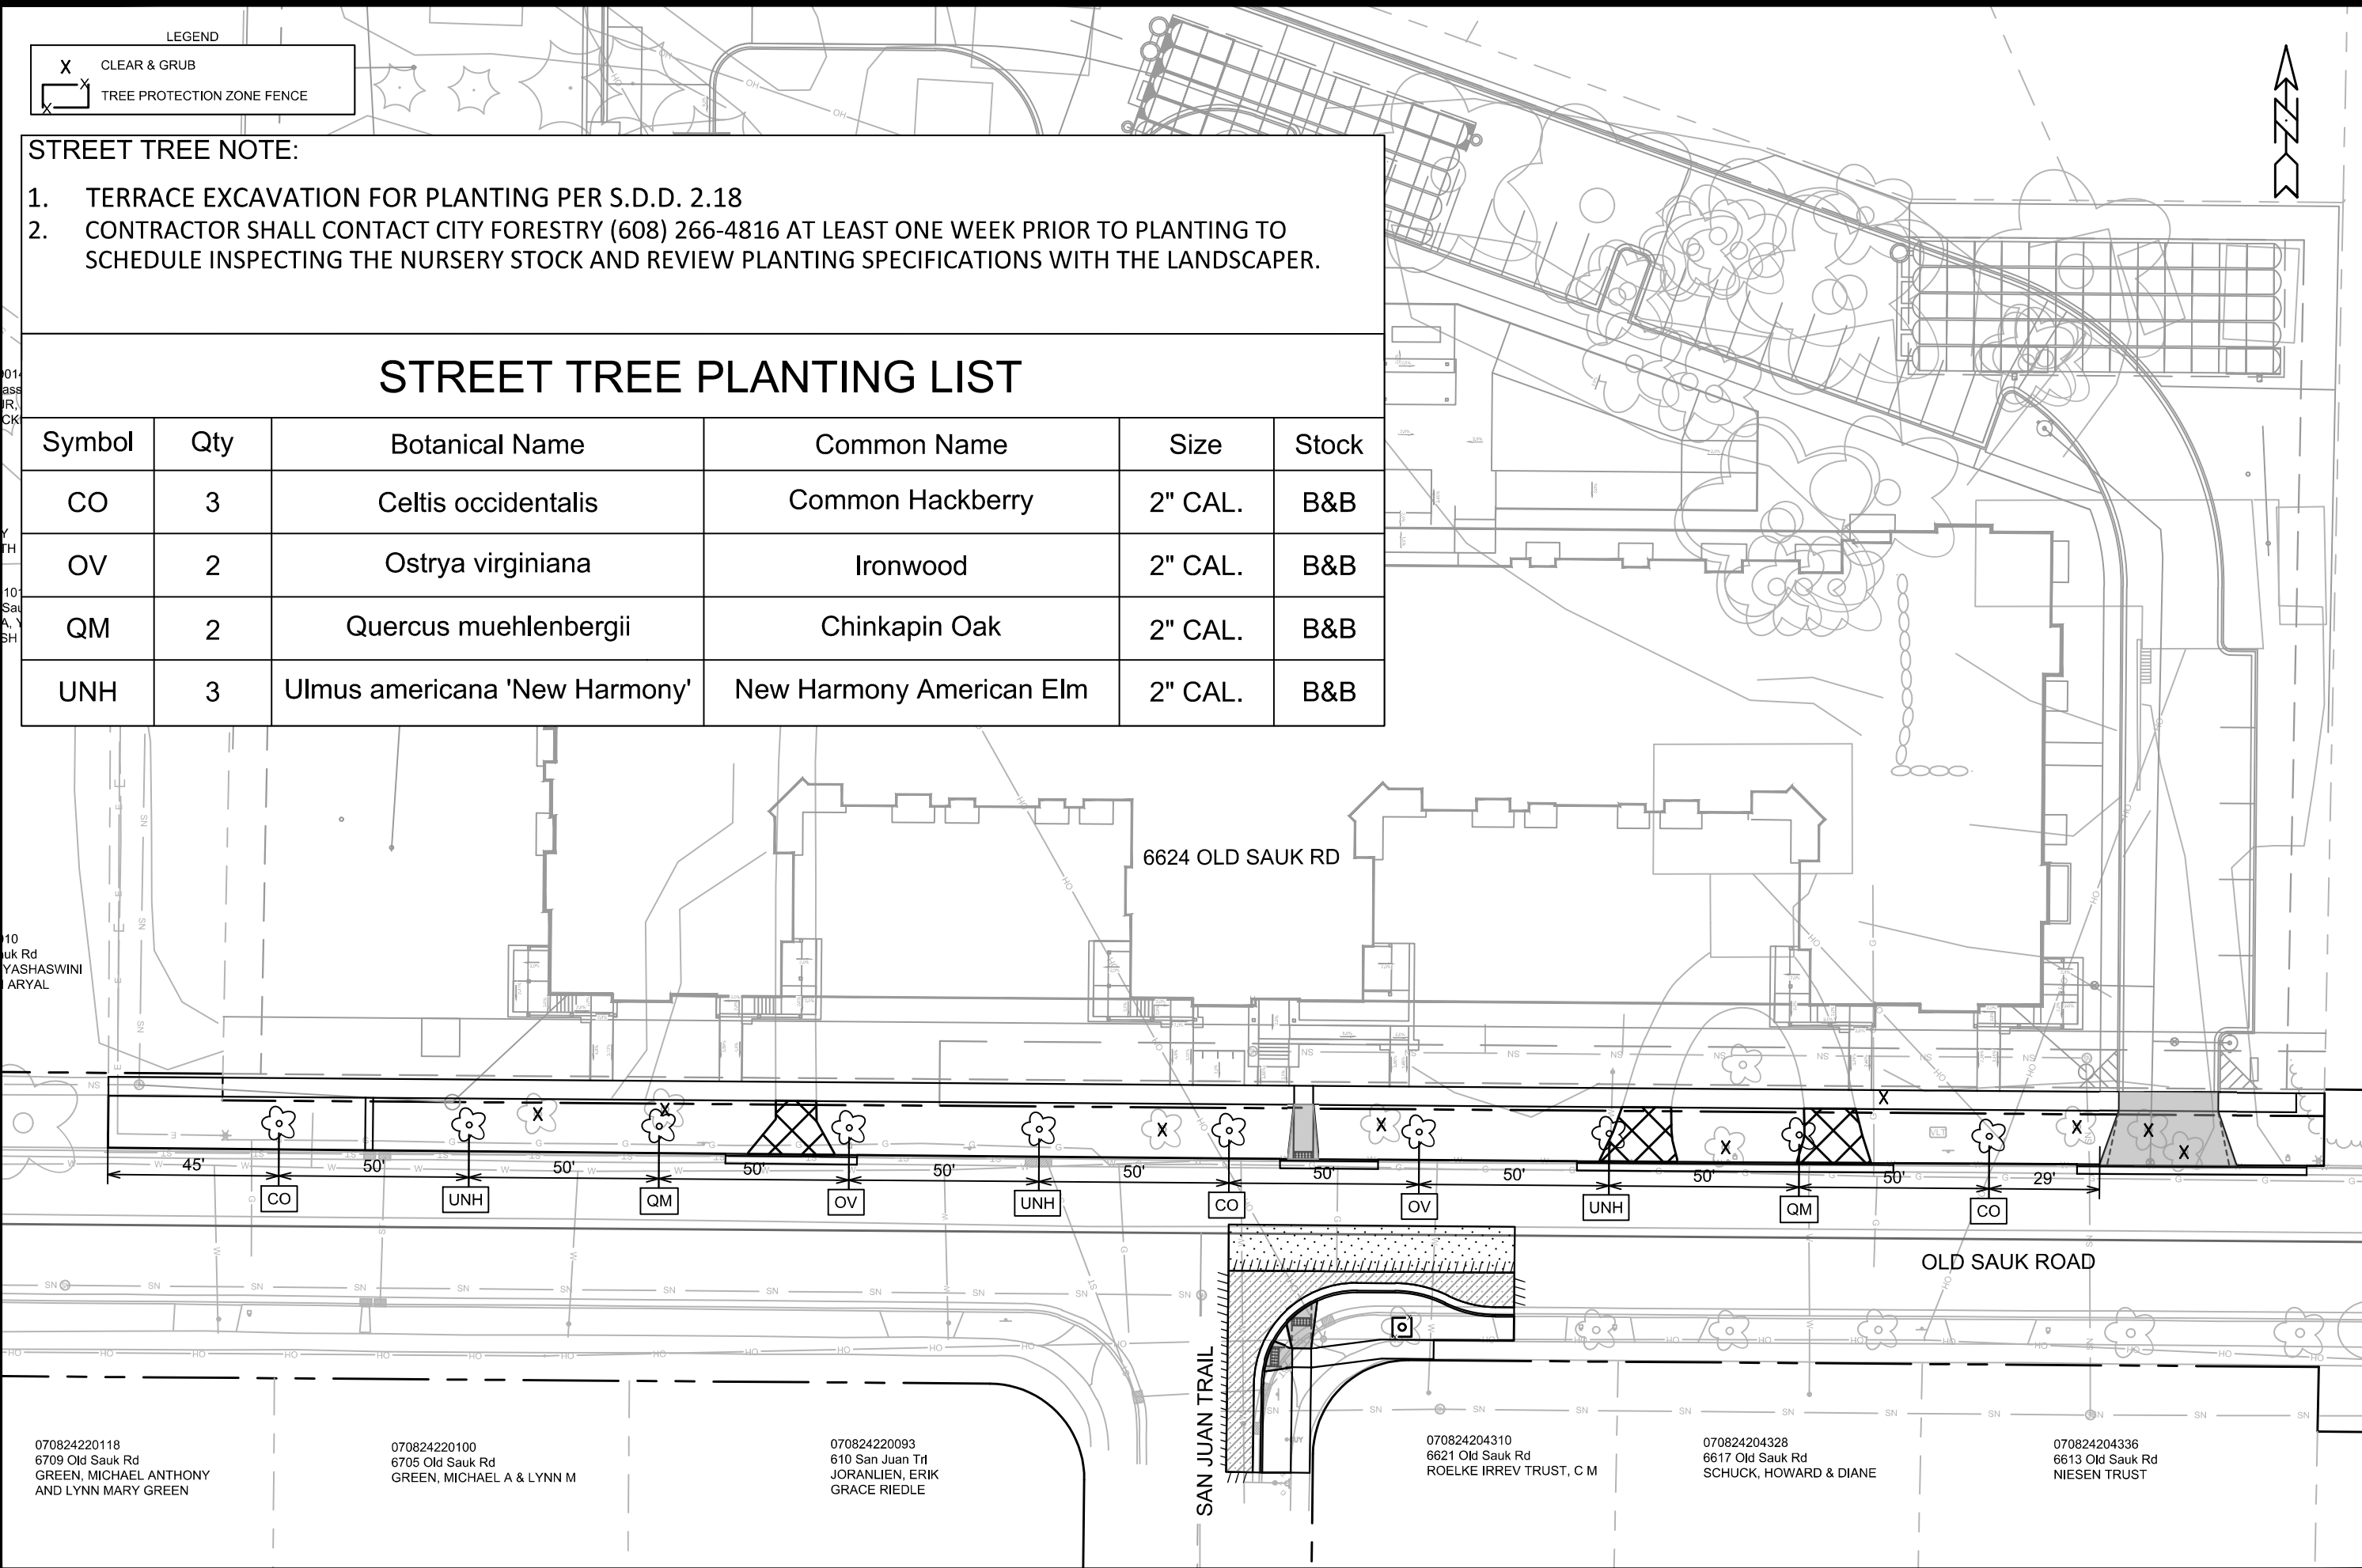

15514

MADISON, WI

9614

LANDSCAPING PLAN

6624 OLD SAUK ROAD

M:\DESIGN\Projects\15514\CAD\Streets\15514EN-LandscapingPlan.dwg

15514

L-1

REVISION







DATE







BY

15514

9/9/2025 10:26 AM

L-1

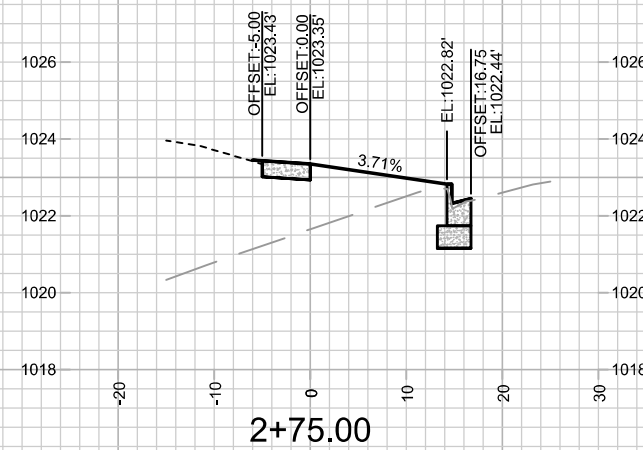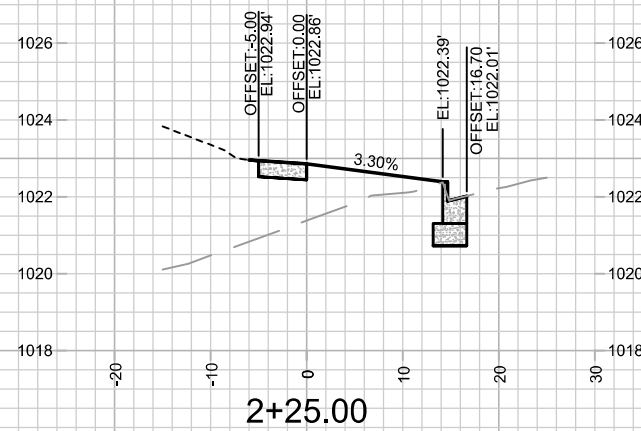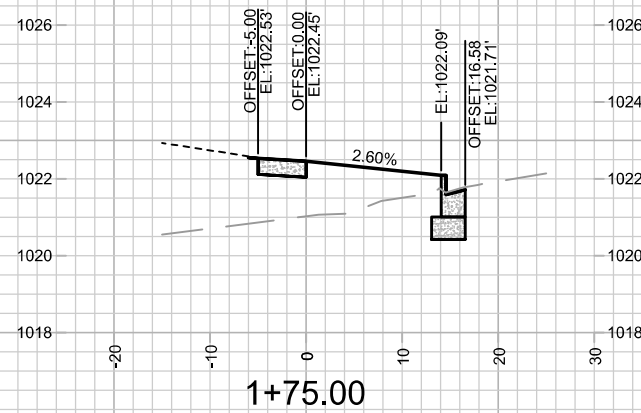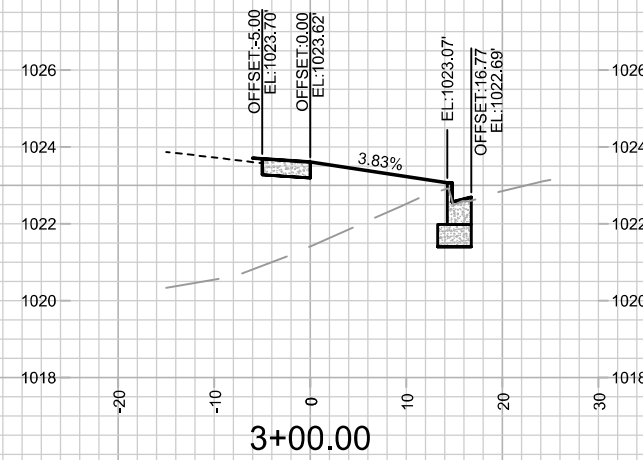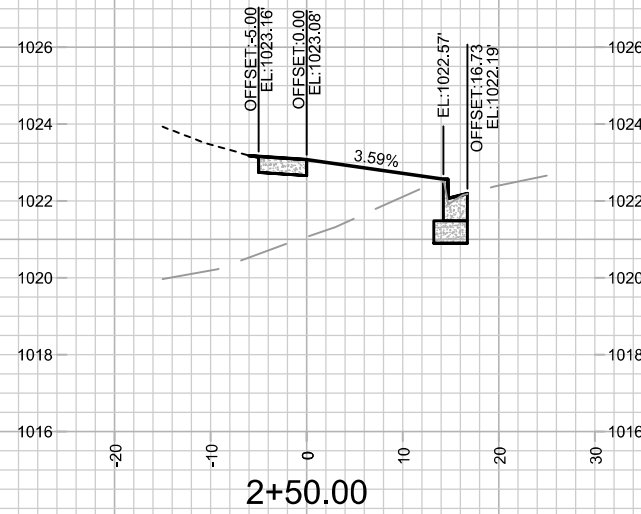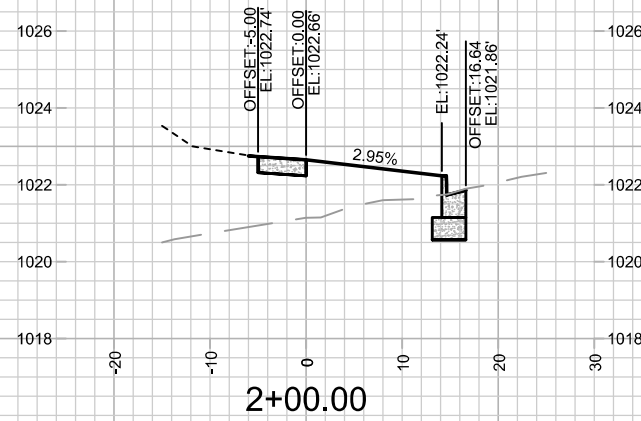

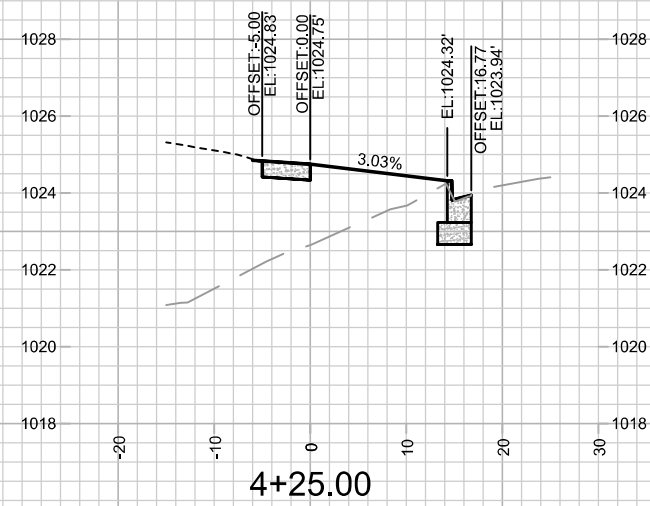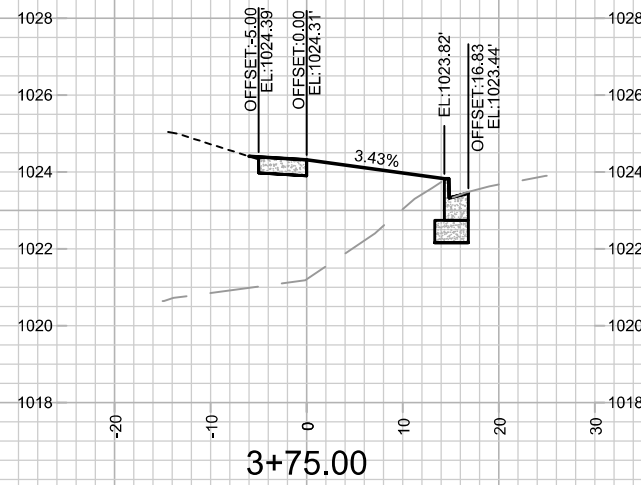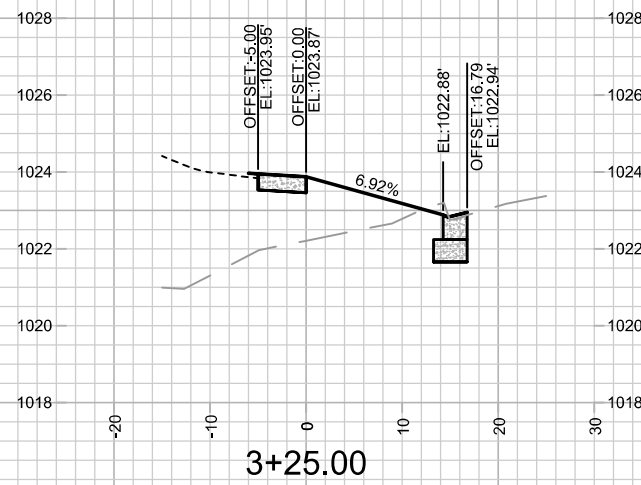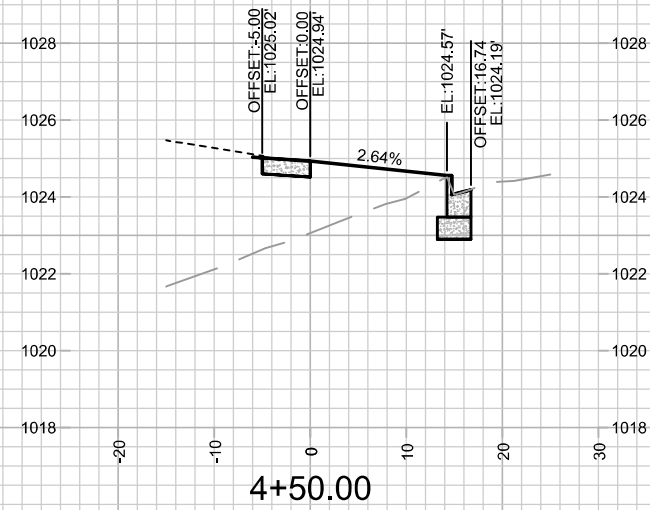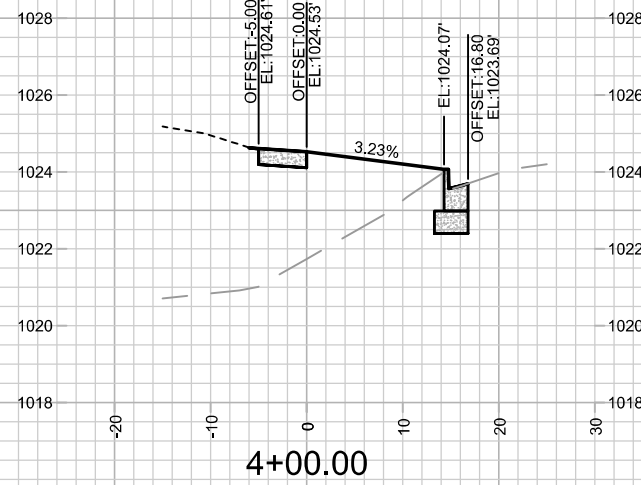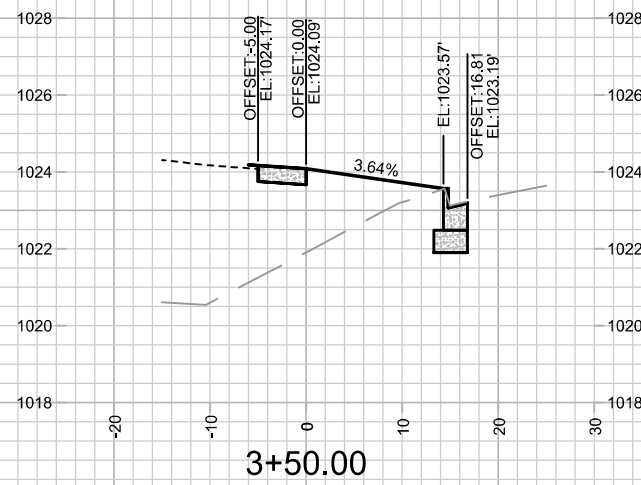

15514

X-3

CROSS SECTIONS - OLD SAUK ROAD
6624 OLD SAUK ROAD

15514	MADISON, WI
CONTRACT NO:	9614

MARK	REVISION	DATE	BY
15514	Date: 9/9/2025 10:30 AM	Scale: 1" = 20'	X-3

