



Madison, Wisconsin

CITY OF MADISON

CITY ENGINEERING DIVISION

DEPARTMENT OF PUBLIC WORKS

PLAN OF PROPOSED IMPROVEMENT


INDEX OF SHEETS

SHEET NO. C14-C18 UTILITY PLAN & PROFILES

3030 OHMEDA DRIVE CSM

CITY PROJECT NO. 13825
CONTRACT NO. 9082

PROJECT LOCATION

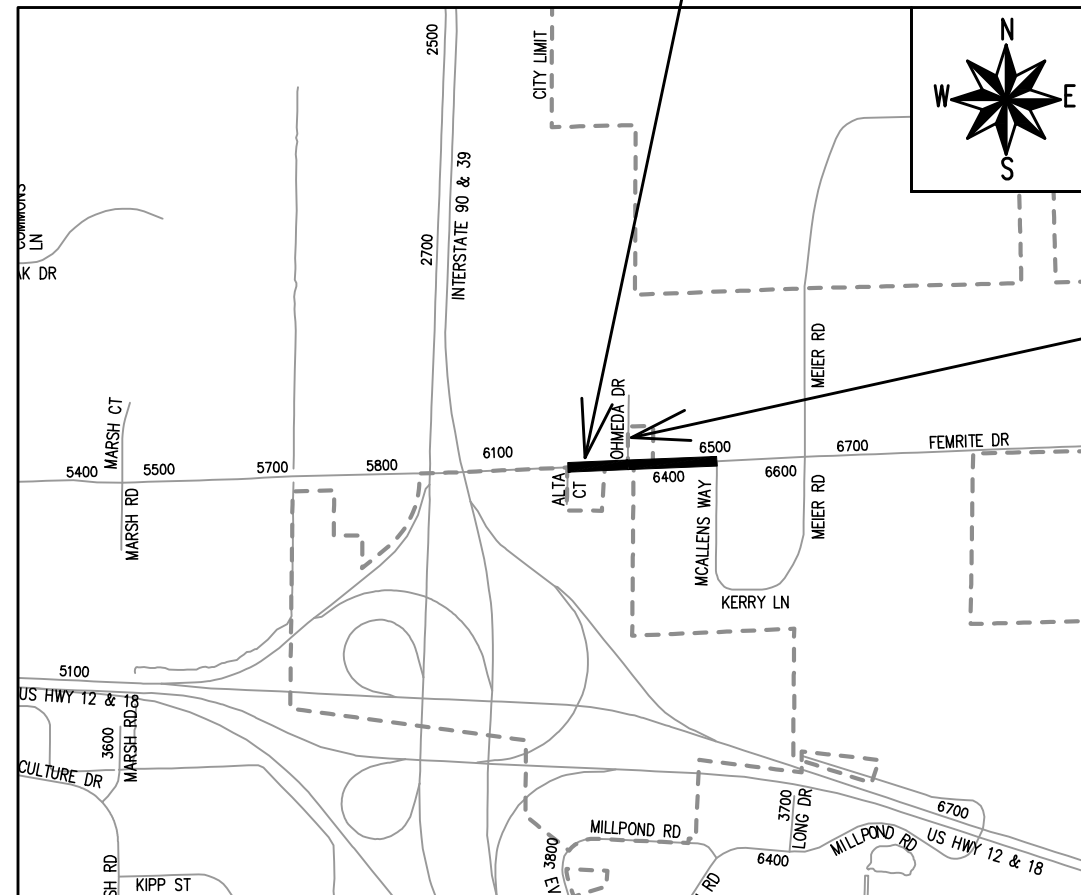

OHMEDA DRIVE STREET PLANS
(SEE PROJECT NO. 13810, CONTRACT NO. 8631)

CONVENTIONAL SIGNS FIELD VERIFY ALL UTILITY LOCATIONS

GAS	— G —
STORM SEWER	— ST —
SANITARY SEWER	— SN —
WATER	— W —
BURIED ELECTRIC	— E —
OVERHEAD ELECTRIC	— OH —
POWER POLE	
ADA COMPLIANT RAMP W/ DETECTABLE WARNING FIELD	
COMBUSTIBLE FLUIDS	

PUBLIC IMPROVEMENT PROJECT
APPROVED

APPROVED DATE November 16, 2021

BY THE COMMON COUNCIL
OF MADISON, WISCONSIN

PUBLIC IMPROVEMENT DESIGN
APPROVED BY:

Greg Fries

Sep 30, 2022

City Engineer

Date

SANITARY SEWER
DESIGNED BY:





THESE PLANS AND DESIGNS ARE COPYRIGHT PROTECTED AND MAY NOT BE USED IN WHOLE OR IN PART WITHOUT THE WRITTEN CONSENT OF PINNACLE ENGINEERING GROUP, LLC

REVIEWED: TOM

DESIGNED: TOM

DRAFTED: MRG

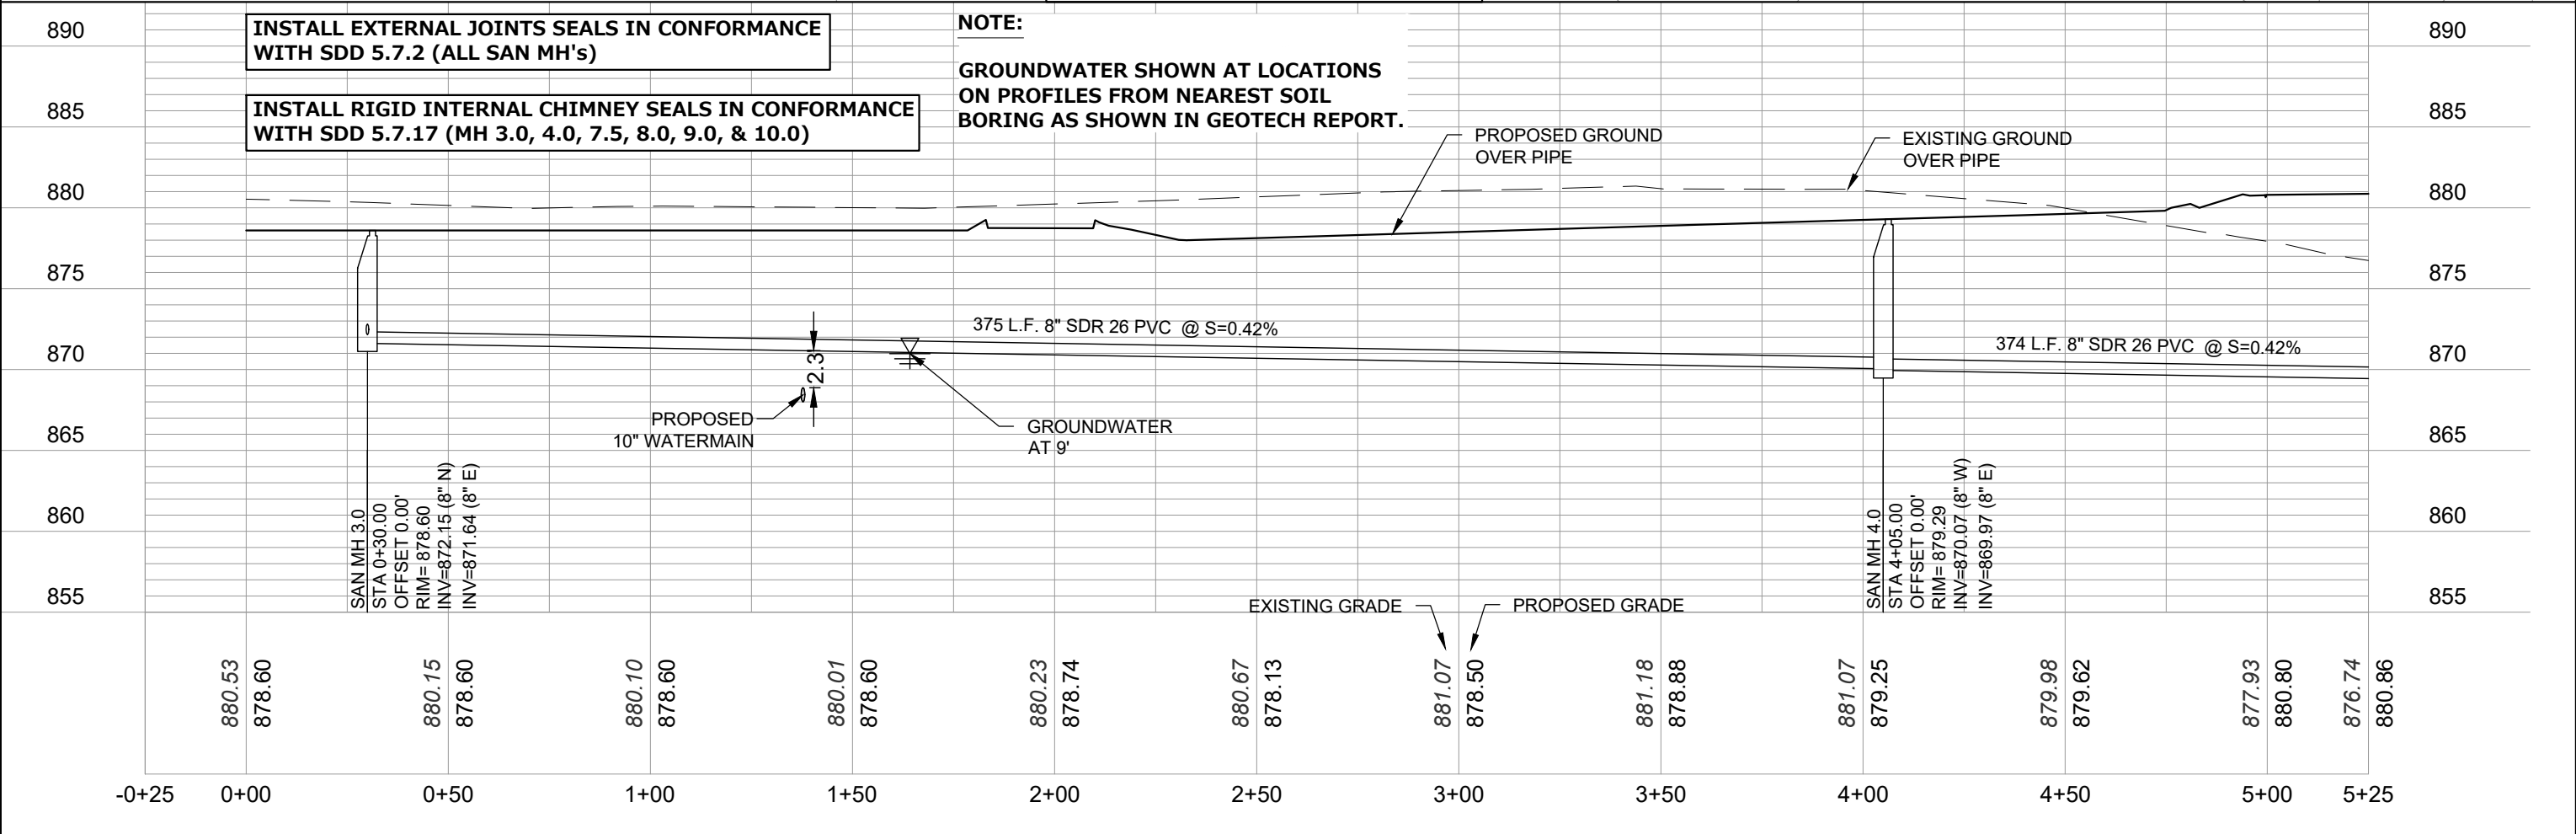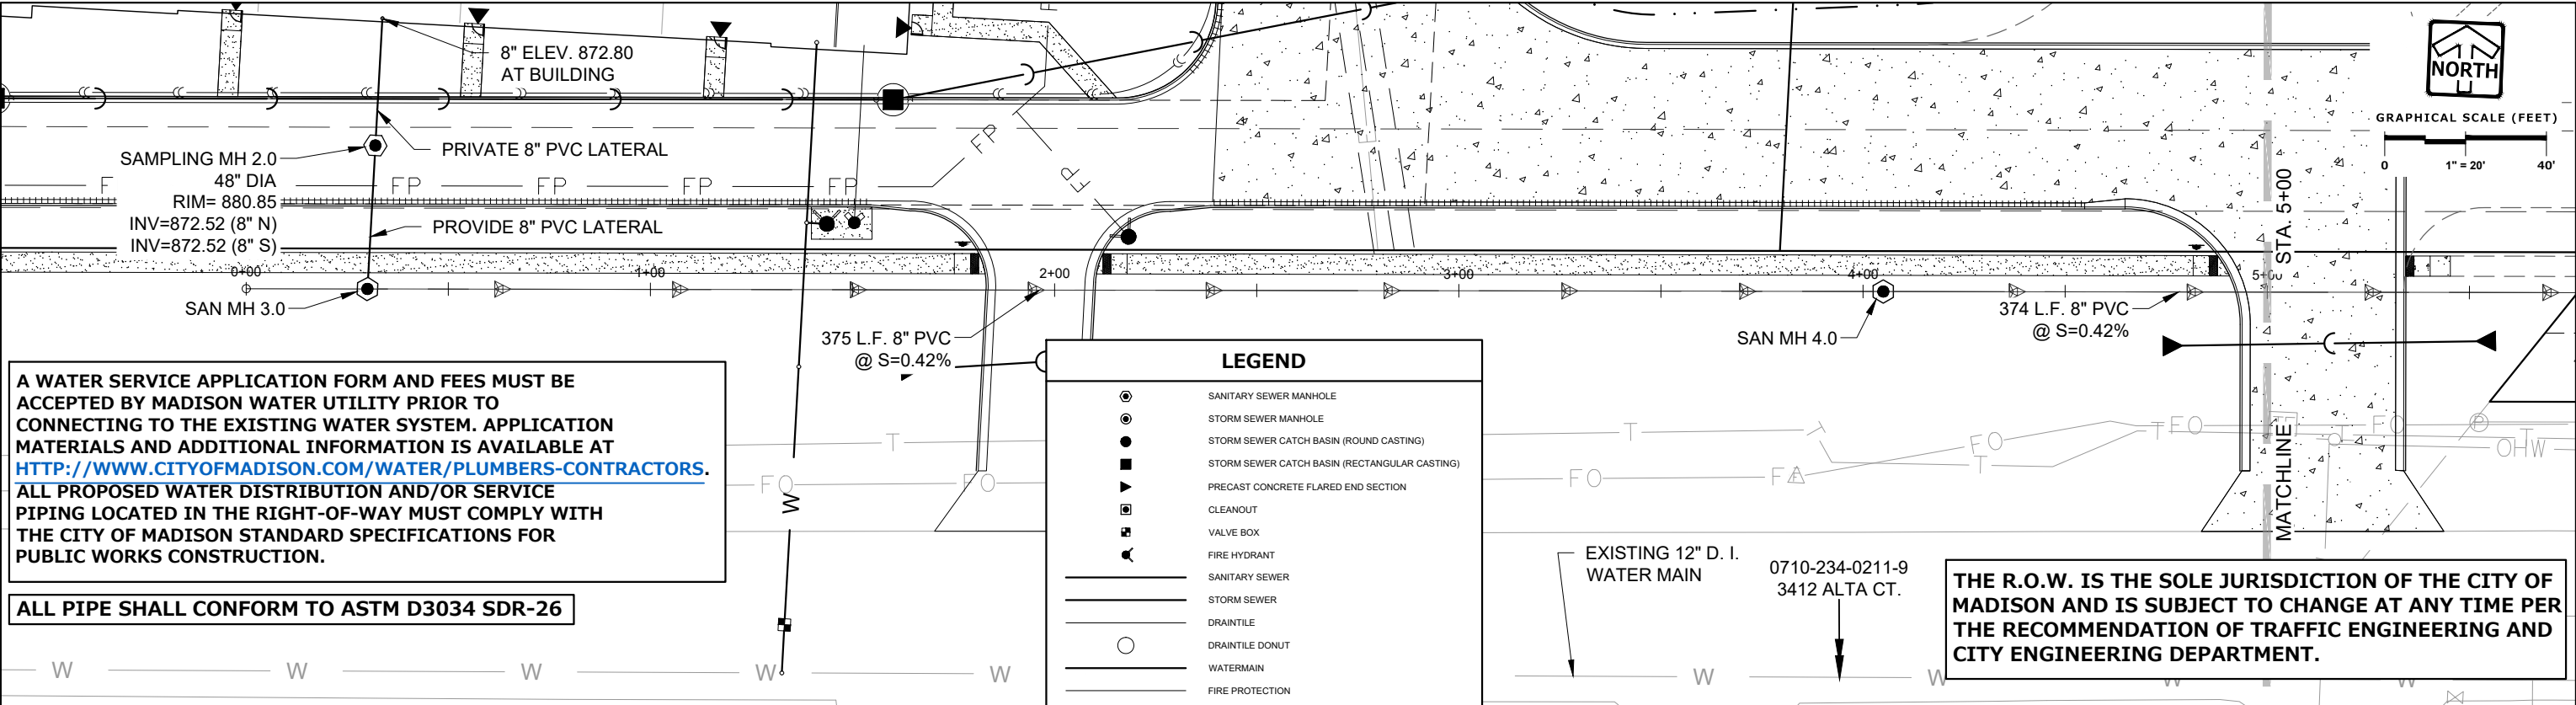



PINNACLE ENGINEERING GROUP
ENGINEERING | NATURAL RESOURCES | SURVEYING

PLAN | DESIGN | DELIVER
www.pinnacle-engr.com

WISCONSIN OFFICE:
20725 WATERTOWN ROAD, SUITE 100
BROOKFIELD, WI 53186
(262) 754-6888

CHICAGO | MILWAUKEE | NATIONWIDE

3030 OHMEDA DRIVE CSM

MADISON, WISCONSIN

UTILITY PLAN

REVISIONS

9	PER CITY COM/SAN SEWER	07/22/22	5	PER CITY COMMENTS	06/06/22
10	PER CITY COMMENTS	07/25/22	6	PER CITY COMMENTS	07/12/22
11	PER CITY COMMENTS	08/10/22	7	PER CITY COMMENTS	07/15/22
12	PER CITY COMMENTS	09/21/22	8	PER CITY COM/SAN SEWER	07/21/22

PEG JOB No. 1933.00

PEG PM. AREA

START DATE 08/05/20

SCALE 1" = 40'



SHEET C-14 C-29

THESE PLANS AND DESIGNS ARE COPYRIGHT PROTECTED AND MAY NOT BE USED IN WHOLE OR IN PART WITHOUT THE WRITTEN CONSENT OF PINNACLE ENGINEERING GROUP, LLC

DESIGNED: TGM

REVIEWED: TGM

DRAFTED: MRG

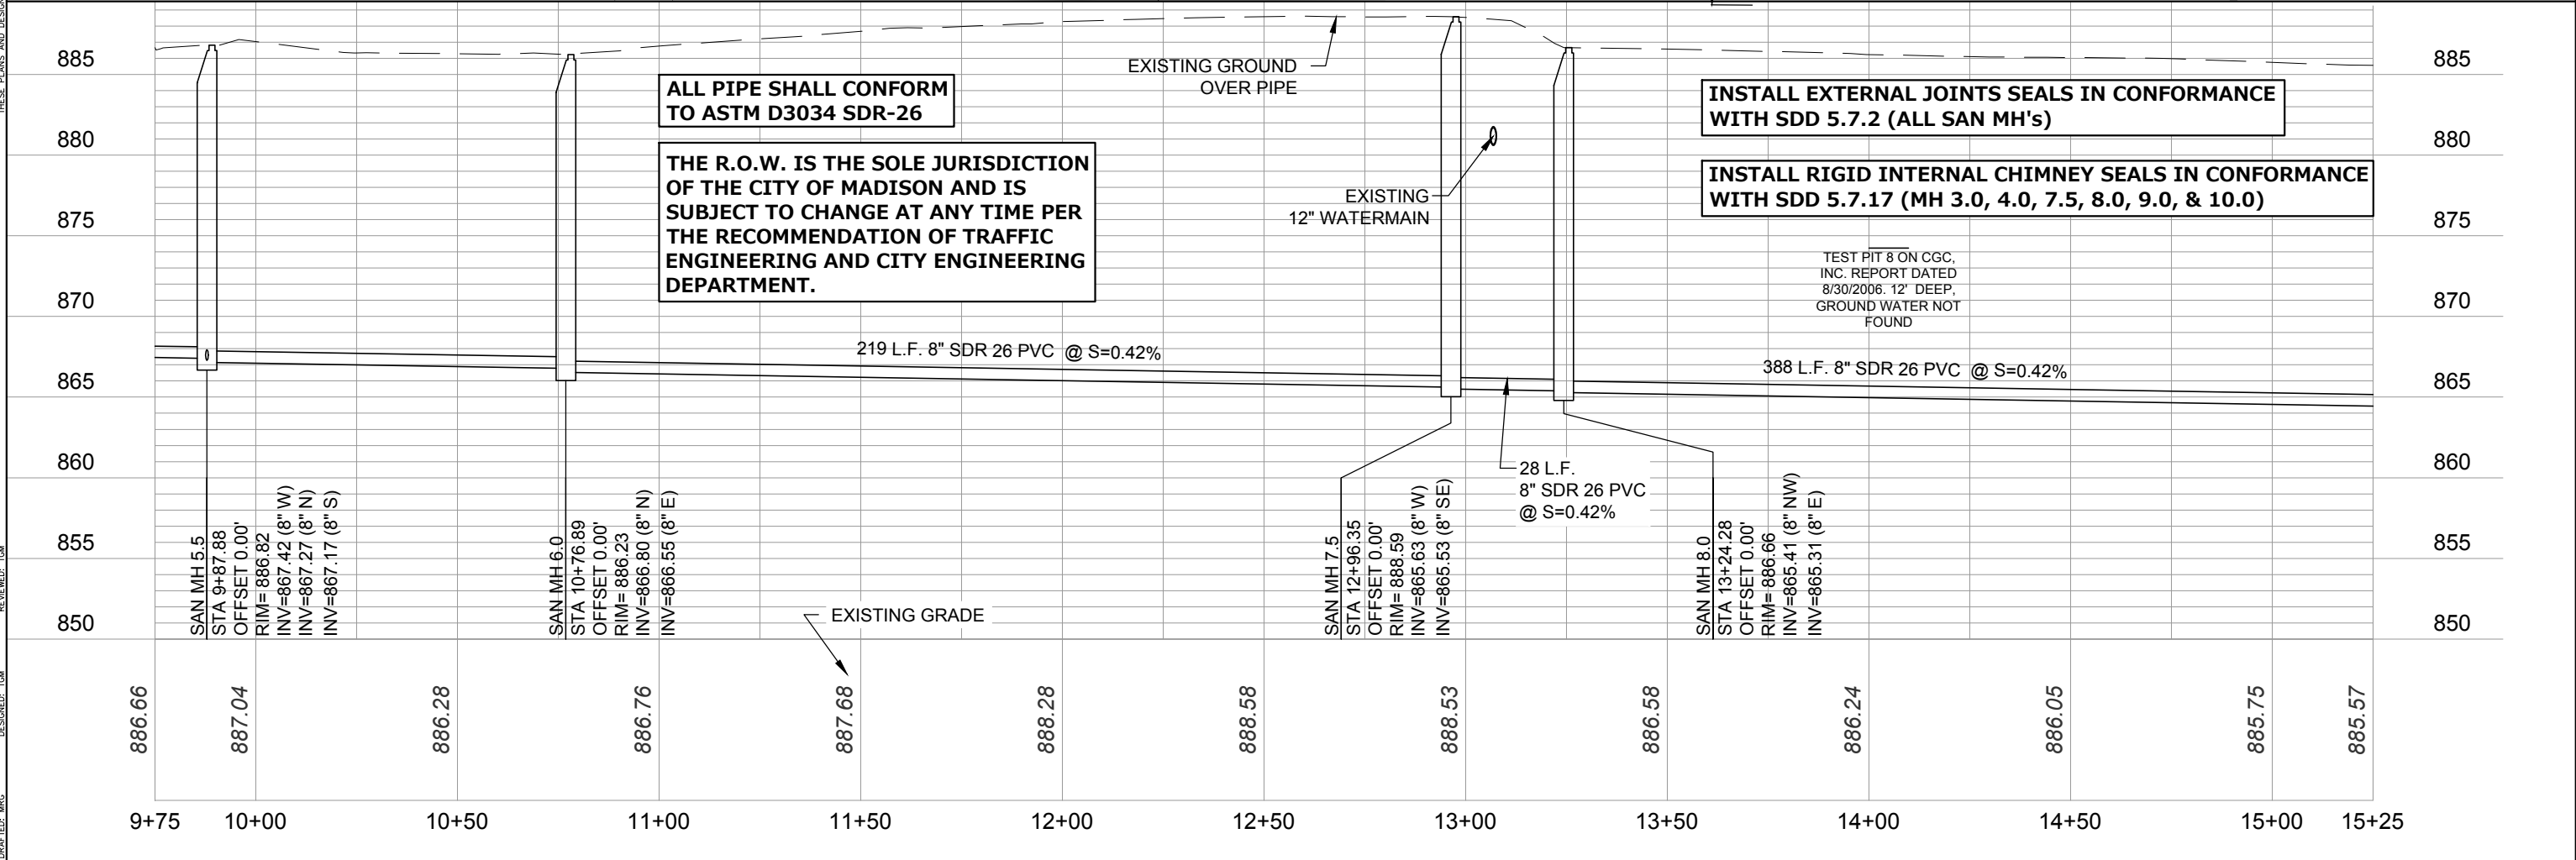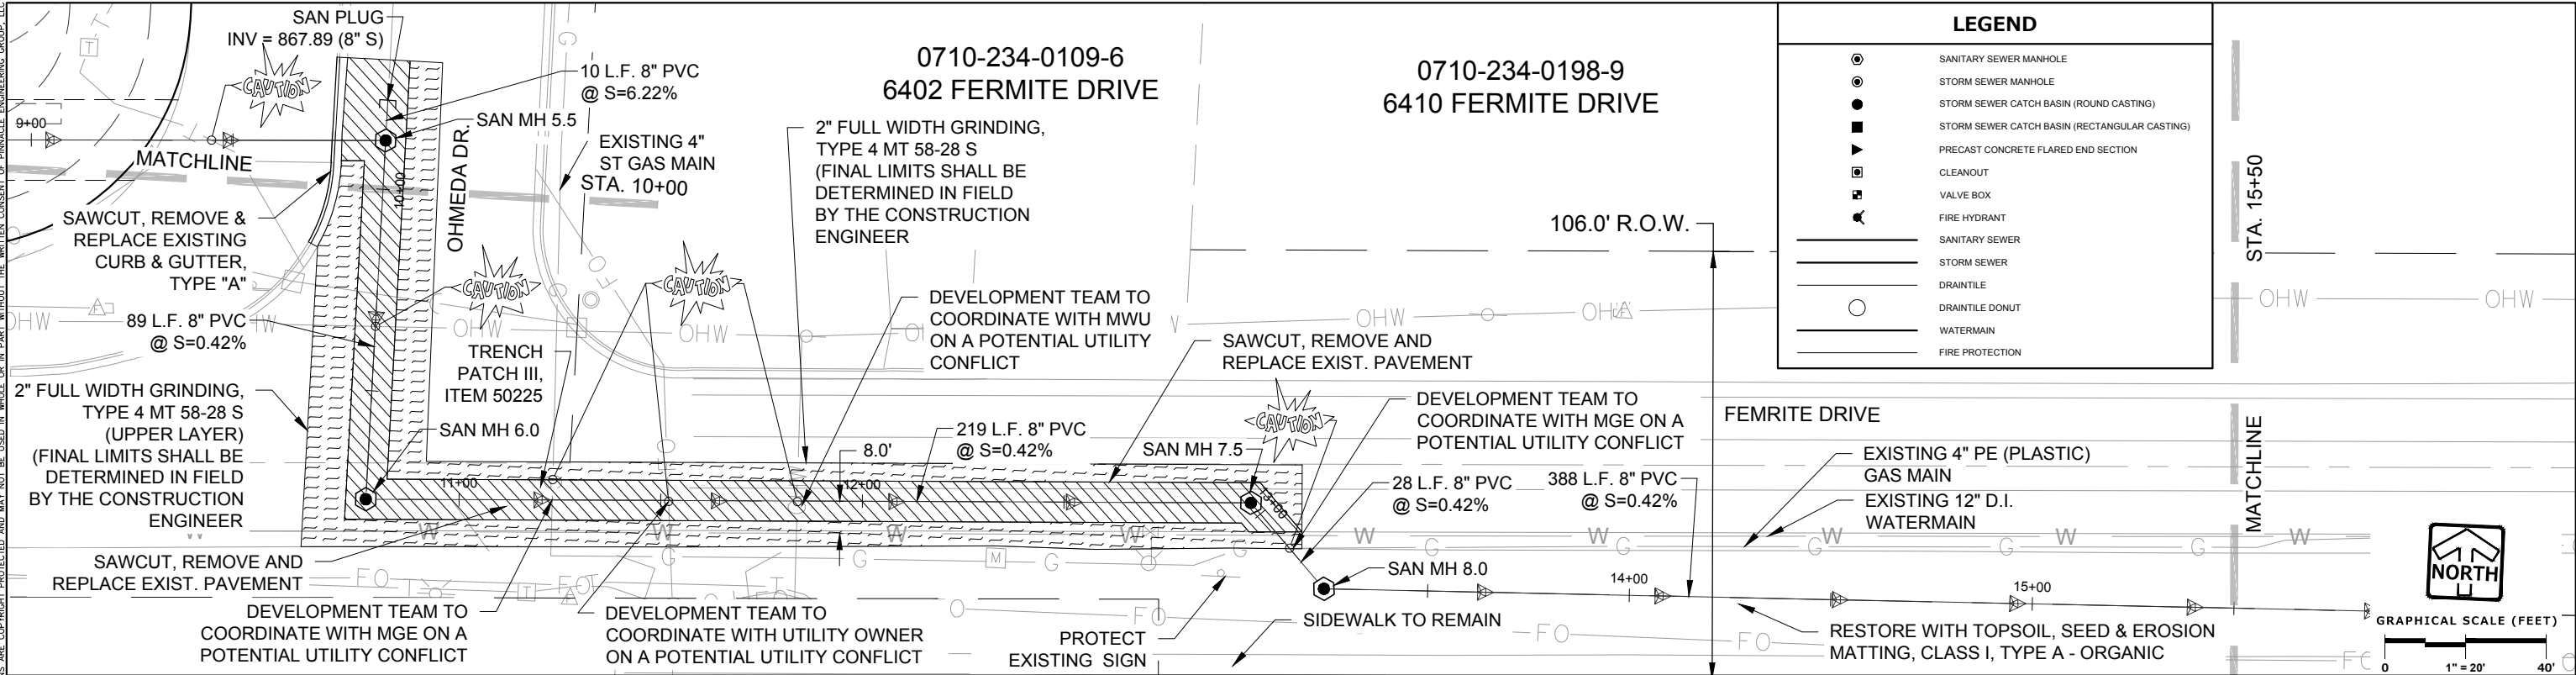



PINNACLE ENGINEERING GROUP
ENGINEERING | NATURAL RESOURCES | SURVEYING

PLAN | DESIGN | DELIVER
www.pinnacle-engr.com

WISCONSIN OFFICE:
20725 WATERTOWN ROAD, SUITE 100
BROOKFIELD, WI 53186
(262) 754-6888

CHICAGO | MILWAUKEE | NATIONWIDE

3030 OHMEDA DRIVE CSM

MADISON, WISCONSIN

UTILITY PLAN

REVISIONS

NO.	DESCRIPTION	DATE
9	PER CITY COM/SAN SEWER	07/22/22
10	PER CITY COMMENTS	07/25/22
11	PER CITY COMMENTS	08/10/22
12	PER CITY COMMENTS	09/21/22
5	PER CITY COMMENTS	06/06/22
6	PER CITY COMMENTS	07/12/22
7	PER CITY COMMENTS	07/15/22
8	PER CITY COM/SAN SEWER	07/21/22



PEG JOB No. 1933.00
PEG PM. AREA
START DATE 08/05/20
SCALE 1" = 40'

SHEET C-16 C-29

THESE PLANS AND DESIGNS ARE COPYRIGHT PROTECTED AND MAY NOT BE USED IN WHOLE OR IN PART WITHOUT THE WRITTEN CONSENT OF PINNACLE ENGINEERING GROUP, LLC

DESIGNED: MRG

REVIEWED: TOM

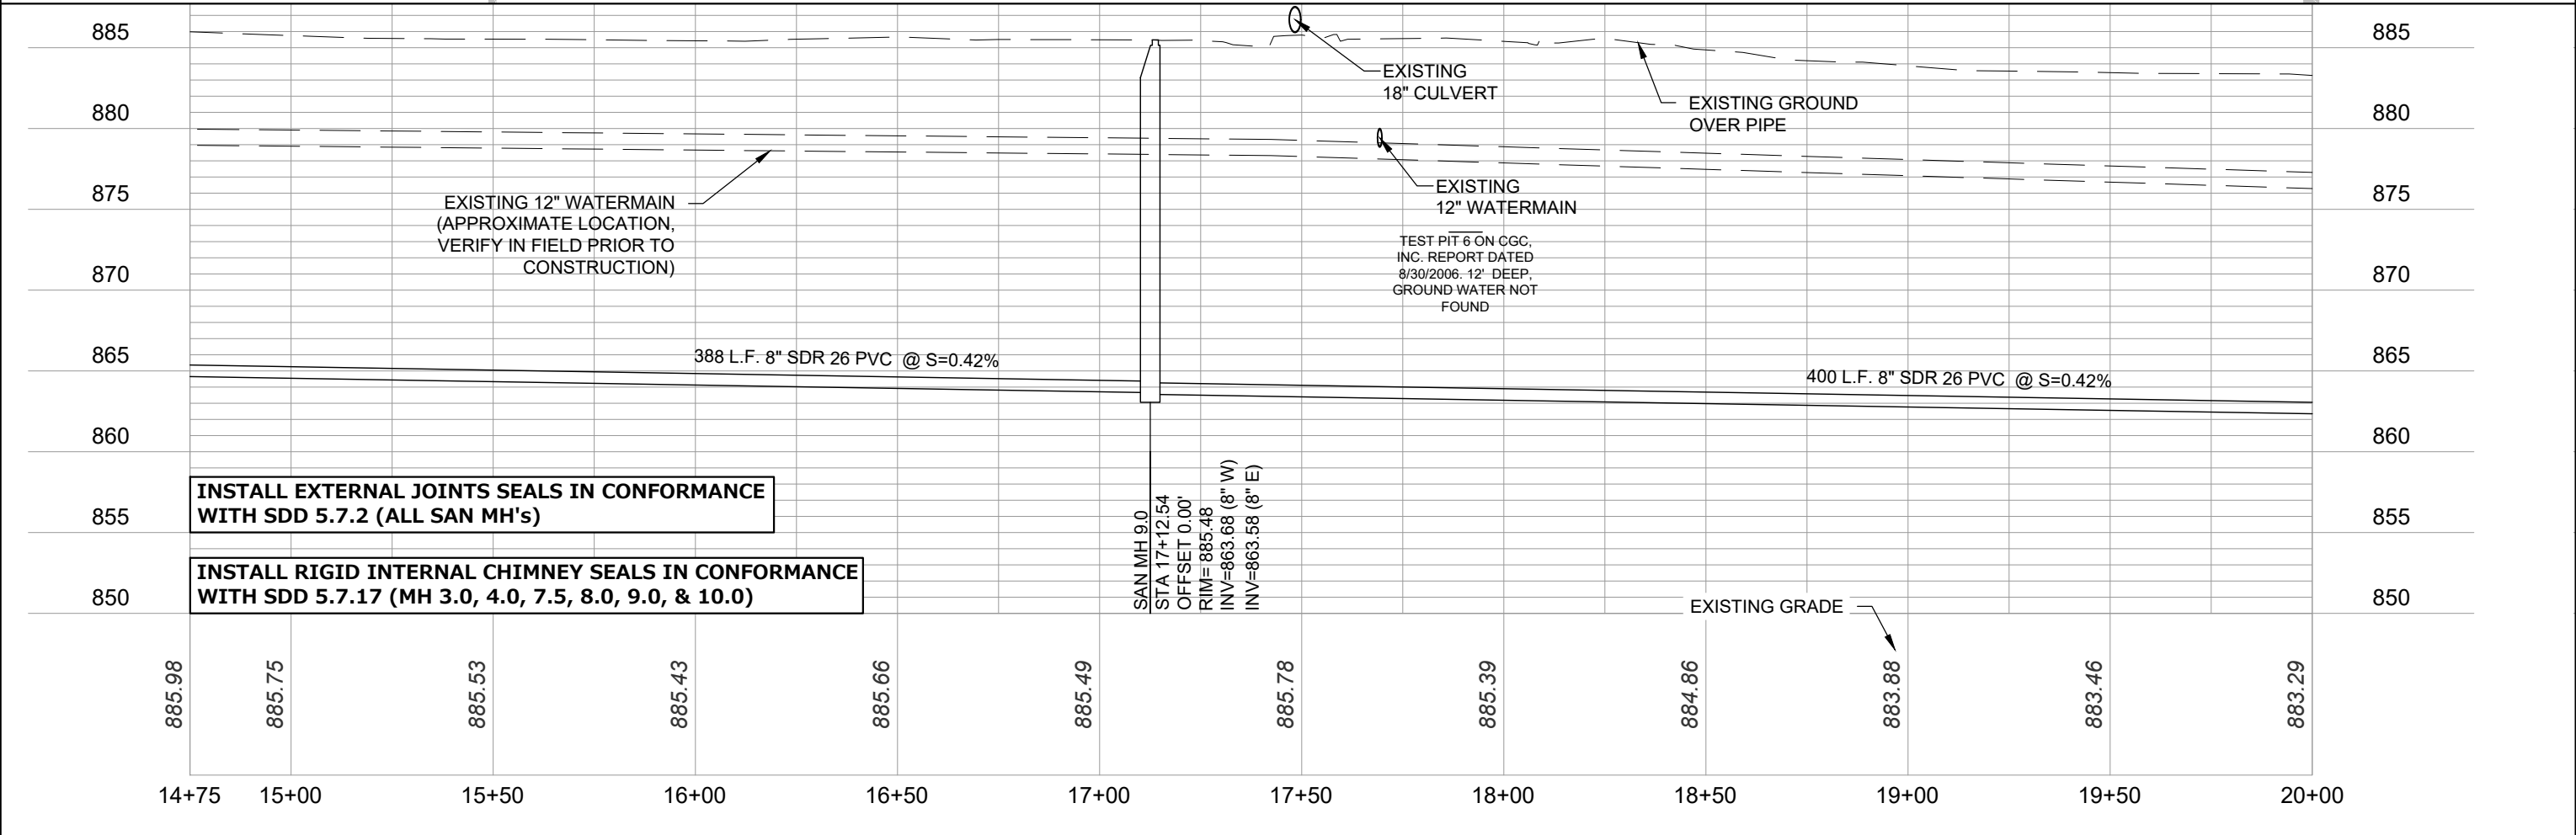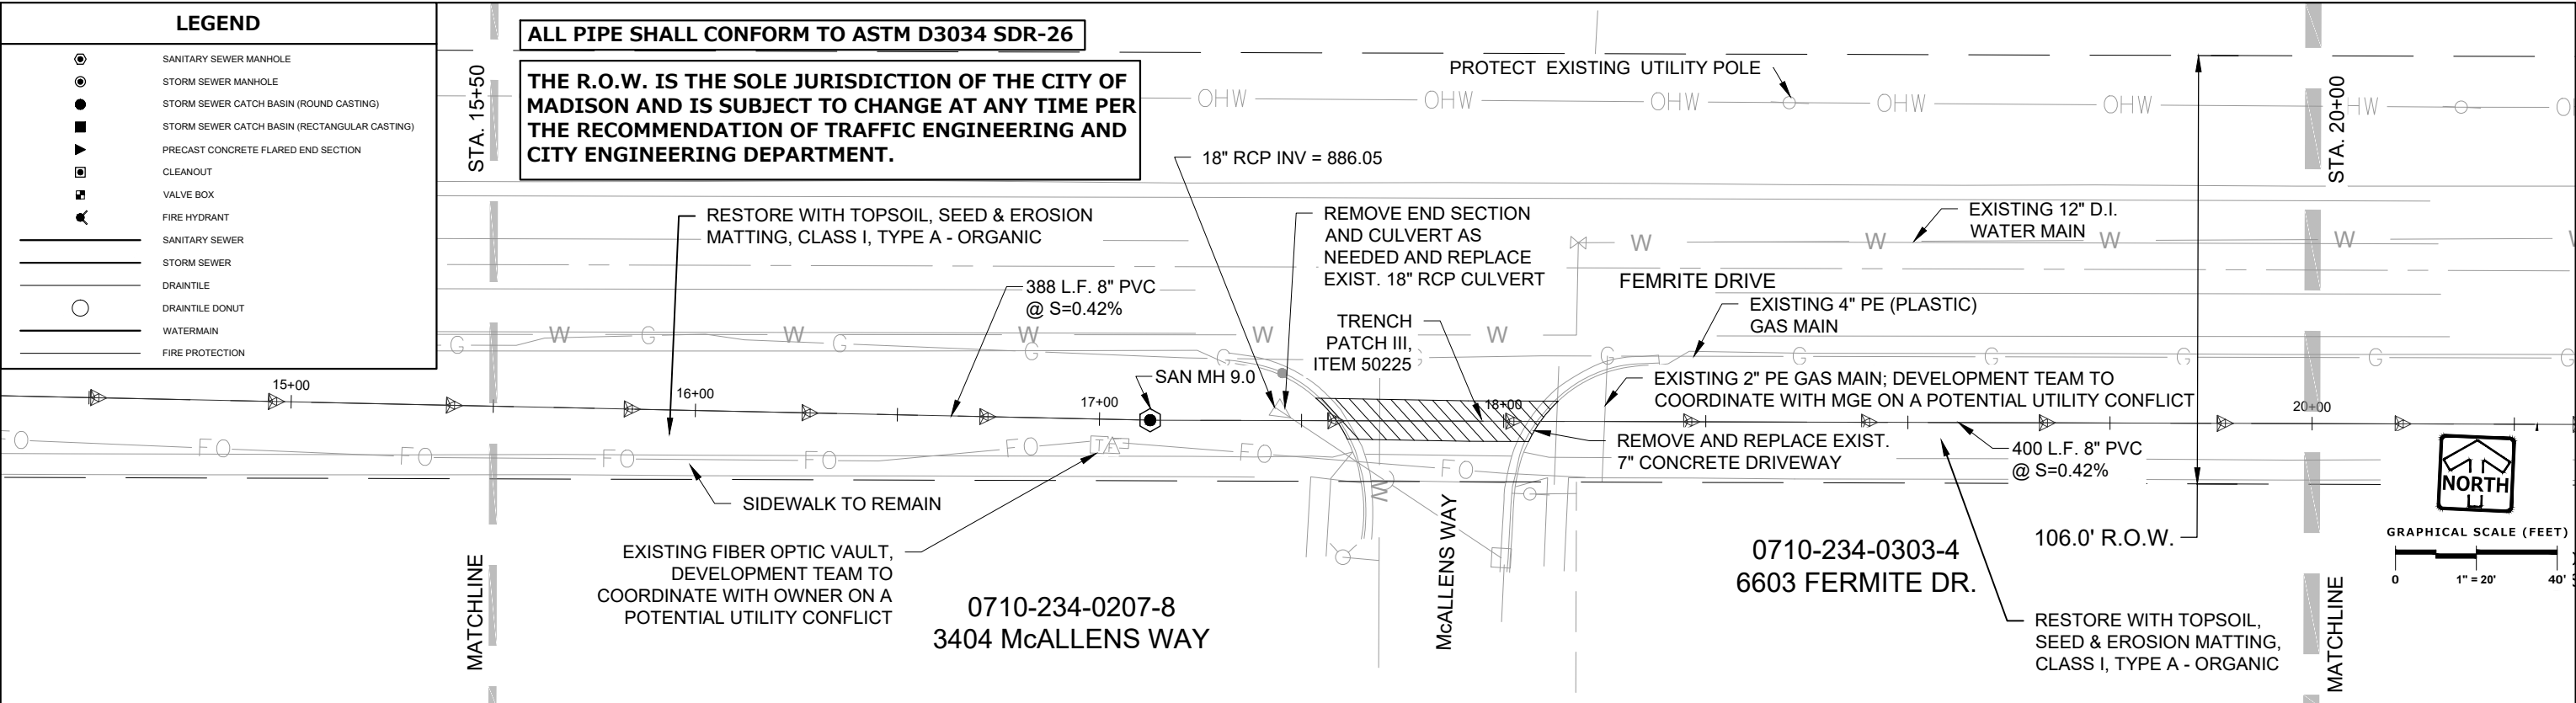



PINNACLE ENGINEERING GROUP
ENGINEERING | NATURAL RESOURCES | SURVEYING

PLAN | DESIGN | DELIVER
www.pinnacle-engr.com

WISCONSIN OFFICE:
20725 WATERTOWN ROAD, SUITE 100
BROOKFIELD, WI 53186
(262) 754-6888
CHICAGO | MILWAUKEE | NATIONWIDE

3030 OHMEDA DRIVE CSM

MADISON, WISCONSIN

UTILITY PLAN

REVISIONS

9	PER CITY COM/SAN SEWER	07/22/22	5	PER CITY COMMENTS	06/06/22
10	PER CITY COMMENTS	07/25/22	6	PER CITY COMMENTS	07/12/22
11	PER CITY COMMENTS	08/10/22	7	PER CITY COMMENTS	07/15/22
12	PER CITY COMMENTS	09/21/22	8	PER CITY COM/SAN SEWER	07/21/22

REG JOB No. 1933.00

REG PM AREA

START DATE 08/05/20



SCALE 1" = 40'

SHEET C-17 C-29

© COPYRIGHT 2018

THESE PLANS AND DESIGNS ARE COPYRIGHT PROTECTED AND MAY NOT BE USED IN WHOLE OR IN PART WITHOUT THE WRITTEN CONSENT OF PINNACLE ENGINEERING GROUP, LLC

DRAFTED: MRG
DESIGNED: TOM
REVIEWED: TOM

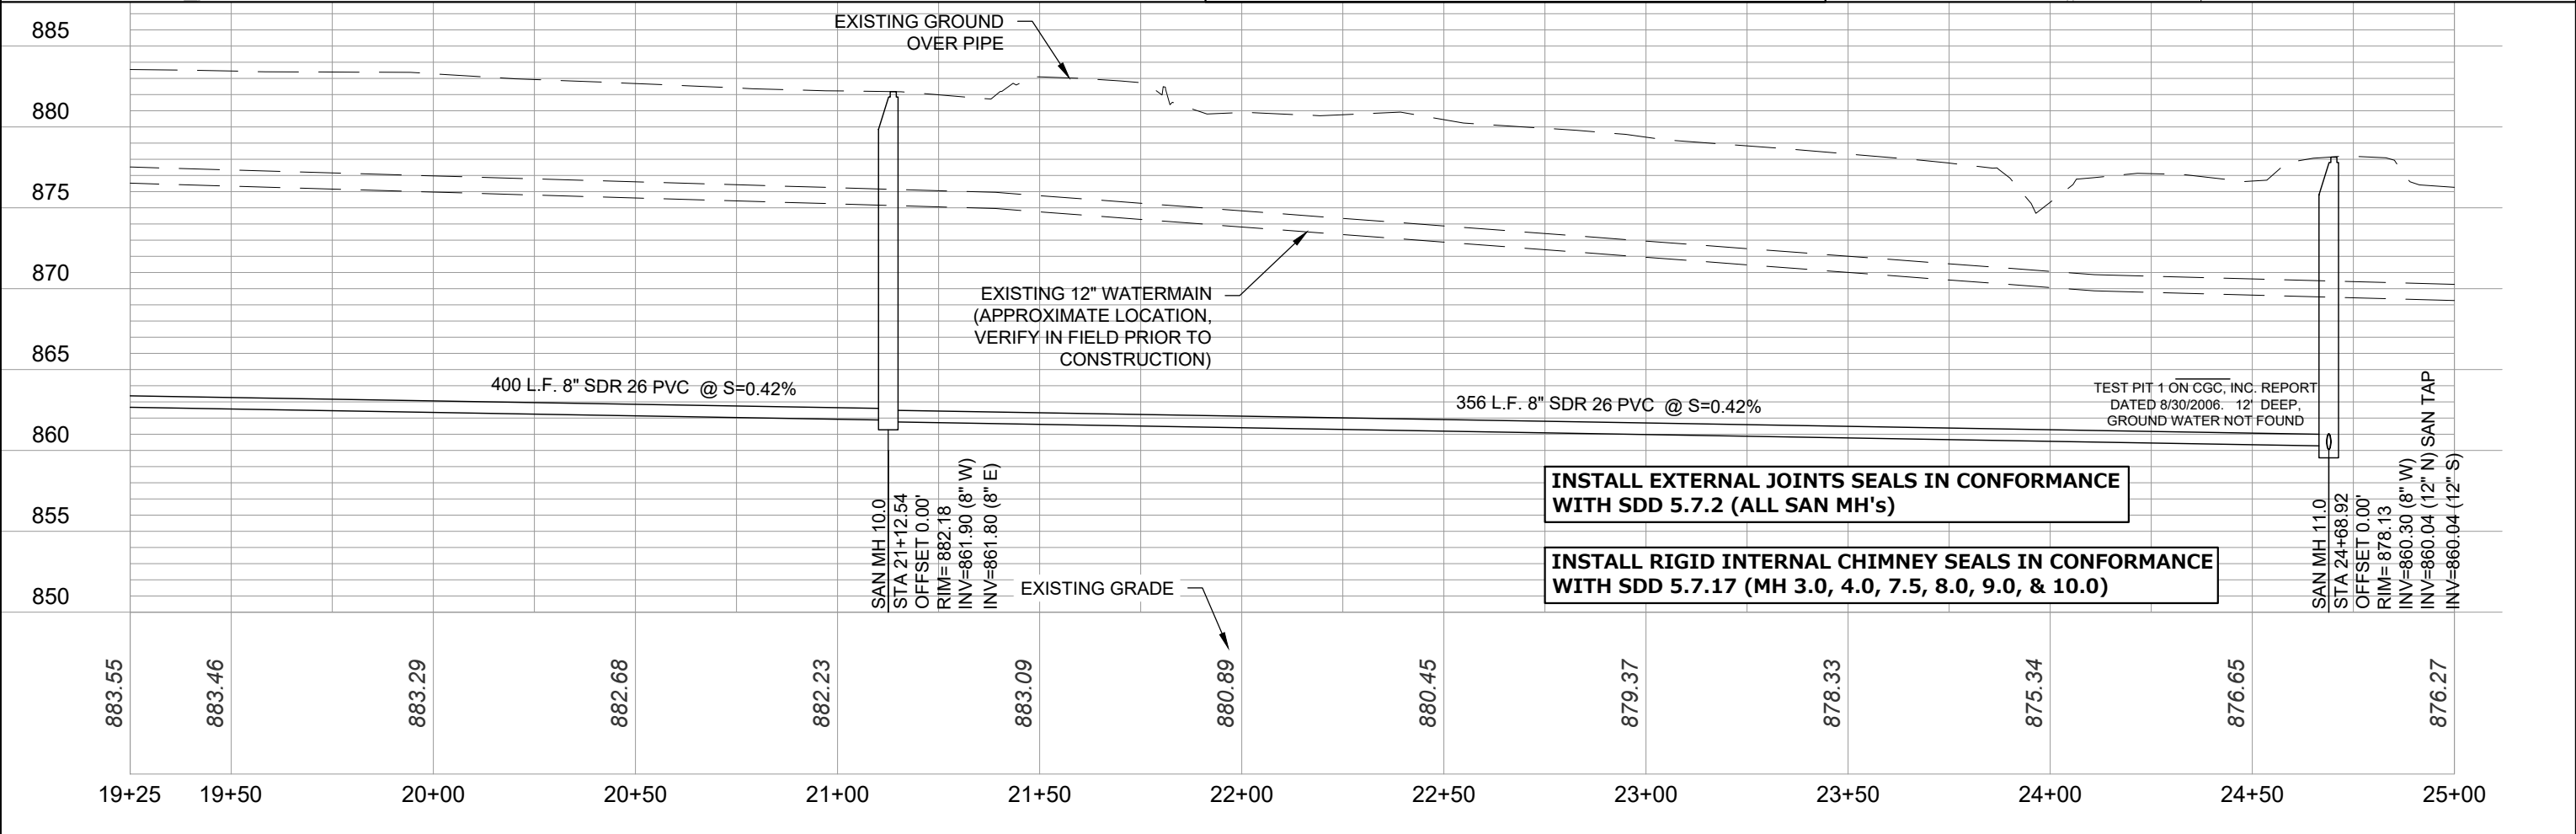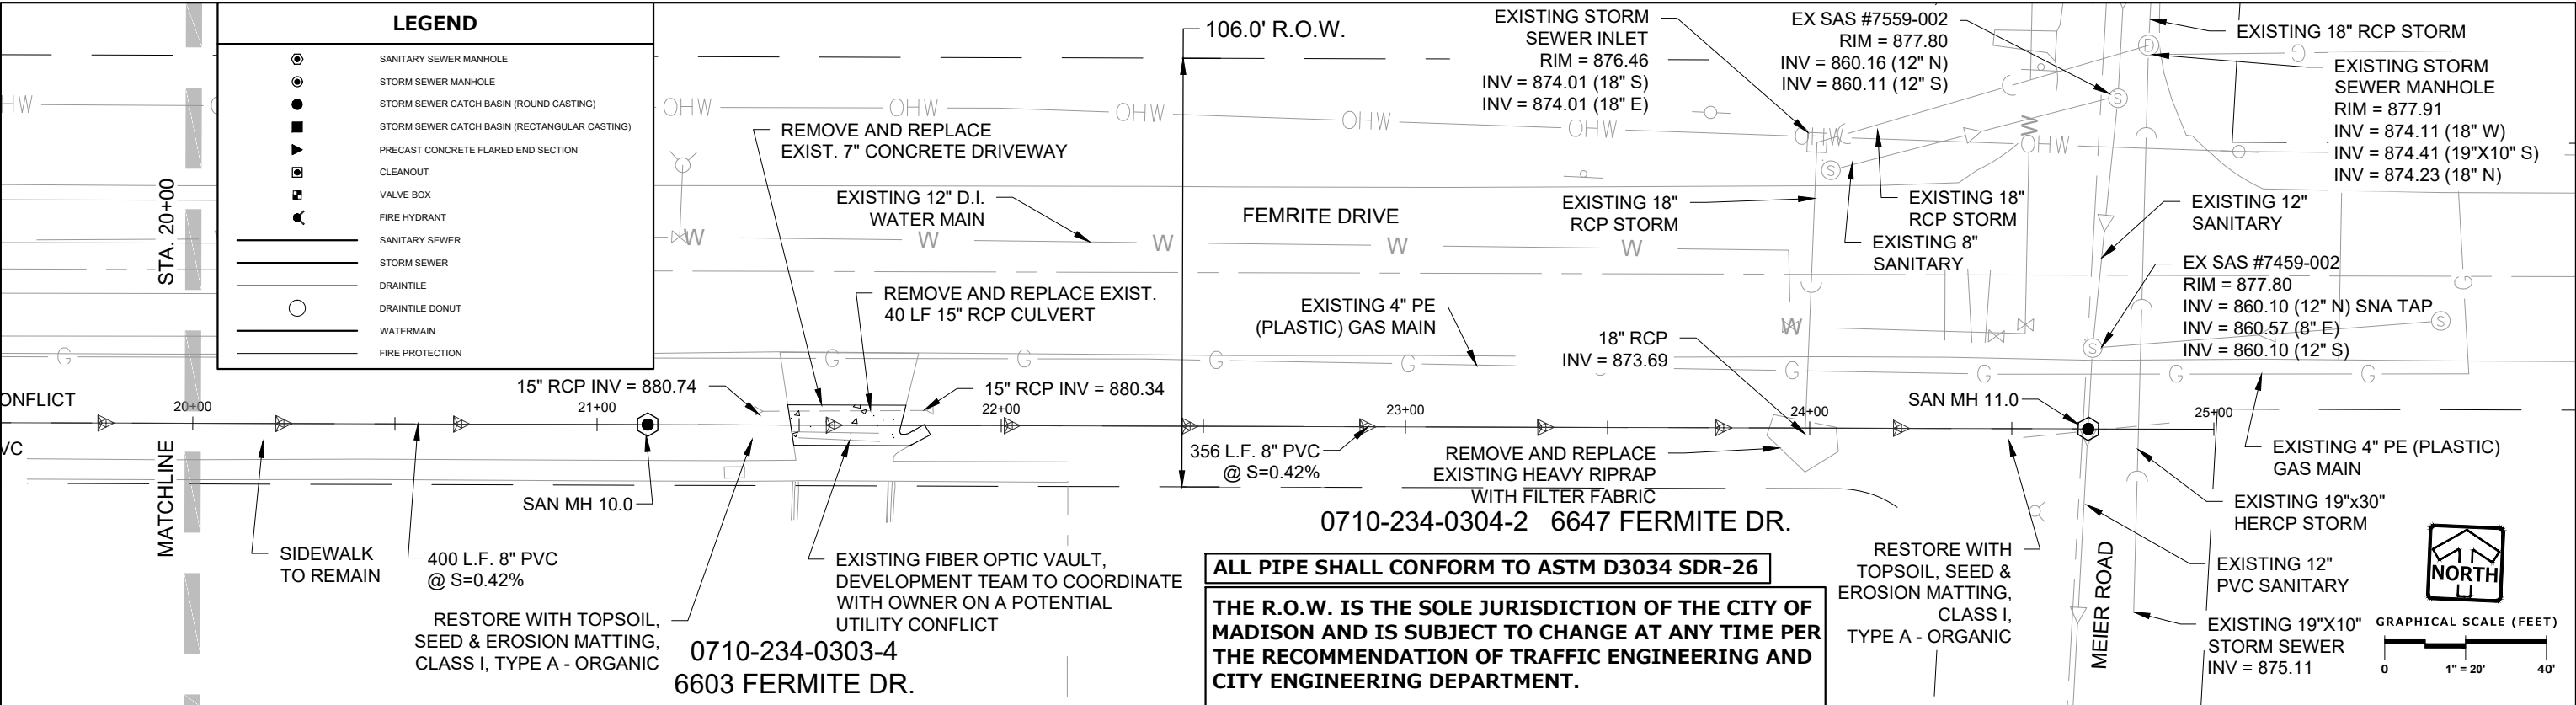



PINNACLE ENGINEERING GROUP
ENGINEERING | NATURAL RESOURCES | SURVEYING

PLAN | DESIGN | DELIVER
www.pinnacle-engr.com

WISCONSIN OFFICE:
20725 WATERTOWN ROAD, SUITE 100
BROOKFIELD, WI 53186
(262) 754-6886

CHICAGO | MILWAUKEE | NATIONWIDE

3030 OHMEDA DRIVE CSM

MADISON, WISCONSIN

UTILITY PLAN

REVISIONS

9	PER CITY COM/SAN SEWER	07/22/22	5	PER CITY COMMENTS	06/06/22
10	PER CITY COMMENTS	07/25/22	6	PER CITY COMMENTS	07/12/22
11	PER CITY COMMENTS	08/10/22	7	PER CITY COMMENTS	07/15/22
12	PER CITY COMMENTS	09/21/22	8	PER CITY COM/SAN SEWER	07/21/22

PEG JOB No. 1933.00

PEG PM AREA

START DATE 08/05/20

SCALE 1" = 40'

SHEET **C-18**
C-29

© COPYRIGHT 2019