


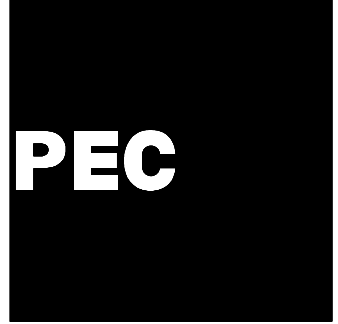


POWER ENGINEERS
COLLABORATIVE LLC
150 Sunny Slope Road
Suite 110
Brookfield, Wisconsin 53005
WWW.PECLLC.COM



PLT Project No:
2009.07.00

State of Wisconsin
Department of Administration
Division of State Facilities

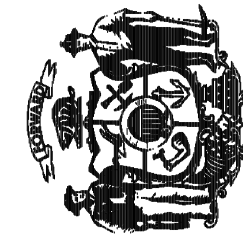

Agency/Institution:
UNIVERSITY OF WISCONSIN SYSTEM


**CHARTER STREET HEATING
PLANT REBUILD**
MADISON, WI
GDP SITE REFERENCE PLAN

Project Title:
Project Location:
Sheet Title:

Revisions:

No.	Date:	By:	Description:


Graphic Scale	
DSF Number	09A2L
Set Type	PR
Date Issued	03-10-10
Sheet Number	A100

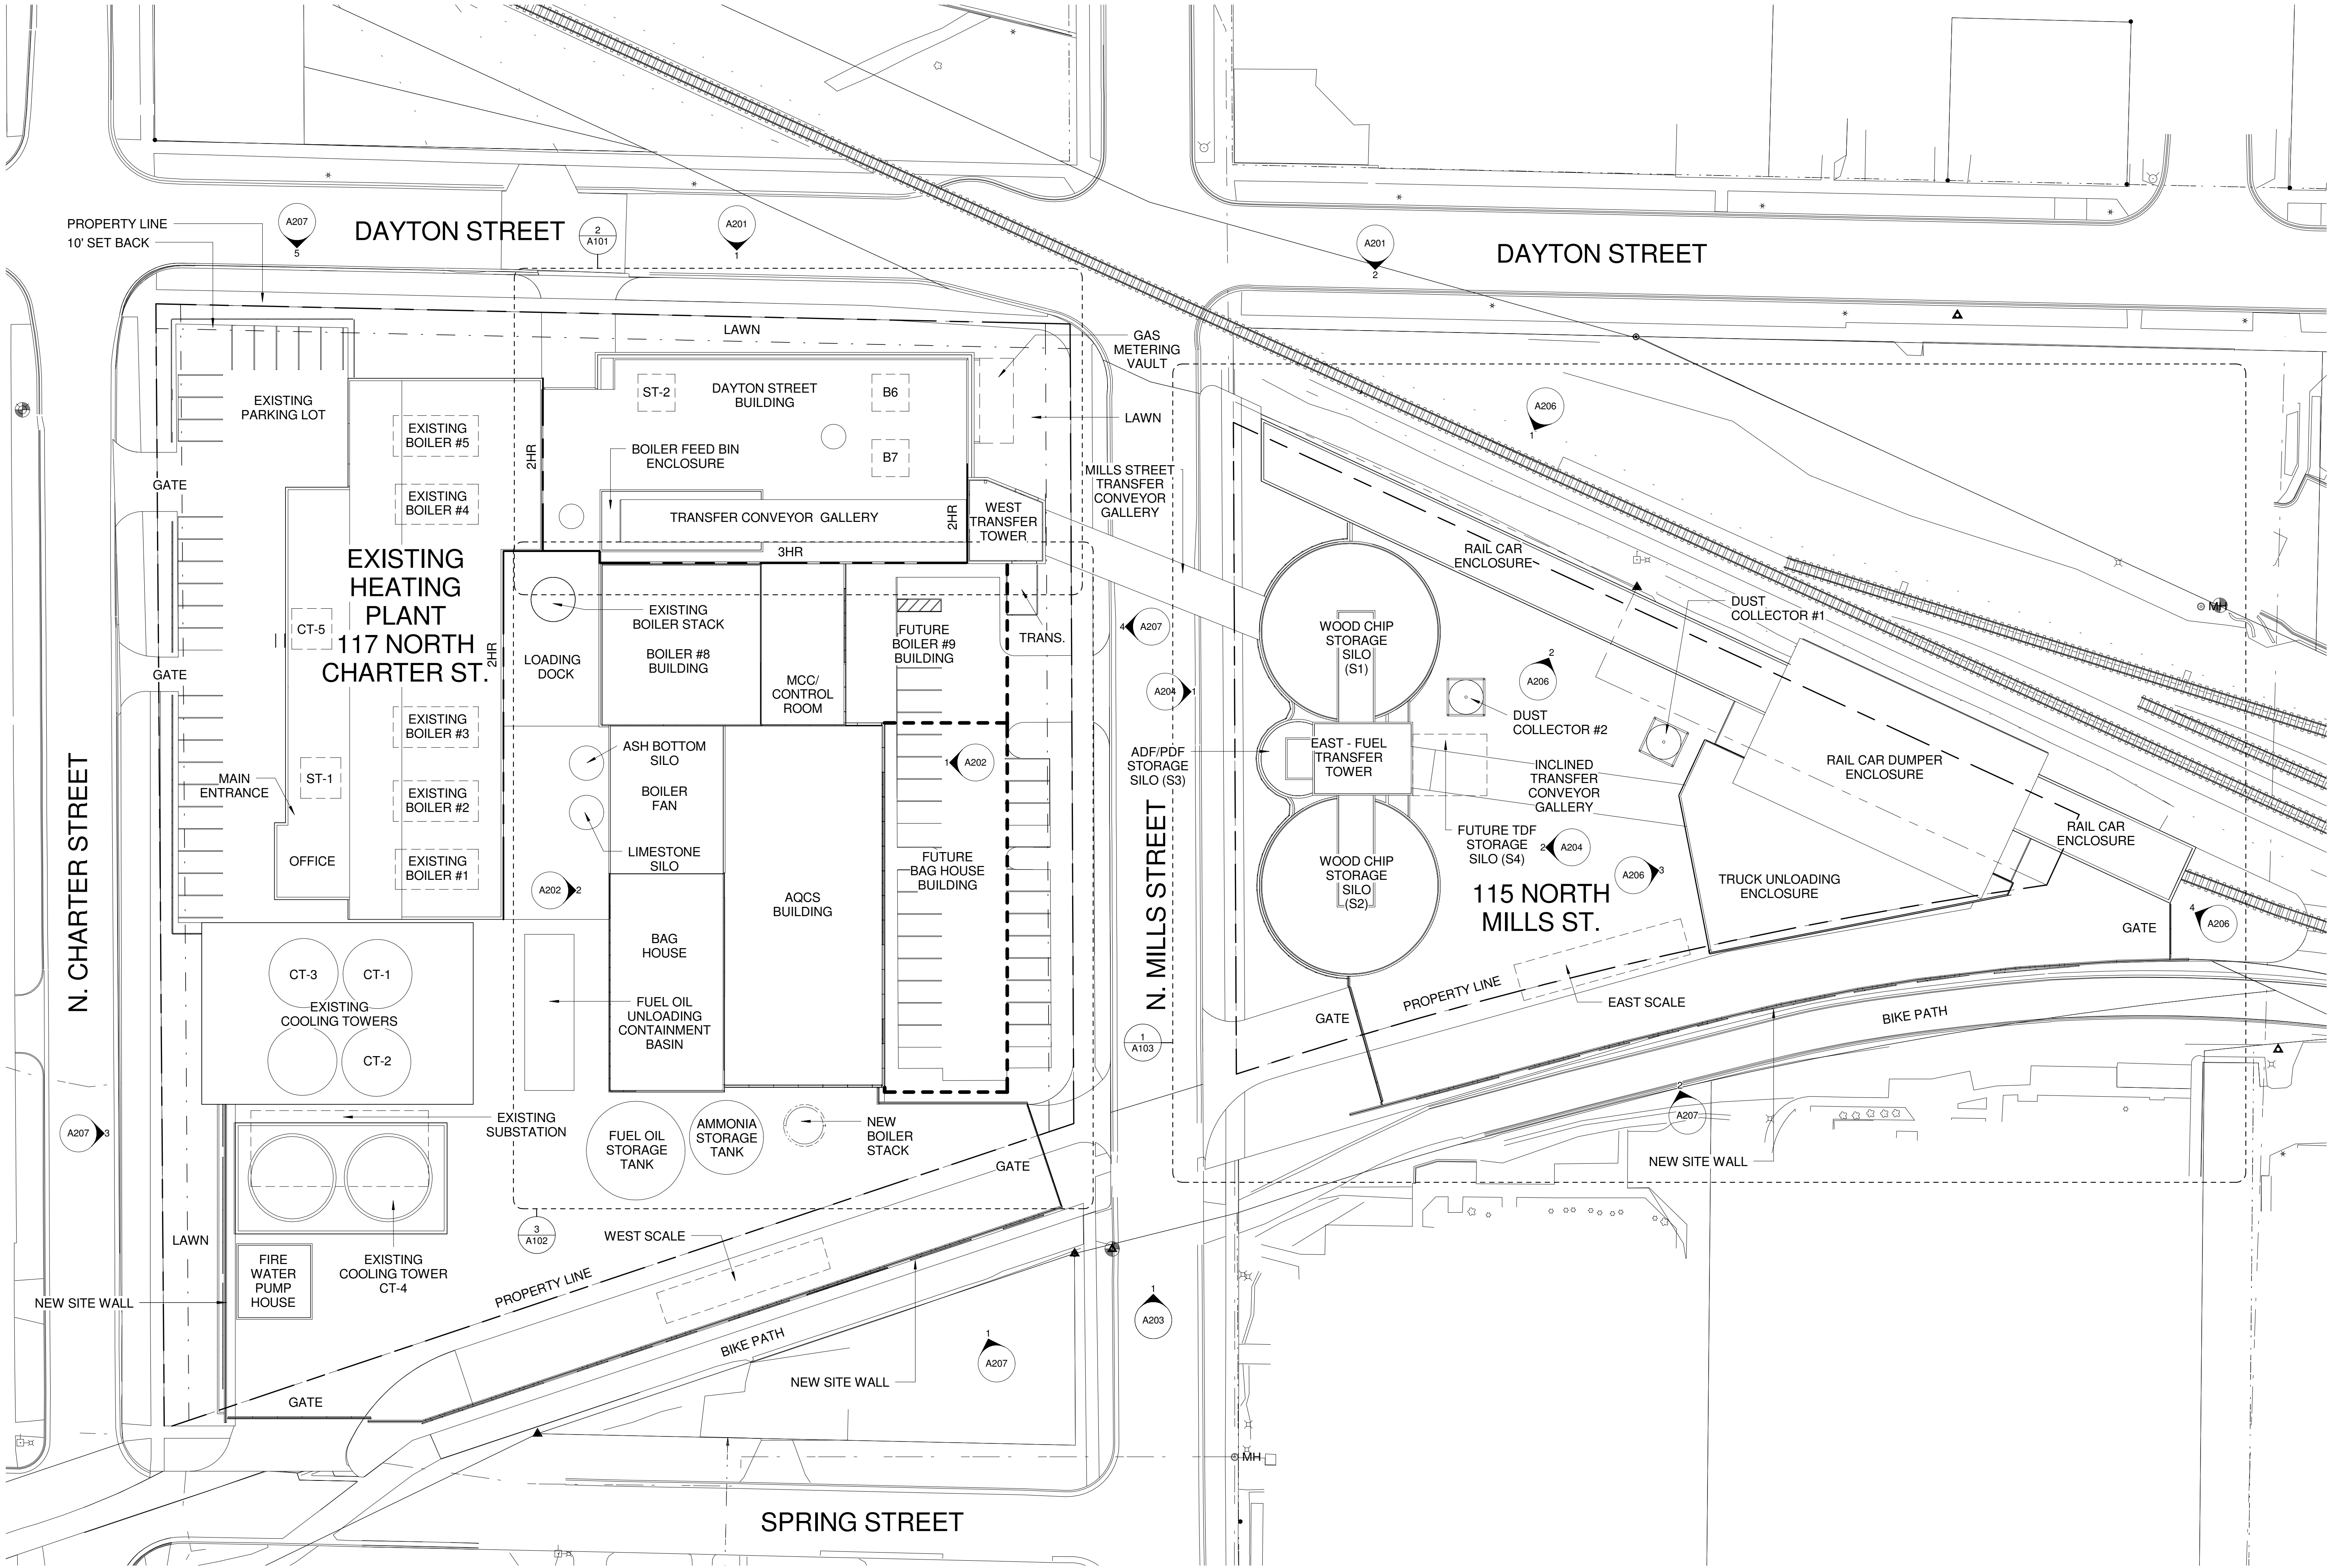


1
A100

SITE REFERENCE PLAN - ARCHITECTURAL
1" = 30'-0"




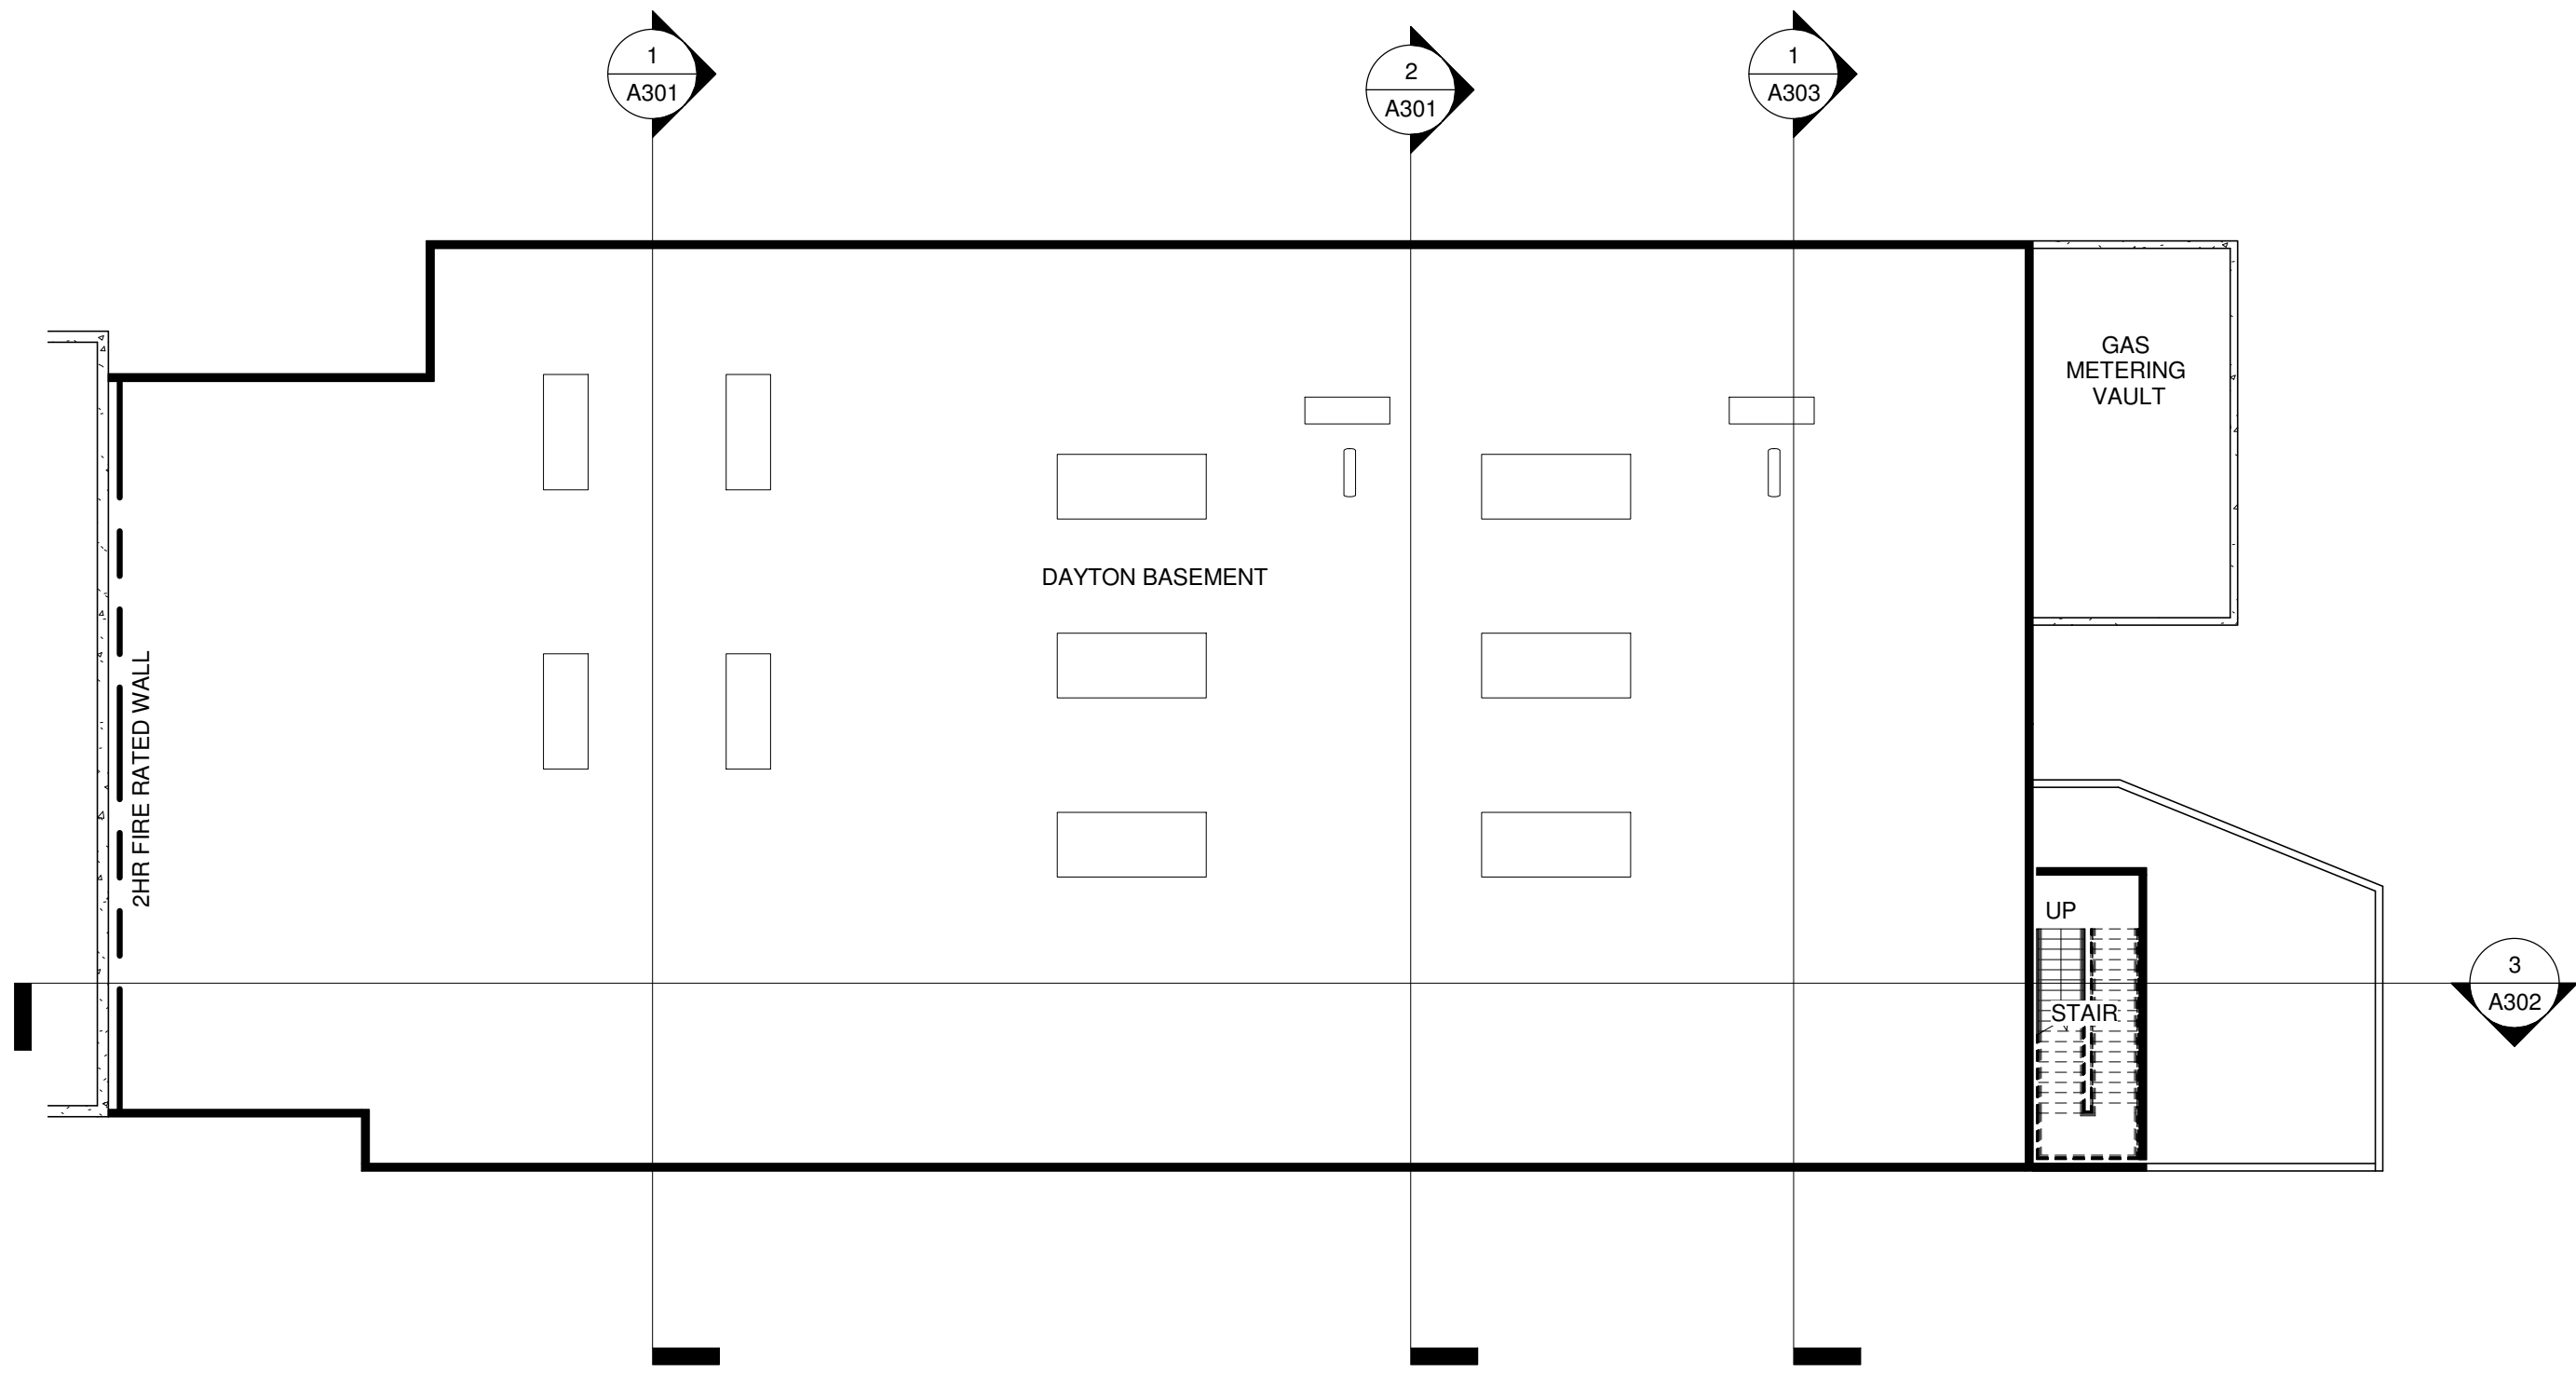

1 DAYTON STREET BUILDING BASEMENT PLAN
A101 1/16" = 1'-0" NORTH

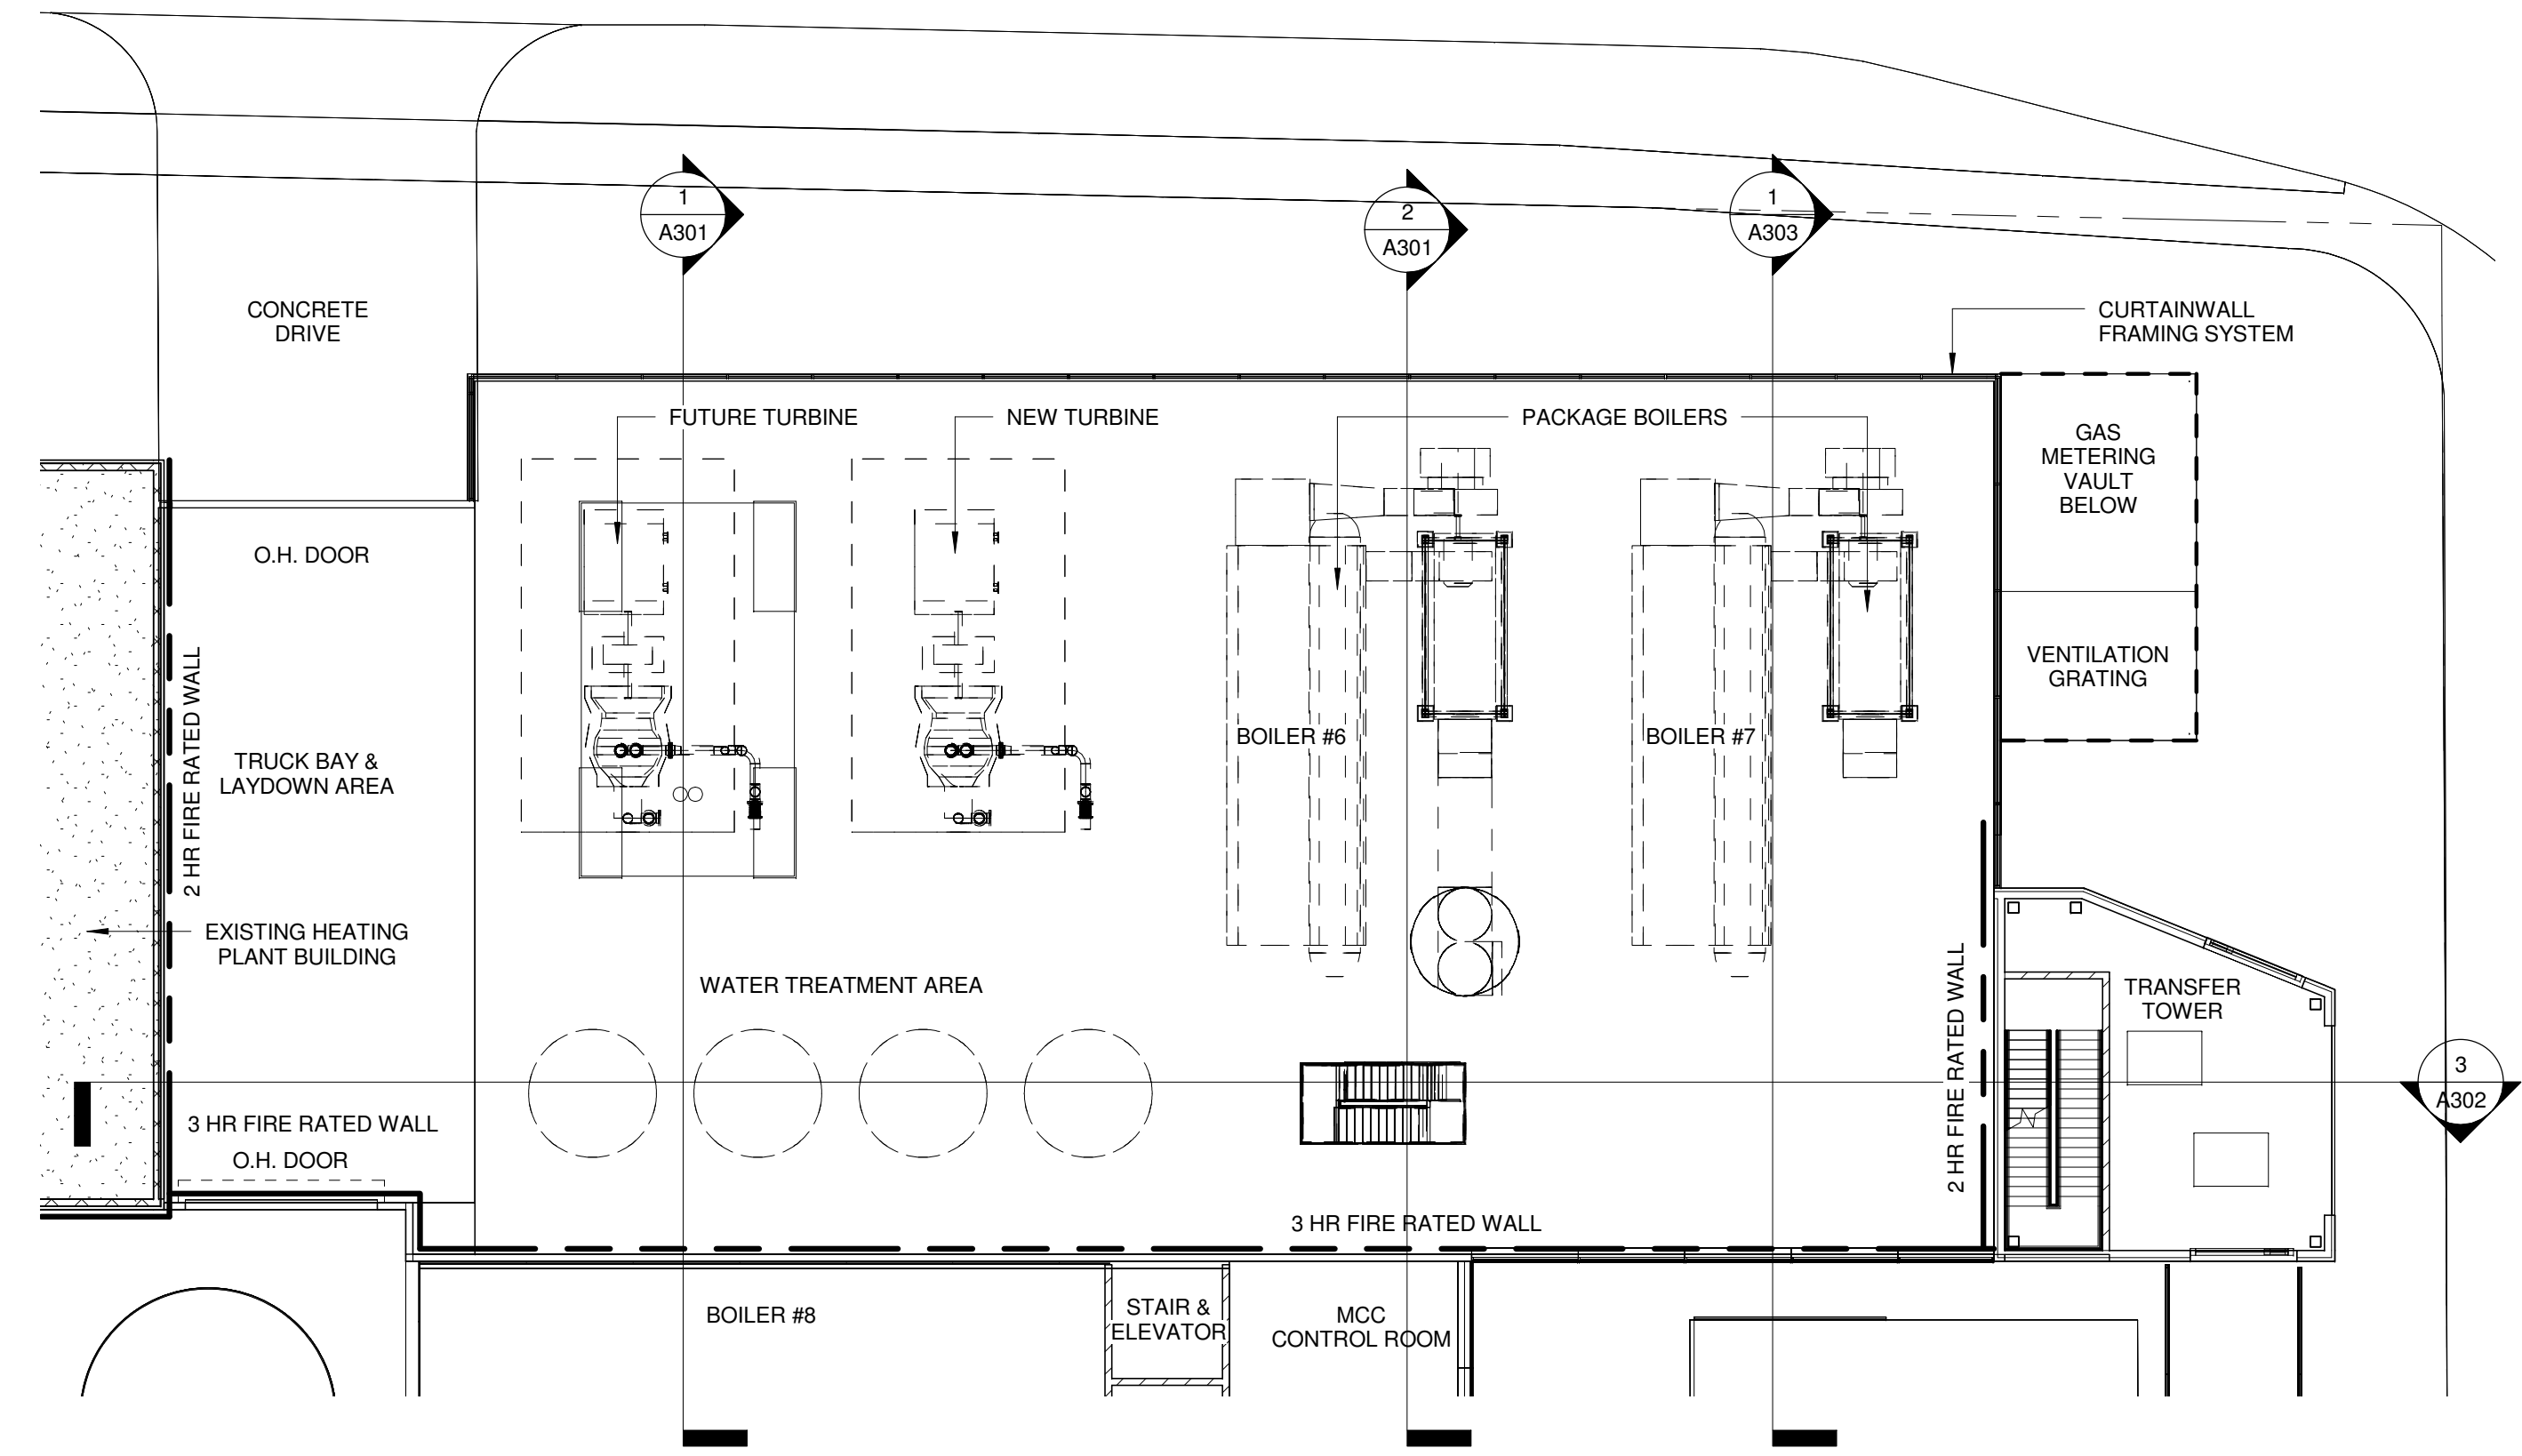

2 DAYTON STREET BUILDING - FIRST FLOOR PLAN
A101 1/16" = 1'-0" NORTH

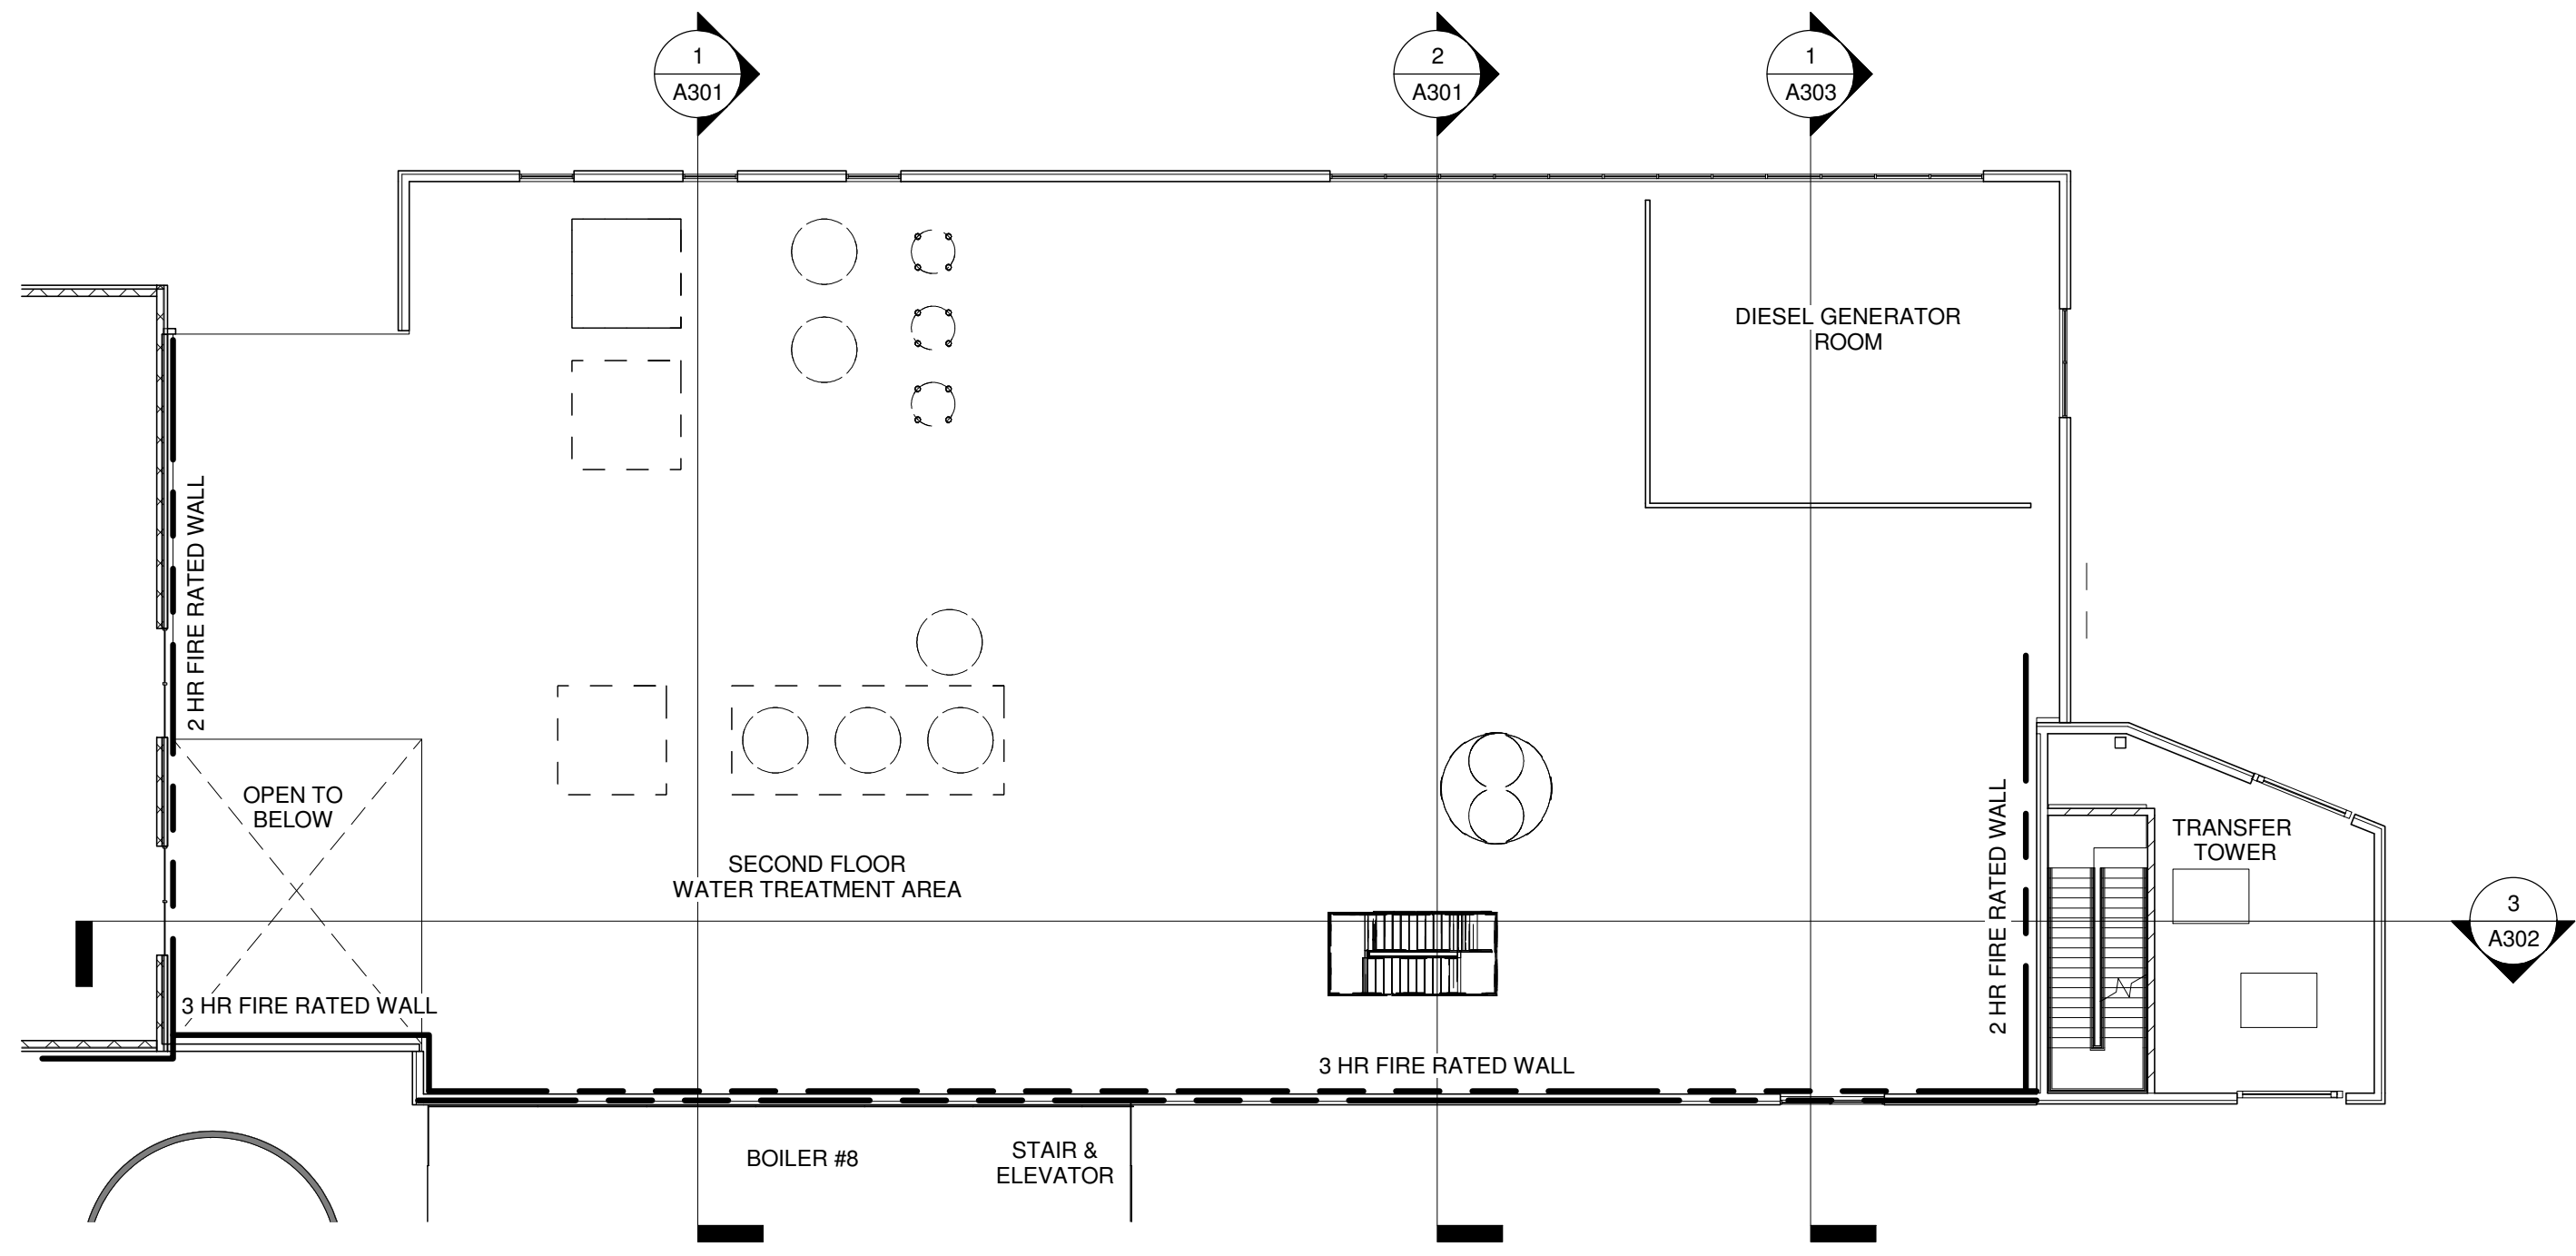

3 DAYTON STREET BUILDING SECOND FLOOR PLAN
A101 1/16" = 1'-0" NORTH

PLT Project No:
2009.07.00

State of Wisconsin
Department of Administration
Division of State Facilities

Agency / Institution:
UNIVERSITY OF WISCONSIN SYSTEM



**CHARTER STREET HEATING
PLANT REBUILD**
MADISON, WI

Project Title:
GDP FLOOR PLANS - DAYTON STREET BUILDING
BASEMENT, FIRST AND OPERATING FLOOR PLANS


Revisions:			
No.	Date:	By:	Description:

Graphic Scale	
DSF Number	09A2L
Set Type	PR
Date Issued	03-10-10
Sheet Number	A101


aphic ale	
F mber	09A2L
t ce	PR
te ued	03-10-10
reet mber	A102

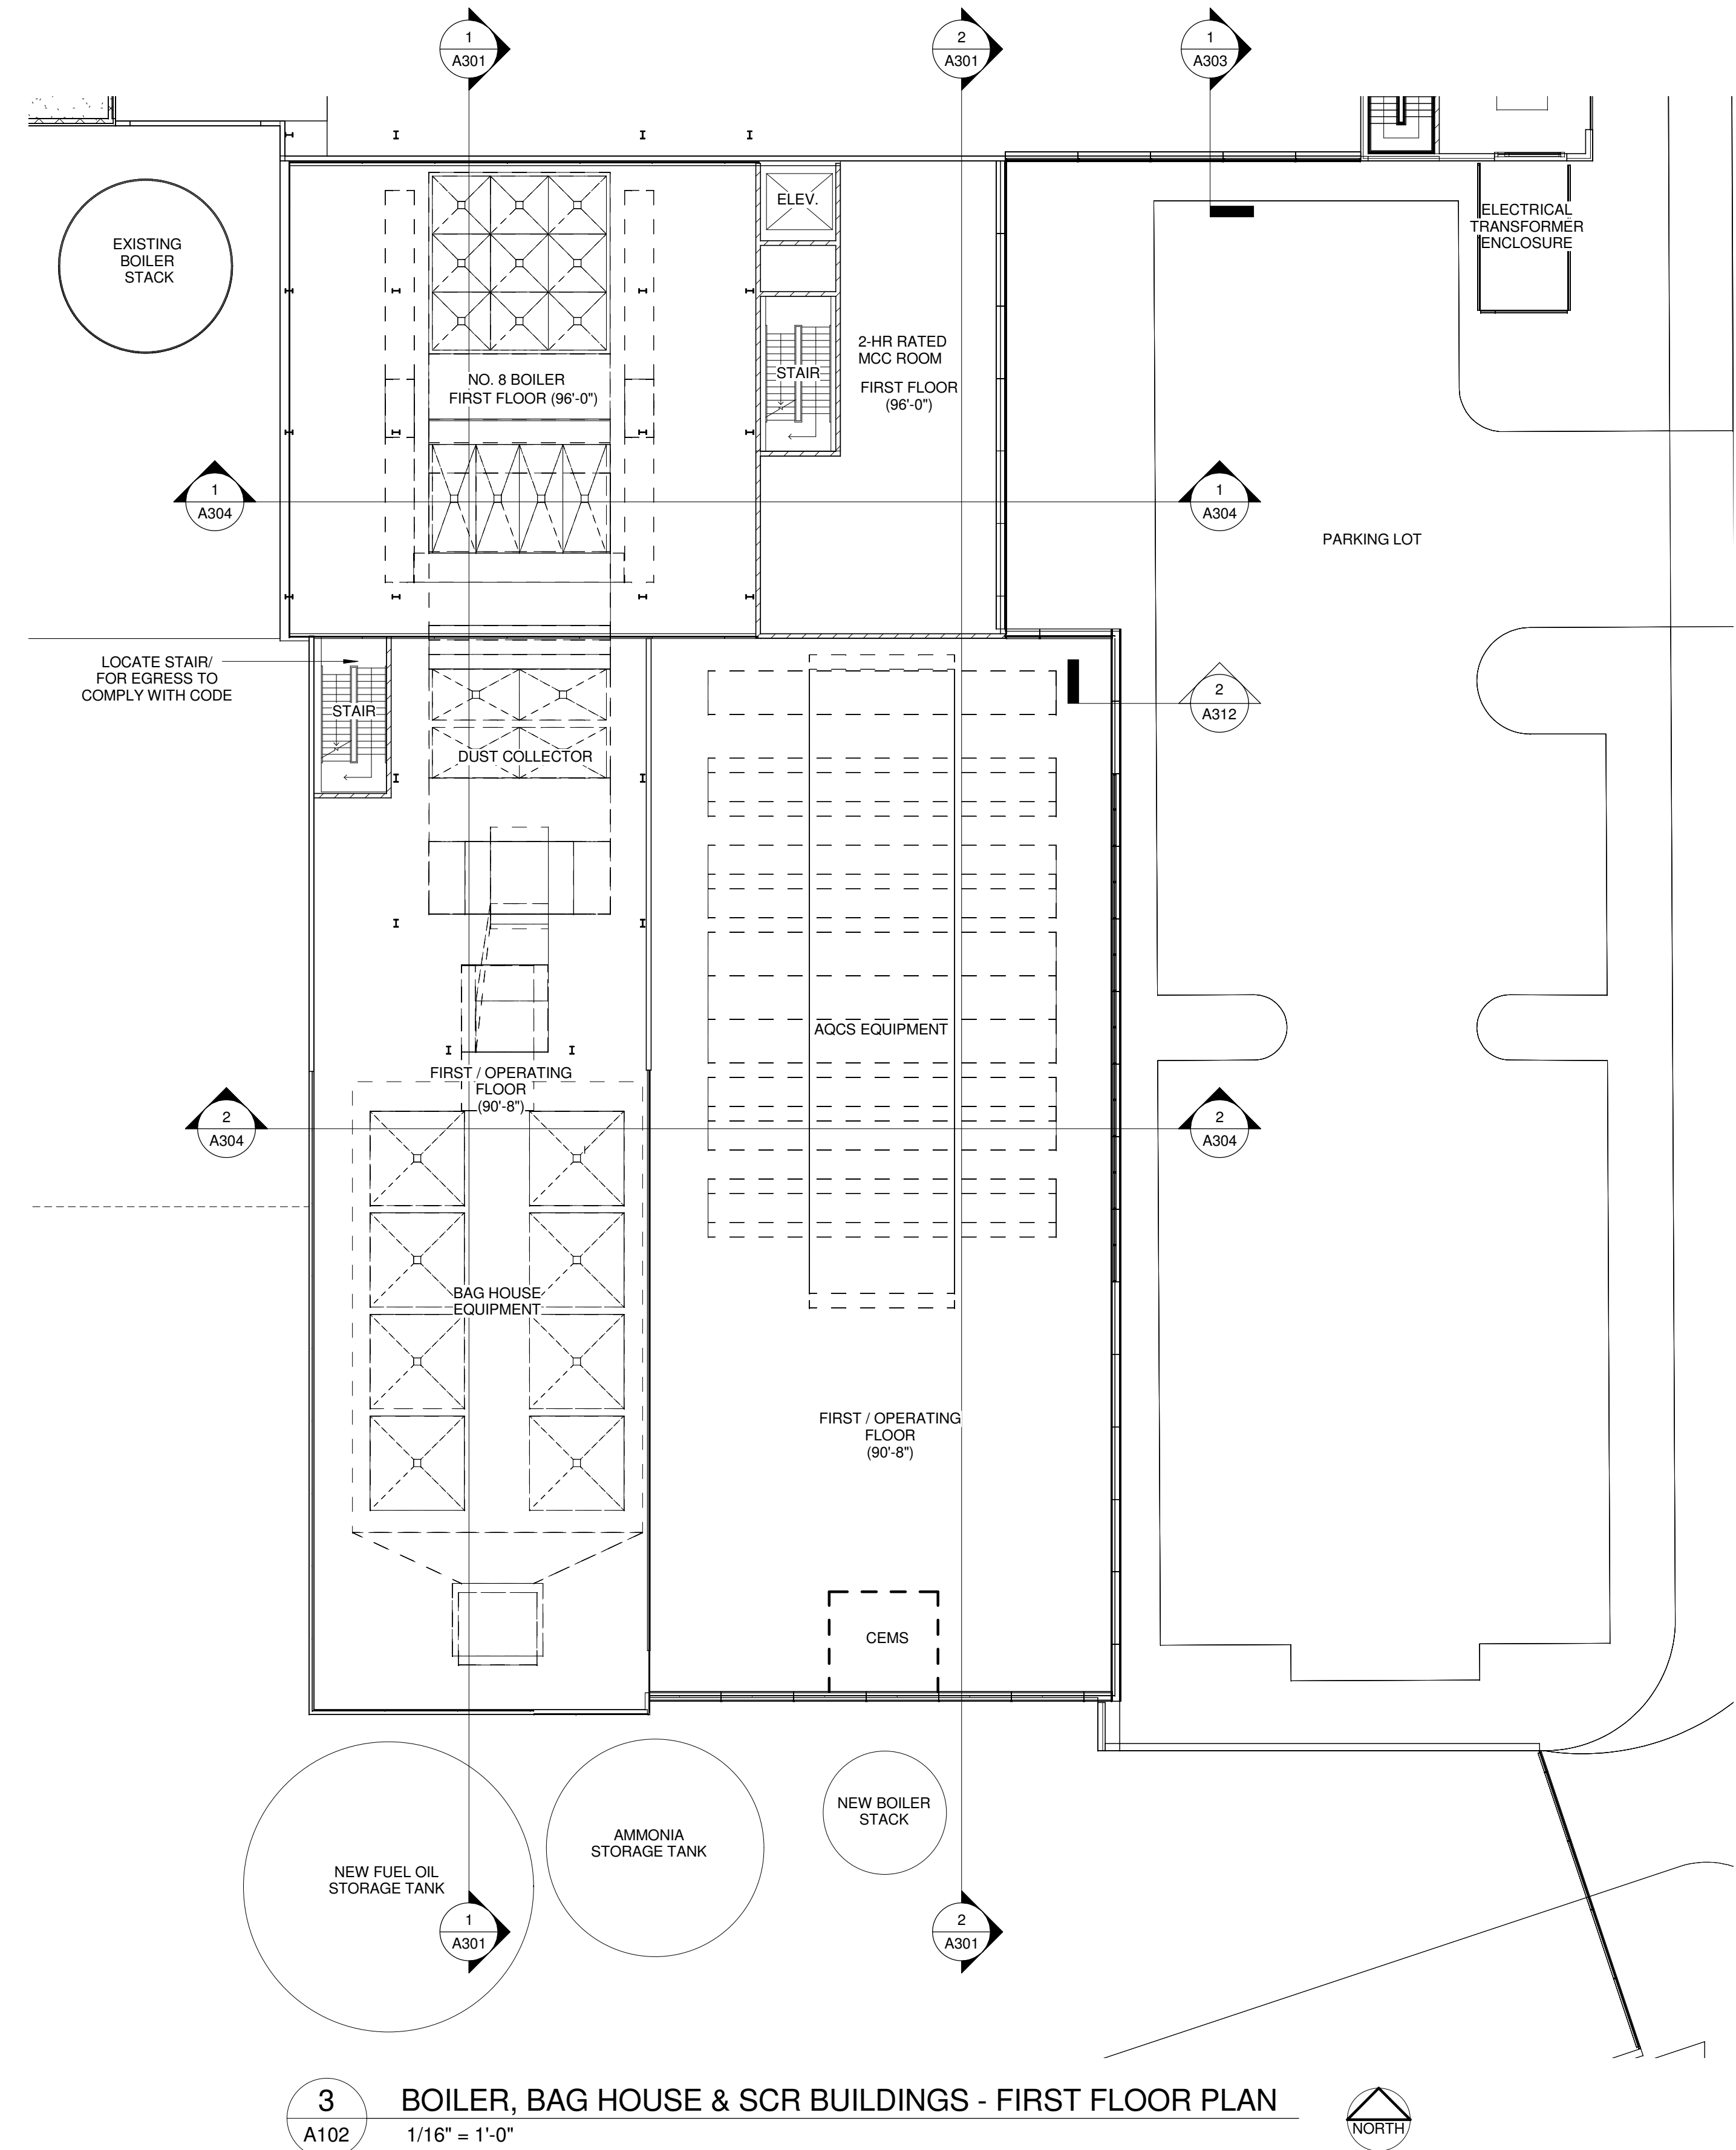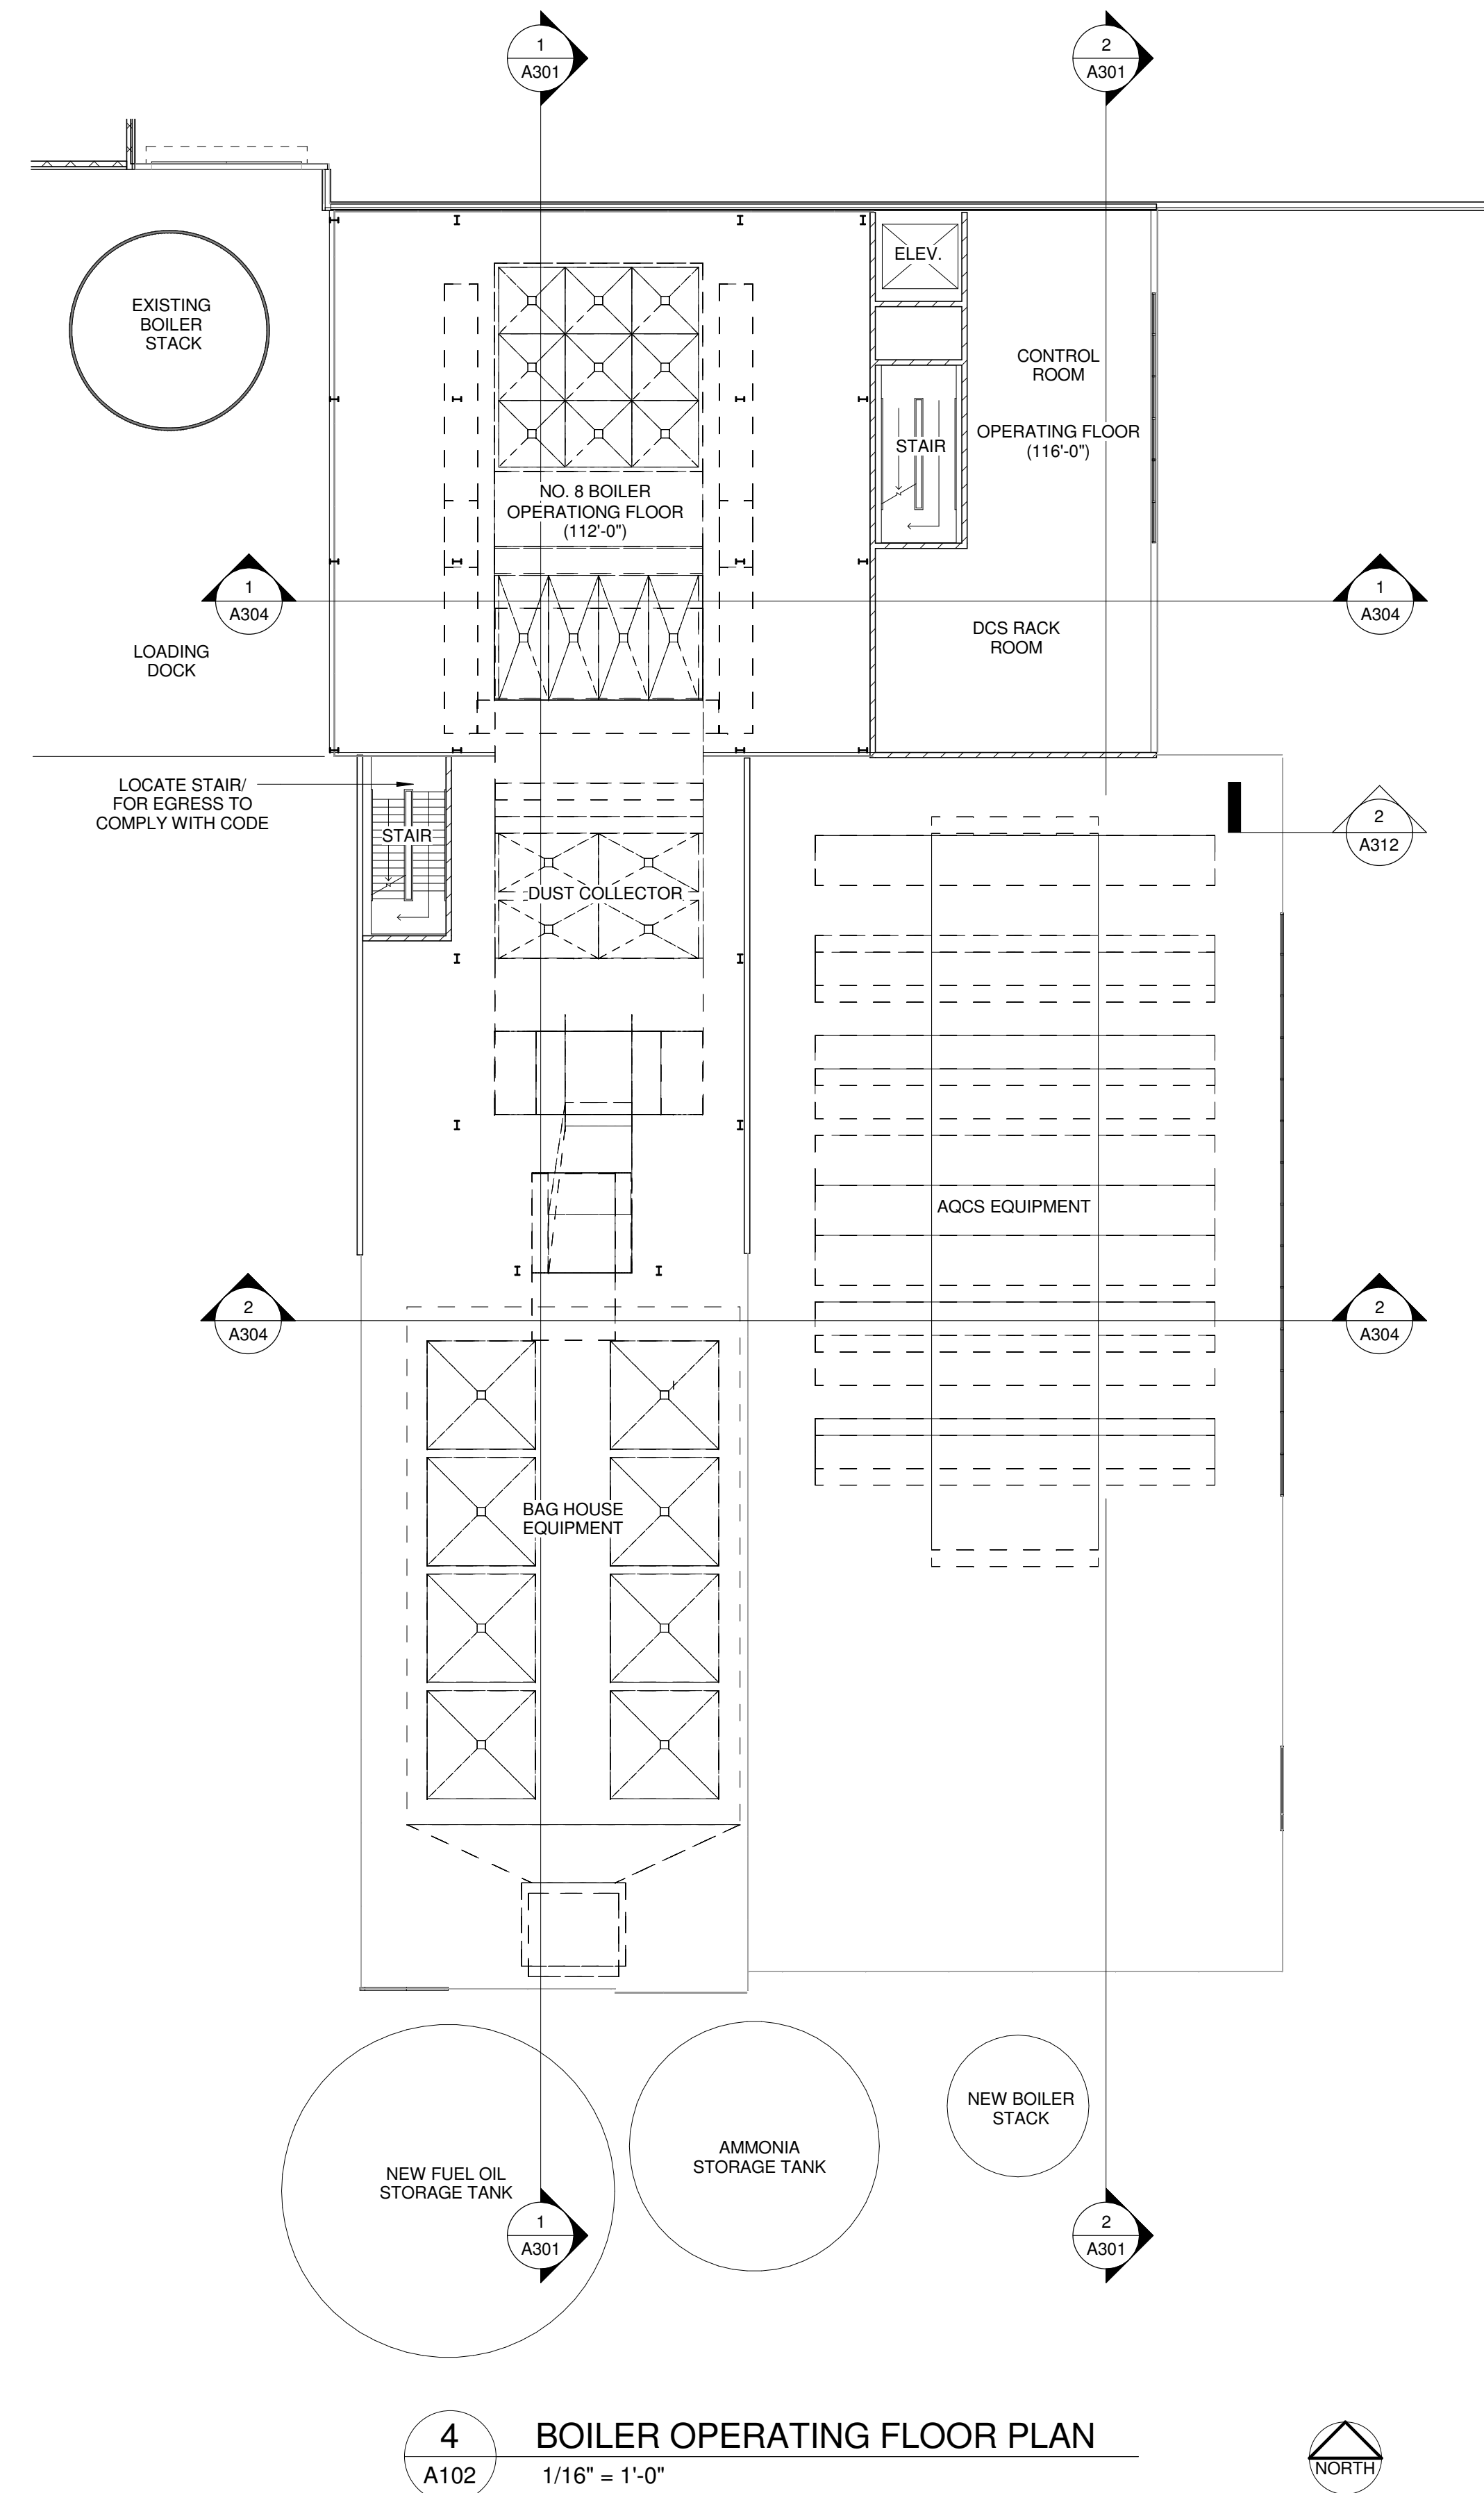

3/9/2010 11:11:55 AM

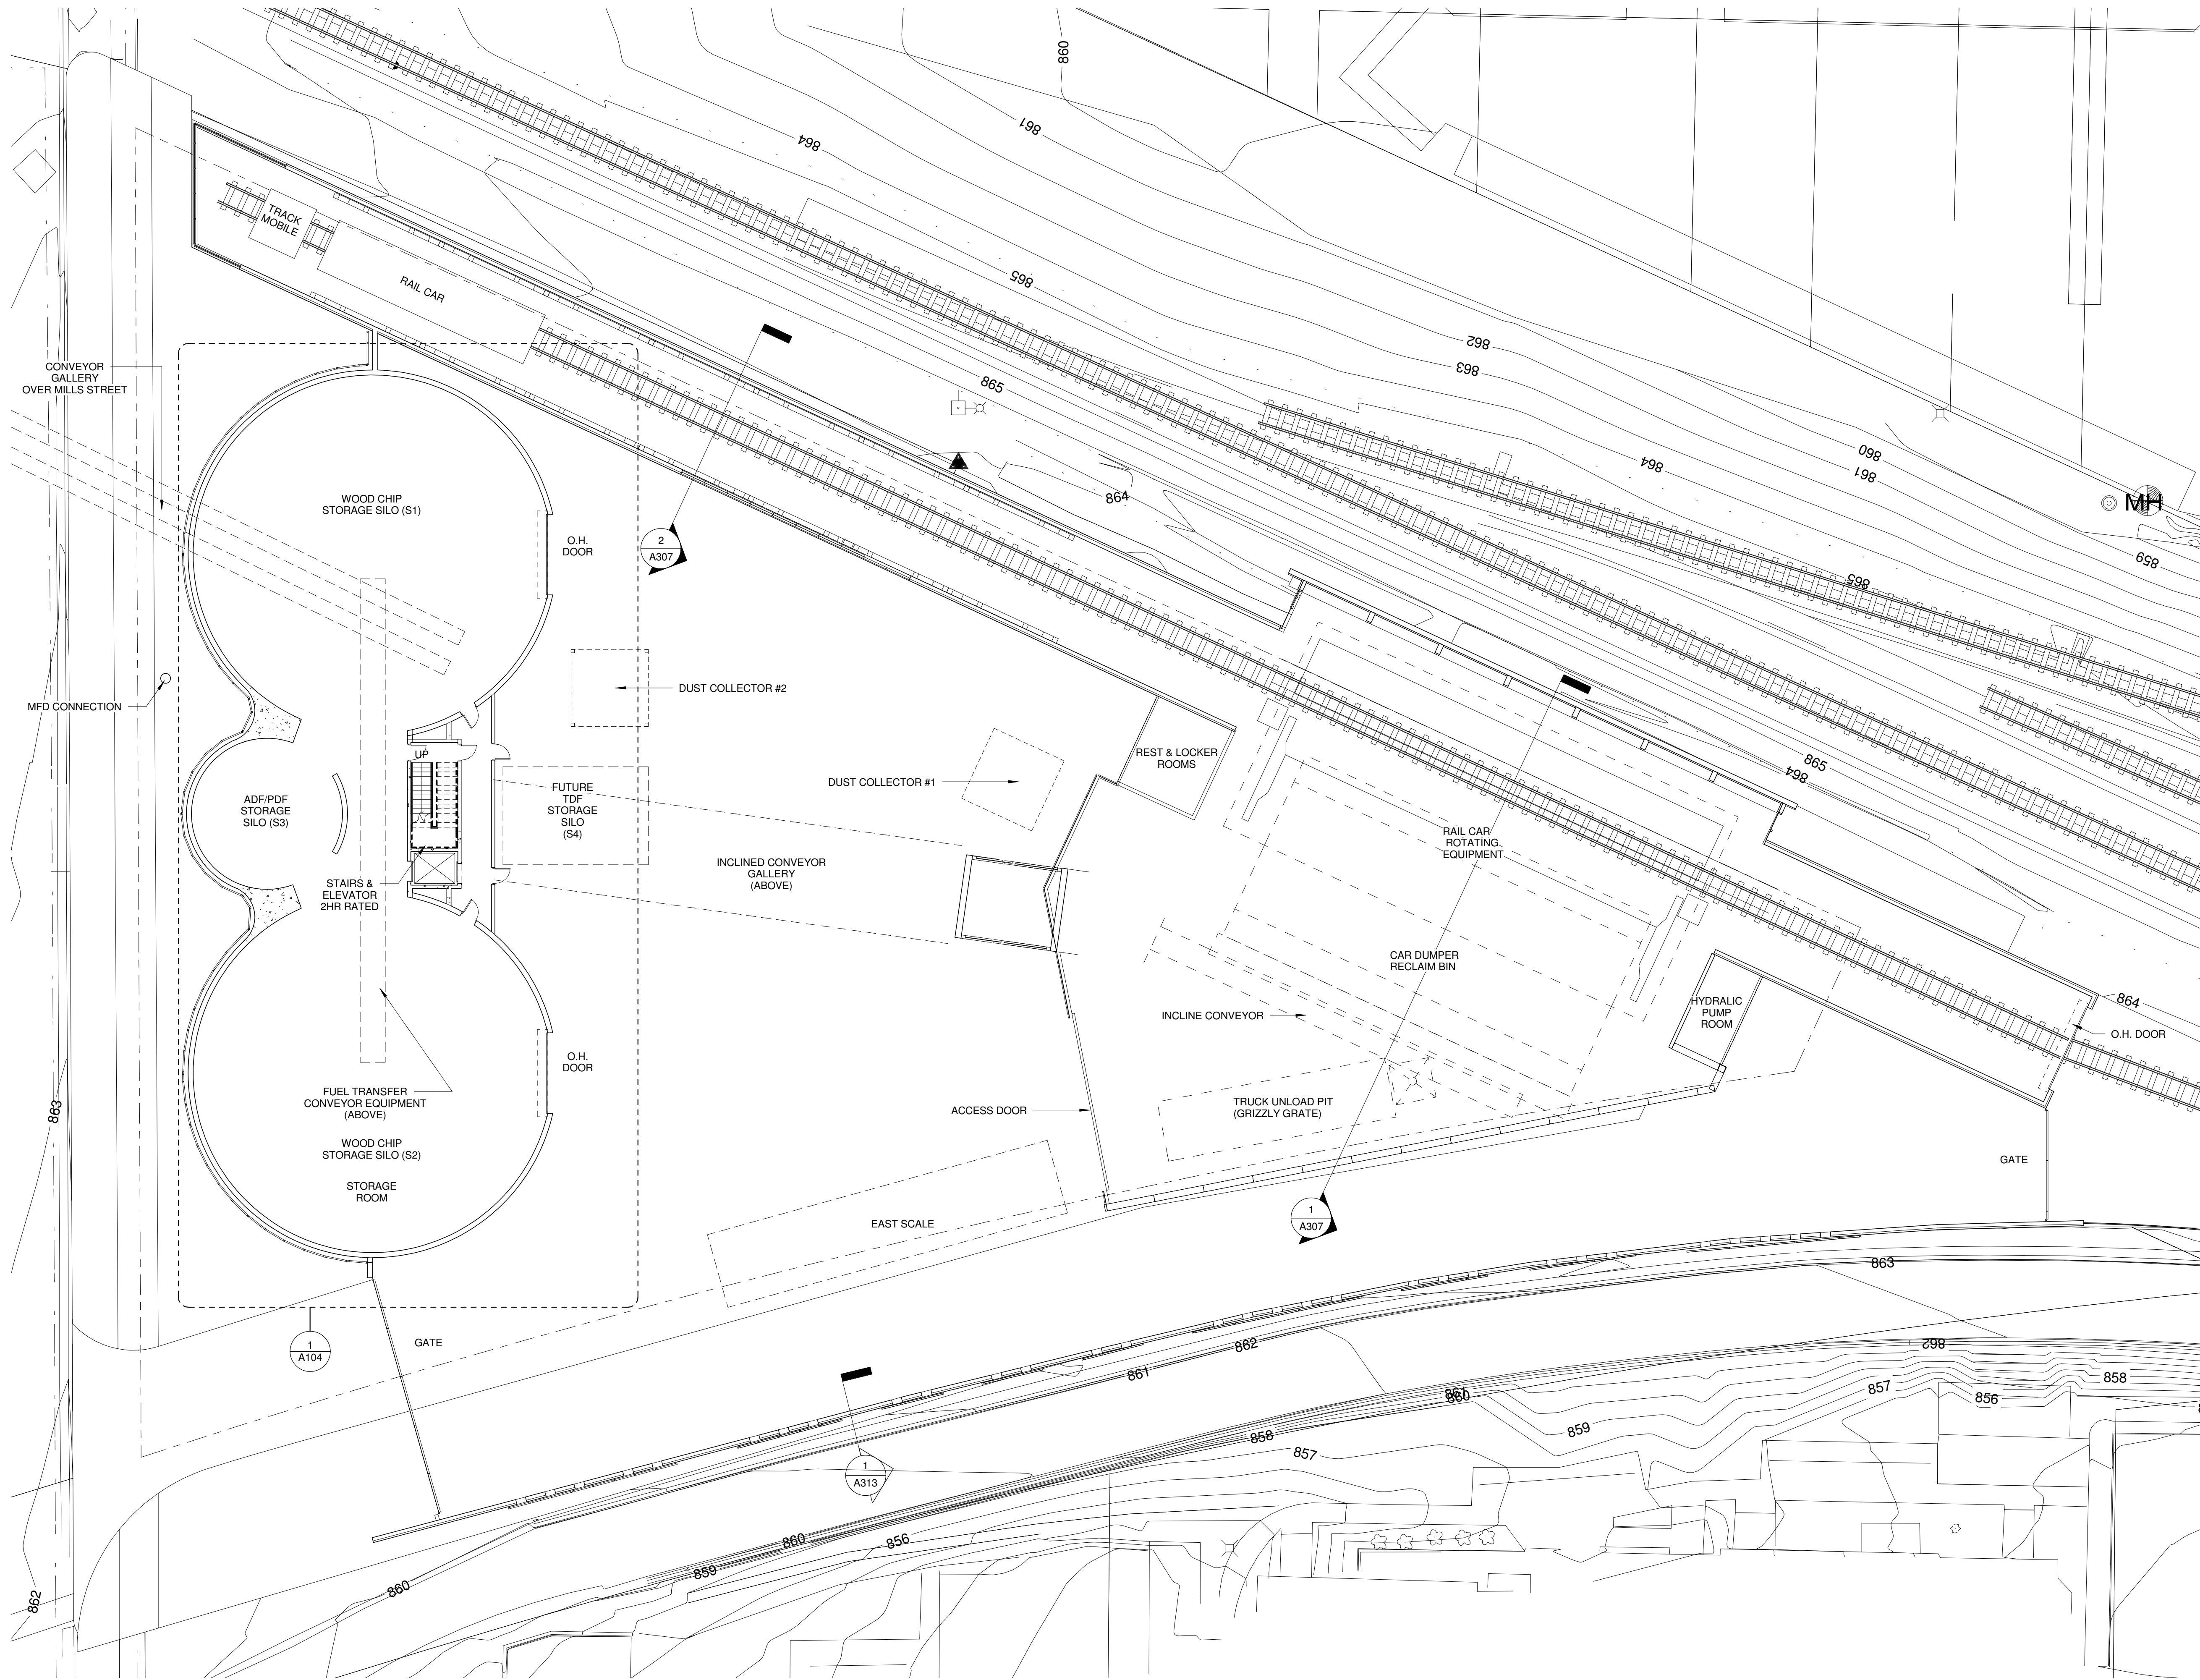

1 RAIL SHED, HOPPER & FUEL STORAGE - FIRST FLOOR PLAN
A103 1/16" = 1'-0"

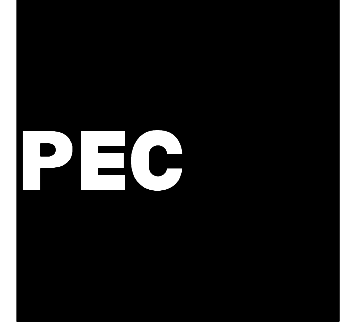


POWER ENGINEERS
COLLABORATIVE LLC
150 Sunny Slope Road
Suite 110
Brookfield, Wisconsin 53005
WWW.PECLLC.COM



PLI Project No:
2009.07.00

State of Wisconsin
Department of Administration
Division of State Facilities

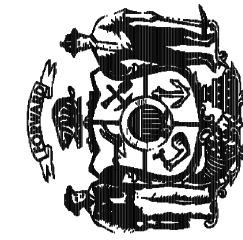


Agency / Institution:
UNIVERSITY OF WISCONSIN SYSTEM

CHARTER STREET HEATING
PLANT REBUILD
MADISON, WI
GDP FLOOR PLANS - FUEL HANDLING

Project Title:
Project Location:
Sheet Title:

Revisions:			
No.	Date:	By:	Description:

Graphic Scale	
DSF Number	09A2L
Set Type	PR
Date Issued	03-10-10
Sheet Number	A103

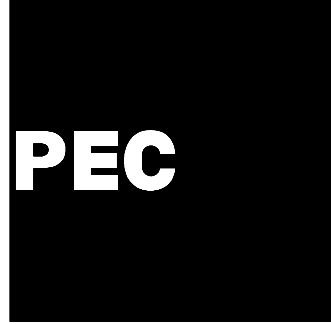


POWER ENGINEERS
COLLABORATIVE LLC
150 Sunny Slope Road
Suite 110
Brookfield, Wisconsin 53005
WWW.PECLLC.COM



PLT Project No:
2009.07.00

State of Wisconsin
Department of Administration
Division of State Facilities

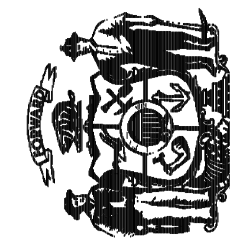

Agency / Institution:
UNIVERSITY OF WISCONSIN SYSTEM

CHARTER STREET HEATING
PLANT REBUILD

MADISON, WI

GDP BUILDING ELEVATIONS

Project Title:

Project Location:

Sheet Title:

Revisions:

No.	Date:	By:	Description:

Graphic
Scale

DSF
Number

09A2L

Set
Type



PR

Date
Issued


03-10-10

Sheet
Number


A201

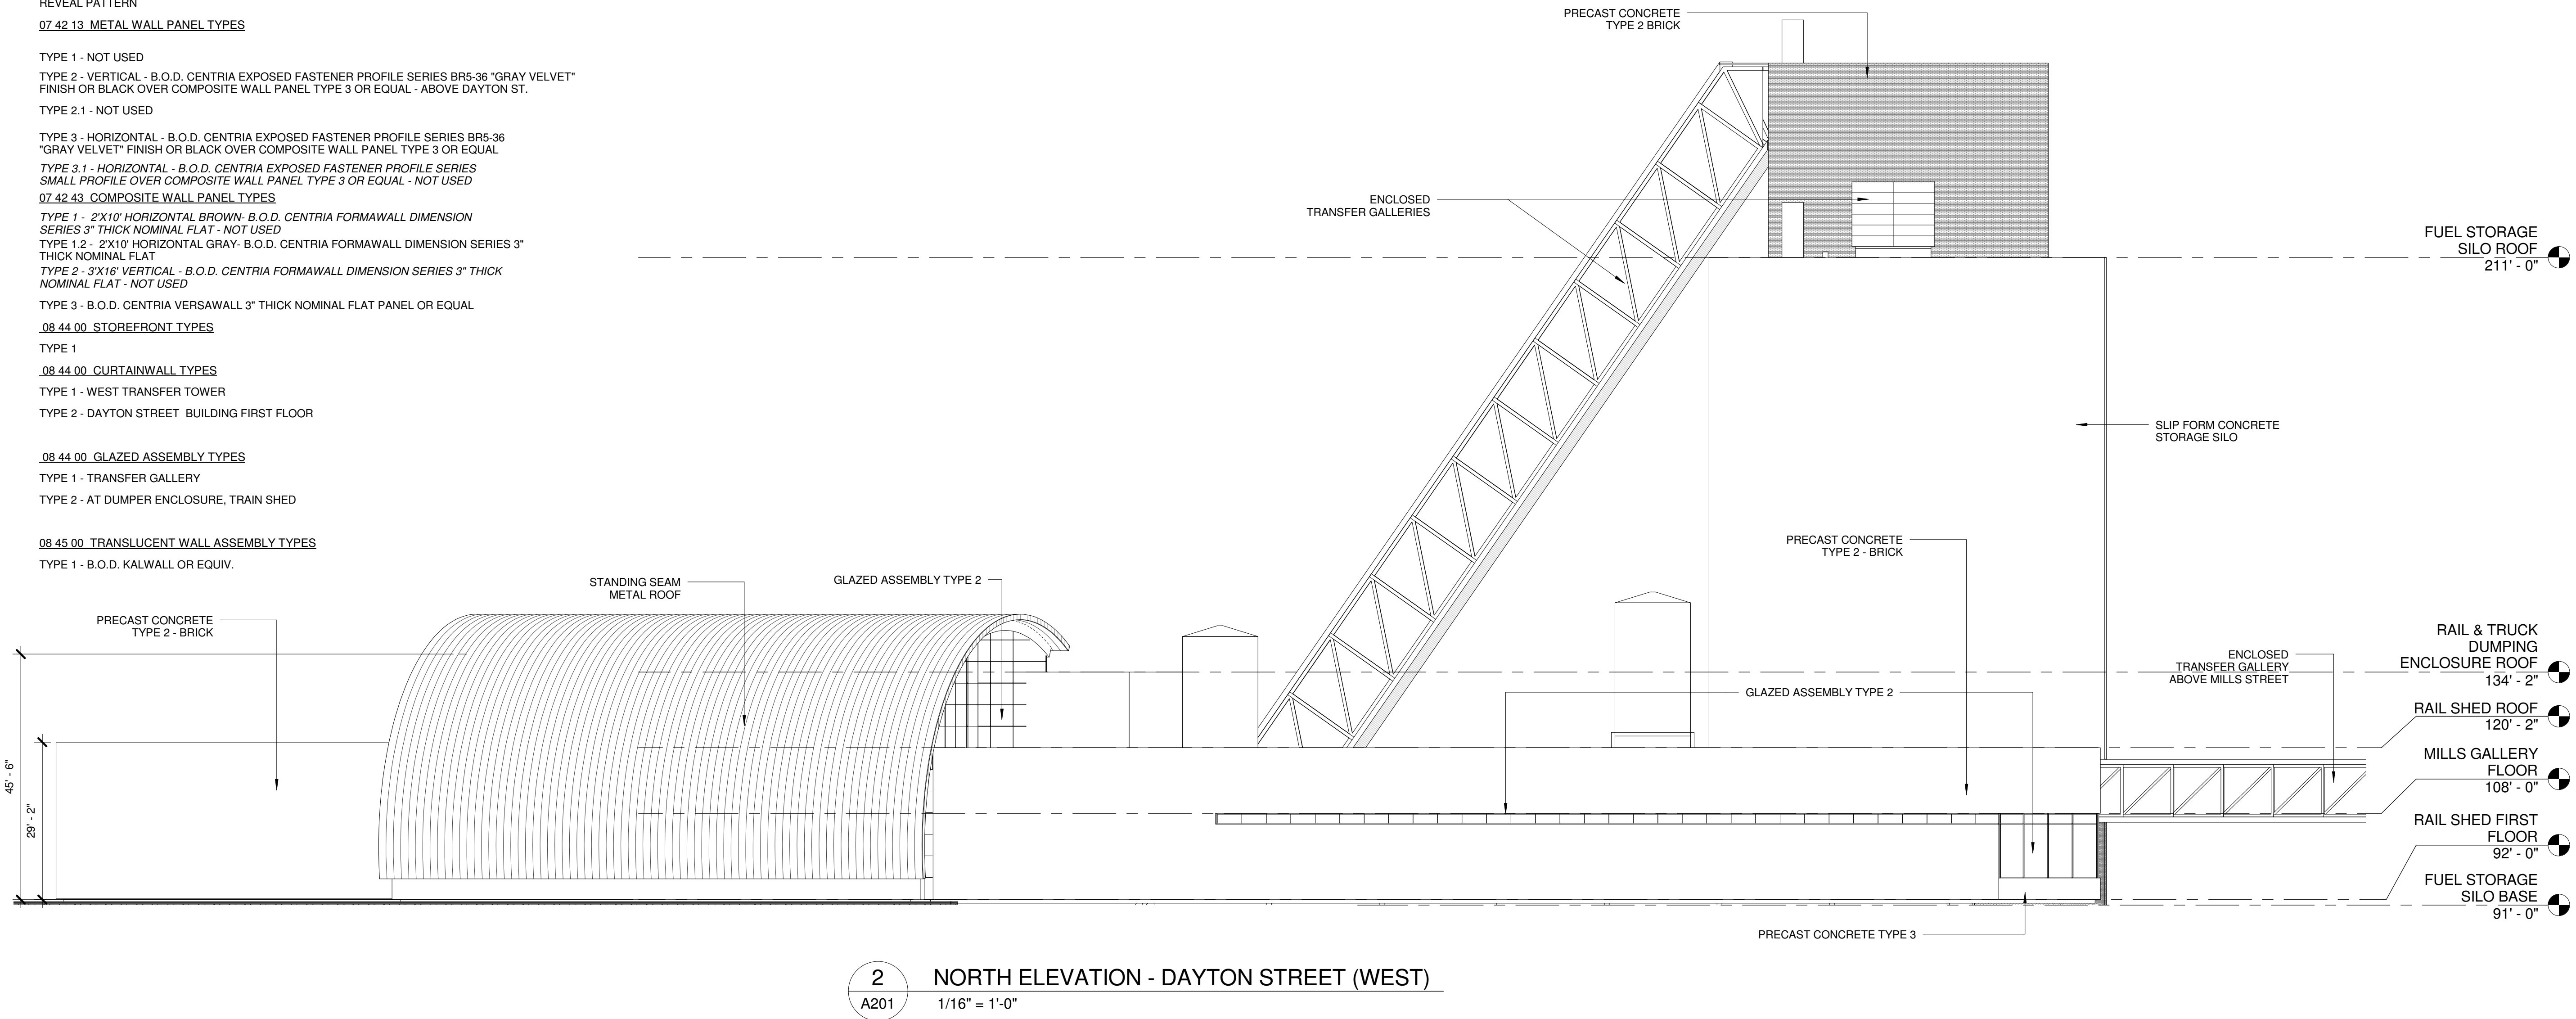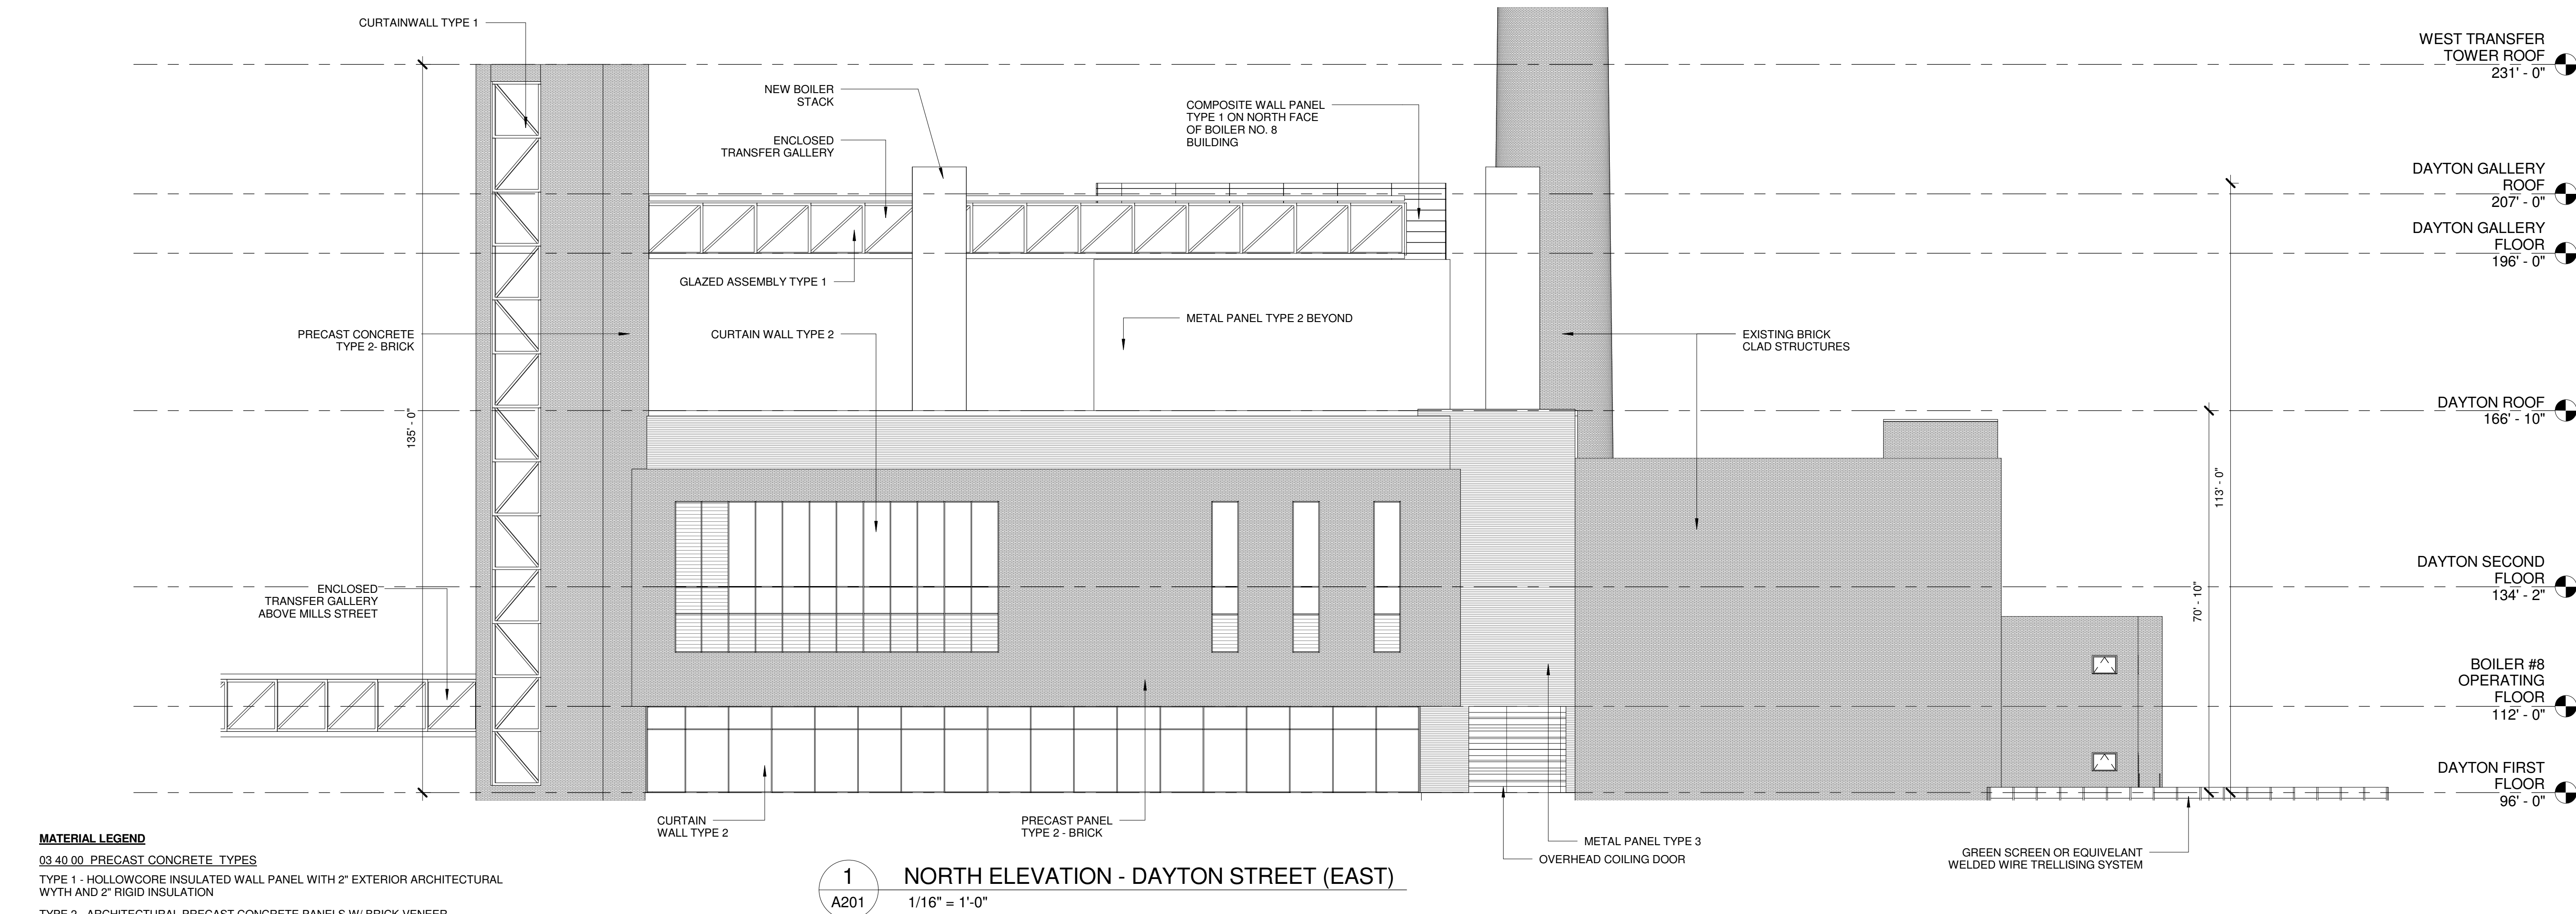


No.	Date:	By:	Description:

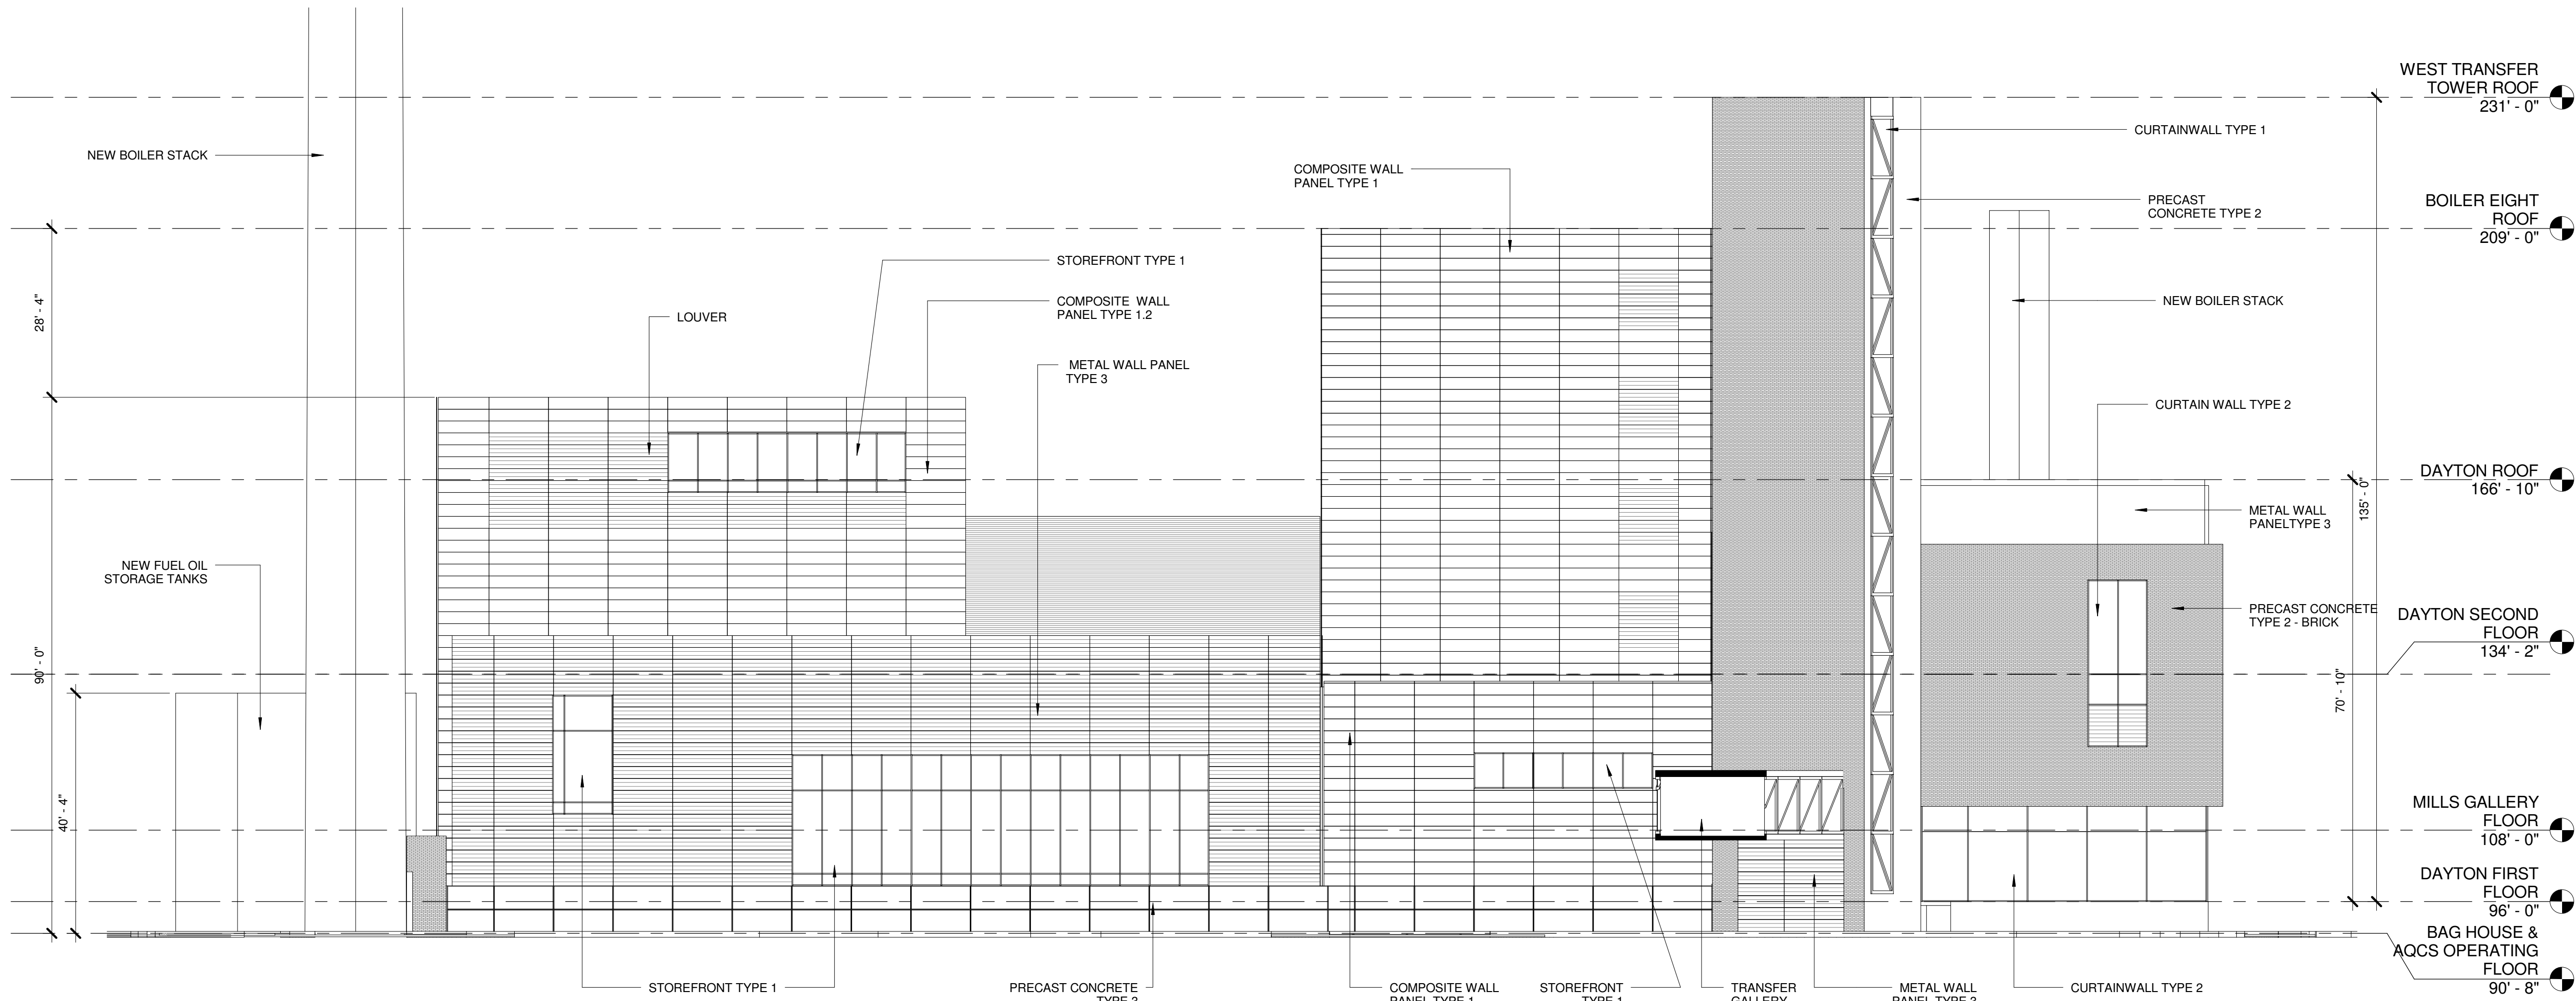

1 EAST ELEVATION - HEATING PLANT
1/16" = 1'-0"

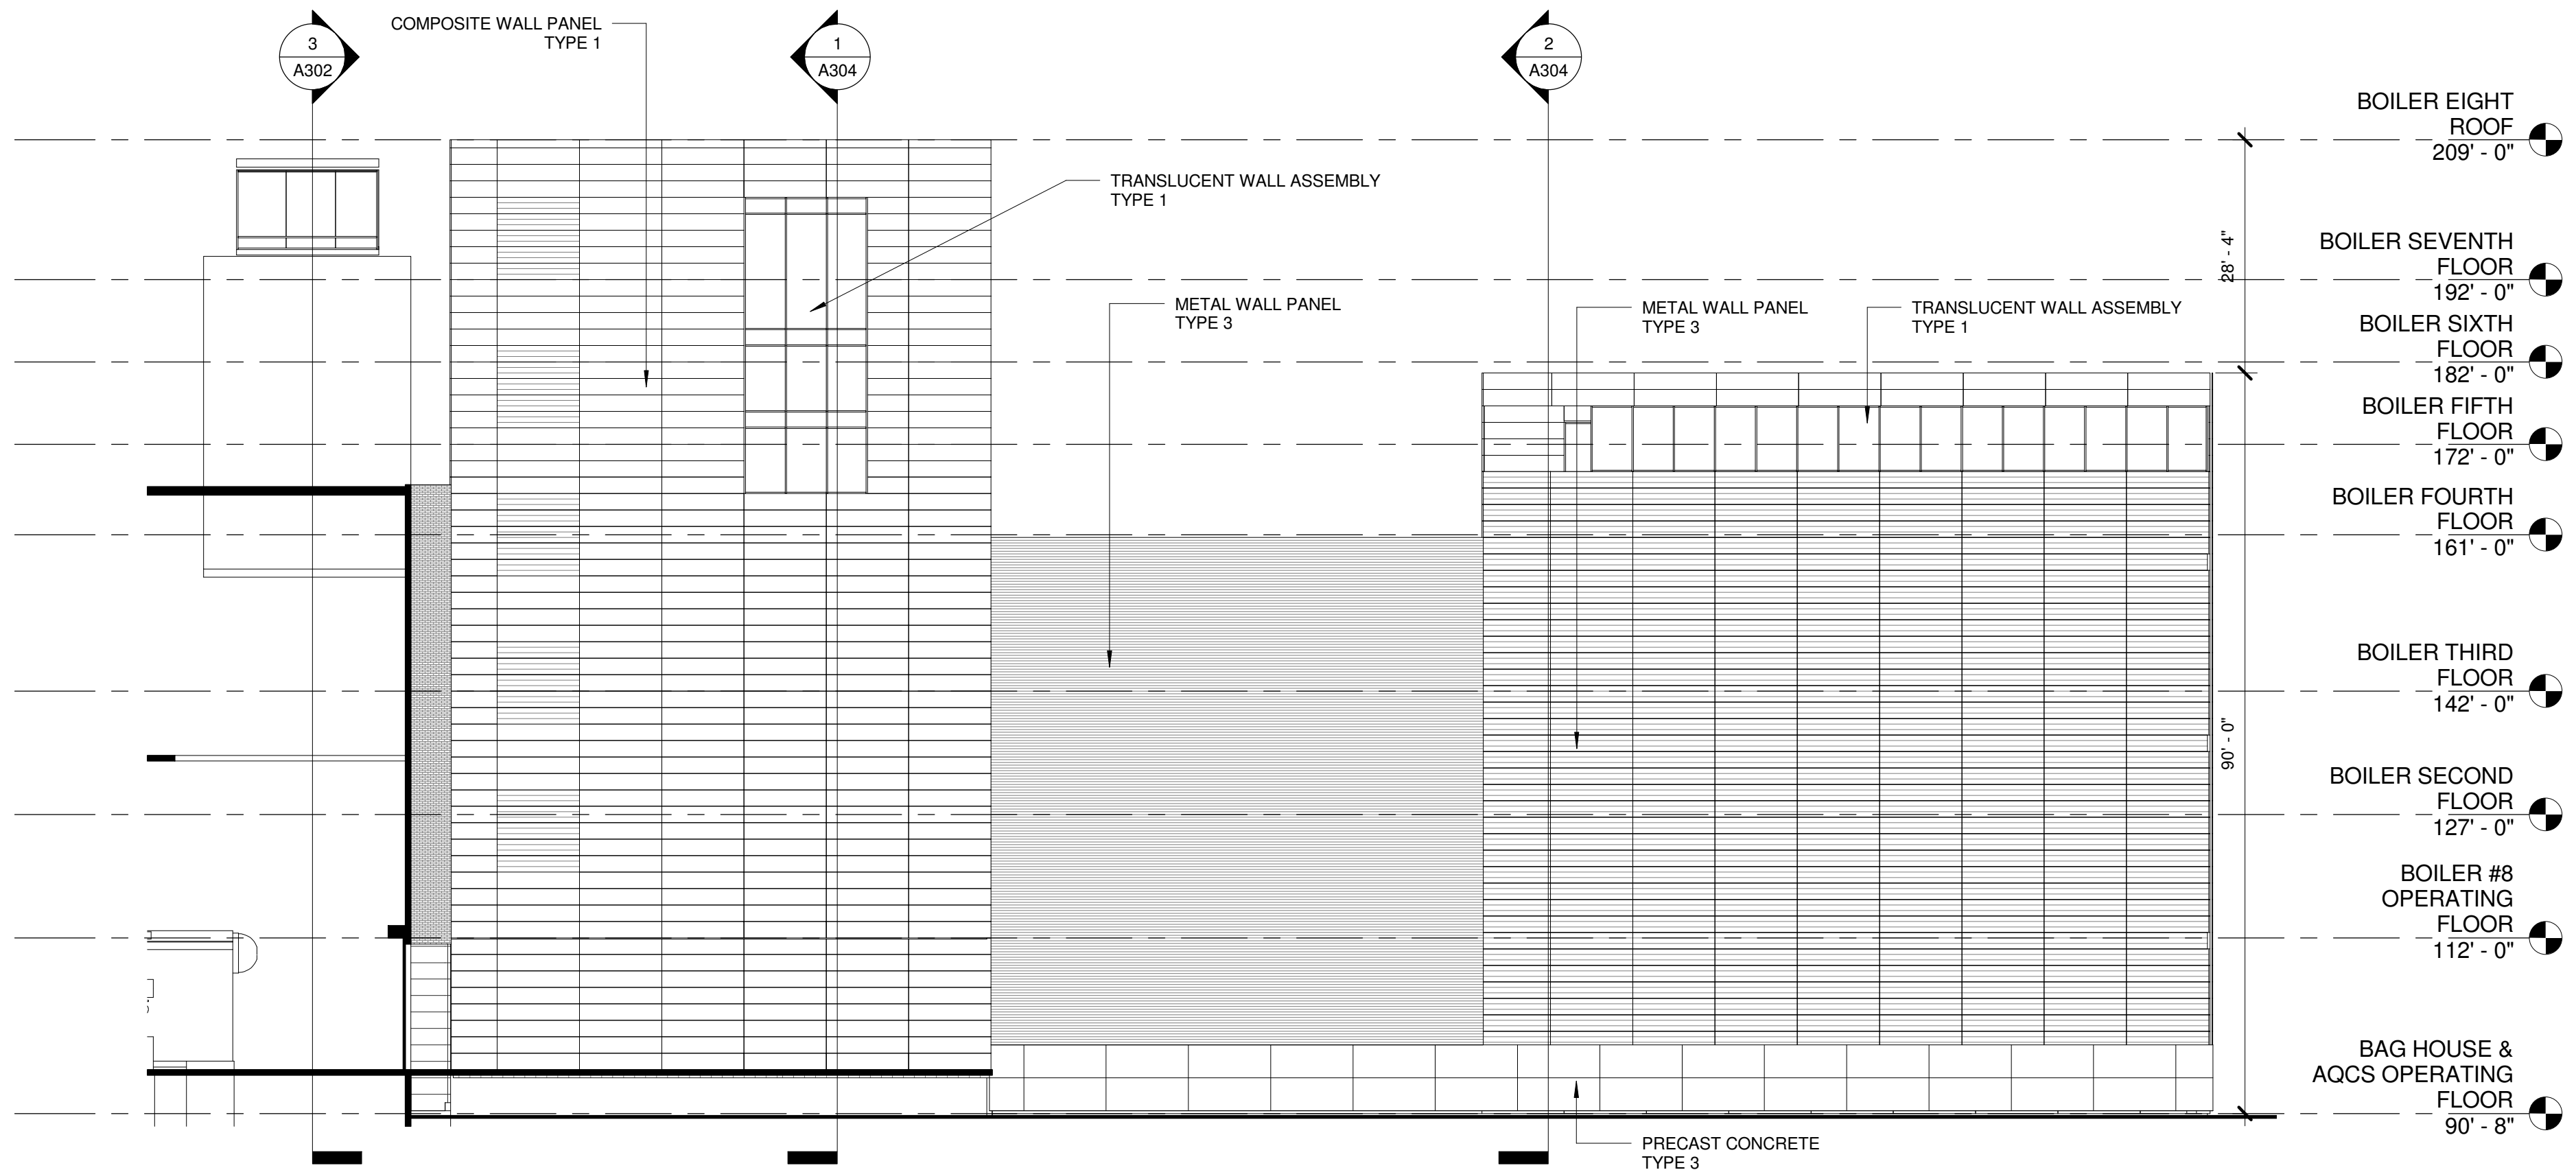

2 WEST ELEVATION - HEATING PLANT
1/16" = 1'-0"

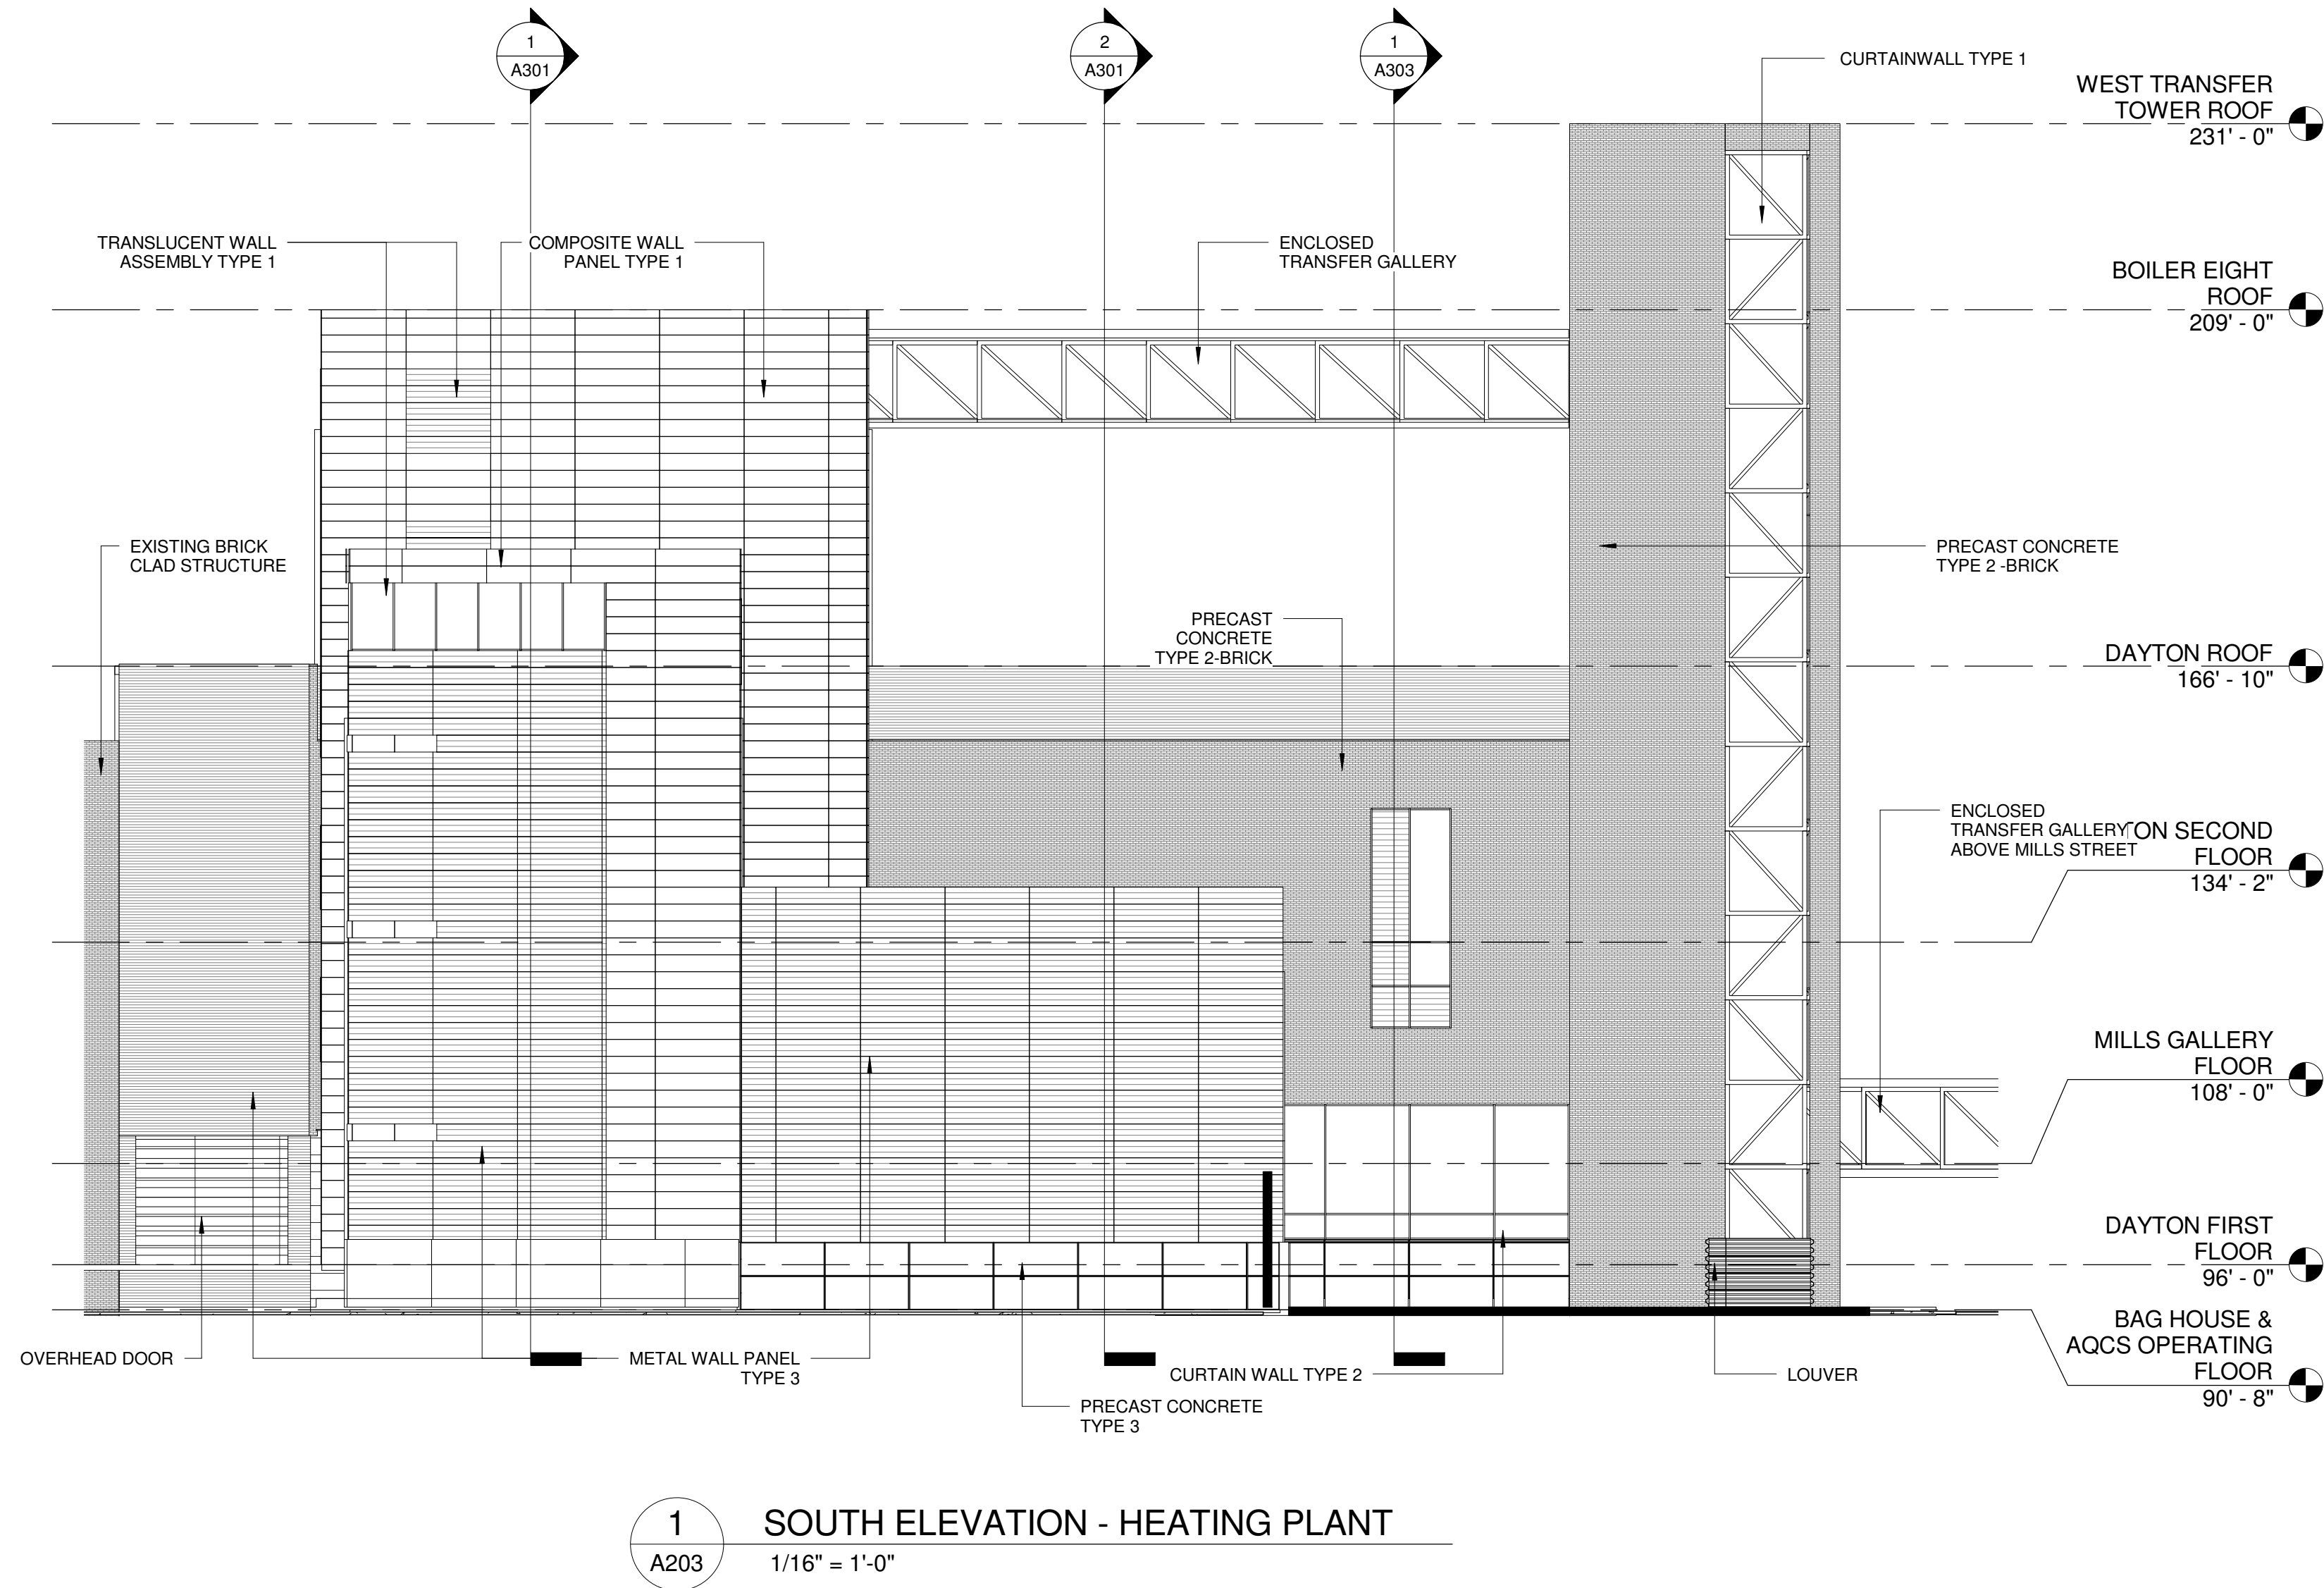

PEC

POWER ENGINEERS
COLLABORATIVE LLC

150 Sunny Slope Road
Suite 110
Brookfield, Wisconsin 53005
WWW.PECLLC.COM

PÖYRY

POWER ARCHITECTS LLC


OFFICE: WISCONSIN

middough

Potter Lawson

PLT Project No:
2009.07.00

State of Wisconsin
Department of Administration
Division of State Facilities

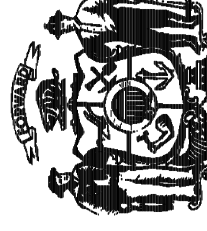
Agency / Institution:
UNIVERSITY OF WISCONSIN SYSTEM

CHARTER STREET HEATING
PLANT REBUILD

MADISON, WI

GDP BUILDING ELEVATIONS

Project Title:
CHARTER STREET HEATING
PLANT REBUILD

Project Location:
MADISON, WI

Sheet Title:
GDP BUILDING ELEVATIONS

Revisions:

No.	Date:	By:	Description:

Graphic
Scale

DSF
Number

Set
Type

Date
Issued


Sheet
Number

09A2L

PR

03-10-10

A203

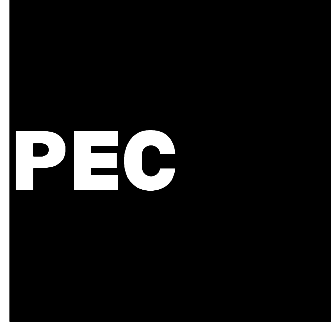


POWER ENGINEERS
COLLABORATIVE LLC
150 Sunny Slope Road
Suite 110
Brookfield, Wisconsin 53005
WWW.PECLLC.COM



PLI Project No:
2009.07.00

State of Wisconsin
Department of Administration
Division of State Facilities

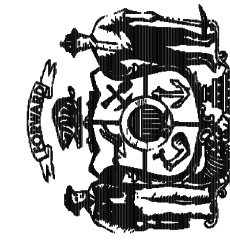

Agency / Institution:
UNIVERSITY OF WISCONSIN SYSTEM

CHARTER STREET HEATING
PLANT REBUILD

MADISON, WI

GDP BUILDING ELEVATIONS

Project Title:

Project Location:

Sheet Title:

Revisions:

No.	Date:	By:	Description:

Graphic
Scale

DSF
Number

09A2L

Set
Type


PR

Date
Issued


03-10-10

Sheet
Number



A204

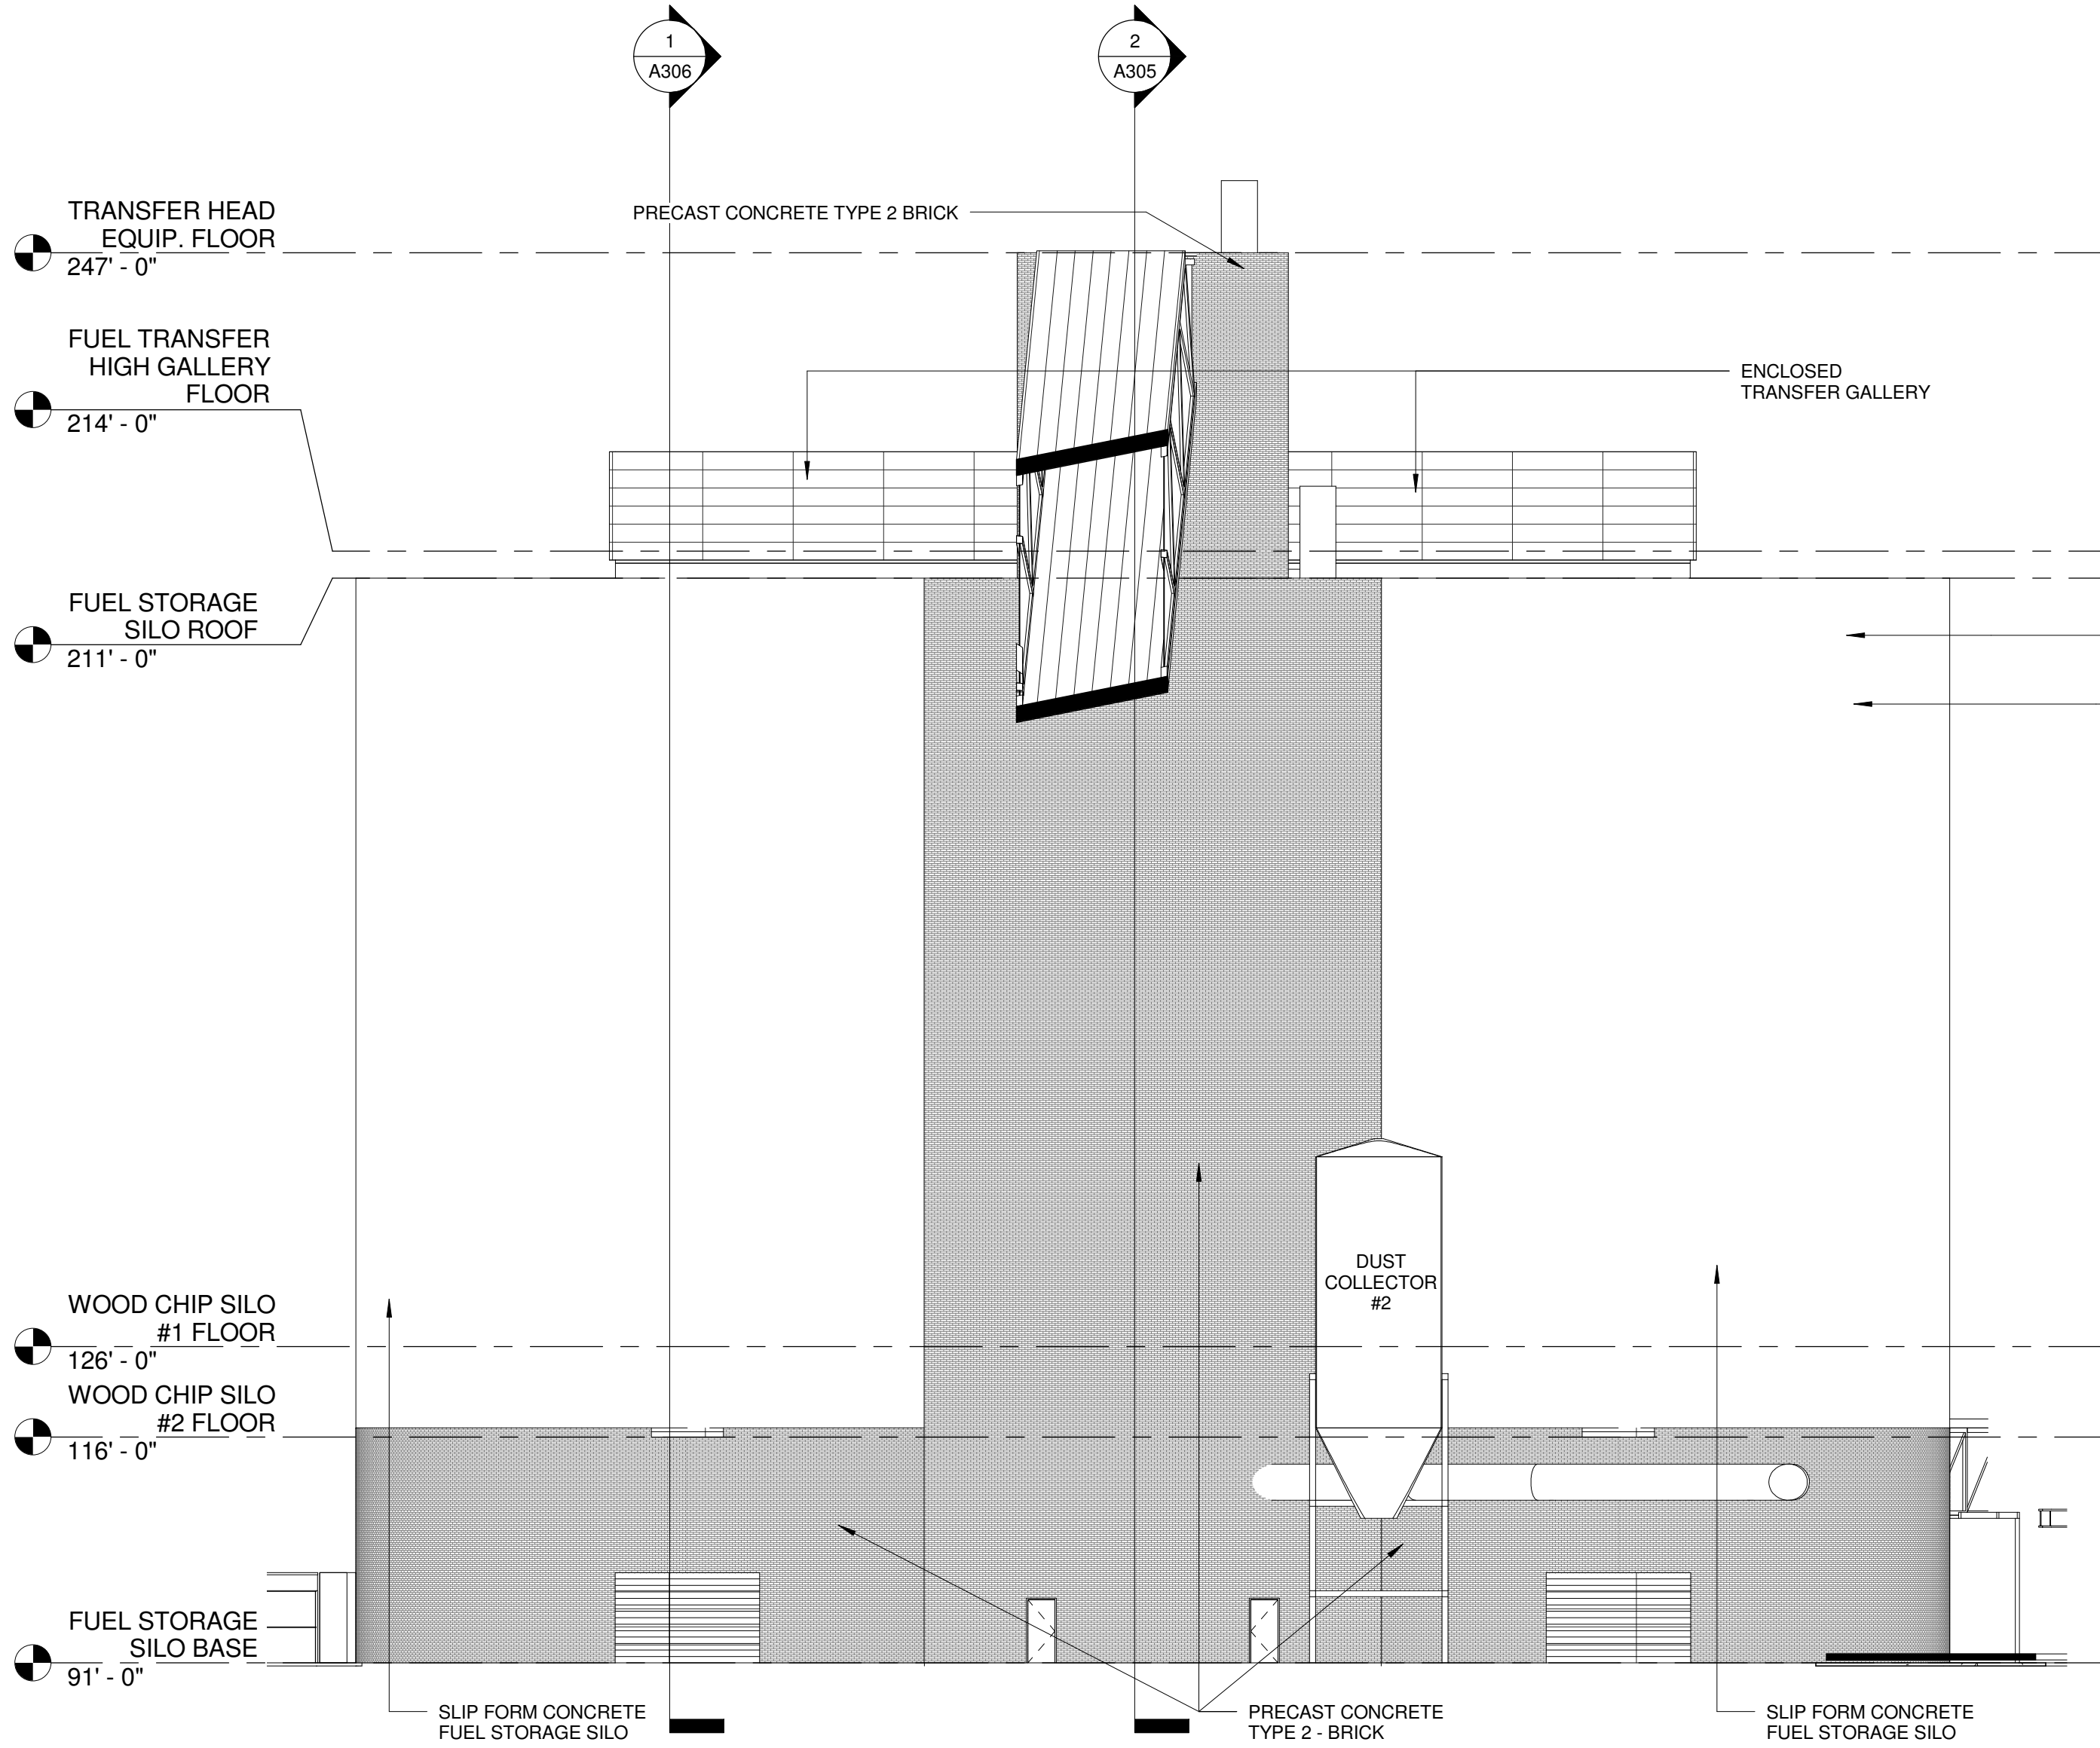

2 FUEL STORAGE - EAST ELEVATION
A204 1/16" = 1'-0"

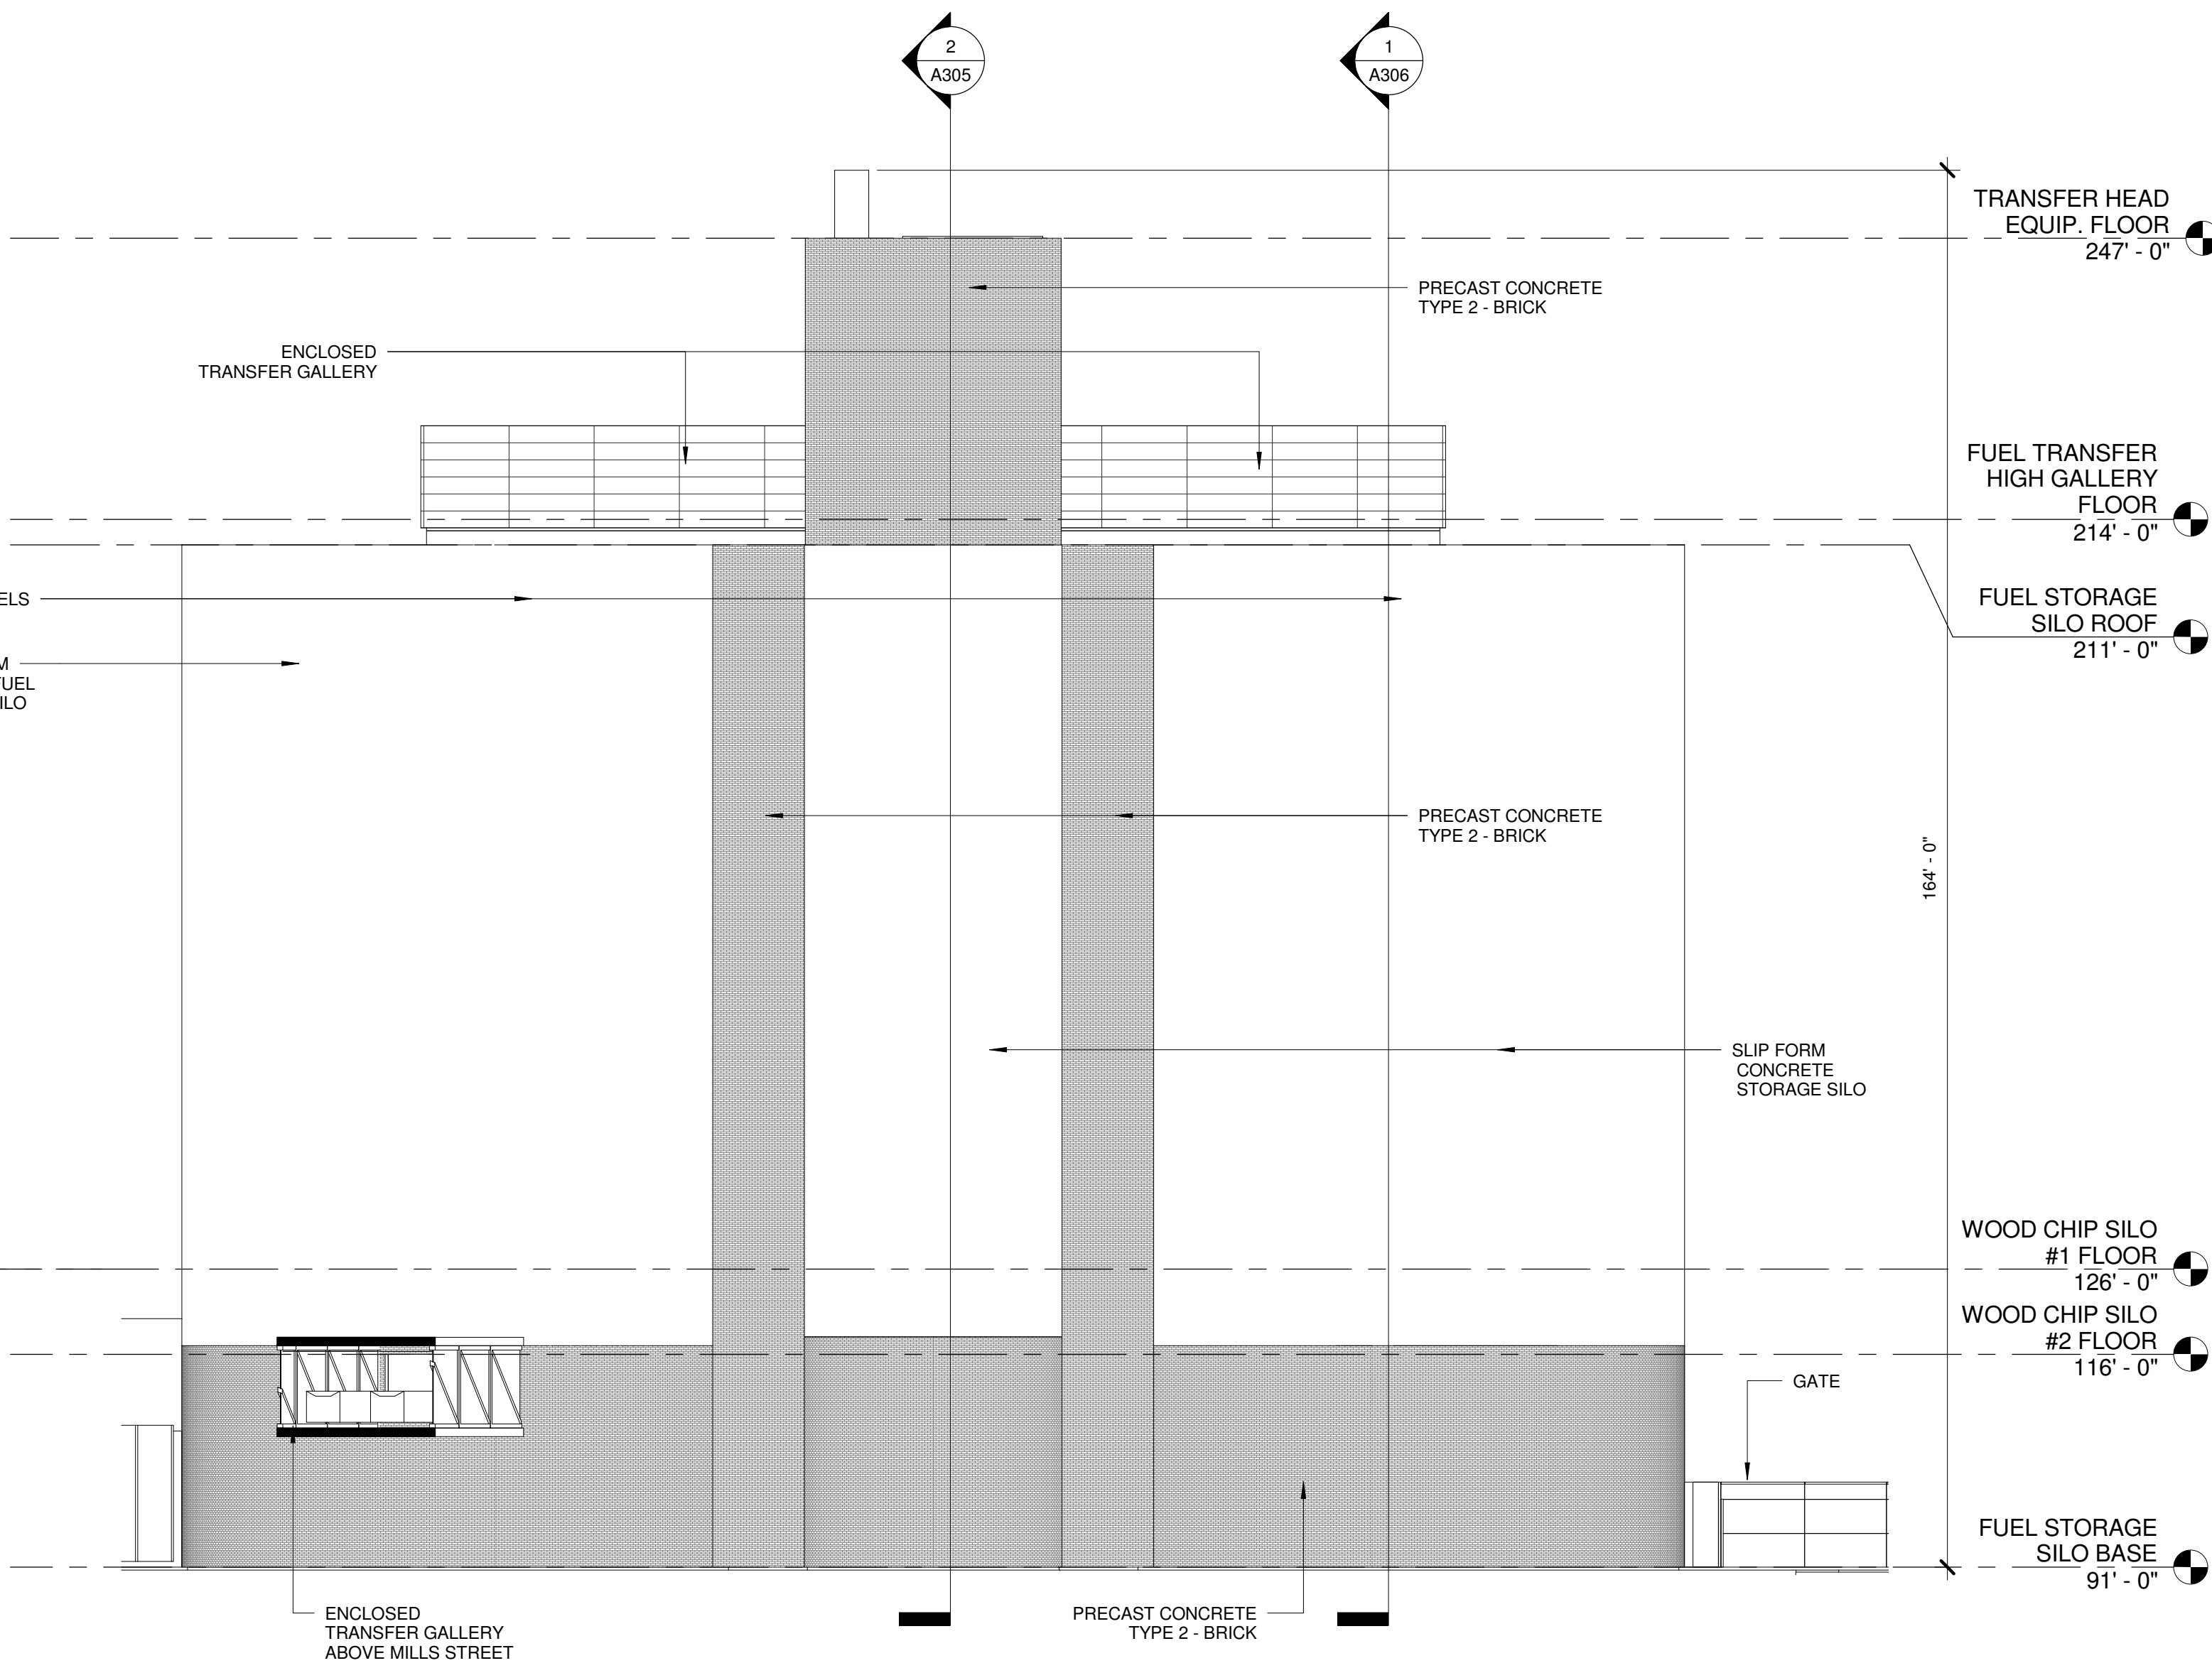

1 FUEL STORAGE - WEST ELEVATION (MILLS STREET)
A204 1/16" = 1'-0"

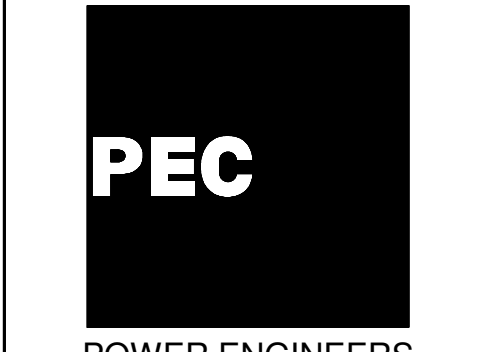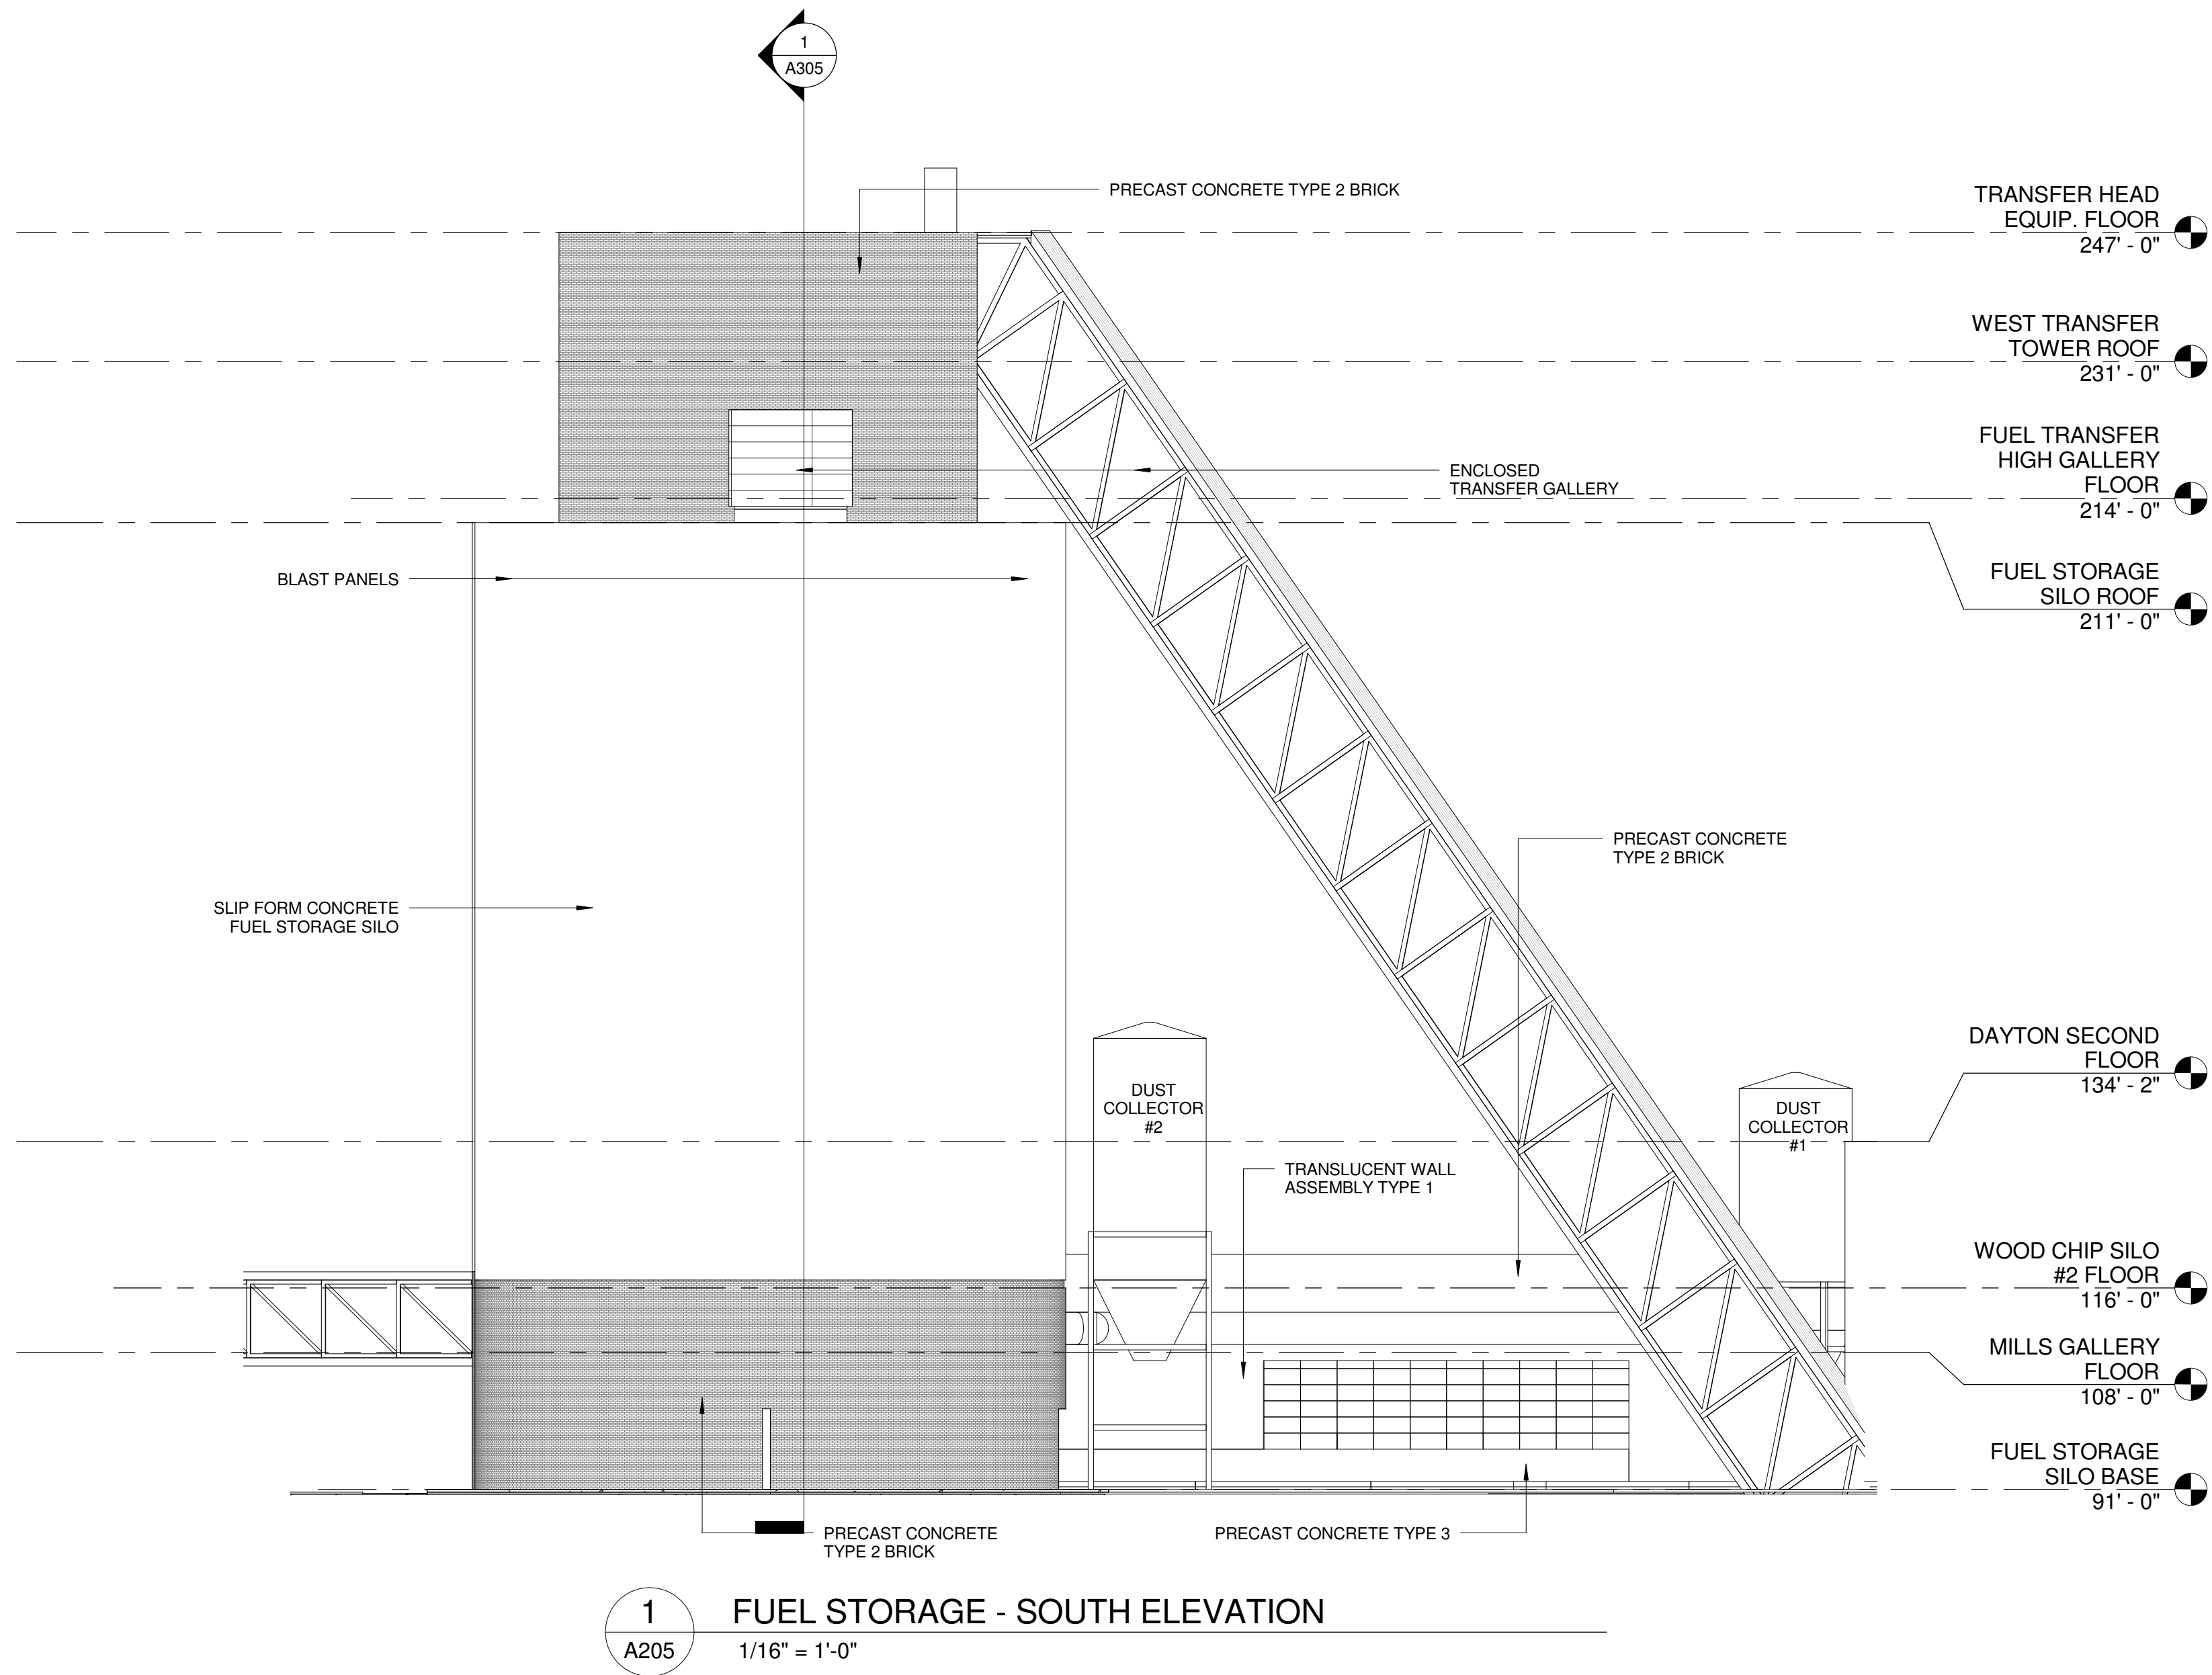


POWER ENGINEERS
COLLABORATIVE LLC
150 Sunny Slope Road
Suite 110
Brookfield, Wisconsin 53005
WWW.PECLLC.COM



PLI Project No:
2009.07.00

State of Wisconsin
Department of Administration
Division of State Facilities

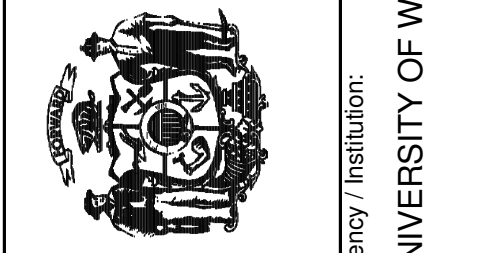


**CHARTER STREET HEATING
PLANT REBUILD**
MADISON, WI
GDP BUILDING ELEVATIONS

Project Title:
Project Location:
Sheet Title:

Revisions:			
No.	Date:	By:	Description:

Graphic Scale	
DSF Number	09A2L
Set Type	PR
Date Issued	03-10-10
Sheet Number	A205

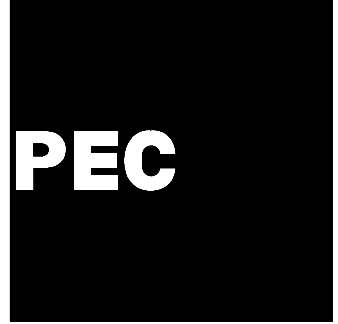


POWER ENGINEERS
COLLABORATIVE LLC
150 Sunny Slope Road
Suite 110
Brookfield, Wisconsin 53005
WWW.PECLLC.COM



PLT Project No:
2009.07.00

State of Wisconsin
Department of Administration
Division of State Facilities

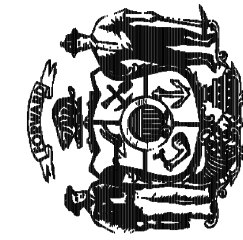

Agency/Institution:
UNIVERSITY OF WISCONSIN SYSTEM


CHARTER STREET HEATING
PLANT REBUILD
MADISON, WI
GDP BUILDING ELEVATIONS

Project Title:
Project Location:
Sheet Title:


Revisions:

No.	Date:	By:	Description:


Graphic Scale	
DSF Number	09A2L
Set Type	PR
Date Issued	03-10-10
Sheet Number	A206

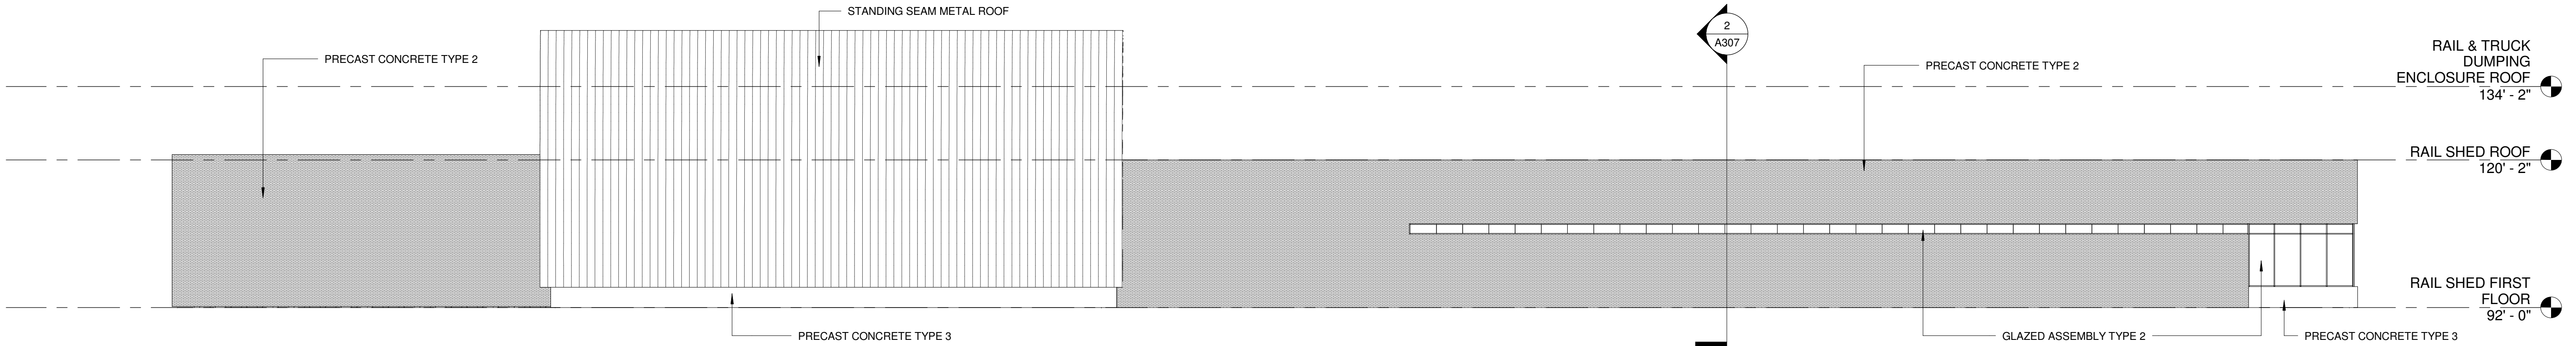

1 RAIL SHED & HOPPER - NORTH ELEVATION
A206 1/16" = 1'-0"

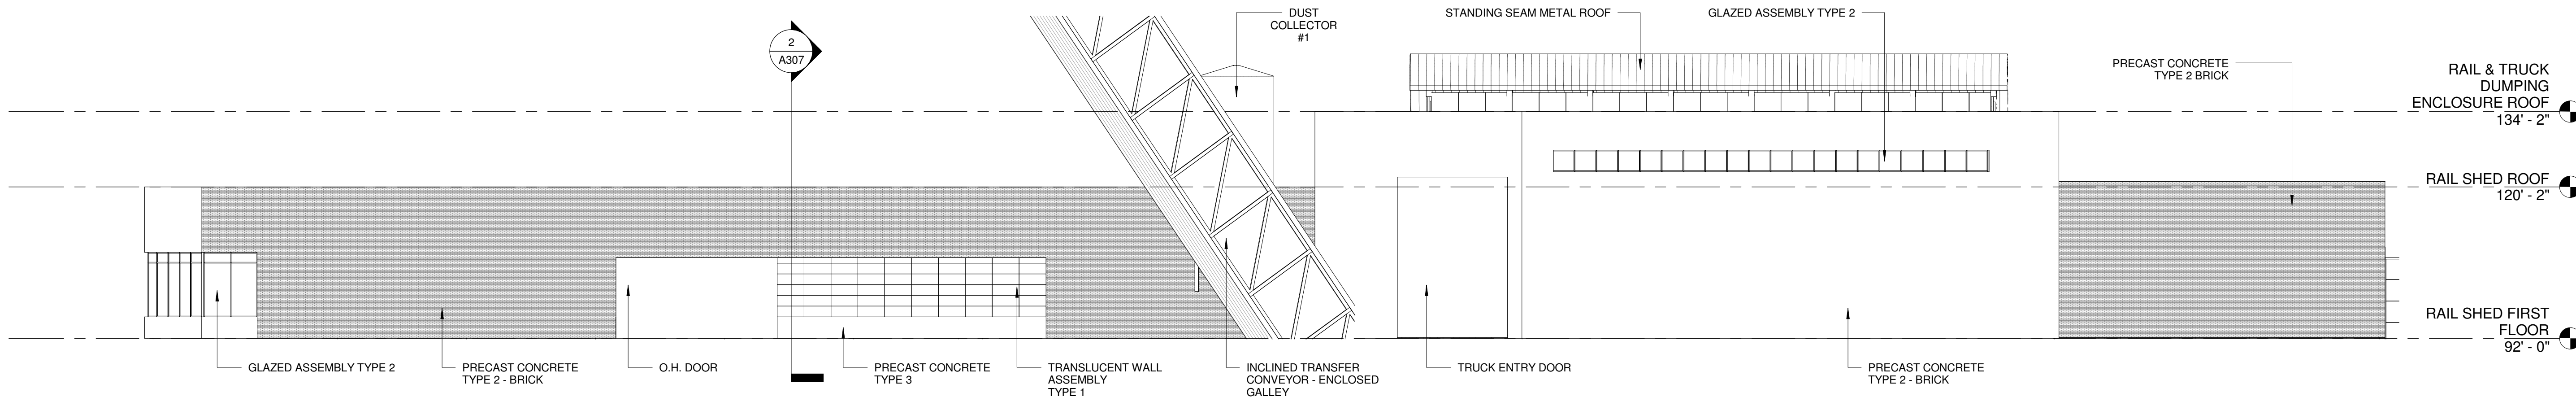


2 RAIL SHED & HOPPER SOUTH ELEVATION
A206 1/16" = 1'-0"

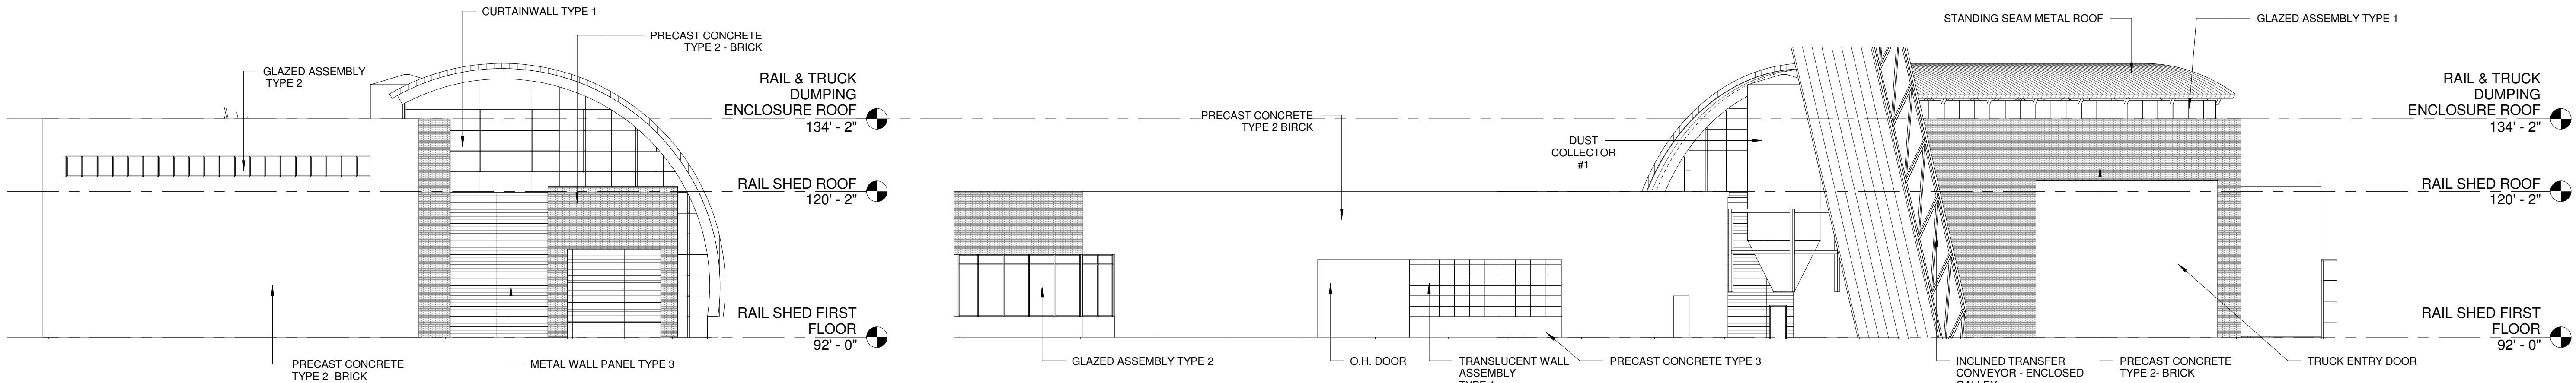


4 RAIL SHED - EAST ELEVATION
A206 1/16" = 1'-0"


3 RAIL SHED WEST ELEVATION
A206 1/16" = 1'-0"

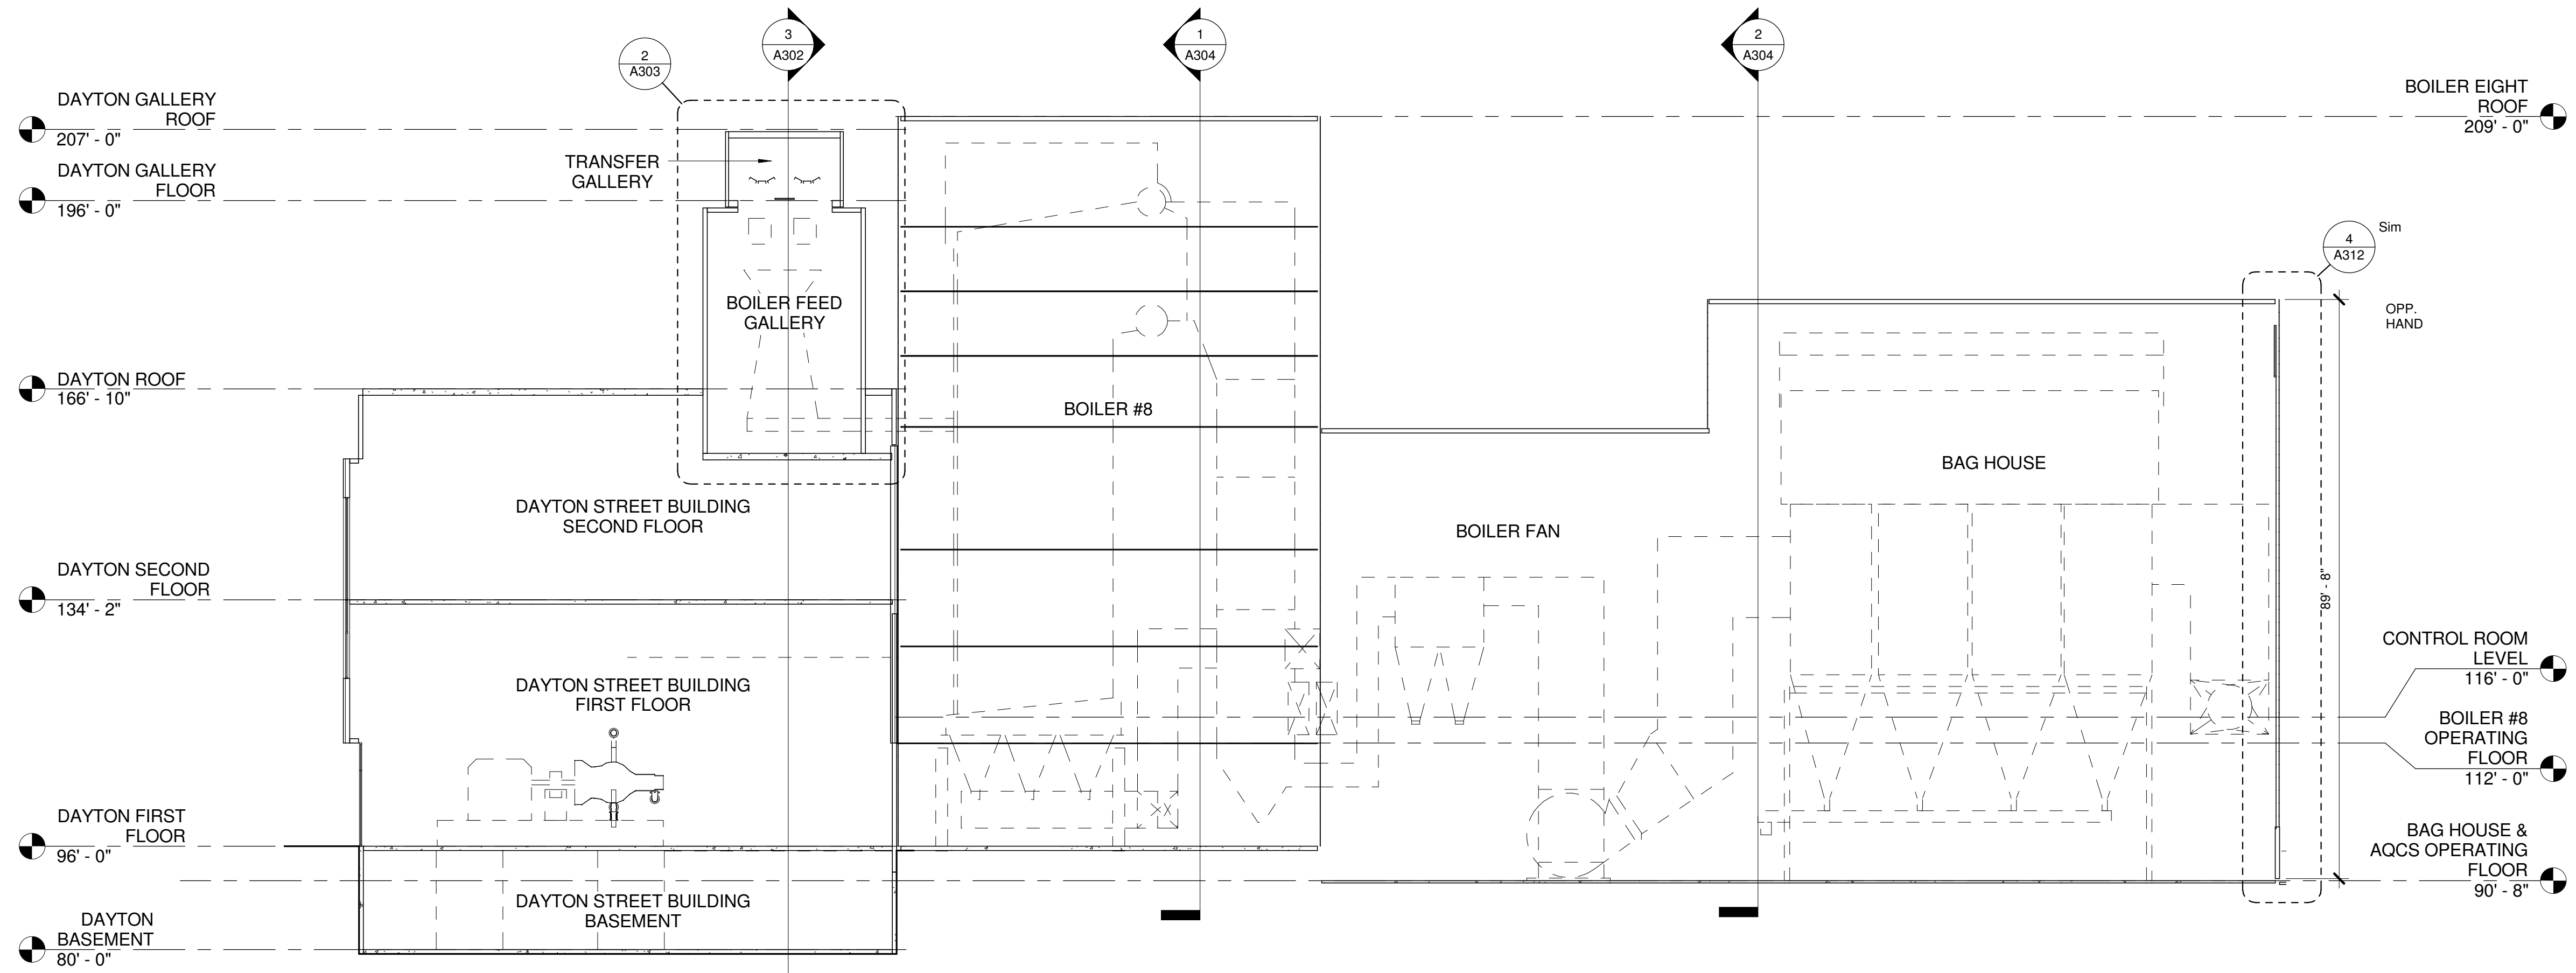

1
A301
BUILDING SECTION
1/16" = 1'-0"

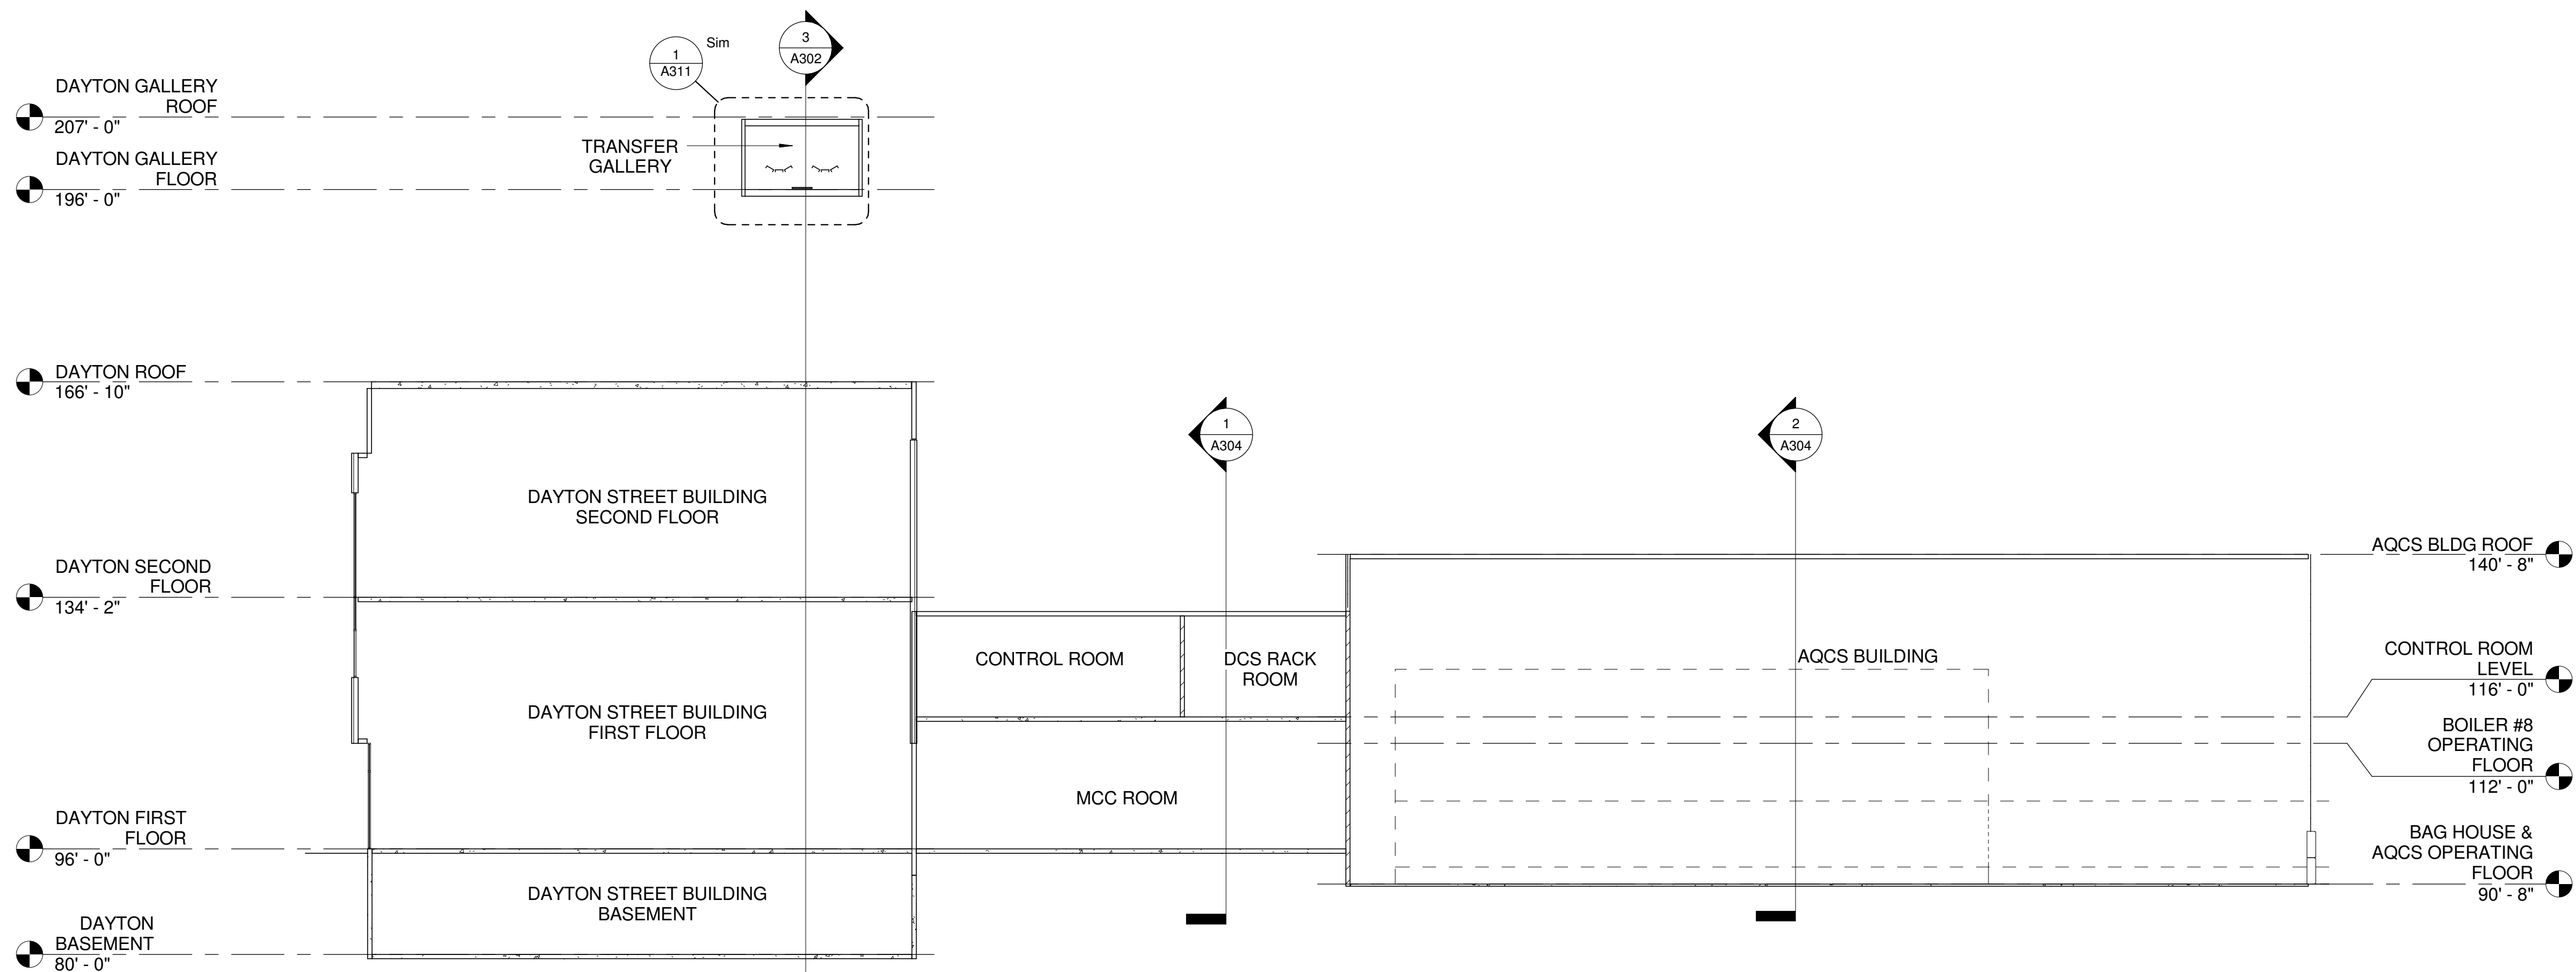

2
A301
BUILDING SECTION
1/16" = 1'-0"

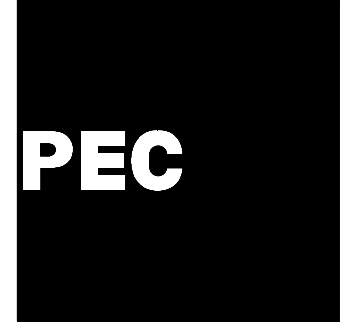


POWER ENGINEERS
COLLABORATIVE LLC
150 Sunny Slope Road
Suite 110
Brookfield, Wisconsin 53005
WWW.PECLLC.COM



PLT Project No:
2009.07.00

State of Wisconsin
Department of Administration
Division of State Facilities

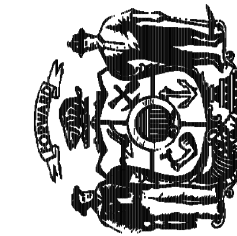

Agency / Institution:
UNIVERSITY OF WISCONSIN SYSTEM

CHARTER STREET HEATING
PLANT REBUILD

MADISON, WI

GDP BUILDING SECTIONS

Project Title:


Project Location:

Sheet Title:


Revisions:

No.	Date:	By:	Description:

Graphic Scale	
DSF Number	09A2L
Set Type	PR
Date Issued	03-10-10
Sheet Number	A301

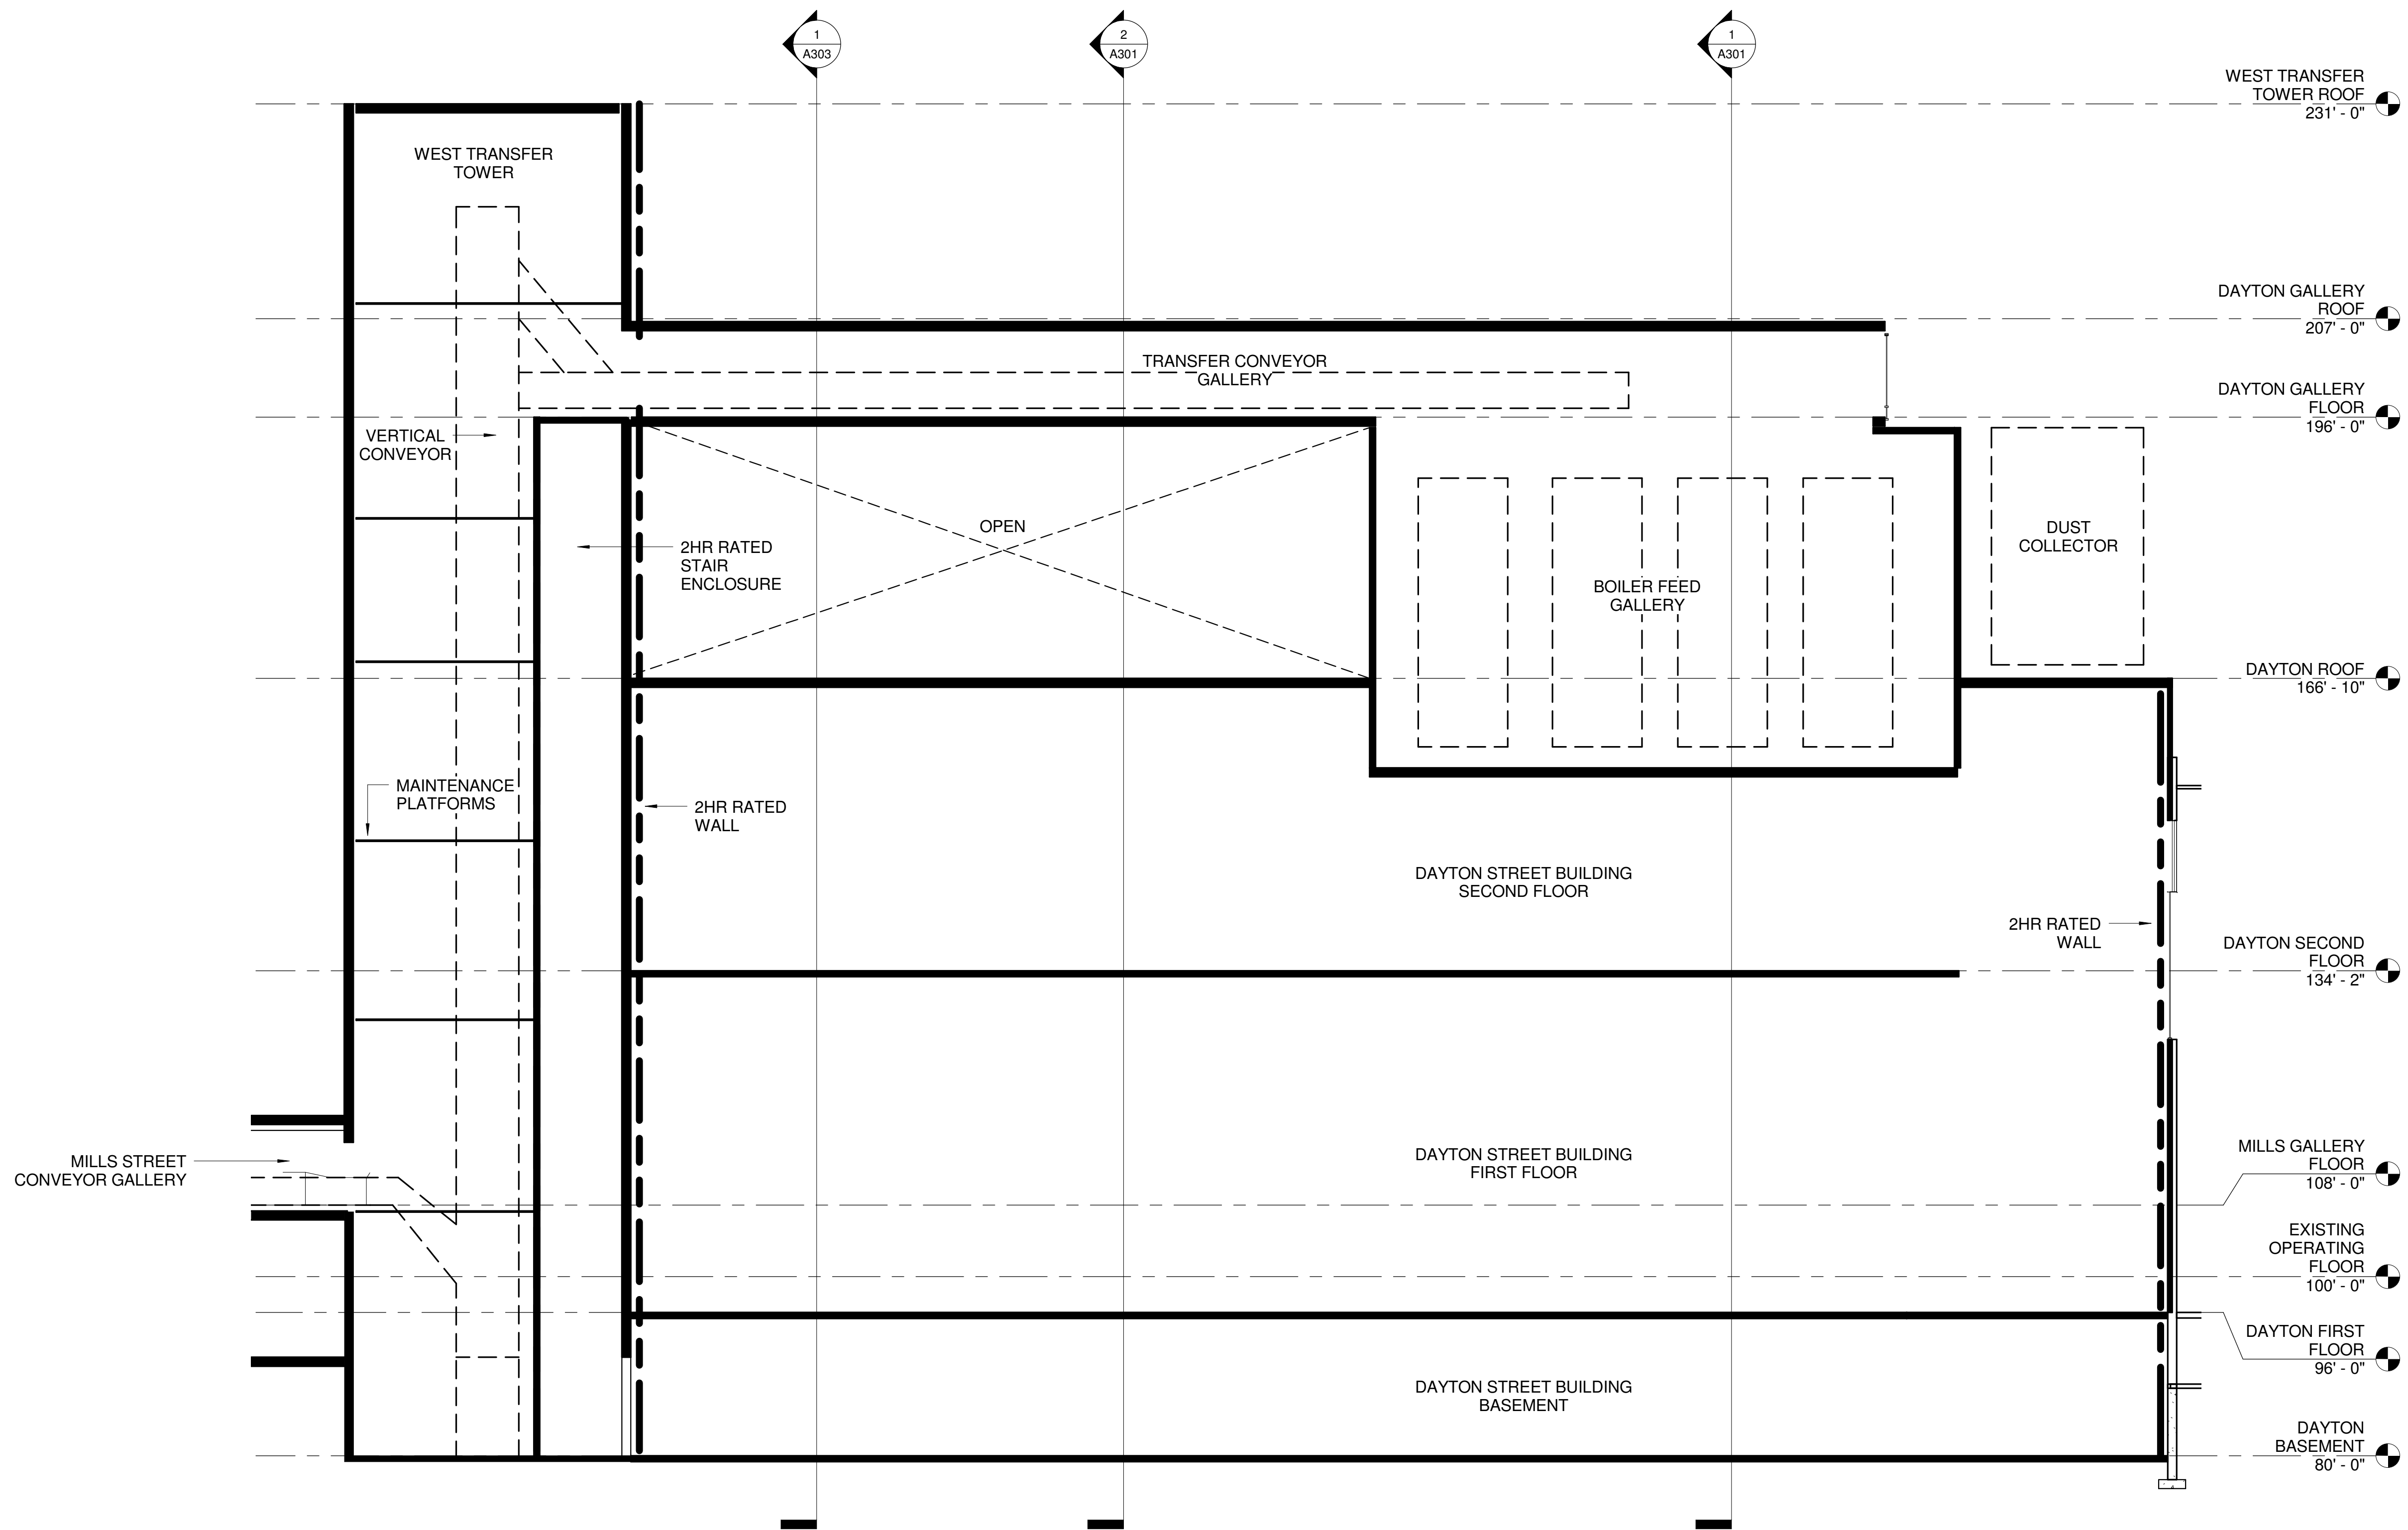

3 DAYTON STREET BUILDING SECTION
A302 3/32" = 1'-0"

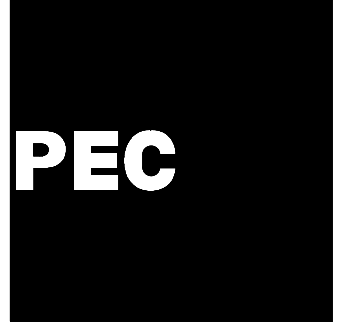


POWER ENGINEERS
COLLABORATIVE LLC
150 Sunny Slope Road
Suite 110
Brookfield, Wisconsin 53005
WWW.PECLLC.COM



PLT Project No:
2009.07.00

State of Wisconsin
Department of Administration
Division of State Facilities

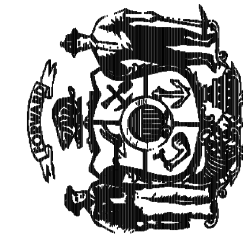

Agency / Institution:
UNIVERSITY OF WISCONSIN SYSTEM

CHARTER STREET HEATING
PLANT REBUILD
MADISON, WI
GDP BUILDING SECTIONS

Project Title:
Project Location:
Sheet Title:

Revisions:

No.	Date:	By:	Description:

Graphic Scale	
DSF Number	09A2L
Set Type	PR
Date Issued	03-10-10
Sheet Number	A302




Potter Lawson

Project No: 2009.07.00

State of Wisconsin
Department of Administration
Division of State Facilities

WISCONSIN SYSTEM

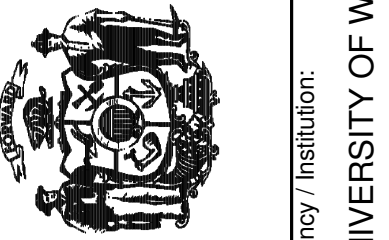

Agency / Institution:
UNIVERSITY C

CHARTER STREET HEATING PLANT REBUILD	
MADISON, WI	
GDP BUILDING SECTIONS	


Project Location:
Sheet Title:

visions:


[illegible]

aphic ale	
F mber	09A2L
t ce	PR
te ued	03-10-10
et mber	A303




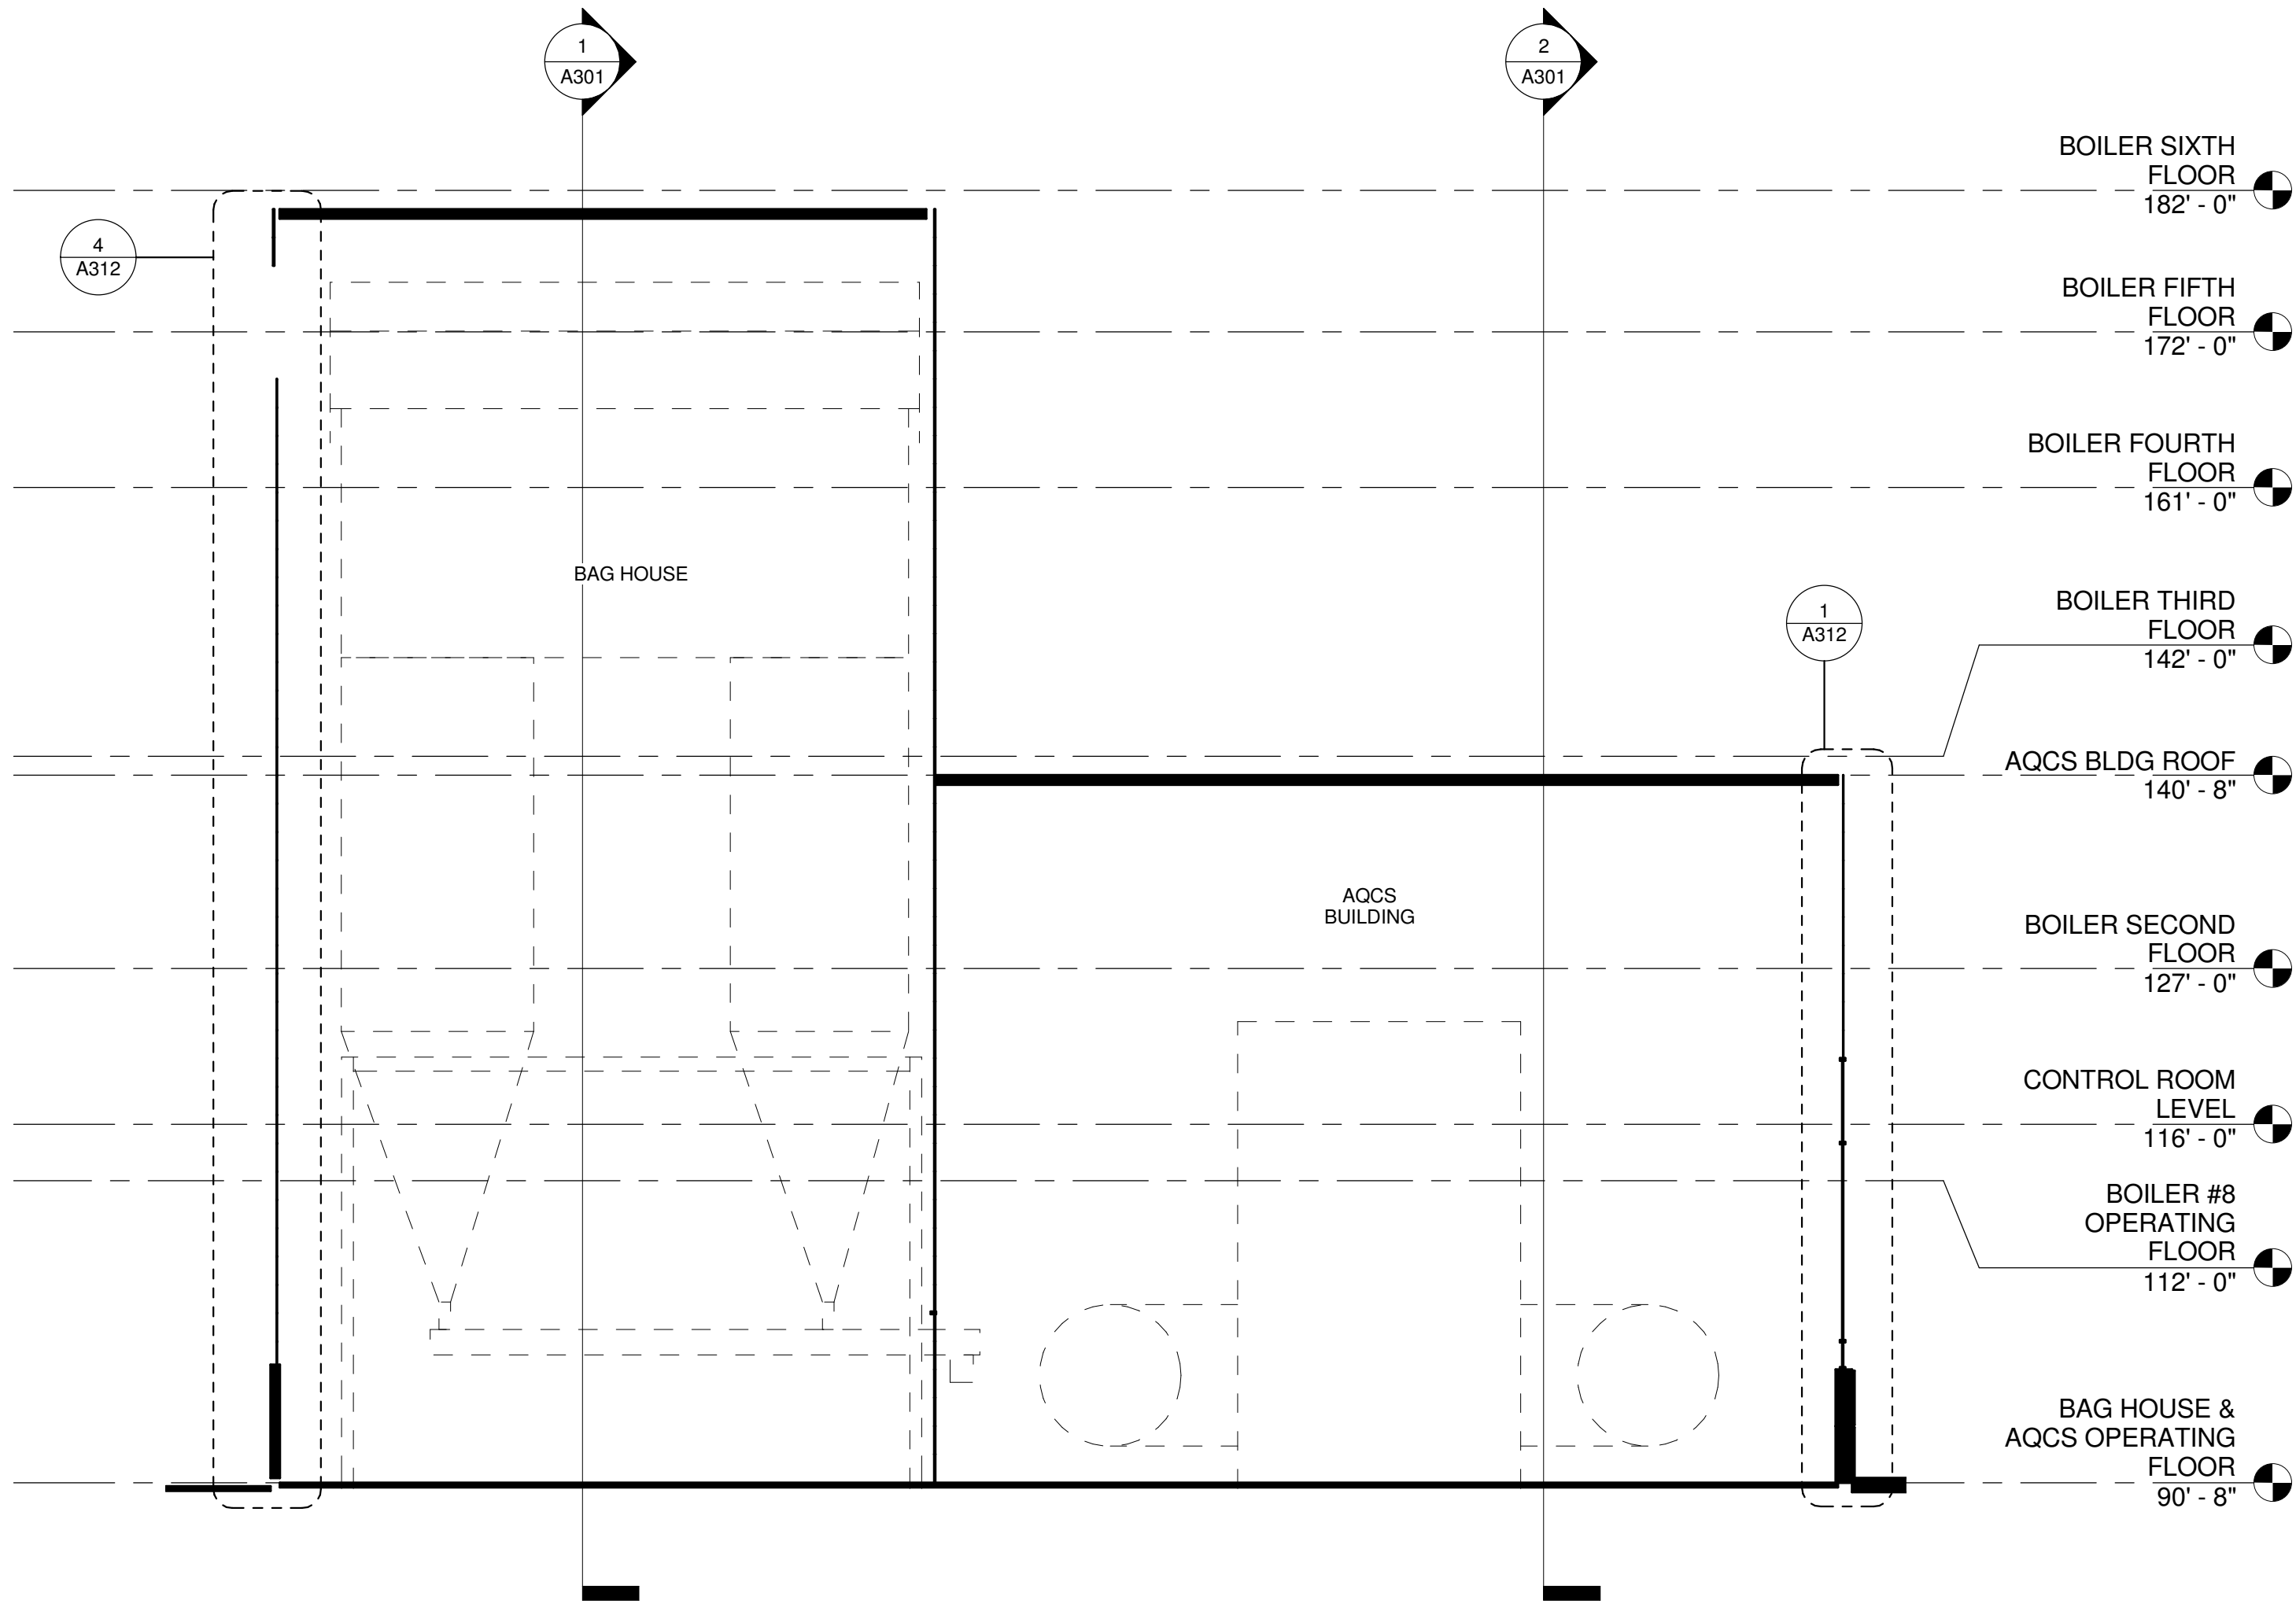

2
A304 **BAG HOUSE, AIR POLLUTION CONTROL BUILDING SECTION**
3/32" = 1'-0"

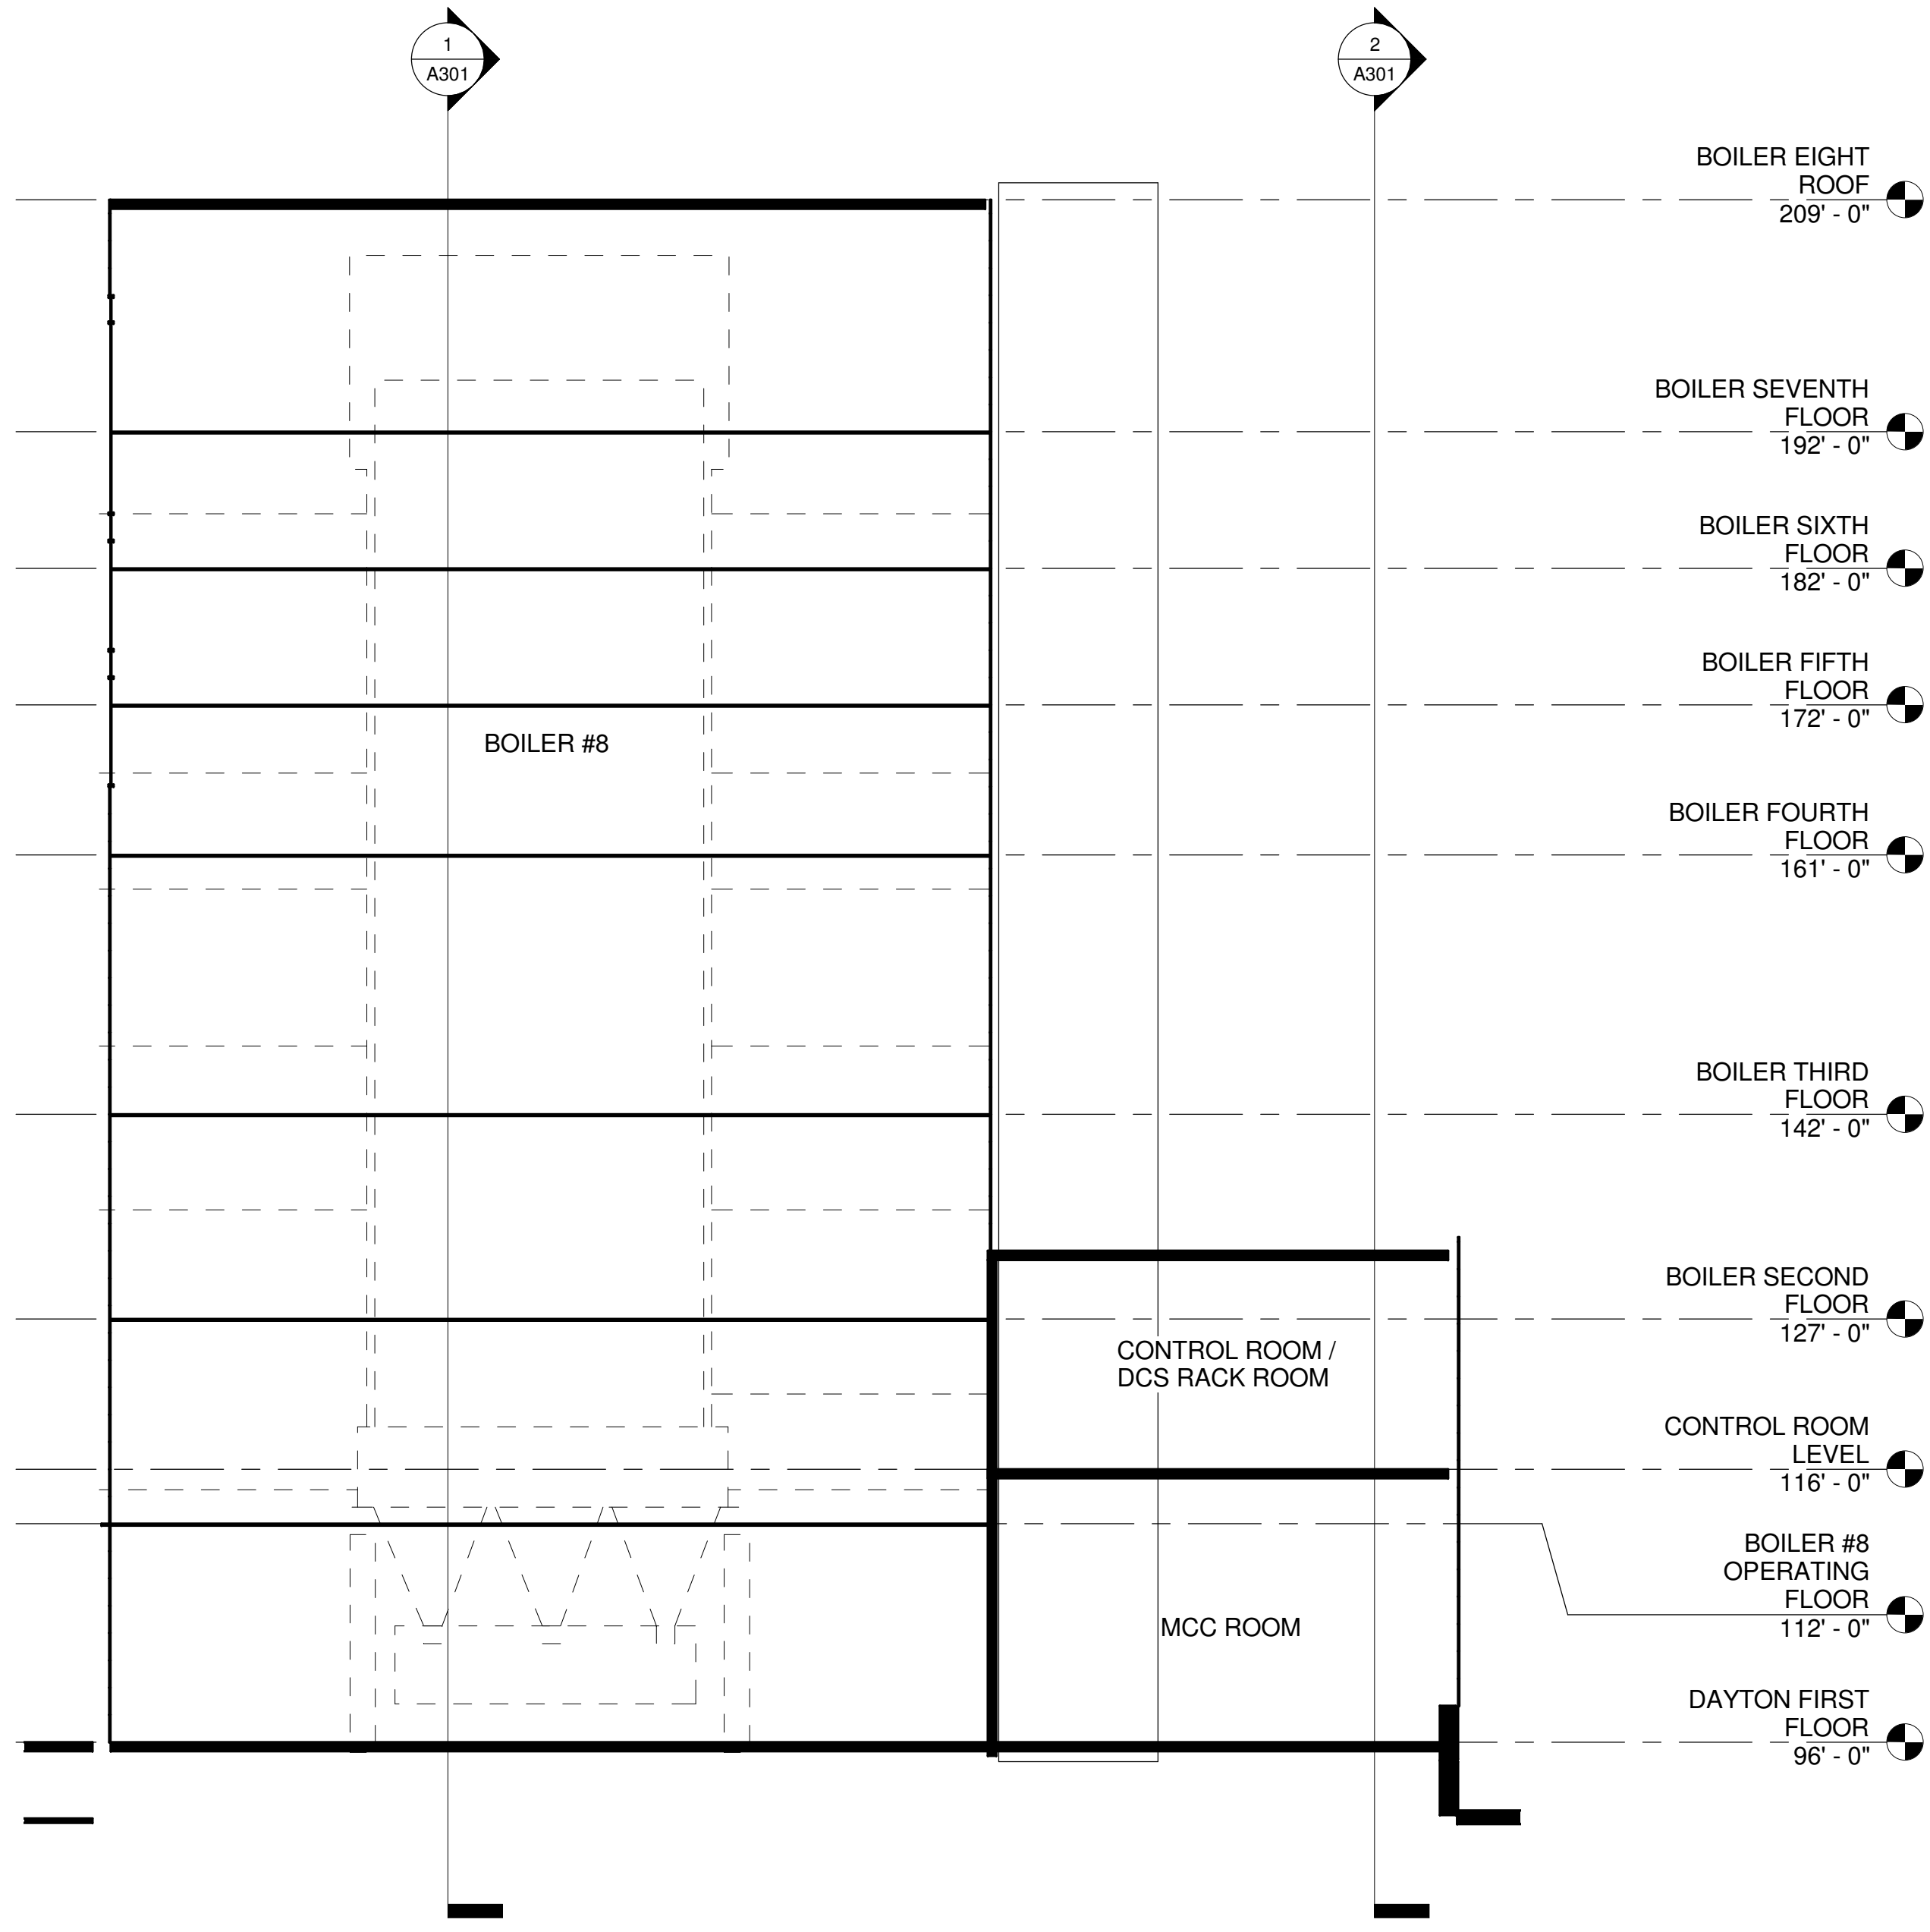

1
A304 **BOILER NO. SIX / CONTROL ROOM SECTION**
3/32" = 1'-0"

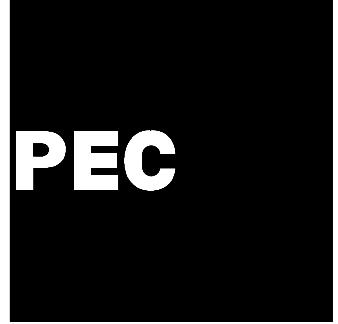


POWER ENGINEERS
COLLABORATIVE LLC
150 Sunny Slope Road
Suite 110
Brookfield, Wisconsin 53005
WWW.PECLLC.COM



PLT Project No:
2009.07.00

State of Wisconsin
Department of Administration
Division of State Facilities

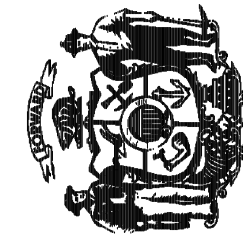

Agency / Institution:
UNIVERSITY OF WISCONSIN SYSTEM

**CHARTER STREET HEATING
PLANT REBUILD**
MADISON, WI
GDP BUILDING SECTIONS

Project Title:
Project Location:
Sheet Title:

Revisions:

No.	Date:	By:	Description:

Graphic Scale	
DSF Number	09A2L
Set Type	PR
Date Issued	03-10-10
Sheet Number	A304




middough

Potter Lawson

Project No:
2009.07.00

State of Wisconsin
 Department of Administration
 Division of State Facilities

WISCONSIN SYSTEM

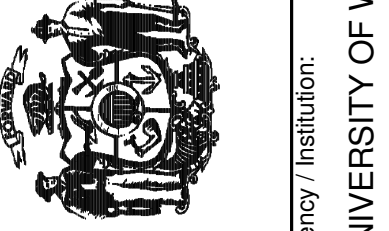

Agency / Institution:
UNIVERSITY OF CAMBRIDGE

CHARTER STREET HEATING
PLANT REBUILD

MADISON, WI

SDP BUILDING SECTIONS

Project Location:
Sheet Title:

visions:

[illegible]

aphic ale	


Number	09A2L
--------	-------


PR

te ued	03-10-10
-----------	----------

Sheet
Number

A305

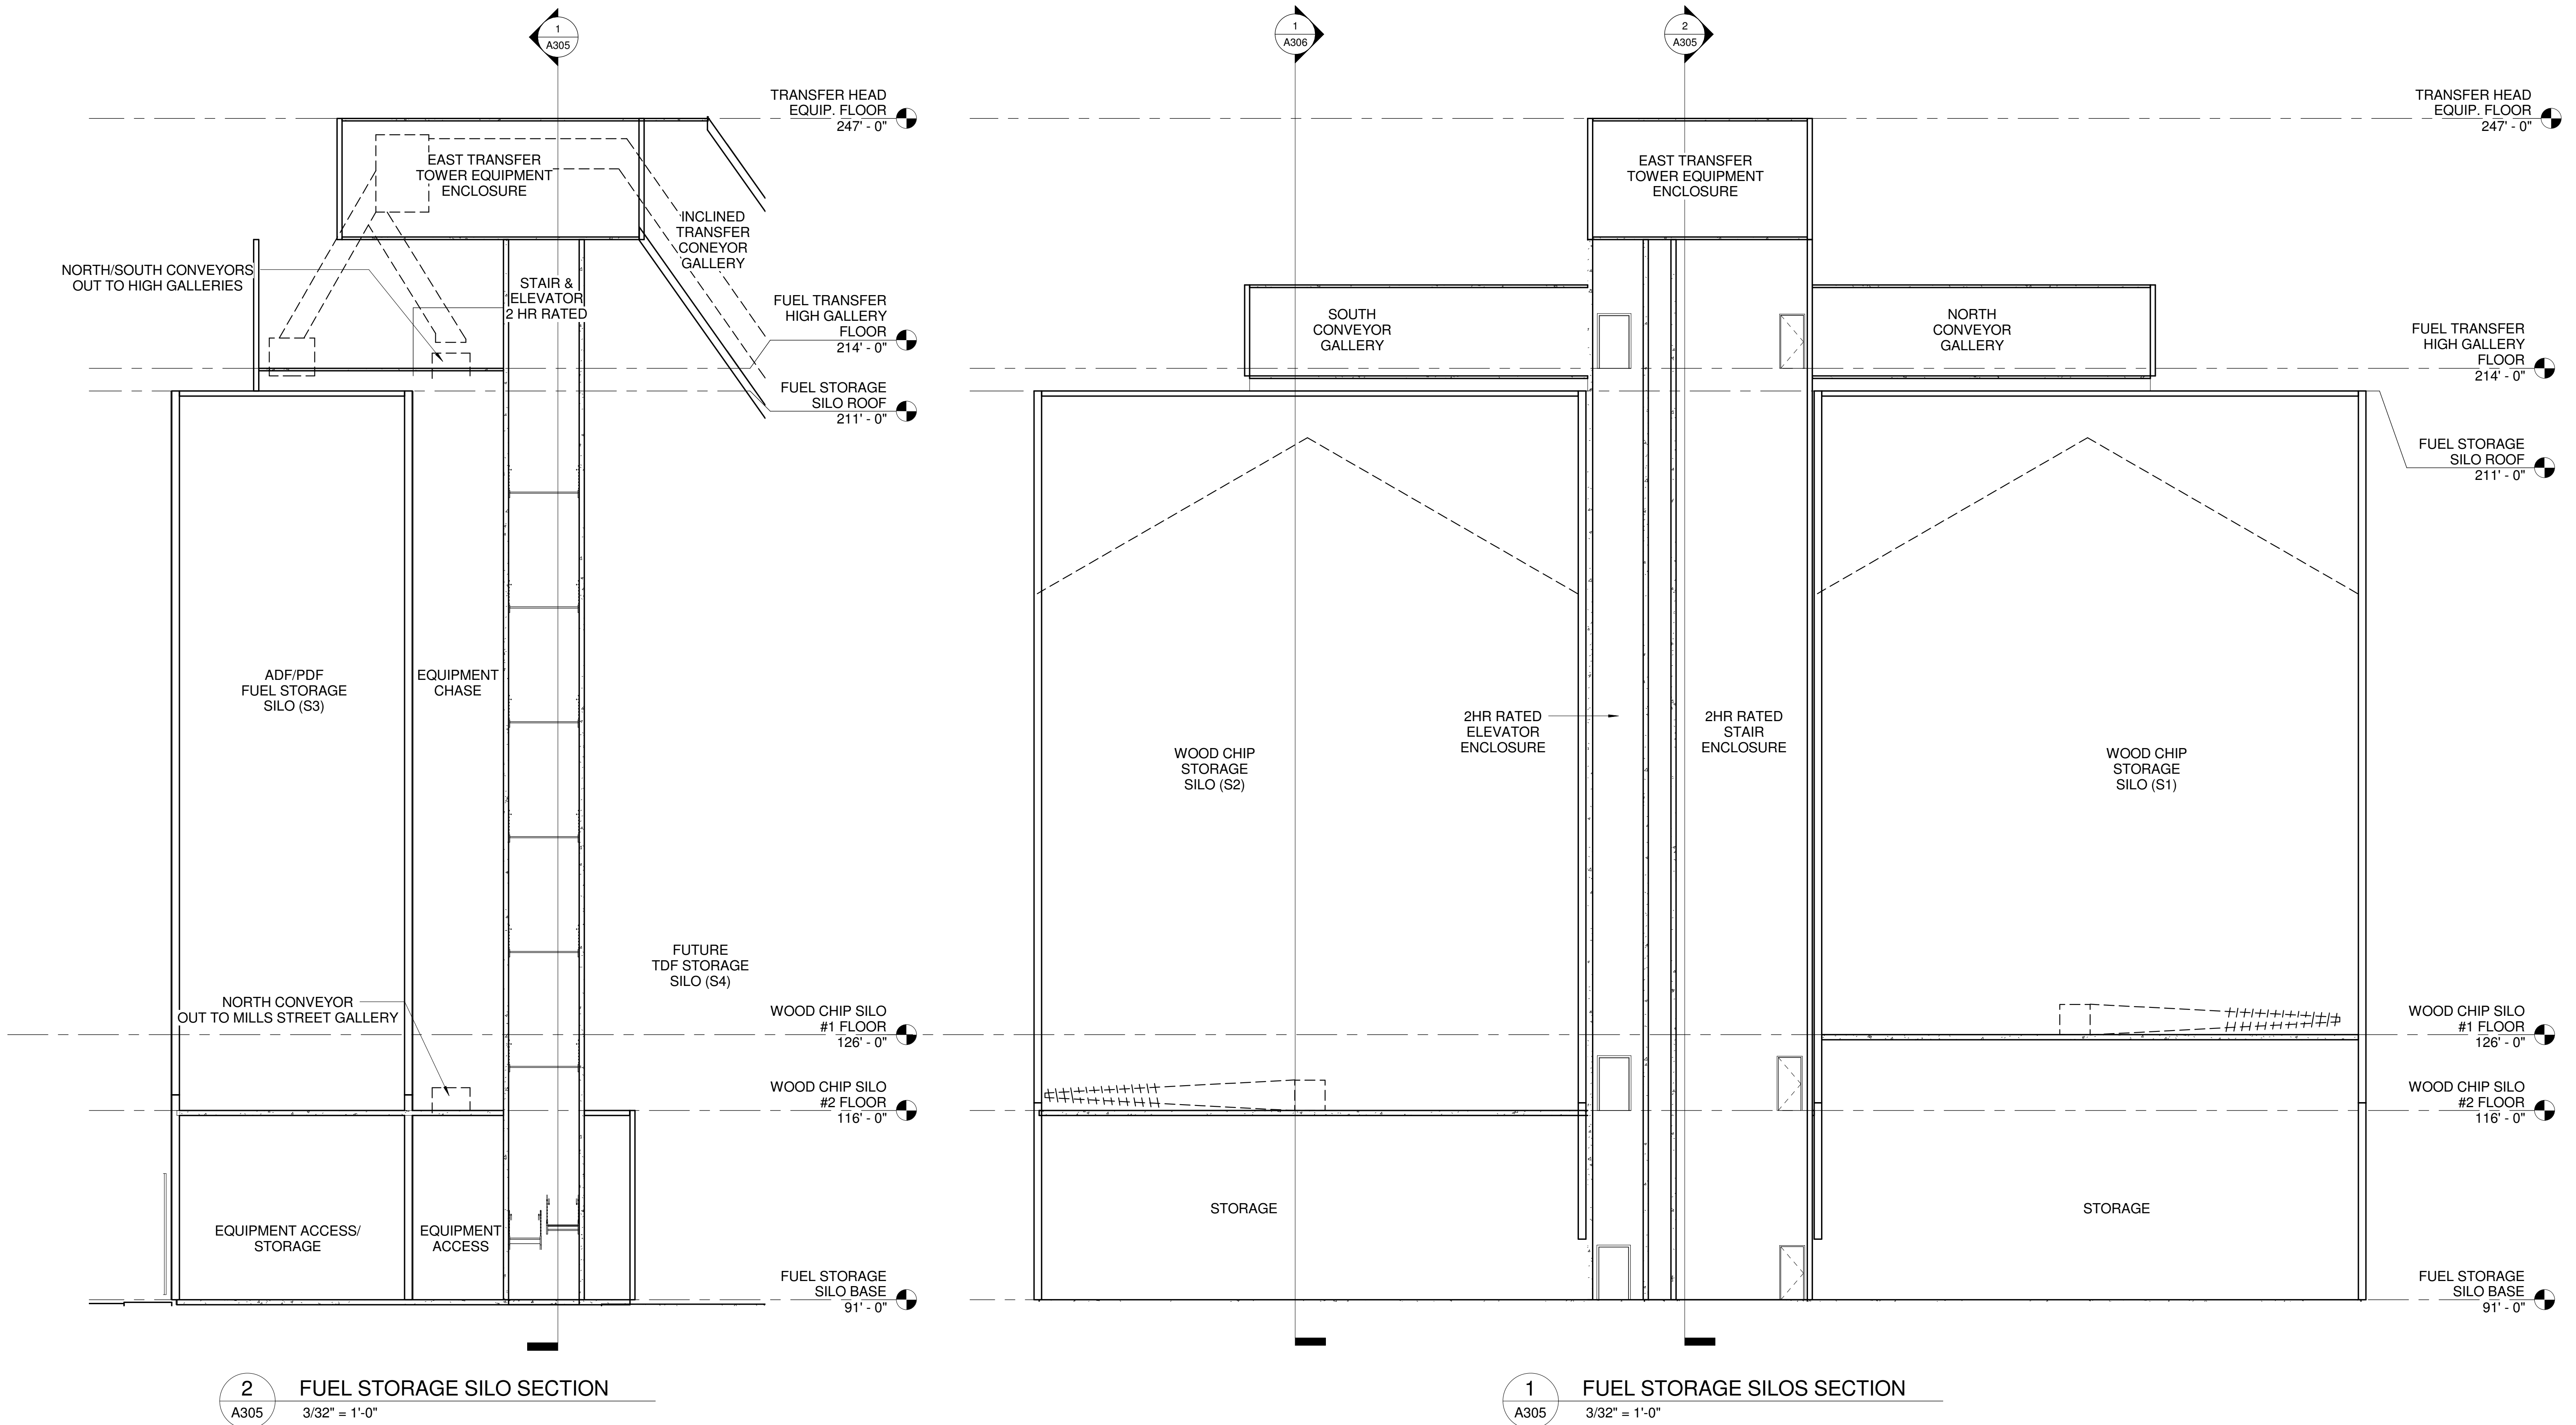

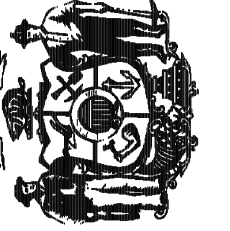

CHARTER STREET HEATING PLANT REBUILD

MADISON, WI

GDP BUILDING SECTIONS

visions:

[illegible]

graphic
ale

number

t
de

ued

et
mhor


9A2L

R


-10-10

A306




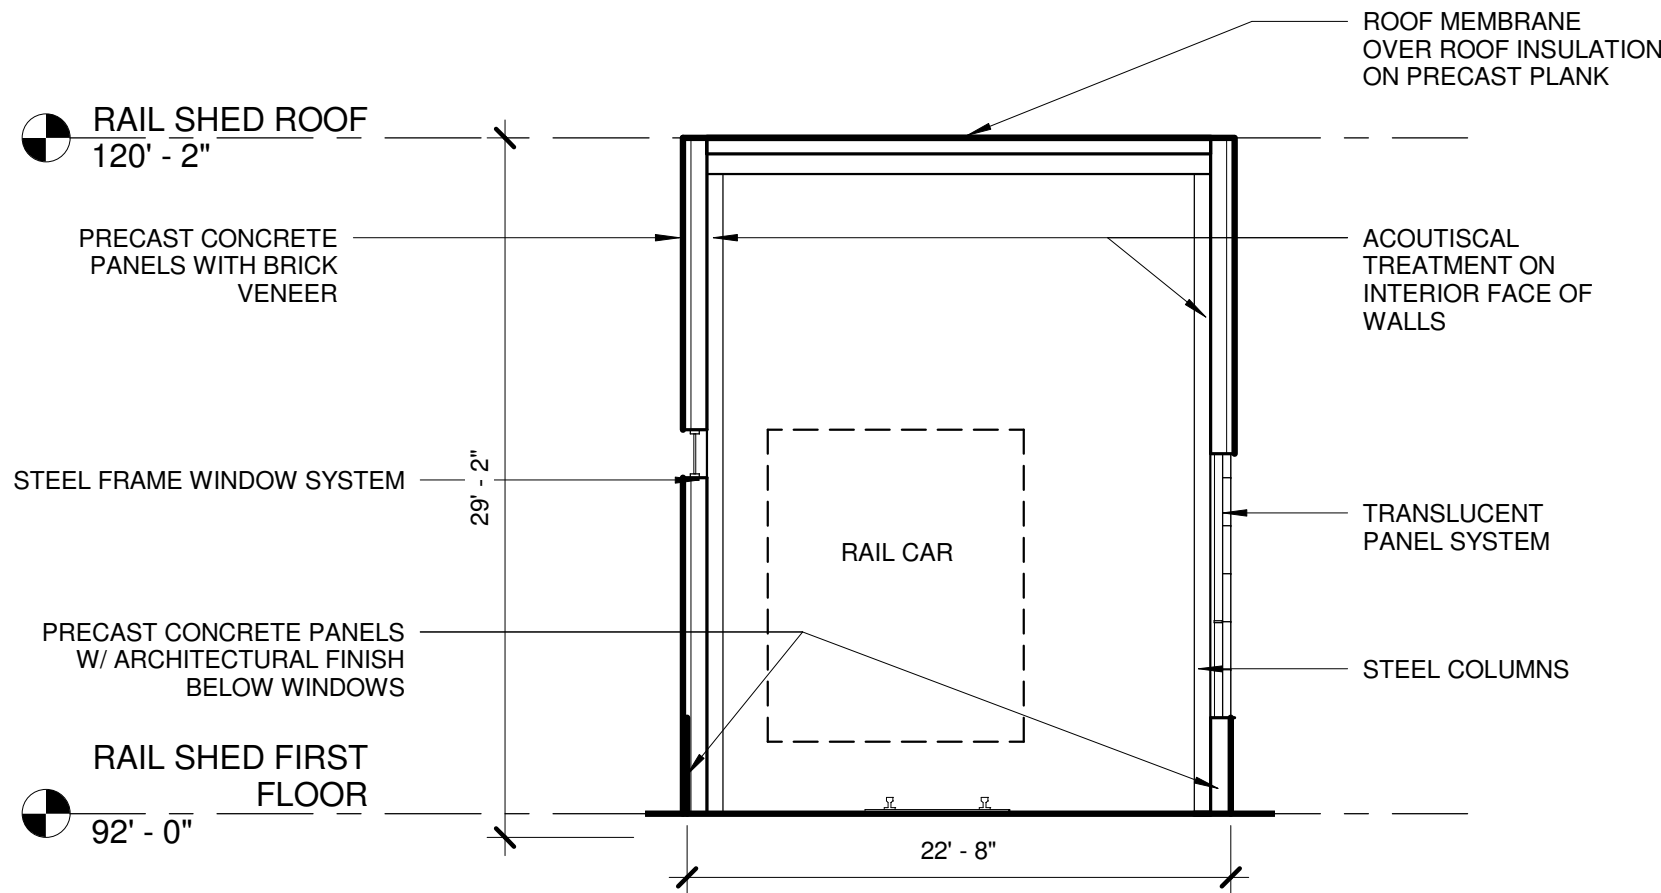

2 RAIL SHED SECTION
A307 1/8" = 1'-0"

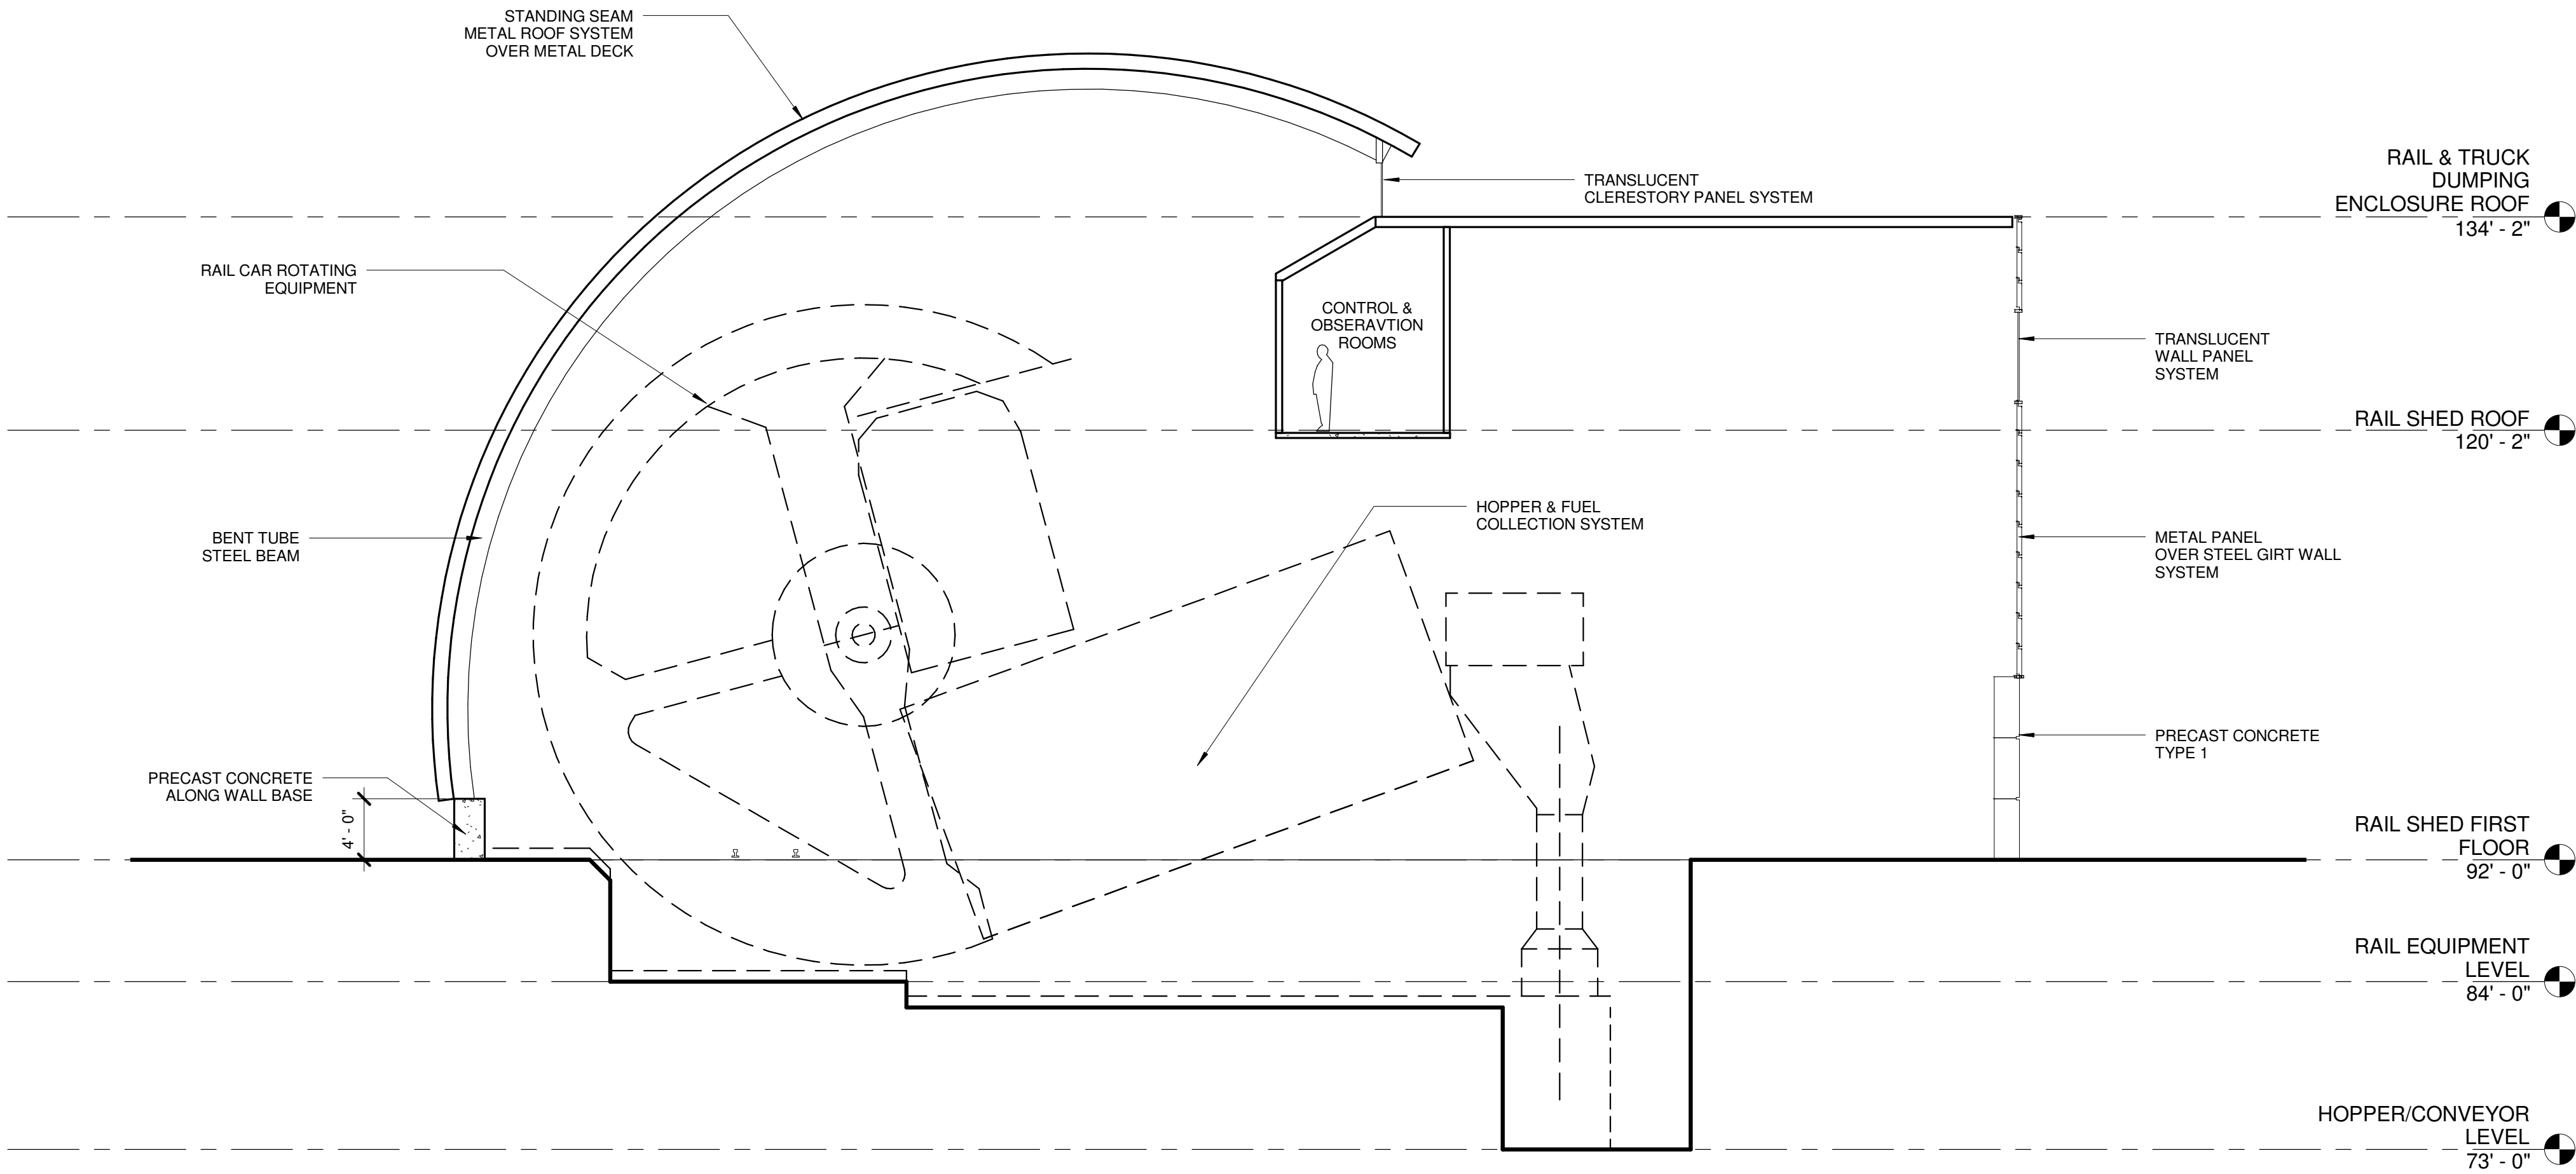

1 ROTARY DUMPER SECTION
A307 1/8" = 1'-0"

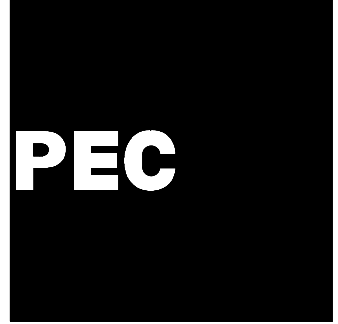


POWER ENGINEERS
COLLABORATIVE LLC
150 Sunny Slope Road
Suite 110
Brookfield, Wisconsin 53005
WWW.PECLLC.COM



PLT Project No:
2009.07.00

State of Wisconsin
Department of Administration
Division of State Facilities

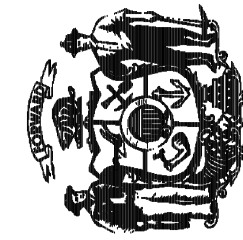

Agency/ Institution:
UNIVERSITY OF WISCONSIN SYSTEM


CHARTER STREET HEATING
PLANT REBUILD
MADISON, WI
GDP BUILDING SECTIONS

Project Title:
Project Location:
Sheet Title:

Revisions:

No.	Date:	By:	Description:

Graphic Scale	
DSF Number	09A2L
Set Type	PR
Date Issued	03-10-10
Sheet Number	A307

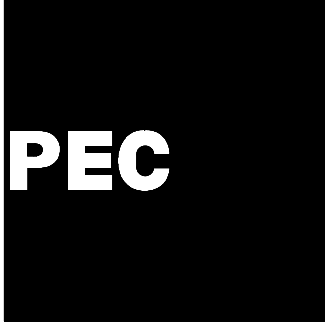


POWER ENGINEERS
COLLABORATIVE LLC
150 Sunny Slope Road
Suite 110
Brookfield, Wisconsin 53005
WWW.PECLLC.COM



PLT Project No:
2009.07.00

State of Wisconsin
Department of Administration
Division of State Facilities

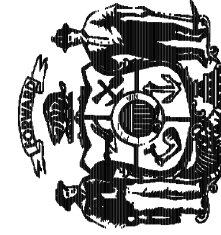

Agency / Institution:
UNIVERSITY OF WISCONSIN SYSTEM

CHARTER STREET HEATING
PLANT REBUILD

MADISON, WI

GDP WALL SECTIONS

Project Title:


Project Location:

Sheet Title:


Revisions:

No.	Date:	By:	Description:

Graphic Scale	
DSF Number	09A2L
Set Type	PR
Date Issued	03-10-10
Sheet Number	A311

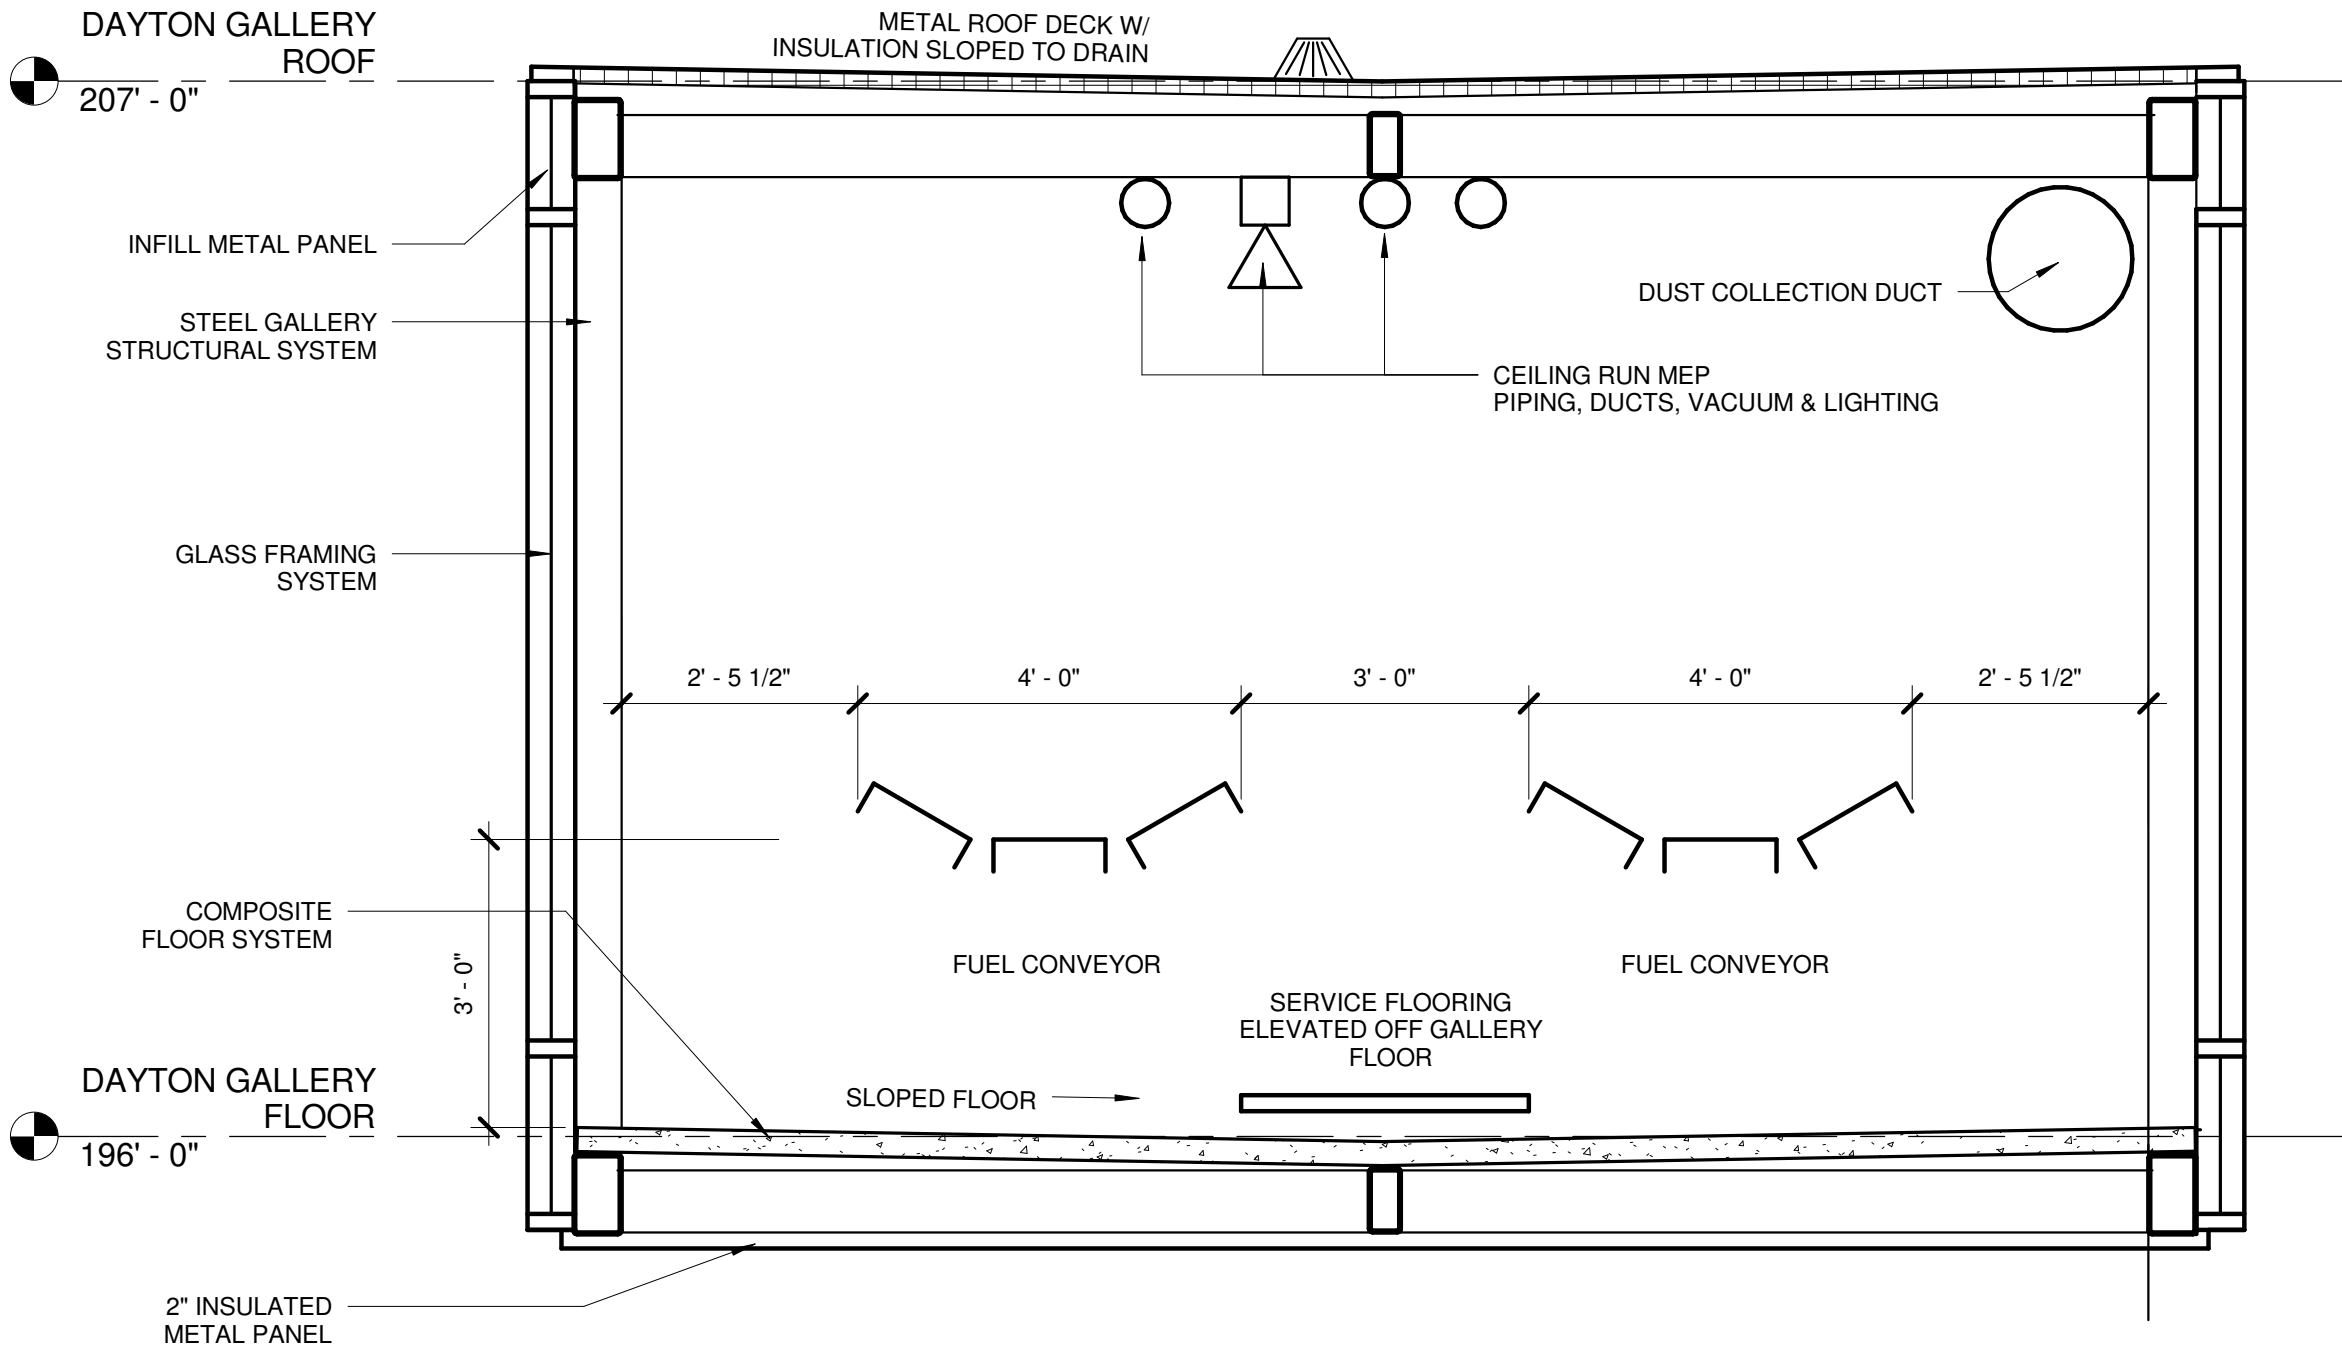

1 DAYTON STREET HIGH GALLERY
A311 1/2" = 1'-0"

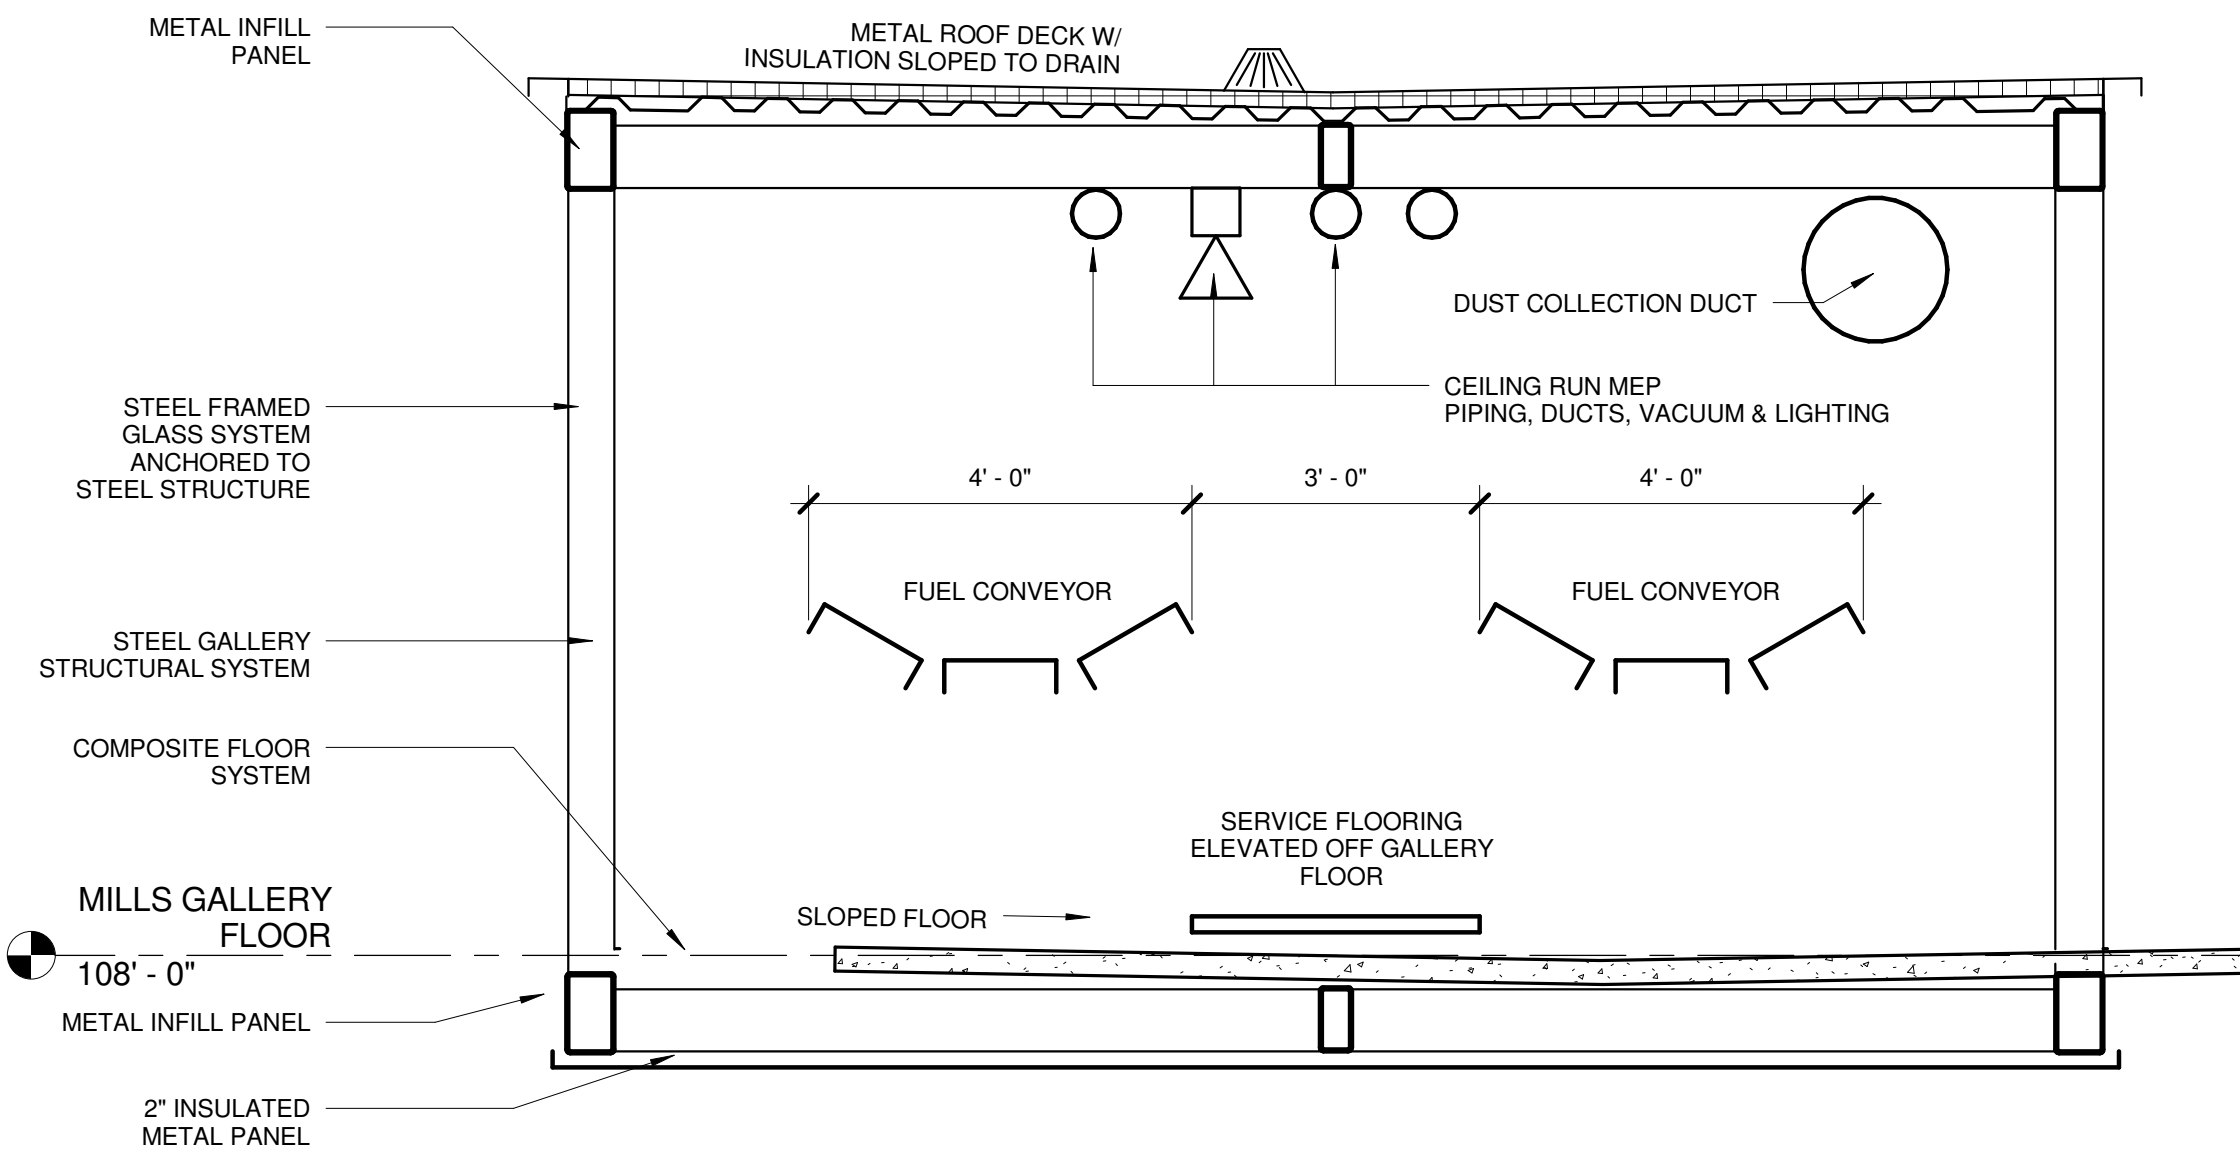

2 MILLS STREET GALLERY SECTION
A311 1/2" = 1'-0"