



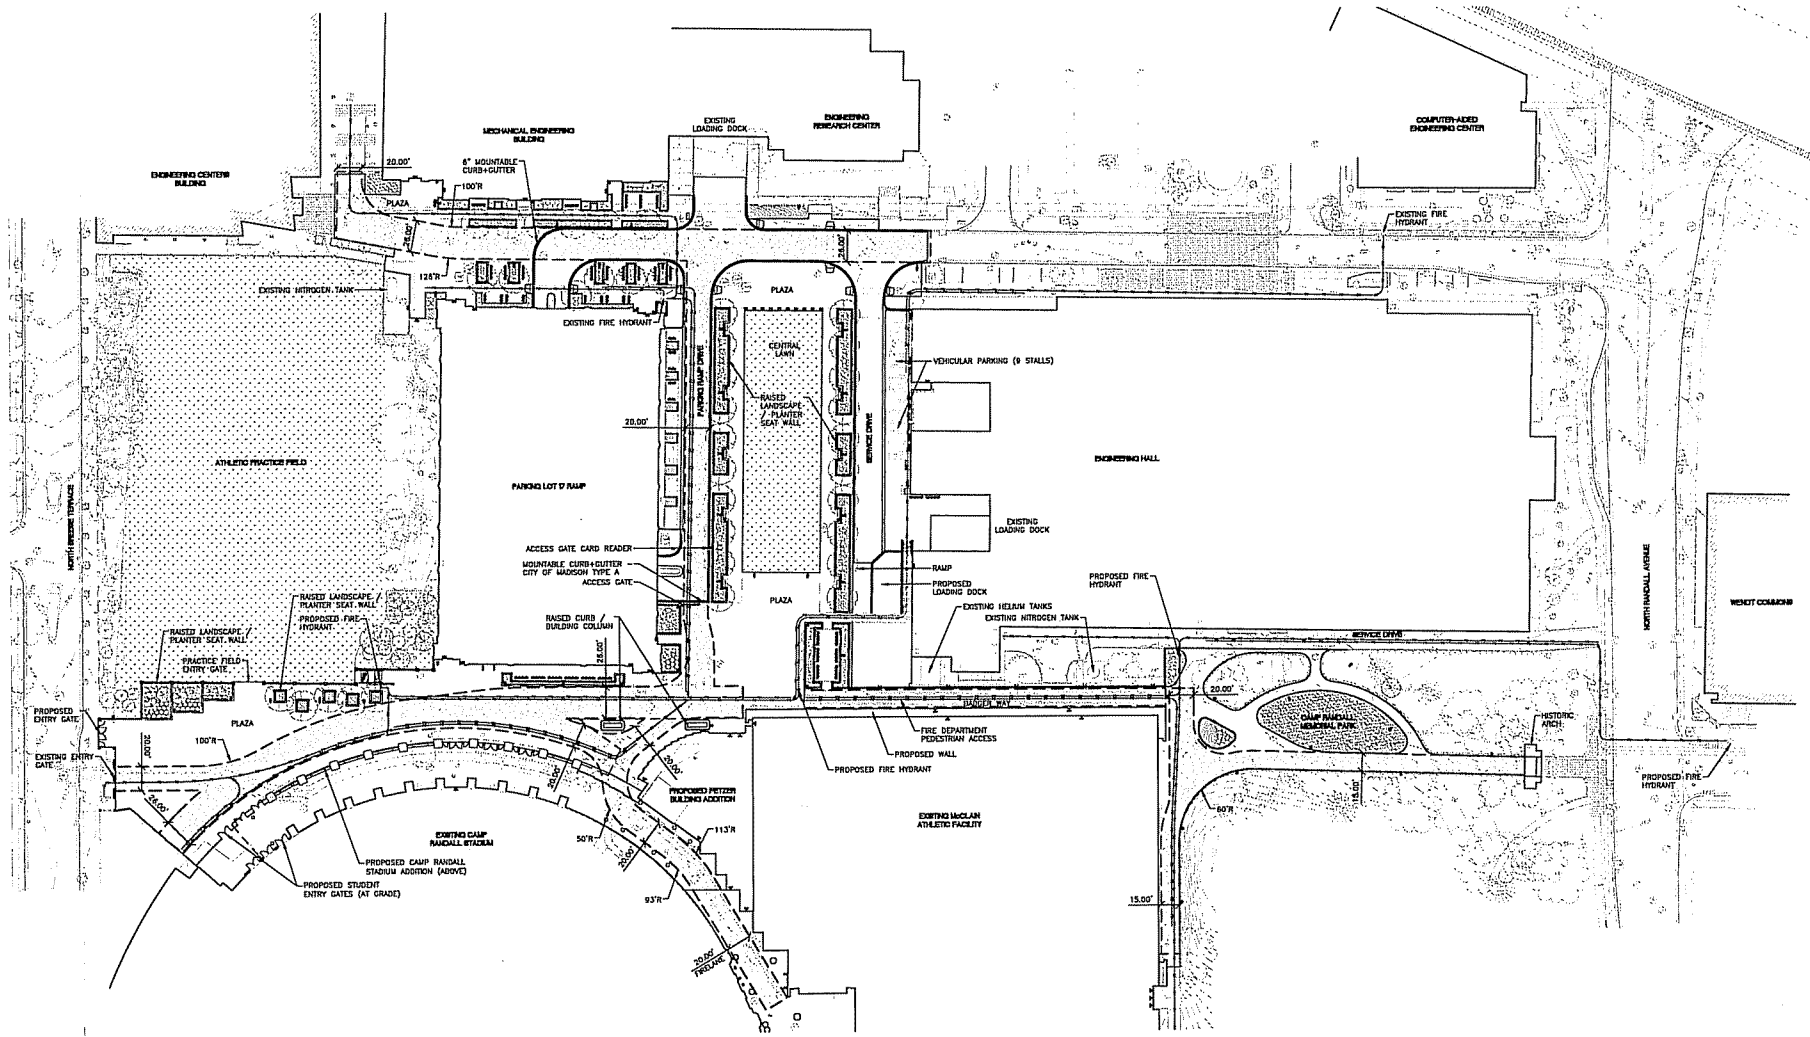


1 FIRE ACCESS PLAN

SCALE: 1" = 40'-0"

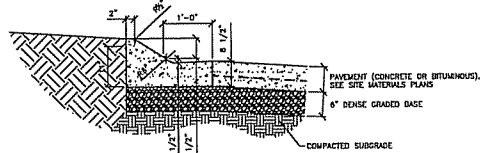

2 6" MOUNTABLE CURB + GUTTER

NOT TO SCALE

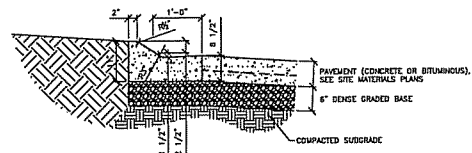

3 6" MOUNTABLE CURB + GUTTER - CITY OF MADISON TYPE A

NOT TO SCALE

LEGEND

- LIMITS OF CONSTRUCTION
- PROPOSED FIRE LANE
- PROPOSED PEDESTRIAN FIRE ACCESS
- FIRE HOSE LAY
- EXISTING FIRE HYDRANT
- PROPOSED FIRE HYDRANT

NOTES

1. CONTRACTOR SHALL CONTACT DIGGERS HOTLINE AND APPROPRIATE UTILITY COMPANIES TO FIELD VERIFY UTILITIES PRIOR TO ANY CONSTRUCTION.
2. LENGTH OF FIRE HOSES SHOWN DO NOT EXCEED 500 LINEAR FEET.
3. ALL FIRE LANE RADII ARE 30'-0" UNLESS OTHERWISE NOTED.



BERNERS & SCHOBER
architects + engineers + planners
1175 20

VOA
DATA





JJR
JJR LLC
 430 WILLIAMSHIRE STREET
 MADISON, WI 53703
 608.251.1177
 608.251.8117
 www.jjr.com

State of Wisconsin
 Department of Administration
 Division of State Facilities

1440 MONROE ST.
 MADISON, WI 53711

STUDENT ATHLETE PERFORMANCE CENTER
McCLELLAN CENTER REMODELING
 University of Wisconsin - Madison
 Madison, Wisconsin

Project No. 10133
 Sheet Title: Fire Access Plan
 Date: 12/28/14
 Designer: [blank]
 Checker: [blank]
 Engineer: [blank]
 Graphic Scale: 0' 10' 20' 40' 80'
 PDF Number: 10133A
 Set Type: PR
 Date Issued: 12/21/2011
 Sheet Number: G 102

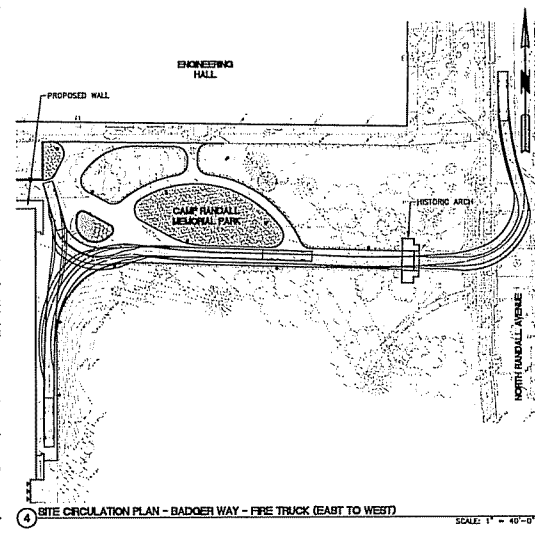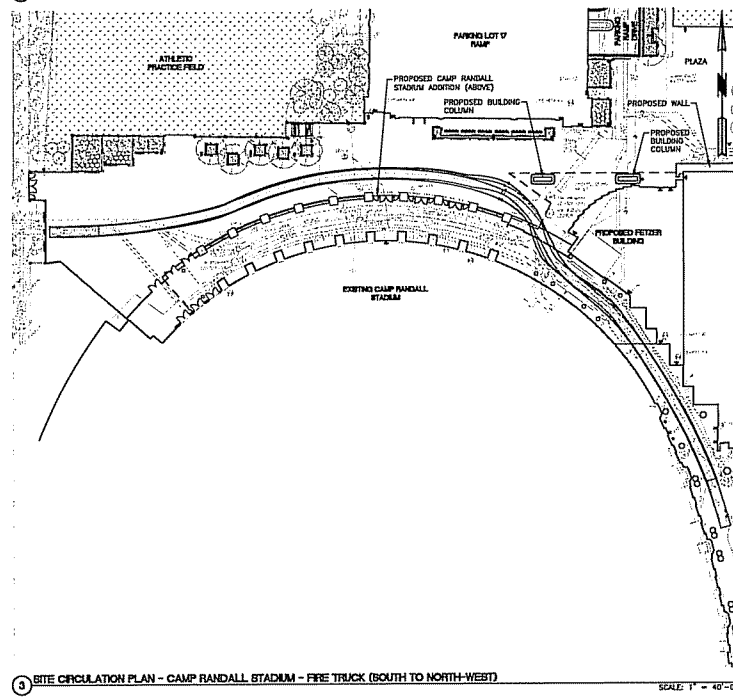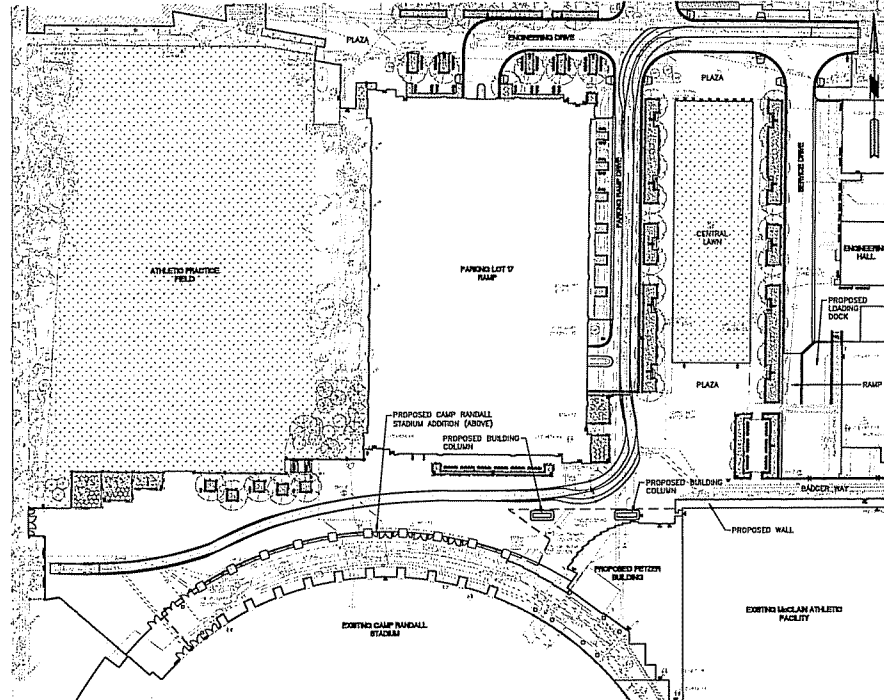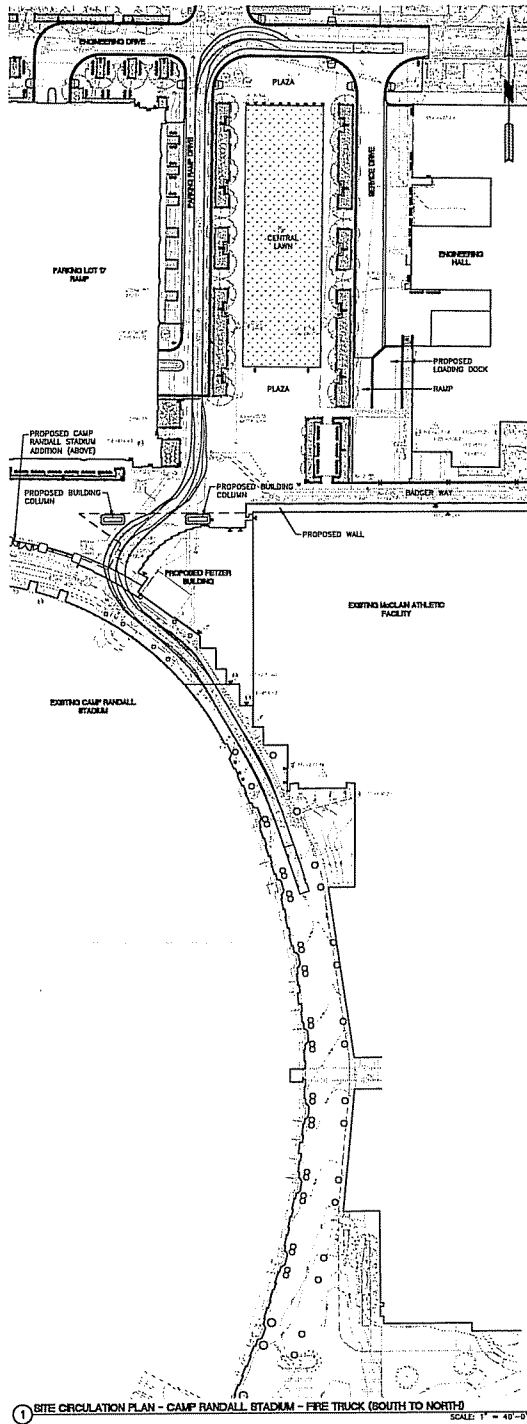


NOTES
1. CONTRACTOR SHALL CONTACT DIGGERS HOTLINE AND APPROPRIATE UTILITY COMPANIES TO FIELD VERIFY UTILITIES PRIOR TO ANY CONSTRUCTION.



 BERNERS & SCHOBERT ARCHITECTS + ENGINEERS + PLANNERS 1410 MONROE ST. MADISON, WI 53711	
 VOA VISIONARY OUTREACH ASSOCIATES	
JJR JAMES J. RYAN, LLC 425 WILLIAMSON STREET MADISON, WI 53703 608.251.1177 608.251.1177 www.jjr-llc.com	
State of Wisconsin Department of Administration Division of State Facilities 1410 MONROE ST. MADISON, WI 53711	
STUDENT ATHLETE PERFORMANCE CENTER McCLAIN CENTER REMODELING University of Wisconsin - Madison Madison, Wisconsin Project Title: _____ Revision: _____ No. 1 Date: 02/26/13 Designer: _____ 02/26/13 Plan Committee Graphic Scale: 0' 10' 20' 40' 80' BSF Number: 10H3A Set Type: PR Date Issued: 12/21/2011 Sheet Number: G 103	



 SCALE: 1" = 20'-0"




SCALE: 1" = 20'-0"



now what's below.
Call before you dig.

 [illegible]



SCALE: 1" = 20'-0"




SCALE: 1" = 20'-0"



SCALE: 1" = 20'



																																																																																																																																																																																									
---	--	---	--	---	--	---	--	---	--	---	--	--	--	---	--	---	--	--	
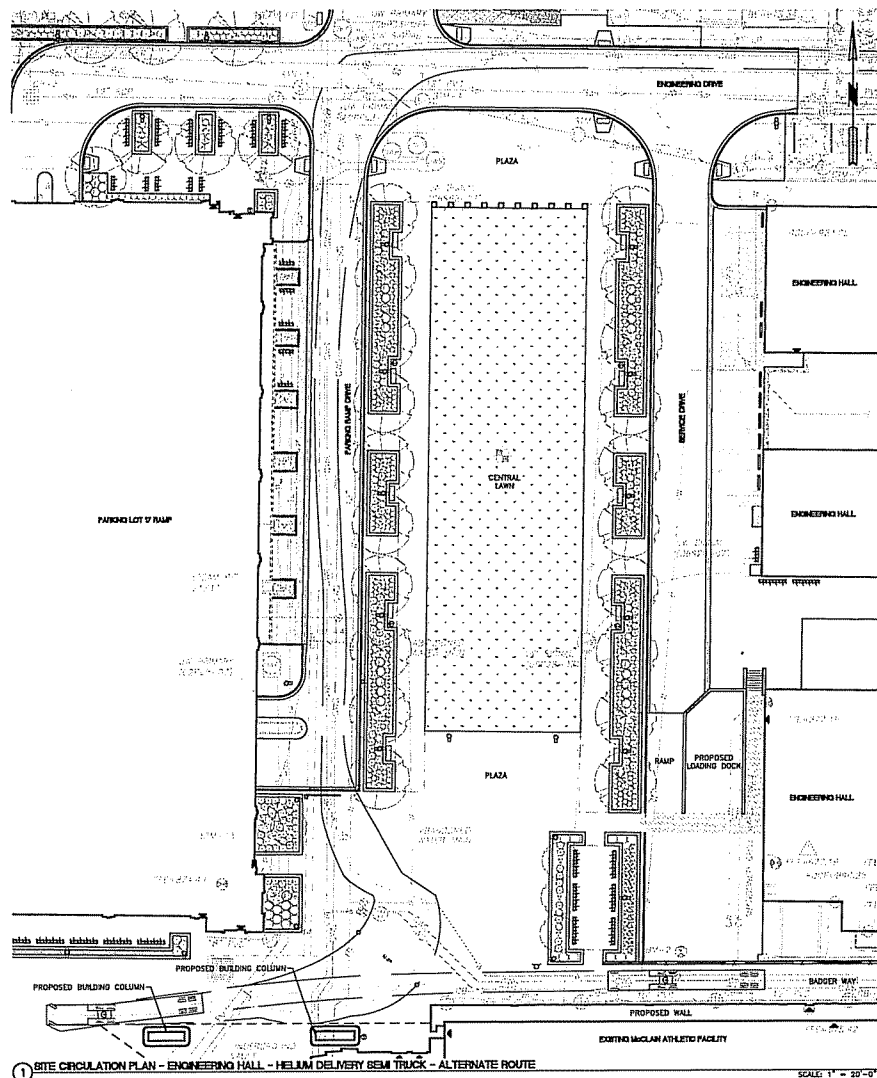





NOTES:

1. CONTRACTOR SHALL CONTACT DIGGERS HOTLINE AND APPROPRIATE UTILITY COMPANIES TO FIELD VERIFY UTILITIES PRIOR TO ANY CONSTRUCTION.



Know what's below.
Call before you dig.

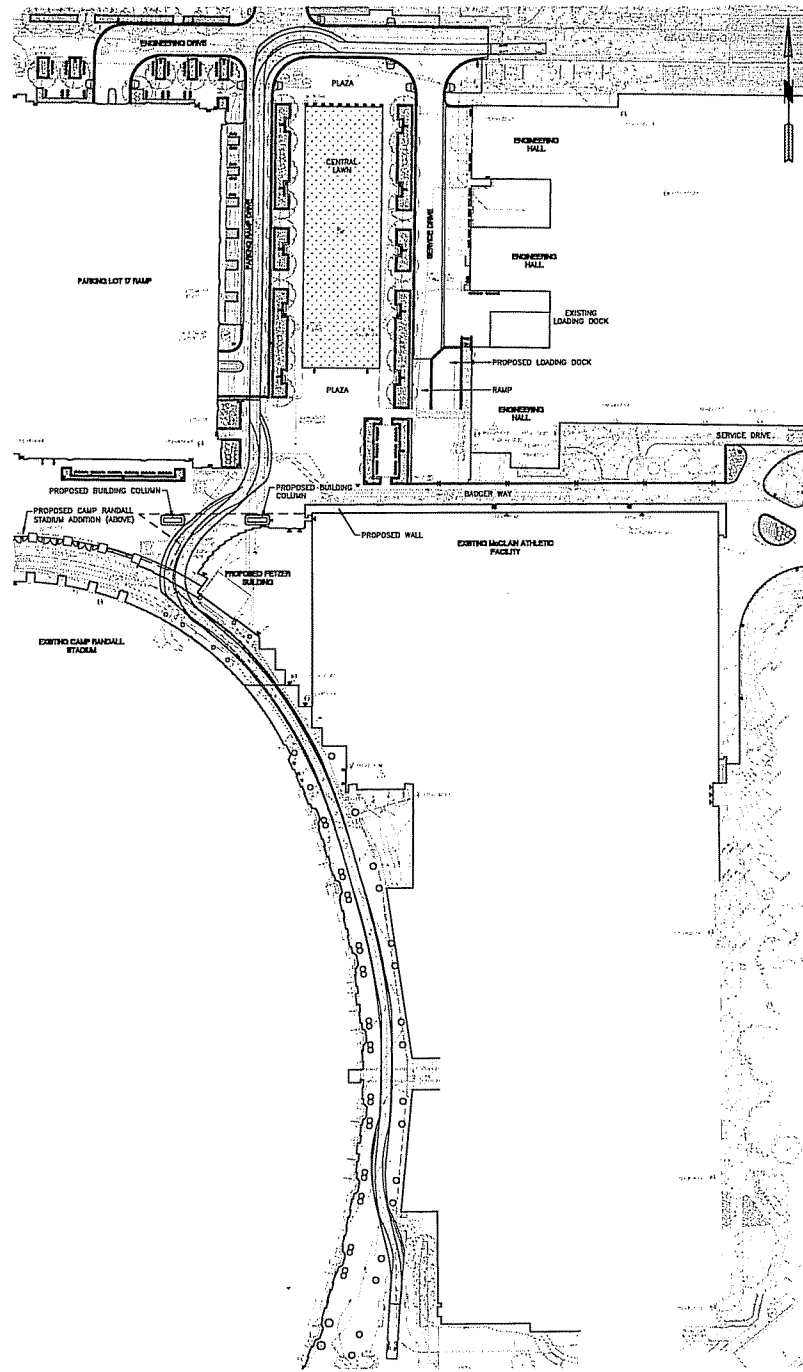

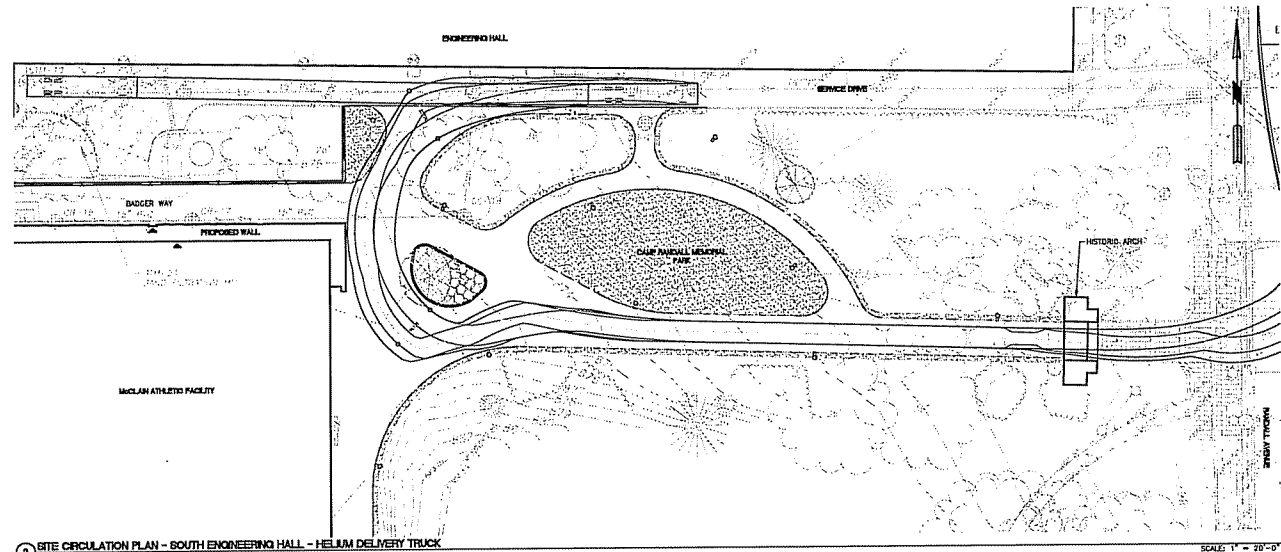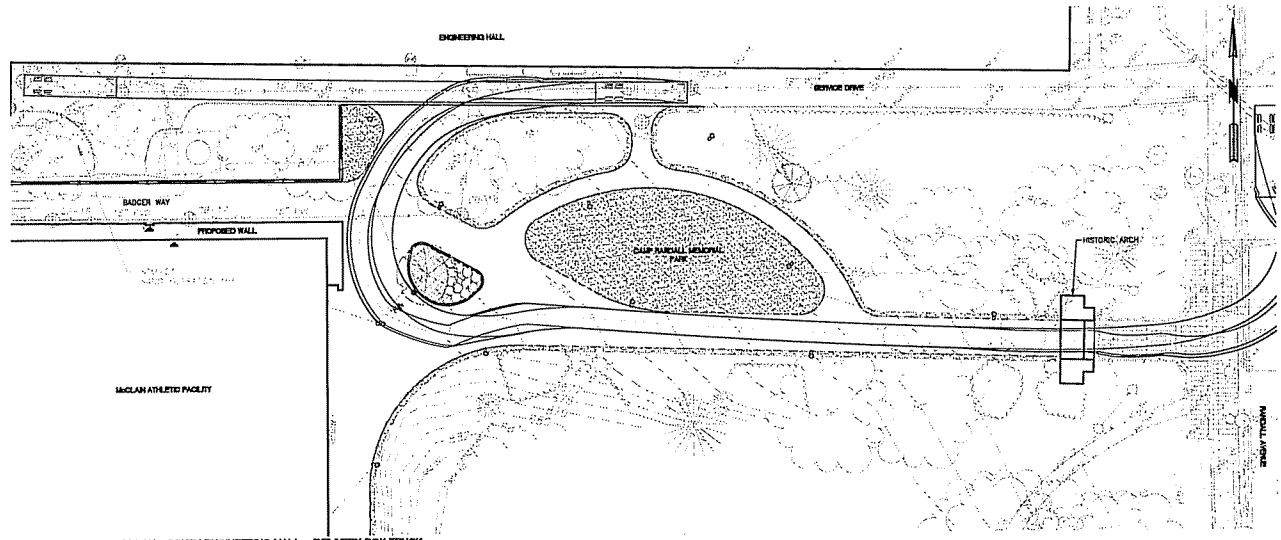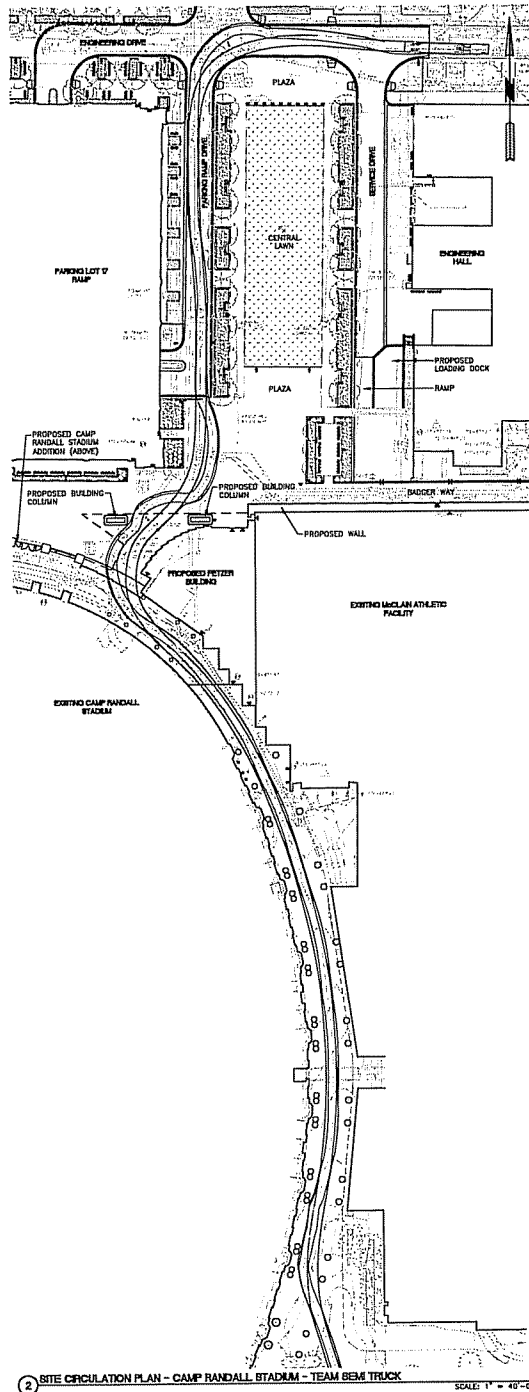

NOTES

1. CONTRACTOR SHALL CONTACT DIGGERS HOTLINE AND APPROPRIATE UTILITY COMPANIES TO FIELD VERIFY UTILITIES PRIOR TO ANY CONSTRUCTION.




Know what's below.
Call before you dig.

PROJECT: STUDENT ATHLETE PERFORMANCE CENTER
McCLAIN CENTER REMODELING
University of Wisconsin - Madison
Madison, Wisconsin

Sheet: 107
Site Circulation Plan

Revision	Date	Description
1	12/21/11	Plan Generation

Graphic Scale	0' 10' 20' 40' 60'
DIST. Number	10H3A
Set Type	PR
Date Issued	12/21/2011
Sheet Number	G 107

 

State of Wisconsin
Department of Administration
Division of State Facilities


1440 MONROE ST.
MADISON, WI 53711

JJR LLC
100 WILKINSON STREET
MADISON, WI 53703
608.261.1177
www.jjr.com

VOA
DATA

SWARTZMAN
ARCHITECTS

BERNERS
SCHROEDER
and Associates
ENGINEERING & ARCHITECTS
LTD.

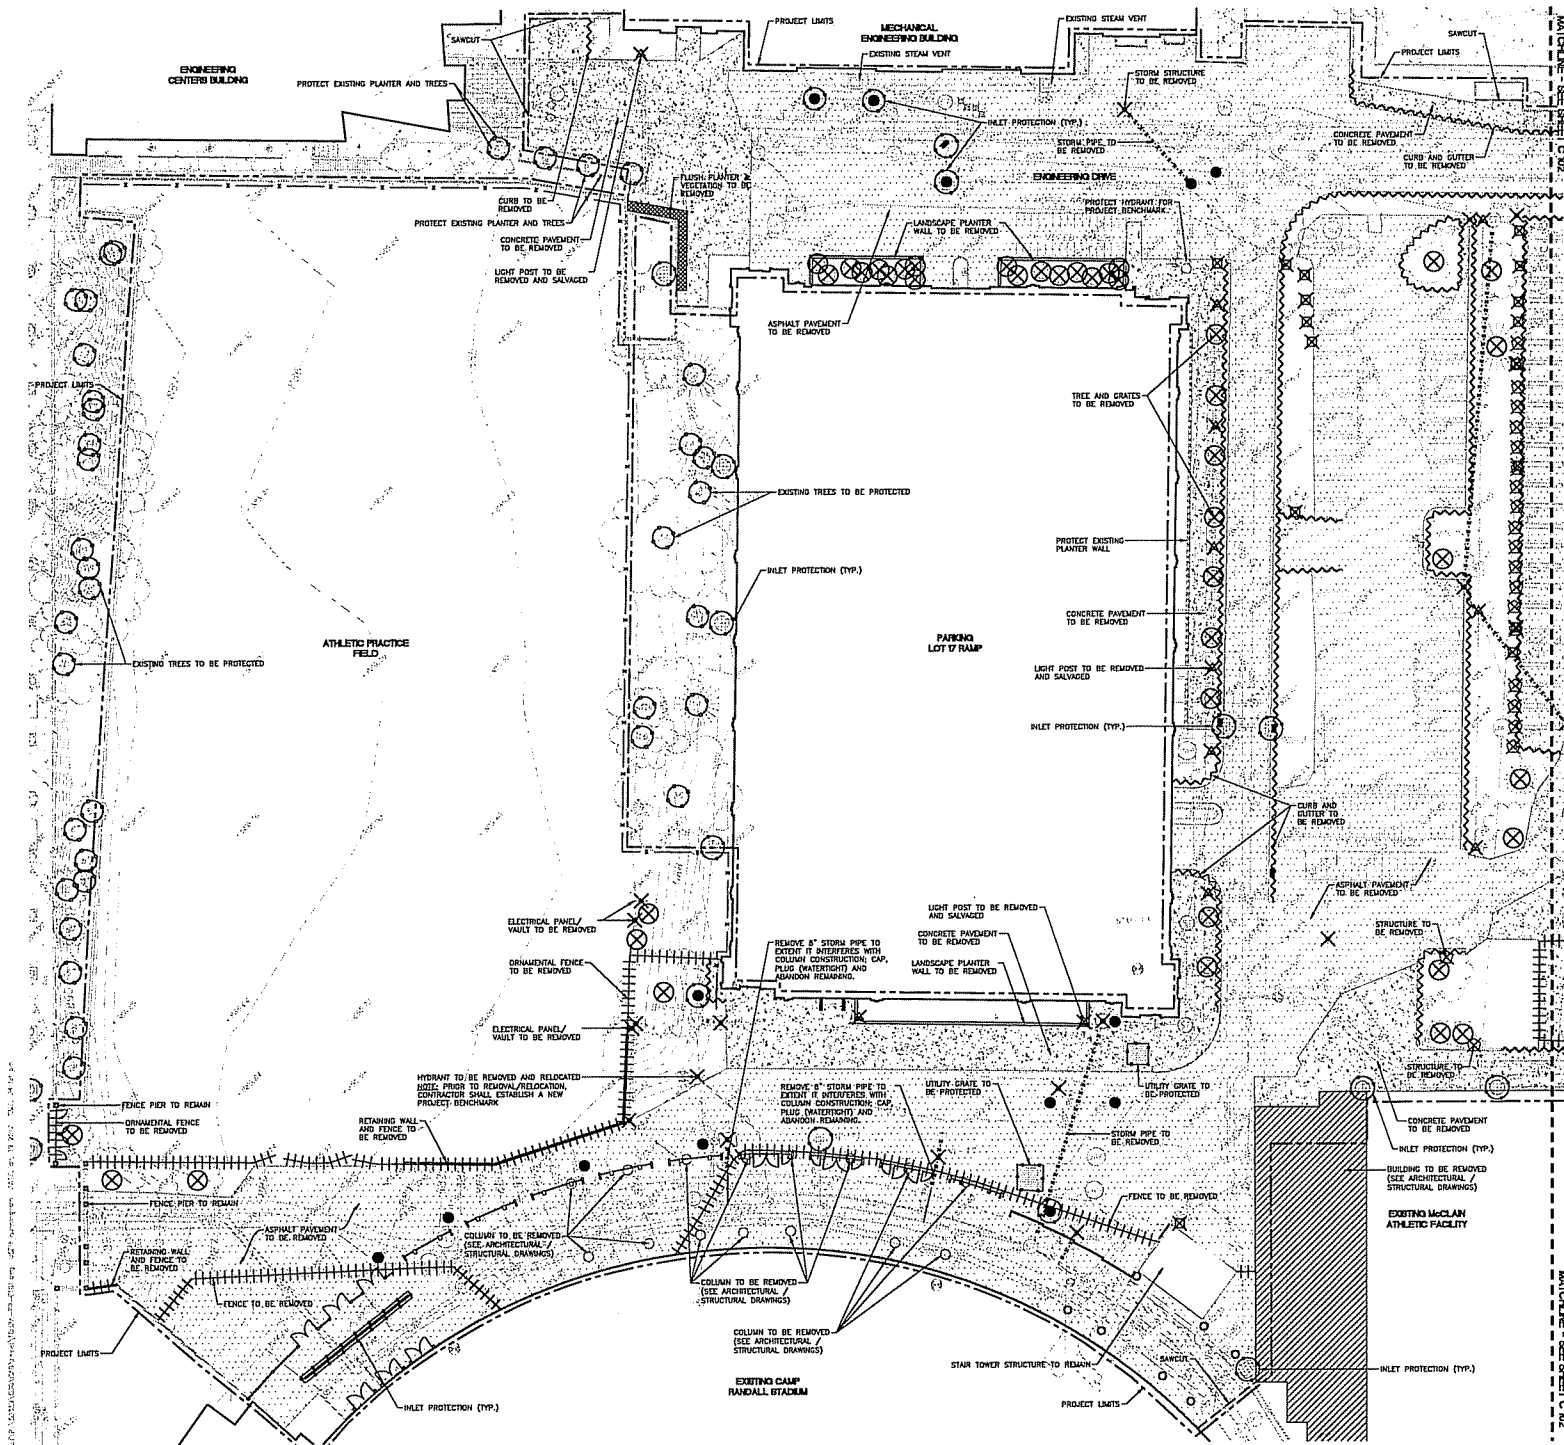

LEGEND:

- CONCRETE PAVEMENT TO BE REMOVED
- STANDARD PAVEMENT TO BE REMOVED
- BUILDING/STRUCTURE TO BE REMOVED
- MISCELLANEOUS ITEMS TO BE REMOVED
- CURB & GUTTER TO BE REMOVED
- RETAINING WALL TO BE REMOVED
- FENCE TO BE REMOVED
- VEGETATION TO BE REMOVED
- LIGHT POLE TO BE REMOVED AND SALVAGED
- UTILITY STRUCTURE TO BE REMOVED
- SIGN TO BE REMOVED AND SALVAGED
- UTILITY LINE TO BE REMOVED
- UTILITY LINE TO BE ABANDONED
- SANICUT
- SET FENCE, SEE DETAIL
- INLET PROTECTION, SEE DETAIL
- TREE PROTECTION, SEE DETAIL
- STONE TRACKING PAD, SEE DETAIL

- NOTES:**
- CONTRACTOR SHALL CONTACT ENGINEERS NOTIFIED AND APPROPRIATE UTILITY COMPANIES TO FIELD VERIFY UTILITIES PRIOR TO ANY CONSTRUCTION.
 - SEE EXISTING CONDITIONS PLAN V 101 FOR LEGEND OF EXISTING FEATURES AND PROJECT CONTROL BENCHMARKS AND CONTROL MONUMENTS.
 - CONTRACTOR SHALL PROTECT ALL UTILITIES AND SITE FEATURES UNLESS OTHERWISE SHOWN TO BE REMOVED OR ABANDONED.
 - ITEMS SALVAGED ON UNIVERSITY PROPERTY SHALL REMAIN THE PROPERTY OF THE UNIVERSITY UNLESS OTHERWISE NOTED.
 - ALL SITE EROSION CONTROL MEASURES SHALL BE MAINTAINED BY CONTRACTOR, AND SHALL BE REPAIRED OR REPLACED AS NEEDED TO SERVE INTENDED FUNCTION.
 - ALL SITE EROSION CONTROL DEVICES SHALL BE INSTALLED PRIOR TO LAND DISTURBANCE IN UP-GRADIENT AREAS.
 - CONTRACTOR IS RESPONSIBLE FOR REMOVAL OF ALL CONSTRUCTION AND EROSION CONTROL FENCING AT PROJECT COMPLETION.
 - CONTRACTOR SHALL CLEAN ROAD SURFACES THROUGHOUT THE DAY TO PREVENT TRACKING OF MATERIALS OFF SITE.

BERNERS & SCHOBER
INCORPORATED
1410 MONROE ST.
MADISON, WI 53711

JJR
JAMES J. RYAN
1410 MONROE STREET
MADISON, WI 53711
608.251.8100
www.jjr.com


State of Wisconsin
Department of Administration
Division of State Facilities

**1410 MONROE ST.
MADISON, WI 53711**

**STUDENT ATHLETE PERFORMANCE CENTER
McCLAIN CENTER REMODELING
University of Wisconsin - Madison
Madison, Wisconsin**

Project Title: _____
Revision: _____
No. _____ Date: 12/26/11 Per: _____
Graphic Scale: 0' 5' 10' 20' 30'
DOT Number: 10H3A
Sht Type: PR
Date Issued: 12/21/2011
Sheet Number: C 101



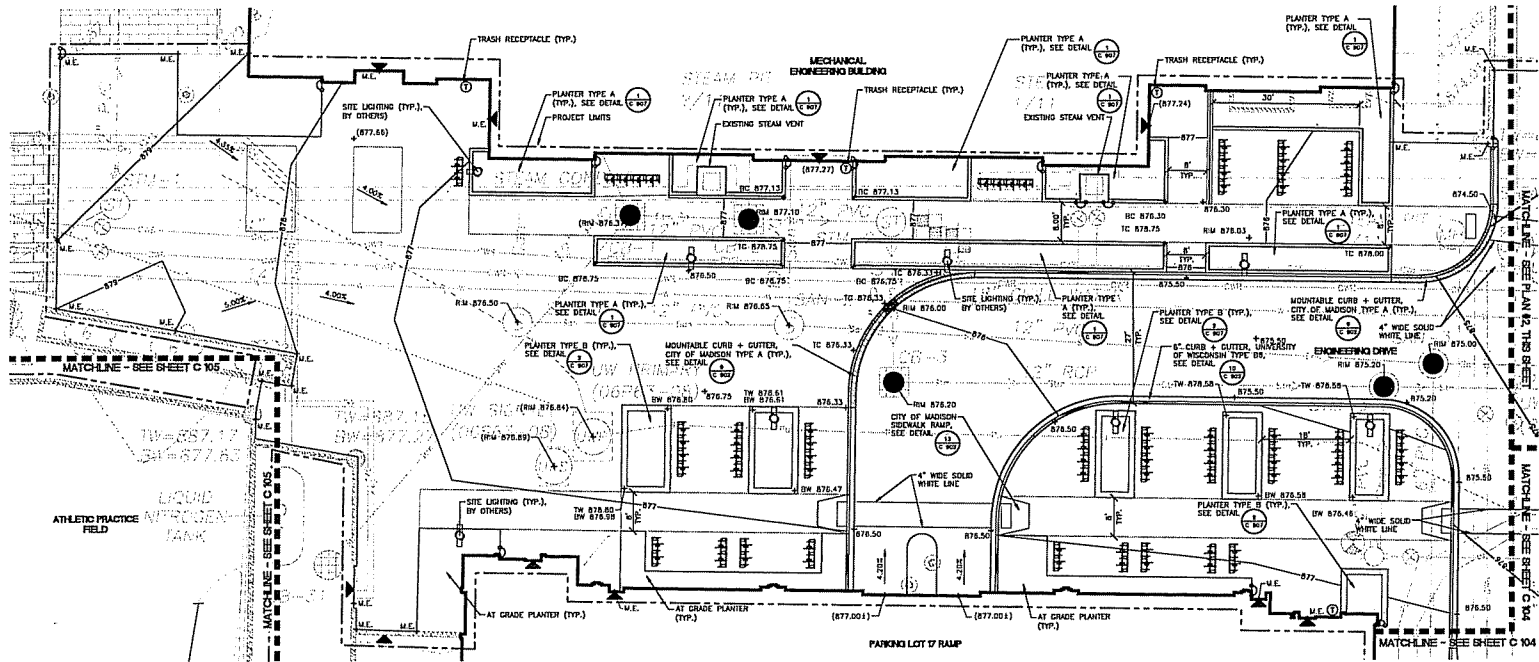

1 SITE LAYOUT PLAN #1


SCALE: 1"=10'-0"

LEGEND:

- PROJECT LIMITS
- BUILDING INCREAS/EDGES
- CONTROL JOINT
- EXPANSION JOINT
- CURB AND CUTTER
- MOUNTABLE CURB AND CUTTER
- REBORN CURB
- 9'-BKE RACK SEE DETAIL
- 5'-BKE RACK SEE DETAIL
- SIDEWALK RAMP
- BENCH
- TRASH RECEPTACLE
- SITE LIGHTING (BY OTHERS)
- ORNAMENTAL FENCE
- PLANTER / SEAT WALL
- MANHOLE / CATCH BASIN
- ALIGN EDGES
- EXISTING MAJOR CONTOUR
- EXISTING MINOR CONTOUR
- PROPOSED MAJOR CONTOUR
- PROPOSED MINOR CONTOUR
- EXISTING ELEVATION
- SPOT ELEVATION
- HP 876.75 HIGH POINT ELEVATION
- LP 876.75 LOW POINT ELEVATION
- TW 876.75 TOP OF WALL ELEVATION
- BW 876.75 BOTTOM OF WALL ELEVATION
- TP 876.75 TOP OF PIER ELEVATION
- TC 876.75 TOP OF CURB ELEVATION
- BC 876.75 BOTTOM OF CURB ELEVATION
- FL 876.75 FLOW LINE ELEVATION
- TS 876.75 TOP OF STAIR ELEVATION
- BS 876.75 BOTTOM OF STAIR ELEVATION
- RM 876.75 STRUCTURE RM ELEVATION
- ME+ WATCH EXISTING

NOTES:

- CONTRACTOR SHALL CONTACT DIGGERS HOTLINE AND APPROPRIATE UTILITY COMPANIES TO FIELD VERIFY UTILITIES PRIOR TO ANY CONSTRUCTION.
- SEE EXISTING CONDITIONS PLANS V 101 FOR LEGEND OF EXISTING FEATURES, PROJECT CONTROL, DIMENSIONS, AND CONTROLS.
- LAYOUT INFORMATION WILL BE PROVIDED TO CONTRACTOR IN ELECTRONIC FORMAT FOR CONSTRUCTION LAYOUT. ALL DIMENSIONS SHOWN ARE FOR INFORMATIONAL PURPOSES ONLY. ANY DISCREPANCIES BETWEEN INFORMATION SHOWN ON CAD FILE SHALL BE BROUGHT TO ENGINEER/LANDSCAPE ARCHITECT'S ATTENTION PRIOR TO CONSTRUCTION.
- IN ADDITION TO THOSE NOTED ON PLANS, EXPANSION JOISTS SHALL BE LOCATED WHERE CONCRETE PAVEMENT ADJACENT TO ALL FIXED SITE STRUCTURES, I.E. BUILDING FACE, WALLS, ETC.
- ALL CURB DIMENSIONS GIVEN TO BACK OF CURB.
- SEE SHEETS C 801 AND C 802 FOR PRELIMINARY SITE LIGHTING LAYOUT FOR 3/5X REWORK. FINAL SITE LIGHTING PLANS WILL BE BY OTHERS.

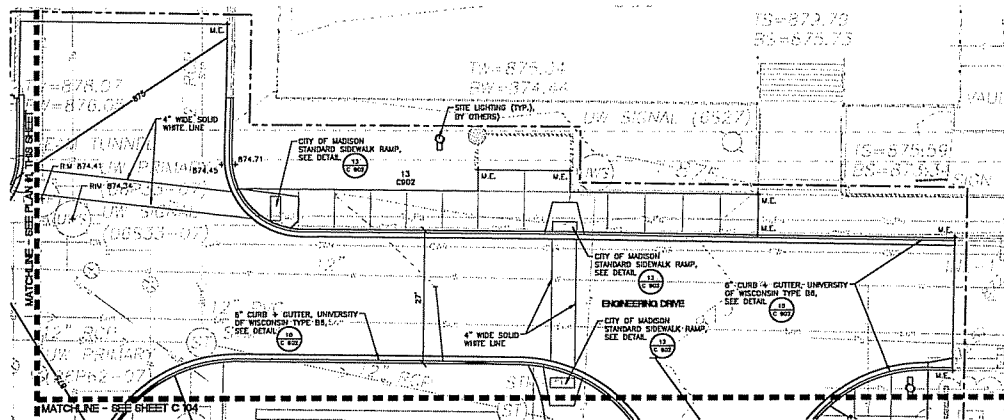


2 SITE LAYOUT PLAN #2

SCALE: 1"=10'-0"



Know what's below.
Call before you dig.

State of Wisconsin Department of Administration Division of State Facilities	
1440 MORRIS ST. MADISON, WI 53711	
STUDENT ATHLETE PERFORMANCE CENTER McCLAIN CENTER REMODELING University of Wisconsin - Madison Madison, Wisconsin	
Project No: _____ Revision: _____ Date: _____ Drawn by: _____ Checked by: _____ Date: _____ Scale: 0"=2.5' 0"=10' 15'	
Graphs: _____ Scale: 0"=2.5' 0"=10' 15' NSF Number: 10H3A Set Type: PR Date Issued: 12/21/2011 Sheet Number: C 103	

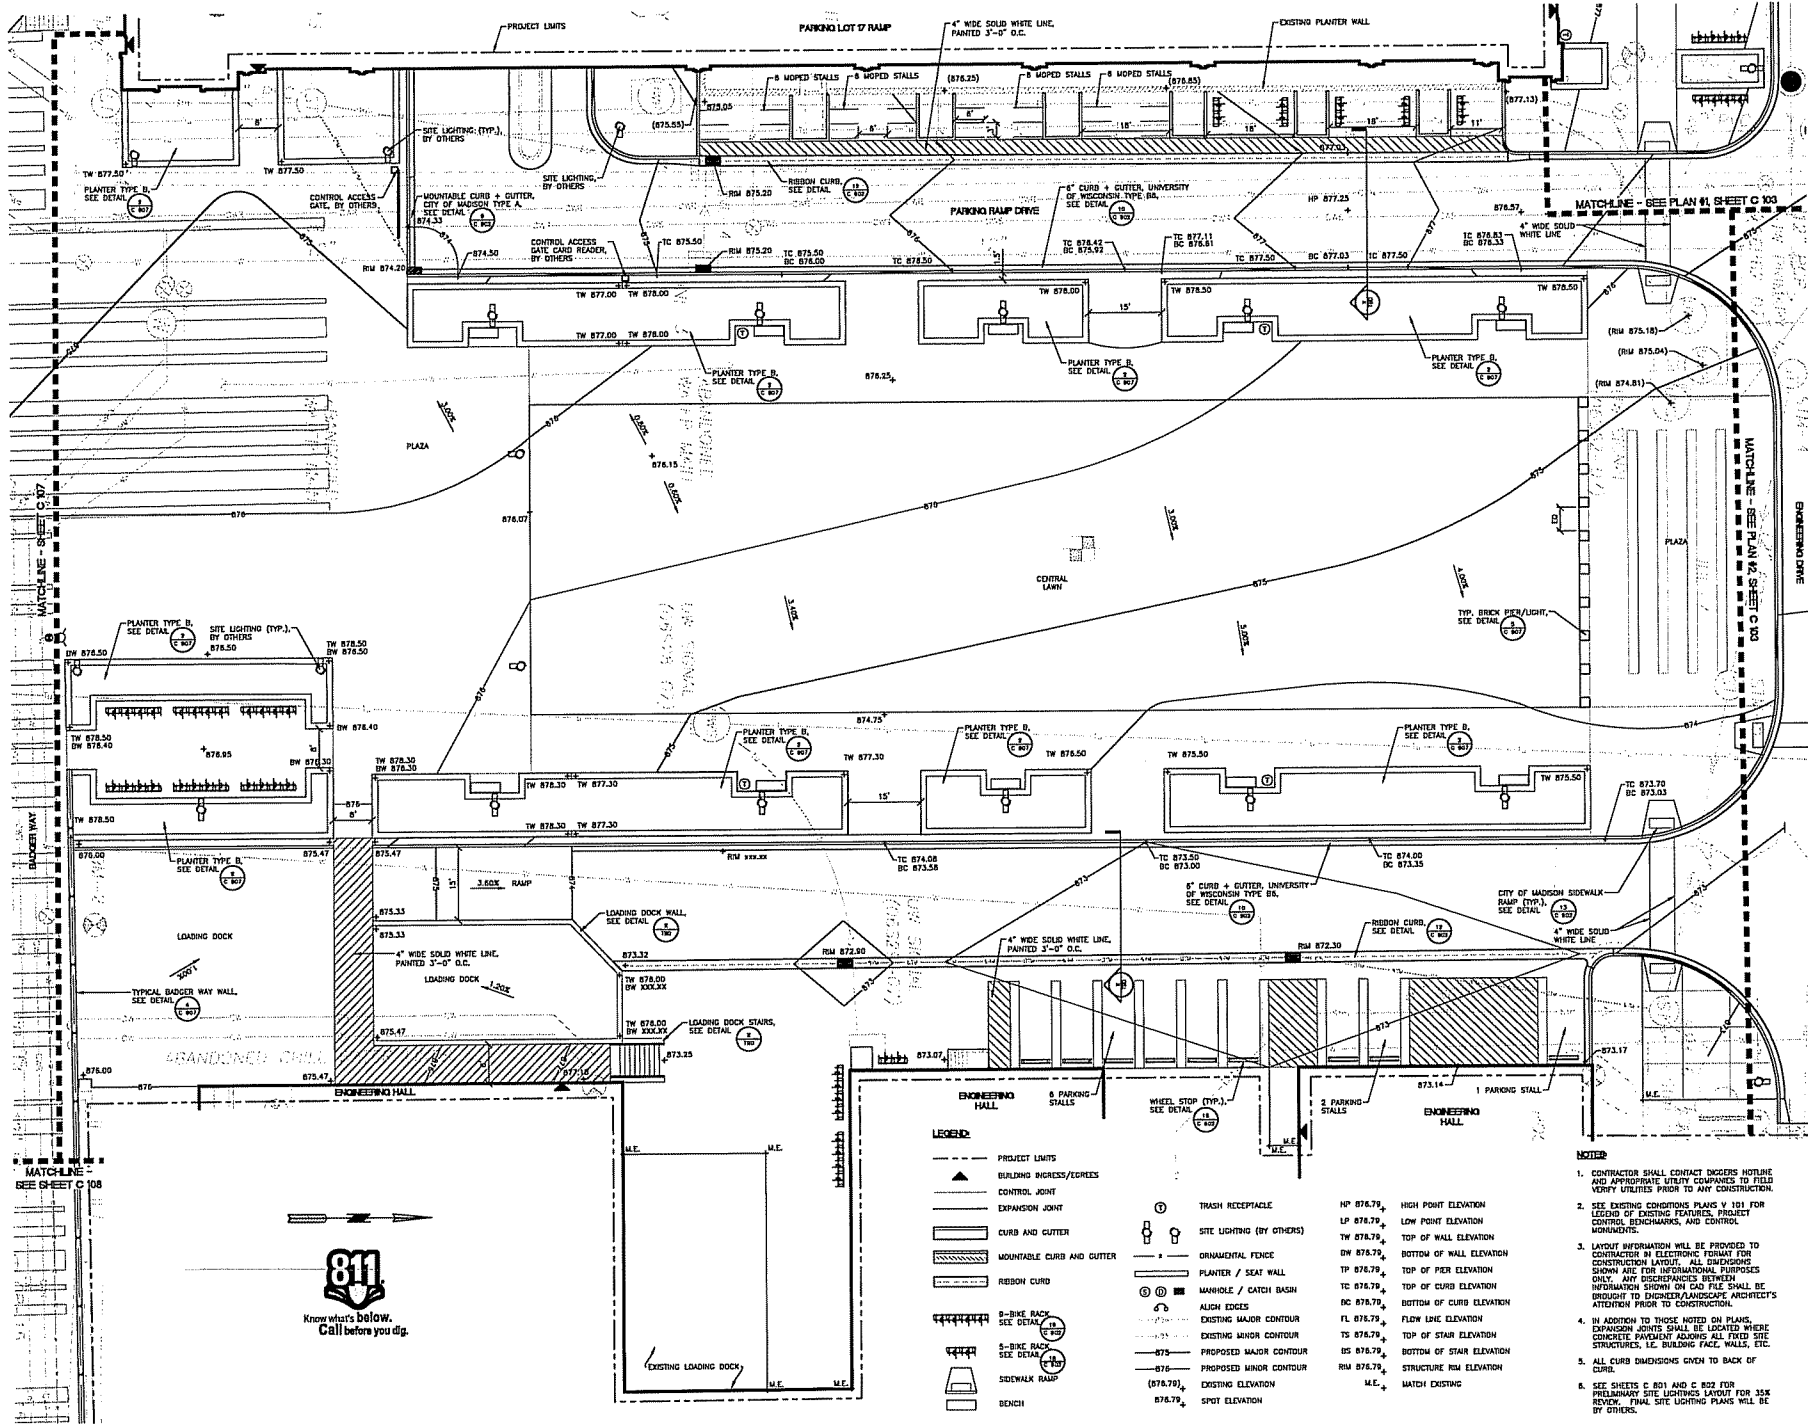

BERNERS & SCHRIEBER
ARCHITECTS - ENGINEERS - PLANNERS

VOA
VERIFICATION OF ADOPTION

JJR
JAMES J. RYAN, INC.
1000 WILLOW STREET
MADISON, WI 53703
(608) 261-1177
www.jjr.com

State of Wisconsin
Department of Administration
Division of State Facilities


1440 MONROE ST.
MADISON, WI 53711

**STUDENT ATHLETE PERFORMANCE CENTER
McCLAIN CENTER REMODELING**
University of Wisconsin - Madison
Madison, Wisconsin

Project No: 10H3A
Date: 02/09/11
Per: Designer

Scale: 1" = 3'-0"

Sheet No: **C 104**

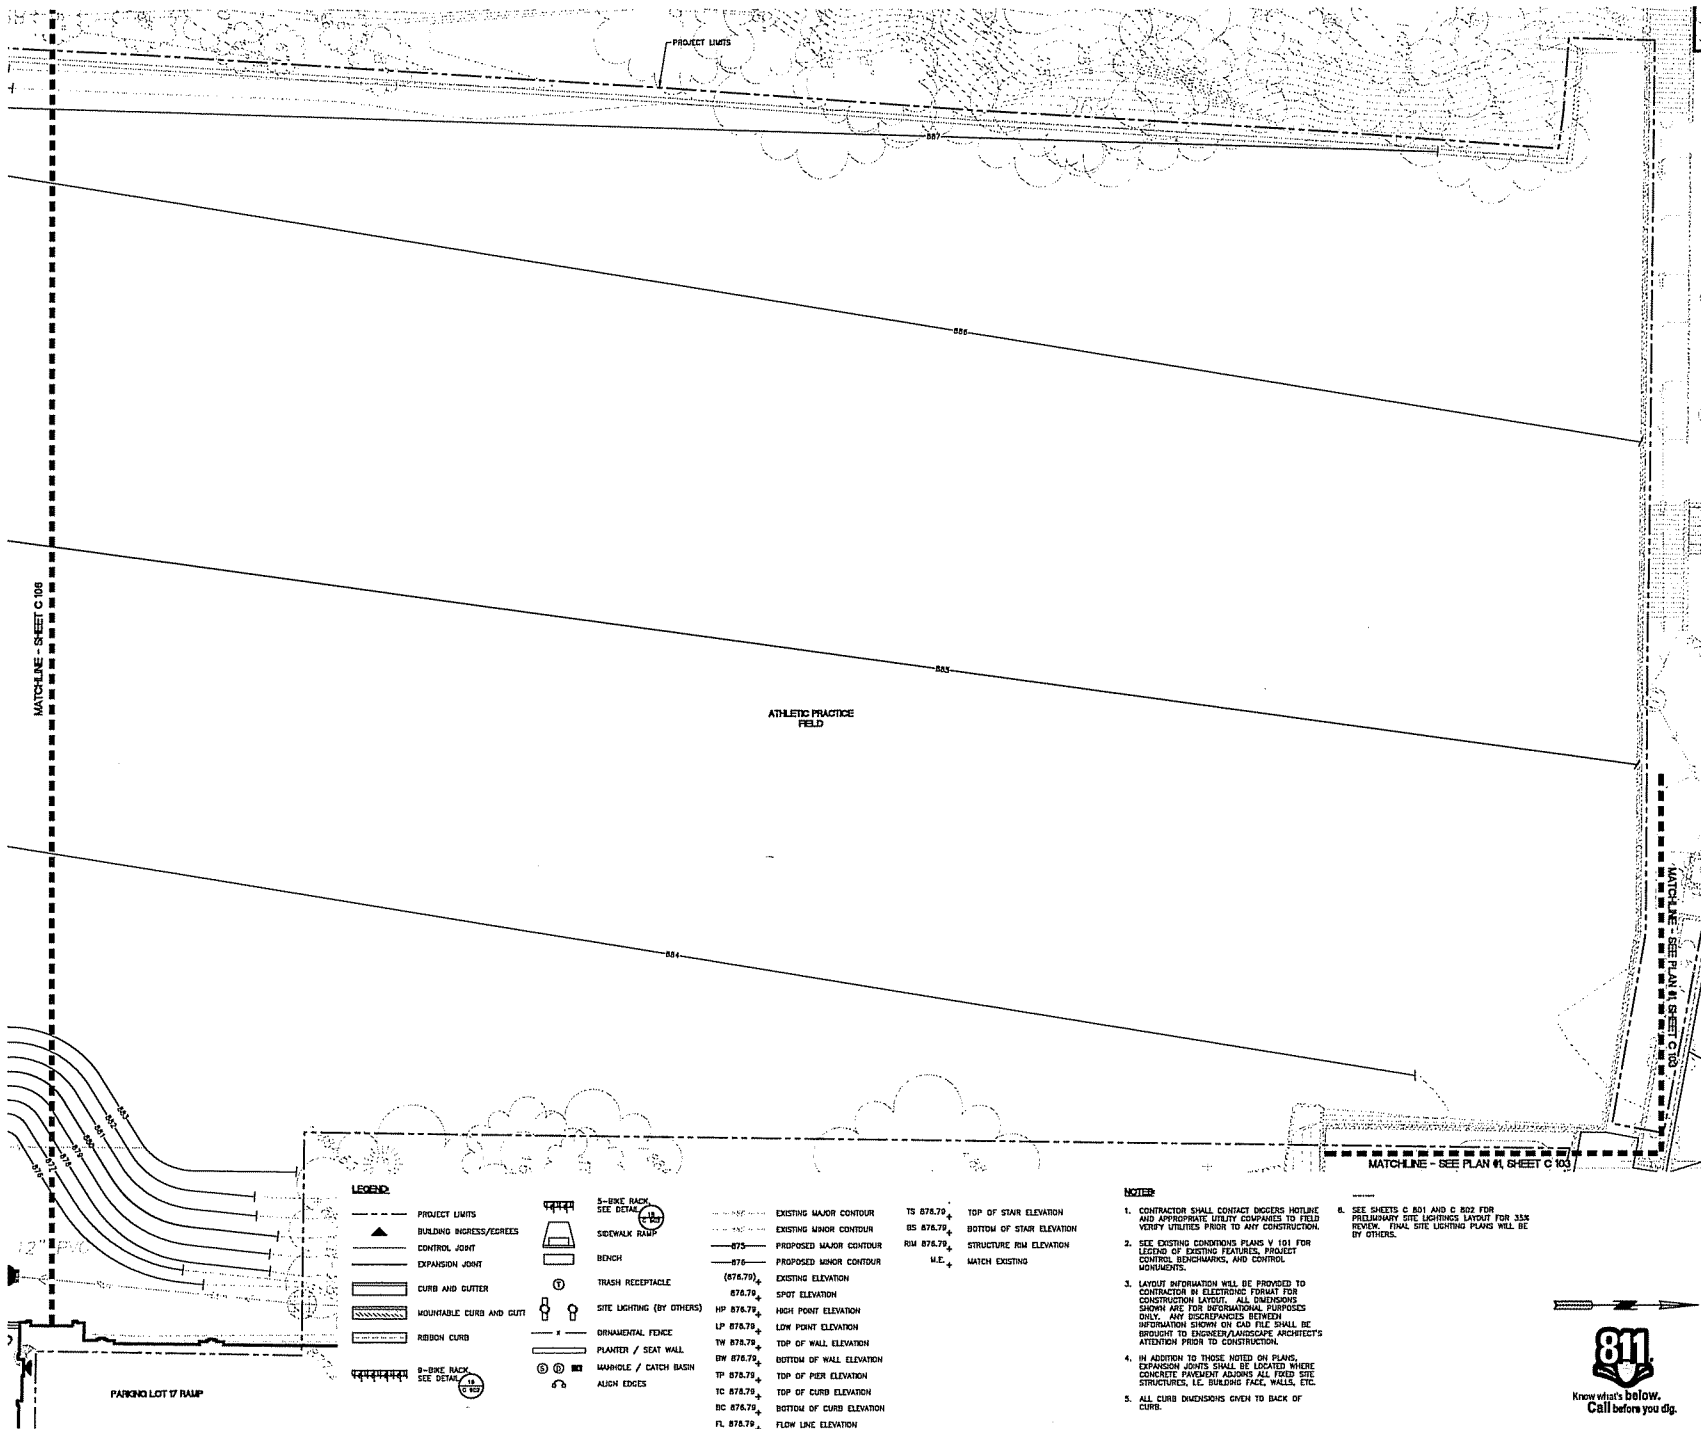

BERNERS & SCHOBERT
Civil Engineers & Surveyors - Madison, WI
L11111

VOA
VOLUME 1

JJR
JAMES J. RYAN, INC.
11111
11111
11111
11111

State of Wisconsin
Department of Administration
Division of State Facilities

1440 MONROE ST.
MADISON, WI 53711

STUDENT ATHLETE PERFORMANCE CENTER
McCLAIN CENTER REMODELING
University of Wisconsin - Madison
Madison, Wisconsin

Project Title: Site Layout and Grading Plan

Revisions:

No.	Date	Revised By	Description
1	02/06/11	PR	Plan Completion

Graphic Scale: 0" = 2.5' 0" 10' 15'

DSF Number: 10H3A


Set Type: PR

Date Issued: 12/21/2011

Sheet Number: C 105




P:\Projects\10H3A\10H3A.dwg 12/21/2011 10:18:10 AM JJR

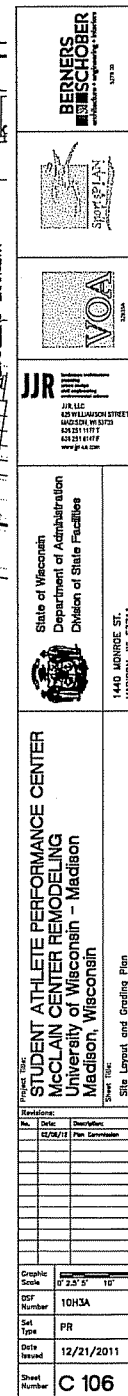


811

Know what's below.
Call before you dig.

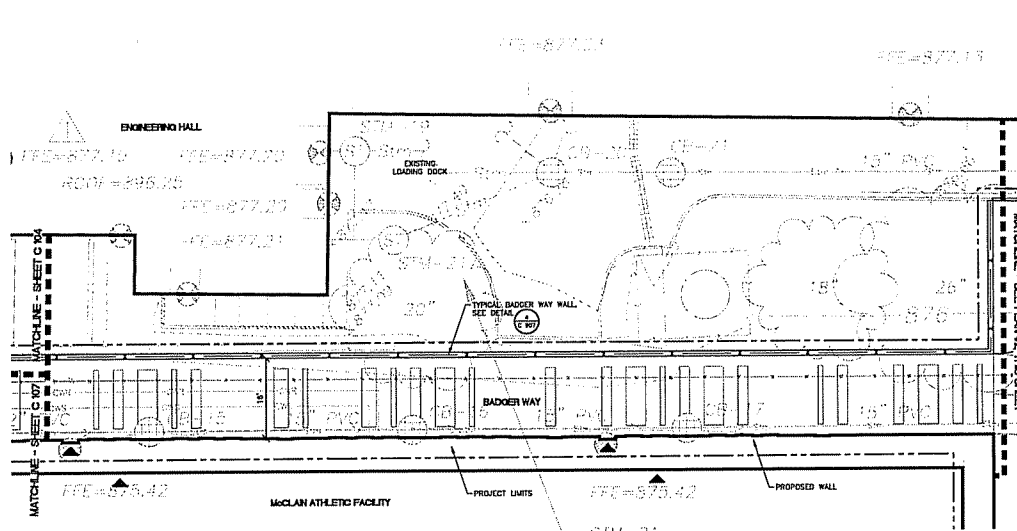

1 SITE LAYOUT PLAN #1

SCALE: 1"=10'-0"

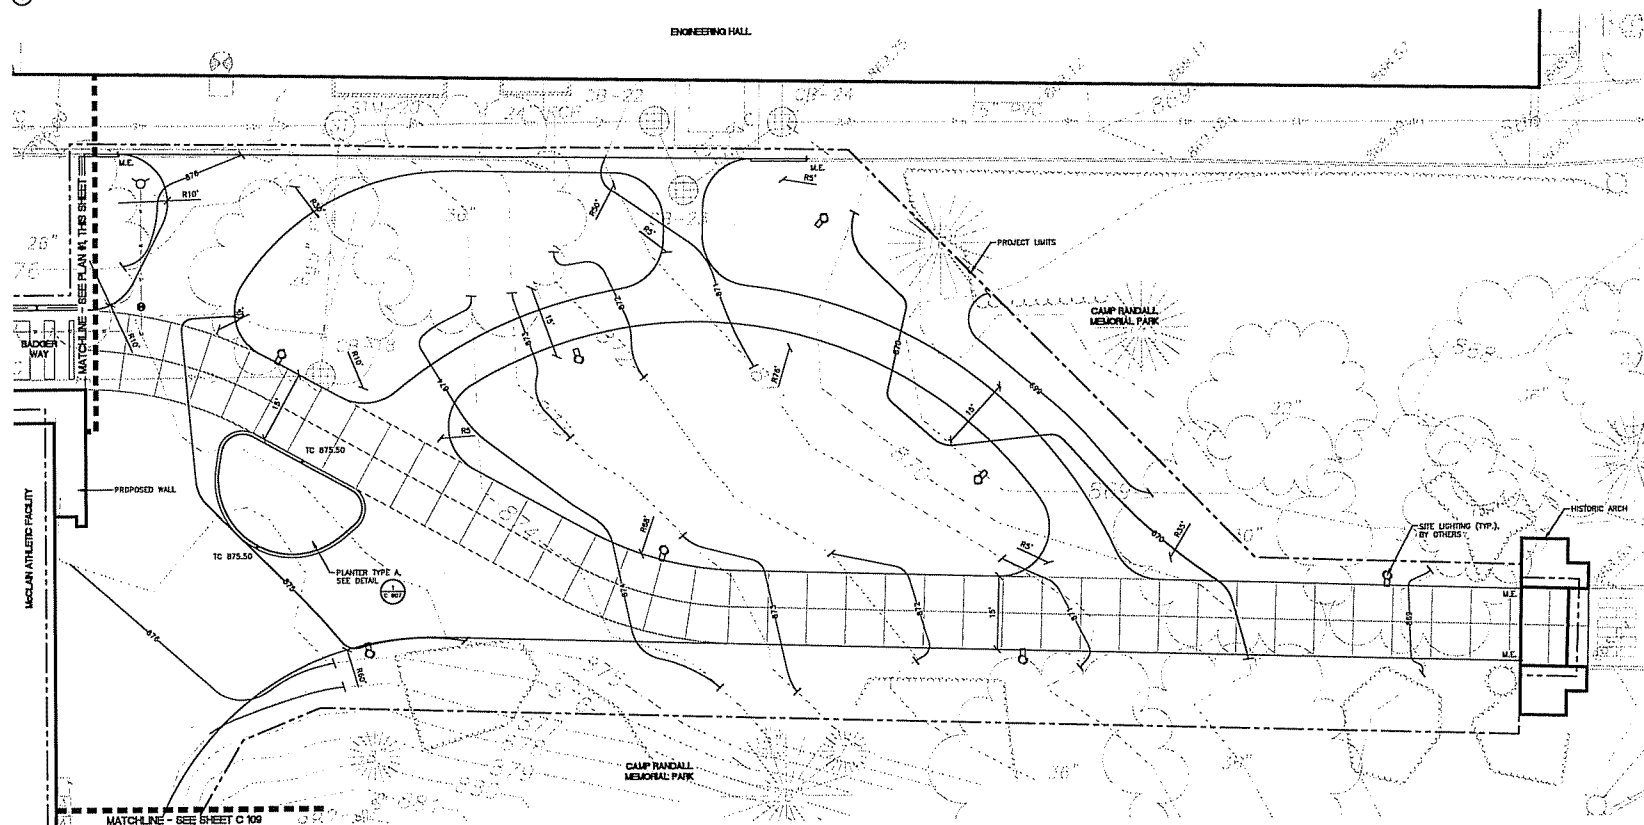

1 SITE LAYOUT PLAN #2

SCALE: 1"=10'-0"

LEGEND

- PROJECT LIMITS
- BUILDING INGRESS/EGRESS
- CONTROL JOINT
- EXPANSION JOINT
- CURB AND GUTTER
- MOUNTABLE CURB AND GUTTER
- RIBBON CURB
- 6-BIKE RACK SEE DETAIL
- 5-BIKE RACK SEE DETAIL
- SIDEWALK RAMP
- BENCH
- TRASH RECEPTACLE
- SITE LIGHTING (BY OTHERS)
- ORNAMENTAL FENCE
- PLANTER / SEAT WALL
- MANHOLE / CATCH BASIN
- ALIGN EDGES

- EXISTING MAJOR CONTOUR
- EXISTING MAJOR CONTOUR
- PROPOSED MAJOR CONTOUR
- PROPOSED MAJOR CONTOUR
- EXISTING ELEVATION
- SPOT ELEVATION
- HP 878.79 HIGH POINT ELEVATION
- LP 878.79 LOW POINT ELEVATION
- TH 878.79 TOP OF WALL ELEVATION
- BW 878.79 BOTTOM OF WALL ELEVATION
- TP 878.79 TOP OF PIER ELEVATION
- TC 878.79 TOP OF CURB ELEVATION
- BC 878.79 BOTTOM OF CURB ELEVATION
- FL 878.79 FLOW LINE ELEVATION
- TS 878.79 TOP OF STAIR ELEVATION
- BS 878.79 BOTTOM OF STAIR ELEVATION
- RM 878.79 STRUCTURE RM ELEVATION
- M.E. MATCH EXISTING

NOTES

- CONTRACTOR SHALL CONTACT DIGGERS NOTLINE AND APPROPRIATE UTILITY COMPANIES TO FIELD VERIFY UTILITIES PRIOR TO ANY CONSTRUCTION.
- SEE EXISTING CONDITIONS PLANS V 101 FOR LEGEND OF EXISTING FEATURES, PROJECT CONTROL, BENCHMARKS, AND CONTROL MONUMENTS.
- LAYOUT INFORMATION WILL BE PROVIDED TO CONTRACTOR IN ELECTRONIC FORMAT FOR CONSTRUCTION LAYOUT. ALL DIMENSIONS SHOWN ARE FOR INFORMATIONAL PURPOSES ONLY. ANY DISCREPANCIES BETWEEN INFORMATION SHOWN ON CAD FILE SHALL BE BROUGHT TO ENGINEER/LANDSCAPE ARCHITECT'S ATTENTION PRIOR TO CONSTRUCTION.
- IN ADDITION TO THOSE NOTED ON PLANS, EXPANSION JOINTS SHALL BE LOCATED WHERE CONCRETE PAVEMENT ADJACENT TO EXISTING STRUCTURES, I.E. BUILDING FACE WALLS, ETC.
- ALL CURB DIMENSIONS GIVEN TO BACK OF CURB.
- SEE SHEETS C 201 AND C 202 FOR PRELIMINARY SITE LIGHTING LAYOUT FOR 35% REVIEW. FINAL SITE LIGHTING PLANS WILL BE BY OTHERS.

BERNERS & SCHOBERT
LANDSCAPE ARCHITECTS & ENGINEERS
SINCE 1978

VOA
VOLUME 100

JJR LLC
625 WILKINSON STREET
MADISON, WI 53703
608.261.1111
608.261.1111
www.jjr.com

State of Wisconsin
Department of Administration
Division of State Facilities

1440 MONROE ST.
MADISON, WI 53711

Project Title:
**STUDENT ATHLETE PERFORMANCE CENTER
McCLAIN CENTER REMODELING
University of Wisconsin - Madison
Madison, Wisconsin**

Sheet Title:
Site Layout and Grading Plan

Revisions	
No.	Description
01/28/18	Per Commission

Graphic Scale: 0' 2.5' 5' 10' 15'

DSF Number: 1013A




Site Type: PR

Date Issued: 12/21/2011

Sheet Number: C 108




FILED IN MADISON, WISCONSIN, JANUARY 12, 2011, 10:00 AM, BY: [Signature]

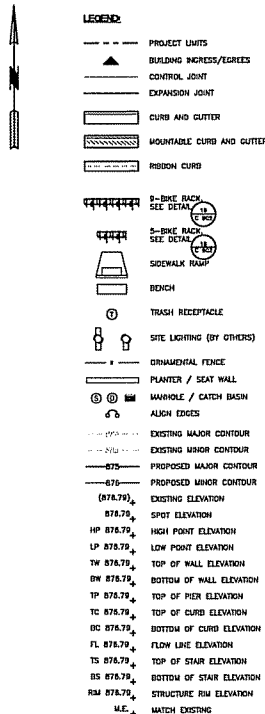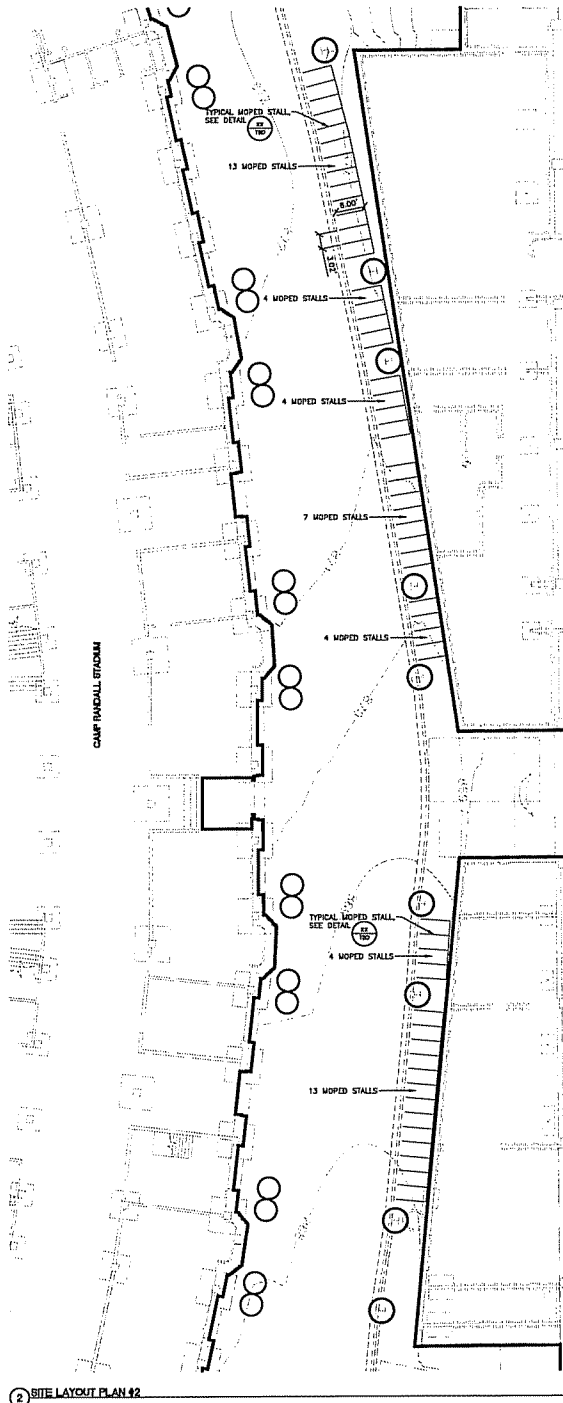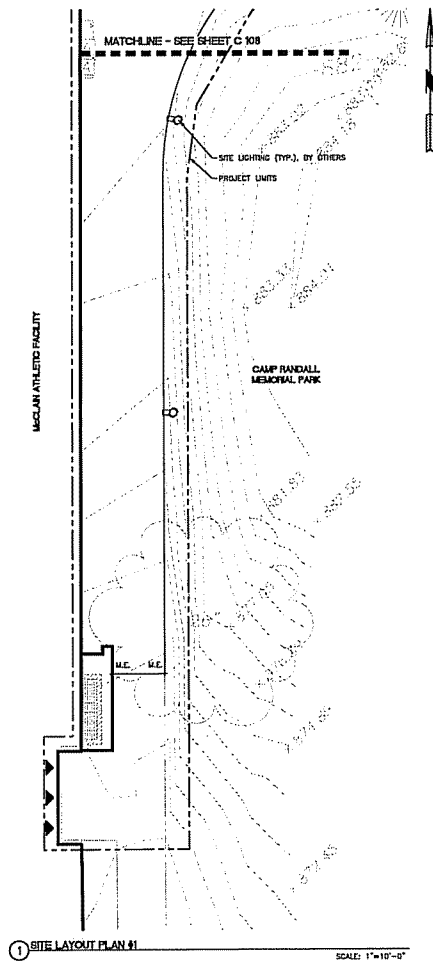

- NOTES
- CONTRACTOR SHALL CONTACT DIGGERS HOTLINE AND APPROPRIATE UTILITY COMPANIES TO FIELD VERIFY UTILITIES PRIOR TO ANY CONSTRUCTION.
 - SEE EXISTING CONDITIONS PLANS V 101 FOR LEGEND OF EXISTING FEATURES, PROJECT CONTROL, BENCHMARKS, AND CONTROL MONUMENTS.
 - LAYOUT INFORMATION WILL BE PROVIDED TO CONTRACTOR IN ELECTRONIC FORMAT FOR CONSTRUCTION LAYOUT. ALL DIMENSIONS SHOWN ARE FOR INFORMATIONAL PURPOSES ONLY. ANY DISCREPANCIES BETWEEN INFORMATION SHOWN ON CAD FILE SHALL BE BROUGHT TO ENGINEER/LANDSCAPE ARCHITECT'S ATTENTION PRIOR TO CONSTRUCTION.
 - IN ADDITION TO THOSE NOTED ON PLANS, EXPANSION JOINTS SHALL BE LOCATED WHERE CONCRETE PAVEMENT ADJACENT ALL FIXED SITE STRUCTURES, I.E. BUILDING FACE WALLS, ETC.
 - ALL CURB DIVISIONS GIVEN TO BACK OF CURB.
 - SEE SHEETS C 801 AND C 802 FOR PRELIMINARY SITE LIGHTING LAYOUT FOR 35% REVIEW. FINAL SITE LIGHTING PLANS WILL BE BY OTHERS.

KEY PLAN - NOT TO SCALE


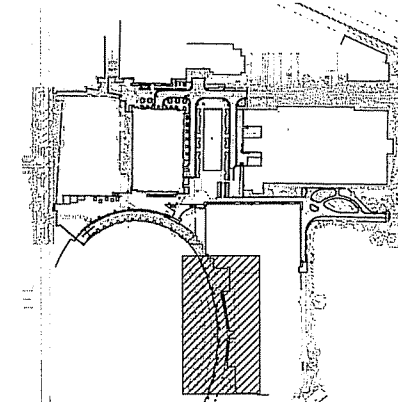


SCALE: 1"=10'-0"



JJR JAMES J. RYAN, INC. 400 N. LAMAR STREET MADISON, WI 53703 608.251.1171 608.251.6117 www.jjr-inc.com	
State of Wisconsin Department of Administration Division of State Facilities	
Project Title: STUDENT ATHLETE PERFORMANCE CENTER McClellan Center Remodeling University of Wisconsin - Madison Madison, Wisconsin	
Project No.: Revision: No. Date Description 02/02/12 Pen Completion	Sheet Title: Site Layout and Grading Plan
Graphic Scale: 0' 2.5' 5' 10' 15'	DSW Number: 10H3A Set Type: PR Date Issued: 12/21/2011 Sheet Number: C 109

P:\P\10200000\10200000\10200000.dwg 12/21/2011 10:20:00 AM 10/20/2011 10:20:00 AM 10/20/2011 10:20:00 AM

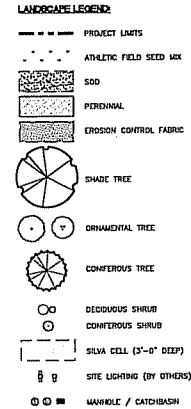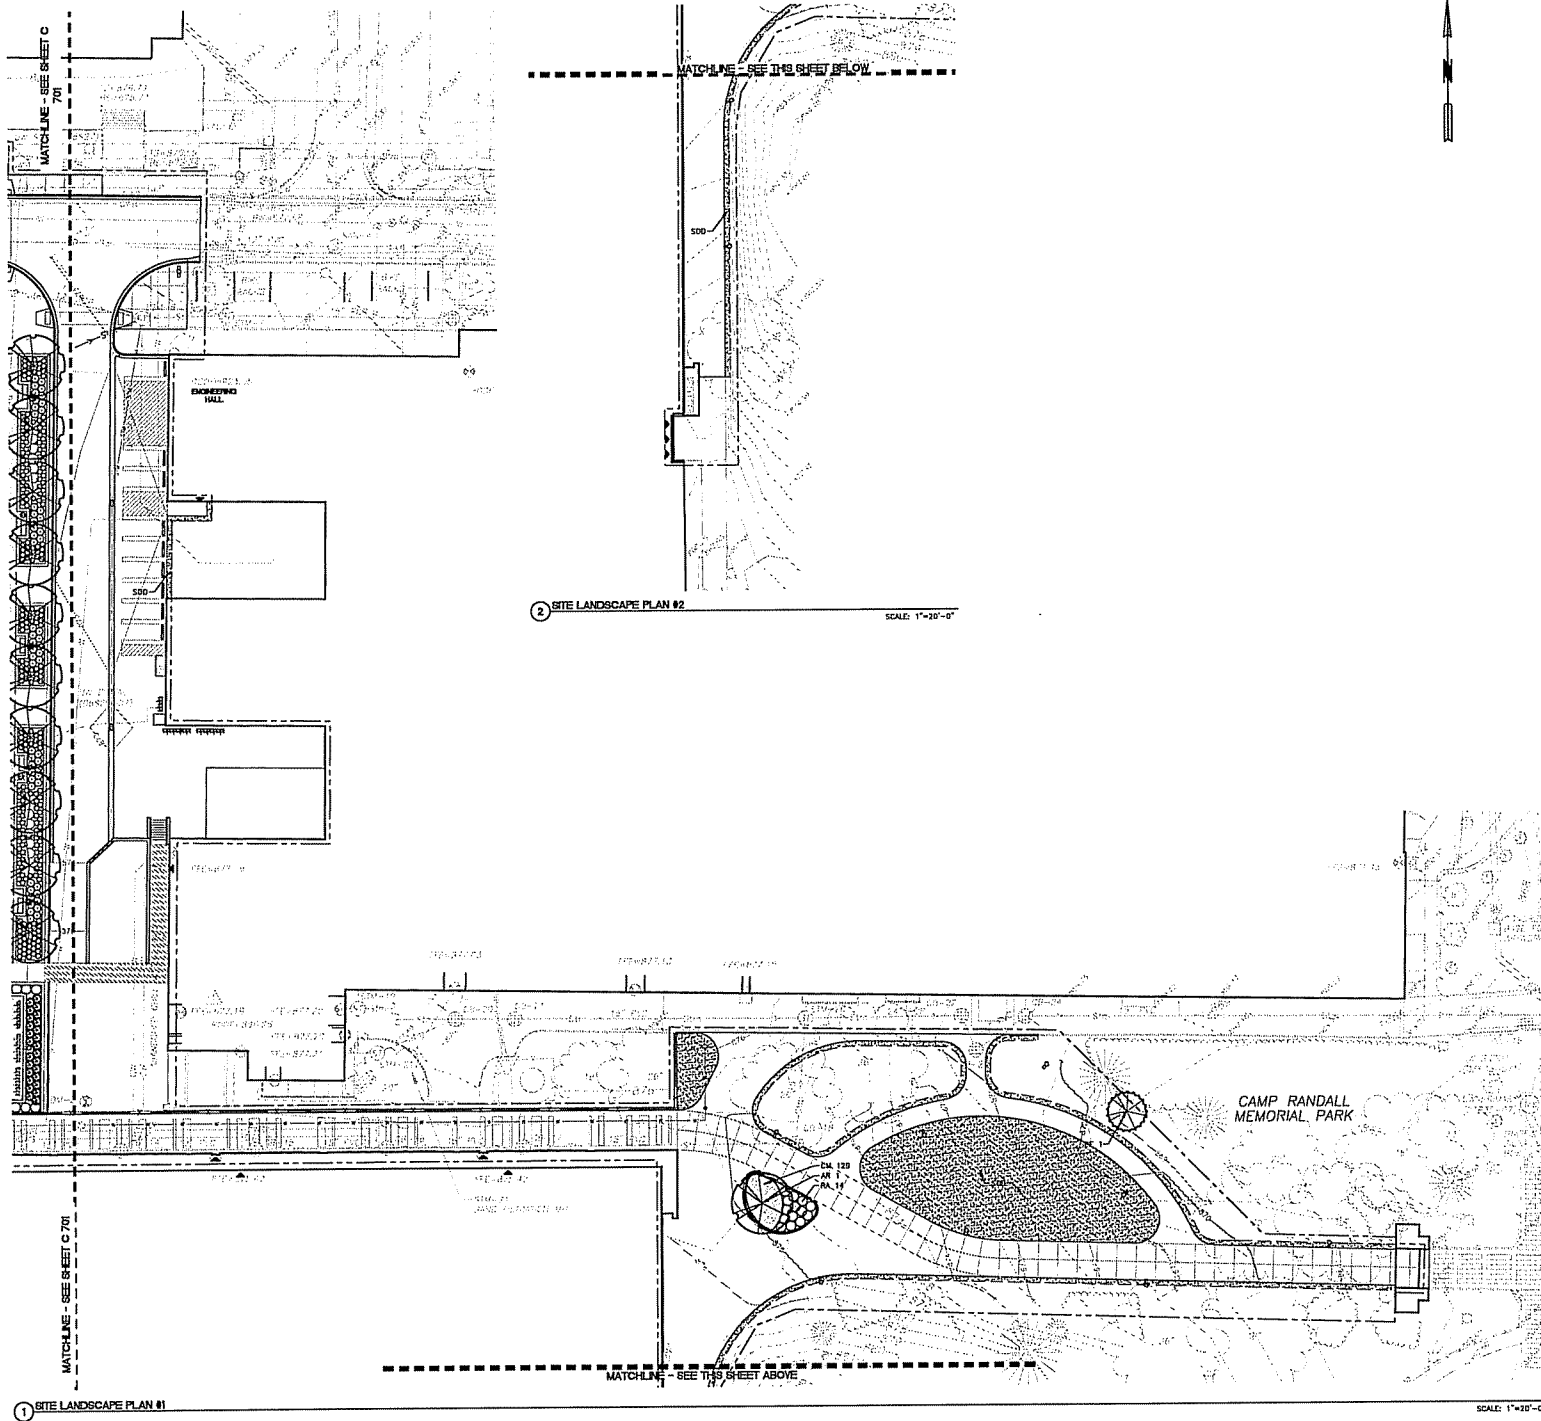

- LANDSCAPE NOTES**
1. PRIOR TO CONSTRUCTION ACTIVITIES, CONTRACTOR SHALL CALL DIFFERS HOTLINE TO LOCATE SITE UTILITIES.
 2. SEE SHEET V 101 FOR PROJECT CONTROL AND LEGEND OF EXISTING FEATURES
 3. SEE SHEET C 703 FOR PLANT LIST AND PLANTING DETAILS.

BERNERS & SCHOBERT
ARCHITECTS & ENGINEERS

VOA
VOLUME 1

JJR
JAN, LLC
400 WILLIAMSON STREET
MADISON, WI 53703
608.261.1177
www.jjr.com

State of Wisconsin
Department of Administration
Division of State Facilities

1440 MONROE ST.
MADISON, WI 53711

PROJECT NAME
**STUDENT ATHLETE PERFORMANCE CENTER
McCLAIN CENTER REMODELING
University of Wisconsin - Madison
Madison, Wisconsin**

Sheet Title
Site Landscape Plan

Revision	Date	Description
1	12/21/11	Per. Completion


Graphic Scale	Scale
0' 5' 10' 20' 30'	

DDP Number	10H3A
Set Type	PR
Date Issued	12/21/2011
Sheet Number	C 702



NOTES:

1. PLANT EACH TREE SUCH THAT THE TRUNK FLARE IS VISIBLE AT THE TOP OF THE ROOT BALL. DO NOT COVER THE TOP OF THE ROOT BALL WITH SOIL.
2. IF PLANT IS SHIPPED WITH A WIRE BASKET AROUND THE ROOT BALL, CUT THE WIRE BASKET AND REMOVE COMPLETELY FROM ROOT BALL. REMOVE TRUNK, ROOT, AND BURLAP ENTIRELY FROM ROOT BALL.
3. DO NOT PLACE MULCH IN CONTACT WITH TRUNK.
4. PRUNE ONLY TO REMOVE DEAD OR BROKEN BRANCHES.

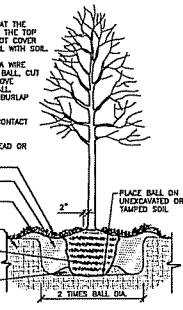


1 DECIDUOUS TREE PLANTING DETAIL

NOT TO SCALE

NOTES:

1. PLANT EACH TREE SUCH THAT THE TRUNK FLARE IS VISIBLE AT THE TOP OF THE ROOT BALL. DO NOT COVER THE TOP OF THE ROOT BALL WITH SOIL.
2. IF PLANT IS SHIPPED WITH A WIRE BASKET AROUND THE ROOT BALL, CUT THE WIRE BASKET AND REMOVE COMPLETELY FROM ROOT BALL. REMOVE TRUNK, ROOT, AND BURLAP ENTIRELY FROM ROOT BALL.
3. DO NOT PLACE MULCH IN CONTACT WITH TRUNK.
4. PRUNE ONLY TO REMOVE DEAD OR BROKEN BRANCHES.

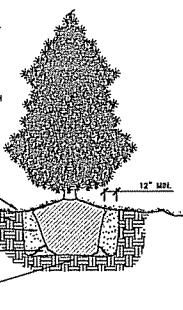


2 EVERGREEN TREE PLANTING DETAIL

NOT TO SCALE

NOTES:

1. PLANT EACH TREE SUCH THAT THE TRUNK FLARE IS VISIBLE AT THE TOP OF THE ROOT BALL. DO NOT COVER THE TOP OF THE ROOT BALL WITH SOIL.
2. IF PLANT IS SHIPPED WITH A WIRE BASKET AROUND THE ROOT BALL, CUT THE WIRE BASKET AND REMOVE COMPLETELY FROM ROOT BALL. REMOVE TRUNK, ROOT, AND BURLAP ENTIRELY FROM ROOT BALL.
3. DO NOT PLACE MULCH IN CONTACT WITH TRUNK.
4. PRUNE ONLY TO REMOVE DEAD OR BROKEN BRANCHES.

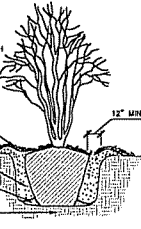


3 FLOWERING TREE PLANTING DETAIL

NOT TO SCALE

NOTES:

1. PLANT EACH SHRUB SUCH THAT THE ROOT COLLAR IS VISIBLE AT THE TOP OF THE ROOT BALL. DO NOT COVER THE TOP OF THE ROOT BALL WITH SOIL.
2. IF PLANT IS SHIPPED WITH A WIRE BASKET AROUND THE ROOT BALL, CUT THE WIRE BASKET AND REMOVE COMPLETELY FROM ROOT BALL. REMOVE TRUNK, ROOT, AND BURLAP ENTIRELY FROM ROOT BALL.
3. DO NOT PLACE MULCH IN CONTACT WITH STEMS.

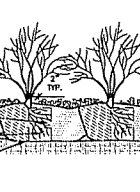


4 SHRUB PLANTING DETAIL

NOT TO SCALE

NOTES:

1. FOR 3 TO 10 GALLON CONTAINERS: MAKE 1" - 2" DEEP VERTICAL CUTS EVERY 8" AROUND THE CIRCUMFERENCE OF THE ROOT BALL BEFORE PLANTING.
2. PLANT EACH PLANT SUCH THAT THE STEM FLARE IS VISIBLE AT THE TOP OF THE ROOT BALL. DO NOT COVER THE TOP OF THE ROOT BALL WITH SOIL.
3. PLANTING HOLE MUST BE NO DEEPER THAN THE HEIGHT OF THE ROOT BALL.
4. DO NOT PLACE MULCH IN CONTACT WITH STEMS.

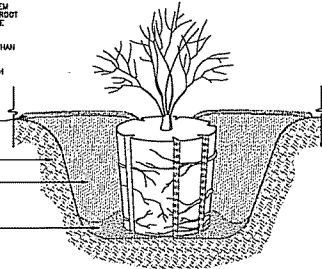


5 LARGE CONTAINER PLANTING DETAIL

NOT TO SCALE


NOTES:

1. FOR 1 TO 2 GALLON CONTAINERS: BUTTERFLY ROOT BALL. SEVER LOWER 8 TO 10" OF ROOT BALL WITH A SINGLE CUT. SPREAD OPEN SEVERED ROOT BALL AND PLACE AGAINST BOTTOM OF THE MODIFIED PLANTING HOLE.
2. PLANT EACH PLANT SUCH THAT THE STEM FLARE IS VISIBLE AT THE TOP OF THE ROOT BALL. DO NOT COVER THE TOP OF THE ROOT BALL WITH SOIL.
3. PLANTING HOLE MUST BE NO DEEPER THAN THE HEIGHT OF THE ROOT BALL.
4. DO NOT PLACE MULCH IN CONTACT WITH STEMS.

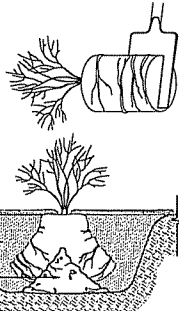


6 SMALL CONTAINER PLANTING DETAIL

NOT TO SCALE

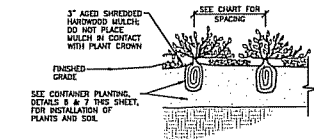

7 PERENNIAL PLANTING DETAIL

 NOT TO SCALE



8 PLANT SPACING DETAIL

NOT TO SCALE

Master Plant List

Key	Scientific Name	Common Name	Quantity Total	Condition	Size	Comments
Shade Trees						
AB	Acer saccharum 'Banksia'	Banksia Sugar Maple	1	P&B	3" Cal.	Specie on shown
AR	Acer rubrum 'October Glory'	October Glory Red Maple	2	P&B	4" Cal.	Specie on shown
CB	Cornus alternifolia 'Pendula Colona'	Swampy/Pendulous Spicebush	12	P&B	3" Cal.	Specie on shown
CV	Salix virginiana	Willow	3	P&B	3" Cal.	Specie on shown
UA	Ulmus americana 'Princeton'	Princeton Elm	20	P&B	3" Cal.	Specie on shown
Ornamental Trees						
AC	Amelanchier canadensis 'Robineau Pilon'	Robineau Pilon Serviceberry	15	P&B	8" Ht.	Clone
AL	Amelanchier laevis	Allegheny Serviceberry	4	P&B	8" Ht.	Clone
CA	Corylus americana	American Hazel	5	P&B	6" Ht.	Specie on shown
IV	Hamamelis virginica 'Autumn Embers'	Autumn Embers Witchhazel	1	P&B	5" Ht.	
Coniferous Trees						
PD	Picea canadensis	Canadian Spruce	7	P&B	10" Ht.	12" O.C.
PT	Pinus strobus 'Vanderwolfi'	Vanderwolfi Limb Pine	4	P&B	14" Ht.	8" O.C.
TD	Taxodium distichum	Bald Cypress	4	P&B	14" Ht.	Low Branching
TD	Thuja occidentalis 'Smaragd'	Emerald Green Arborvitae	31	P&B	6" Ht.	3" O.C.
TE	Thuja occidentalis	Canadian Hemlock	3	P&B	12" Ht.	12" O.C.
Deciduous Shrubs						
CA	Comptonia alternifolia 'Red Hot'	Red Hot Burning Bush	20	P&B	10" Ht.	4" O.C.
HA	Hydrangea arborescens 'Annabelle'	Annabelle Hydrangea	13	cont.	#5	4" O.C.
HP	Hydrangea paniculata 'Little Lime'	Little Lime Panicle Hydrangea	51	cont.	#5	4" O.C.
RA	Rhus glabra 'Crown-of-Thorns'	Crown-of-Thorns Sumac	14	cont.	#5	4" O.C.
SP	Spiraea x bumalda 'Little Princess'	Little Princess Spirea	108	cont.	#2	2" O.C.
SA	Spiraea japonica 'Norman'	Japanese Spirea	110	cont.	#5	10" O.C.
VD	Viburnum dentatum 'Little Joe'	Little Joe Arrowwood Viburnum	34	cont.	#5	4" O.C.
Coniferous Shrubs						
JC	Juniperus chinensis 'Blue Point'	Blue Point Chinese Juniper	6	P&B	6" Ht.	4" O.C.
JS	Juniperus chinensis 'Gold Lace'	Gold Lace Chinese Juniper	27	cont.	#5	4" O.C.
YW	Yucca x media 'Everlow'	Everlow Yucca	157	P&B	24" Ht.	3" O.C.
Grasses						
CF	Calamagrostis x acutiflora 'Karl Foerster'	Karl Foerster Reed Grass	20	cont.	#1	24" O.C.
CM	Carex maritima 'Ice Dance'	Ice Dance Sedge	125	cont.	#2F4	18" O.C.
OK	Ornithoglossum 'Krasa Regal'	Krasa Regal Lily	31	cont.	#1	10" O.C.
LS	Lilium Spicata	Lily	180	cont.	#2F4	12" O.C.
HB	Hesperis 'Blue Wonder'	Blue Wonder Columbine	130	cont.	#1	18" O.C.
PA	Panicum oligosperum 'Hemlock'	Hemlock Fountain Grass	67	cont.	#1	24" O.C.
Seeds/Plants						
	Arboreal Field Seed Mix		69,531 lb	seed	0	-
	Seed		6,932 lb	seed	0	-

BERNERS
SCHUBER
and Associates • Engineering • Architecture

VOA
VOLUME 10

JJR
JUNIOR
JUNIOR
JUNIOR

State of Wisconsin
Department of Administration
Division of State Facilities

1440 MONROE ST.
MADISON, WI 53711

STUDENT ATHLETE PERFORMANCE CENTER
McCLAIN CENTER REMODELING
University of Wisconsin - Madison
Madison, Wisconsin

Project Title: Site Landscape Plant List and Details

Revision:

No.	Date	Description
02/26/12	Rev. 02/26/12	Rev. 02/26/12


Graphic Scale: 0' 30' 60' 1' 1.5'

DSF Number: 10H3A

Set Type: FR

Date Issued: 12/21/2011


Sheet Number: C 703

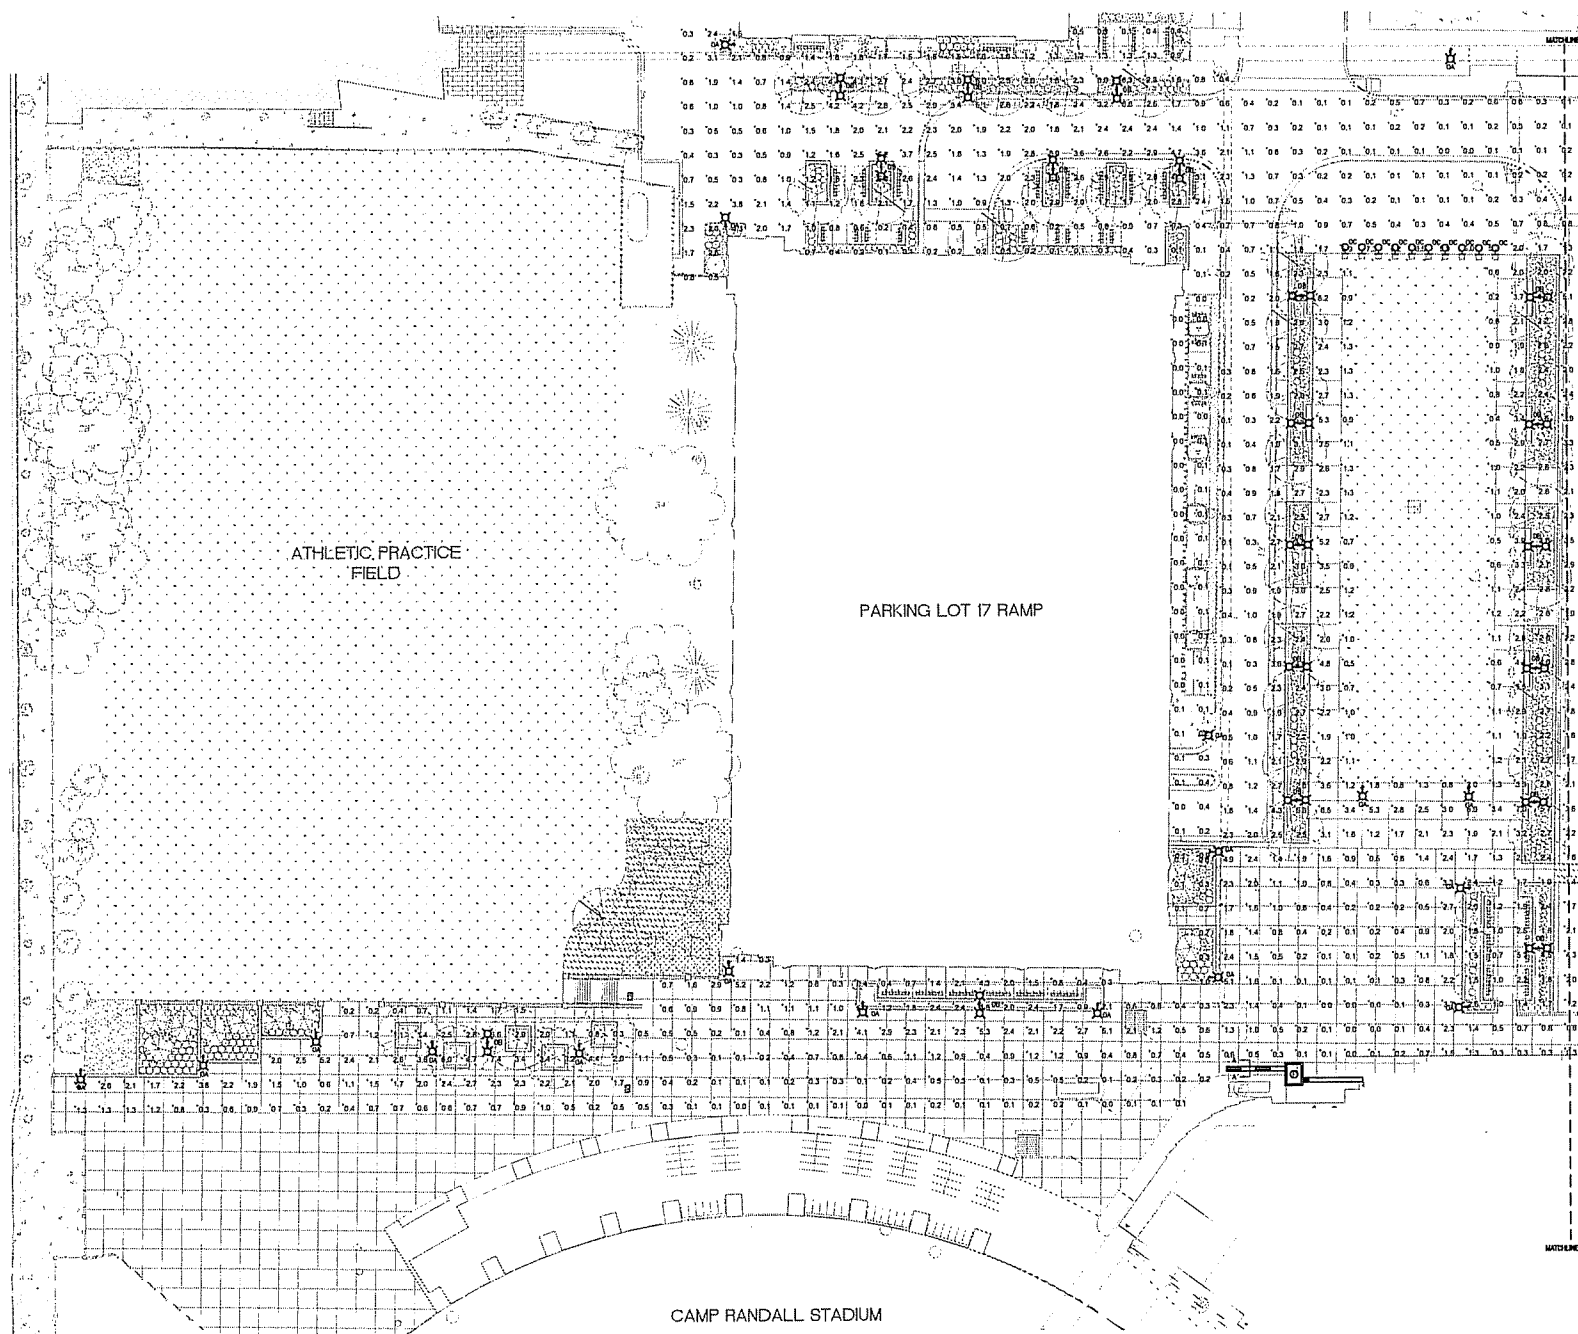


1 SITE PLAN - WEST

GENERAL NOTES:
1. NOTES START HERE

 SHEET NOTES:
② NOTES START HERE



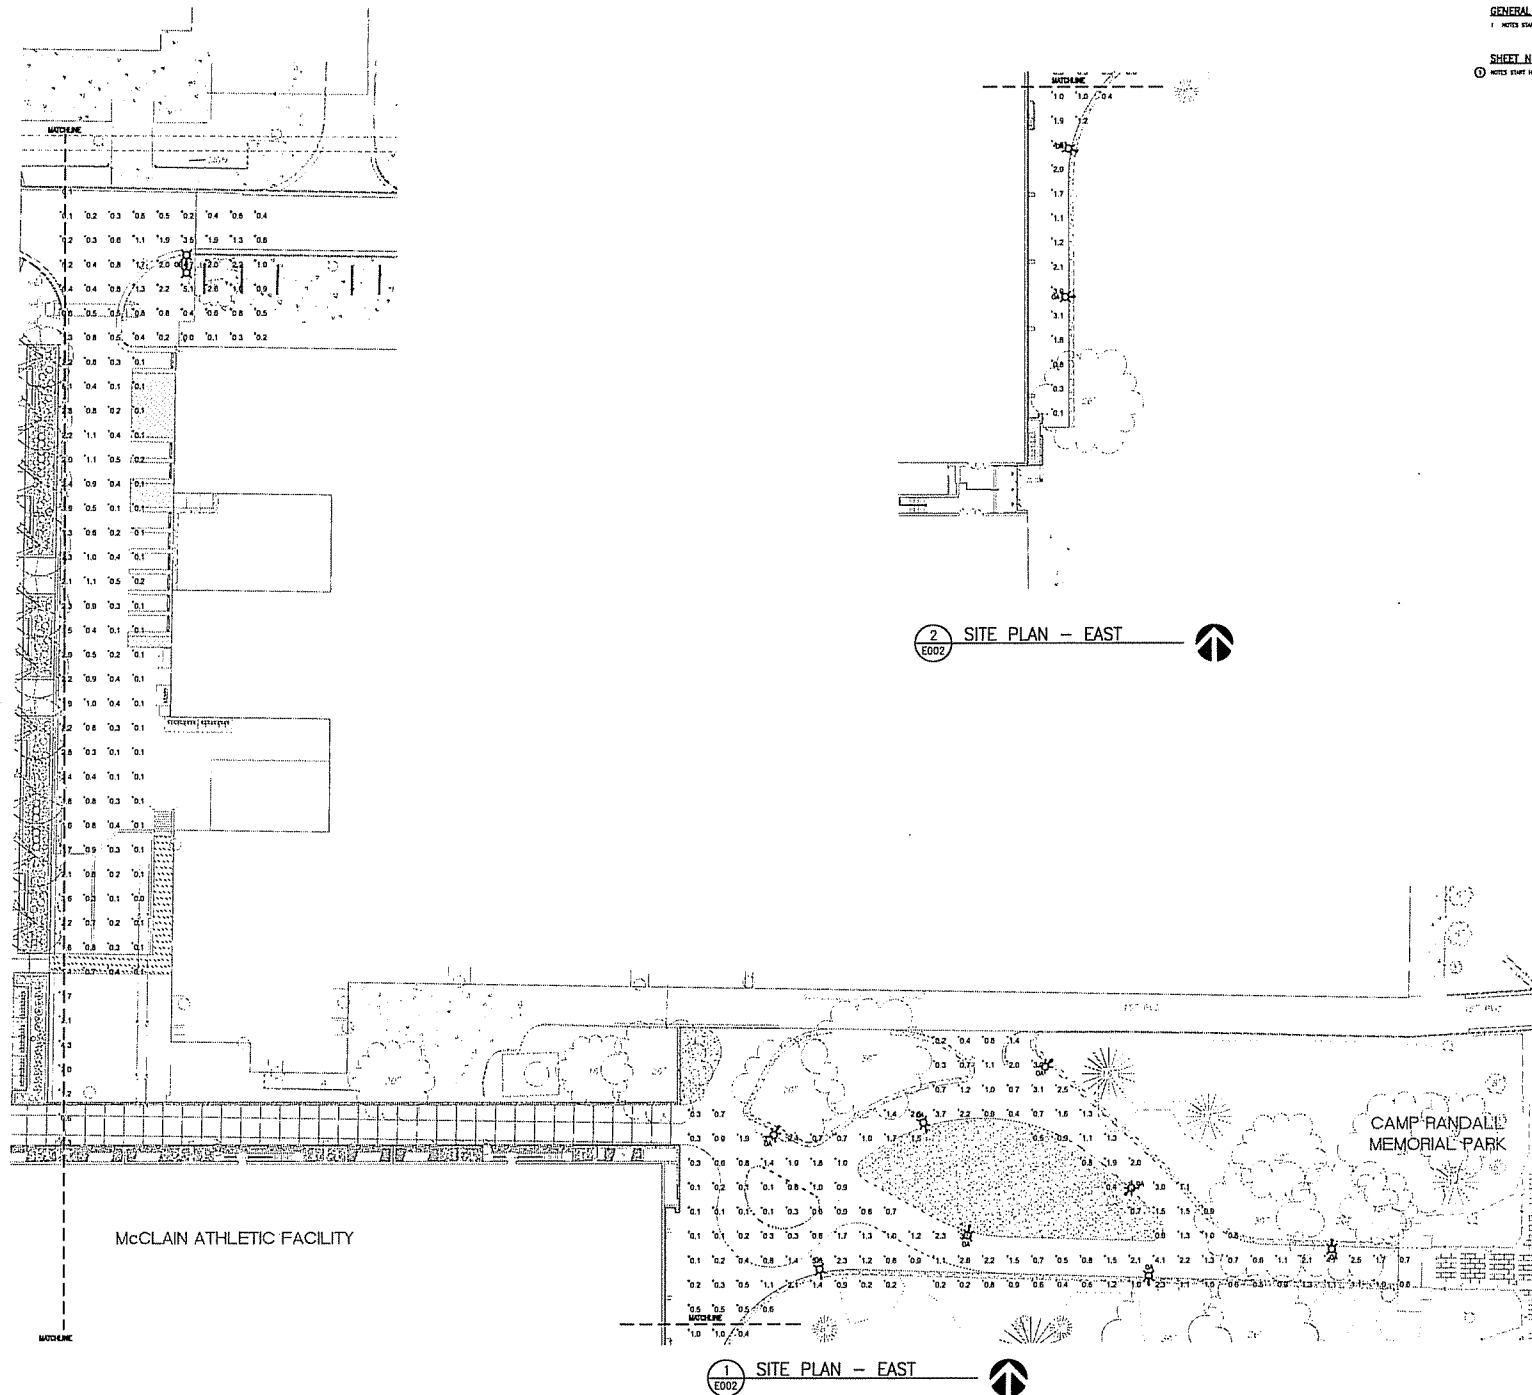

GENERAL NOTES:
1. NOTES SHOWN HERE.

SHEET NOTES:
2. NOTES SHOWN HERE.

PHASE 3 - BID PACKAGE # - FETZER ADDITION

STUDENT ATHLETE PERFORMANCE CENTER
CAMP RANDALL NORTH ADDITION

University of Wisconsin - Madison
Madison, Wisconsin

SHEET NO. 1

SITE PLAN - EAST

State of Wisconsin
Department of Administration
Division of State Facilities



University of Wisconsin



Scale	0' 5' 10' 20' 30'
DSF Number	1013A
Type	PR
Date Issued	01.27.2012
Sheet Number	E002