

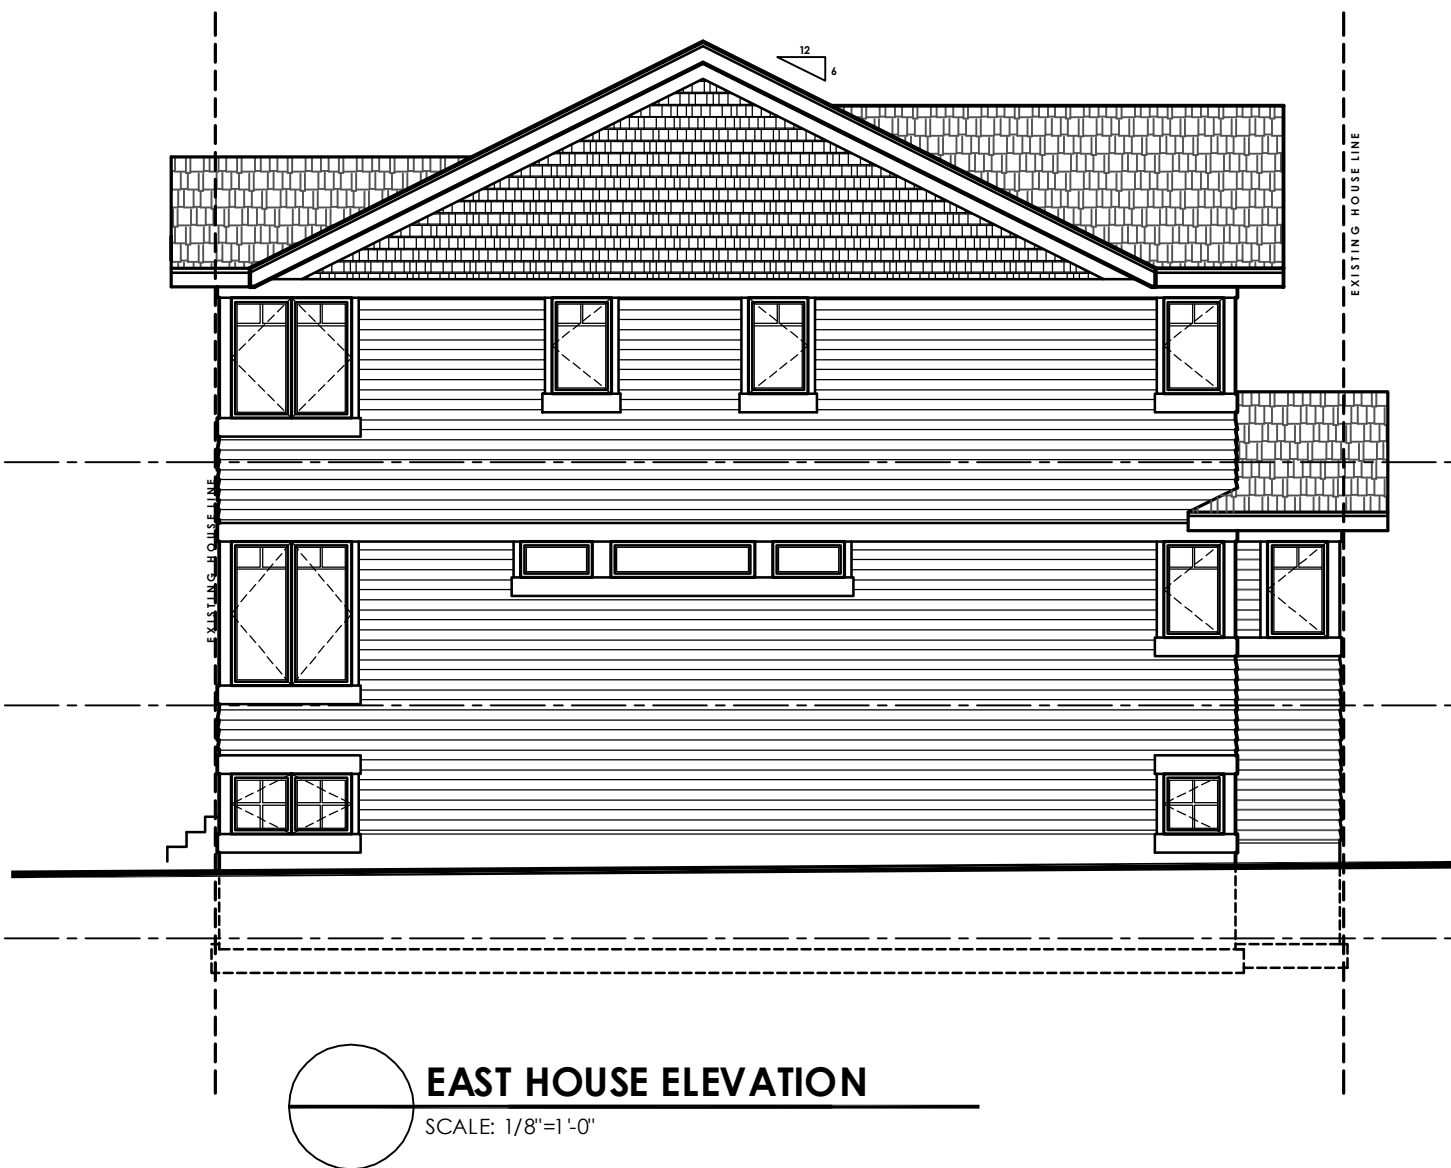
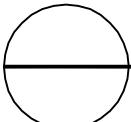


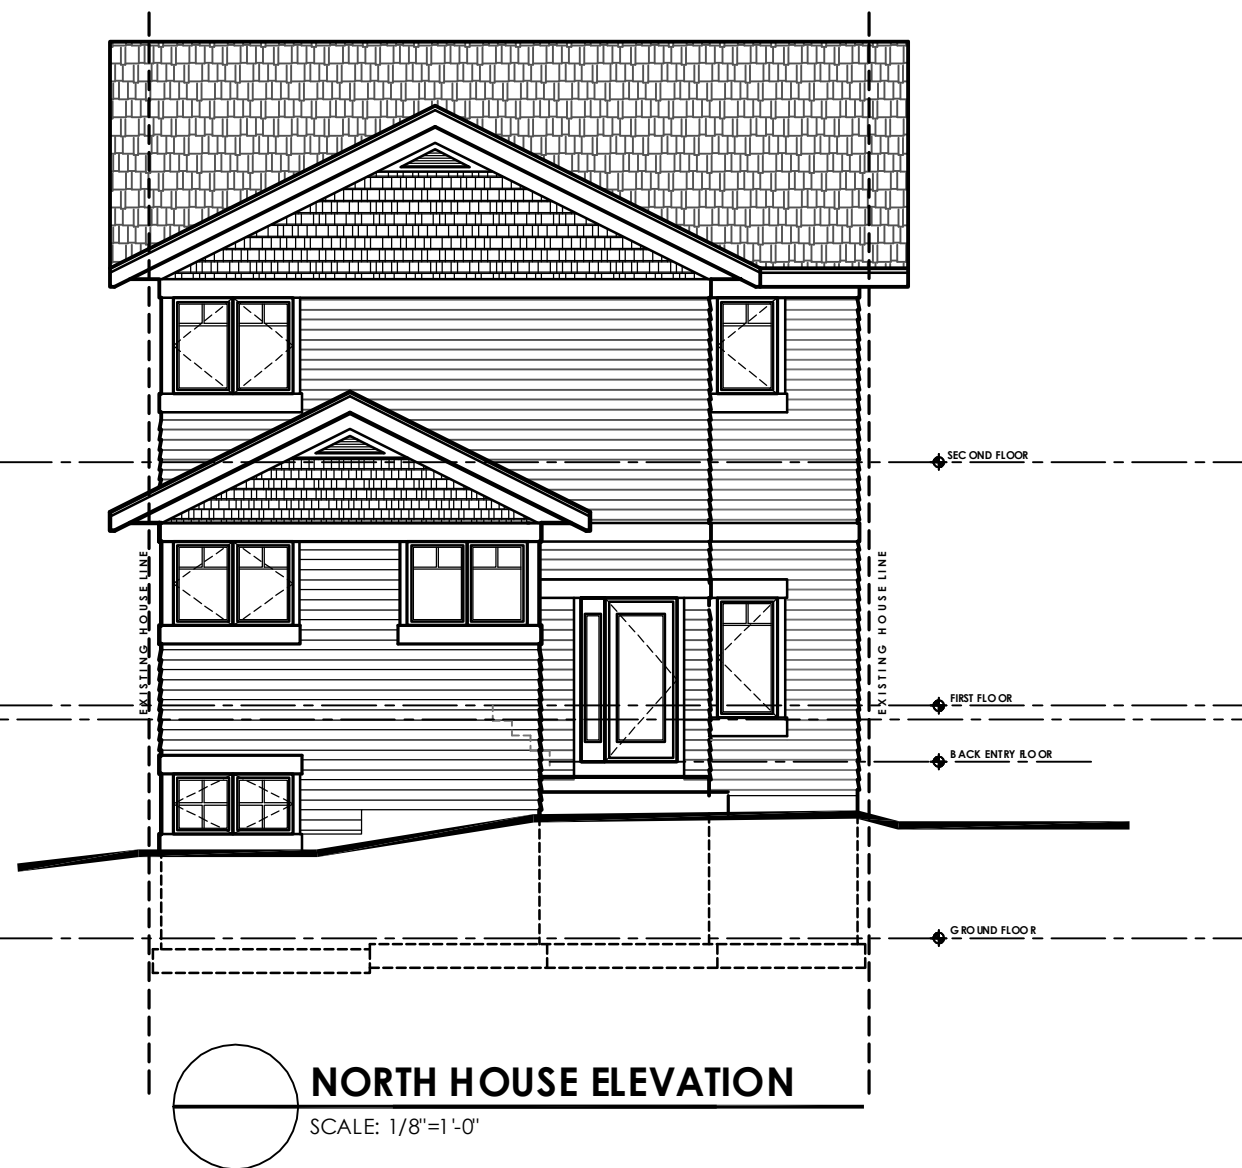

 **EAST HOUSE ELEVATION**
SCALE: 1/8"=1'-0"

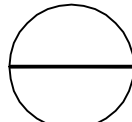

 **NORTH HOUSE ELEVATION**
SCALE: 1/8"=1'-0"

01.23.2008




PRELIMINARY DESIGN CONCEPTS FOR


EHRlich/FAGERHOLM RESIDENCE

155 SOUTH BRITTINGHAM ST.
LOT 7

MADISON
DANE COUNTY, WI

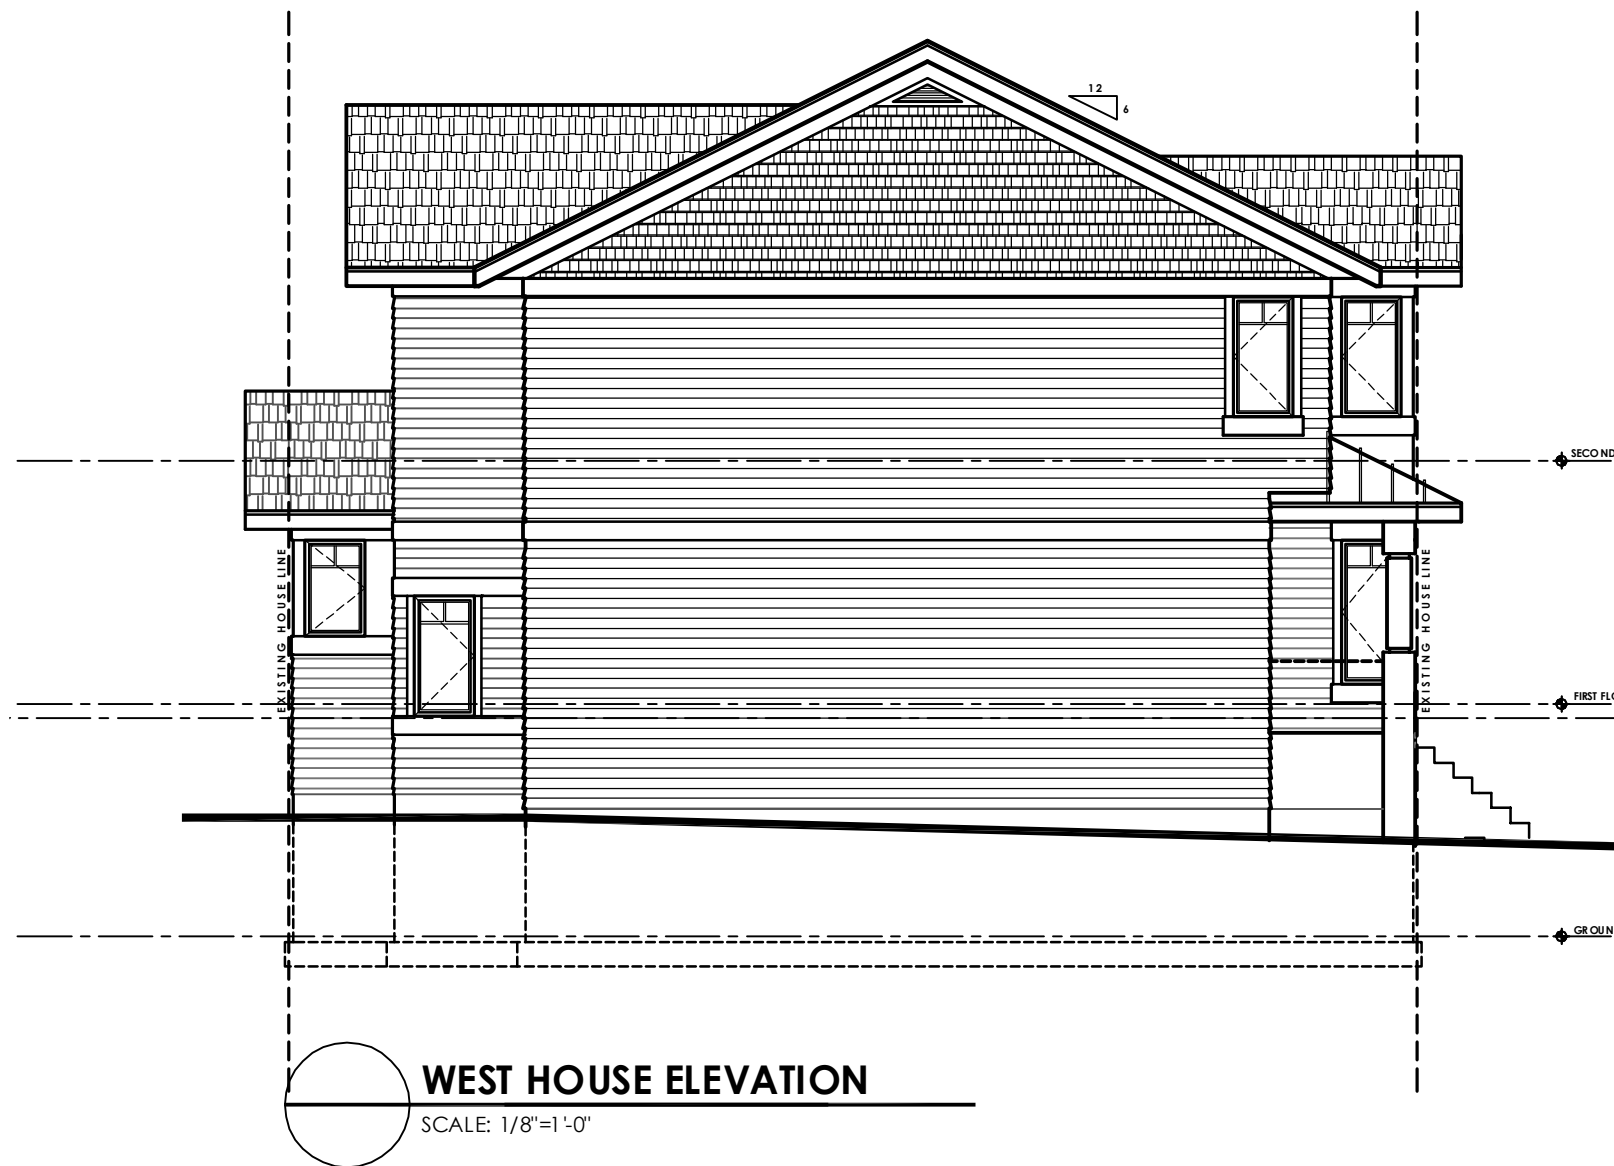

WEST HOUSE ELEVATION
SCALE: 1/8"=1'-0"

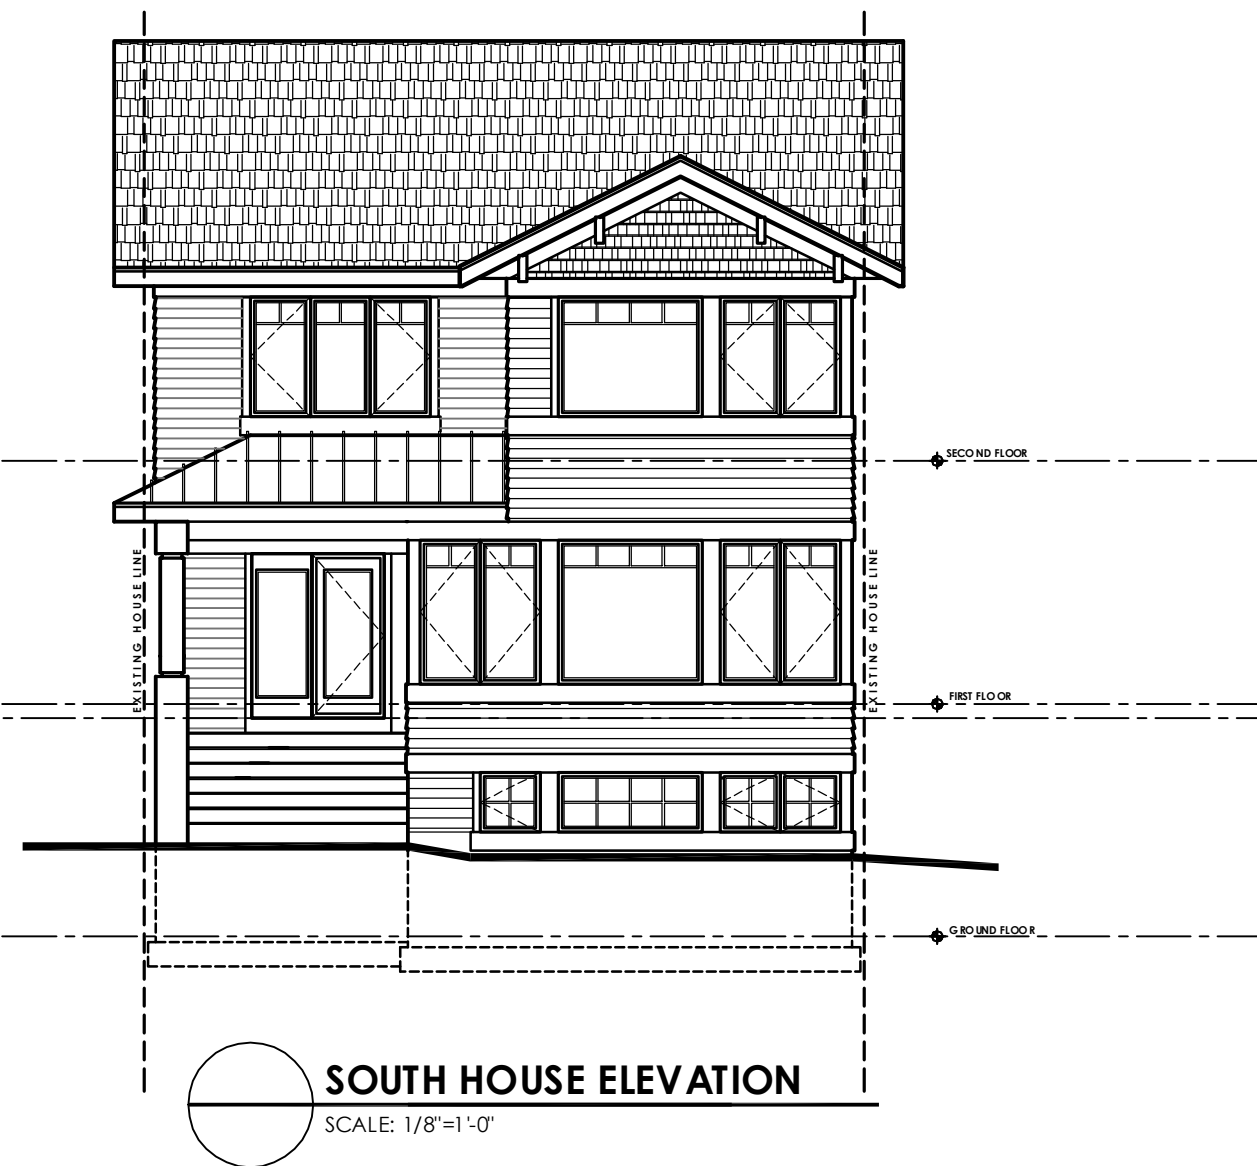

SOUTH HOUSE ELEVATION
SCALE: 1/8"=1'-0"

01.23.2008




PRELIMINARY DESIGN CONCEPTS FOR

EHRlich/FAGERHOLM RESIDENCE


155 SOUTH BRITTINGHAM ST.
LOT 7

MADISON
DANE COUNTY, WI

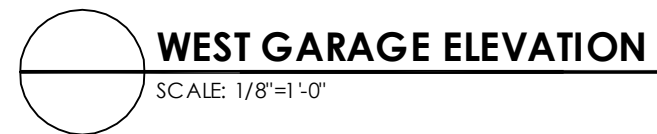udvari
solner
design
company

EHRlich/FAGERHOLM RESIDENCE

MADISON
DANE COUNTY, WI

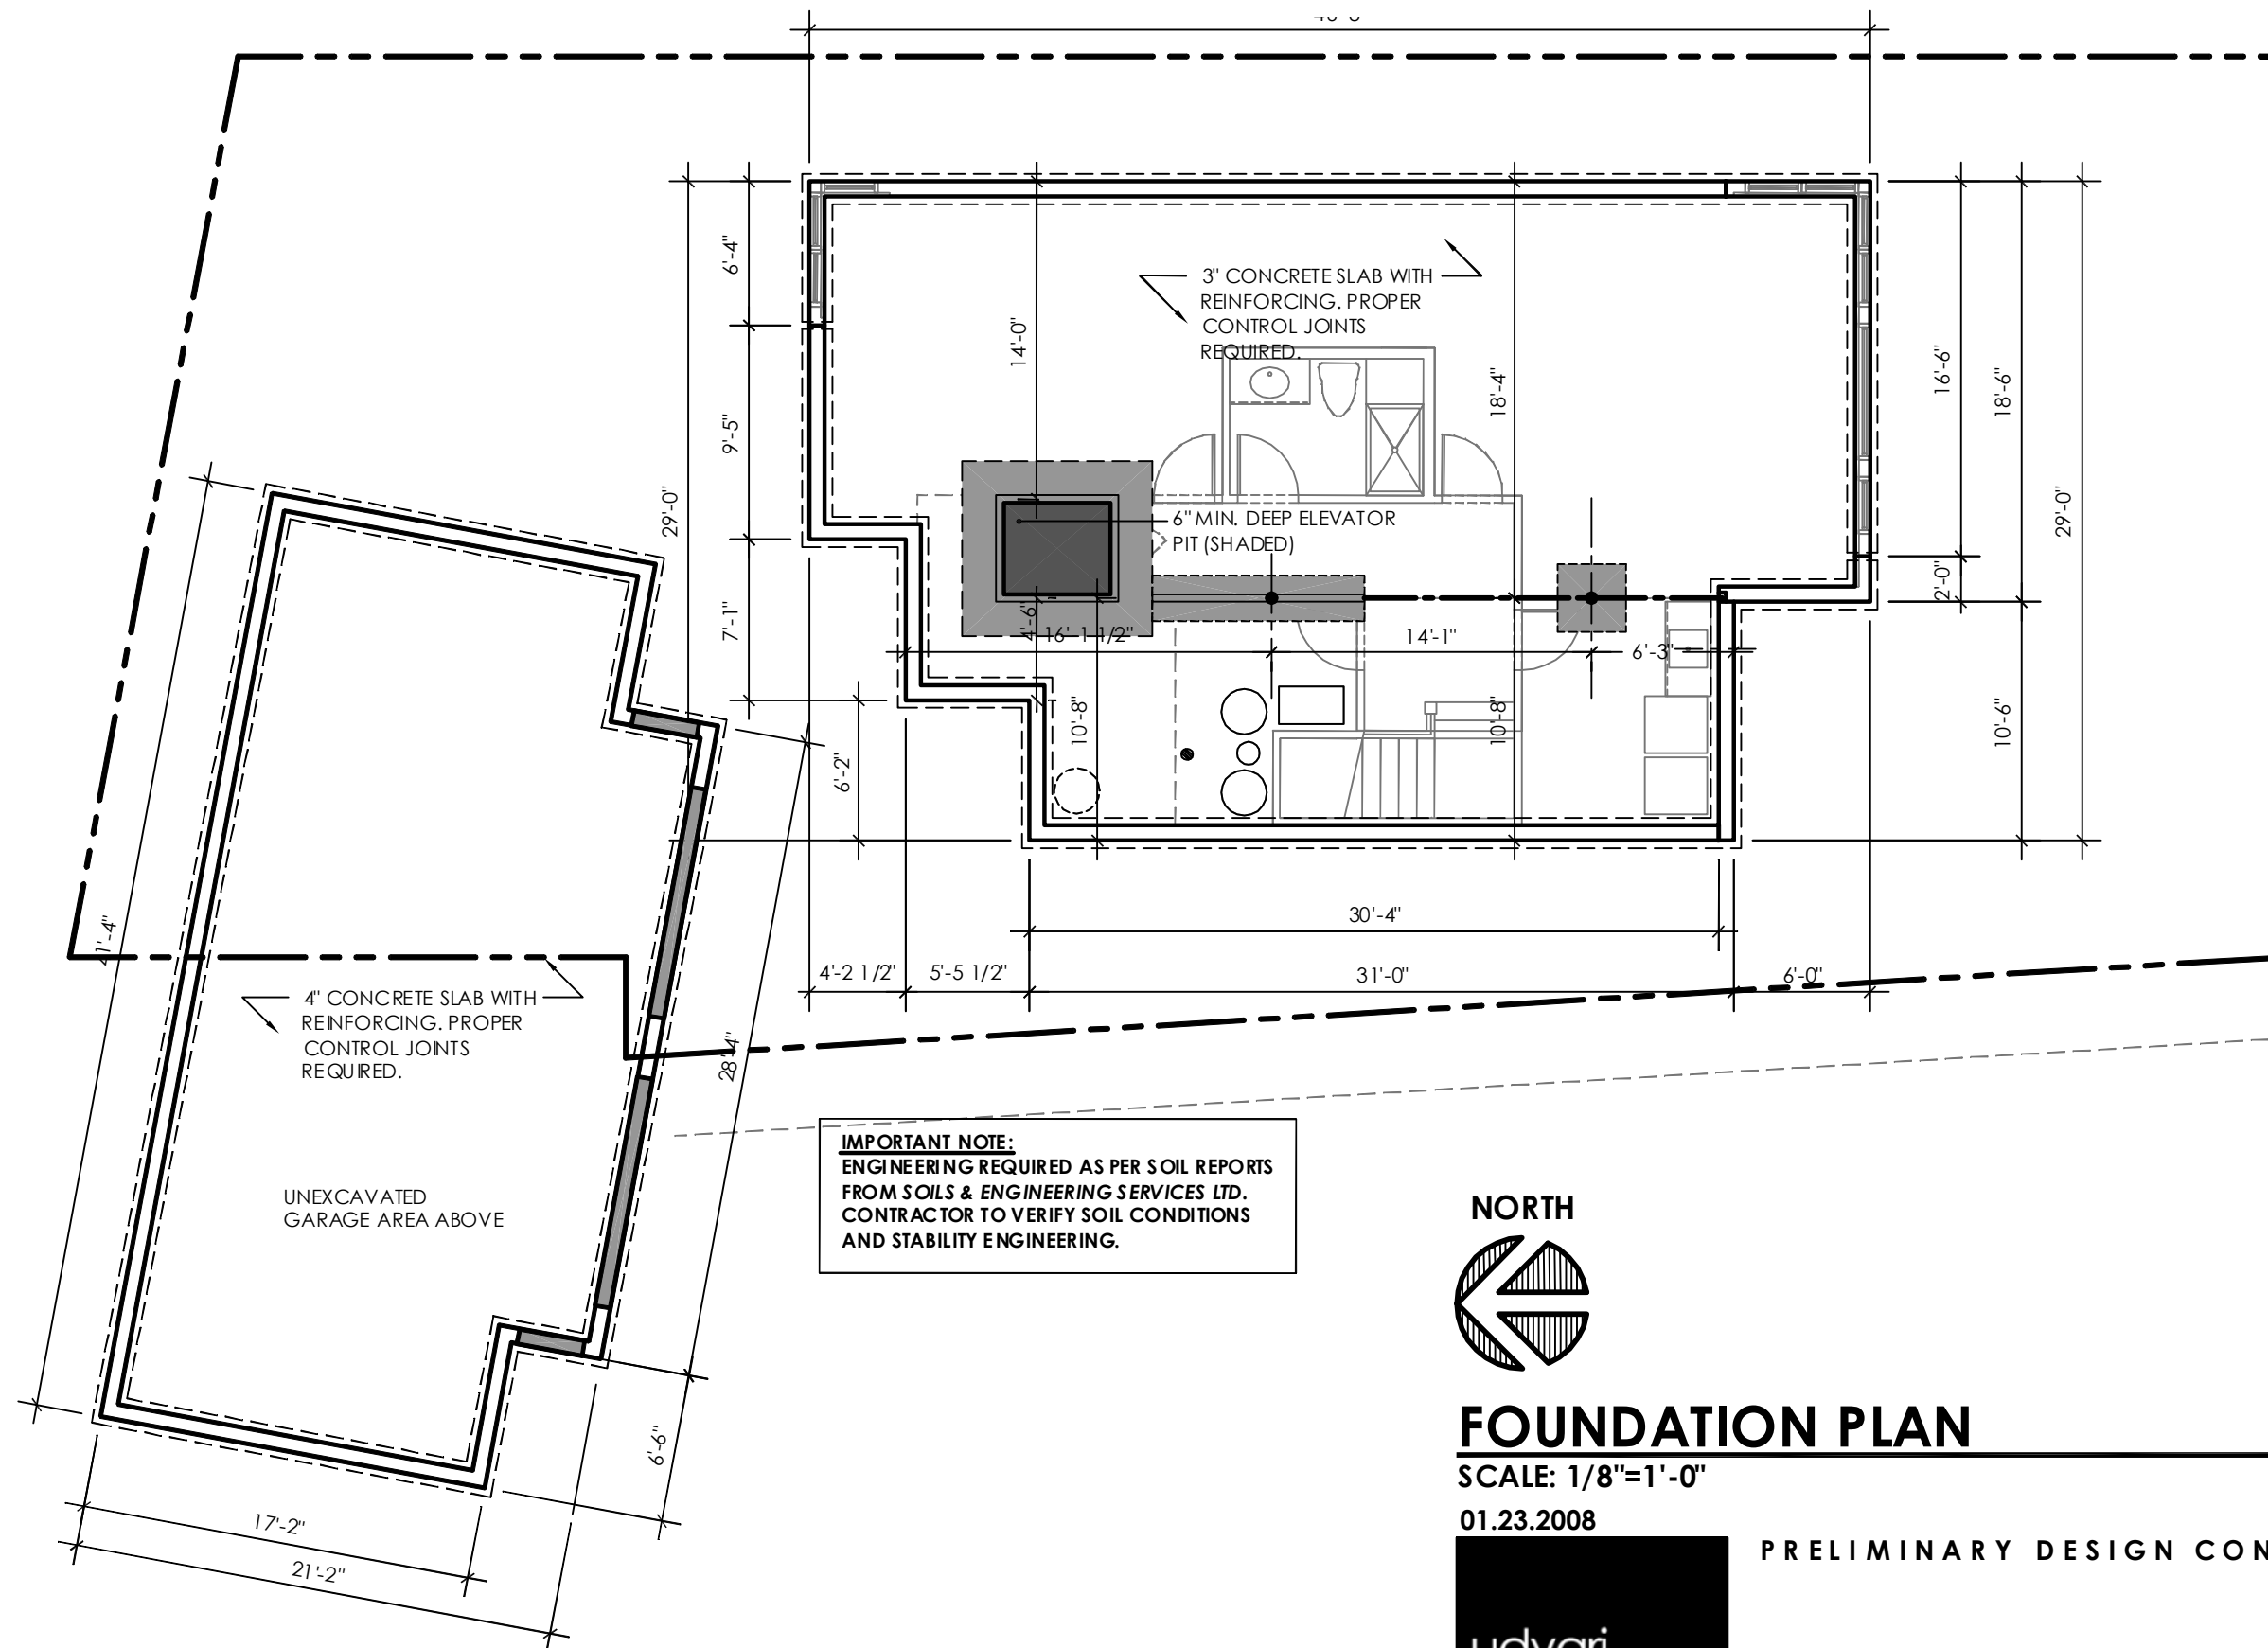

FOUNDATION PLAN

SCALE: 1/8"=1'-0"

01.23.2008


PRELIMINARY DESIGN CONCEPTS FOR



EHRlich/FAGERHOLM RESIDENCE

155 SOUTH BRITTINGHAM ST.
LOT 7

MADISON
DANE COUNTY, WI

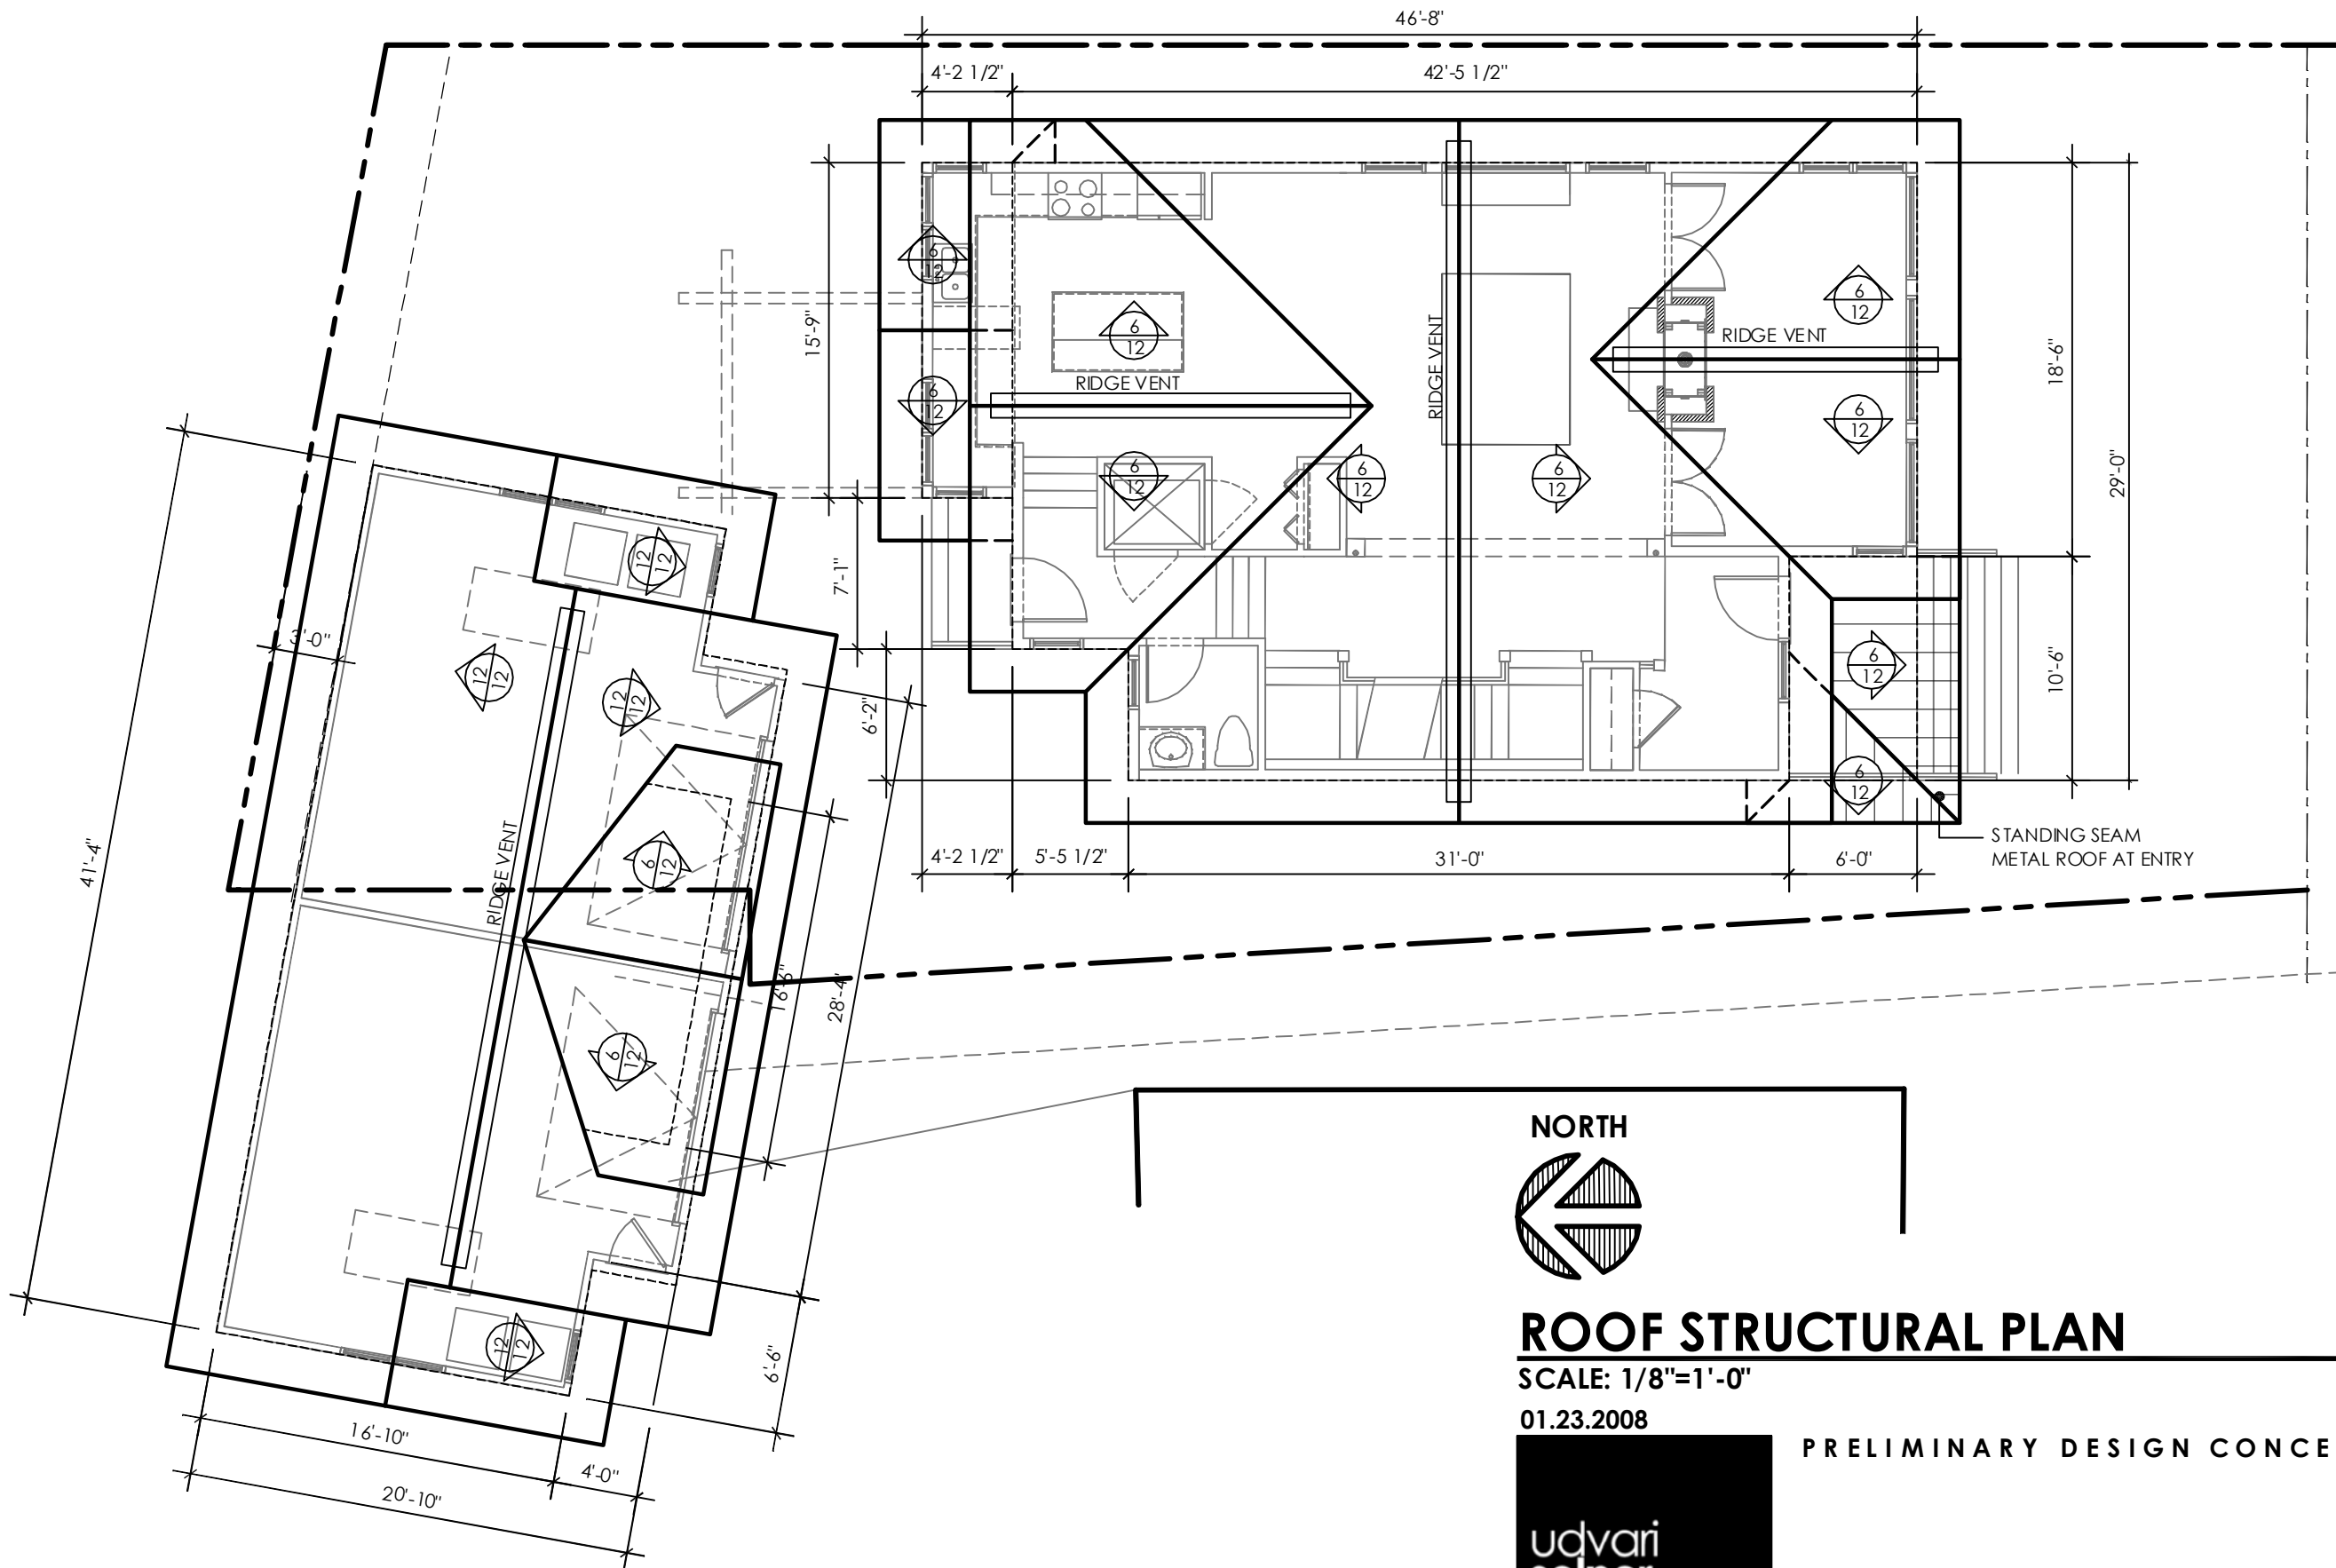

ROOF STRUCTURAL PLAN

SCALE: 1/8"=1'-0"

01.23.2008




PRELIMINARY DESIGN CONCEPTS FOR


EHRlich/FAGERHOLM RESIDENCE

155 SOUTH BRITTINGHAM ST.
LOT 7

MADISON
DANE COUNTY, WI

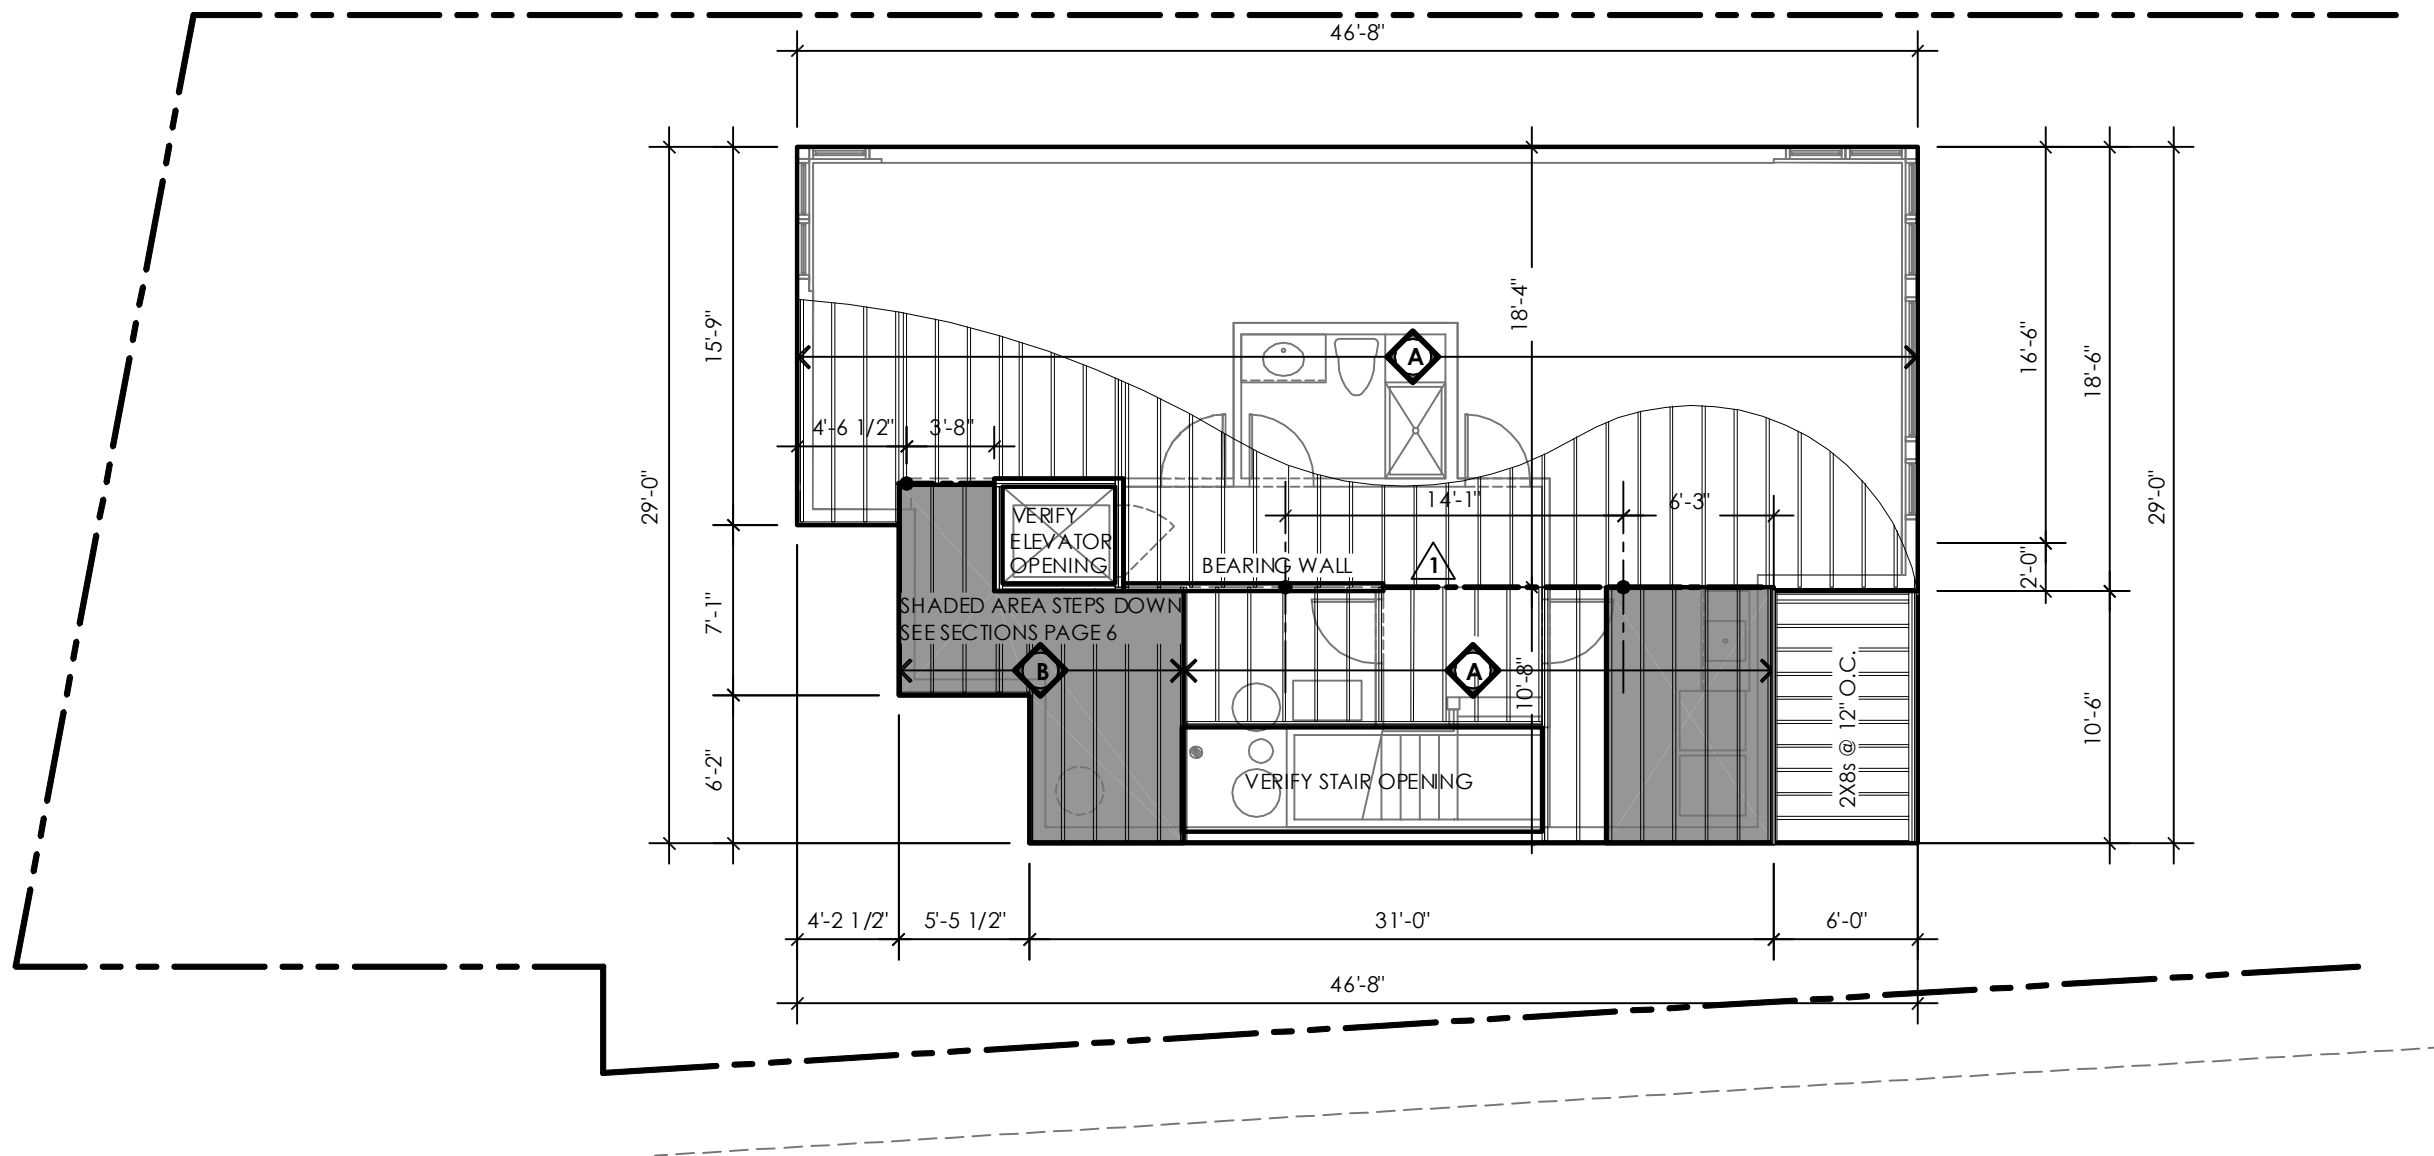

NORTH

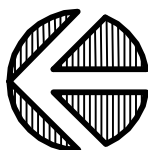

FIRST FLOOR STRUCTURAL PLAN

SCALE: 1/8"=1'-0"

01.23.2008




PRELIMINARY DESIGN CONCEPTS FOR

EHRlich/FAGERHOLM RESIDENCE

155 SOUTH BRITTINGHAM ST.
LOT 7

MADISON
DANE COUNTY, WI

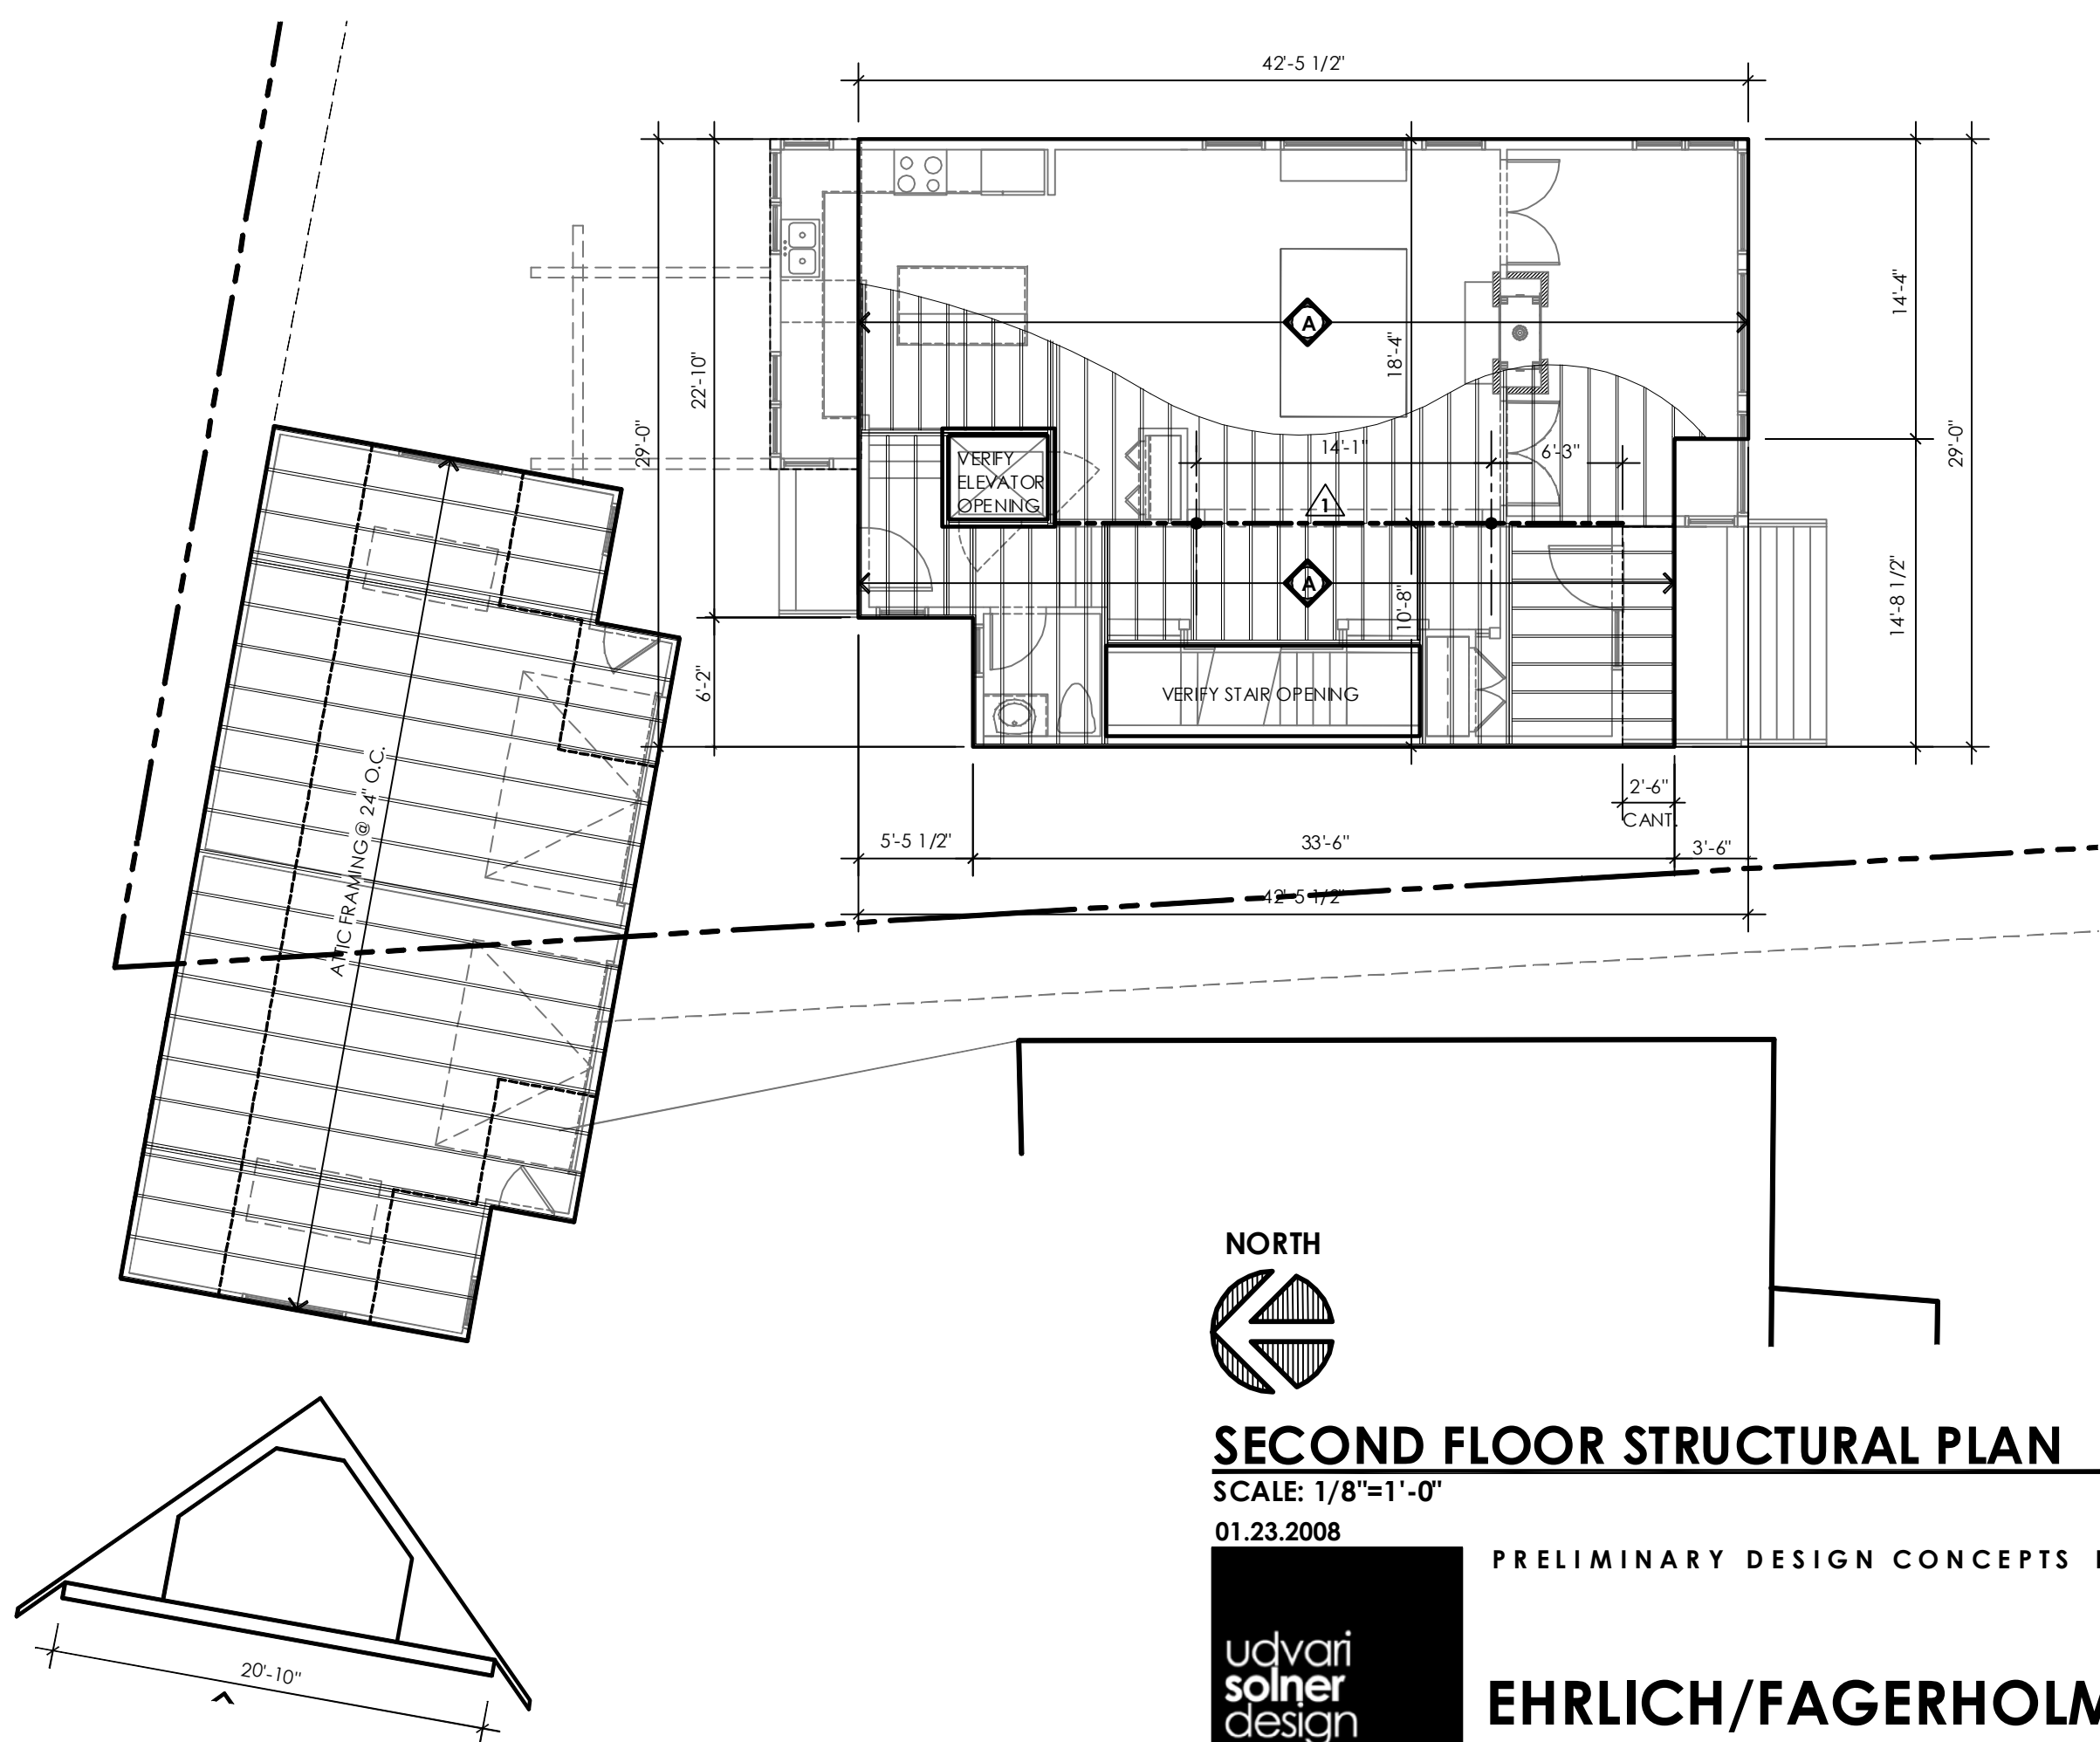

SECOND FLOOR STRUCTURAL PLAN

SCALE: 1/8"=1'-0"

01.23.2008




PRELIMINARY DESIGN CONCEPTS FOR


EHRlich/FAGERHOLM RESIDENCE

155 SOUTH BRITTINGHAM ST.
LOT 7

MADISON
DANE COUNTY, WI

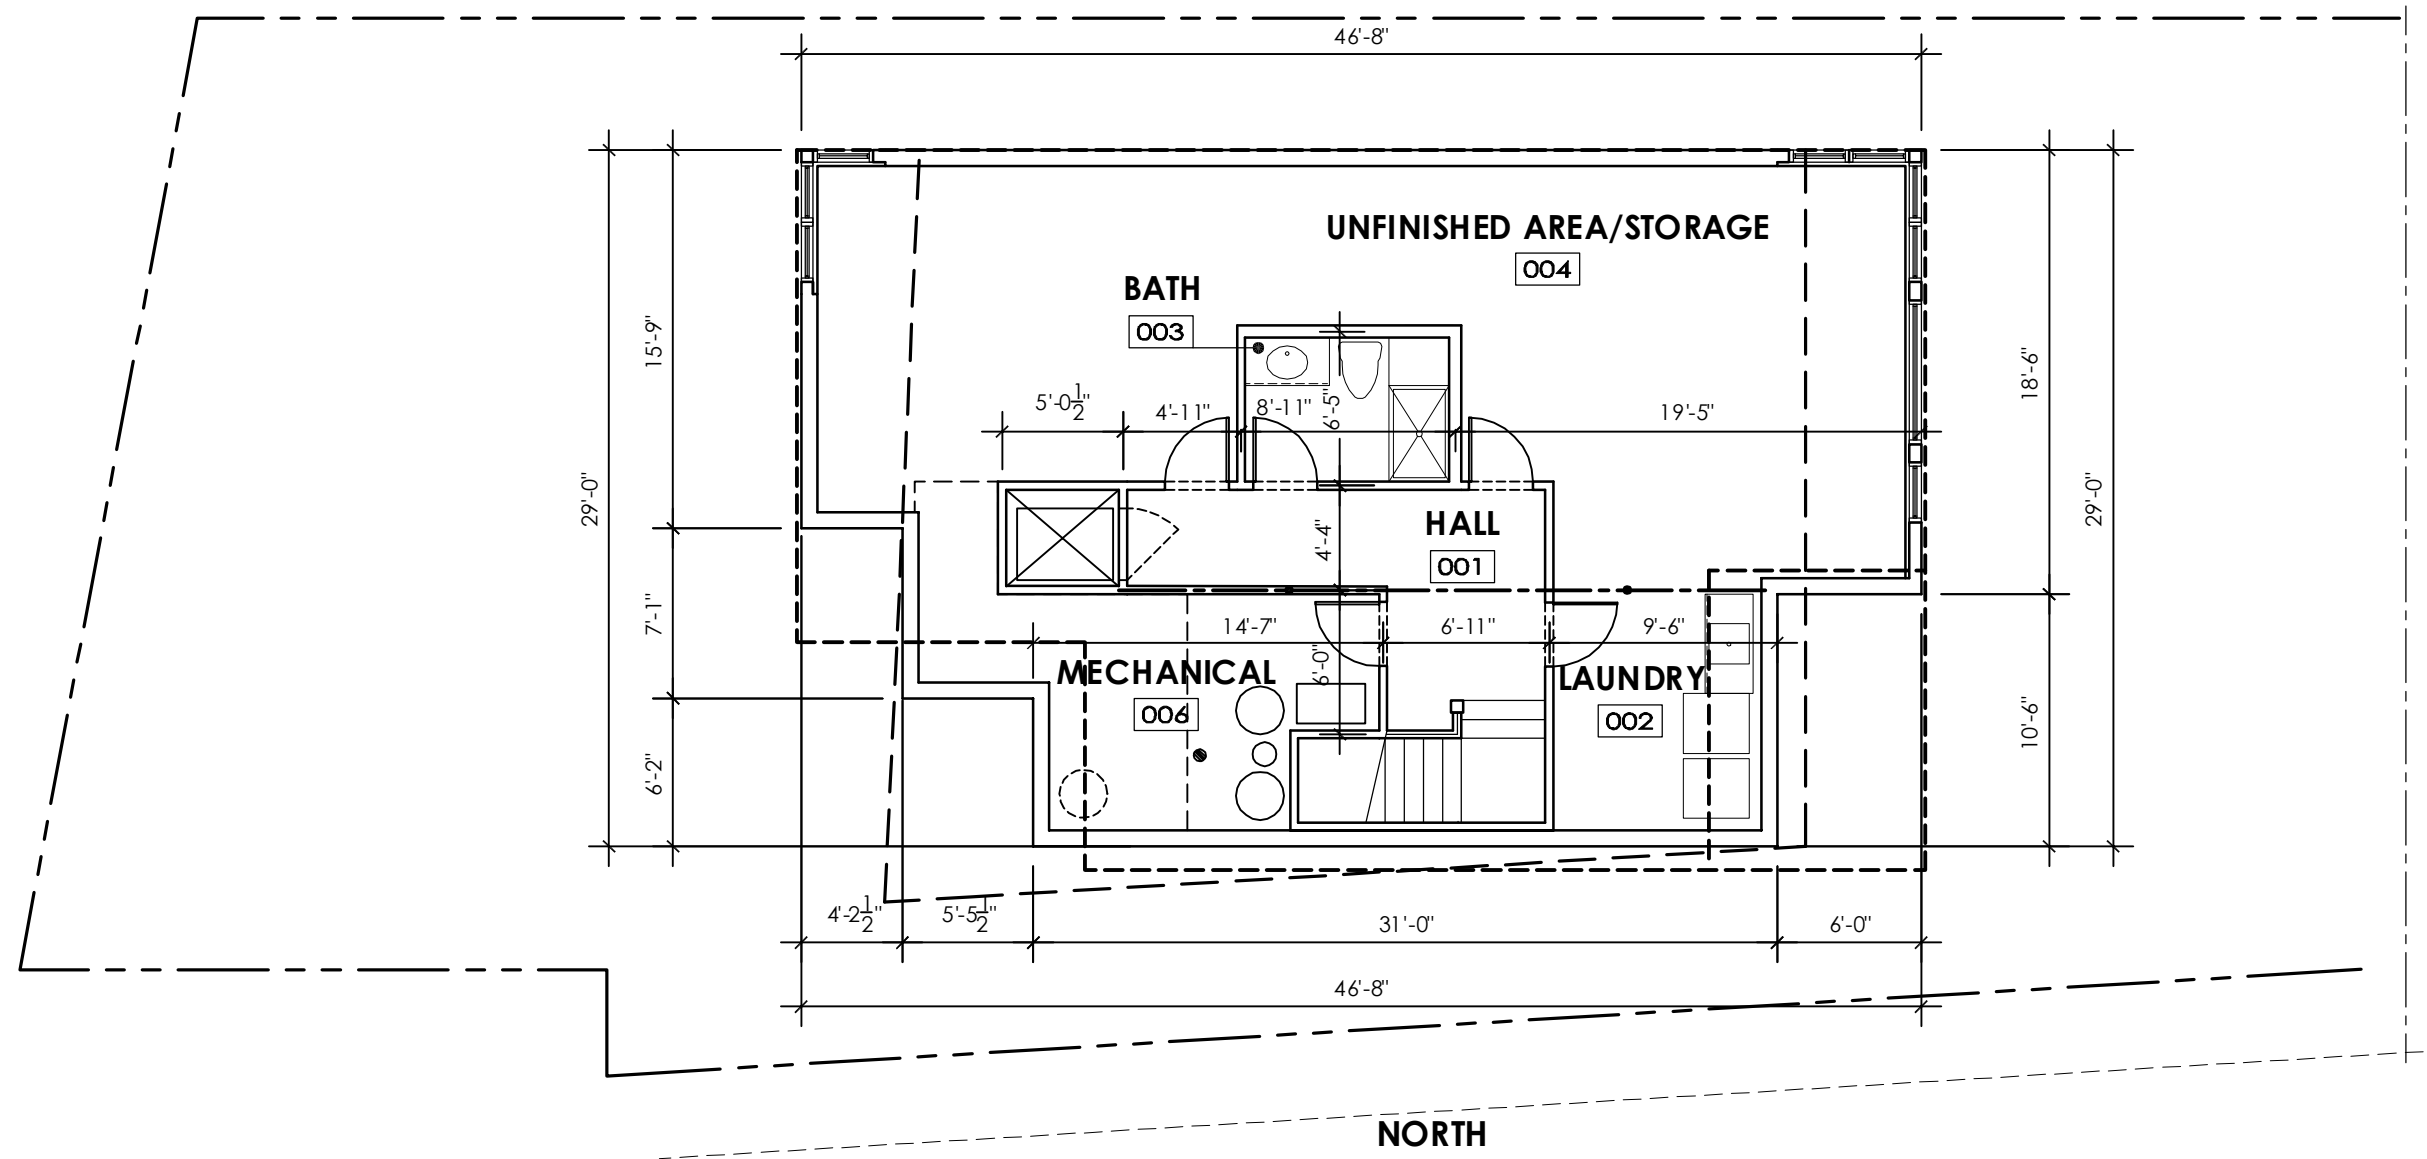

NORTH

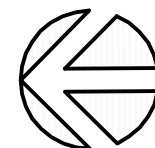

GROUND FLOOR PLAN

SCALE: 1/8"=1'-0"

FINISHED GROUND FLOOR LIVING SPACE SQUARE FEET

185

01.23.2008




PRELIMINARY DESIGN CONCEPTS FOR

EHRlich/FAGERHOLM RESIDENCE

155 SOUTH BRITTINGHAM ST.
LOT 7

MADISON
DANE COUNTY, WI

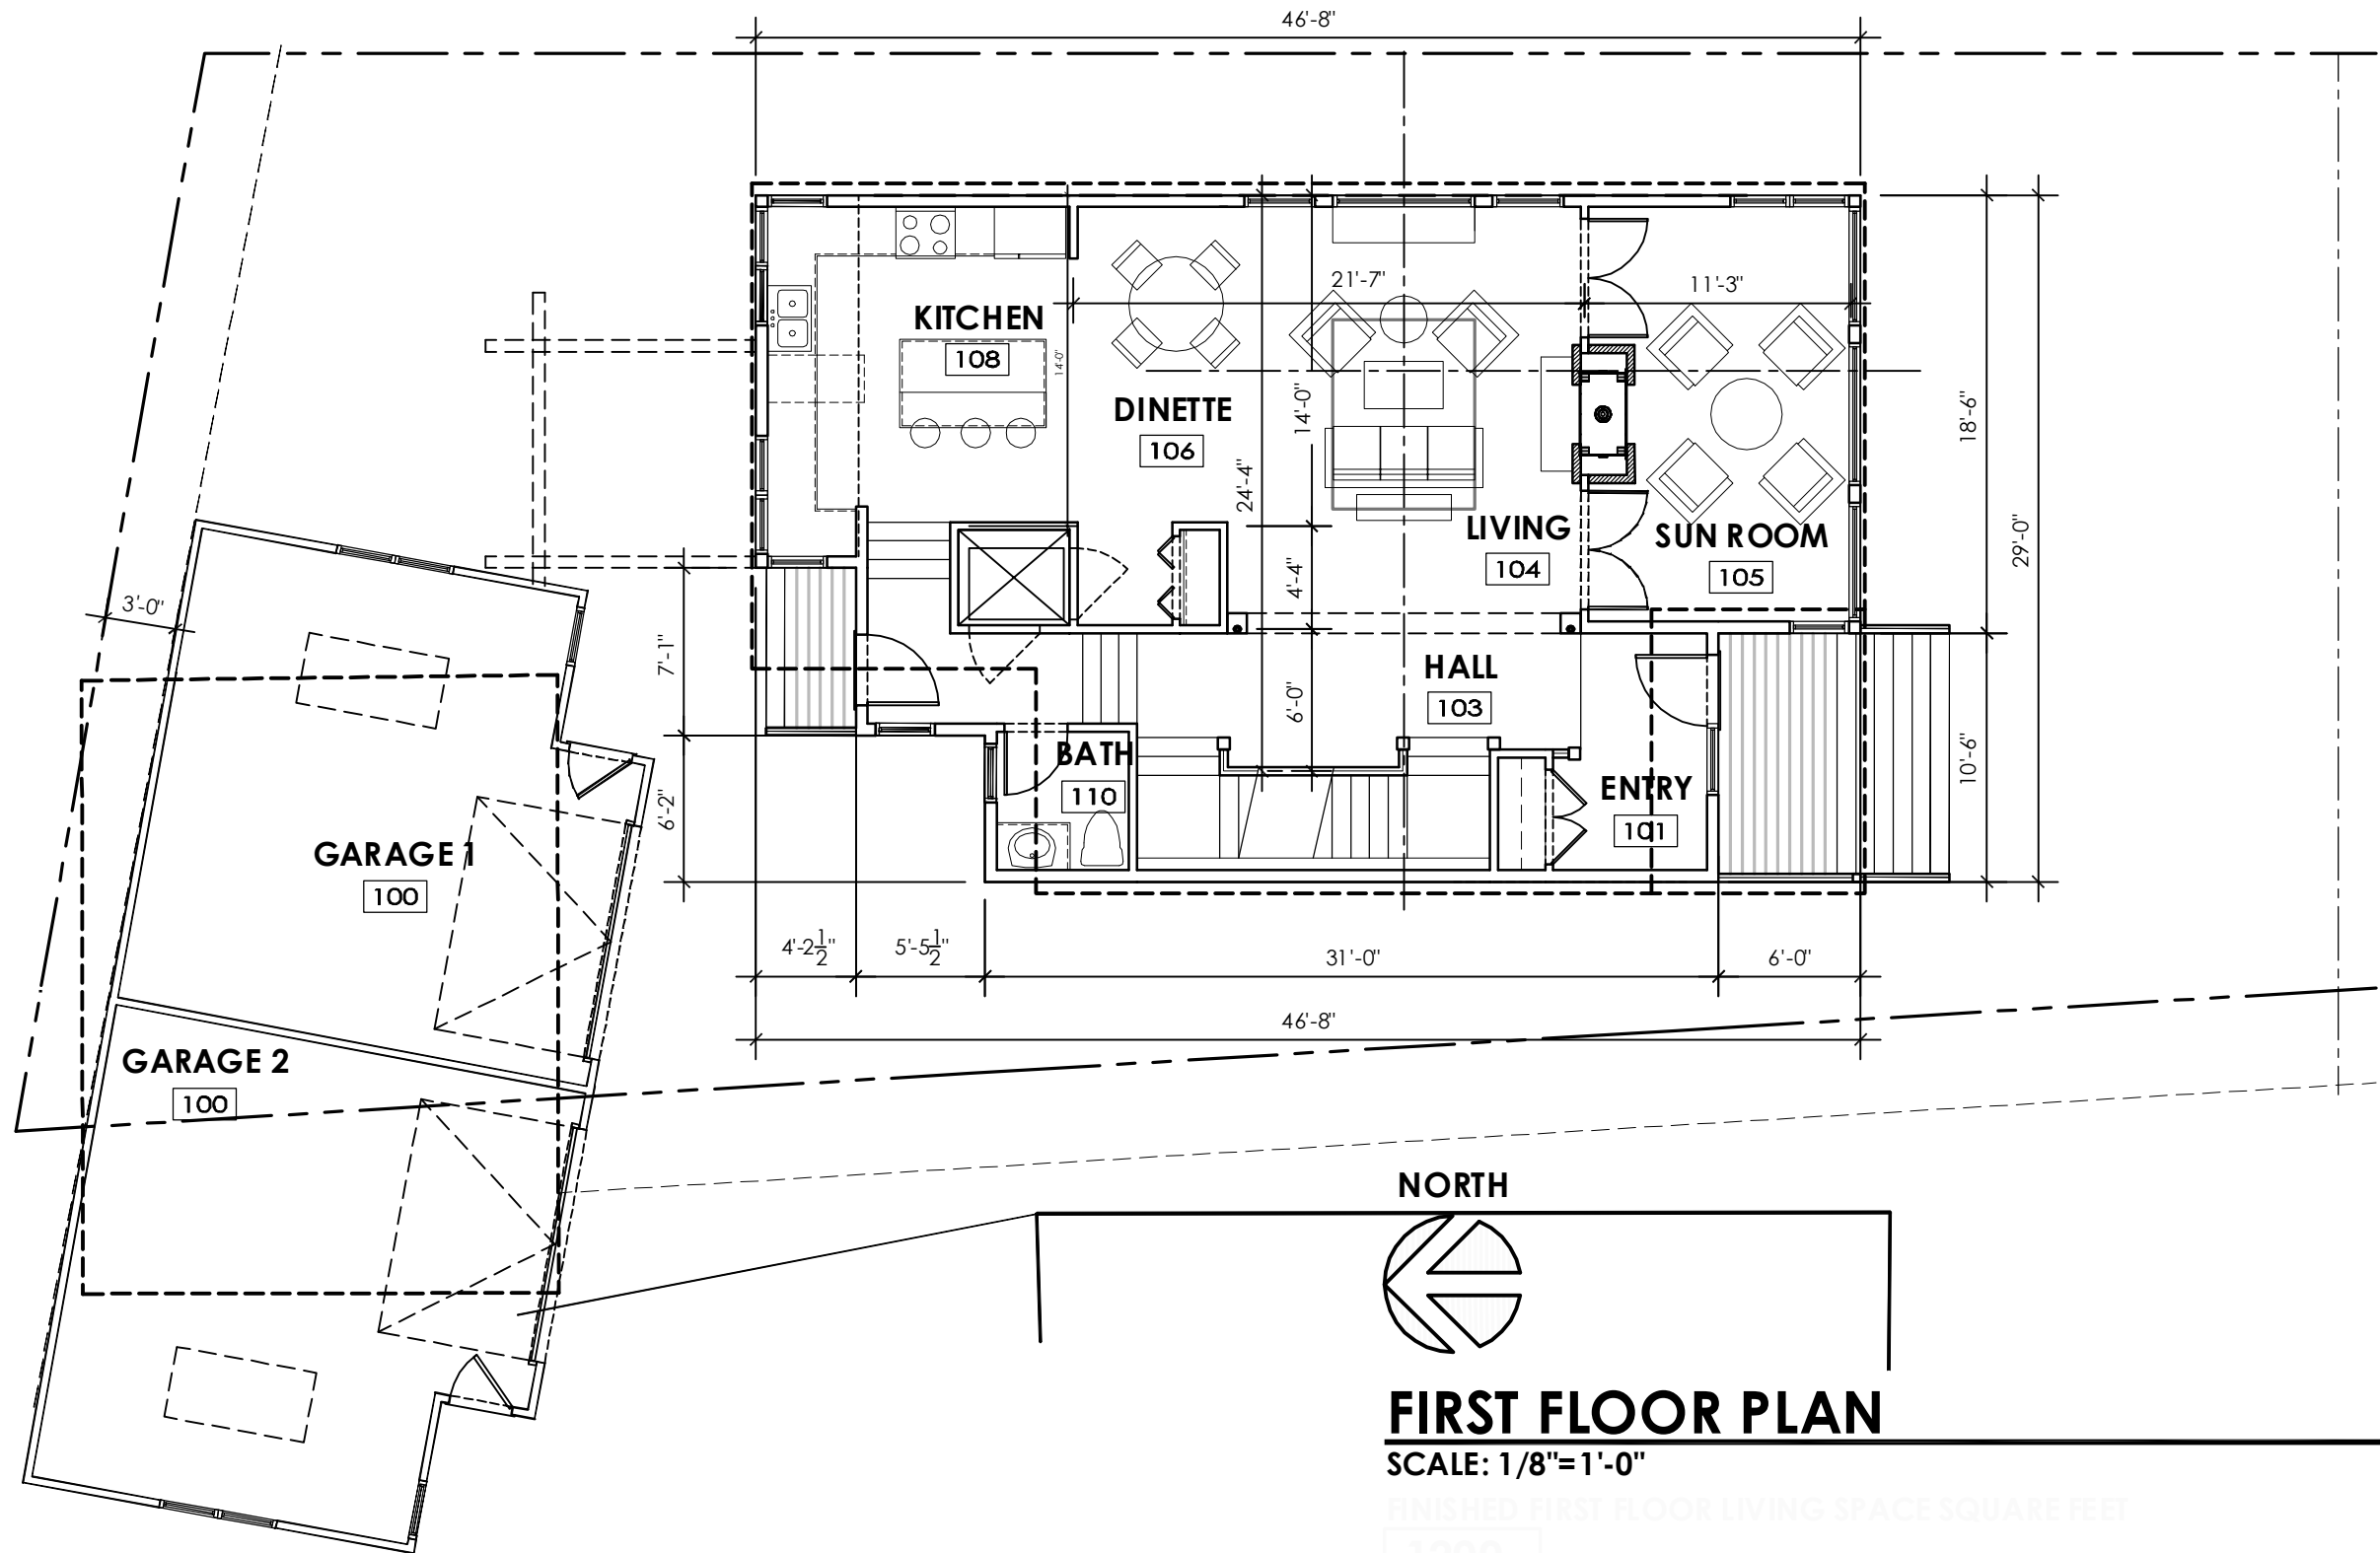

FIRST FLOOR PLAN

SCALE: 1/8"=1'-0"

FINISHED FIRST FLOOR LIVING SPACE SQUARE FEET
1200

01.23.2008





PRELIMINARY DESIGN CONCEPTS FOR

EHRlich/FAGERHOLM RESIDENCE

155 SOUTH BRITTINGHAM ST.
LOT 7

MADISON
DANE COUNTY, WI

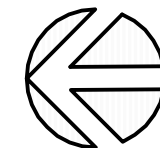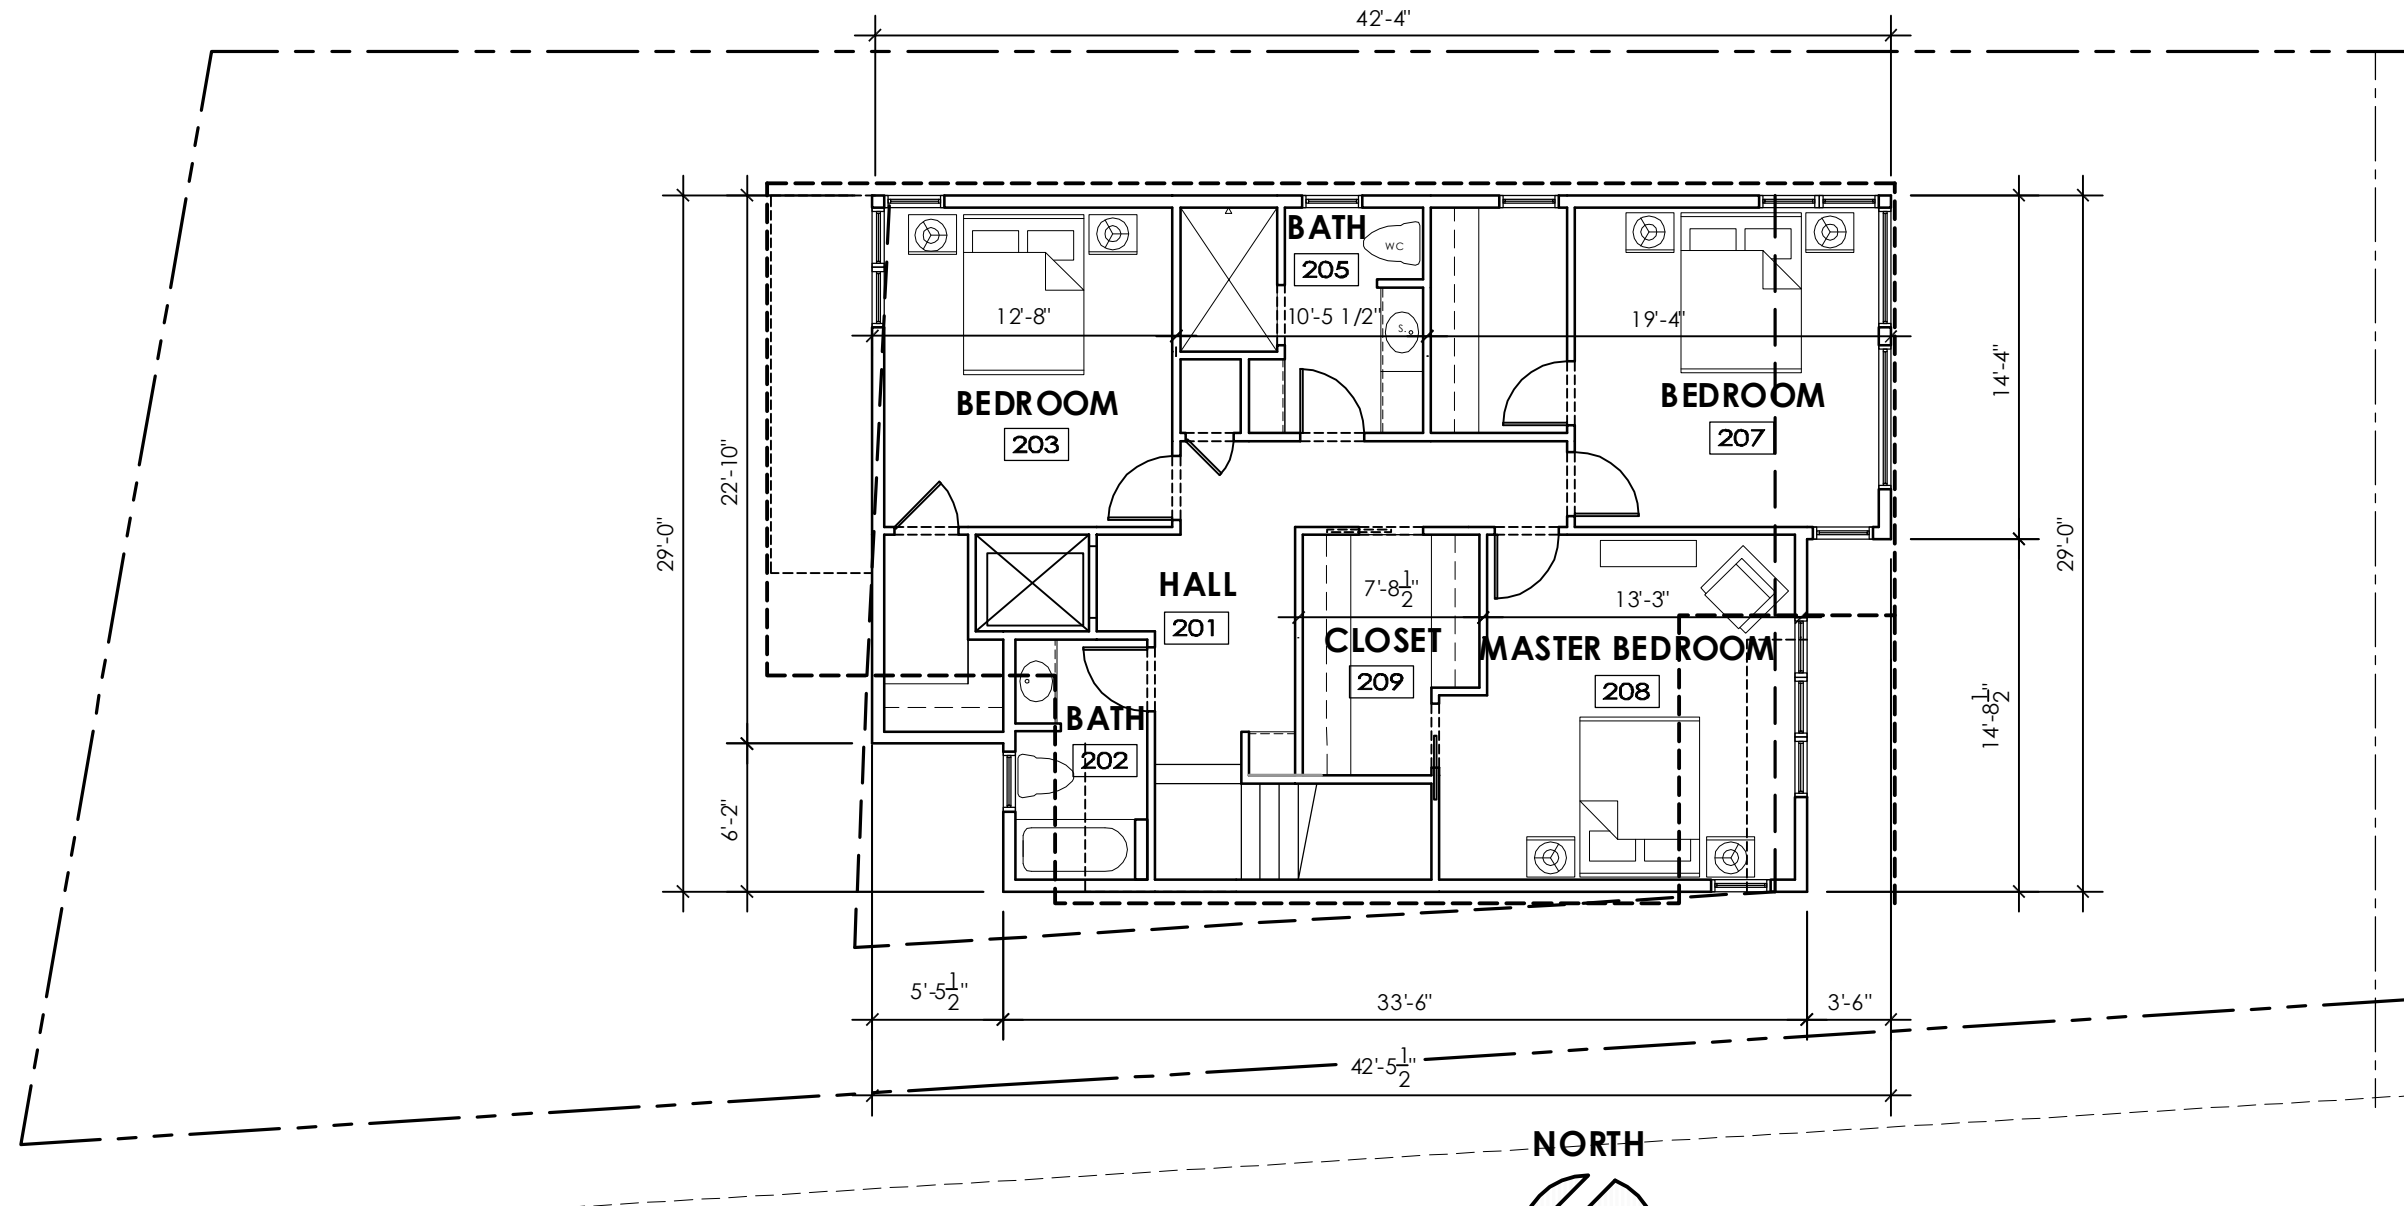

SECOND FLOOR PLAN

SCALE: 1/8"=1'-0"

FINISHED SECOND FLOOR LIVING SPACE SQUARE FEET

1070

01.23.2008




PRELIMINARY DESIGN CONCEPTS FOR

EHRlich/FAGERHOLM RESIDENCE


155 SOUTH BRITTINGHAM ST.
LOT 7

MADISON
DANE COUNTY, WI

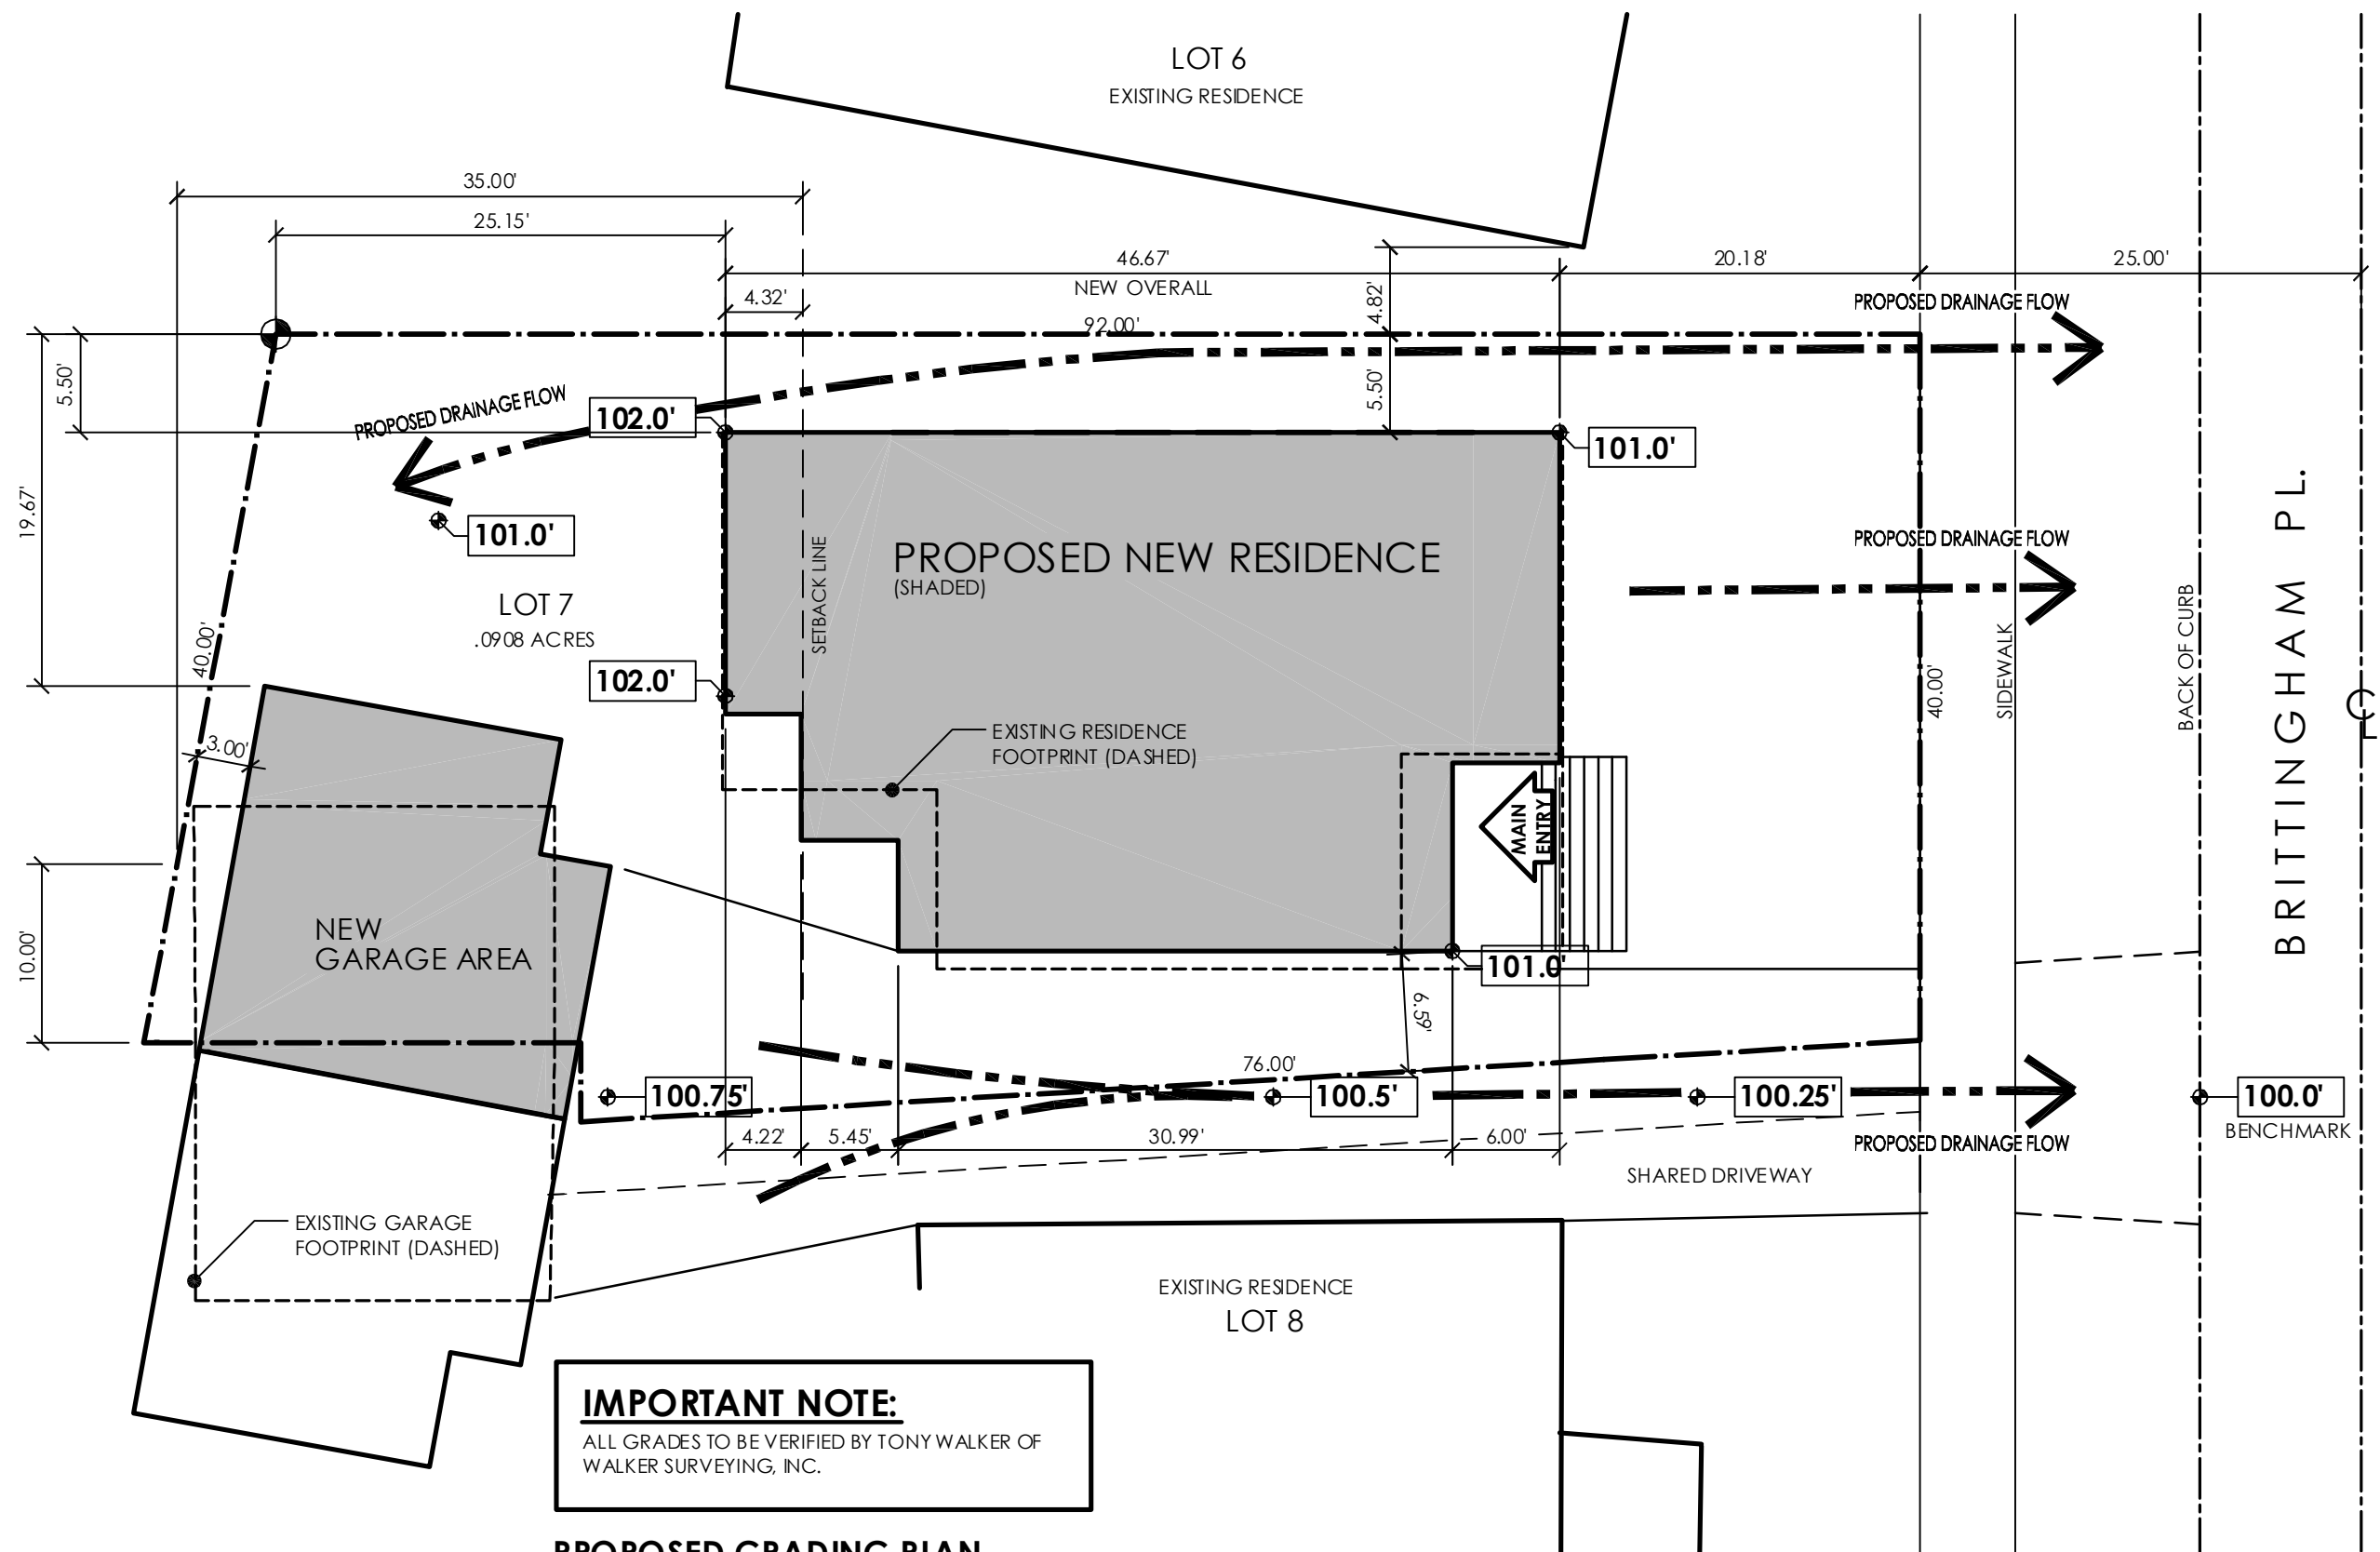

IMPORTANT NOTE:
ALL GRADES TO BE VERIFIED BY TONY WALKER OF
WALKER SURVEYING, INC.

 PROPOSED GRADING PLAN



01.23.2008




PRELIMINARY DESIGN CONCEPTS FOR

EHRlich/FAGERHOLM RESIDENCE

155 SOUTH BRITTINGHAM ST.
LOT 7


MADISON
ZONE R4, DANE COUNTY, WI

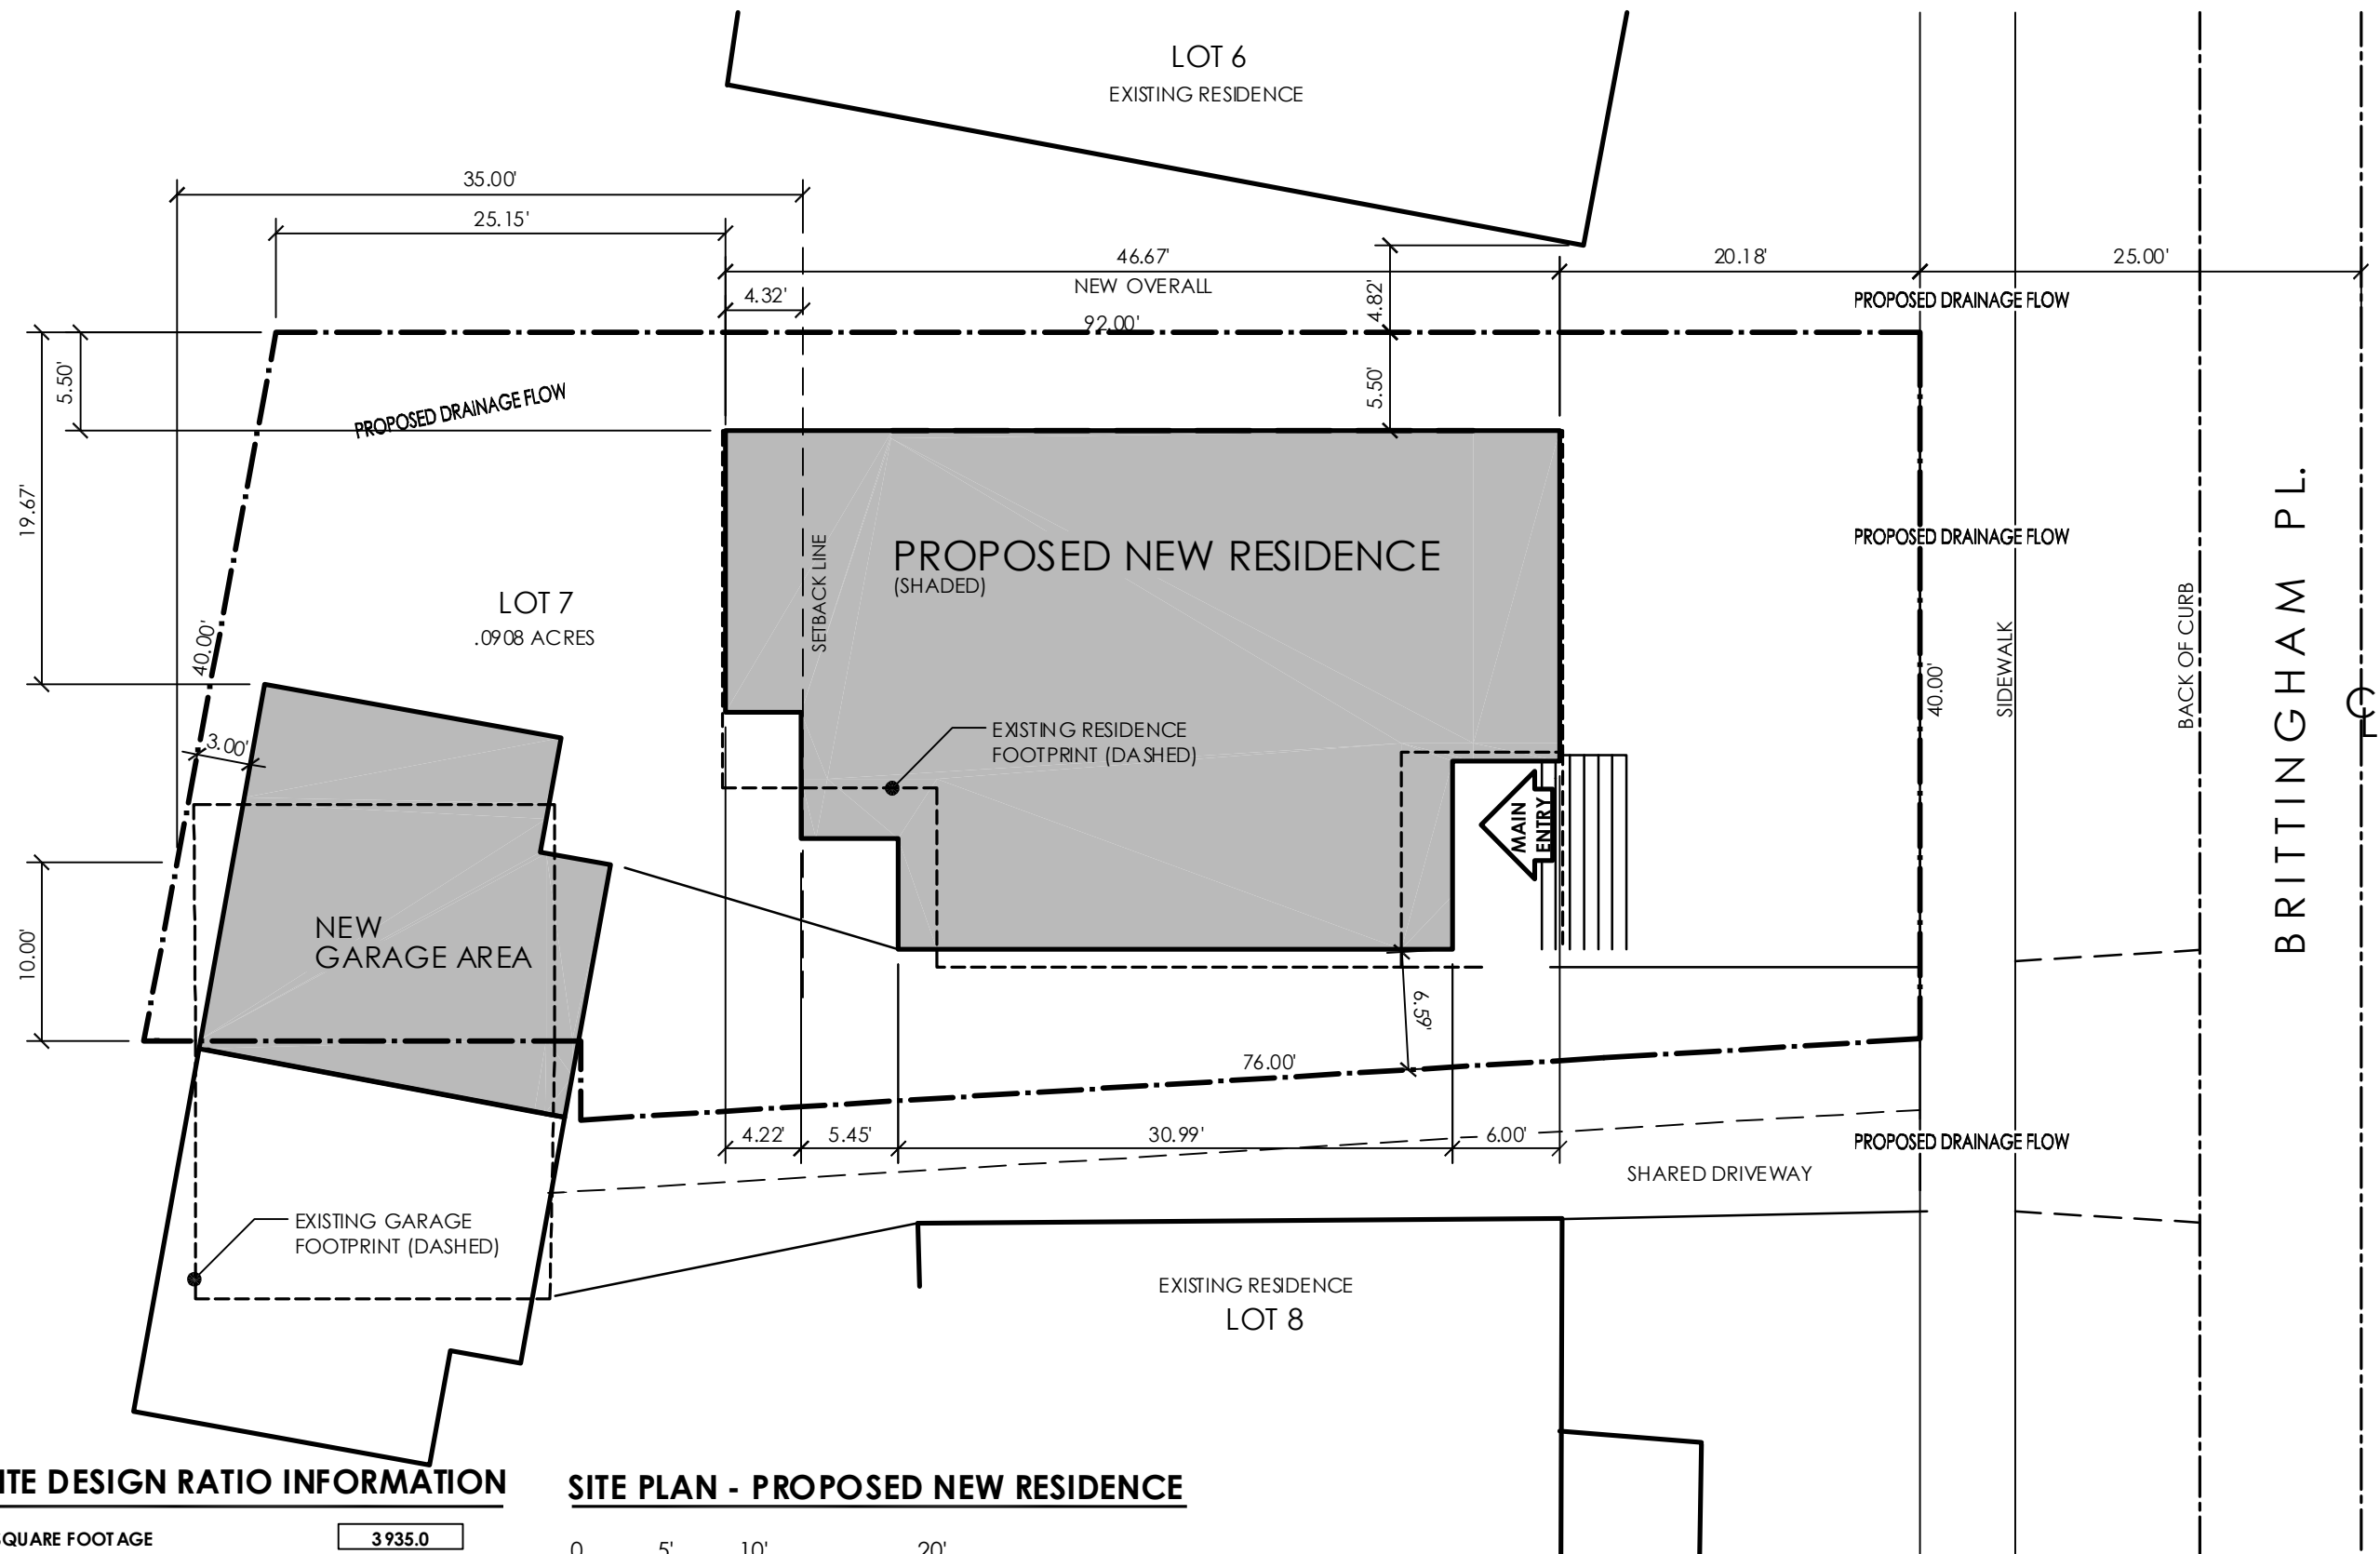

NEW SITE DESIGN RATIO INFORMATION

TOTAL LOT SQUARE FOOTAGE	3935.0
NEW BUILDING GROUND COVERAGESQUARE FOOTAGE	1200.0
1200.0 / 3957.0 = 30.3 %	30.3 %
GARAGE GROUND COVERAGE SQARE FOOTAGE	413.0
413.0 / 3957.0 = 10.4 %	10.4 %
NEW BUILDING + GARAGE GROUND COVERAGE SQUARE FOOTAGE	1613.0
1587.0 / 3957.0 = 40.1 %	40.1 %

 SITE PLAN - PROPOSED NEW RESIDENCE




01.23.2008



PRELIMINARY DESIGN CONCEPTS FOR


EHRlich/FAGERHOLM RESIDENCE
155 SOUTH BRITTINGHAM ST. MADISON
LOT 7 ZONE R4, DANE COUNTY, WI

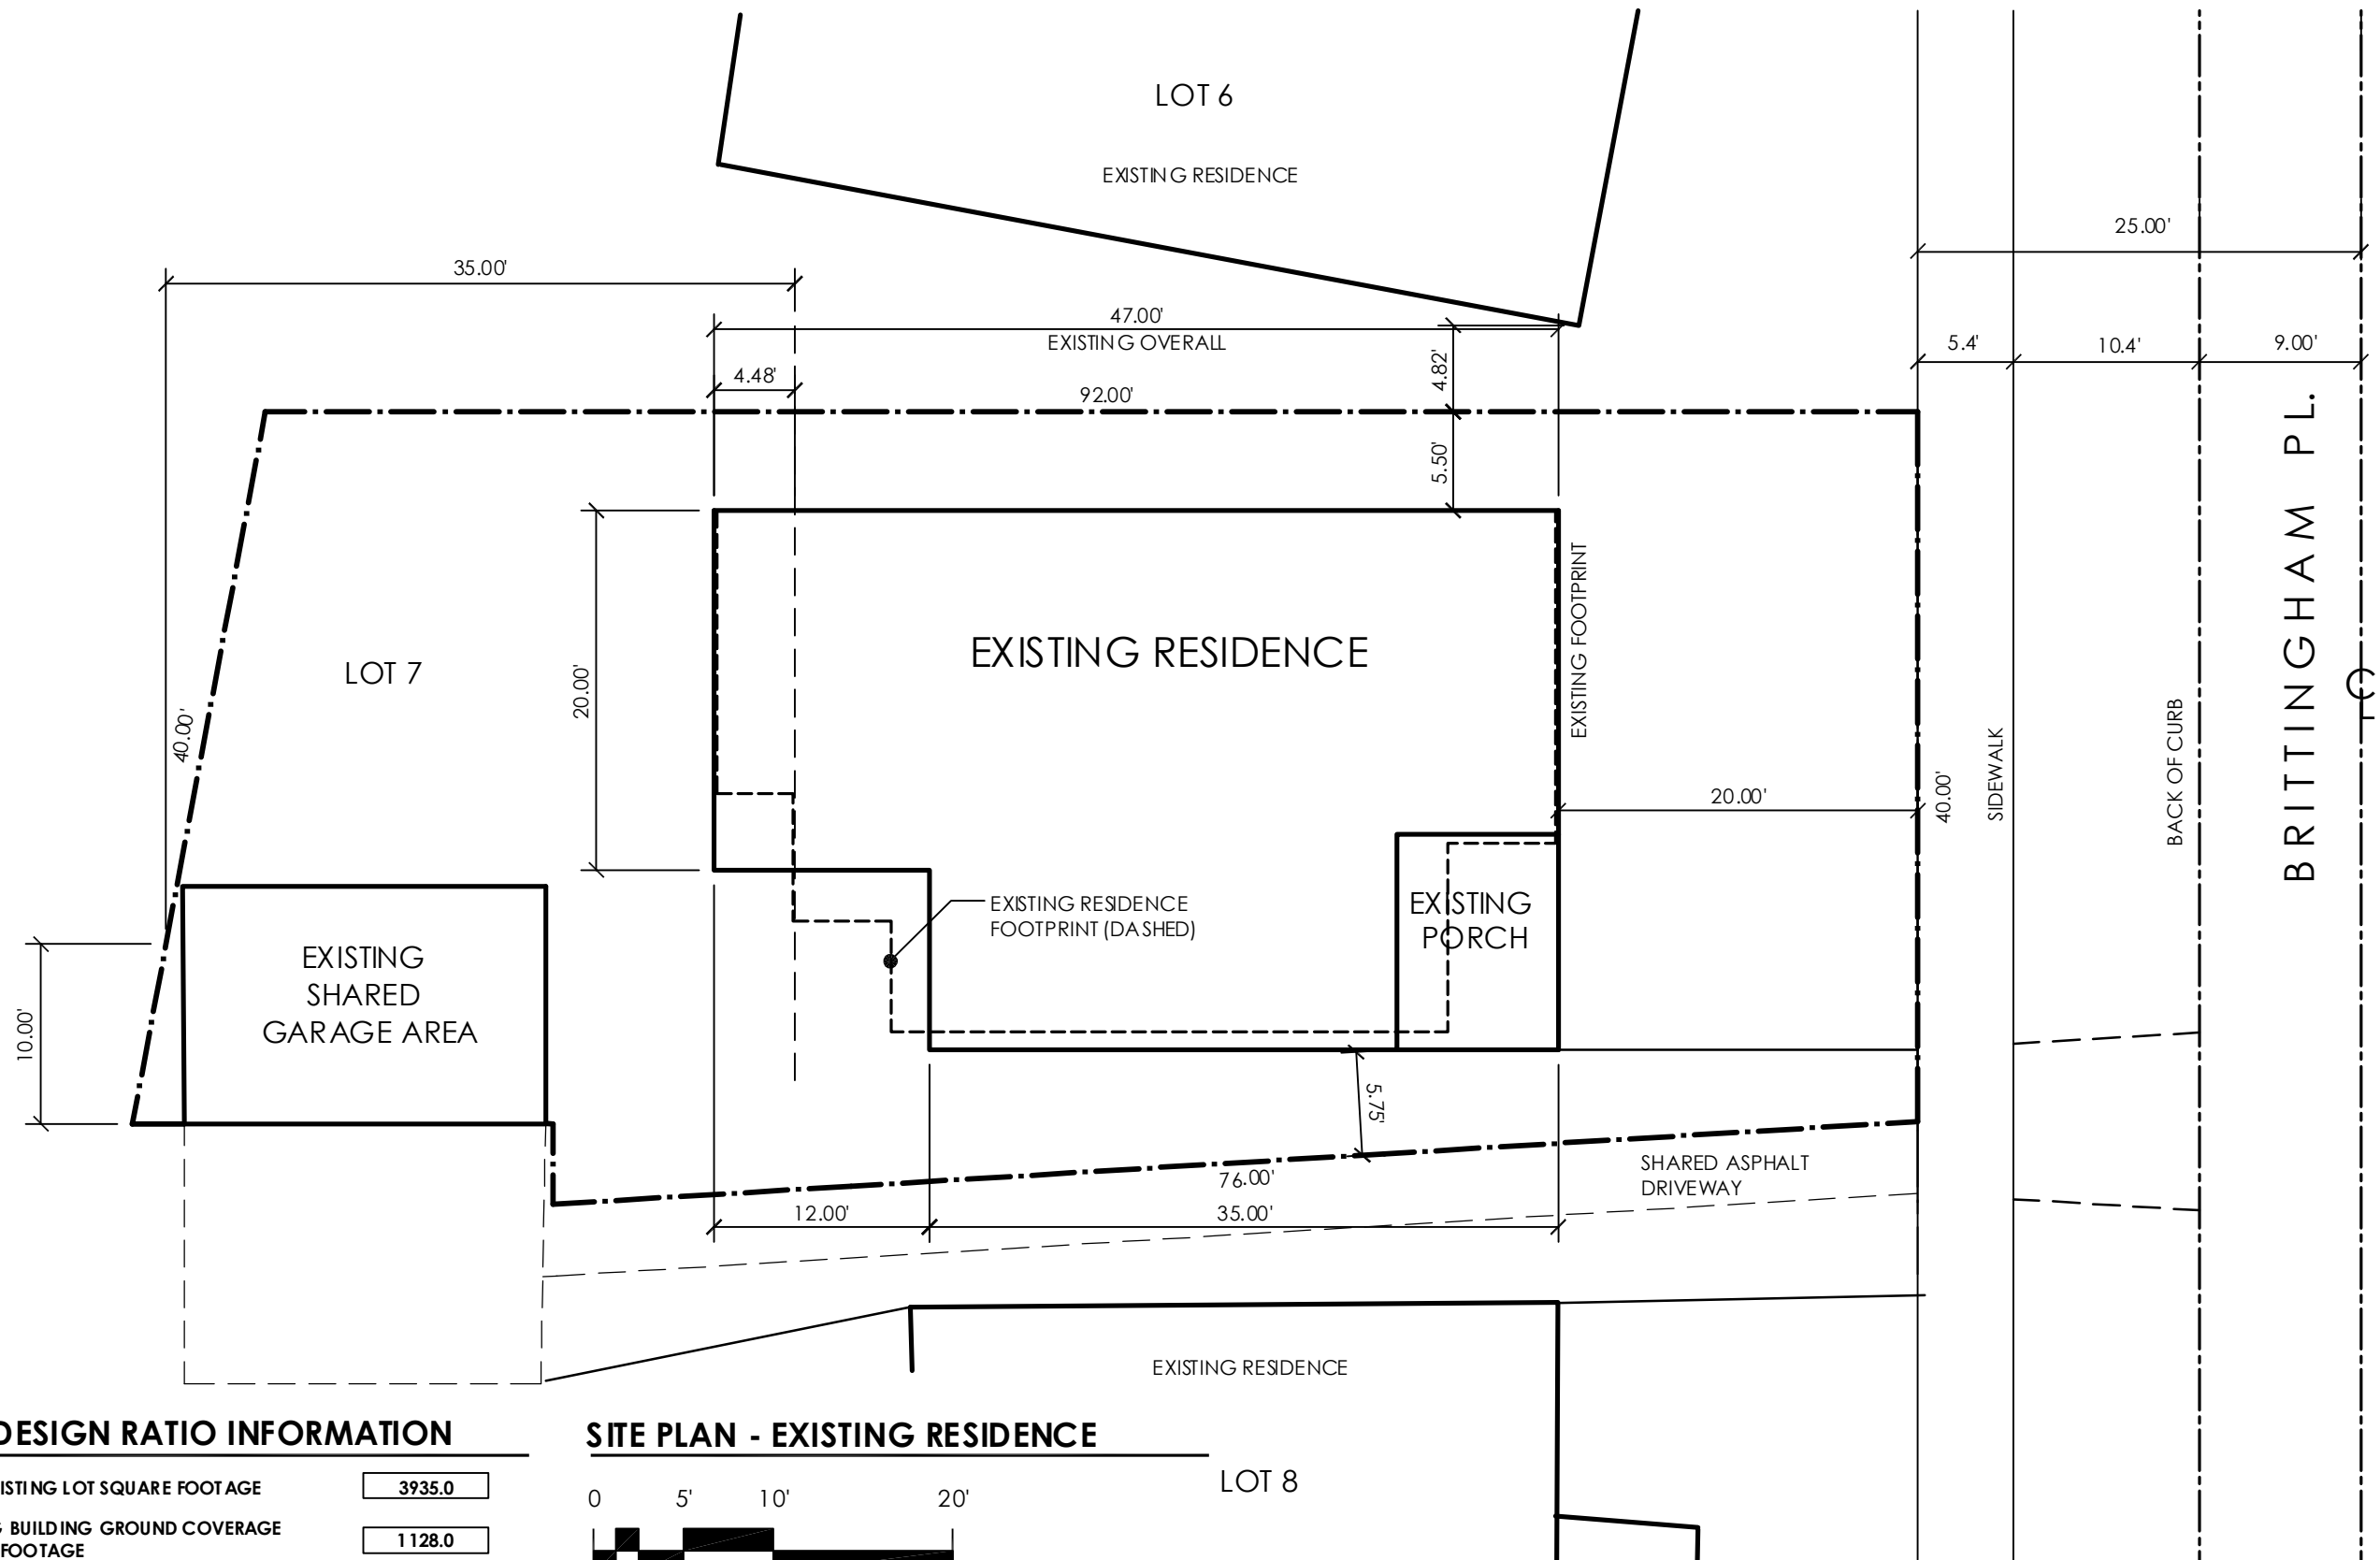

SITE DESIGN RATIO INFORMATION

TOTAL EXISTING LOT SQUARE FOOTAGE	3935.0
EXISTING BUILDING GROUND COVERAGE SQUARE FOOTAGE	1128.0
1128.0 / 3957.0 = 27.8 %	27.8 %
EXISTING GARAGE GROUND COVERAGE SQUARE FOOTAGE	266.0
266.0 / 3957.0 = 6.7 %	6.7 %
EXISTING BUILDING + GARAGE GROUND COVERAGE SQUARE FOOTAGE	1394.0
1394.0 / 3957.0 = 35.2 %	35.2 %

 SITE PLAN - EXISTING RESIDENCE




01.23.2008



PRELIMINARY DESIGN CONCEPTS FOR


EHRlich/FAGERHOLM RESIDENCE
155 SOUTH BRITTINGHAM ST. MADISON
LOT 7 ZONE R4, DANE COUNTY, WI

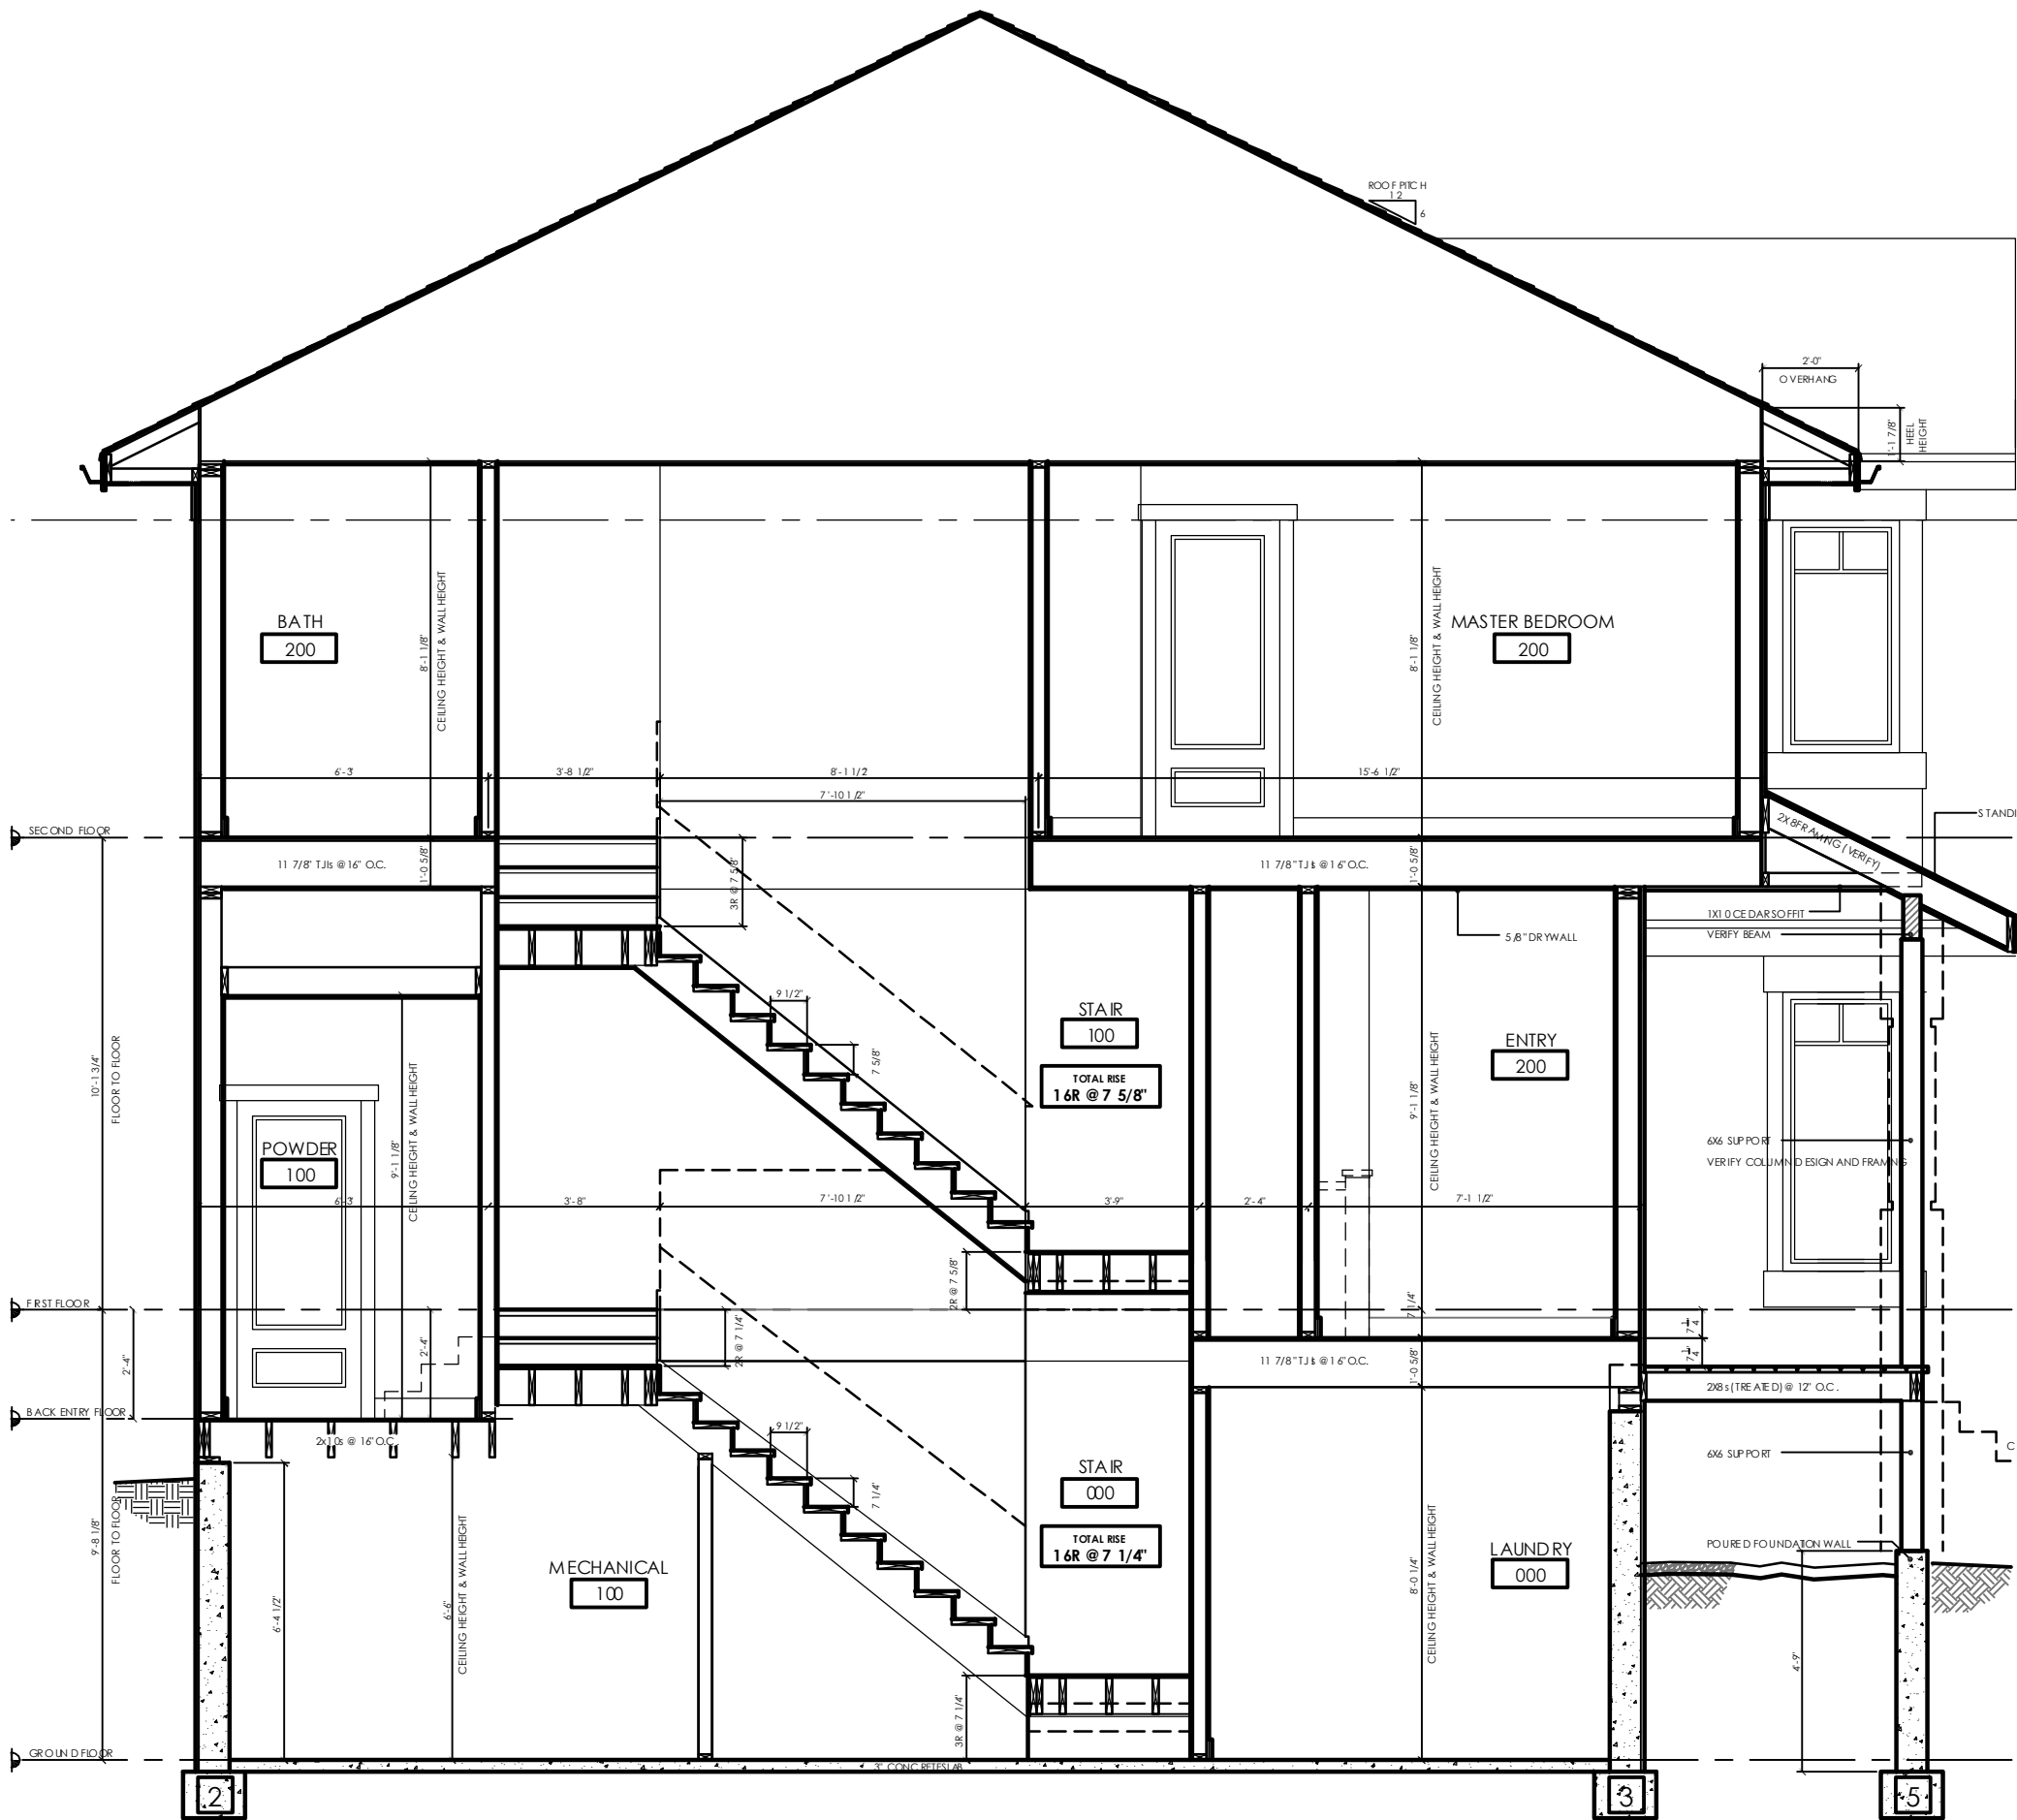

1
6

**CROSS SECTION AT STAIRS
AND FLOOR LEVEL CHANGES**


SCALE: 1/4" = 1'-0"

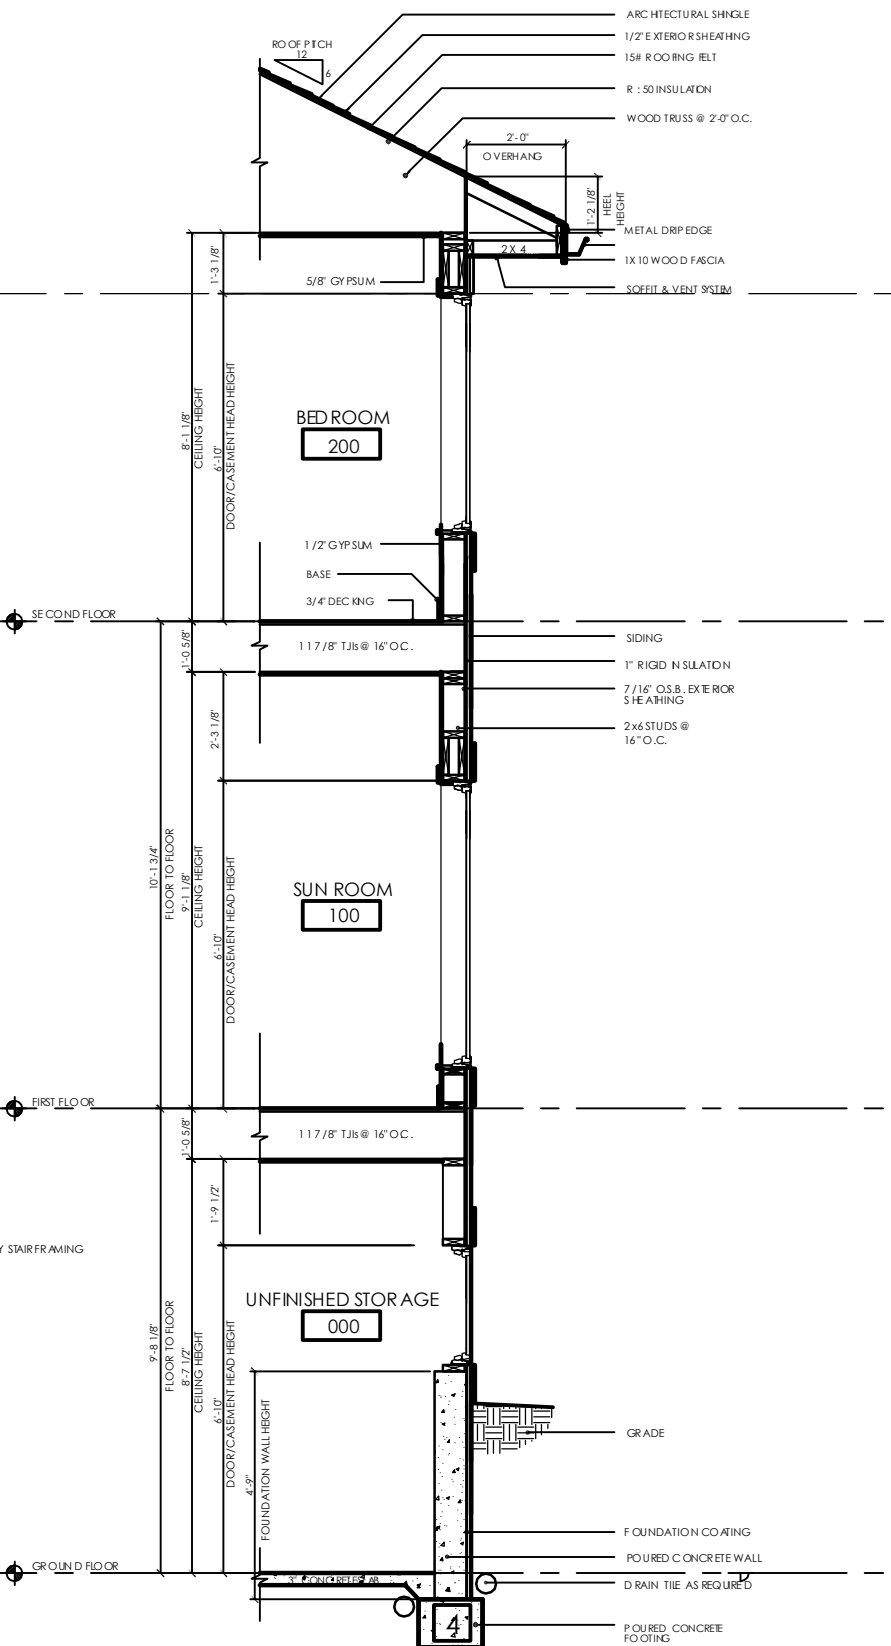

2
6

**WALL SECTION @
TWO-STORY AREA**


SCALE: 1/4" = 1'-0"

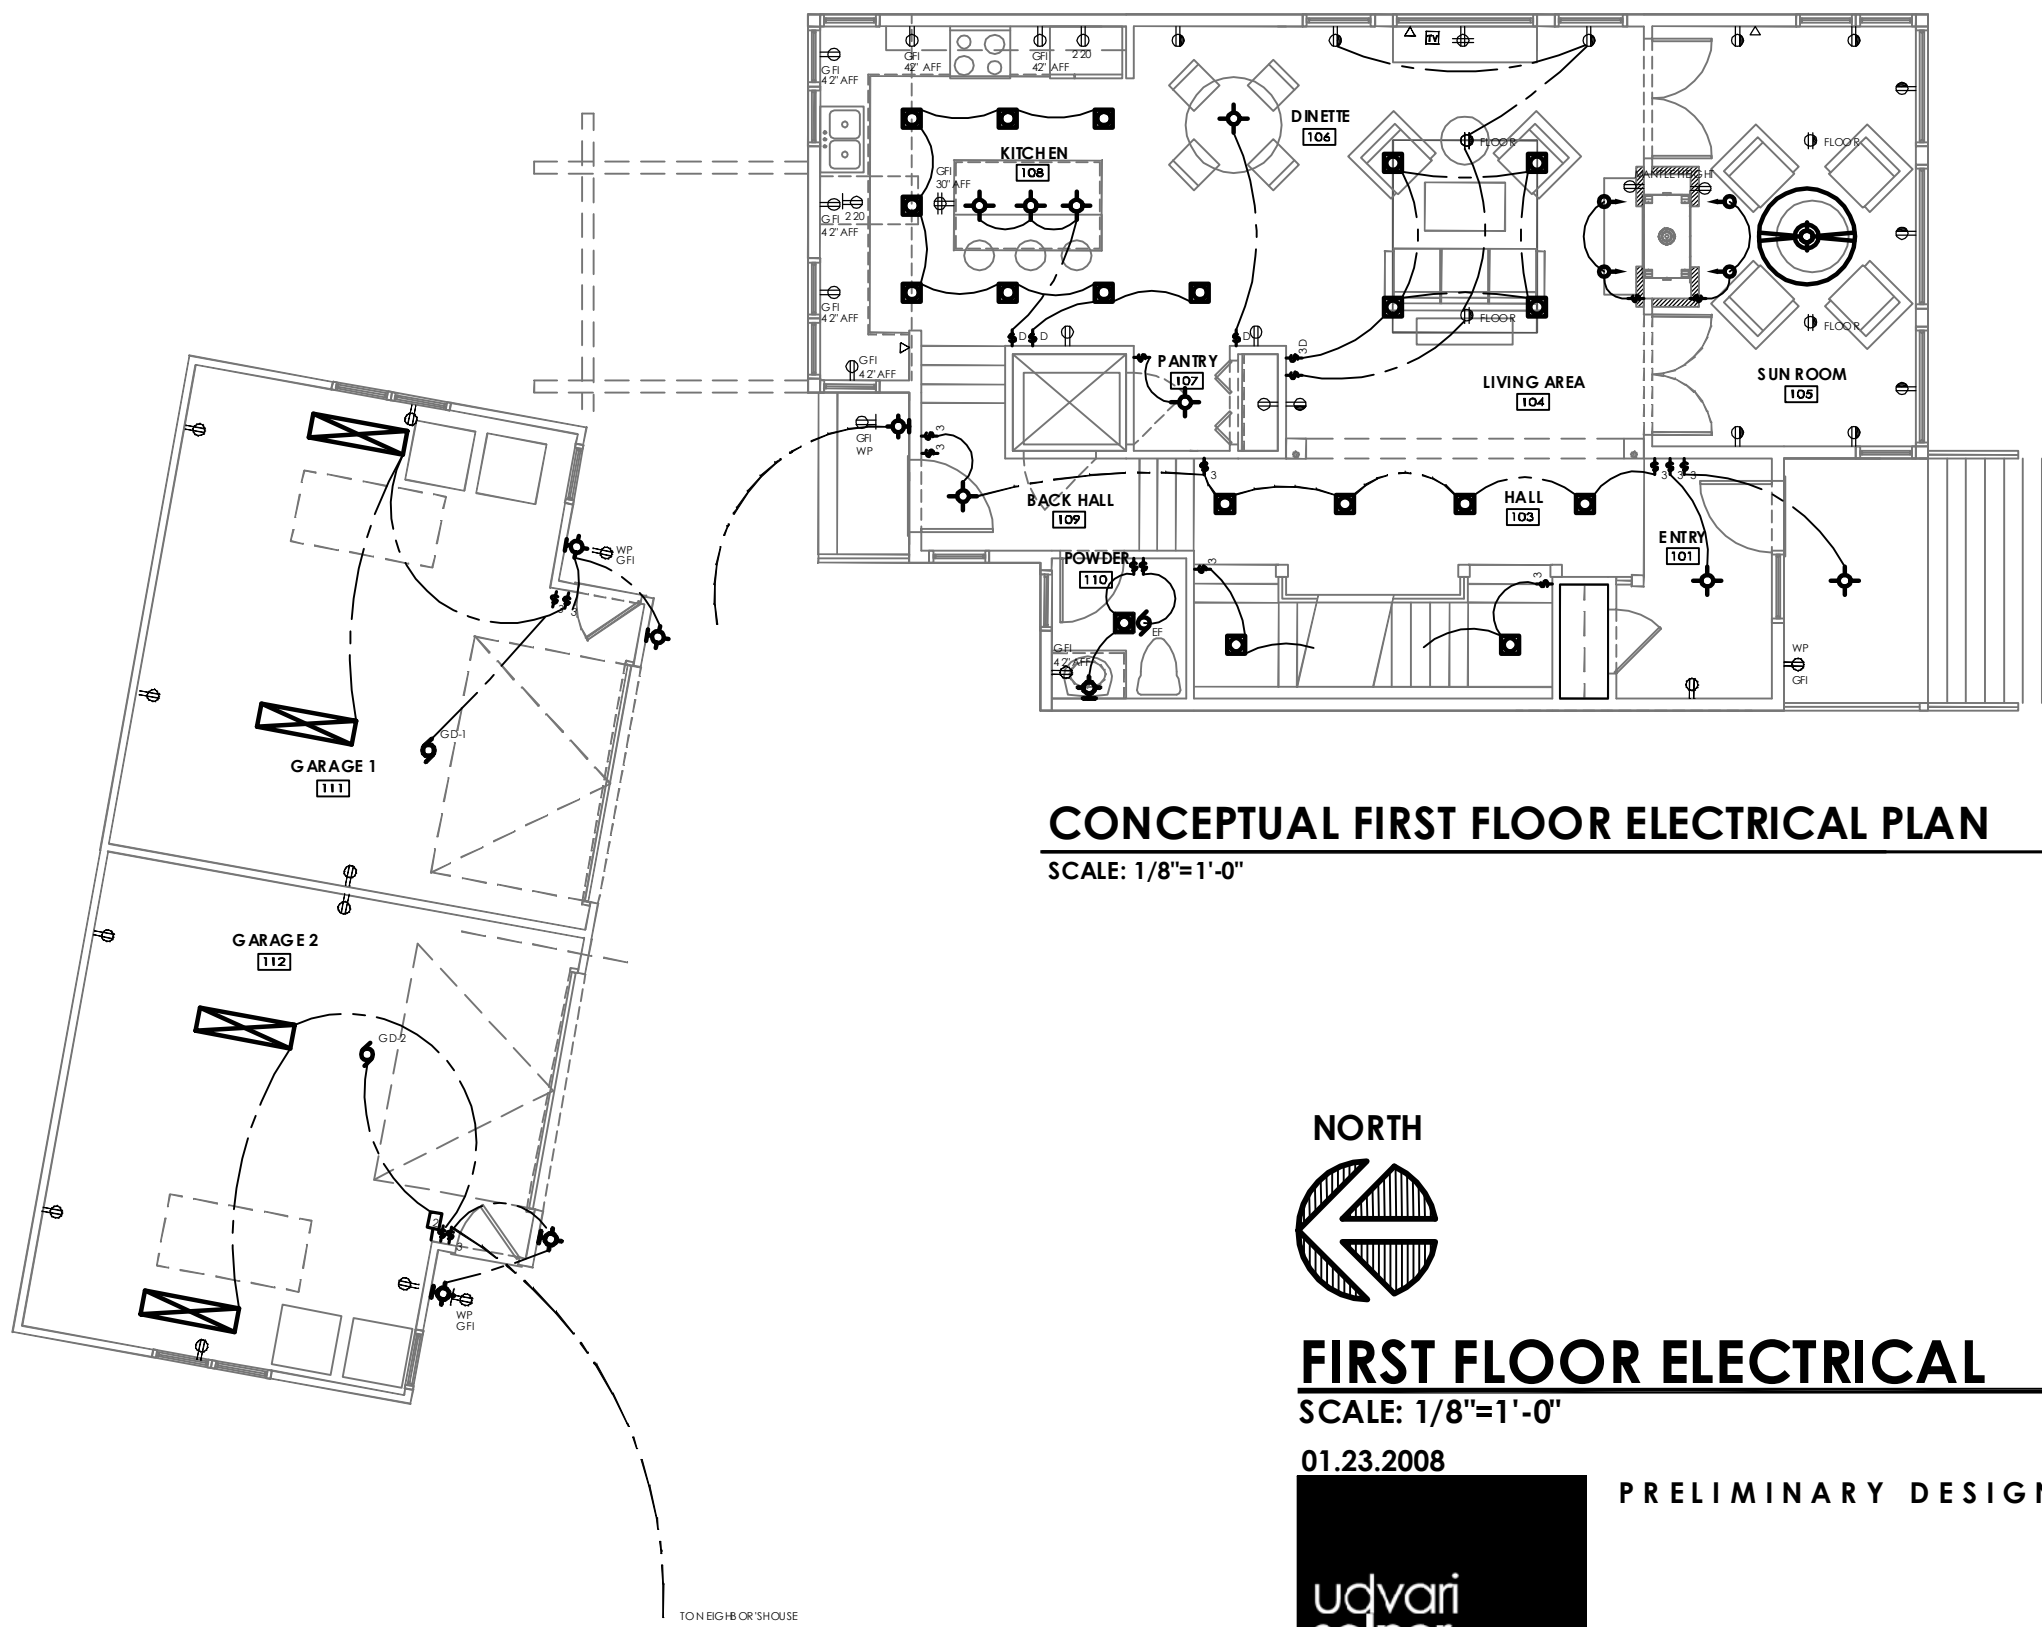

CONCEPTUAL FIRST FLOOR ELECTRICAL PLAN

SCALE: 1/8"=1'-0"

NORTH

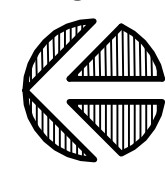

FIRST FLOOR ELECTRICAL

SCALE: 1/8"=1'-0"

01.23.2008




PRELIMINARY DESIGN CONCEPTS FOR


EHRlich/FAGERHOLM RESIDENCE

155 SOUTH BRITTINGHAM ST.
LOT 7

MADISON
DANE COUNTY, WI

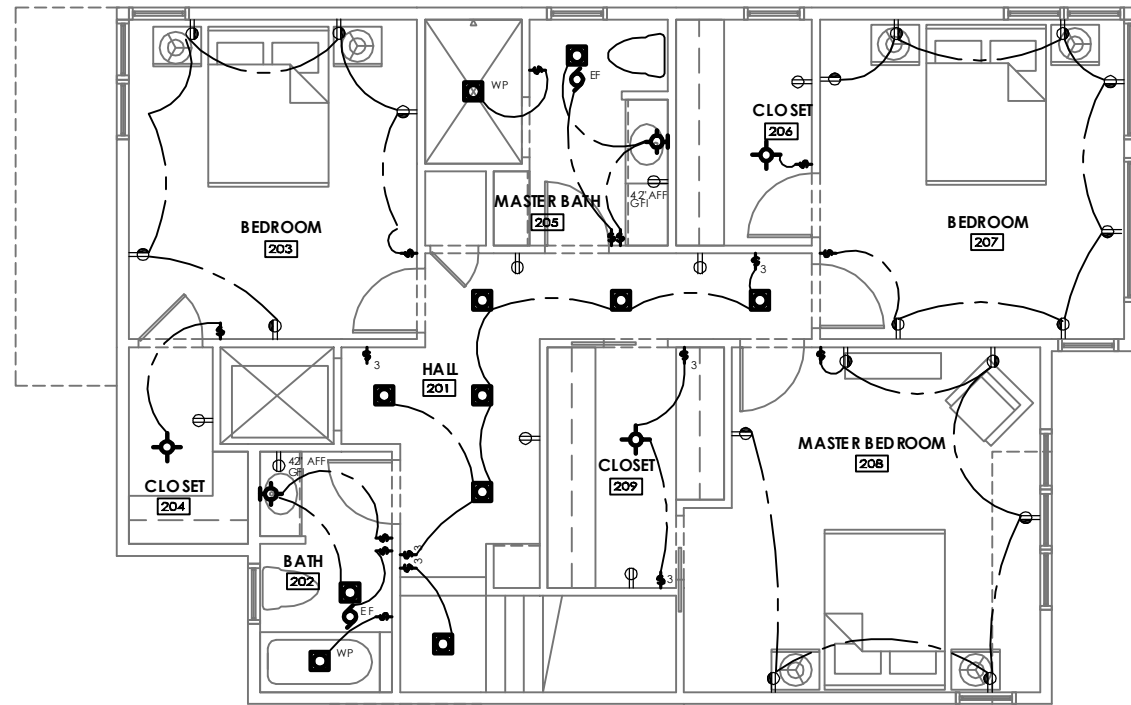


CONCEPTUAL 2ND FLOOR ELECTRICAL PLAN
 SCALE: 1/8"=1'-0"

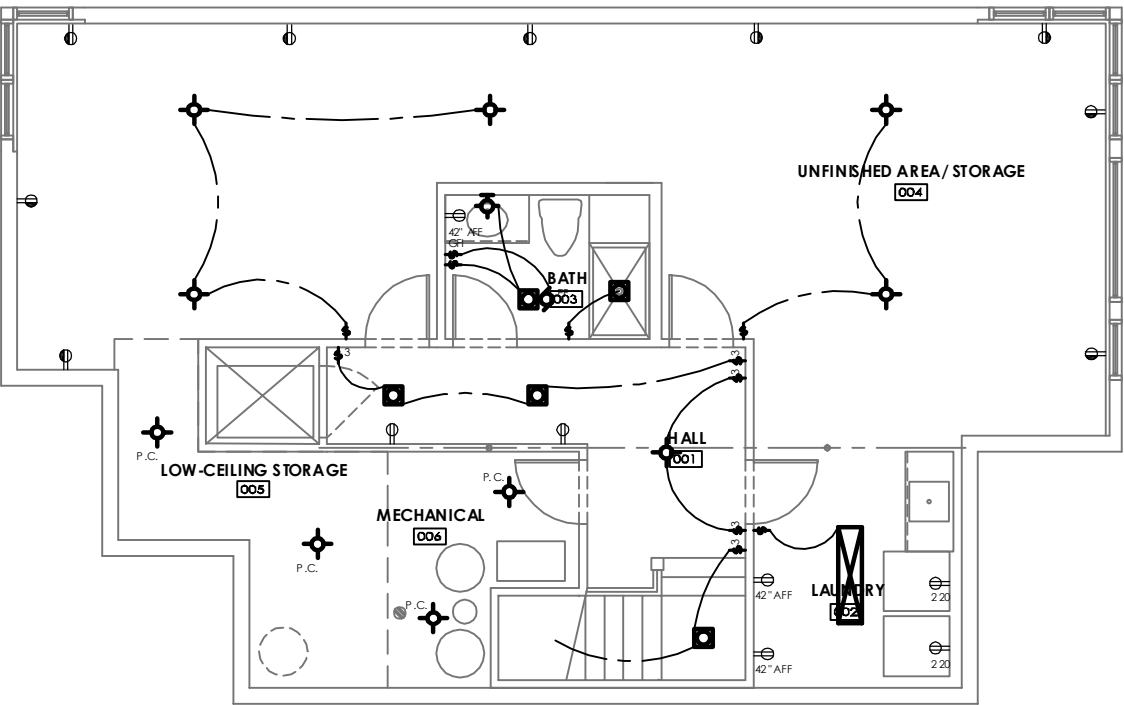

CONCEPTUAL GROUND FLOOR ELECTRICAL PLAN
 SCALE: 1/8"=1'-0"

NORTH

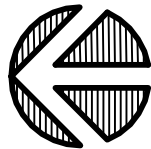

GROUND & 2ND FLOOR ELECTRICAL
 SCALE: 1/8"=1'-0"

01.23.2008



PRELIMINARY DESIGN CONCEPTS FOR

EHRlich/FAGERHOLM RESIDENCE
 155 SOUTH BRITTINGHAM ST. MADISON
 LOT 7 DANE COUNTY, WI