


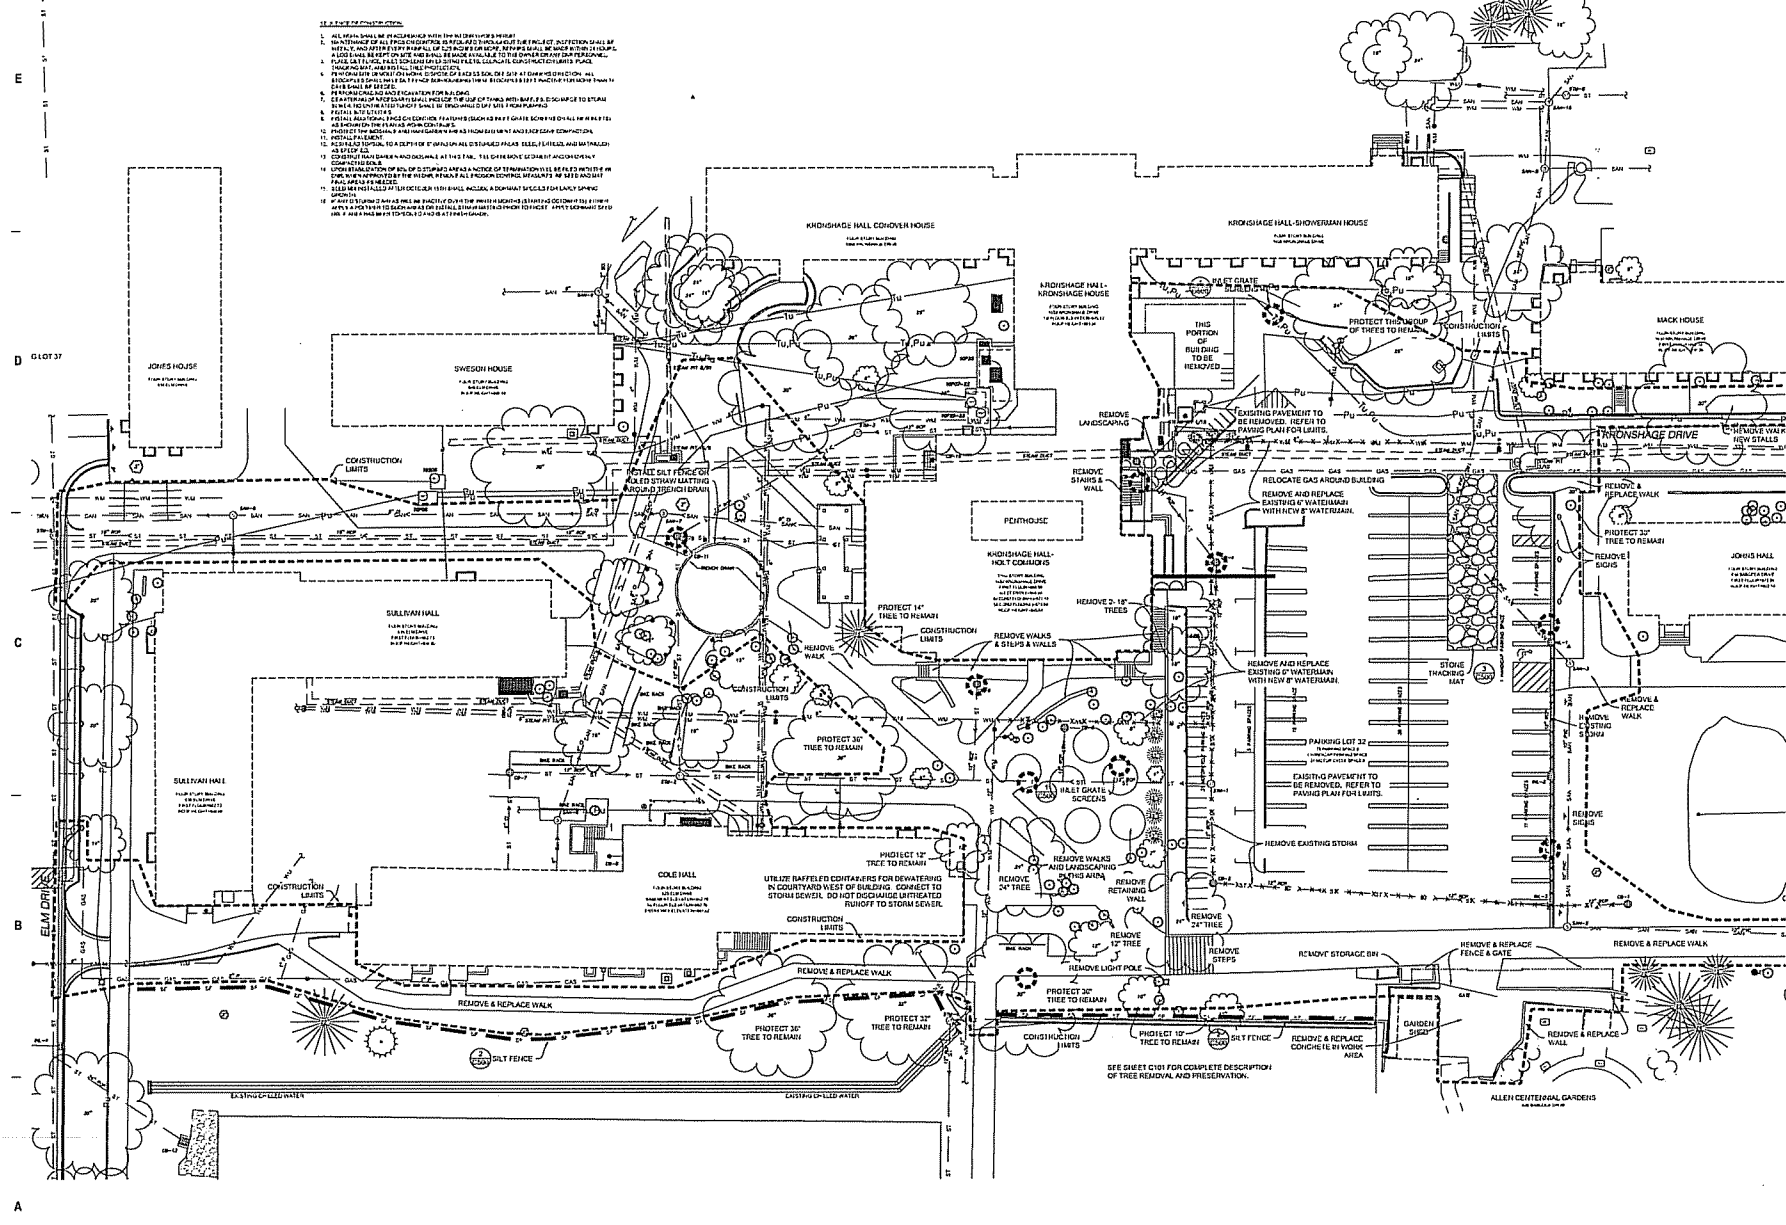

Revision	No.	Date	By	Description


Graphic Scale	0 10 20 30 40
Scale	1" = 20'
Set	EA Package
Date Issued	06/01/11
Sheet Number	C100




NO.	DATE	DESCRIPTION
1	06/01/11	TOP PART ON HYDRAULIC SOUTH OF FULT
2	06/01/11	TOP PART ON HYDRAULIC SOUTH OF FULT
3	06/01/11	TOP PART ON HYDRAULIC SOUTH OF FULT
4	06/01/11	TOP PART ON HYDRAULIC SOUTH OF FULT
5	06/01/11	TOP PART ON HYDRAULIC SOUTH OF FULT
6	06/01/11	TOP PART ON HYDRAULIC SOUTH OF FULT
7	06/01/11	TOP PART ON HYDRAULIC SOUTH OF FULT
8	06/01/11	TOP PART ON HYDRAULIC SOUTH OF FULT
9	06/01/11	TOP PART ON HYDRAULIC SOUTH OF FULT
10	06/01/11	TOP PART ON HYDRAULIC SOUTH OF FULT

DIGGERS HOTLINE
 WISCONSIN STATE STATUTE 162.07(3) REQUIRES
 THREE WORK DAYS NOTICE BEFORE YOU EXCAVATE
 CALL 608-261-0000 FOR MORE INFORMATION

100000
 THE LOCATION AND SIZE OF UNDEVELOPED AREAS AND UTILITIES SHOWN ARE BASED ON THE INFORMATION PROVIDED BY THE
 DESIGNER DOES NOT GUARANTEE THE LOCATION OR SIZE OF UNDEVELOPED AREAS OR UTILITIES. CONTRACTORS SHALL
 VERIFY THE LOCATION AND SIZE OF UNDEVELOPED AREAS AND UTILITIES PRIOR TO CONSTRUCTION. THE DESIGNER
 SHALL NOT BE RESPONSIBLE FOR ANY DAMAGE TO UTILITIES OR OTHER PROPERTY CAUSED BY THE CONTRACTOR'S
 NEGLIGENCE OR MISFEASANCE. THE DESIGNER SHALL NOT BE RESPONSIBLE FOR ANY DAMAGE TO UTILITIES OR
 OTHER PROPERTY CAUSED BY THE CONTRACTOR'S NEGLIGENCE OR MISFEASANCE. THE DESIGNER SHALL
 NOT BE RESPONSIBLE FOR ANY DAMAGE TO UTILITIES OR OTHER PROPERTY CAUSED BY THE CONTRACTOR'S
 NEGLIGENCE OR MISFEASANCE. THE DESIGNER SHALL NOT BE RESPONSIBLE FOR ANY DAMAGE TO UTILITIES
 OR OTHER PROPERTY CAUSED BY THE CONTRACTOR'S NEGLIGENCE OR MISFEASANCE. THE DESIGNER
 SHALL NOT BE RESPONSIBLE FOR ANY DAMAGE TO UTILITIES OR OTHER PROPERTY CAUSED BY THE
 CONTRACTOR'S NEGLIGENCE OR MISFEASANCE. THE DESIGNER SHALL NOT BE RESPONSIBLE FOR ANY
 DAMAGE TO UTILITIES OR OTHER PROPERTY CAUSED BY THE CONTRACTOR'S NEGLIGENCE OR MISFEASANCE.
 100000
 THE LOCATION AND SIZE OF UNDEVELOPED AREAS AND UTILITIES SHOWN ARE BASED ON THE INFORMATION PROVIDED BY THE
 DESIGNER DOES NOT GUARANTEE THE LOCATION OR SIZE OF UNDEVELOPED AREAS OR UTILITIES. CONTRACTORS SHALL
 VERIFY THE LOCATION AND SIZE OF UNDEVELOPED AREAS AND UTILITIES PRIOR TO CONSTRUCTION. THE DESIGNER
 SHALL NOT BE RESPONSIBLE FOR ANY DAMAGE TO UTILITIES OR OTHER PROPERTY CAUSED BY THE CONTRACTOR'S
 NEGLIGENCE OR MISFEASANCE. THE DESIGNER SHALL NOT BE RESPONSIBLE FOR ANY DAMAGE TO UTILITIES OR
 OTHER PROPERTY CAUSED BY THE CONTRACTOR'S NEGLIGENCE OR MISFEASANCE. THE DESIGNER SHALL
 NOT BE RESPONSIBLE FOR ANY DAMAGE TO UTILITIES OR OTHER PROPERTY CAUSED BY THE CONTRACTOR'S
 NEGLIGENCE OR MISFEASANCE. THE DESIGNER SHALL NOT BE RESPONSIBLE FOR ANY DAMAGE TO UTILITIES
 OR OTHER PROPERTY CAUSED BY THE CONTRACTOR'S NEGLIGENCE OR MISFEASANCE. THE DESIGNER
 SHALL NOT BE RESPONSIBLE FOR ANY DAMAGE TO UTILITIES OR OTHER PROPERTY CAUSED BY THE
 CONTRACTOR'S NEGLIGENCE OR MISFEASANCE. THE DESIGNER SHALL NOT BE RESPONSIBLE FOR ANY
 DAMAGE TO UTILITIES OR OTHER PROPERTY CAUSED BY THE CONTRACTOR'S NEGLIGENCE OR MISFEASANCE.

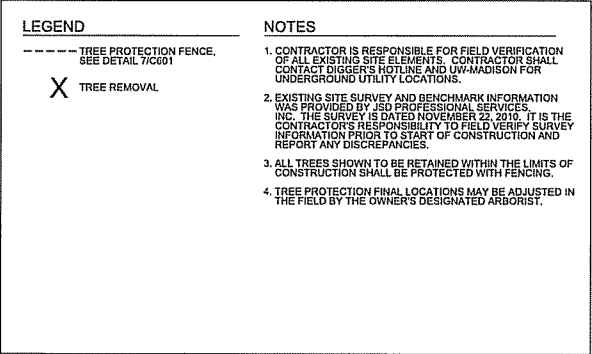

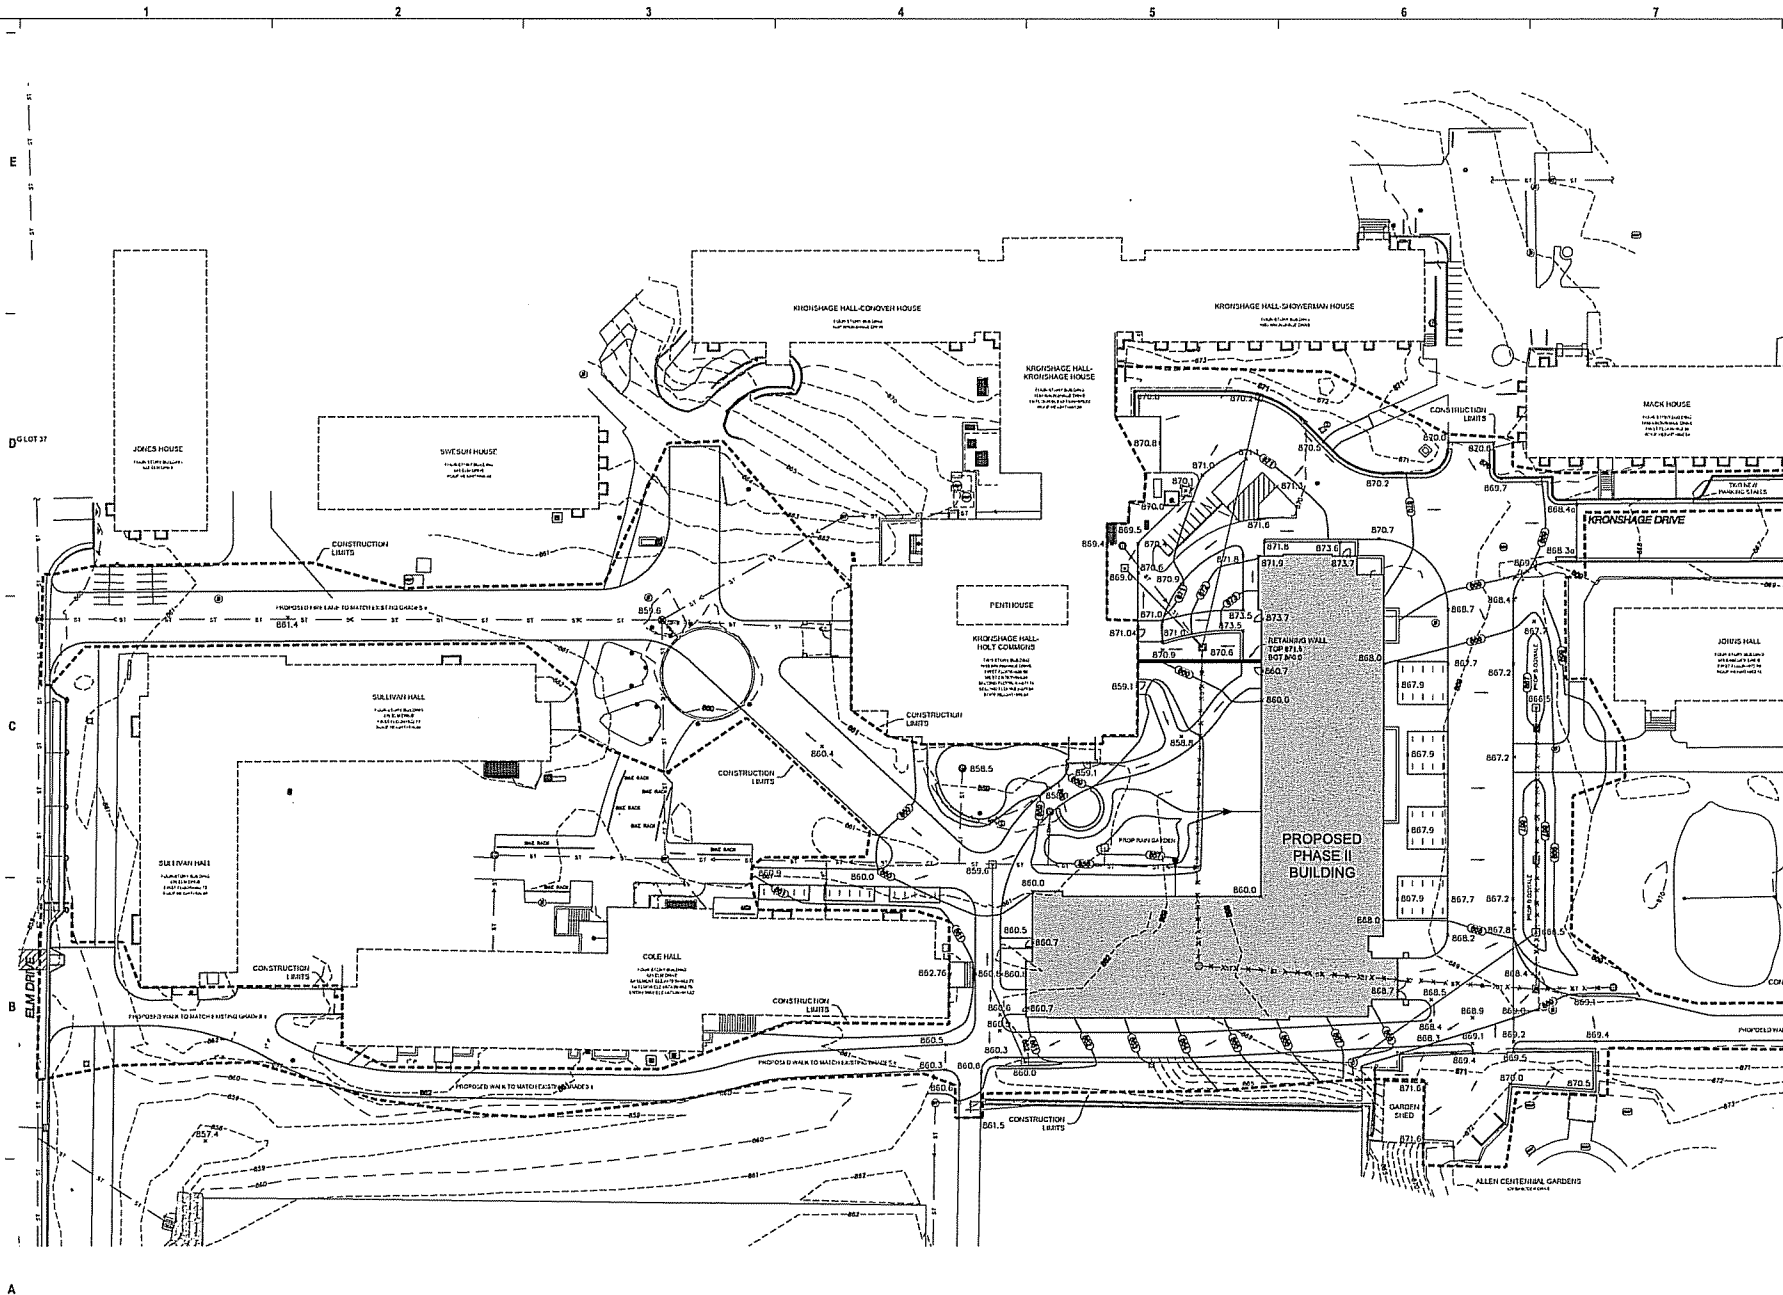

A

NOTES:
 1. THE LOCATION AND SIZE OF UNDERGROUND STRUCTURES AND UTILITIES IS SHOWN HEREIN BASED ON RECORD DRAWINGS AND FIELD SURVEY. CONTACT DIGNERS FOR THE LATEST RECORD DRAWINGS AND FIELD SURVEY DATA.
 2. ALL SITE GRADING AND CONSTRUCTION SHALL BE IN ACCORDANCE WITH THE WISCONSIN DEPARTMENT OF TRANSPORTATION'S CONSTRUCTION STANDARDS AND SPECIFICATIONS, LATEST EDITION.
 3. DIGNERS ENGINEERING, INC. ASSUMES NO LIABILITY FOR ALTERATIONS AND/OR CONSTRUCTION THAT DOES NOT CONFORM TO THE DESIGN DETAIL ON THIS PLAN. NO CHANGES MAY BE MADE TO THIS DESIGN WITHOUT THE WRITTEN CONSENT OF DIGNERS ENGINEERING, INC. IF ANY DEVIATIONS ARE REQUIRED FOR ANY REASON, IT IS THE CONTRACTOR'S RESPONSIBILITY TO NOTIFY THE PROJECT MANAGER IMMEDIATELY.

MARK	ELEVATION	DESCRIPTION
BM-1	862.80	TOP OF EXISTING CONCRETE FOUNDATION
BM-2	862.80	TOP OF EXISTING CONCRETE FOUNDATION
BM-3	862.79	TOP OF EXISTING CONCRETE FOUNDATION
BM-4	862.78	TOP OF EXISTING CONCRETE FOUNDATION
BM-100	861.82	TOP OF EXISTING CONCRETE FOUNDATION

DIGNERS HOTLINE
 WISCONSIN STATE STATUTE 90.01(1) REQUIRES
 THAT YOU CALL DIGNERS HOTLINE BEFORE YOU EXCAVATE
 CALL DIGNERS HOTLINE 1-800-843-8111

N
 SCALE: 1" = 20'
 S
 E
 W

epstein when: architects
 222 East Wisconsin Street
 Milwaukee, WI 53202
 Tel: 414.224.1111
 Fax: 414.224.1112

epstein when: architects
 222 East Wisconsin Street
 Milwaukee, WI 53202
 Tel: 414.224.1111
 Fax: 414.224.1112

epstein when: architects
 222 East Wisconsin Street
 Milwaukee, WI 53202
 Tel: 414.224.1111
 Fax: 414.224.1112

Consultant:

DAAR ENGINEERING, INC.
 222 East Wisconsin Street
 Milwaukee, WI 53202
 Tel: 414.224.1111
 Fax: 414.224.1112

State of Wisconsin
 Department of Administration
 Division of State Facilities

UNIVERSITY OF WISCONSIN - MADISON

Project Name: **LAKE SHORE PHASE II**

Location: **MADISON, WISCONSIN**

Sheet Title: **GRADING PLAN**

Graphic Scale: 1" = 20'

DSP Number: 10630

Set Type: 35% REVIEW

Date Issued: 6/29/11

Sheet Number: **C200**




100


--	--

Project Title: LAKE SHORE PHASE II	Project Location: MADISON, WISCONSIN
Sheet Title: SITE LAYOUT PLAN	

[illegible]

Graphic Scale	
DSF Number	10G3D
Set Type	PR
Date Issued	06/20/2011
Sheet Number	C300

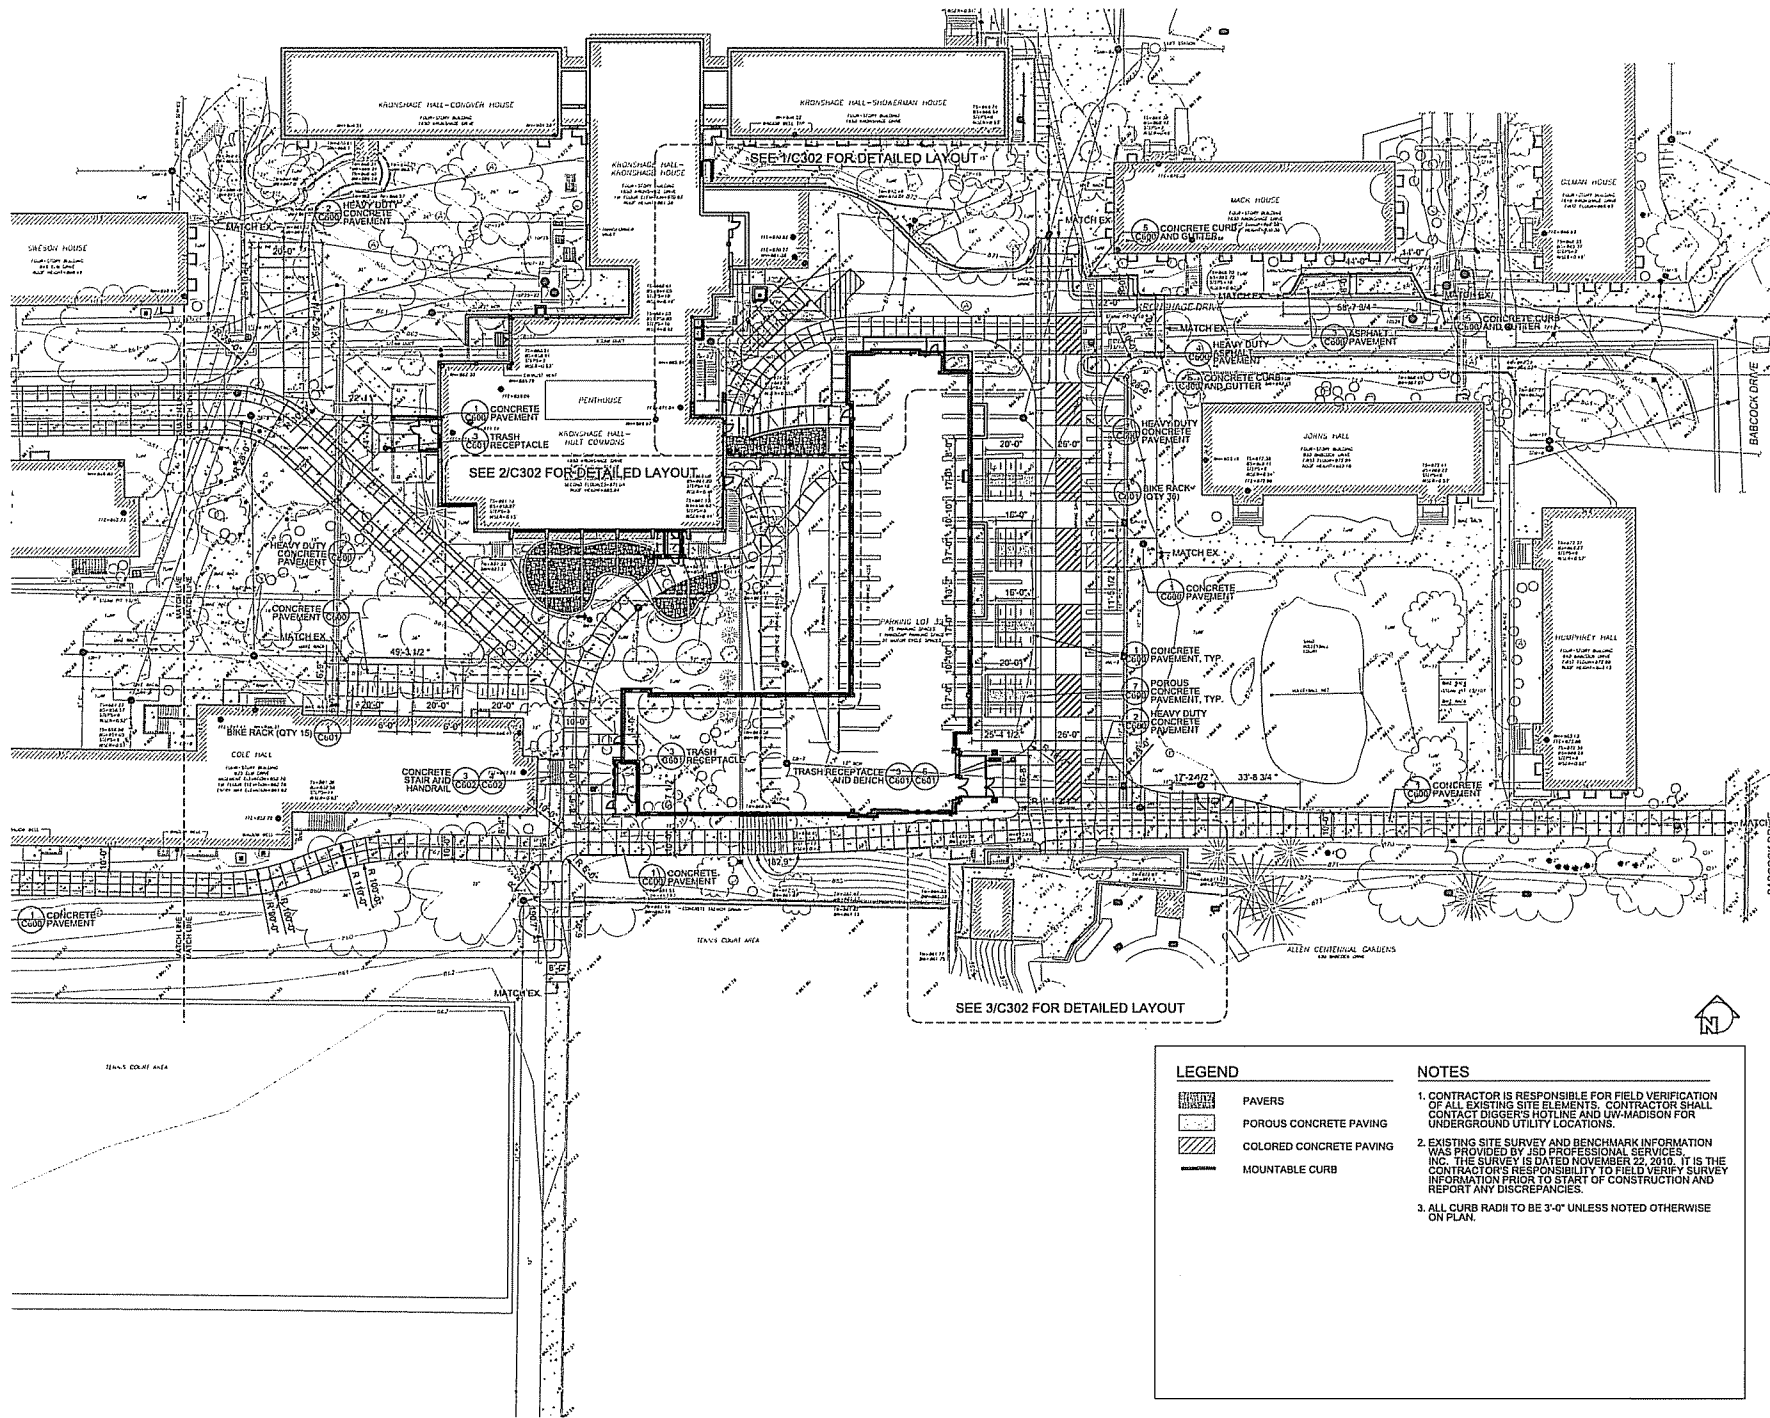

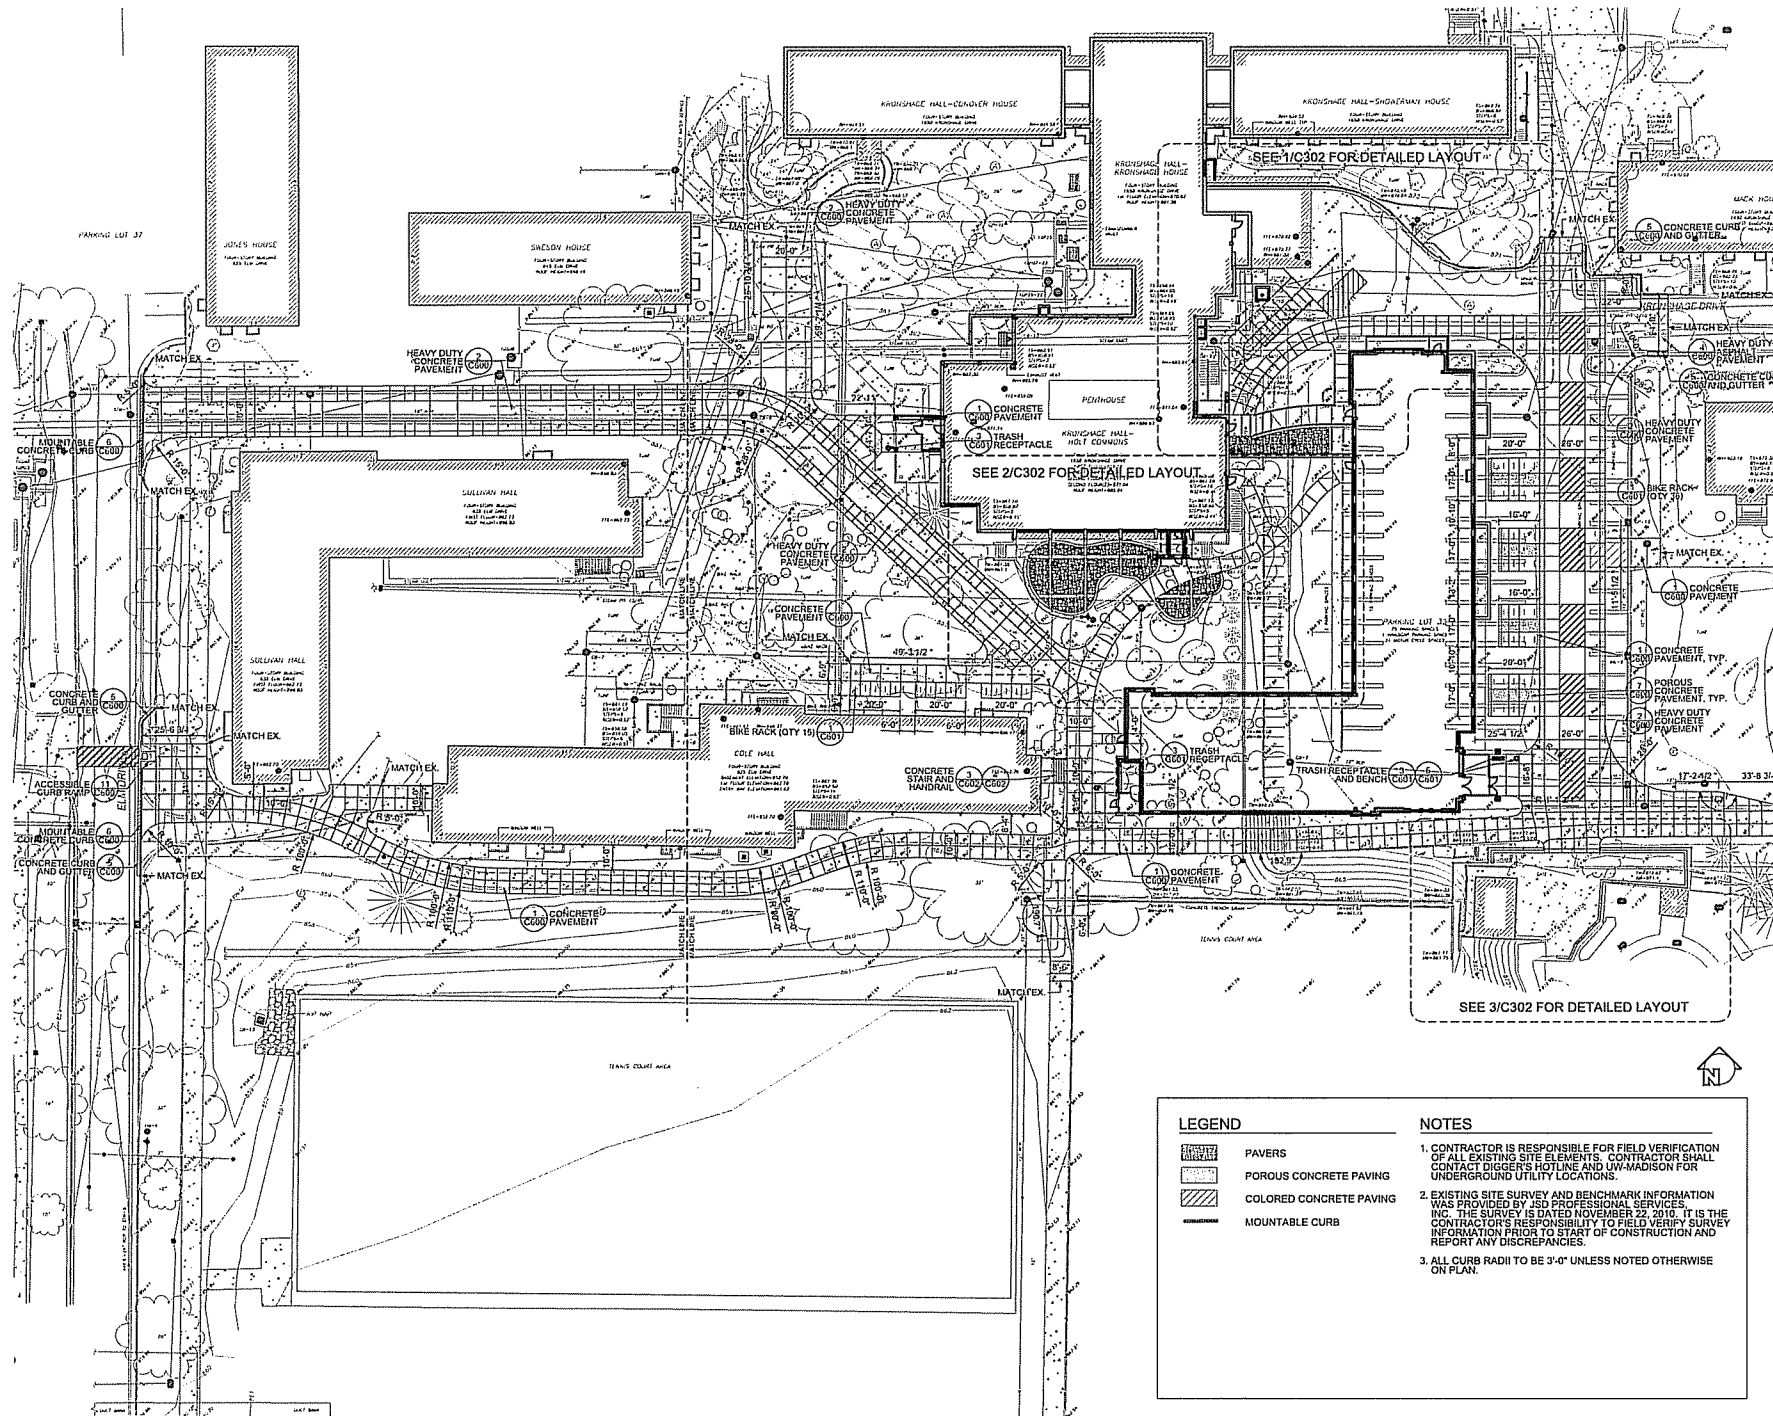

LEGEND

	PAVERS
	POROUS CONCRETE PAVING
	COLOR CONCRETE PAVING
	MOUNTABLE CURB

NOTES

- CONTRACTOR IS RESPONSIBLE FOR FIELD VERIFICATION OF ALL EXISTING SITE ELEMENTS. CONTRACTOR SHALL CONTACT BIGGER'S HOTLINE AND UW-MADISON FOR UNDERGROUND UTILITY LOCATIONS.
- EXISTING SITE SURVEY AND BENCHMARK INFORMATION WAS PROVIDED BY 2SD PROFESSIONAL SERVICES, INC. THE SURVEY IS DATED NOVEMBER 22, 2010. IT IS THE CONTRACTOR'S RESPONSIBILITY TO FIELD VERIFY SURVEY INFORMATION PRIOR TO START OF CONSTRUCTION AND REPORT ANY DISCREPANCIES.
- ALL CURB RADII TO BE 3'-0" UNLESS NOTED OTHERWISE ON PLAN.

epstein uhen : architects
 133 East Cottage Street
 Madison, Wisconsin 53703
 Tel: 608.255.1212 Fax: 608.255.1213
 233 West Monmouth Ave., Suite 900
 Madison, Wisconsin 53704
 Tel: 608.452.7790 Fax: 608.452.7791

CONSULTANT

State of Wisconsin
 Department of Administration
 Division of State Facilities

UNIVERSITY OF WISCONSIN - MADISON

Project Location:
MADISON, WISCONSIN

Project Name:
LAKESHORE PHASE II

Sheet No.:
C301

Scale:
 1" = 10'-0"

Date:
 06/30/2011

Drawn by:
 [Name]

Checked by:
 [Name]

Approved by:
 [Name]




UNIVERSITY OF WISCONSIN - MADISON

Project Title: **LAKESHORE PHASE II**

Project Location: MADISON, WISCONSIN

1	2	3	466
---	---	---	---	---	---	---	---	---	----	----	-----	-----	
Revisions:			
No.	Date:	By:	Description:
Graphic Scale			
DGF Number	15G3D		
Get Type	FR		
Data Issued	6-6-2011		
Sheet Number	C303		



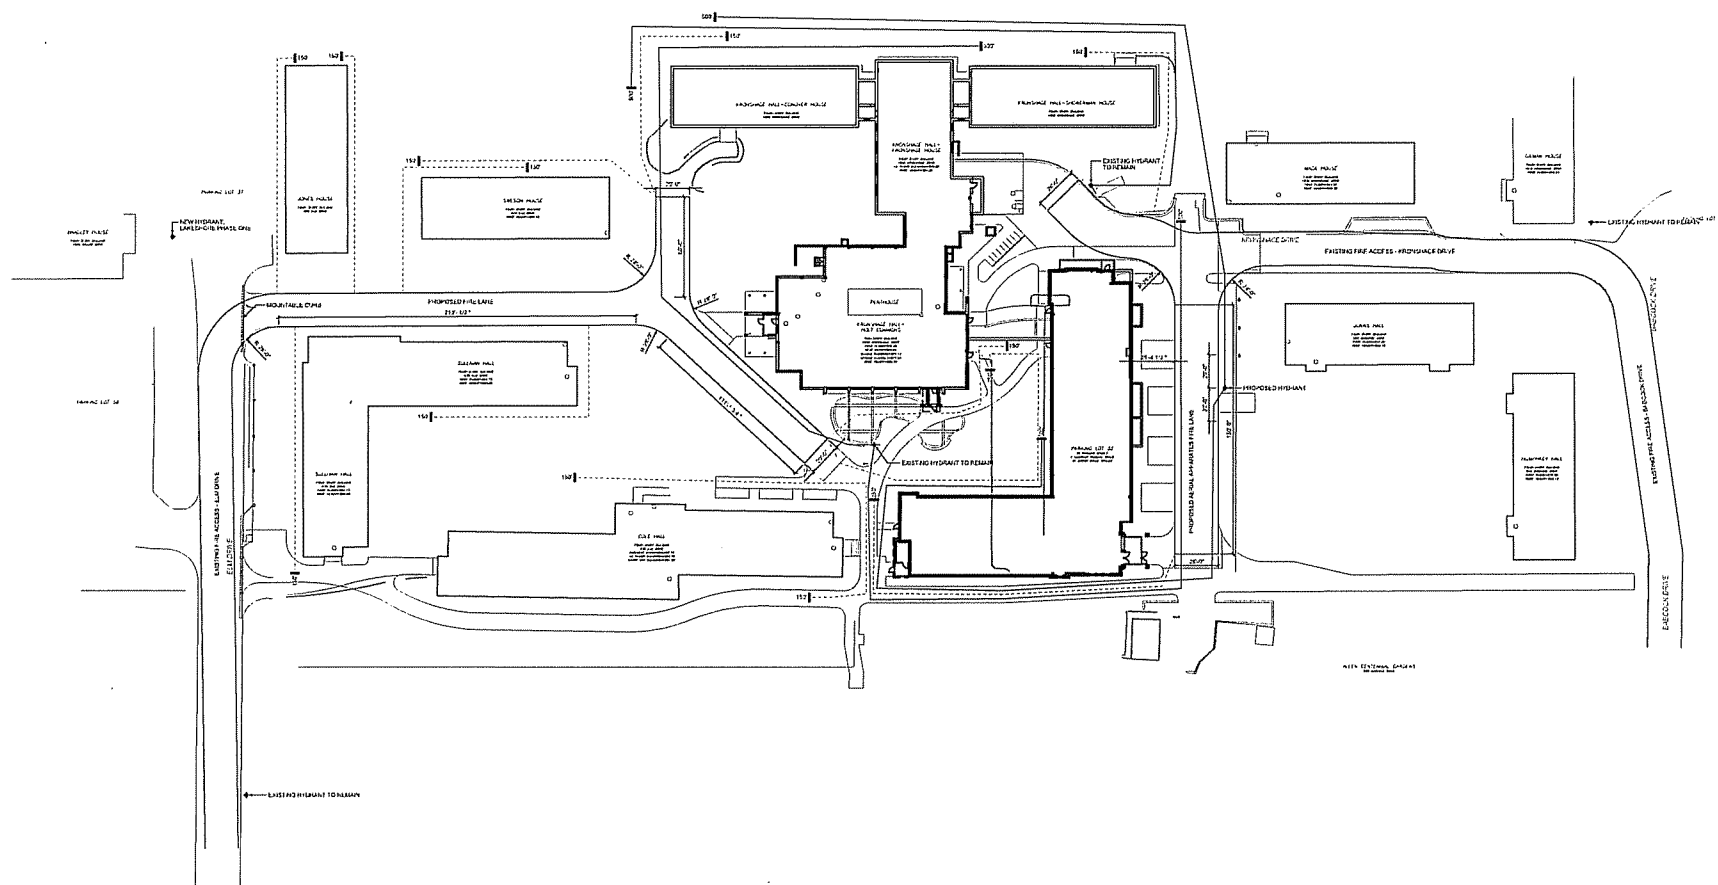


LEGEND

----- HOSE LAY FROM FIRE LANE
150' = NON-SPRINKLERED
250' = SPRINKLERED

HOSE LAY FROM HYDRANT
500'

♦ FIRE HYDRANT

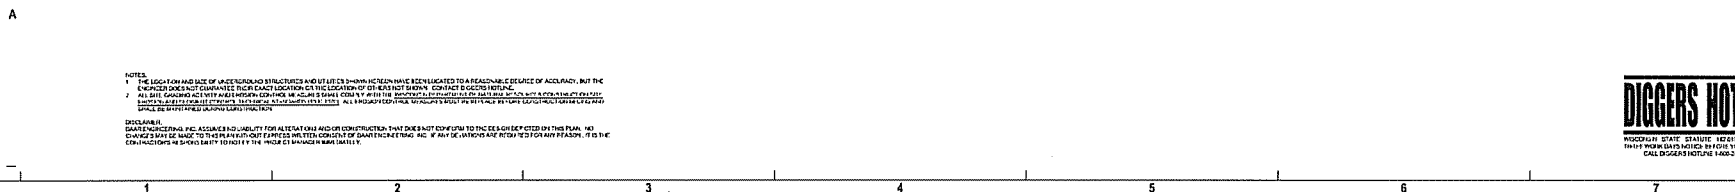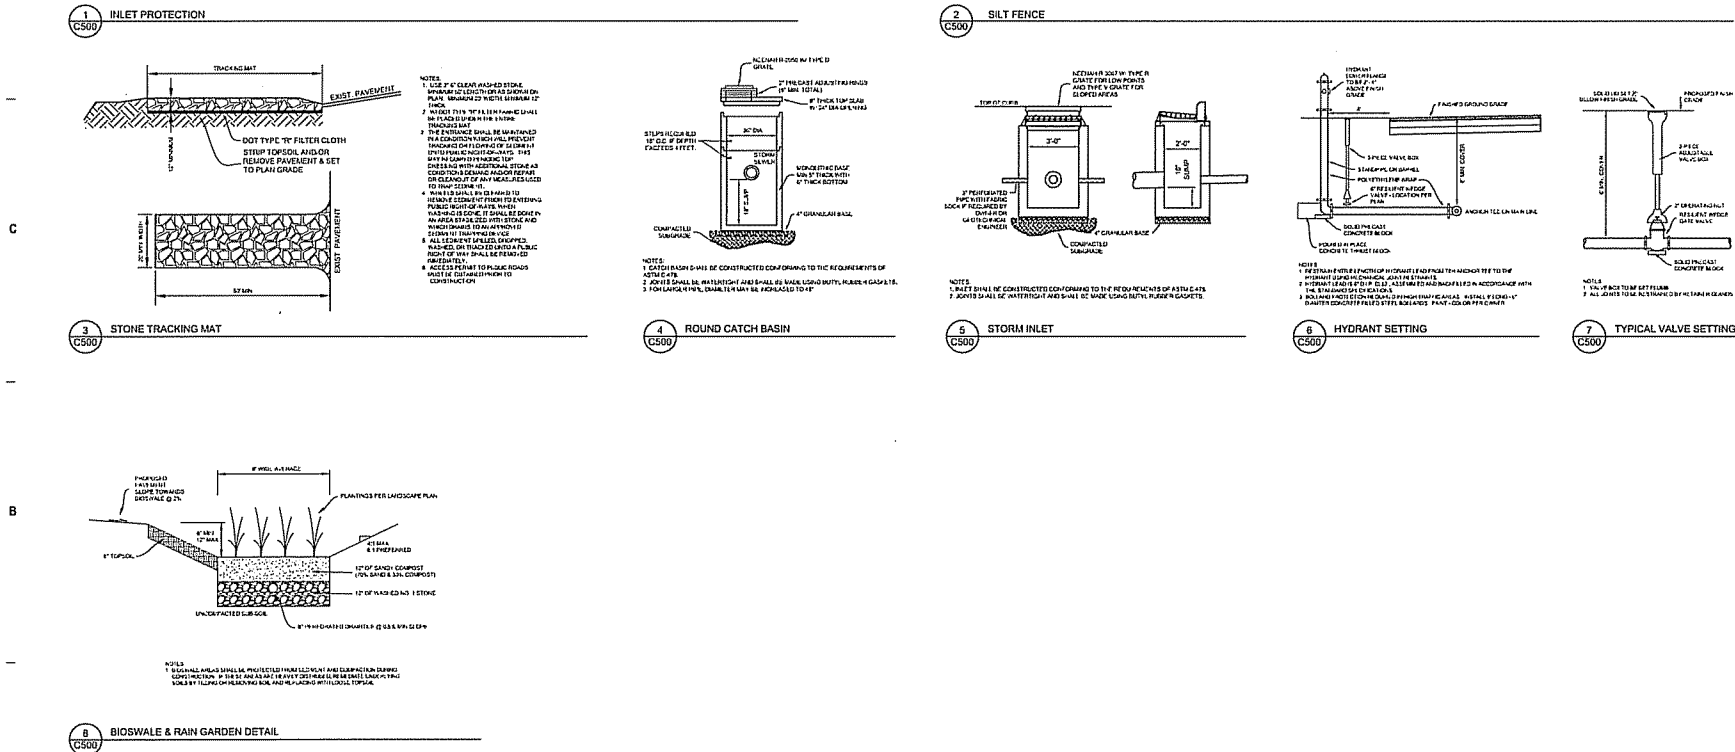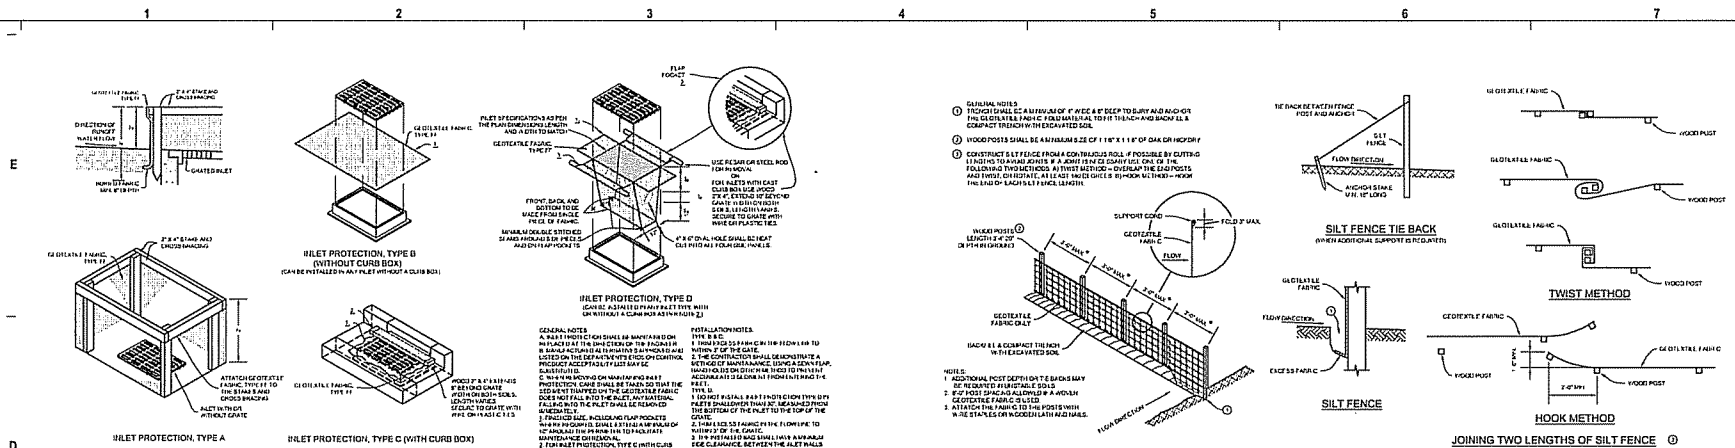

eua
 erpstein when : architects
 333 East Chicago Street
 Milwaukee, WI 53212
 Tel: 414.271.5555 Fax: 414.271.5774
 722 West Maryland Ave. Suite 600
 Milwaukee, WI 53212
 Tel: 414.271.5555 Fax: 414.271.5774


DAAR
 ENGINEERING, INC.
 1000 N. 10th St., Suite 100
 Milwaukee, WI 53233
 Tel: 414.271.5555 Fax: 414.271.5774

State of Wisconsin
 Department of Administration
 Division of State Facilities
 UNIVERSITY OF WISCONSIN - MADISON
 Agency / Division:
 Project Name:
 LAKESHORE PHASE II
 Project Location:
 MADISON, WISCONSIN
 Project Number:
 10000
 Scale:
 1/4" = 1'-0"
 Date:
 06/20/11
 Sheet:
 1 of 1
 Title:
 DETAILS


Revision:	No.	Date	By	Description
	1			
	2			
	3			
	100			

DIGGERS HOTLINE
 WISCONSIN STATE STATISTICAL SERVICE
 1-800-444-4444
 1-800-444-4444


C500

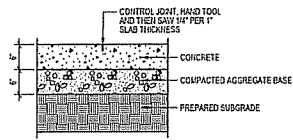


1 CONCRETE PAVEMENT SCALE: 1"=1'-0"

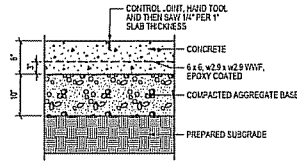

 
2 HEAVY DUTY CONCRETE PAVEMENT SCALE: 1"=1'-0"




3 ASPHALT PAVEMENT SCALE: 1"=1'-0"

 


4 HEAVY DUTY ASPHALT PAVEMENT SCALE: 1"=1'-0"

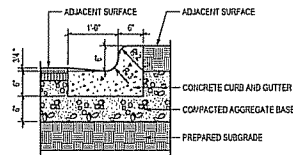


5 CONCRETE CURB AND GUTTER SCALE: 1"=1'-0"

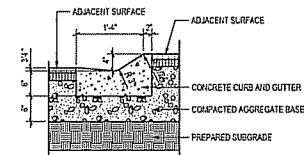


6 MOUNTABLE CONCRETE CURB SCALE: 1"=1'-0"

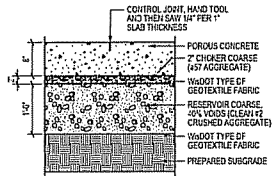


7 POROUS CONCRETE PAVEMENT SCALE: 1"=1'-0"

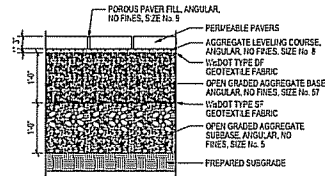

 
8 POROUS CONCRETE PAVERS SCALE: 1"=1'-0"





9 CONCRETE PAVERS SCALE: 1"=1'-0"

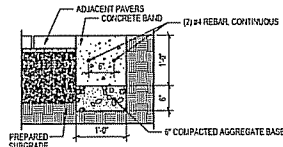


10 CONCRETE BAND SCALE: 1"=1'-0"

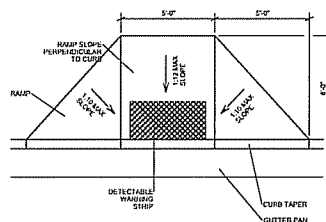

11 ACCESSIBLE CURB RAMP SCALE: 3/8"=1'-0"

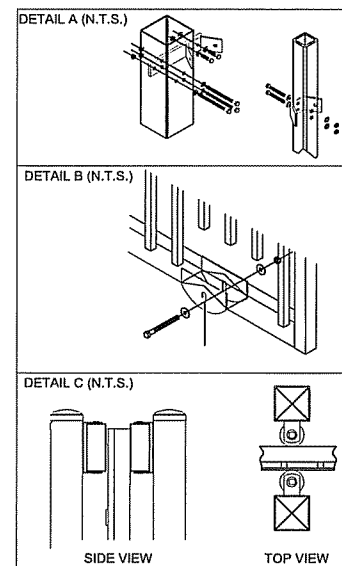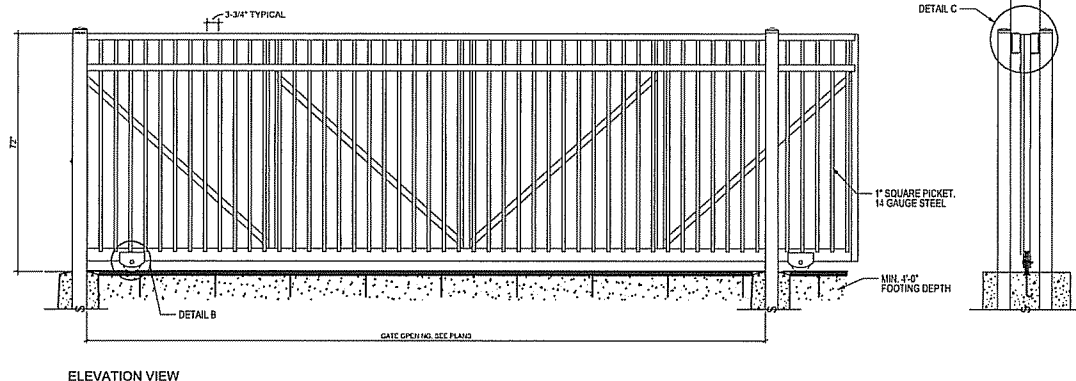


SCALE: 3/4"=1'-0"

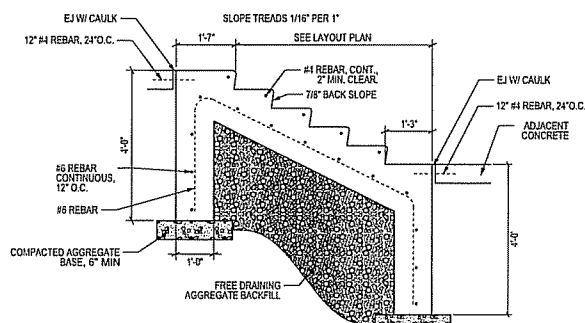


3 CONCRETE STAIR
C602


SCALE: 3/4"=1'-0"

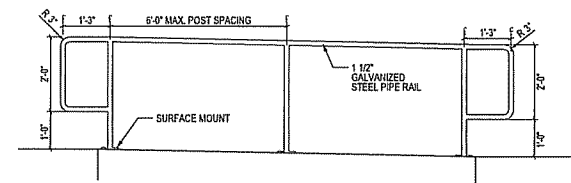

5 RAMP HANDRAIL SCALE: 3/4"=1'-0"

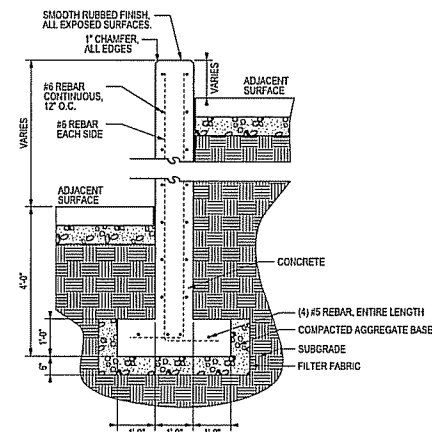

6 CONCRETE WALL SCALE: 1"=1'-0"

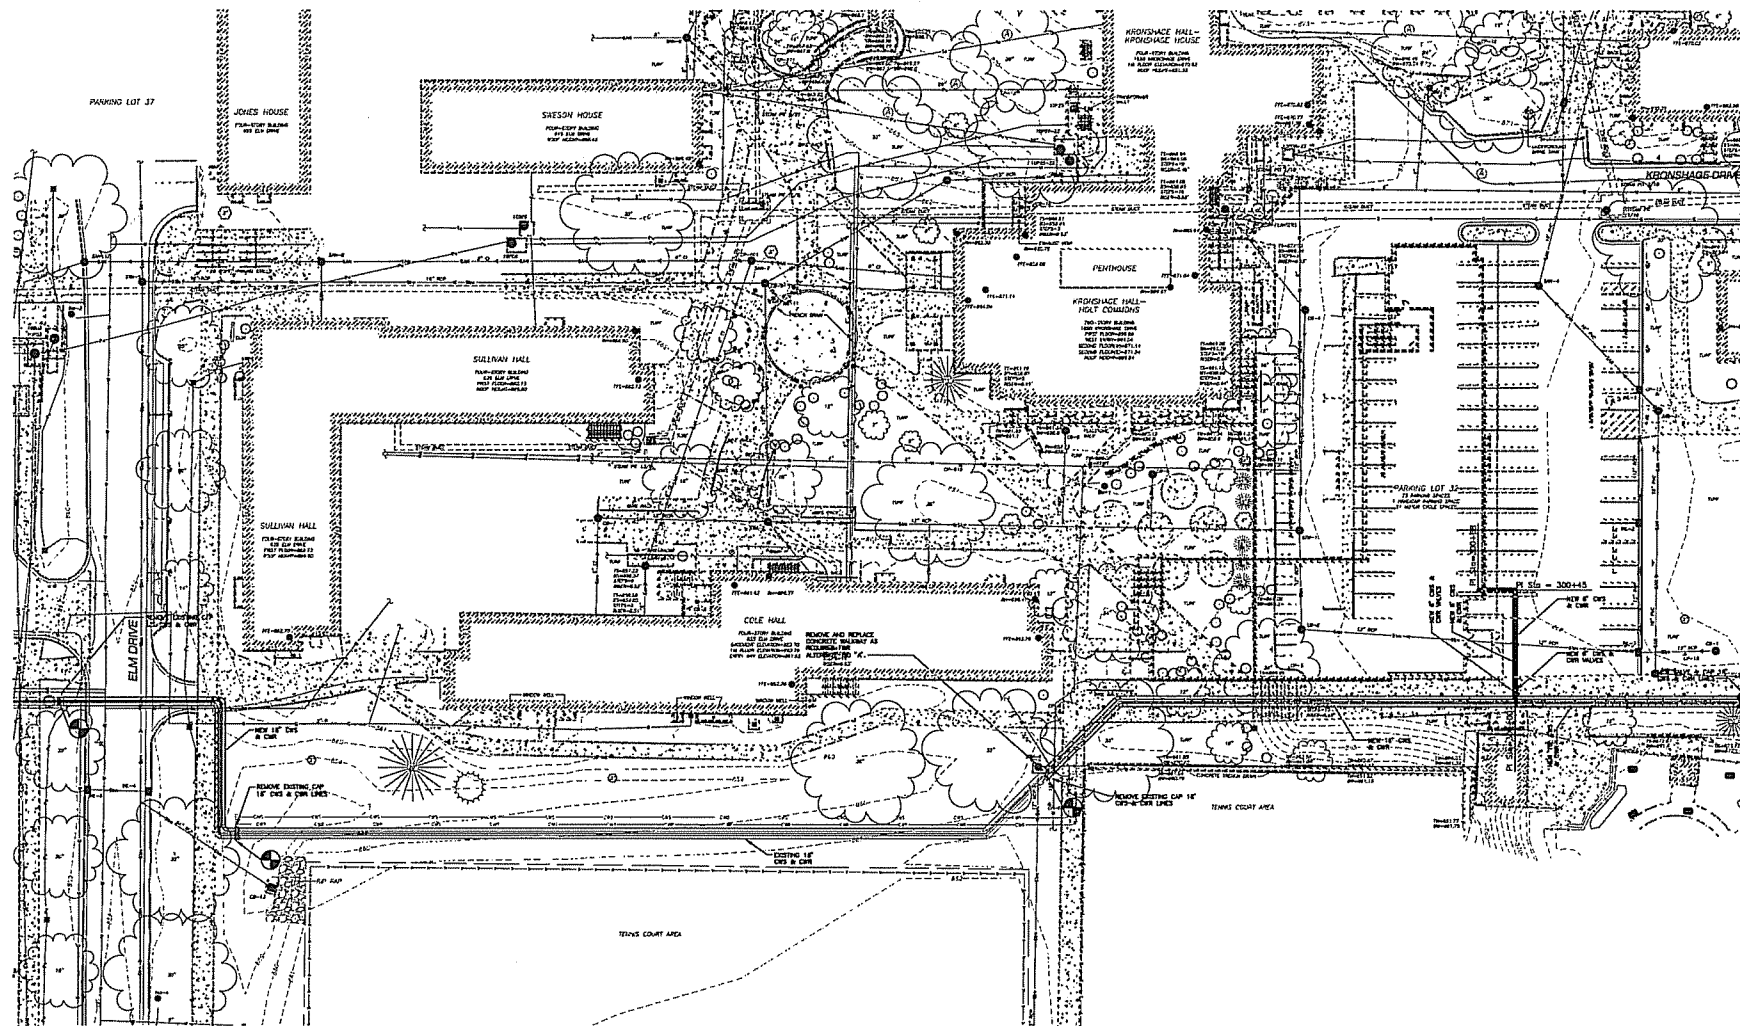

1 CHILLED WATER & POWER OVERALL SITE PLAN
C901



eppstein uhen : architects
milwaukee 333 East Chicago Street
Milwaukee, Wisconsin 53202
tel 414 271 8200 fax 414 271 7794
madison 222 West Washington Ave. Suite 503
Madison, Wisconsin 53703
tel 608 442 5360 fax 608 442 8620

Consultant:

RY

**RING &
DUCHATEAU**

10101 INNOVATION DR.
MILWAUKEE, WI 53228
PHONE: 414.778.1700
FAX: 414.778.2350
EMAIL: R-D@RYCOU.COM
PROJECT NUMBER: 211053

State of Wisconsin
Department of Administration
Division of State Facilities


UNIVERSITY OF WISCONSIN - MADISON
Agency/Institution:Project Title: **LAKESHORE PHASE II**

Project Location: MADISON, WISCONSIN

[illegible]

Graphic Scale	
DSF Number	10G3D
Gel Type	Eld Package
Date Issued	00/00/00
Sheet Number	C901

 C901



1. ALL EROSION CONTROL MEASURES ARE TO BE INSTALLED AND MAINTAINED THROUGHOUT THE CONSTRUCTION PERIOD. EROSION CONTROL MEASURES SHALL BE MAINTAINED UNTIL REVEALED MATERIAL SHALL BE COVERED BY A PERMANENT EROSION CONTROL MEASURE.
2. EROSION CONTROL MEASURES SHALL BE INSTALLED AND MAINTAINED THROUGHOUT THE CONSTRUCTION PERIOD AND BE MAINTAINED THROUGHOUT THE CONSTRUCTION PERIOD (TMP).
3. ALL SLOES WITHIN THE PROJECT LIMITS AND ADJACENCY SHALL BE PROTECTED FROM EROSION. EROSION CONTROL MEASURES SHALL BE INSTALLED AND MAINTAINED THROUGHOUT THE CONSTRUCTION PERIOD (TMP).
4. ADDITIONAL EROSION CONTROL MEASURES SHALL BE ADDED TO THE PROJECT LIMITS AND ADJACENCY AS REQUIRED BY THE DGP CONSTRUCTION REPRESENTATIVE.
5. THE CONTRACTOR SHALL BE RESPONSIBLE FOR PROVIDING PROTECTIVE MEASURES TO PREVENT EROSION OF THE DISTURBED PORTION OF THE SLOPE. ALL EROSION CONTROL MEASURES SHALL BE INSTALLED AND MAINTAINED THROUGHOUT THE CONSTRUCTION PERIOD. EROSION CONTROL MEASURES SHALL BE RESPONSIBLE FOR PROVIDING THAT THE EROSION CONTROL MEASURES ARE MAINTAINED THROUGHOUT THE CONSTRUCTION PERIOD. THE CONTRACTOR SHALL BE RESPONSIBLE FOR PROVIDING THAT THE EROSION CONTROL MEASURES ARE MAINTAINED THROUGHOUT THE CONSTRUCTION PERIOD.
6. THE CONTRACTOR SHALL BE RESPONSIBLE FOR PROVIDING THAT THE EROSION CONTROL MEASURES ARE MAINTAINED THROUGHOUT THE CONSTRUCTION PERIOD. THE CONTRACTOR SHALL BE RESPONSIBLE FOR PROVIDING THAT THE EROSION CONTROL MEASURES ARE MAINTAINED THROUGHOUT THE CONSTRUCTION PERIOD.
7. THE CONTRACTOR SHALL BE RESPONSIBLE FOR PROVIDING THAT THE EROSION CONTROL MEASURES ARE MAINTAINED THROUGHOUT THE CONSTRUCTION PERIOD. THE CONTRACTOR SHALL BE RESPONSIBLE FOR PROVIDING THAT THE EROSION CONTROL MEASURES ARE MAINTAINED THROUGHOUT THE CONSTRUCTION PERIOD.
8. THE CONTRACTOR SHALL BE RESPONSIBLE FOR PROVIDING THAT THE EROSION CONTROL MEASURES ARE MAINTAINED THROUGHOUT THE CONSTRUCTION PERIOD. THE CONTRACTOR SHALL BE RESPONSIBLE FOR PROVIDING THAT THE EROSION CONTROL MEASURES ARE MAINTAINED THROUGHOUT THE CONSTRUCTION PERIOD.

Sheet Title:
CONSTRUCTION LIMITS, EROSION CONTROL, &
SITE DEMOLITION

[illegible]


Consultant: **RY**
RING & DUCHATEAU
10101 INNOVATION DR.
MILWAUKEE, WI 53218
PHONE: 414.778.1700
FAX: 414.778.2380
EMAIL: R-D@RINGDU.COM
PROJECT #E&B: 211053

Agency / Institution:
UNIVERSITY OF WISCONSIN - MADISON

Project Location:
MADISON, WISCONSIN

[illegible]

C910

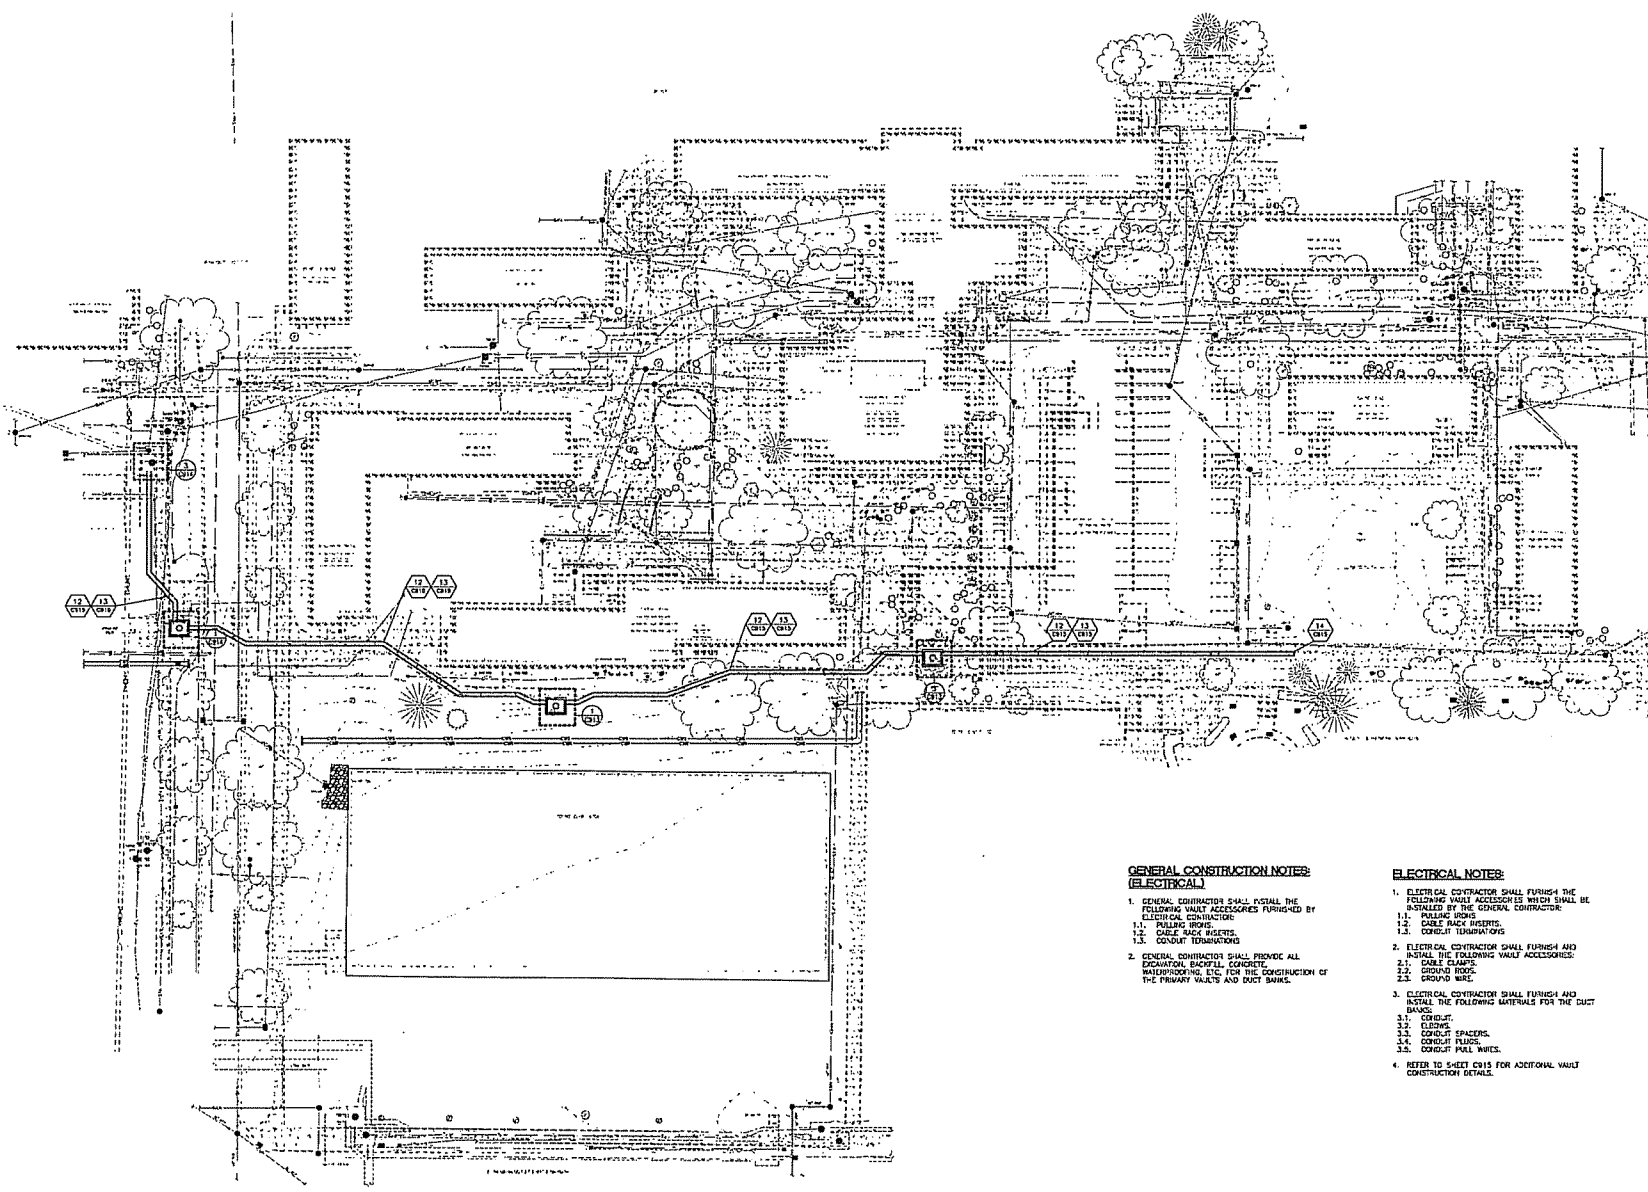

1 ELECTRICAL SITE PLAN - PRIMARY




Project Location:
MADISON, WISCONSIN

Sheet Title:
PLANTING PLAN

No.	Date:	E/p	Description:
Graphic Scale			
D/SF Number	10G3D		
Set Type	FR		
Date Issued	(6/30/2011)		
Sheet Number	L100		



- 1. ALL WRAPPINGS, WIRE BASKETS, BURLAP, AND OTHER MISCELLANEOUS MATERIAL SHALL BE REMOVED FROM ROOT BALLS PRIOR TO INSTALLATION**
- 2. PROVIDE BIODEGRADABLE EROSION CONTROL MATS IN ALL AREAS IDENTIFIED AS SEDGE MIX 1 AND SEDGE MIX 2 IN ACCORDANCE WITH SPECIFICATION 32 92 00 AND DETAIL 5/C602**

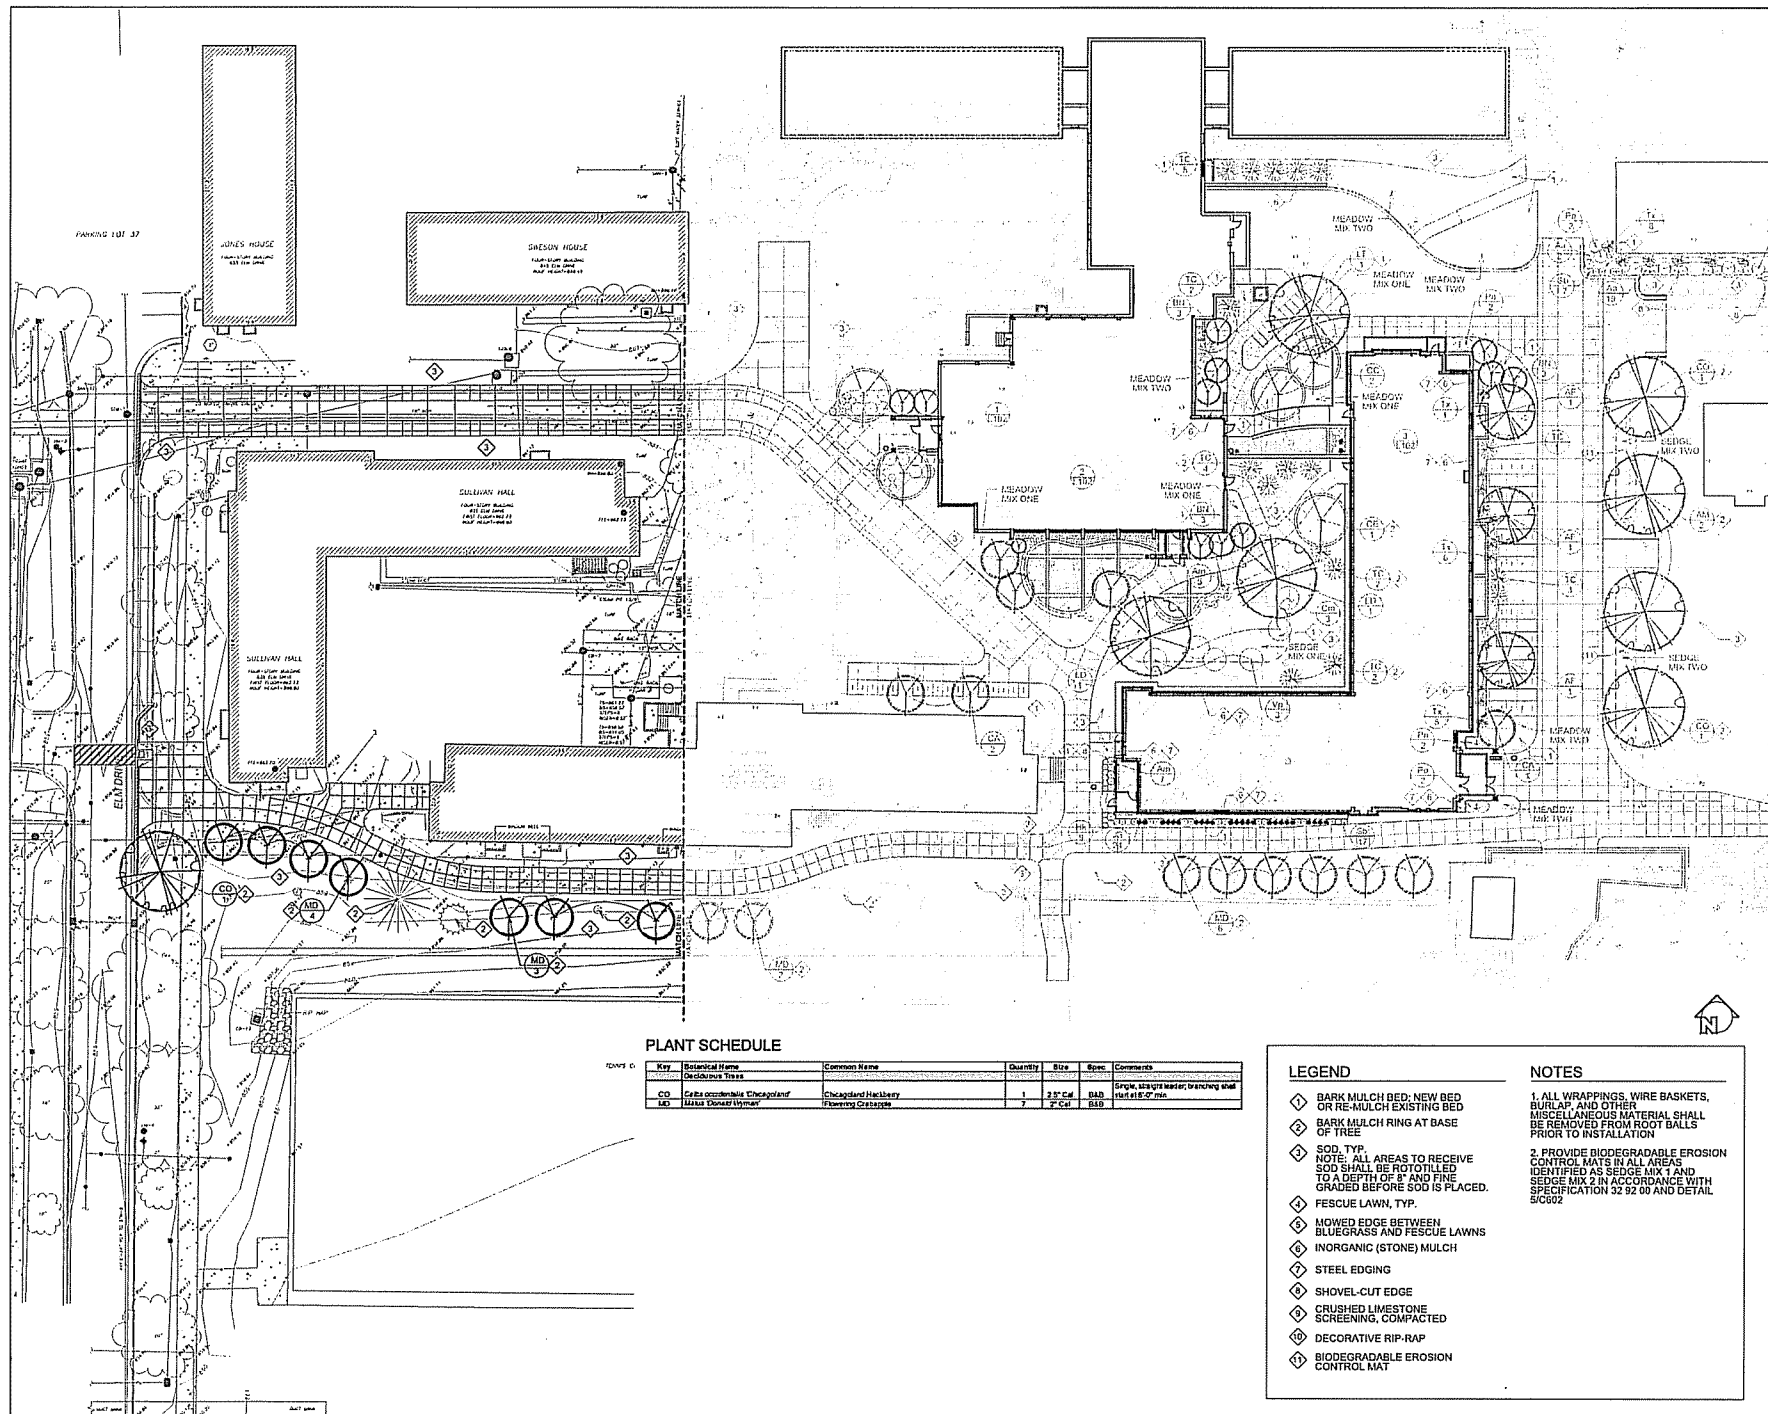

PLANT SCHEDULE

Key	Botanical Name	Common Name	Quantity	Size	Spec.	Comments
CO	<i>Cornus canadensis</i>	Chokeberry	1	3" Cal.	BAB	Single, always water, branching and start at 8" min.
LD	<i>Liriodendron tulipifera</i>	Tulip Tree	7	2" Cal.	BAB	

LEGEND

- ◇ BARK MULCH BED; NEW BED OR RE-MULCH EXISTING BED
- ◇ BARK MULCH RING AT BASE OF TREE
- ◇ SOD, TYP.
NOTE: ALL AREAS TO RECEIVE SOD SHALL BE ROTOTILLED TO A DEPTH OF 8" AND FINE GRADED BEFORE SOD IS PLACED.
- ◇ FESCUE LAWN, TYP.
- ◇ MOWED EDGE BETWEEN BLUEGRASS AND FESCUE LAWNS
- ◇ INORGANIC (STONE) MULCH
- ◇ STEEL EDGING
- ◇ SHOVEL-CUT EDGE
- ◇ CRUSHED LIMESTONE SCREENING, COMPACTED
- ◇ DECORATIVE RIP-RAP
- ◇ BIODEGRADABLE EROSION CONTROL MAT

NOTES

1. ALL WRAPPINGS, WIRE BASKETS, BURLAP, AND OTHER MISCELLANEOUS MATERIAL SHALL BE REMOVED FROM ROOT BALLS PRIOR TO INSTALLATION
2. PROVIDE BIODEGRADABLE EROSION CONTROL MATS IN ALL AREAS IDENTIFIED AS SEDGE MIX 1 AND SEDGE MIX 2 IN ACCORDANCE WITH SPECIFICATION 32 92 00 AND DETAIL 60602

eua
epstein when : architects
211 East Chicago Street
Milwaukee, Wisconsin 53202
Tel: 414.224.4444 Fax: 414.224.4444

MISSION
211 West Washington Ave. Suite 400
Milwaukee, Wisconsin 53203
Tel: 414.224.4444 Fax: 414.224.4444

Consultant:
JEN SAUTER
211 West Washington Ave. Suite 400
Milwaukee, Wisconsin 53203
Tel: 414.224.4444 Fax: 414.224.4444

State of Wisconsin
Department of Administration
Division of State Facilities

UNIVERSITY OF WISCONSIN - MADISON
Agency: Madison
Project Location: MADISON, WISCONSIN
Sheet Title: PLANTING PLAN

Project Title: LAKESHORE PHASE II

Graphic Scale: 0' 5' 10' 20'

DSF Number: 10630


Set Type: FR

Date Issued: 06/19/2011

Sheet Number: **L101**

PLANT SCHEDULE

Key	Botanical Name	Common Name	Quantity	Size	Spec.	Comments
Deciduous Trees						
BN	<i>Betula nigra</i> "Little King"	Little King River Birch	2	3" H.	B&B	State locations and obtain approval from U.S. before planting
CC	<i>Carpinus caroliniana</i>	American Hornbeam	2	2" Cal.	B&B	1/4" stem 8-10 ft
Deciduous Shrubs						
PO	<i>Physocarpus opulifolius</i>	Streaked	10	3" H.	Cont.	
Perennial Grasses/Grasscovers						
PS	<i>Parthenoclella gracilis</i>	Russian Sage	15	1 gal.	Cont.	Space 30" o.c.

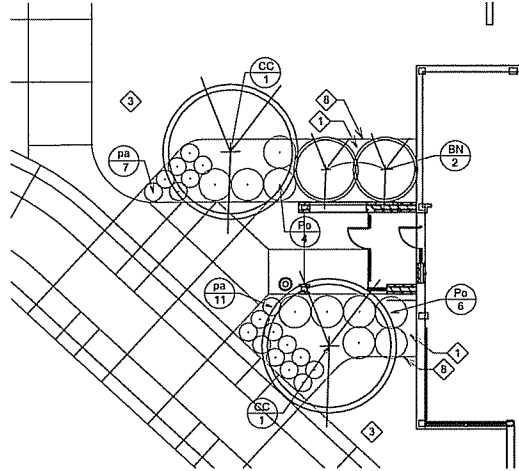


1 WEST HOLT ENTRY PLANTING

SCALE: 1/8"=1'-0"

PLANT SCHEDULE

Key	Botanical Name	Common Name	Quantity	Size	Spec.	Comments
Deciduous Trees						
CA	<i>Campanula medium</i>	Poppy Delmonia	3	8" H.	B&B	Single stem form with scalloped
CV	<i>Centaurea coccinea</i> "Covey"	Winecup Larkspur	1	4" H.	B&B	
Perennial Grasses/Grasscovers						
ES	<i>Echinacea purpurea</i>	Summer Coneflower	67	4"	Pol.	Space 18" o.c.
SM	<i>Salvia x sylvestris</i> "May Night"	May Night Salvia	64	4"	Pol.	Space 12" o.c.
SS	<i>Scorzonilla racemosa</i> "The Blues"	The Blues Little Bluestem	69	1 gal.	Cont.	Space 18" o.c.

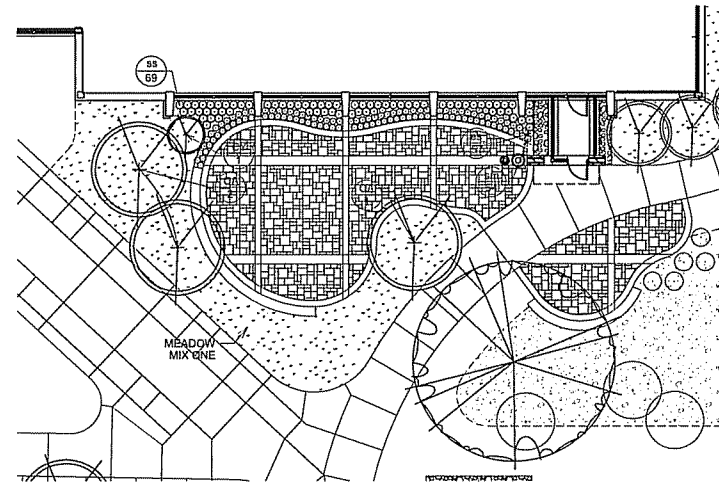


2 LOWER PATIO PLANTING

SCALE: 1/8"=1'-0"

PLANT SCHEDULE

Key	Botanical Name	Common Name	Quantity	Size	Spec.	Comments
Evergreen Trees						
JS	<i>Juniperus horizontalis</i> "Seymour"	Seymour Juniper	2	3" H.	B&B	Space per plan
Perennial Grasses/Grasscovers						
PS	<i>Parthenoclella gracilis</i>	Russian Sage	2	1 gal.	Cont.	Space 30" o.c.
SM	<i>Salvia x sylvestris</i> "May Night"	May Night Salvia	5	1 gal.	Cont.	Space per plan
SS	<i>Scorzonilla racemosa</i> "The Blues"	The Blues Little Bluestem	7	1 gal.	Cont.	Space 18" o.c.

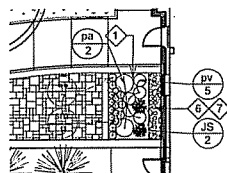

3 UPPER PATIO PLANTING

SCALE: 1/8"=1'-0"

LEGEND

- 1 BARK MULCH BED; NEW BED OR RE-MULCH EXISTING BED
- 2 BARK MULCH RING AT BASE OF TREE
- 3 SOD, TYP. NOTE: ALL AREAS TO RECEIVE SOD SHALL BE ROTOTILLED TO A DEPTH OF 8" AND FINE GRADED BEFORE SOD IS PLACED.
- 4 FESCUE LAWN, TYP.
- 5 MOWED EDGE BETWEEN BLUEGRASS AND FESCUE LAWNS
- 6 INORGANIC (STONE) MULCH
- 7 STEEL EDGING
- 8 SHOVEL-CUT EDGE
- 9 CRUSHED LIMESTONE SCREENING, COMPACTED
- 10 DECORATIVE RIP-RAP
- 11 BIODEGRADABLE EROSION CONTROL MAT

NOTES

- 1. ALL WRAPPINGS, WIRE BASKETS, BURLAP AND OTHER MISCELLANEOUS MATERIAL SHALL BE REMOVED FROM ROOT BALLS PRIOR TO INSTALLATION
- 2. PROVIDE BIODEGRADABLE EROSION CONTROL MATS IN ALL AREAS IDENTIFIED AS SEDGE MIX 1 AND SEDGE MIX 2 IN ACCORDANCE WITH SPECIFICATION 32 92 00 AND DETAIL S1002

eppstein uhen : architects

233 East Chicago Street
Milwaukee, Wisconsin 53202
Tel: 414.224.1100 Fax: 414.224.1101
www.eua.com

Consultant

State of Wisconsin
Department of Administration
Division of State Facilities

Project Location:

MADISON, WISCONSIN

Project Name:

LAKESHORE PHASE II

Drawn By:

10/25/01

Scale:

1"=10'

Graphic Scale:

0 25 50 100'

DSP Number:

10030

Cell Type:

FR

Date Issued:

10/30/2011

Drawn By:

L102

1 2 3 4 5 6 7

KEYNOTES PER SHEET
10/18 10/18 10/18 10/18 10/18 10/18 10/18

eua
eppstein uhen : architects
233 East College Street
Milwaukee, Wisconsin 53202
tel 414 251-1111 fax 414 251-1114
medium 233 West Mearns Avenue, Suite 400
Madison, Wisconsin 53704
tel 608 251-1111 fax 608 251-1114

Consultant:

State of Wisconsin
Department of Administration
Division of State Facilities

Agency / Institution
UNIVERSITY OF WISCONSIN - MADISON

Project Name
UW - MADISON LAKESHORE RESIDENCE
HALL PHASE II
Project Location
MADISON, WISCONSIN
Sheet Title
LOWER LEVEL PLAN

Revisions	No.	Date	By	Description

Graphic Scale
1" = 20'-0"
DSF Number
10030
Set Type
CITY SUBMITTAL
Date Issued
10/03/11
Sheet Number
A100

SEE A500 SERIES DRAWINGS

A1 LOWER LEVEL FLOOR PLAN
10'-0" = 1"



1 2 3 4 5 6 7

1 2 3 4 5 6 7

KEYNOTES PER SHEET



eppstein uhlen : architects
223 East College Street
Madison, WI 53706
608.261.1111
www.eua.com

Consultant:

State of Wisconsin
Department of Administration
Division of State Facilities



UNIVERSITY OF WISCONSIN - MADISON

Project Name
OW - MADISON LAKESHORE RESIDENCE
HALL PHASE II

Project Location
MADISON, WISCONSIN

Sheet Title
THIRD FLOOR PLAN

Rev.	Date	By	Description

Graphic Scale	1" = 2' 0"
DSP Number	10030
Set Type	CITY SUBMITTAL
Date Issued	06/03/11
Sheet Number	A103

E

D

C

B

A

A1 THIRD FLOOR PLAN



1 2 3 4 5 6 7



Consultant

K J
W W

ENGINEERING CONSULTANTS

Experience you can build on™

402 WEST LINDSEY AVE, SUITE 312
VAO EGM, VA 23161
(804) 223-0400 FAX: (804) 223-5401
www.kjww.com # 000022200

STRUCTURAL | MECHANICAL | ELECTRICAL
TECHNOLOGY | MEDICAL EQUIPMENT SOLUTIONS




Project Title: UW - MADISON LAKESHORE RESIDENCE
HALL PHASE II

Project Location.

Sheet Title: SITE PLAN - LIGHTING PHOTOMETRICS

[illegible]

Graphic Scale	
DSF Number	12G3D
Set Type	CITY SUBMITTAL
Date Issued	06/03/11
Sheet Number	EL001

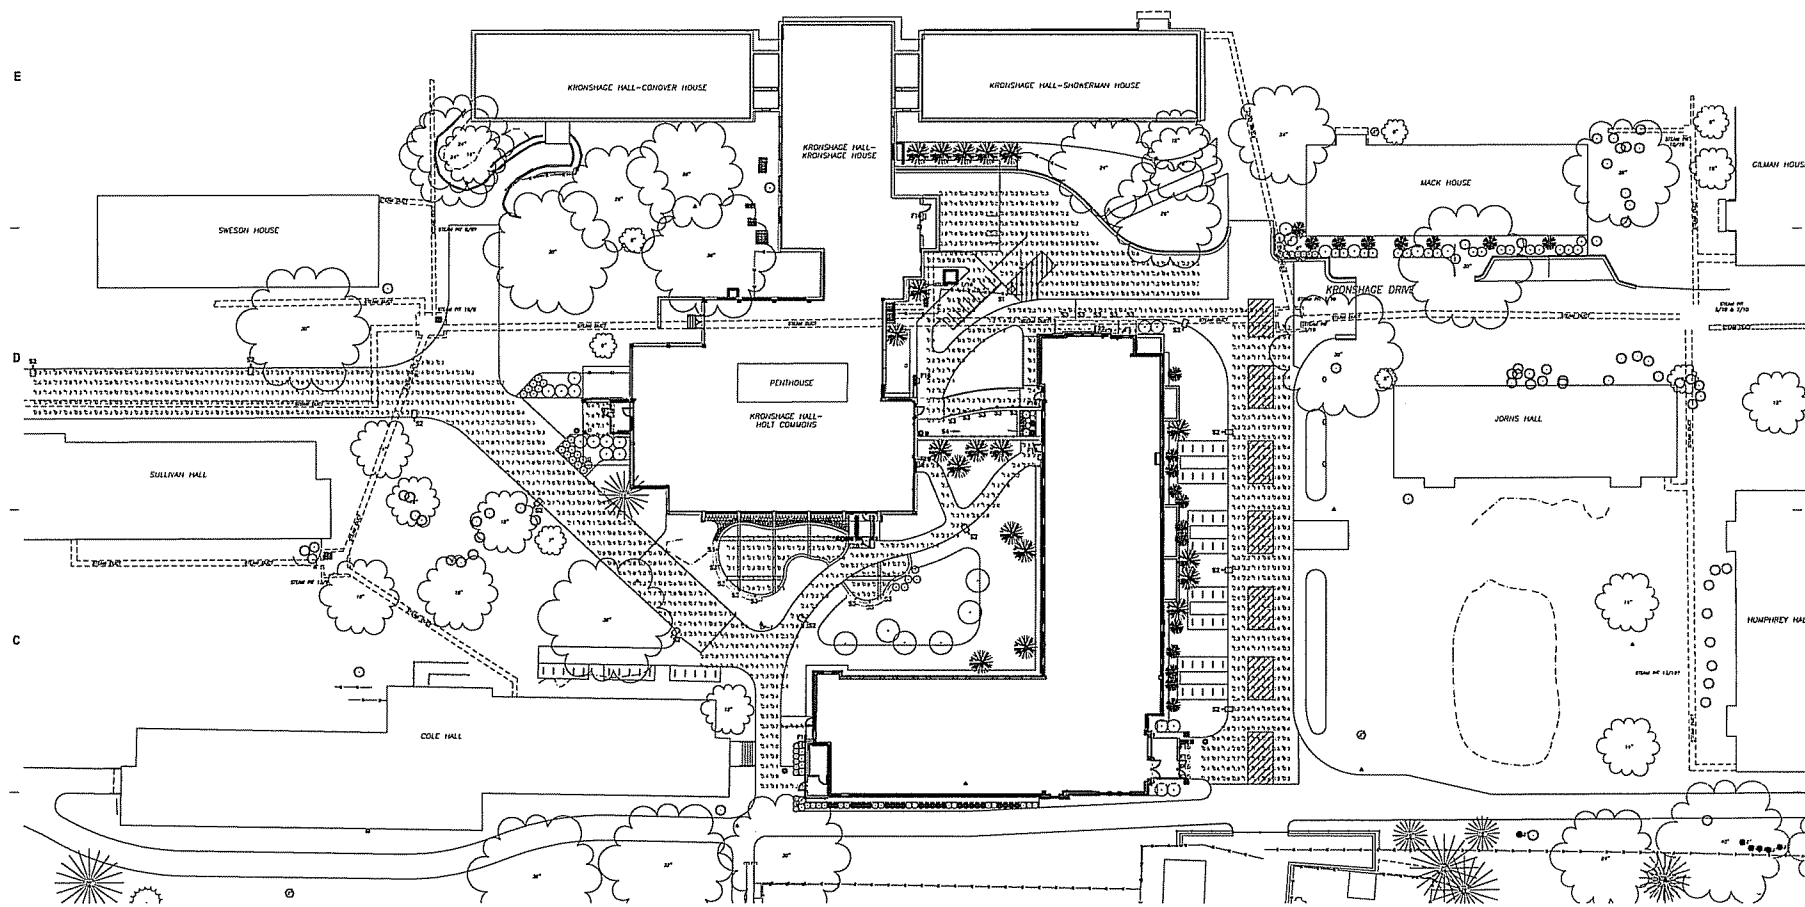


 1 SITE PLAN - LIGHTING PHOTOMETRICS
SCALE: 1/8" = 1'

[illegible][illegible]

POWER DENSITY STATISTICS				
Input	Amplitude	Total Width	Area	Intensity
Power, Full Line	50	1760000	353600000	0.020000
Masking & Bias				

**PRELIMINARY
NOT FOR
CONSTRUCTION**

EL001

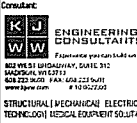[illegible]

Graphic Scale	
DSF Number	12G3D
Set Type	CITY SUBMITTAL
Date Issued	08/03/11
Sheet Number	EL002

