

[Larger Image](#)

© by designer

Front Perspective, Color Rendering



[Larger Image](#)

© by designer

[Larger Image](#)

© by designe

Rear Elevation



[Larger Image](#)

© by designer


Advertisement

- Customization Consultation and Estimate (requires the purchase of a Reproducible print) \$50


Important Extras ?

- Builders Planning Package \$55.00
- Electrical Details Set \$14.95
- Plumbing Details Set \$14.95
- Construction Details Set \$14.95
- Mechanical Detail Set \$14.95
- Specification Outline \$10.00
- Home Furniture Planner \$15.95

First Floor/Main Level

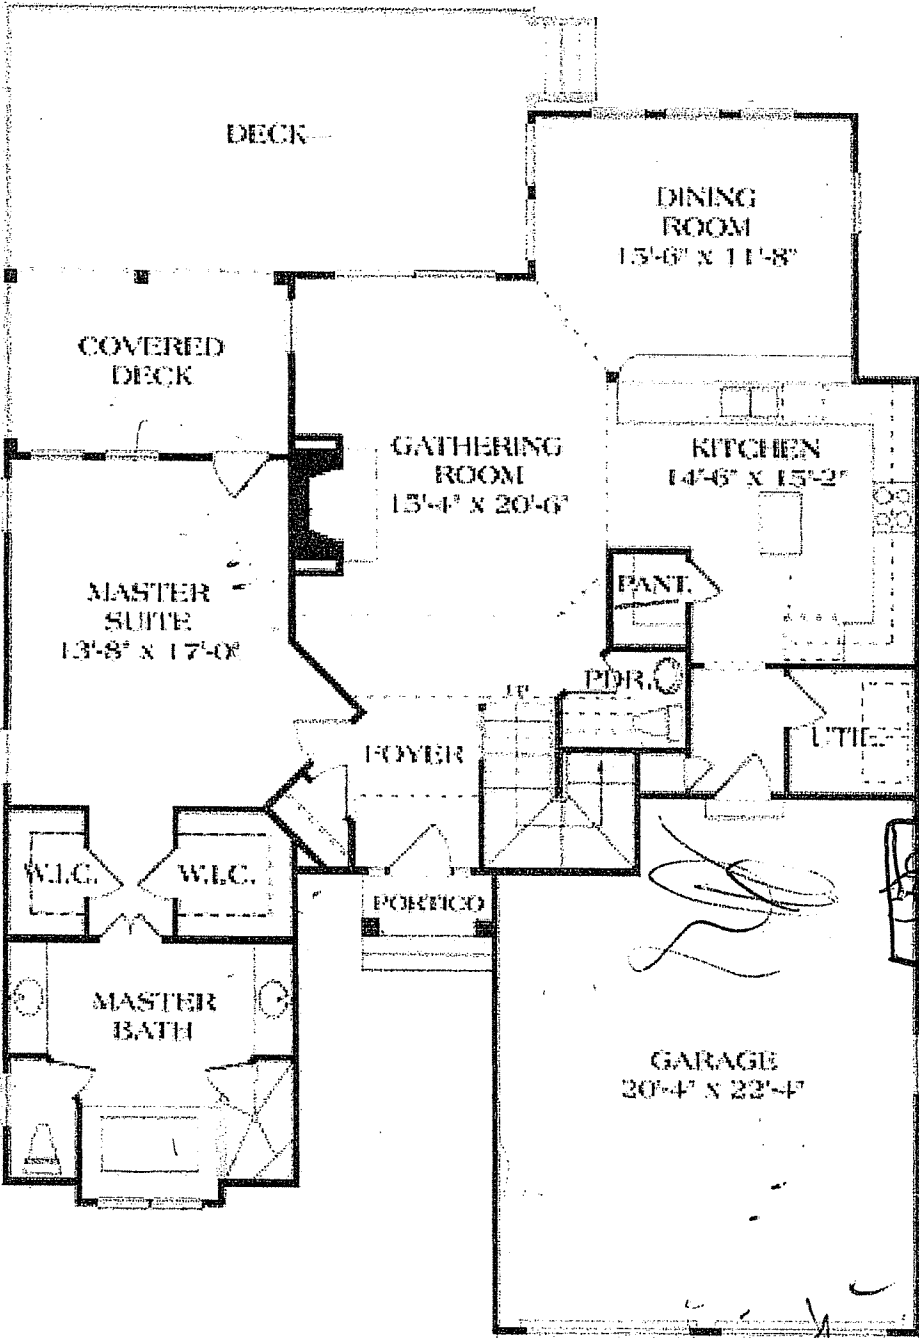

Second Floor

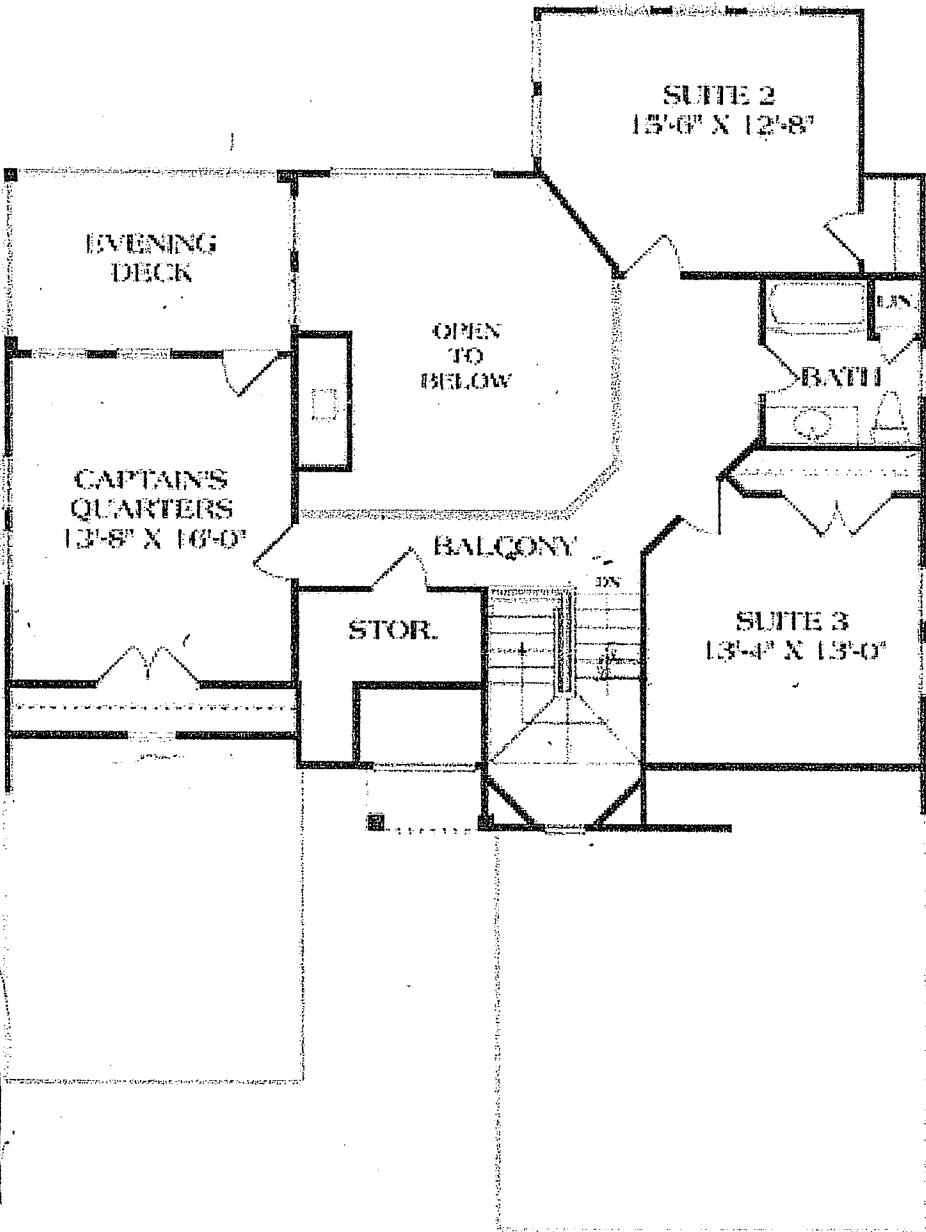

Larger Image

© by designe

DESCRIPTION:
LOTS 1 AND 2, BLOCK 1, RAYWOOD HEIGHTS, CITY OF MADISON, DANE COUNTY,
WISCONSIN.

Legend:

0' 20' 40'
Scale: 1 inch = 20 feet

• = Iron stake found
○ = 1" x 24" iron pipe set
min. wt. = 1.13 lb./in. ft.
() = Recorded as data
CONTOUR INTERVAL = 1 FOOT

- STORM INLET
DECIDUOUS TREE
UTILITY POLE
LIGHT POLE
MAN HOLE

Notes:


"The disturbance of a survey stake by anyone is in violation of Section 238.32 of Wisconsin Statutes."
"Mileage if present has not been delineated."
"This survey is subject to any and all easements and agreements both recorded and unrecorded."

SURVEYOR'S CERTIFICATE:
I, David V. Birrenkott, hereby certify that this survey is in compliance of Wisconsin Administrative Code. I also certify that I have surveyed and mapped the lands described herein and that the map is a correct representation in accordance with the information provided.

David V. Birrenkott
Wisconsin Registered Land Surveyor No. 3-1531.

REFERENCED TO THE NORTH LINE OF WAUNONA WAY
RECORDED AS 1854000 E

NOTE:
COTTAGES AND CABIN TO BE REMOVED.

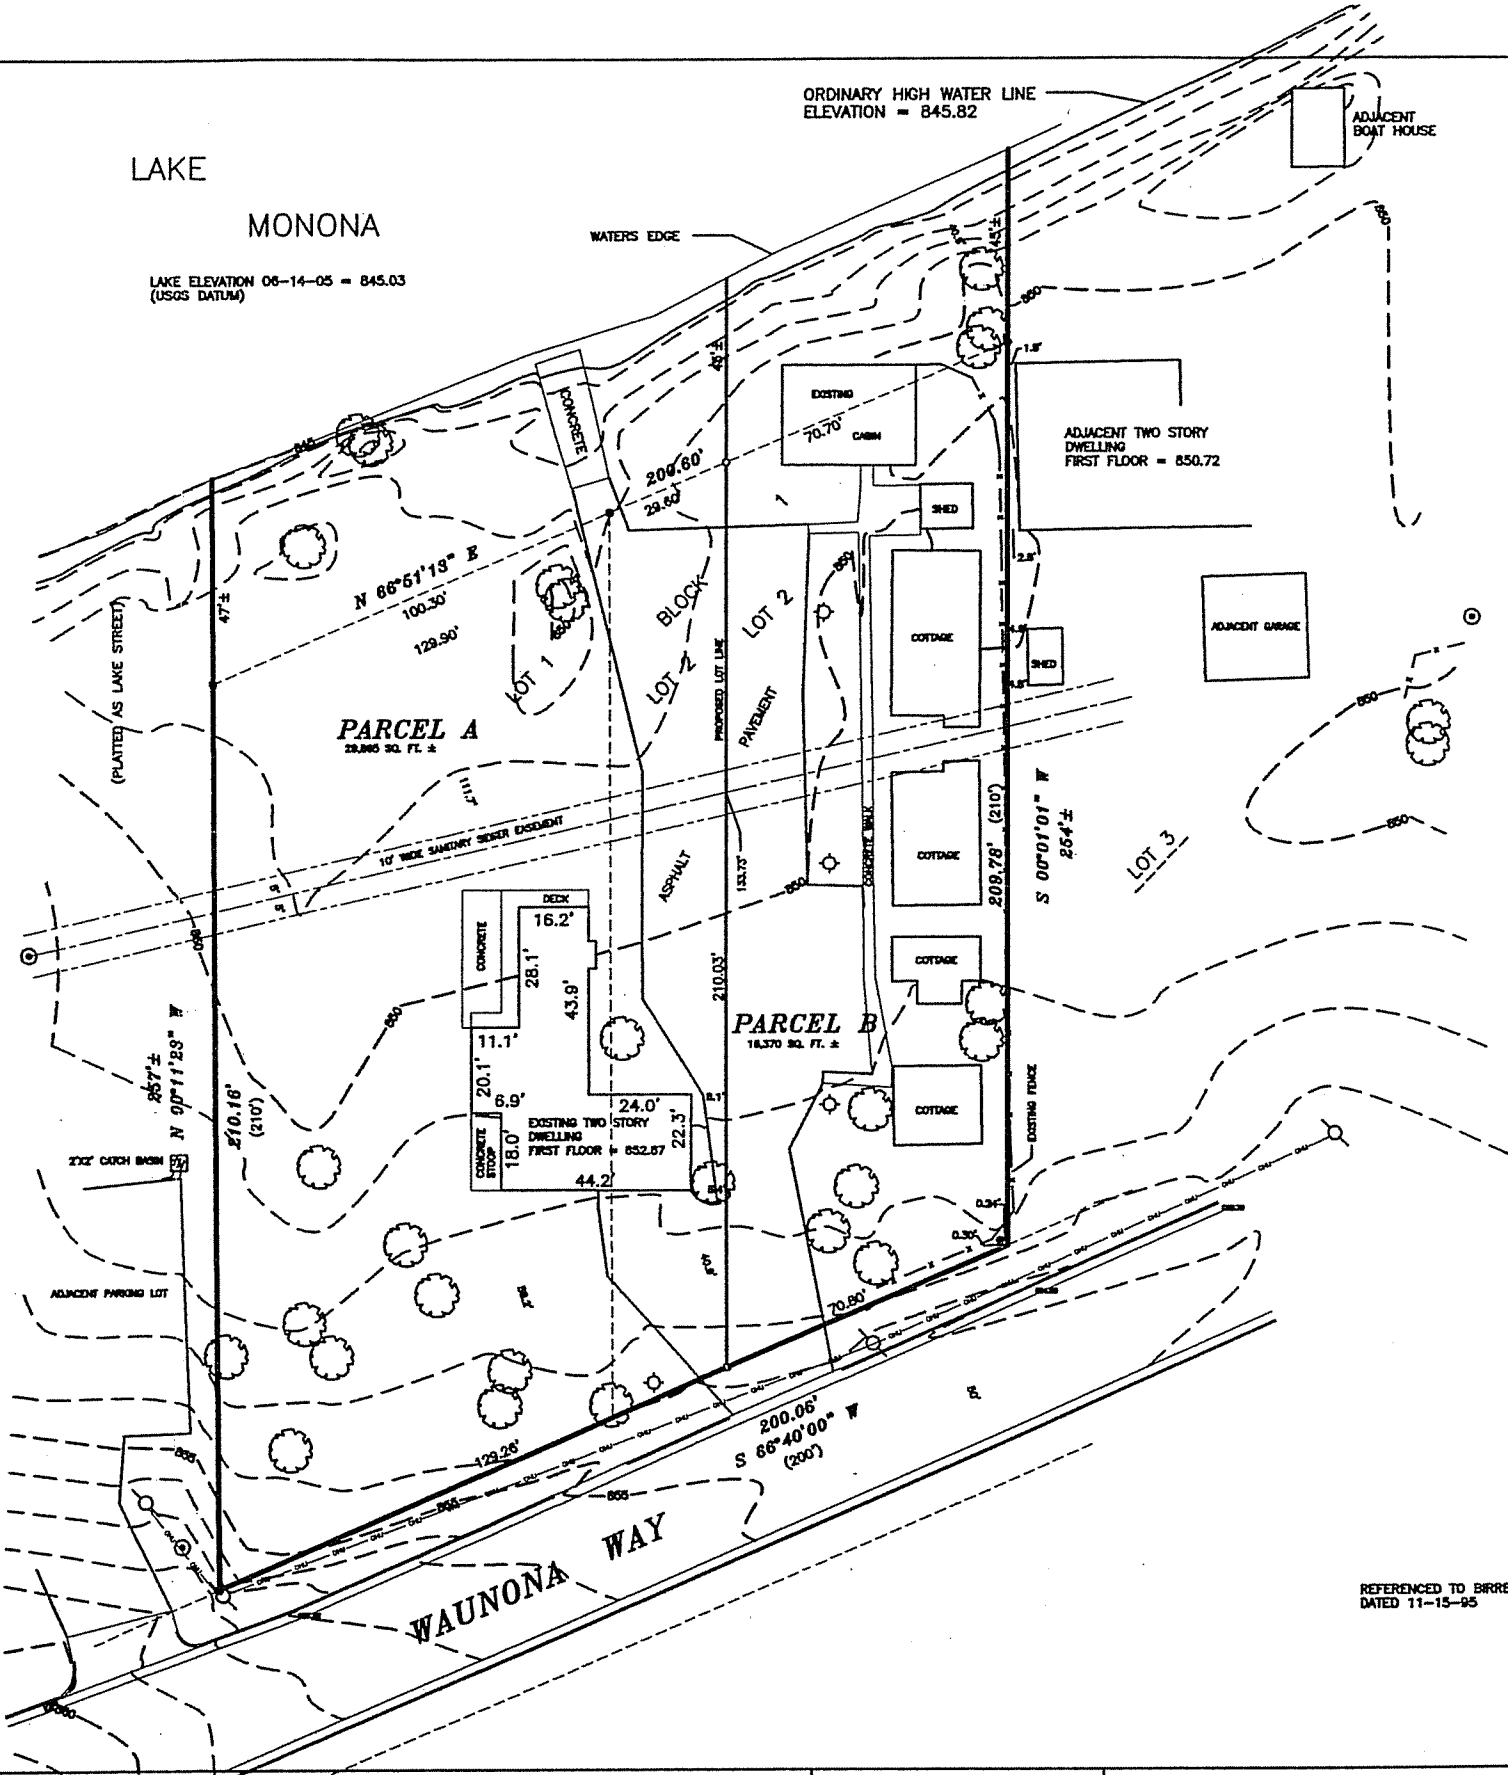

REFERENCED TO BIRRENKOTT SURVEY MAP NO. 9555
DATED 11-15-95

COMP FILE- J:\2005\050432
DRAW FILE- L:\2005\050432T
TNT FILE- J:\1995\050432

BIRRENKOTT SURVEYING INC.
LAND SURVEYING & PERC TESTING
P.O. BOX 237
1677 N. BRISTOL ST.
SUN PRAIRIE, WIS. 53590
(608) 837-7483
FAX (608) 837-1081

TOPOGRAPHIC SURVEY
JUNE 17-2005


SURVEYED BY CC
DRAWN BY MK
CHECKED BY _____
APPRVD BY D.V.B.

PREPARED FOR:
JIM WILLMORE
2724 WAUNONA WAY
MADISON, WI 53713
(608) 222-1052

JOB NO.
050432
SHEET 1 OF 1
96/56-57
FB 271/59-61

LAKE

MONONA

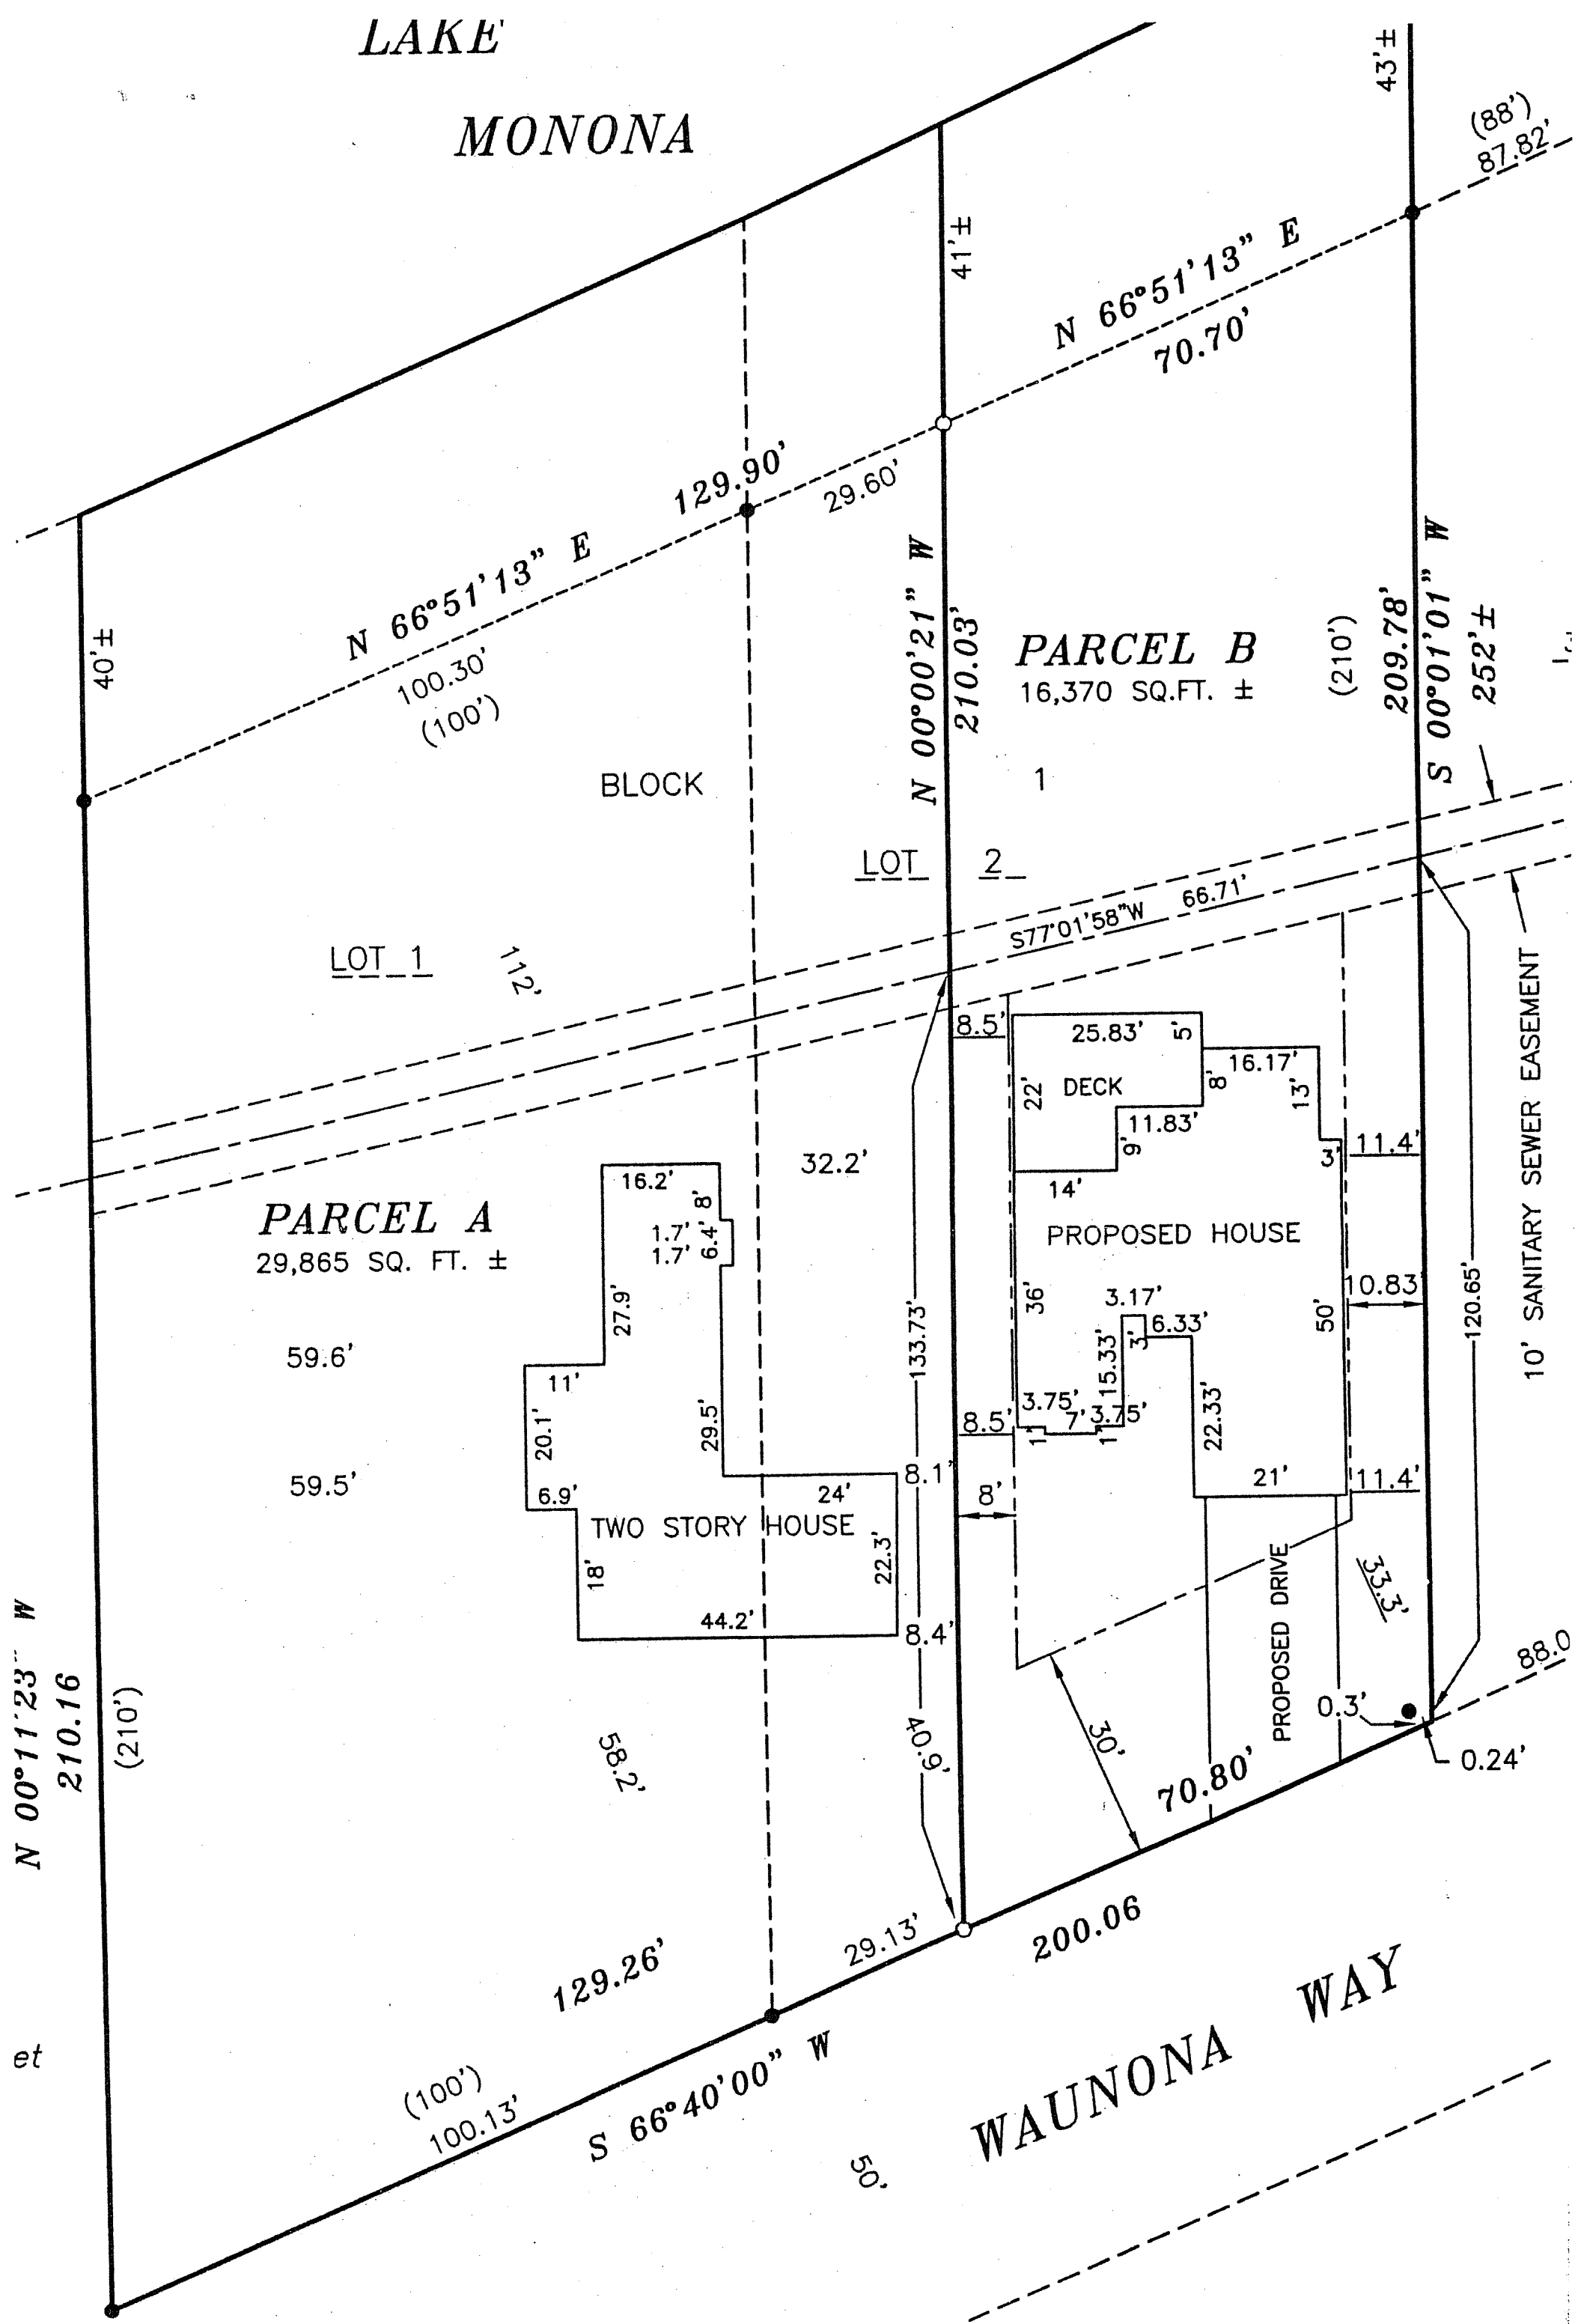

Surveved For:

WILLIAMS