

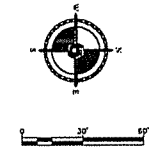


SYMBOL LEGEND

UTILITY POLE	
LIGHT POLE	
GUY WIRE	
ELECTRIC METER	
SIGN	
MH	
UTILITY PEDISTAL	
HYDRANT	
PROPERTY IRON	
PROPOSED STORM SEWER	
ELECTRICAL CONDUIT	

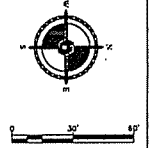

SHEET NAME: **PARCEL 4 - SITE ELECTRICAL PLAN**
 CLIENT: **HO-CHUNK NATION DEPARTMENT OF BUSINESS**
 DRAWN BY: **2E1**
 CHECKED BY: **CC**
 DATE: **12/21/12**
 PROJECT: **CC/1007**
 LOCATION: **1000 EAST AVENUE STREET - WOODROW, MICHIGAN 48091 (900) 342-2004**
 COMPANY: **COLEMAN ENGINEERING COMPANY**

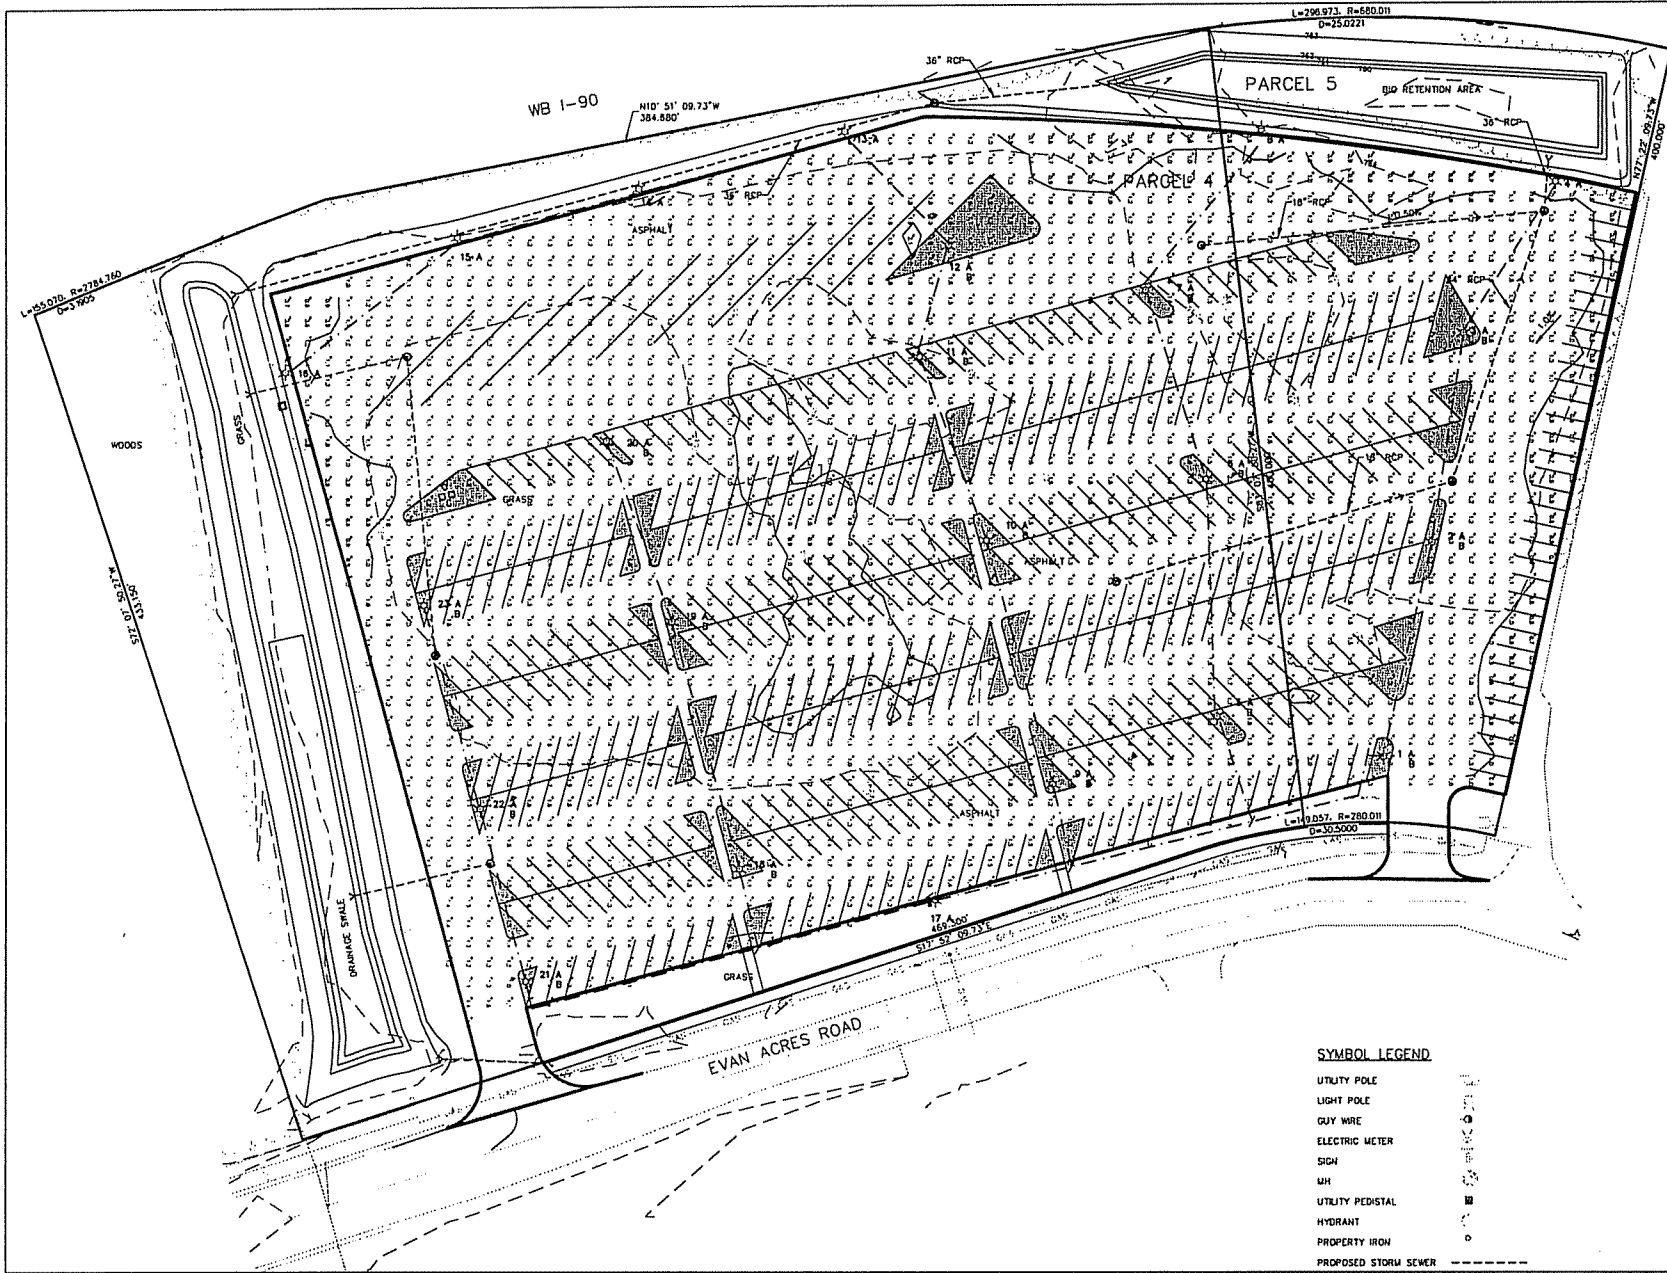

SYMBOL LEGEND

- UTILITY POLE
- LIGHT POLE
- GUY WIRE
- ELECTRIC METER
- SIGN
- MH
- UTILITY PEDISTAL
- HYDRANT
- PROPERTY IRON
- PROPOSED STORM SEWER



SHEET NAME: **PARCEL 4**
PARKING LOT LUMINA LEVELS

CLIENT: **HO-CHUNK NATION**
DEPARTMENT OF BUSINESS

DESIGNED BY:	DATE:	SCALE:
CHECKED BY:	DATE:	SCALE:
PROJECT NO.:	DATE:	SCALE:

2E2
 DRAWING NO.



COLEMAN ENGINEERING COMPANY
 100 EAST AVENUE STREET - ANN ARBOR, MICHIGAN 48106 (734) 962-2800

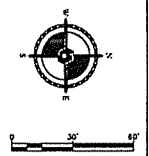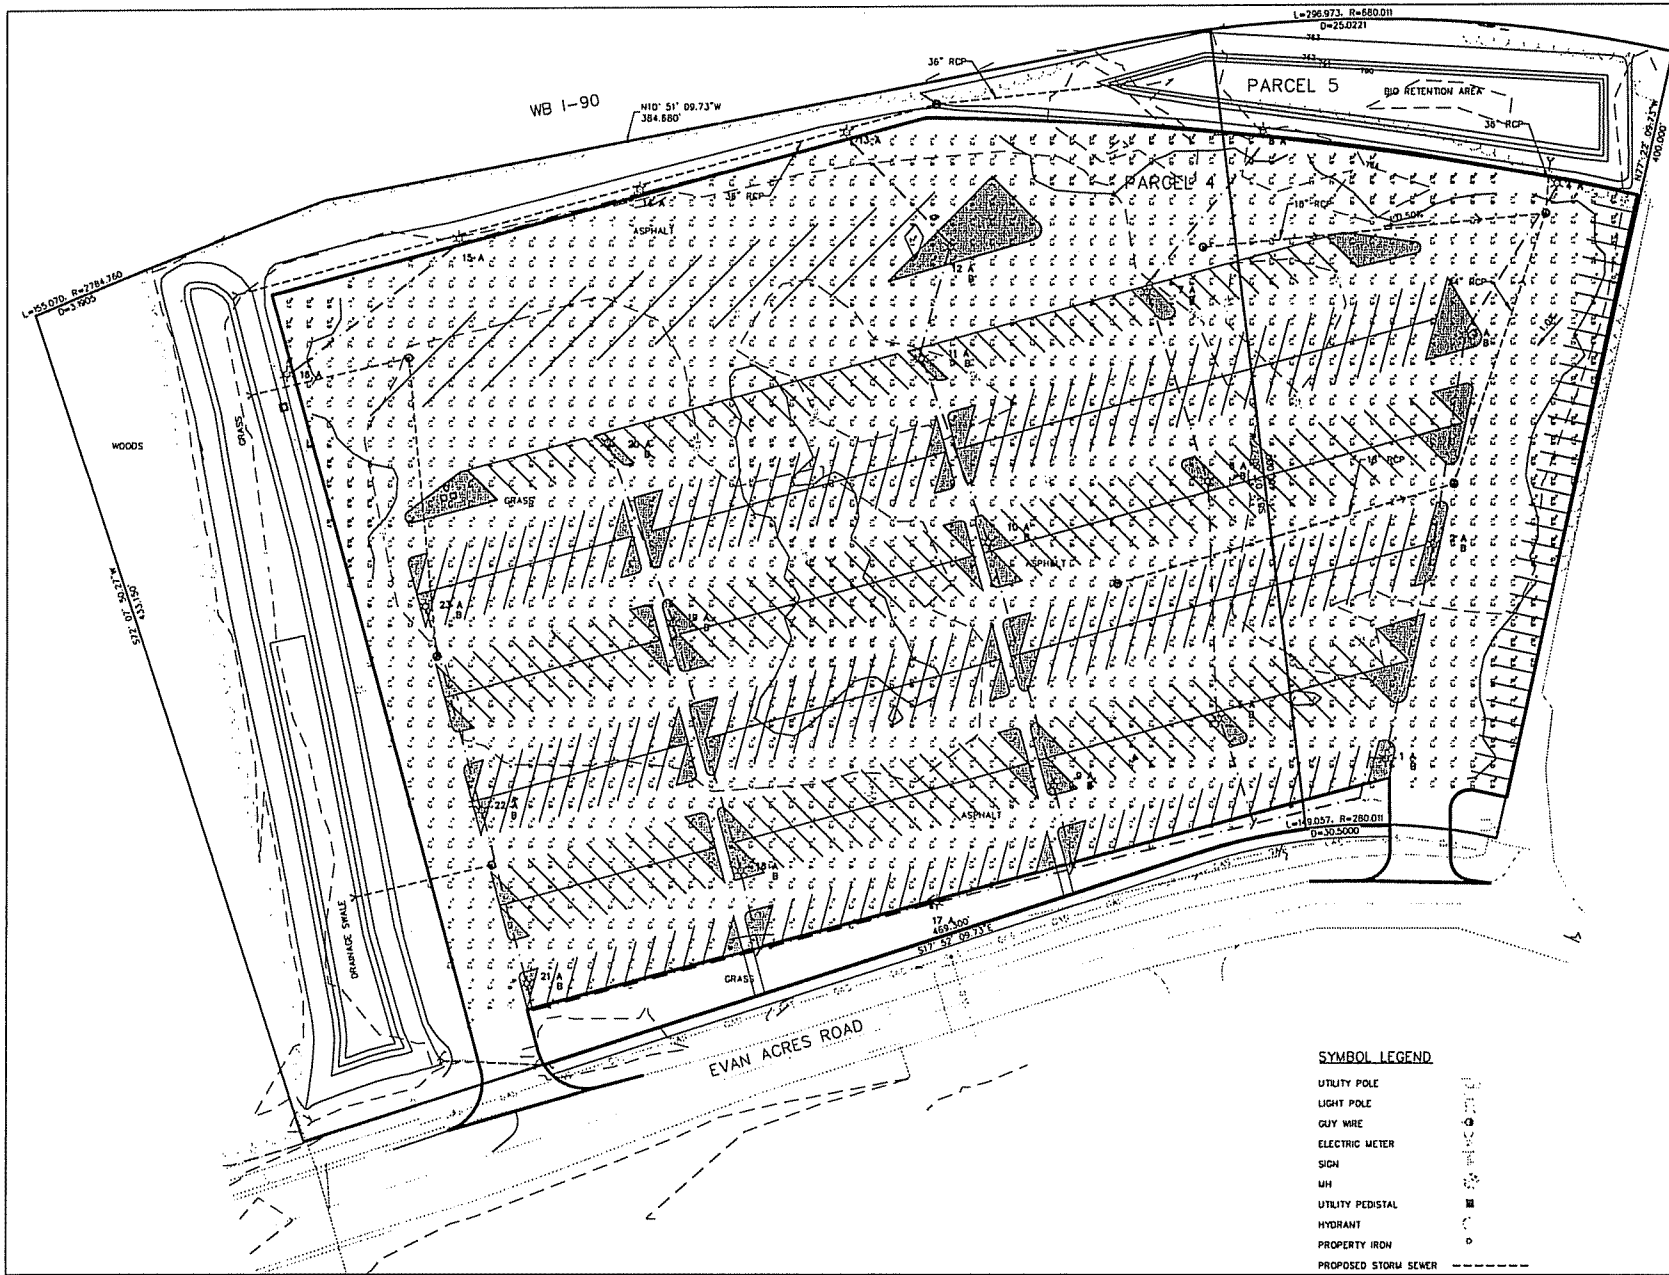

SYMBOL LEGEND

- UTILITY POLE
- LIGHT POLE
- GUY WIRE
- ELECTRIC METER
- SIGN
- UM
- UTILITY PEDISTAL
- HYDRANT
- PROPERTY IRON
- PROPOSED STORM SEWER

SUBMITTED BY: C. GIBSON DATE: 7/21/12	DOW DRAWING: 10011-10000-10000-10000	CHECKED BY: CC	DOW PROJECT: CC	DATE: 04/10/07	SHEET NAME: PARCEL 4 PARKING LOT LUMINA LEVELS
HO-CHUNK NATION DEPARTMENT OF BUSINESS			COLEMAN ENGINEERING COMPANY 10011-10000-10000-10000 300 EAST AVENUE STREET - ARROWWOOD, MISSOURI 65031 (PO) 650-200-2000		
2E2 DRAWING NO.					

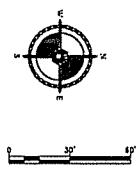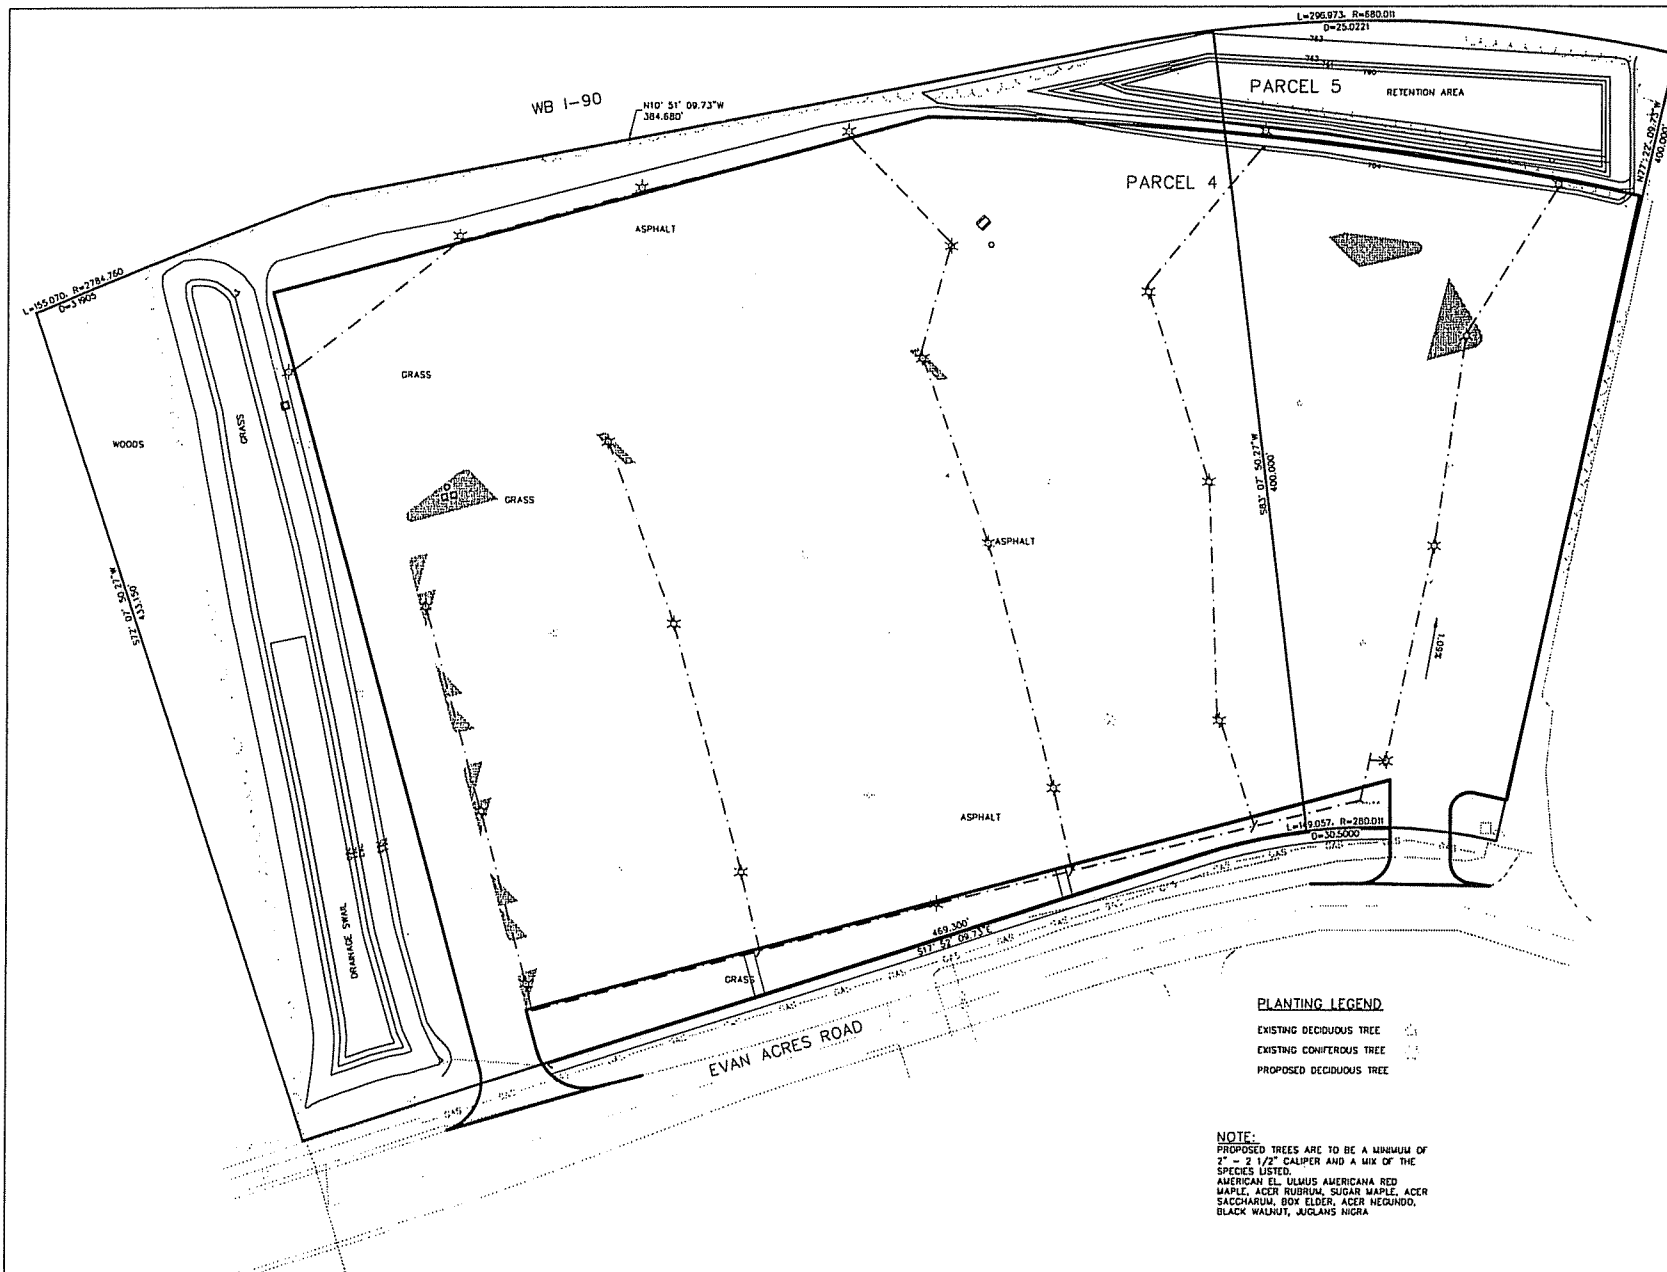

- PLANTING LEGEND**
- EXISTING DECIDUOUS TREE
 - EXISTING CONIFEROUS TREE
 - PROPOSED DECIDUOUS TREE

- SYMBOL LEGEND**
- UTILITY POLE
 - LIGHT POLE
 - CLAY WIRE
 - ELECTRIC METER
 - SIGN
 - MH
 - UTILITY PEDISTAL
 - HYDRANT
 - PROPERTY IRON
 - PROPOSED STORM

NOTE:
 PROPOSED TREES ARE TO BE A MINIMUM OF 7" - 2 1/2" CALIPER AND A MIX OF THE SPECIES LISTED.
 AMERICAN EL, ULMUS AMERICANA RED MAPLE, ACER RUBRUM, SUGAR MAPLE, ACER SACCHARUM, BOX ELDER, ACER NEGUNDO, BLACK WALNUT, JUGLANS NIGRA

SHEET NAME: PARCEL 4 PLANTING PLAN
 CLIENT: HO-CHUNK NATION DEPARTMENT OF BUSINESS
 DRAWN BY: [blank] CHECKED BY: [blank]
 DATE: 7/24/12
 PROJECT: [blank] COUNTY: [blank]

COLEMAN ENGINEERING COMPANY
 433 ORCHARD DRIVE - NEW HARTFORD, MICHIGAN 48851 (920) 774-3440
 201 EAST 41ST STREET - ANN ARBOR, MICHIGAN 48106 (920) 521-5040

2P
 DRAWING NO.