







CODE INFORMATION		PLI Project No. 2010 20 00	
University of Wisconsin All Season Golf Practice Facility		DSF Project No. 1031L	
University Ridge Golf Course		April 27, 2011	
9002 County Road PD		Revised May 2, 2011	
Madison, Wisconsin			
General Code Information			
ITEM	INFORMATION	REMARKS	
Design code(s):	2009 International Building Code Building Code		
Occupancy(ies):	Business Group B Type V-B	Non-separated mixed use	
Construction type:			
Building height & no. of stories:			
Stories	2		
Building Height	32 feet	40' permitted for V-B	
Fully Sprinkled?	Yes, per WCBC 903.3.1.1	Required by Madison FD	
Building Areas			
ITEM	ALLOWABLE AREA / FLOOR; NO. OF STORIES	ACTUAL AREA / FLOOR; NO. OF STORIES	
Construction Type			
Type V-B Occ. B	9,000 GSF; 3 stories	7,640 GSF + 3,782 GSF; 2 stories	
		7,640 + 3,782	
Areas of different construction types separated by a 2 hr firewall		Total Building Area = 11 422 GSF	
Occupant Loads			
OCCUPANCY	ALLOWABLE SF/OCCUPANT Per Table 1004.1.1	TOTAL OCCUPANTS Calculated Actual	
Lower Level Floor			
U Ridge Storage	300 sf gross	1	1
Total First Floor		1	1 Occupant
First Floor			
Locker room (Men)	50 sf gross	12	12
Locker room (Women)	50 sf gross	12	12
Coaches offices	100 sf gross	2	2
Total Second Floor		26	26 Occupants
Total Calculated Occupants		27	
Total Estimated Actual Occupants			27 Occupants

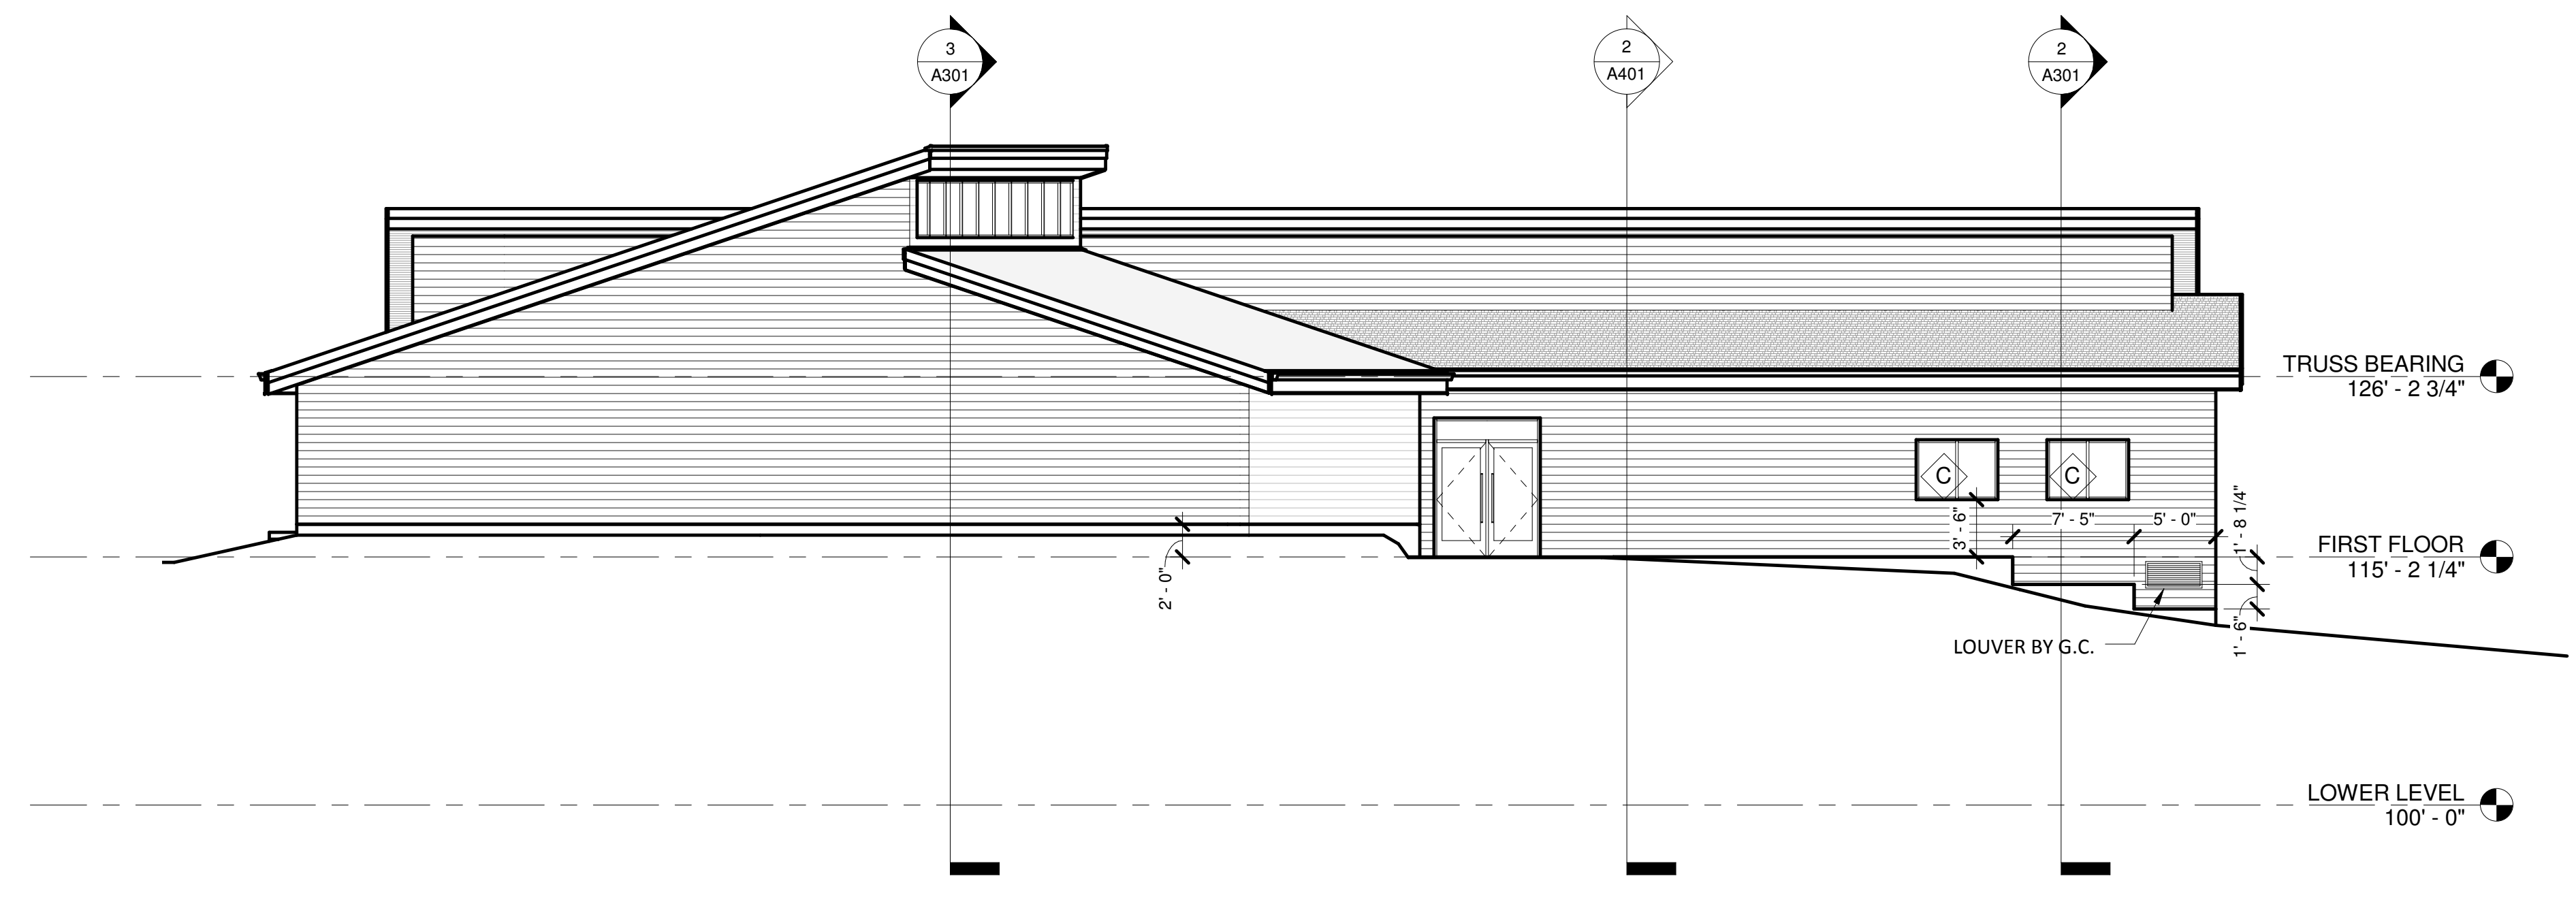

1 WEST ELEVATION
A201 1/8" = 1'-0"

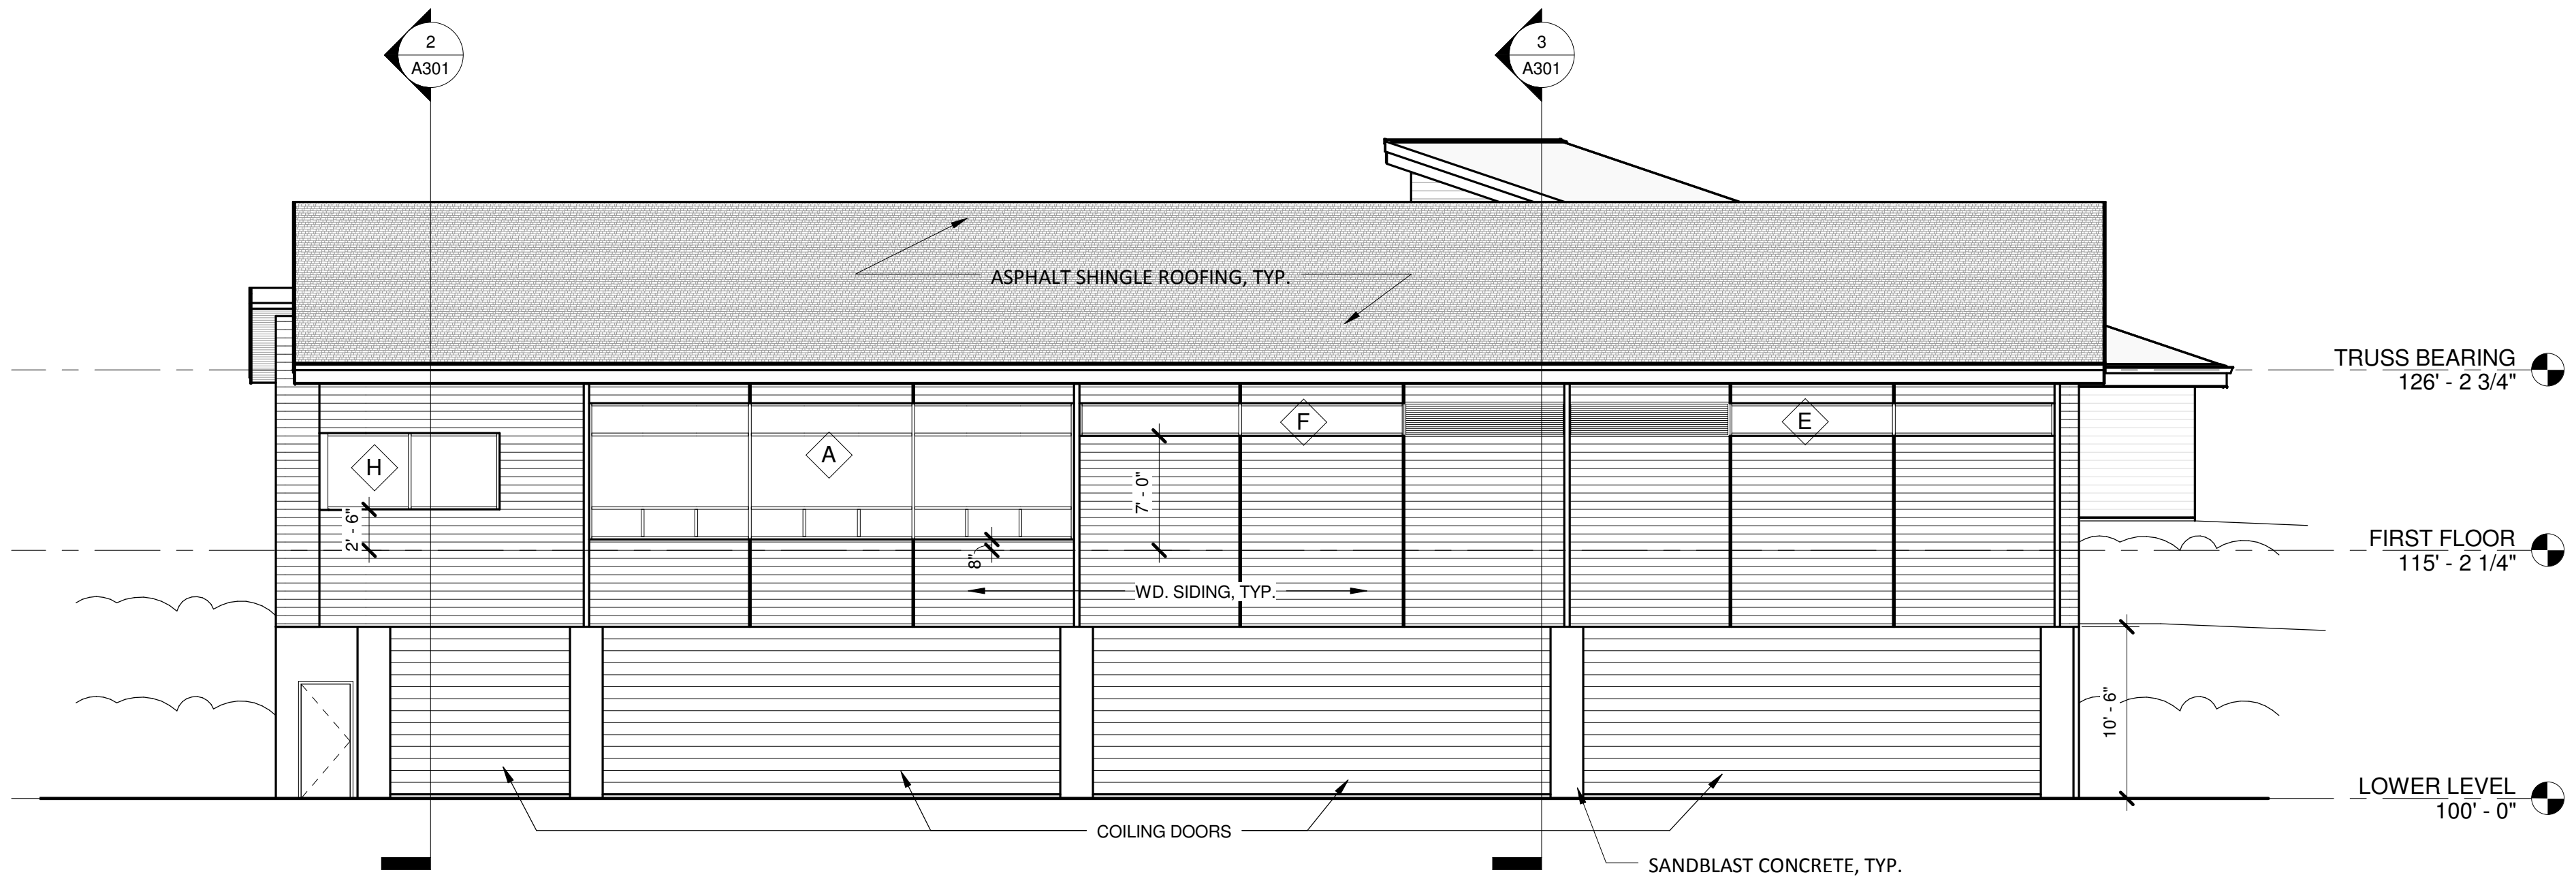


3 EAST ELEVATION
A201 1/8" = 1'-0"

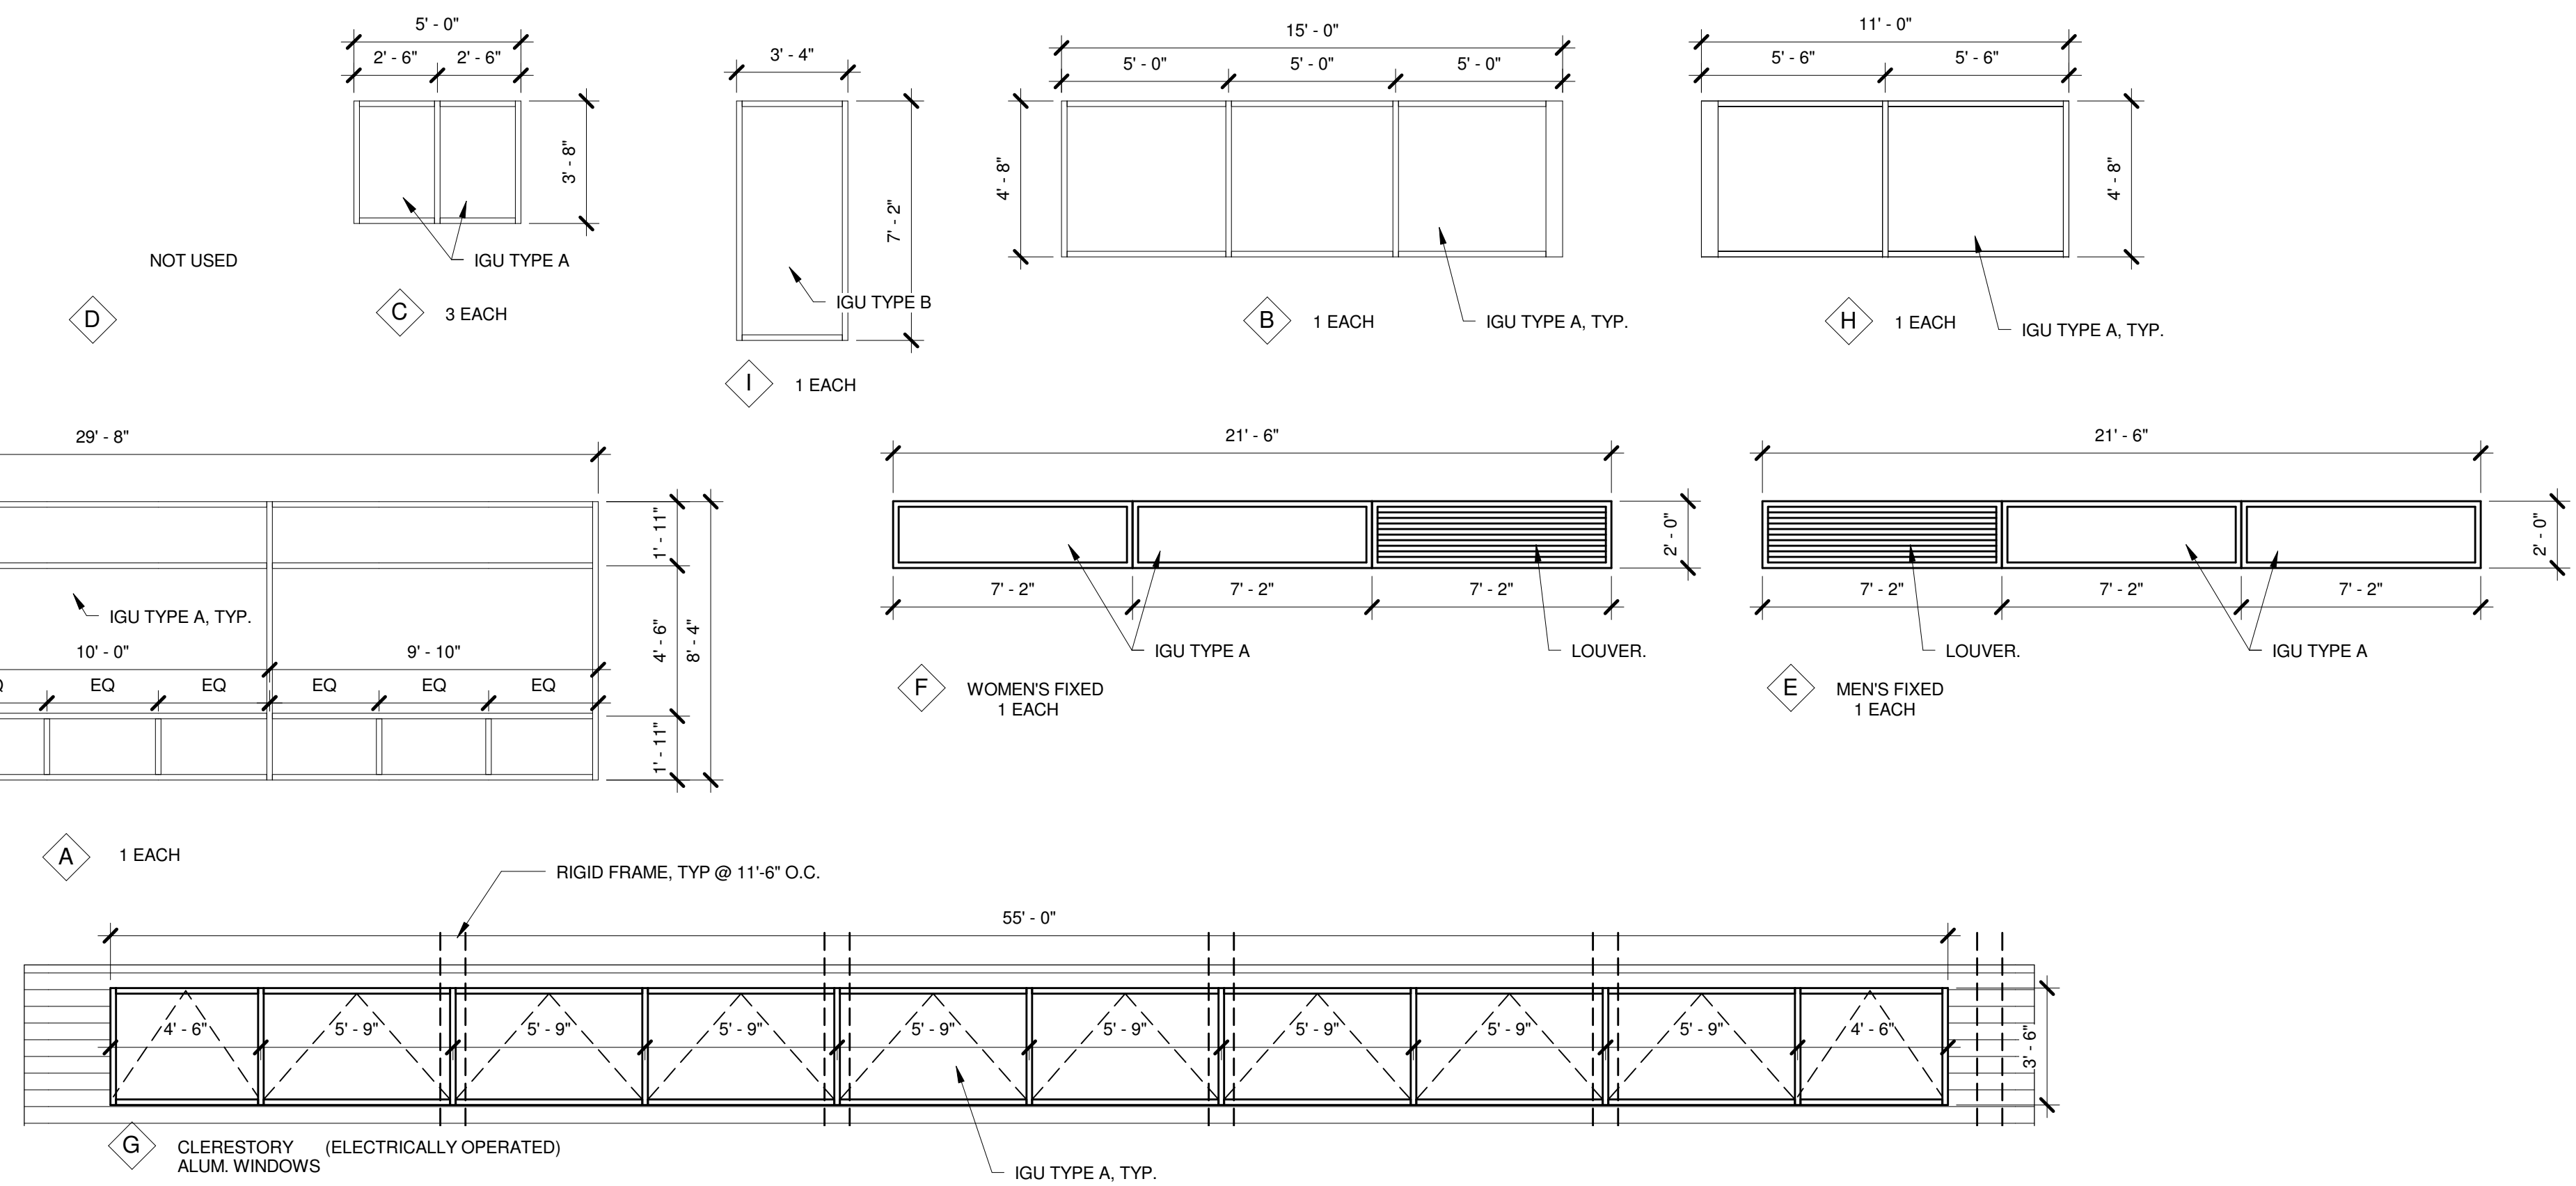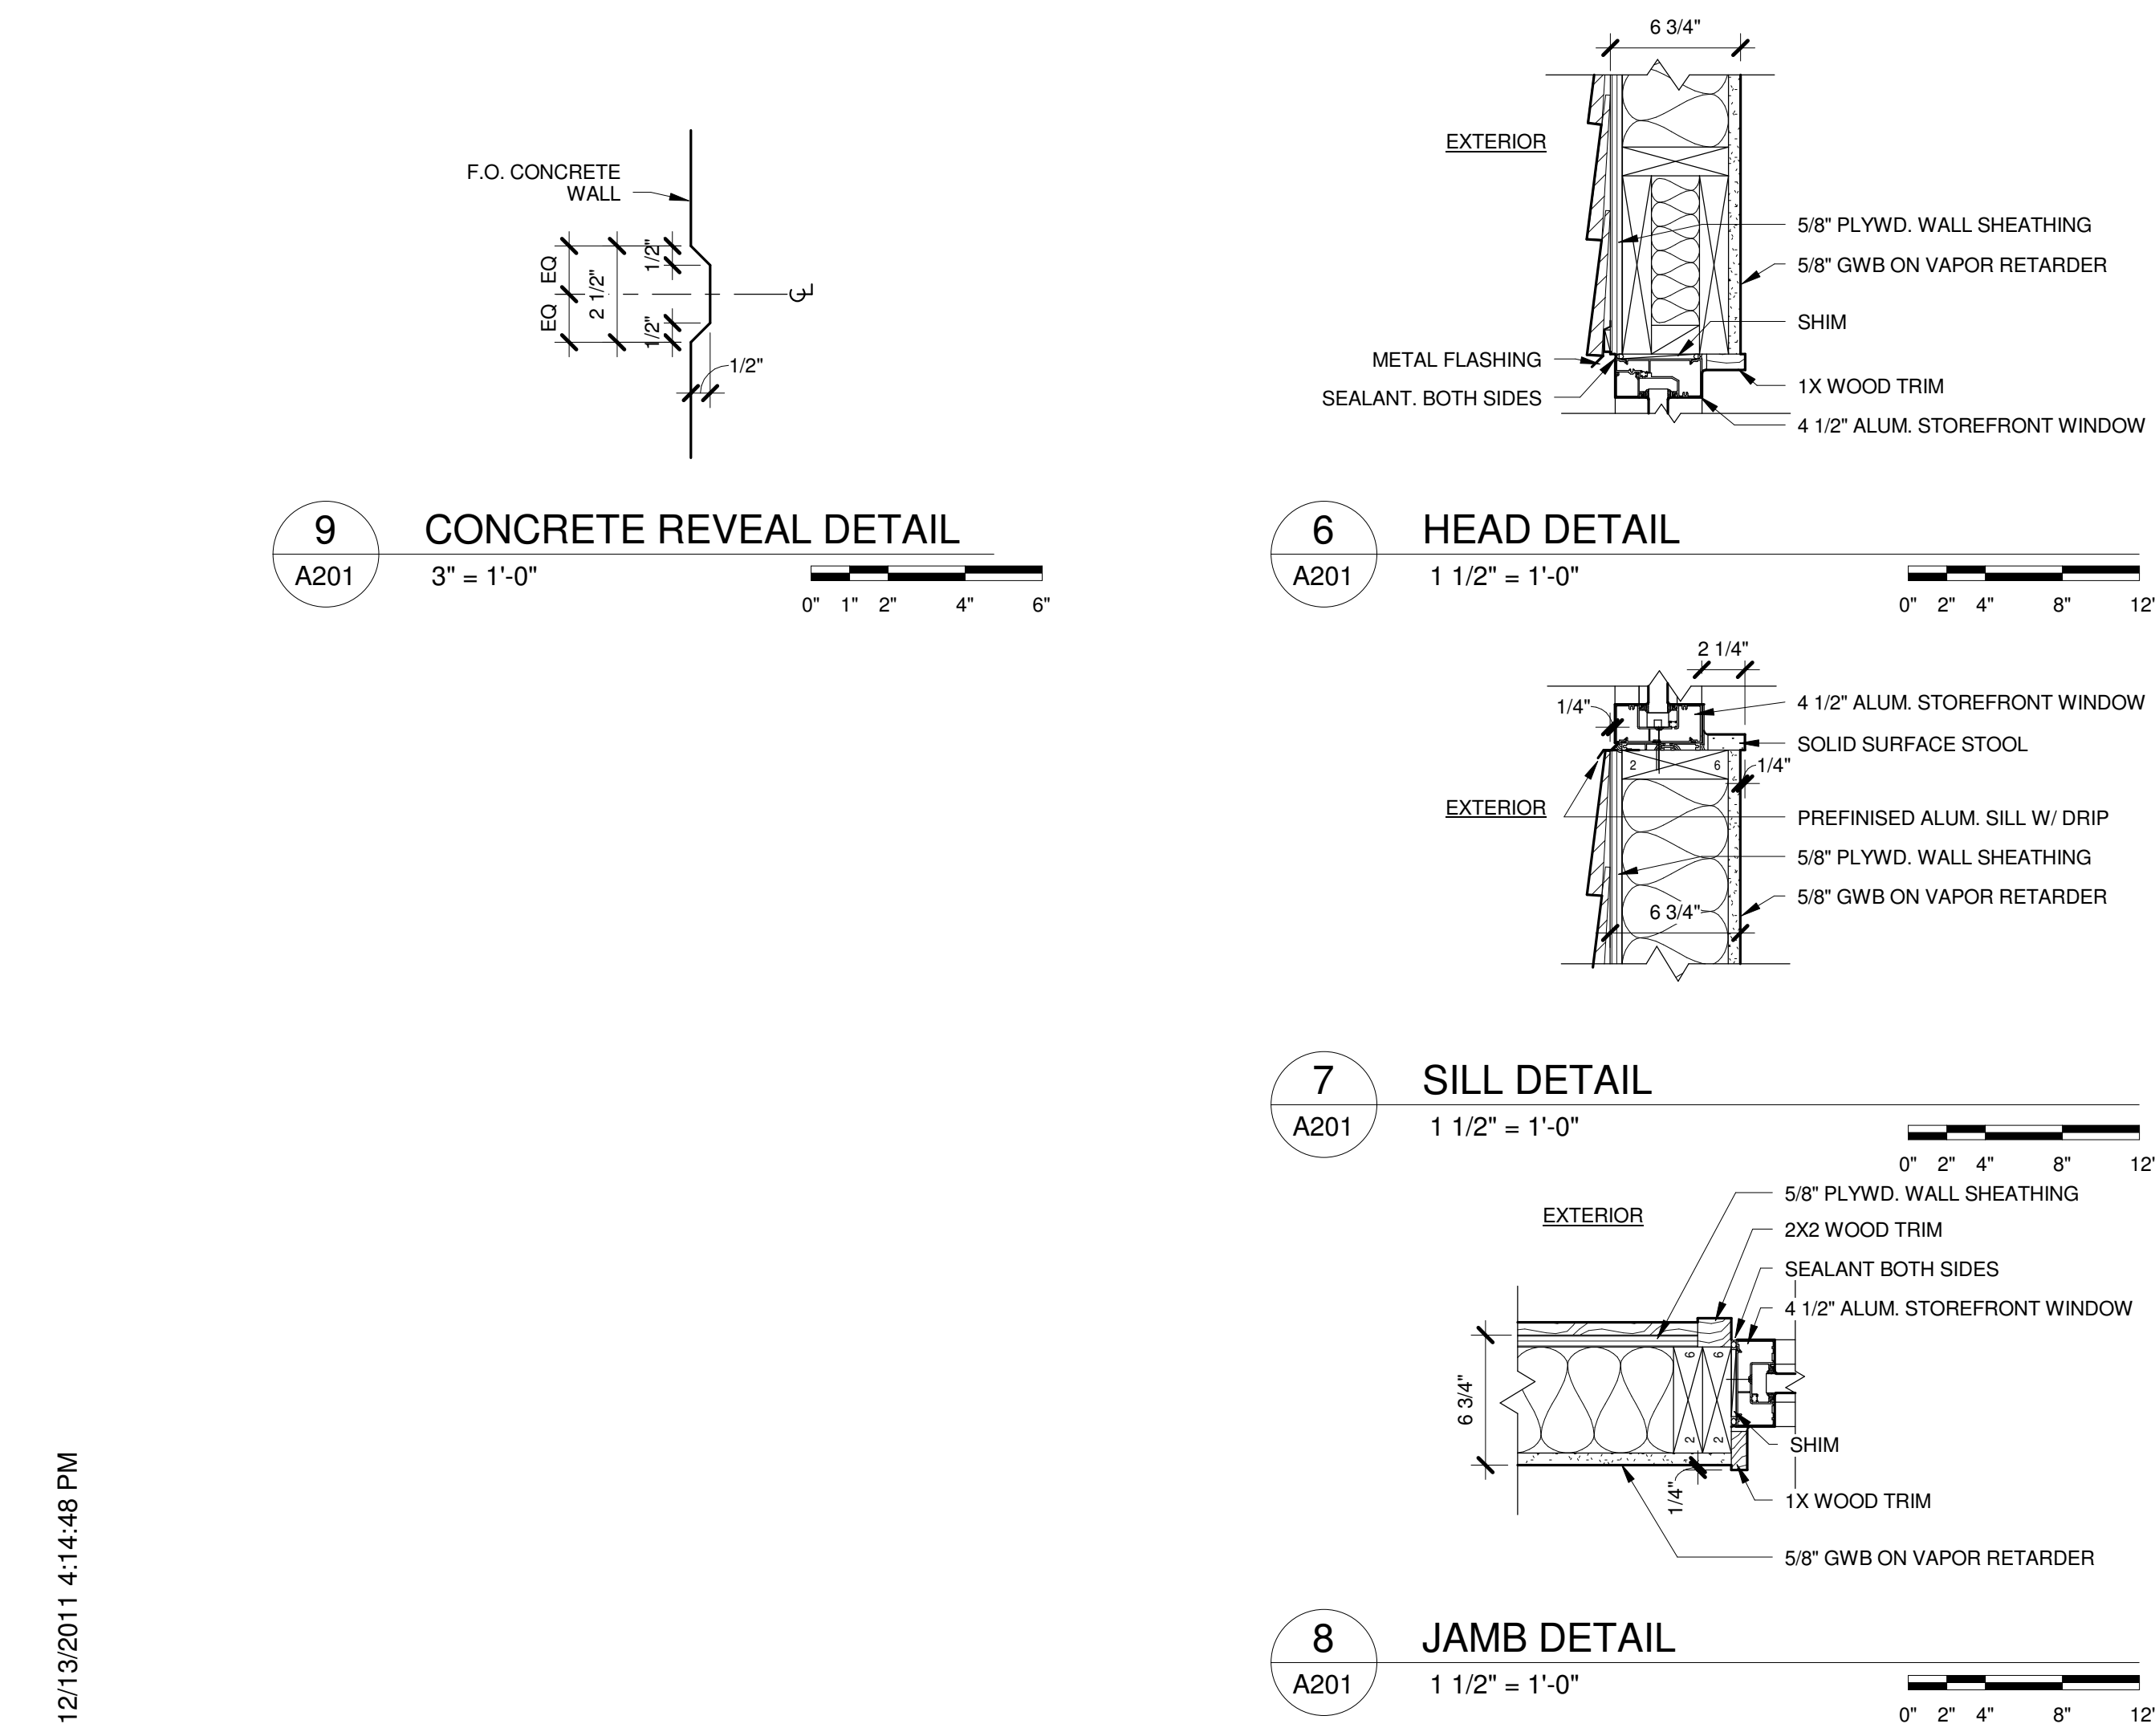

5 WINDOW TYPES
A201 1/4" = 1'-0"

*ALL ARE ALUM. STOREFRONT WINDOW FRAMING U.N.O.

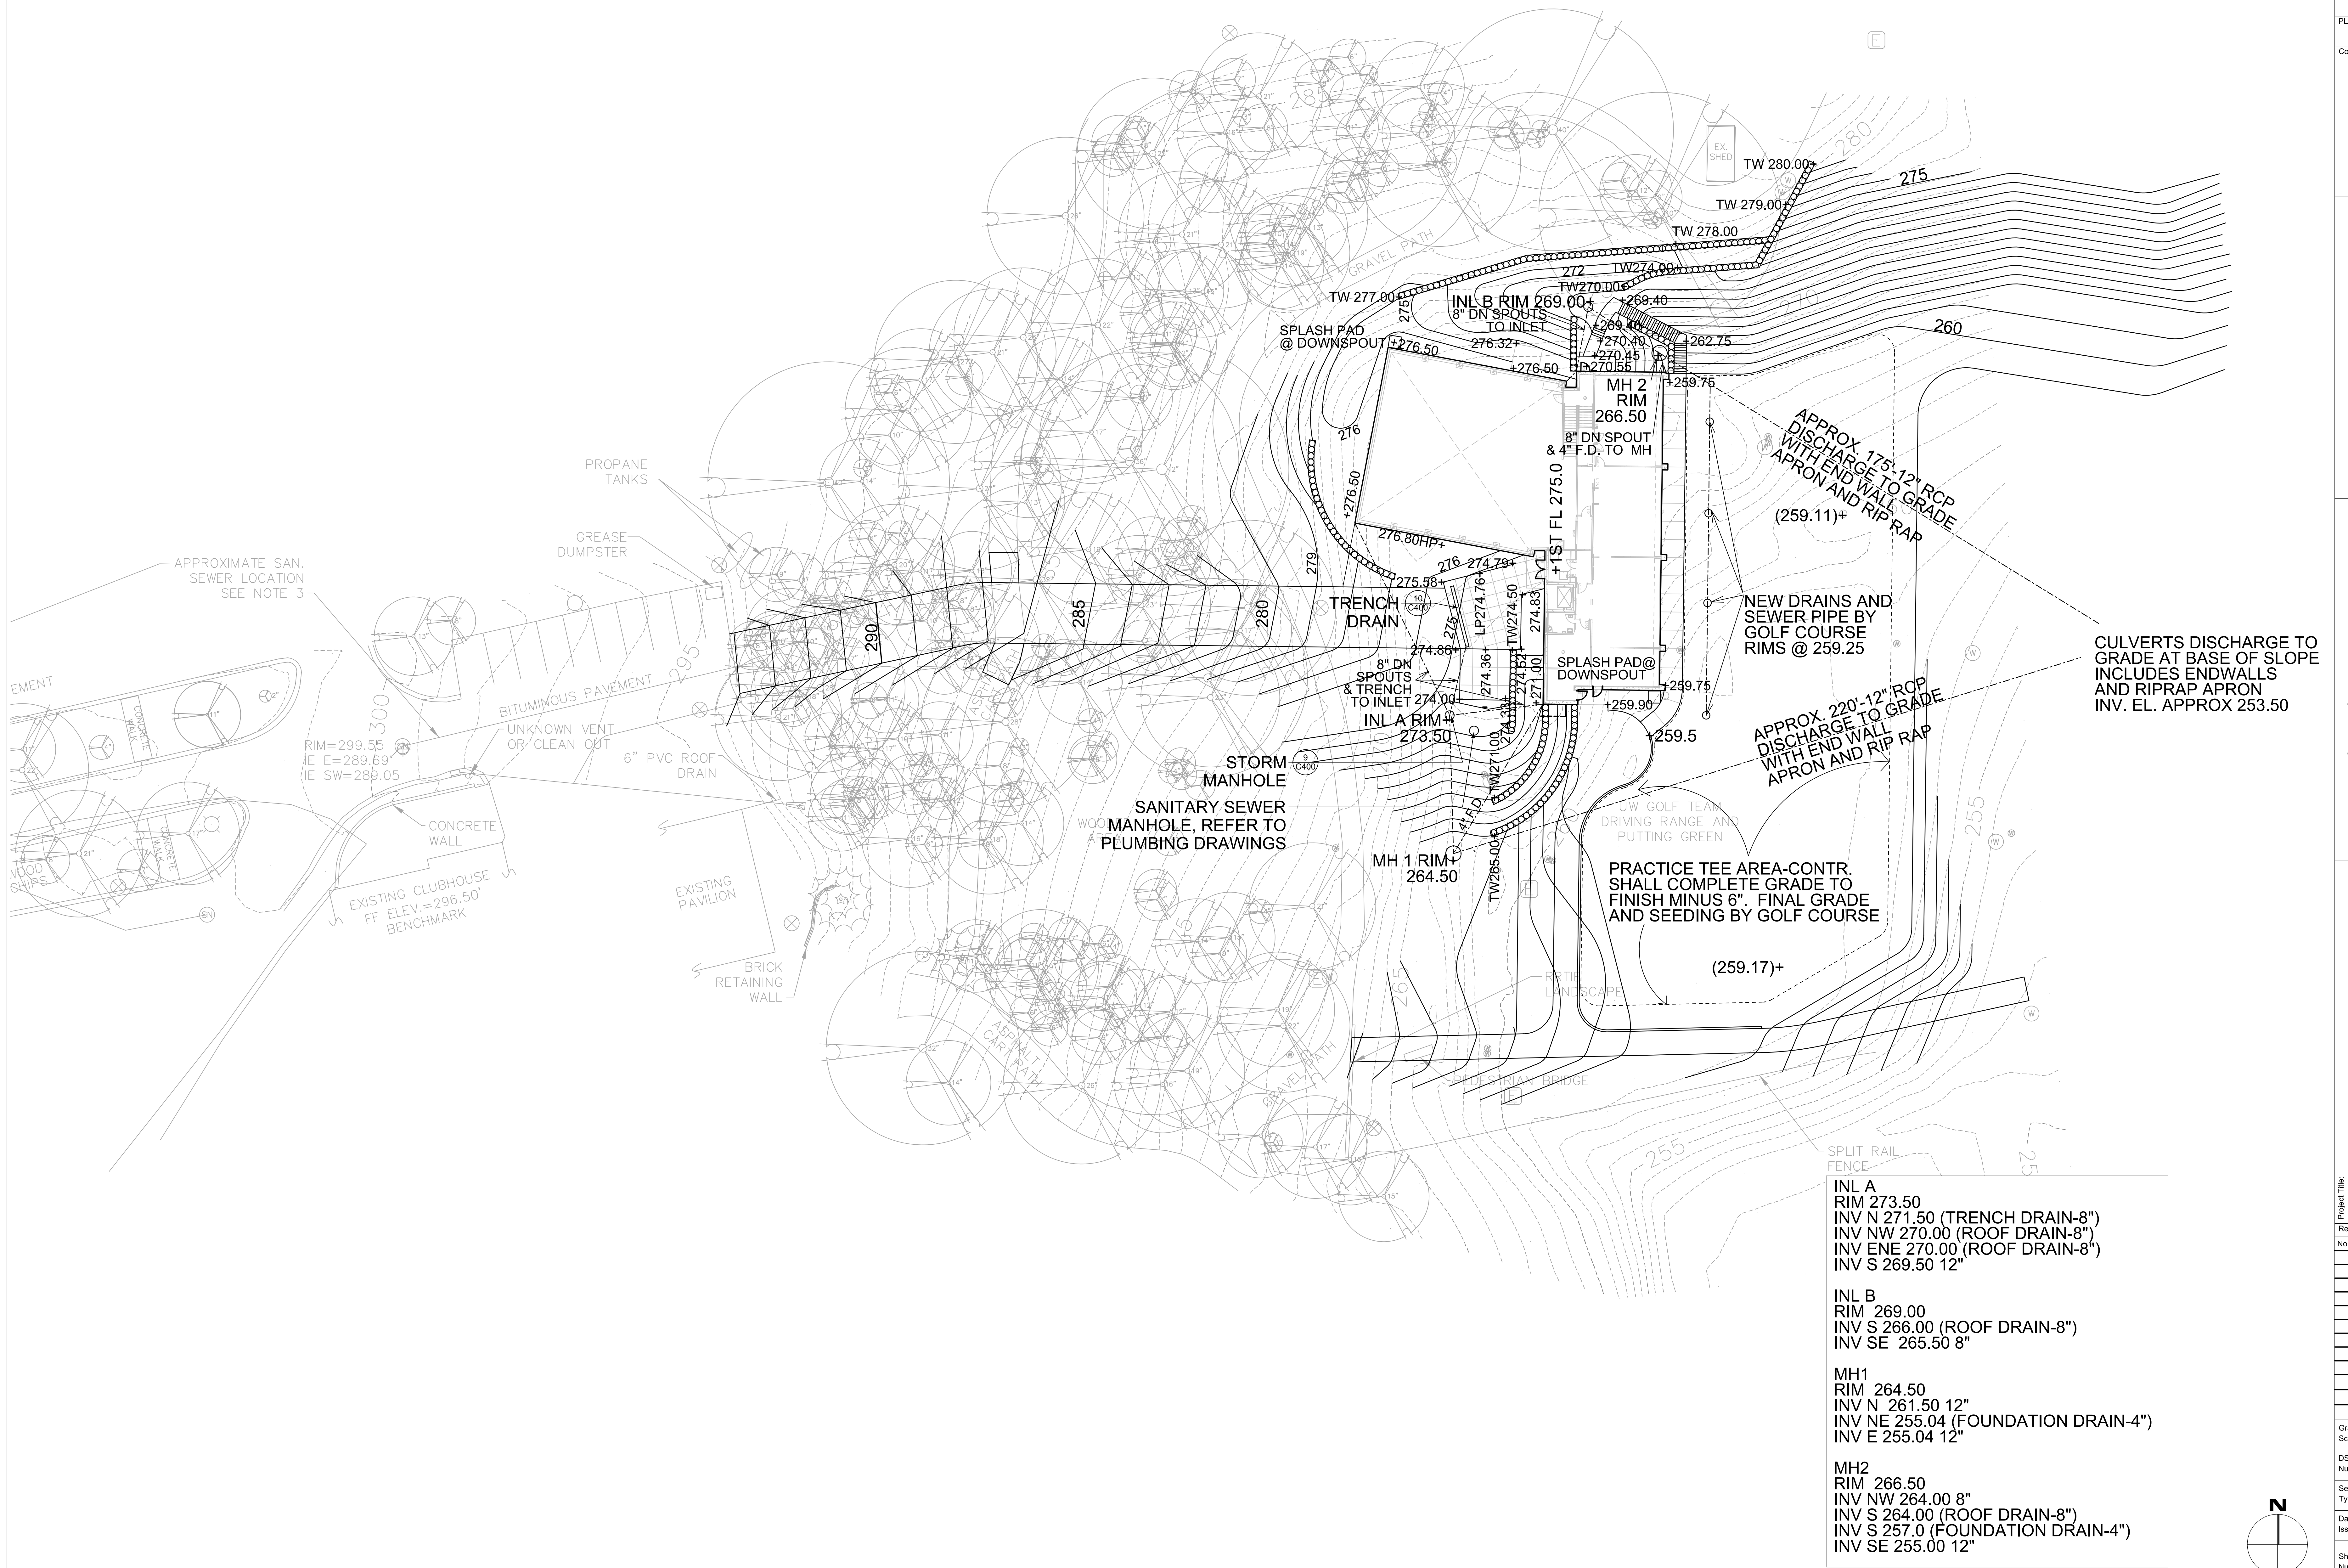

LIGHTING FIXTURE SCHEDULE																
NOTE:		SEE SPECIFICATIONS FOR ADDITIONAL INFORMATION REGARDING LIGHTING FIXTURE AND INSTALLATION REQUIREMENTS. MANUFACTURERS LISTED AS ACCEPTABLE SHALL MEET ALL REQUIREMENTS AND FEATURES INDICATED. ACCEPTABLE MANUFACTURERS MUST MEET THE PHOTOMETRIC PERFORMANCE OF THE LISTED UNIT.														
ABBREVIATIONS: DW = DRY WALL ES = EXPOSED STRUCTURE LG = LAY IN GRID P = PENDANT PL = PLASTER R = RECESS S = SURFACE W = WALL MOUNTED V = VARIES																
DES.	LAMP DATA		DESCRIPTION	LIGHTING FIXTURE		BALLAST		LAMPS		VOLT	MOUNT	CEILING TYPE	FIXTURE DEPTH	ACCEPTABLE MANUFACTURERS		
	NO.	TYPE		MANUFACTURER	CATALOG NUMBER	MANU.	CATALOG NUMBER	STEP DIM	MANUFACTURER						CATALOG NUMBER	
A	1	F32T8 SP50	4' STRIP	METALUX	SSF-132-UNV-EB81	SYLVANIA	QHE1X32T8UNV1SL-SC-1		SYLVANIA	F032/25W/850XP/SS/IECO3	120-277	S	V	3-5/8"	DAYBRITE,WILLIAMS,LITHONIA, COLUMBIA	
A2	2	F32T8 SP50	4' STRIP	METALUX	SSF-232-UNV-EB81	SYLVANIA	QHE2X32T8UNV1SL-SC-1		SYLVANIA	F032/25W/850XP/SS/IECO3	120-277	S	V	3-5/8"	DAYBRITE,WILLIAMS,LITHONIA, COLUMBIA	
B	2	F32T8 SP50	1X4 LENSED TROFFER	COLUMBIA	4PS-14-2-32-G-FSA12-E-U	SYLVANIA	QHE2X32T8UNV1SL-SC-1		SYLVANIA	F032/25W/850XP/SS/IECO3	120-277	R	LG	4-1/4"	DAYBRITE,WILLIAMS,LITHONIA, METALUX	
C	2	F32T8 SP50	4' INDUSTRIAL	METALUX	VT3-232-DR-UNV-EB81-WL-GT4	SYLVANIA	QHE2X32T8UNV1SL-SC		SYLVANIA	F032/25W/850XP/SS/IECO3	120-277	S	V	5"	DAYBRITE,WILLIAMS,LITHONIA, COLUMBIA	
D	2	F32T8 SP50	2X4 VOLUMETRIC TROFFER	METALUX	2AC-232-UNV-HR81DIM	SYLVANIA	QHE2X32T8UNV1PSN-SC	X	SYLVANIA	F032/25W/850XP/SS/IECO3	120-277	R	LG	3-1/4"	DAYBRITE,WILLIAMS,LITHONIA, COLUMBIA	
E	1	55W INDUCTION	10" DOWNLIGHT WET LOCATION	ESCO LIGHTING	R152750-1	PHILIPS	QL GENERATOR 55W		PHILIPS	QL LAMP 55W/850	120	R	V	13"	PORTFOLIO, OMEGA, LITHONIA, PRESCOLITE	
F	1	42W TTT	6" DOWNLIGHT	PORTFOLIO	C6-142E-61S1-LI	GE	GEC226-MVPS-3W		GE	F42TBX/841/A/ECO	120-277	R	V	6-1/2"	OMEGA,INFINITY,GOTHAM, PRESCOLITE	
G	1	F32T8 SP50	4' WALL BRACKET	METALUX	BIU-132-UNV-EB81	SYLVANIA	QHE1X32T8UNV1SL-SC-1		SYLVANIA	F032/25W/850XP/SS/IECO3	120-277	W	-	3-1/2"	DAYBRITE,WILLIAMS,LITHONIA, COLUMBIA	
H	3	F54T5HO SP50	4' WALL BRACKET / INDIRECT (16'-0" AFF)	SPI	E1W9340FT-3F54-120V-WHITE	SYLVANIA	QT3X54120PHO		SYLVANIA	FP54/850HO	120	W	-	8"	PINNACLE, LAM, INSIGHT	
J	-	LED	EXTERIOR WALL SCONCE	KIM	WD14-D-4-60-LSK-120-DB	-	INCLUDED	-	-	INCLUDED	120	W	-	9"	NONE	
L	1	150W INDUCTION	EXTERIOR FLOODLIGHT	PHOENIX	PHLFL-23-200-50-120-YM-BZ	-	INCLUDED	-	-	INCLUDED	120	W	-	23"	MCGRAW EDISON, GARDCO, LITHONIA	
M	1	F32T8 SP50	4' UNDERCABINET	METALUX	CL-132-UNV-EB81	SYLVANIA	QHE1X32T8UNV1SL-SC-1		SYLVANIA	F032/25W/850XP/SS/IECO3	120-277	S	-	1-13/16"	DAYBRITE,WILLIAMS,LITHONIA, COLUMBIA	
N	1	42W TTT	6" DOWNLIGHT	PORTFOLIO	C6-142E-6181-L13WF	GE	GEC226-MVPS-3W		GE	F42TBX/841/A/ECO	120-277	R	V	6-1/2"	OMEGA,INFINITY,GOTHAM, PRESCOLITE	
OC	-	LED	LIGHT POLE (14'-0" POLE / 2'-0" BASE)	KIM	1SA/SAR2/150PMH120DB	-	INCLUDED	-	-	INCLUDED	120	-	-	6"	NONE	
P1	4	42W TTT	DECORATIVE PENDANT	OCL LIGHTING	FB1-P1EC-30-CC/GW-PTD-4TT42-120-18-DMA	ADVANCE	RE2-2Q26-M2-BS		GE	F42TBX/841/A/ECO	120	P	ES	18"	NONE	
P2	4	42W TTT	DECORATIVE PENDANT	OCL LIGHTING	FB1-P1EC-30-CC/GW-PTD-4TT42-120-54-DMA	ADVANCE	RE2-2Q26-M2-BS		GE	F42TBX/841/A/ECO	120	P	ES	54"	NONE	
B2	4	F32T8 SP50	2X4 LENSED TROFFER	METALUX	2GC8-432-A125-UNV-EB82-PAF	SYLVANIA	QHE2X32T8UNV1SL-SC-1		SYLVANIA	F032/25W/850XP/SS/IECO3	120-277	R	LG	4-1/4"	DAYBRITE,WILLIAMS,LITHONIA, COLUMBIA	
T	-	LED	SPOTLIGHT	AMERLUX	C3TV-30-LED-E-BT-C-120-3000	-	INCLUDED	-	-	INCLUDED	120	W	-	6"	NONE	
EM	-	5.4W	EMERGENCY	LITHONIA	ELM2-LED-HO-SD	-	-	-	-	-	120-277	W	-	4-1/4"	FAILSAFE,MCPHILBEN	
EMA	-	6W	EXTERIOR EMERGENCY EGRESS	LITHONIA	AFN-DB-EXT	-	-	-	-	-	120-277	W	V	10"	FAILSAFE,MCPHILBEN	
XEM	-	LED	COMBINATION EXIT LIGHT / EMERGENCY	LITHONIA	LHQM-LED-R-HO-SD	-	-	-	-	-	120-277	V	V	8"	FAILSAFE,MCPHILBEN	

LIGHTING FIXTURE SCHEDULE NOTES:

- MANUFACTURER NAMES AND CATALOG NUMBERS ARE USED FOR QUALITY AND PERFORMANCE ONLY. EQUIPMENT MANUFACTURED BY OTHERS WILL BE EQUALLY ACCTEABLE PROVIDED THEY MEET OR EXCEED THE SPECIFICATIONS.
- ALL MULTI-LAMP BALLASTS SHALL BE WIRED IN PARALLEL, NOT IN SERIES.
- ALL FIXTURES WITH ACCEPTABLE MANUFACTURERS LISTED AS "NONE" ARE TO BE PROVIDED AS SPECIFIED AS THEY ARE THE CAMPUS STANDARD ON LIGHT POLES, PROVIDE A MATCHING 14"0" POLE PER THE CAMPUS STANDARD

MOTOR WIRING SCHEDULE																						
BOL = BUILT-IN OVERLOAD				VFD = VARIABLE FREQUENCY DRIVE				IU = IN UNIT				CS = COMBINATION STARTER				HC = MECH. CONTRACTOR						
MAG = MAGNETIC STARTER				RVS = REDUCED VOLTAGE STARTER				NU = NEAR UNIT				DS = DISCONNECT				(3R) = NEMA 3R WEATHERPROOF						
MAN = MANUAL STARTER				ZSP = 2 SPEED MAGNETIC STARTER				OU = ON UNIT				EC = ELEC. CONTRACTOR				PC= PLUMBING CONTRACTOR						
HP	VOLT	Ø	LOC	DRIVING	FEED FROM		BREAKER		BRANCH WIRING				STARTER WIRING				DISC. WIRING				NOTES	
					PANEL	CKT	SIZE	POLE	NO.	SIZE	GRND.	COND.	NEMA	TYPE	BY	LOC.	SIZE	POLE	TYPE	BY		LOC.
1/4	120	1	100A	Exhaust Fan EF-3	B	52	20	1	2	12	12	1/2	-	-	-	-	-	-	DS	EC	100A	-
3.0KW	208	1	100A	Electric Unit Heater EUH-1	B	64.66	20	2	2	12	12	1/2	-	-	-	-	30	2	DS	EC	100A	-
1.0KW	208	1	107A	Electric Wall Heater EWH-2	B	72.74	15	2	2	12	12	1/2	-	-	-	-	30	2	DS	HC	IU	-
1.0KW	208	1	114A	Electric Wall Heater EWH-3	B	54.56	15	2	2	12	12	1/2	-	-	-	-	30	2	DS	HC	IU	-
5.2A	208	3	111	Energy Recovery Ventilator ERV-1	B	58.60,62	15	3	3	12	12	1/2	1	CS	EC	111	-	-	-	-	-	-
12.7A	120	1	111	Furnace F-1	B	68	15	1	2	12	12	1/2	-	-	-	-	-	-	DS	EC	OU	-
19.1A	120	1	111	Furnace F-2	B	70	20	1	2	12	12	1/2	-	-	-	-	-	-	DS	EC	OU	-
1.0KW	208	1	101	Electric Wall Heater EWH-1	B	80.82	15	2	2	12	12	1/2	-	-	-	-	30	2	DS	HC	IU	-
3.0KW	208	1	100E	Electric Wall Heater EWH-5	B	76.78	20	2	2	12	12	1/2	-	-	-	-	30	2	DS	HC	IU	-
240W	120	1	L116	Destratification Fan DSF-2	A	81	20	1	2	12	12	1/2	-	-	-	-	-	-	DS	EC	L116	-
240W	120	1	L116	Destratification Fan DSF-1	A	81	20	1	2	12	12	1/2	-	-	-	-	-	-	DS	EC	L116	-
15A	120	1	L108	Infrared Heater IRH-1	A	63	20	1	2	12	12	1/2	-	-	-	-	-	-	DS	EC	L108	-
15A	120	1	L107	Infrared Heater IRH-2	A	65	20	1	2	12	12	1/2	-	-	-	-	-	-	DS	EC	L107	-
15A	120	1	L106	Infrared Heater IRH-3	A	67	20	1	2	12	12	1/2	-	-	-	-	-	-	DS	EC	L106	-
15A	120	1	L105	Infrared Heater IRH-4	A	69	20	1	2	12	12	1/2	-	-	-	-	-	-	DS	EC	L105	-
1/12	120	1	L104	Exhaust Fan EF-2	A	77	20	1	2	12	12	1/2	-	-	-	-	-	-	DS	EC	L104	-
1/8	120	1	L104	Exhaust Fan EF-1	A	77	20	1	2	12	12	1/2	-	-	-	-	-	-	DS	EC	L104	-
2.0KW	208	1	100A	Electric Wall Heater EWH-4	B	48.50	15	2	2	12	12	1/2	-	-	-	-	30	2	DS	HC	IU	-
5	208	3	GRADE	Makeup Air Unit MUA-1	A	57.59,61	35	3	3	8	10	3/4	-	CS	HC	IU	-	-	DS	HC	IU	-
23.1A	208	1	GRADE	Condensing Unit ACCU-2	A	53.55	30	2	2	10	10	3/4	-	-	-	-	30	2	DS(3R)	EC	OU	3
28.7A	208	1	GRADE	Condensing Unit ACCU-1	A	49.51	40	2	2	8	10	3/4	-	-	-	-	60	2	DS(3R)	EC	OU	3
25A	208	3	L116A	Elevator	A	71.73,75	110	3	3	2	6	1 1/4	-	-	-	-	200	3	DS	EC	L116A	-
1	208	3	L104	Makeup Air Unit MUA-2	A	79.81,83	15	3	3	12	12	1/2	1	CS	EC	L104	-	-	-	-	-	-
FRAC.	120	1	111	Circulation Pump CP-1	B	84	20	1	2	12	12	1/2	1	CS	EC	111	-	-	-	-	-	-
2@1.5	208	3	SITE	Sanitary Ejector SE-1	A	2.4,6	20	3	3	12	12	1/2	-	-	-	-	30	2	DS	PC	L104	1
3/4	208	1	L104	Sump Pump SP-1 / Control Panel	A	8,10	15	2	2	12	12	1/2	-	-	-	-	30	2	DS	EC	L116A	2
129W	120	1	L102	Transfer Fan TF-1	A	33	20	1	2	12	12	1/2	-	-	-	-	-	-	DS	EC	L102	-
1.0KW	208	1	L116C	Electric Wall Heater EWH-6	A	44,46	15	2	2	12	12	1/2	-	-	-	-	30	2	DS	HC	IU	2

MOTOR WIRING SCHEDULE NOTES:

- PROVIDE A 208V, 25A/2P CONNECTION TO SANITARY EJECTOR AND SANITARY EJECTOR CONTROL PANEL / DISCONNECT IN #L104.
- PROVIDE A 208V, 15A/2P CONNECTION TO SUMP PUMP IN ELEVATOR PIT AND SUMP PUMP CONTROL PANEL IN #L104.

PANEL SCHEDULE																	
ABBREVIATIONS:																	
F = FLUSH														MLO = MAIN LUGS ONLY			
S = SURFACE														MCB = MAIN CIRCUIT BREAKER			
DES.	BREAKER								1 POLE SPACE	LOC.	MTG.	BUSSING	VOLT	NUMBER OF TUBS 20 CIRCUITS EACH 42 CIRCUITS EACH 84 CIRCUITS EACH KAC RATING			
	QTY.	P	AMP	QTY.	P	AMP	QTY.	P							AMP		
A	50	1	20	1	2	40	1	3	110	12	L102	S	400A MLO	120/208V 3Ø, 4W	2	X	22
	2	2	15	1	3	20	1	3	225								
	1	2	30	1	3	35	1	3	15								
B	1	1	15	4	2	15	1	2	30	27	111	S	225A MLO	120/208V 3Ø, 4W	1	X	22
	37	1	20	2	2	20											
	2	1	25	2	3	15											

12/13/2011 10:22:47 AM



1
E001

SITE PLAN - ELECTRICAL



GENERAL NOTES:

1. ALL SITE LIGHTING WIRING SHALL BE #10 MINIMUM.

KEYED NOTES:

- ① EXISTING ALLIANT ENERGY PAD MOUNTED TRANSFORMER.
② NEW ALLIANT ENERGY PAD MOUNTED TRANSFORMER.
③ PROVIDE FOUR(4) 4" CONDUITS FROM CLUBHOUSE MDF TO NEW ELECTRICAL #L102 IN NEW PRACTICE FACILITY TO CONTAIN ONE(1) 24-STRAND SINGLE MODE FIBER AND ONE(1) 50-PAIR COPPER. ROUTE TO NEW ACCESS DRIVE TO MINIMIZE DISRUPTION TO EXISTING SITE. COORDINATE WORK WITH SITE UTILITY CONTRACTOR.

Architect:


Potter Lawson

PLI Project No:
2010.20.00

Consultant:

JDR
ENGINEERING, INC.
5525 NOBEL DRIVE
SUITE 110
MADISON, WI 53711
ph: 608.277.1728 fax: 608.271.7046
JDR Project No.110050

State of Wisconsin
Department of Administration
Division of State Facilities

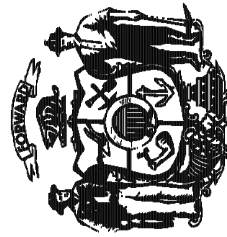

Agency / Institution:


FP&M
UW - MADISON

Project Title:
UW MADISON ALL-SEASON
GOLF PRACTICE FACILITY
Project Location: UNIVERSITY RIDGE GOLF COURSE
MADISON, WISCONSIN
Sheet Title:
SITE PLAN - ELECTRICAL

Revisions:

No.	Date:	Description:
	4/18/2011	35% Review
	11/14/2011	100% Final Review
	12/15/2011	Bid Drawings

 Graphic
Scale



DSF
Number

1031L

Set
Type

BD

Date
Issued

12/15/2011

Sheet
Number

E001

